


three inches = one foot  
one and one half inches = one foot  
one inch = one foot  
three quarters inch = one foot  
one half inch = one foot  
three eighths inch = one foot  
one eighth inch = one foot  
one quarter inch = one foot  
one eighth inch = one foot  
one eighth inch = one foot

SYMBOL LEGEND


- PANELBOARD  
DRY TYPE TRANSFORMER

KEYED NOTES THIS SHEET


- (200) PANELBOARDS AND TRANSFORMERS  
(201) FIRE DAMPER ABOVE CEILING  
(211) NEMA 1 LABORATORY WIREWAY ABOVE CEILING, 6"x6"x48" LONG  
(212) NEMA 1 EQUIPMENT ROOM WIREWAY ABOVE CEILING, 6"x6"x24" LONG  
(221) CONNECTION BOX FOR BIOSAFETY CABINET  
(222) FUME HOOD CONNECTIONS AND BRANCH CIRCUIT  
(223) AUTOCLAVE CONTROL POWER CONNECTION

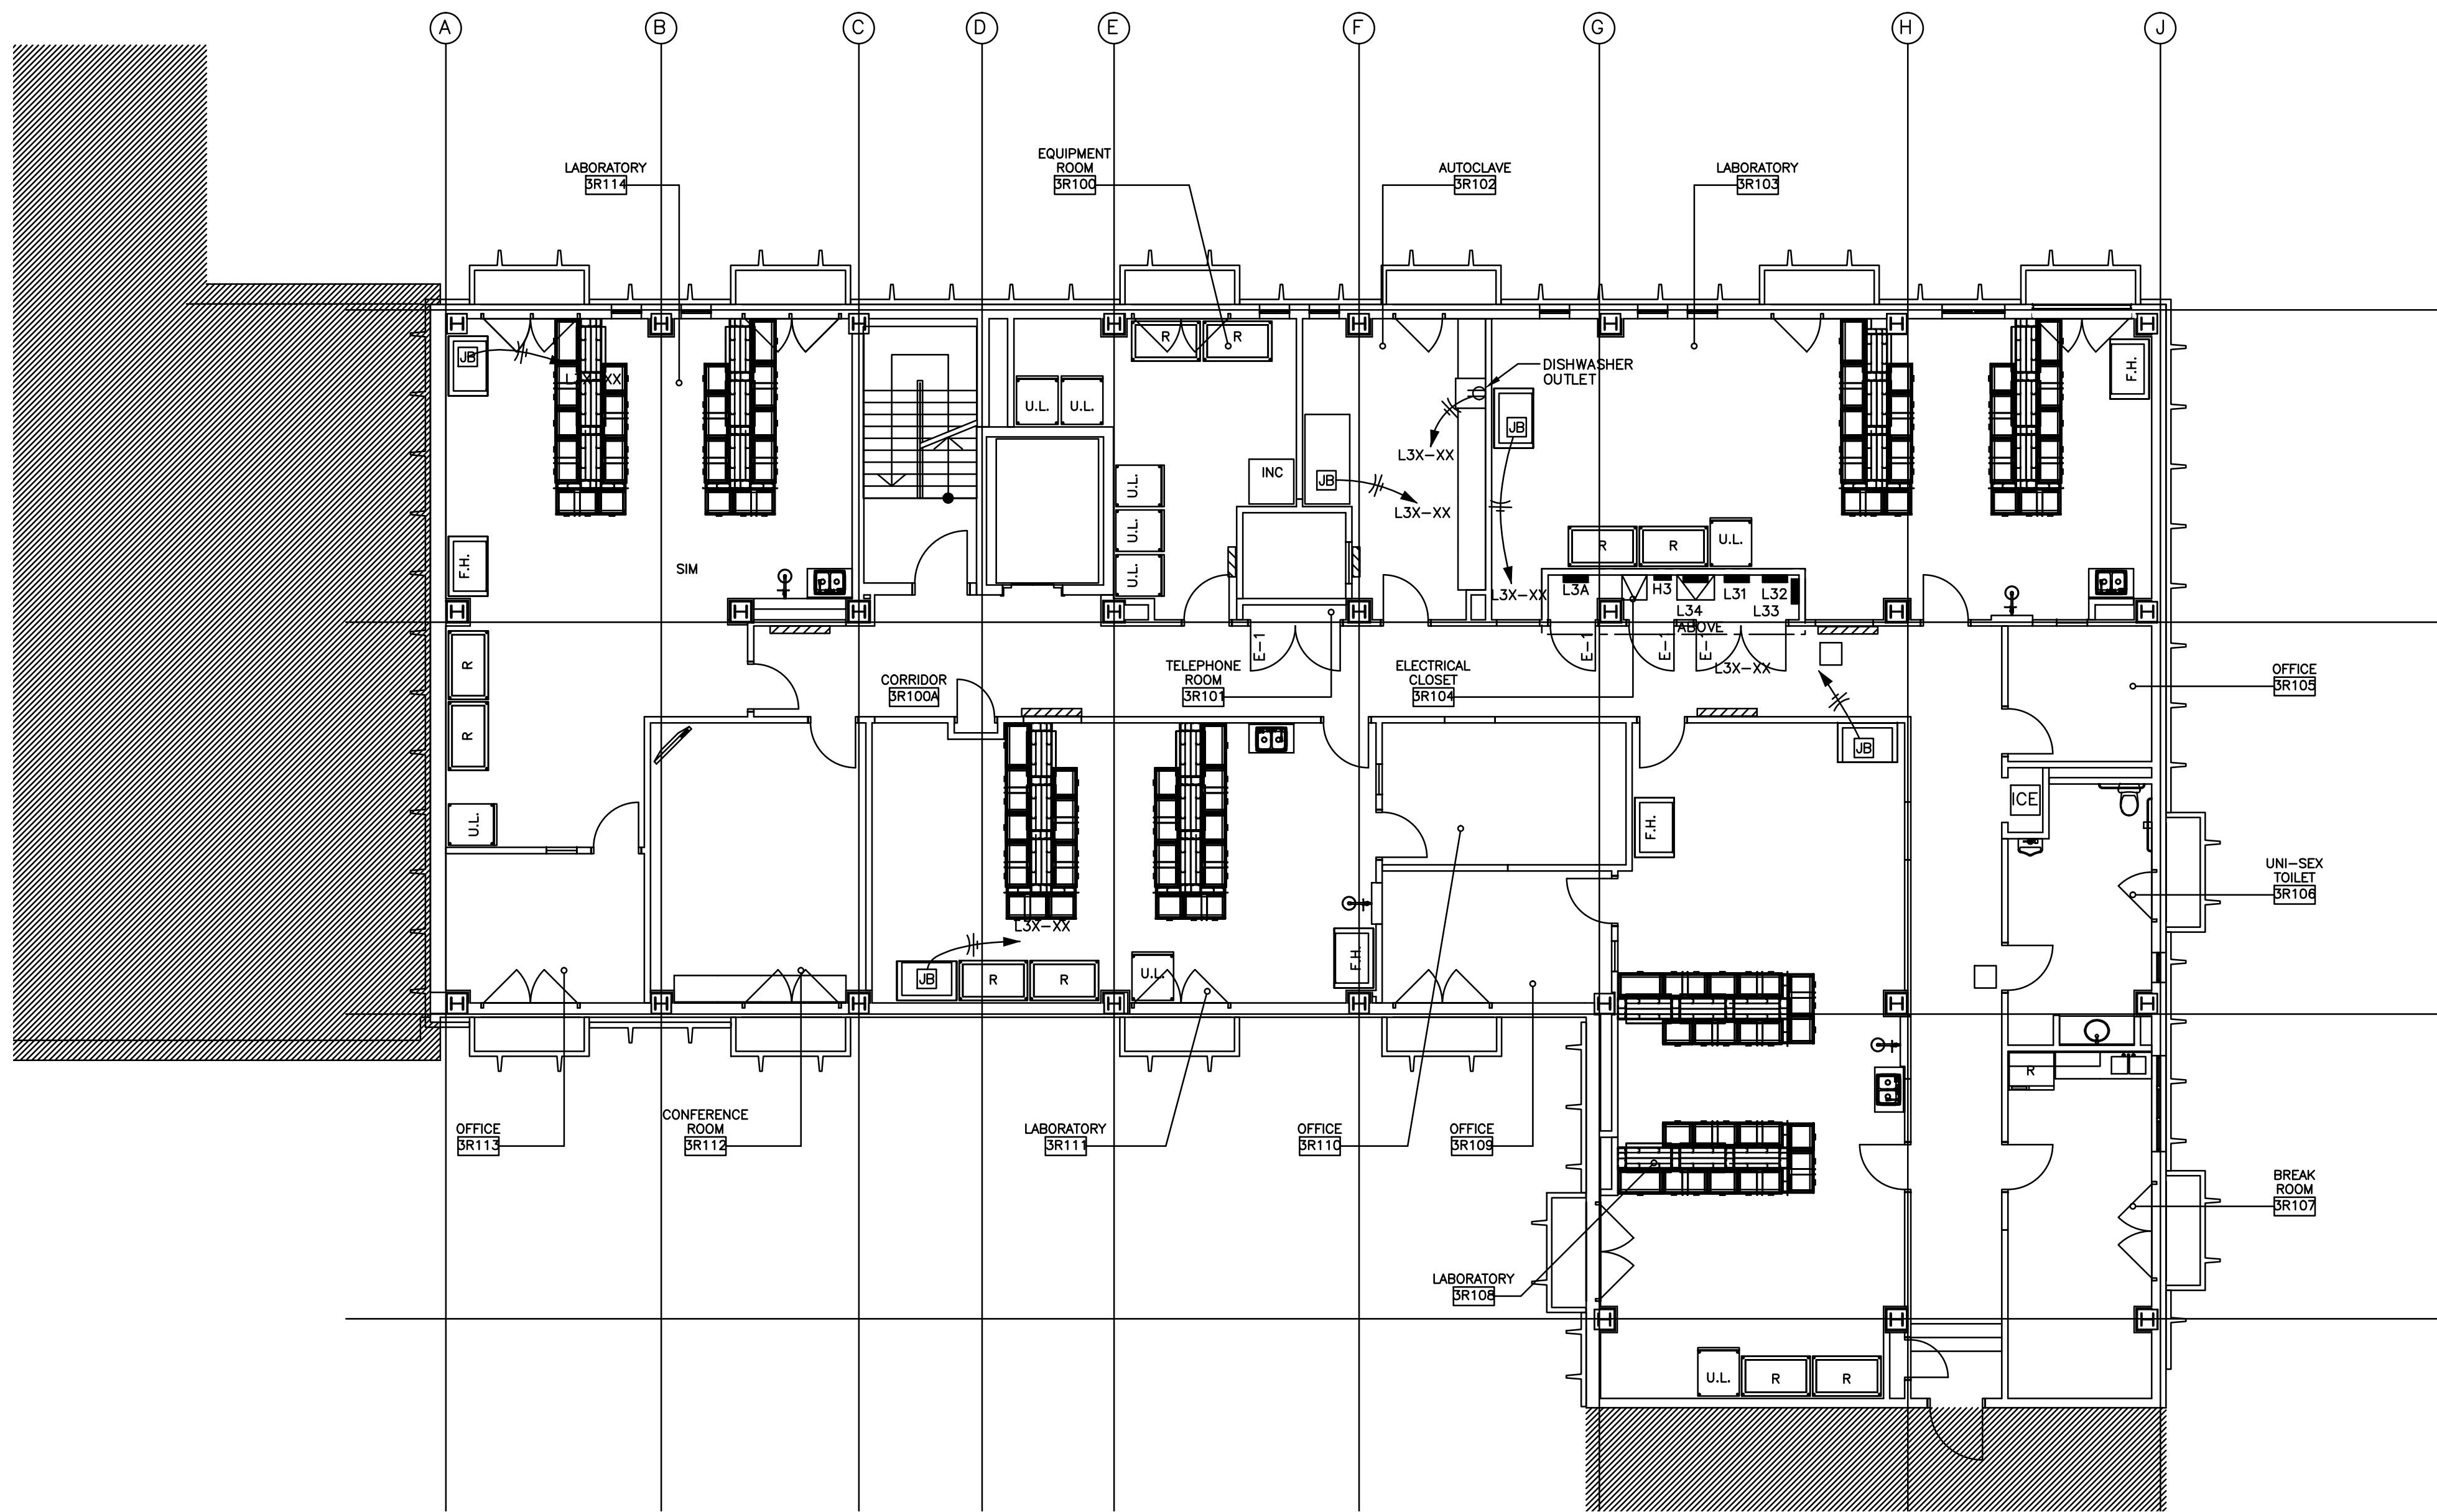

1 POWER PLAN - THIRD FLOOR  
E-203 SCALE: 1/8"=1'-0"  
8' 4' 0 8'  
SCALE IN FEET

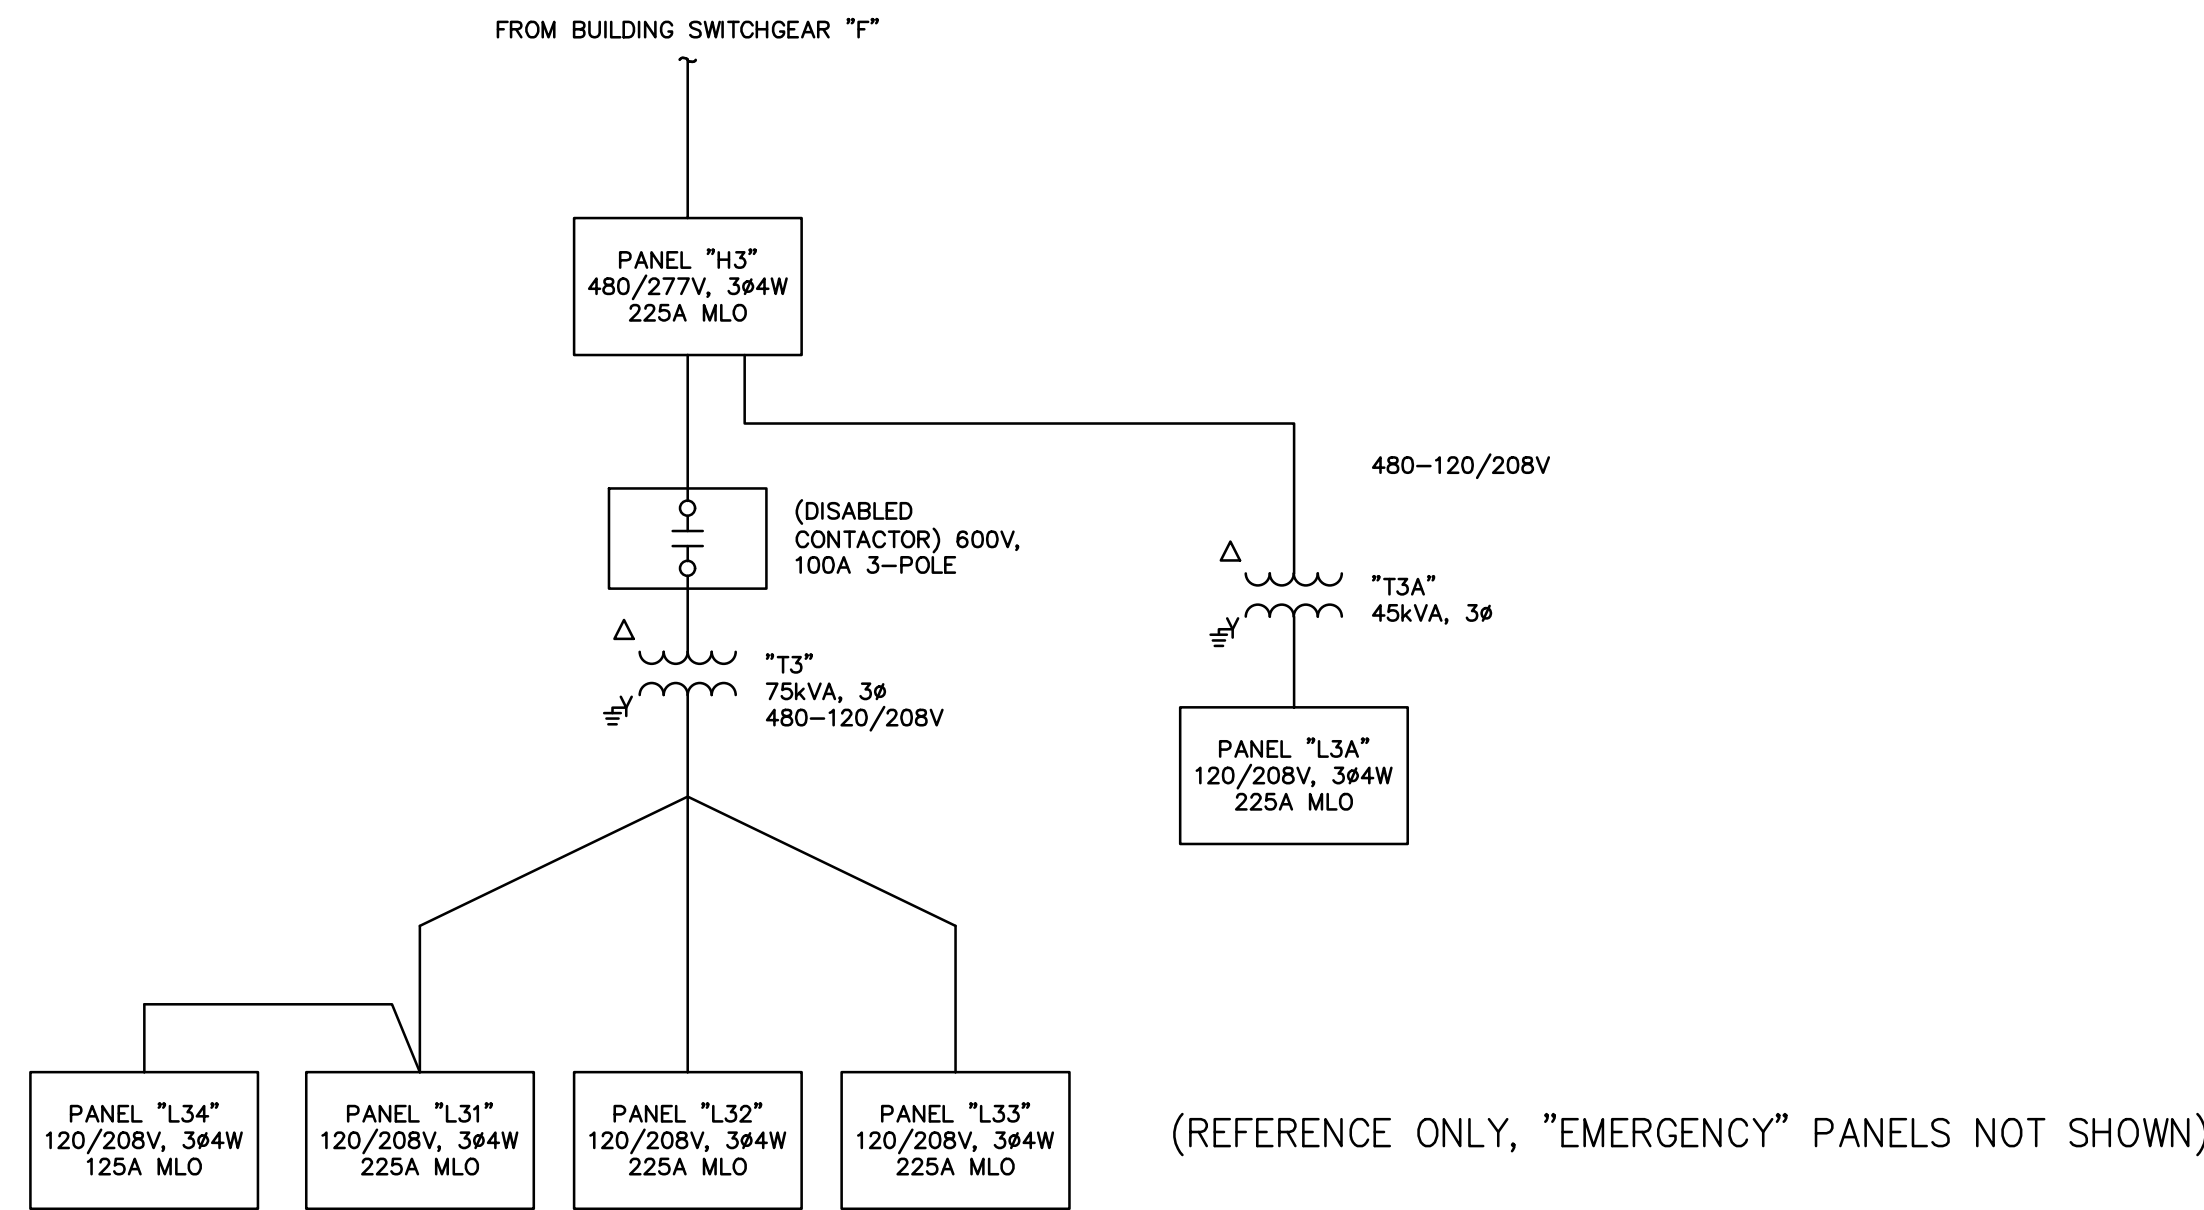

1 PARTIAL SINGLE-LINE DIAGRAM  
E-204 SCALE: NONE

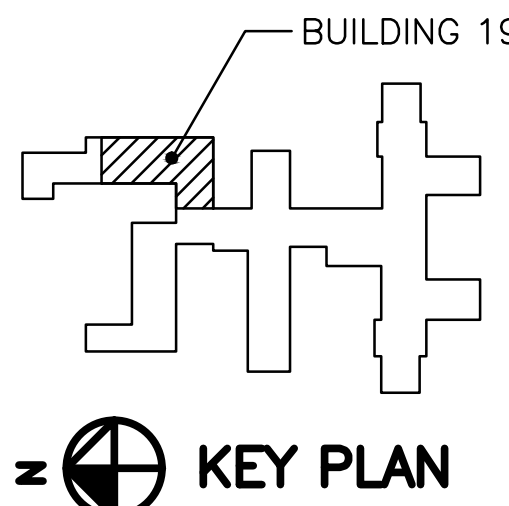

CONSULTANTS:		ARCHITECT/ENGINEERS:		Drawing Title THIRD FLOOR POWER PLAN	Project Title BUILDING 19	Project Number	Office of OKC VAMC ENGINEERING PROJECTS Department of Veterans Affairs	
				Approved Medical Center Director		Building Number Bldg. 1		
				Approved Chief, Engineers		Drawing Number		
				Approved Chief, Projects		Date MAY 2012	Checked	Drawn
Revisions:		Date				Dwg. 4 of 16		