

A

B

C

D

E

F

G

H

I

J

K

L

A

B

C

D

E

F

G

H



I

J


K

L

three inches = one foot
one and one half inches = one foot
one inch = one foot
three quarters inch = one foot
one half inch = one foot
three eighths inch = one foot
one quarter inch = one foot
one eighth inch = one foot

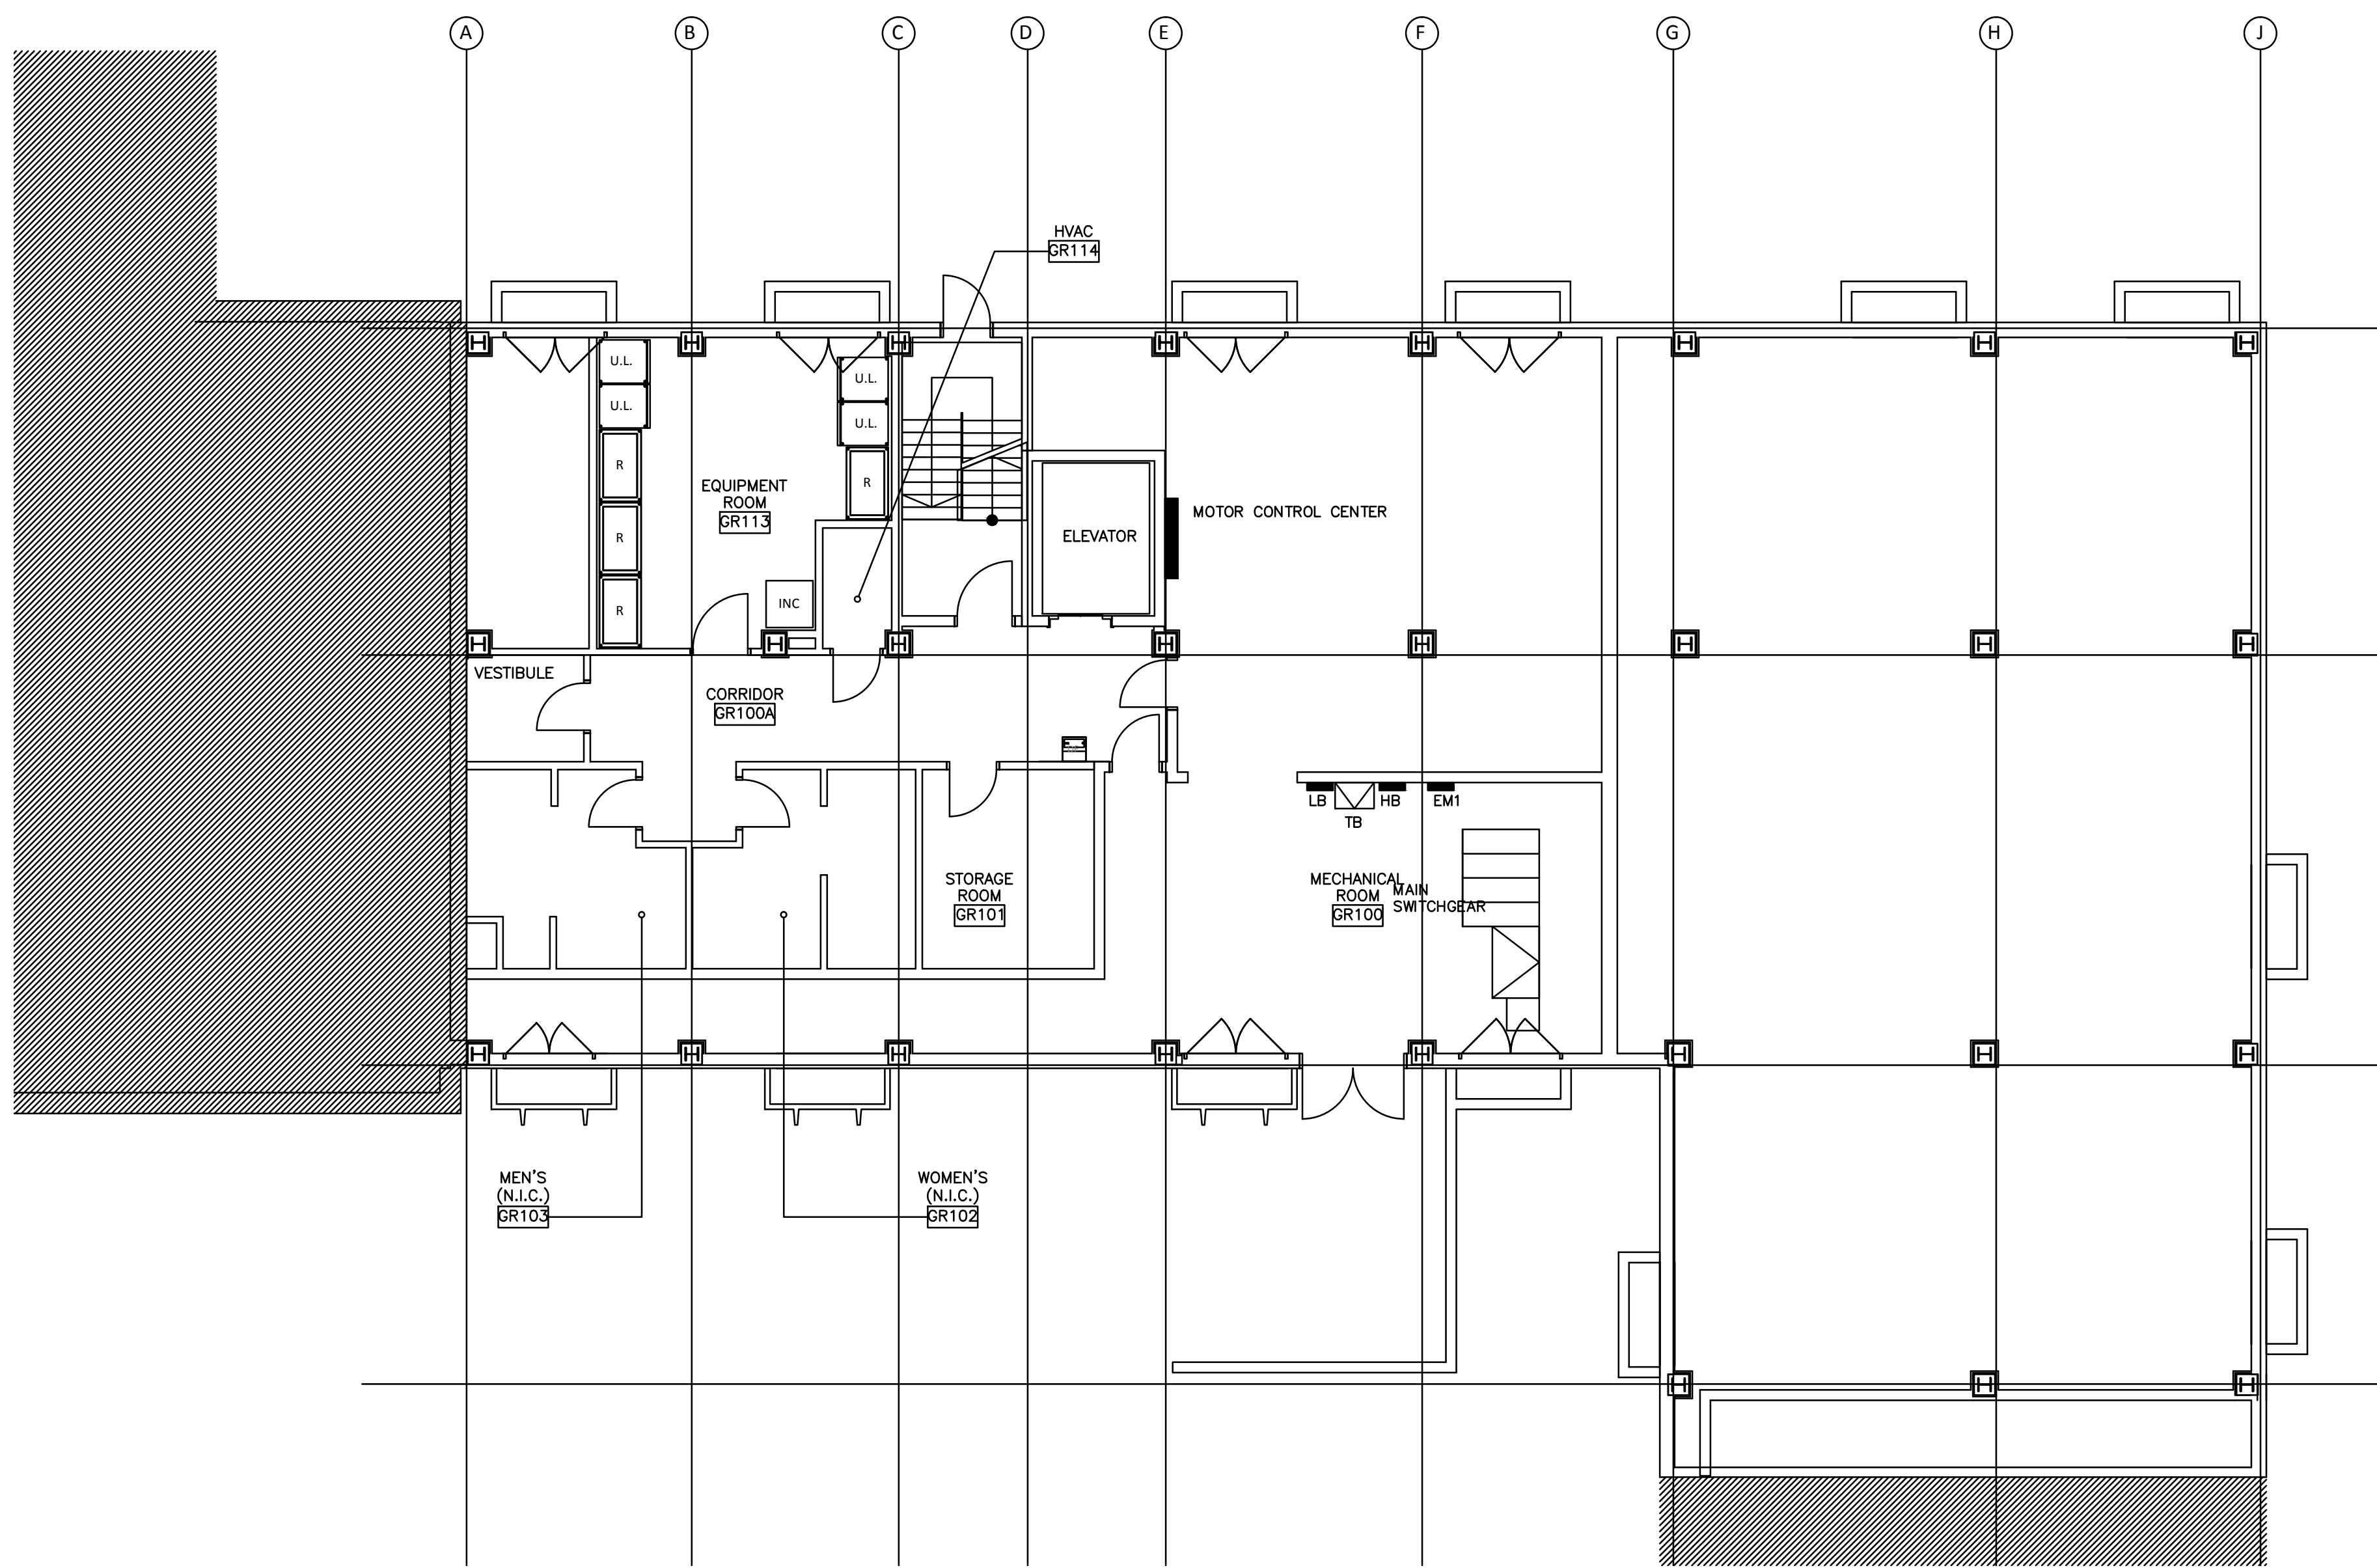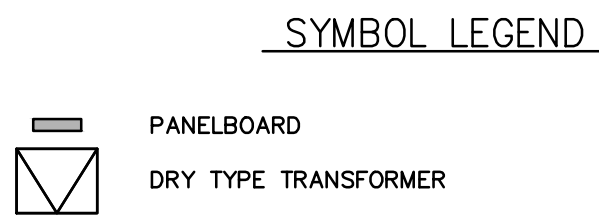


1 POWER PLAN - BASEMENT
E-200/ SCALE: 1/8"=1'-0"
8' 4' 0 8'
SCALE IN FEET

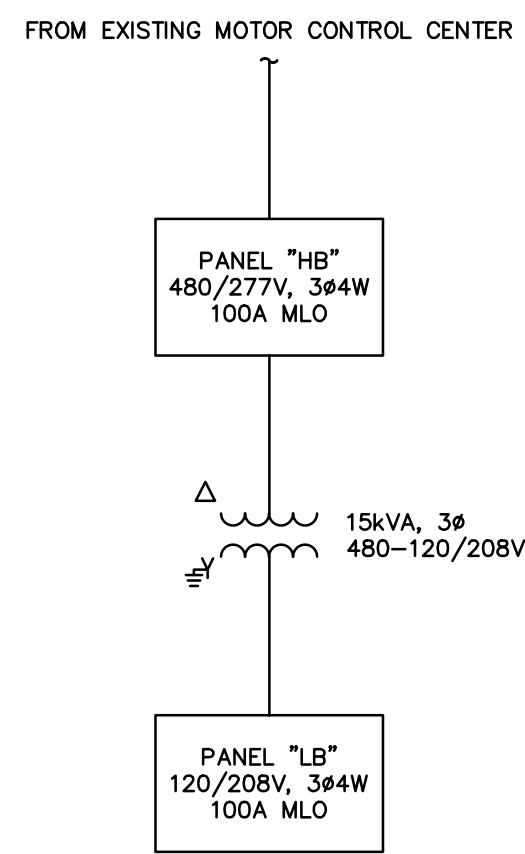

(REFERENCE ONLY, "EMERGENCY" PANELS NOT SHOWN)

2 PARTIAL SINGLE-LINE DIAGRAM
E-201/ SCALE: NONE

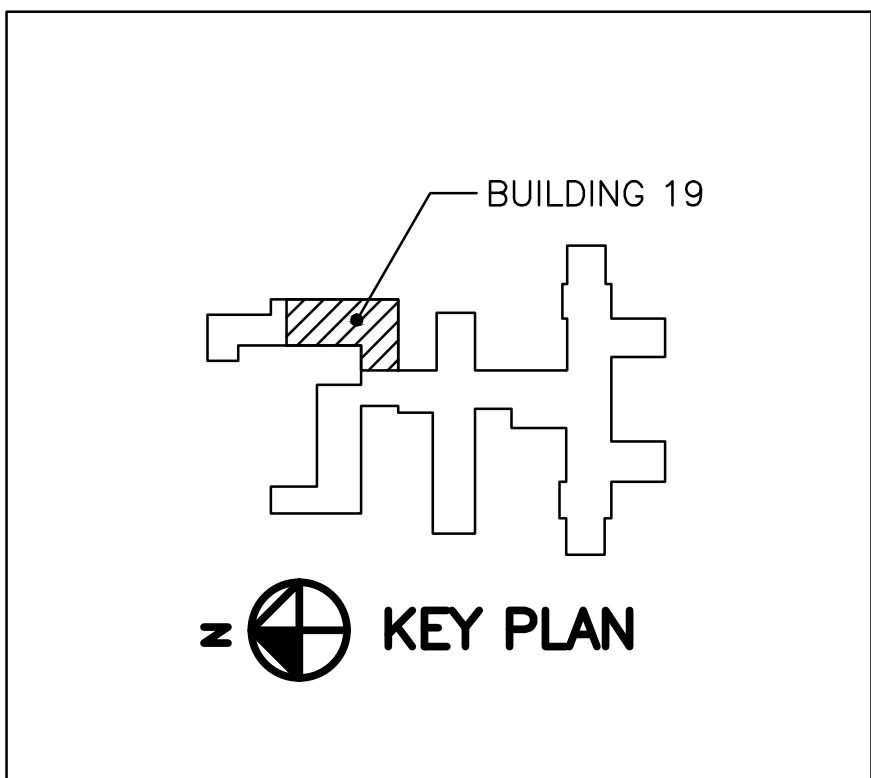

CONSULTANTS:		ARCHITECT/ENGINEERS:		Drawing Title BASEMENT POWER PLAN	Project Title BUILDING 19	Project Number	Office of OKC VAMC ENGINEERING PROJECTS Department of Veterans Affairs
				Approved Medical Center Director		Building Number Bldg. 1	
				Approved Chief, Engineers	Location VA MEDICAL CENTER OKLAHOMA CITY, OKLAHOMA	Drawing Number	
				Approved Chief, Projects	Date MAY 2012	Checked Drawn Dwg. 1 of 16	