

ONE INCH = FORTY FEET (1" = 40')

ONE AND ONE HALF INCHES = ONE FOOT

ONE QUARTER INCH = ONE FOOT

ONE HALF INCH = ONE FOOT

ONE QUARTER INCH = ONE FOOT

ONE EIGHT INCH = ONE FOOT

ONE SIXTEENTH INCH = ONE FOOT

**Roof Types Per RFI 4889 & 4889.1**

**R-MB2:** Typical roof to be used

**R-MB3:** Roof to be used at food service exhaust hood. Provide a 30ft. square centered on the exhaust outlet.

**R-MB4:** To be used on remaining existing roof construction of Dixie.

1 1-8 B8 Level ROOF  
1/8" = 1'-0"

REVISIONS:	DATE	CONSULTANTS:
		DESMAN ASSOCIATES / PARKING
		CODE CONSULTANTS, INC. / CODE CONSULTANT
		THE SEXTANT GROUP / AV & ACOUSTICAL
		HAMMER DESIGN ASSOCIATES / FOOD SERVICE
		PYBURN & ODOM / ABATEMENT
		TATA & HOWARD / TANK CONSULTANT
		I.S.C. GROUP, INC. / IRRIGATION
		DAN EUSER WATER ARCHITECTURE, INC. / WATER FEATURE



**ARCHITECT/ENGINEERS:**

studio **NOVA**

SCHRENK & PETERSON CONSULTING ENGINEERS / CIVIL  
KORDA/NEMETH ENGINEERING / STRUCTURAL  
BR+A CONSULTING ENGINEERS / MECH. ELECT. PLUMBING, LOW VOLTAGE  
ARCHITECTURAL ENGINEERING / PLUMBING  
SCALES ASSOCIATES / FIRE PROTECTION

DRAWING TITLE  
BLDG 8 ROOF PLAN

APPROVED: PROJECT DIRECTOR  
*Judd Sanders*

PROJECT TITLE  
SLVHCS REPLACEMENT MEDICAL CENTER PROJECT

LOCATION  
NEW ORLEANS, LOUISIANA

DATE  
July 16, 2012

CHECKED  
JR

DRAWN  
DS

PROJECT NUMBER  
100342.00


BUILDING NUMBER  
08

DOCUMENT SET PACKAGE  
WP\_09B

DRAWING NUMBER  
**8AS106**

OFFICE OF  
CONSTRUCTION  
AND FACILITIES  
MANAGEMENT

Department of  
Veterans Affairs

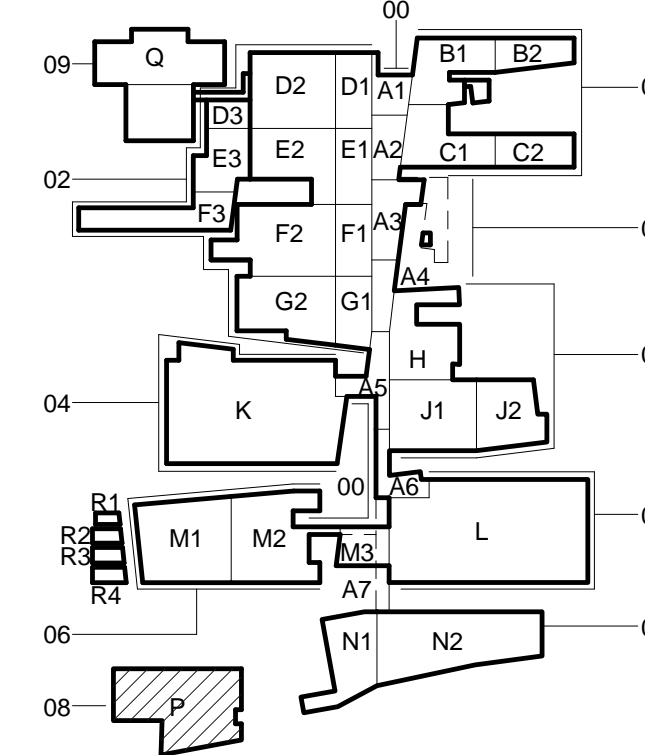

CONSTRUCTION DOCUMENTS 1  
FULLY SPRINKLERED