

ONE INCH = FORTY FEET (1"=40')

THREE INCHES = ONE FOOT

ONE AND ONE HALF INCHES = ONE FOOT


THREE QUARTERS INCH = ONE FOOT

ONE HALF INCH = ONE FOOT


ONE QUARTER INCH = ONE FOOT

ONE EIGHT INCH = ONE FOOT


ONE SIXTEENTH INCH = ONE FOOT

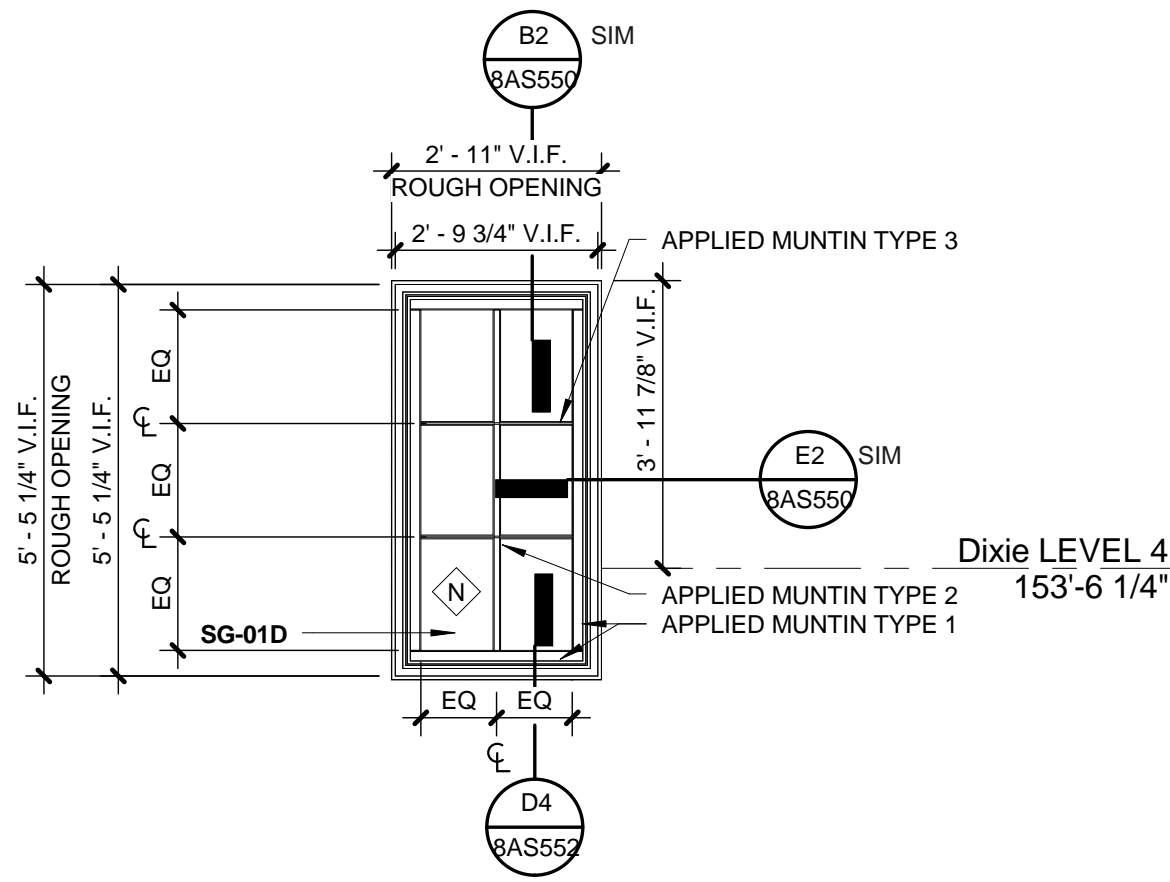


B6 DIXIE INFILL WINDOW AT FORTH FLOOR TULANE WALL
SCALE: 3/8" = 1'-0"

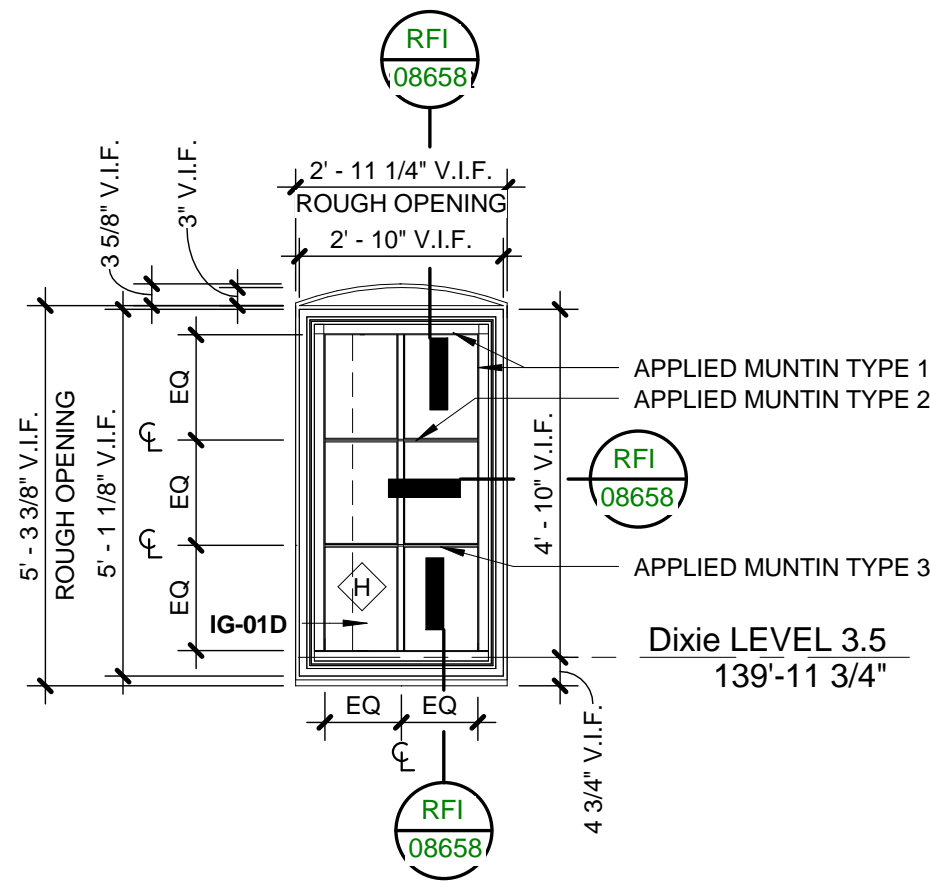


C6 DIXIE INFILL WINDOW AT THIRD FLOOR TULANE WALL
SCALE: 3/8" = 1'-0"

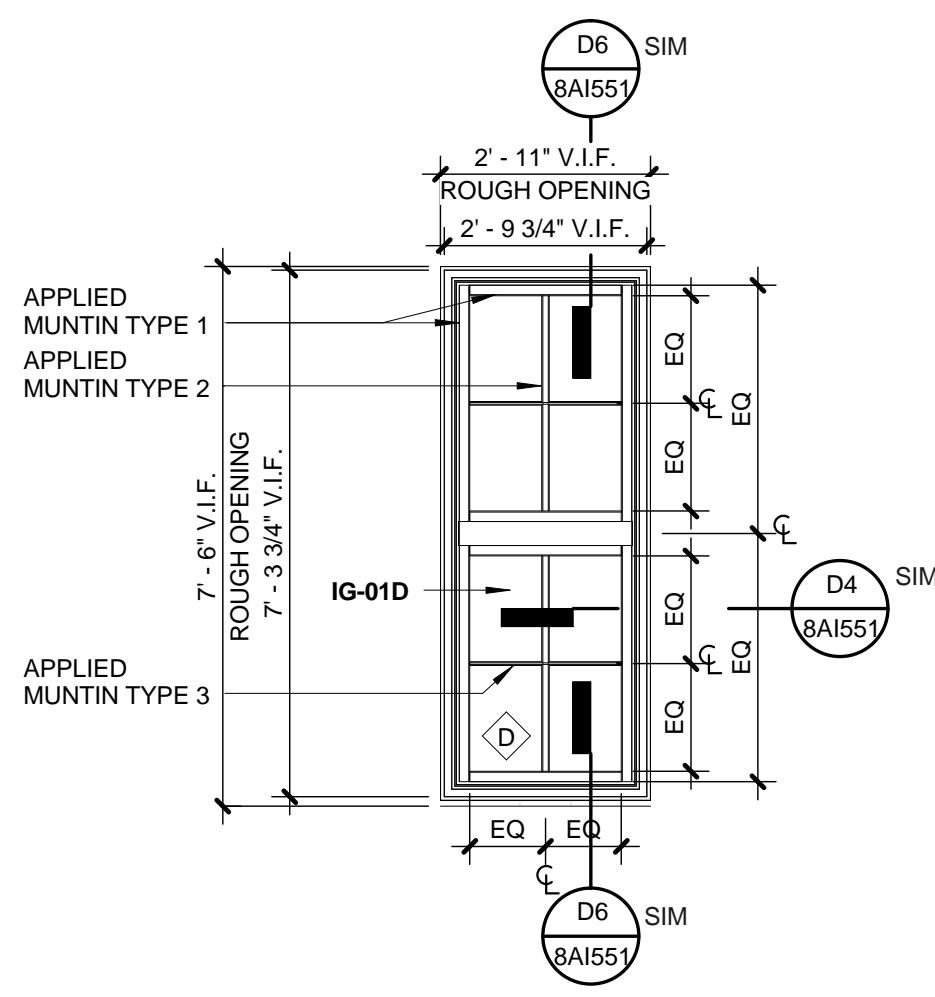


E6 DIXIE INFILL WINDOW AT SECOND FLOOR TULANE WALL
SCALE: 3/8" = 1'-0"

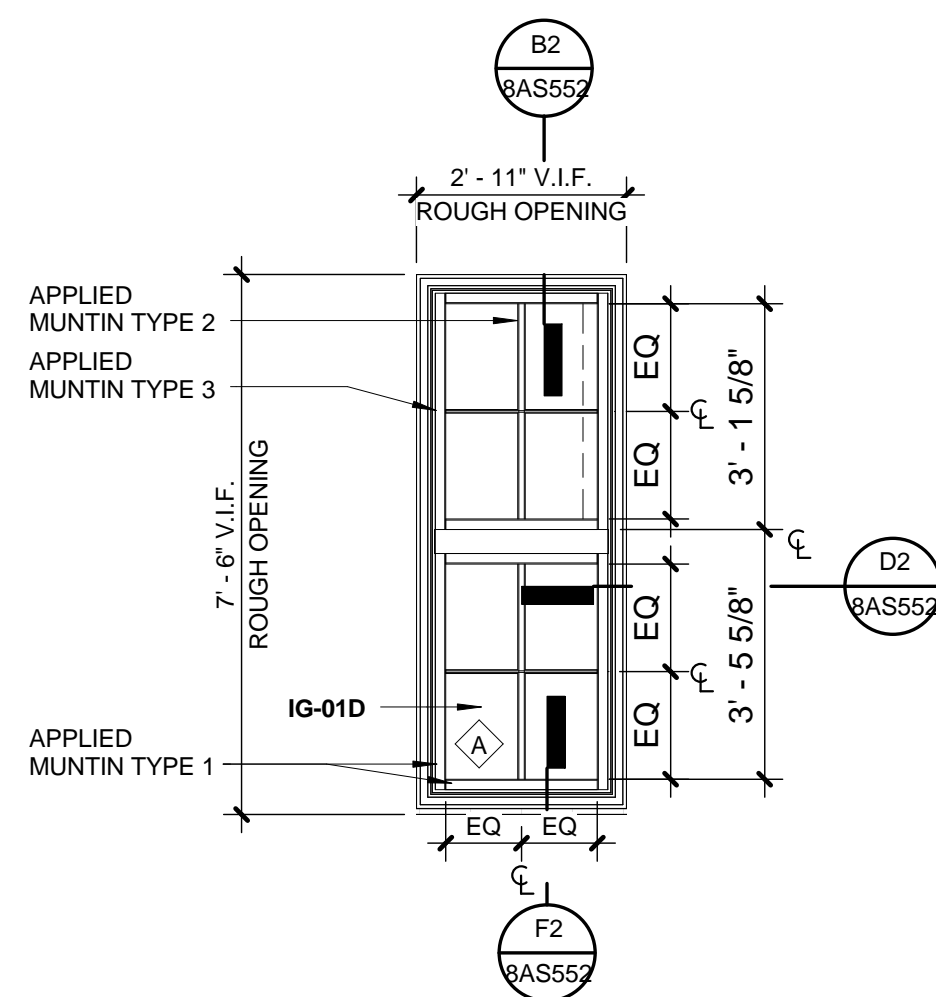


F6 DIXIE INFILL WINDOW AT FIRST FLOOR TULANE WALL
SCALE: 3/8" = 1'-0"

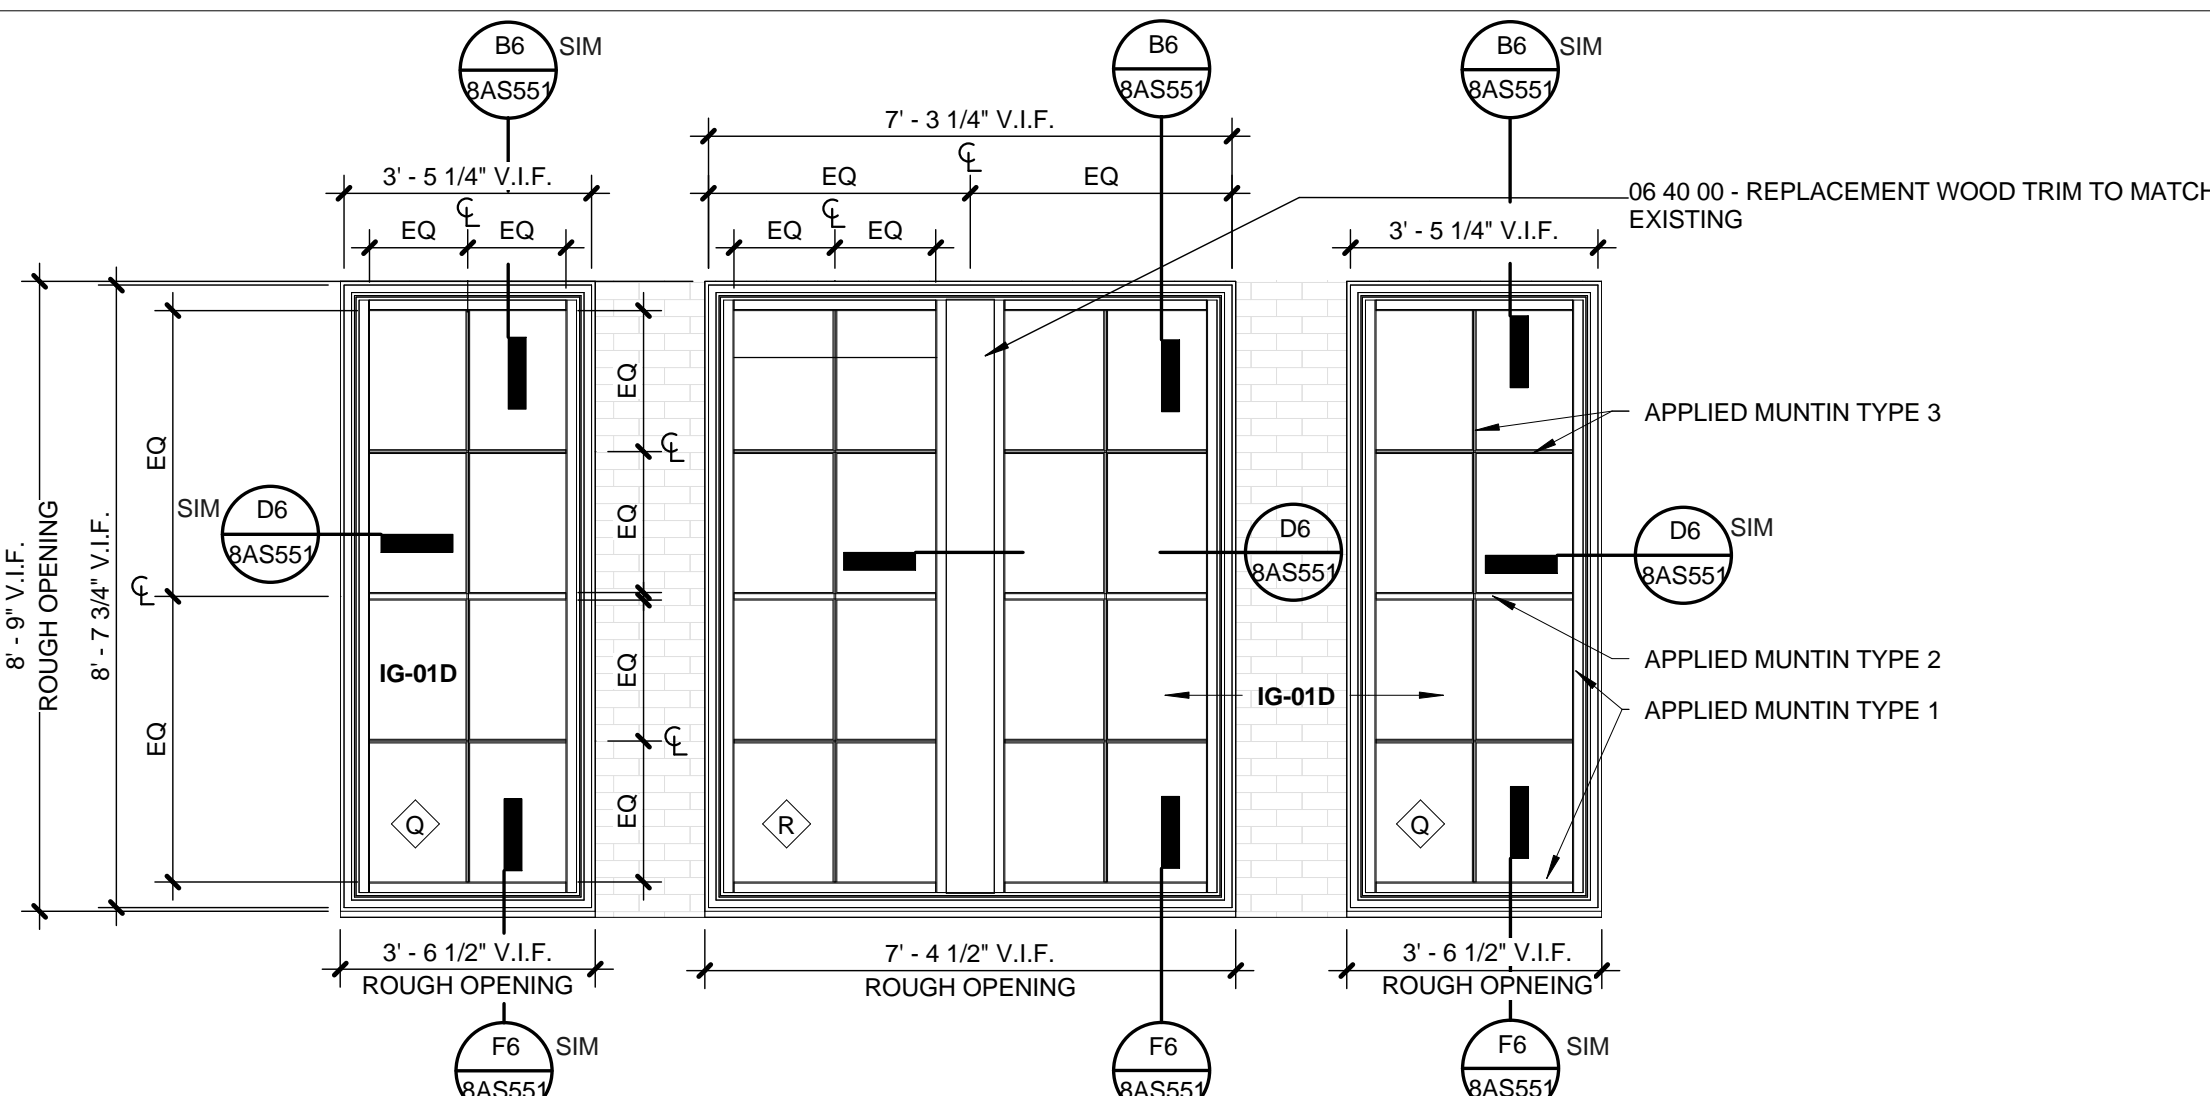


B5 DIXIE INFILL WINDOW AT FIFTH FLOOR UNDER DOME
SCALE: 3/8" = 1'-0"

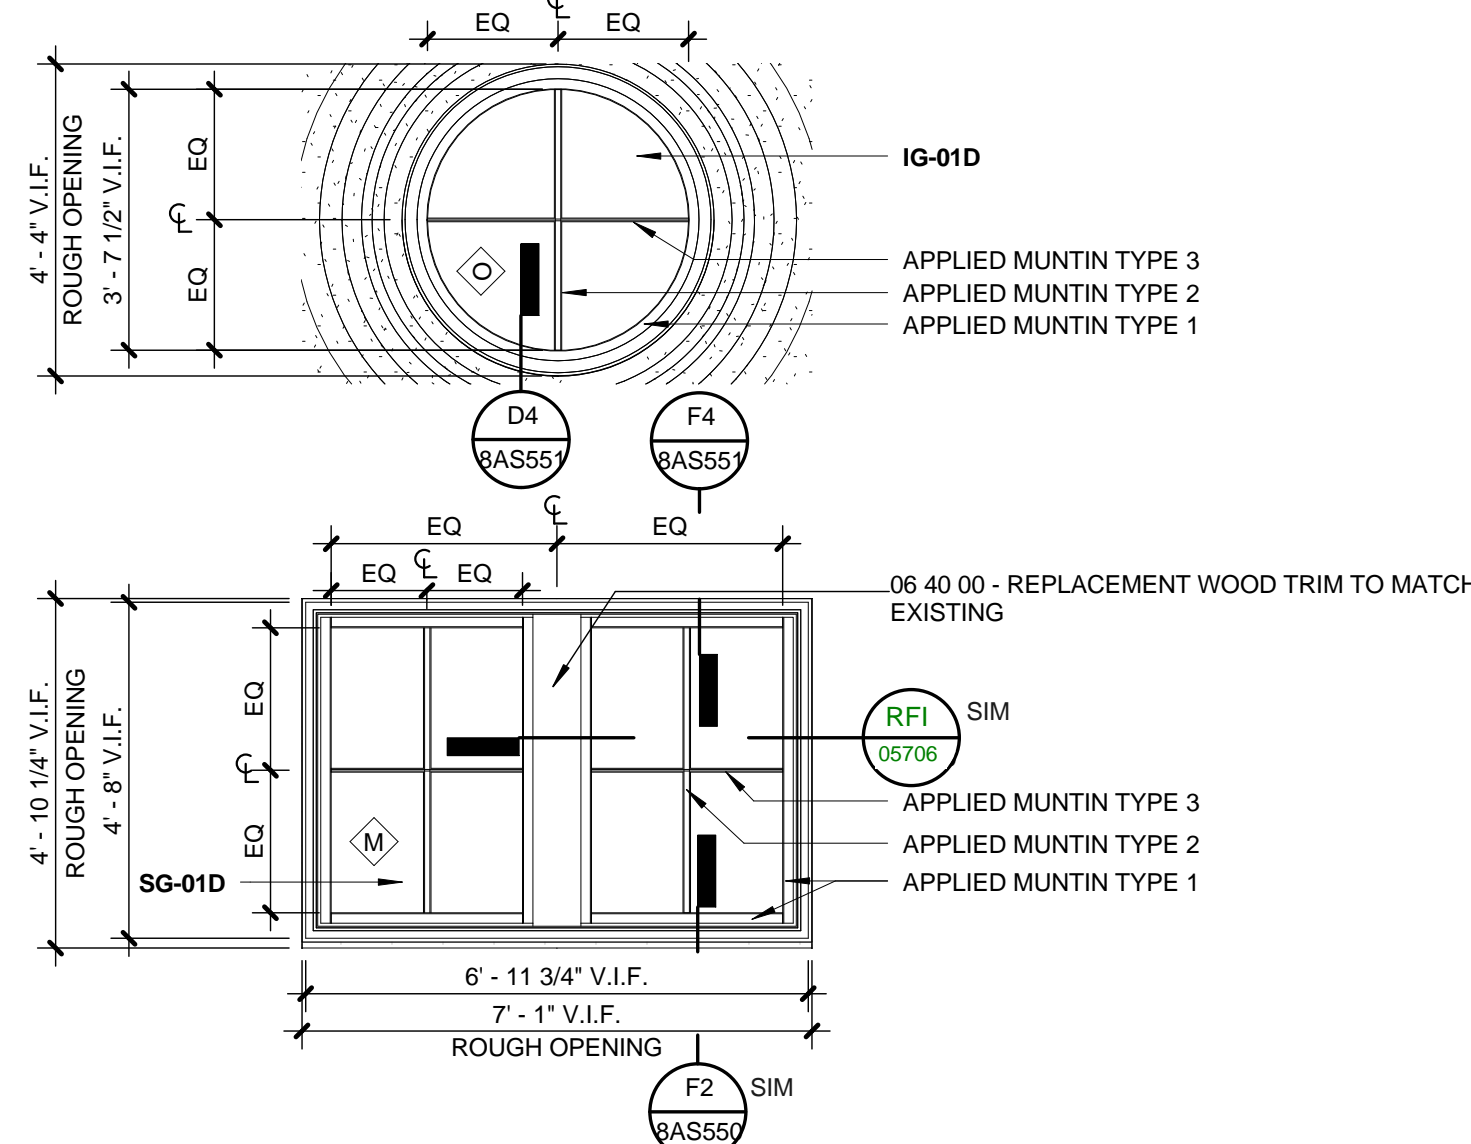


D5 DIXIE INFILL WINDOW AT FOURTH FLOOR UNDER DOME
SCALE: 3/8" = 1'-0"

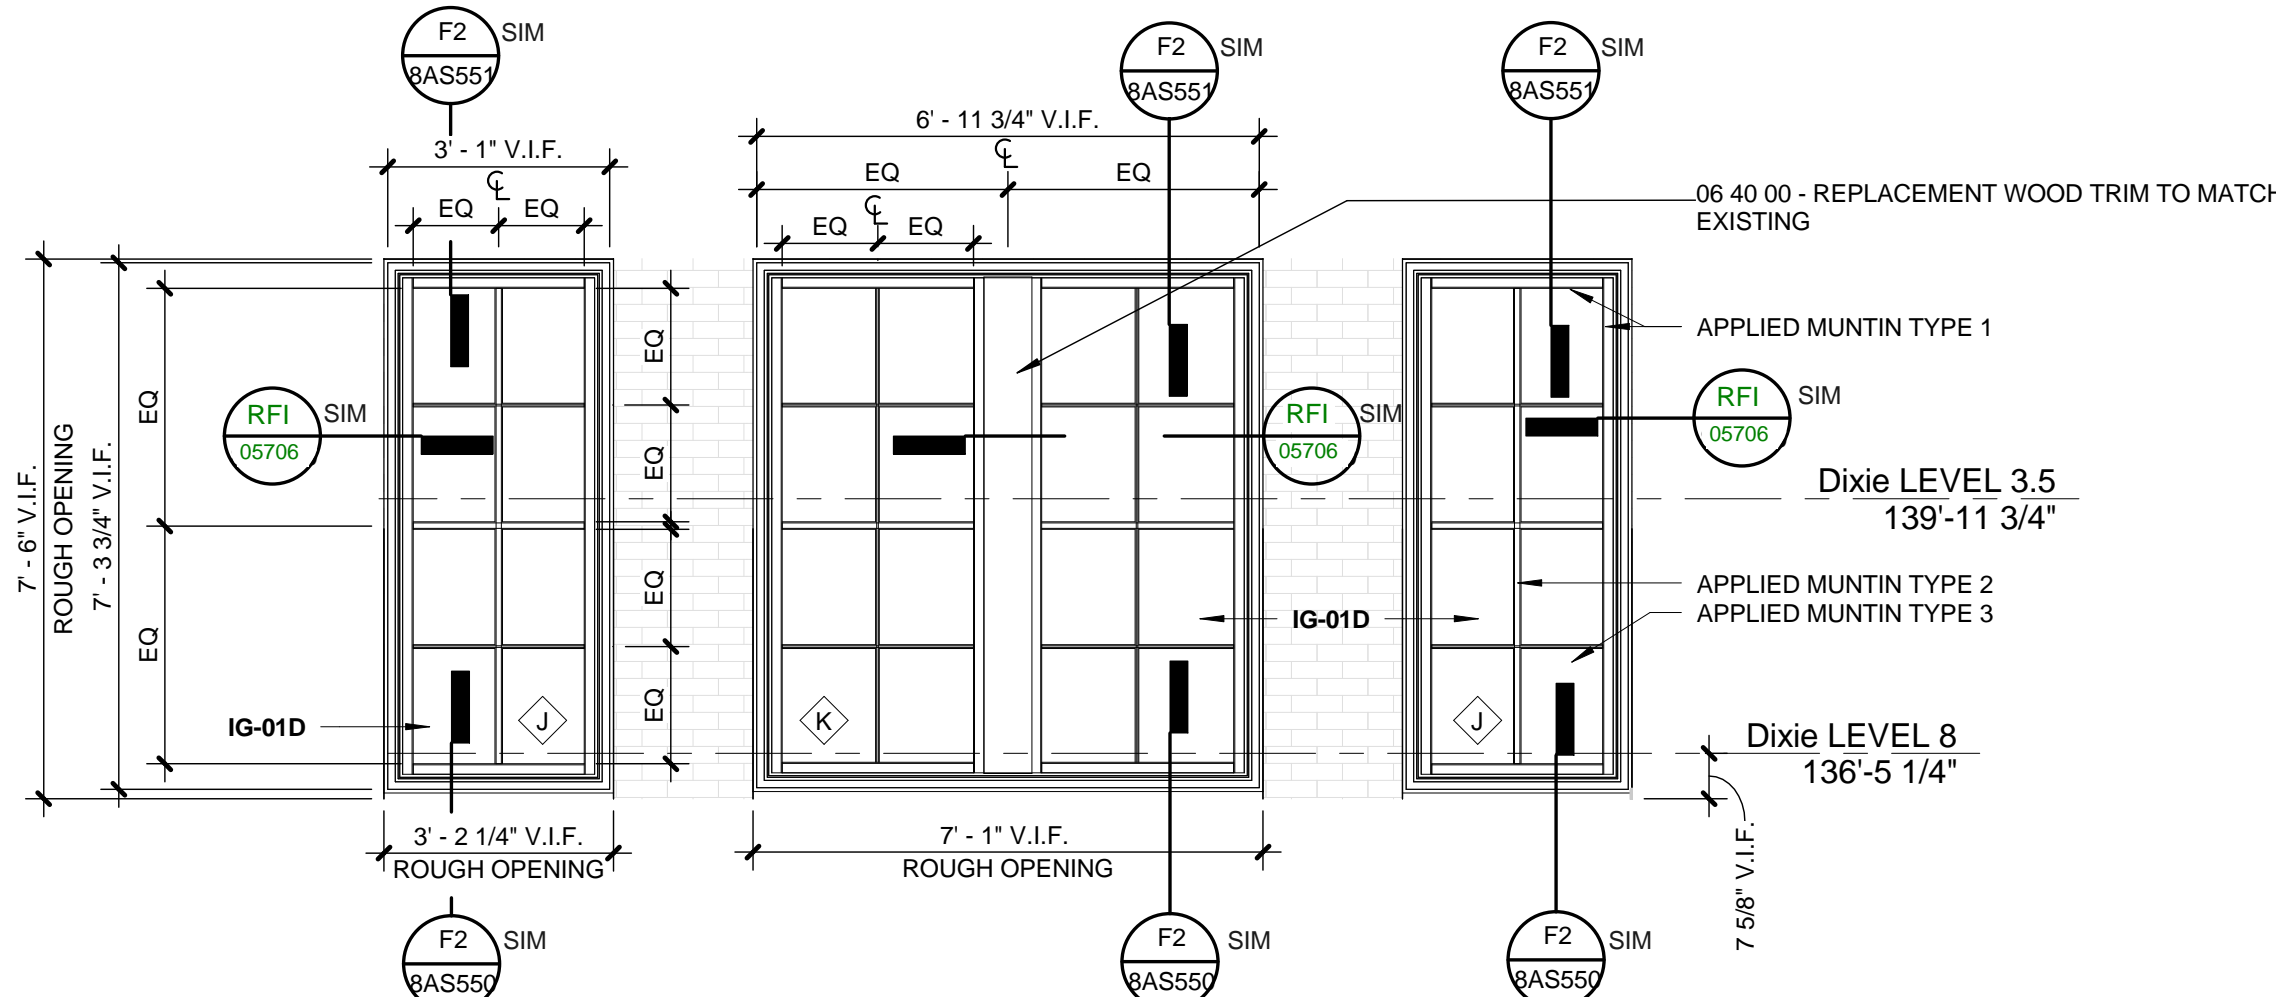


E5 DIXIE INFILL WINDOW AT THIRD FLOOR UNDER DOME
SCALE: 3/8" = 1'-0"

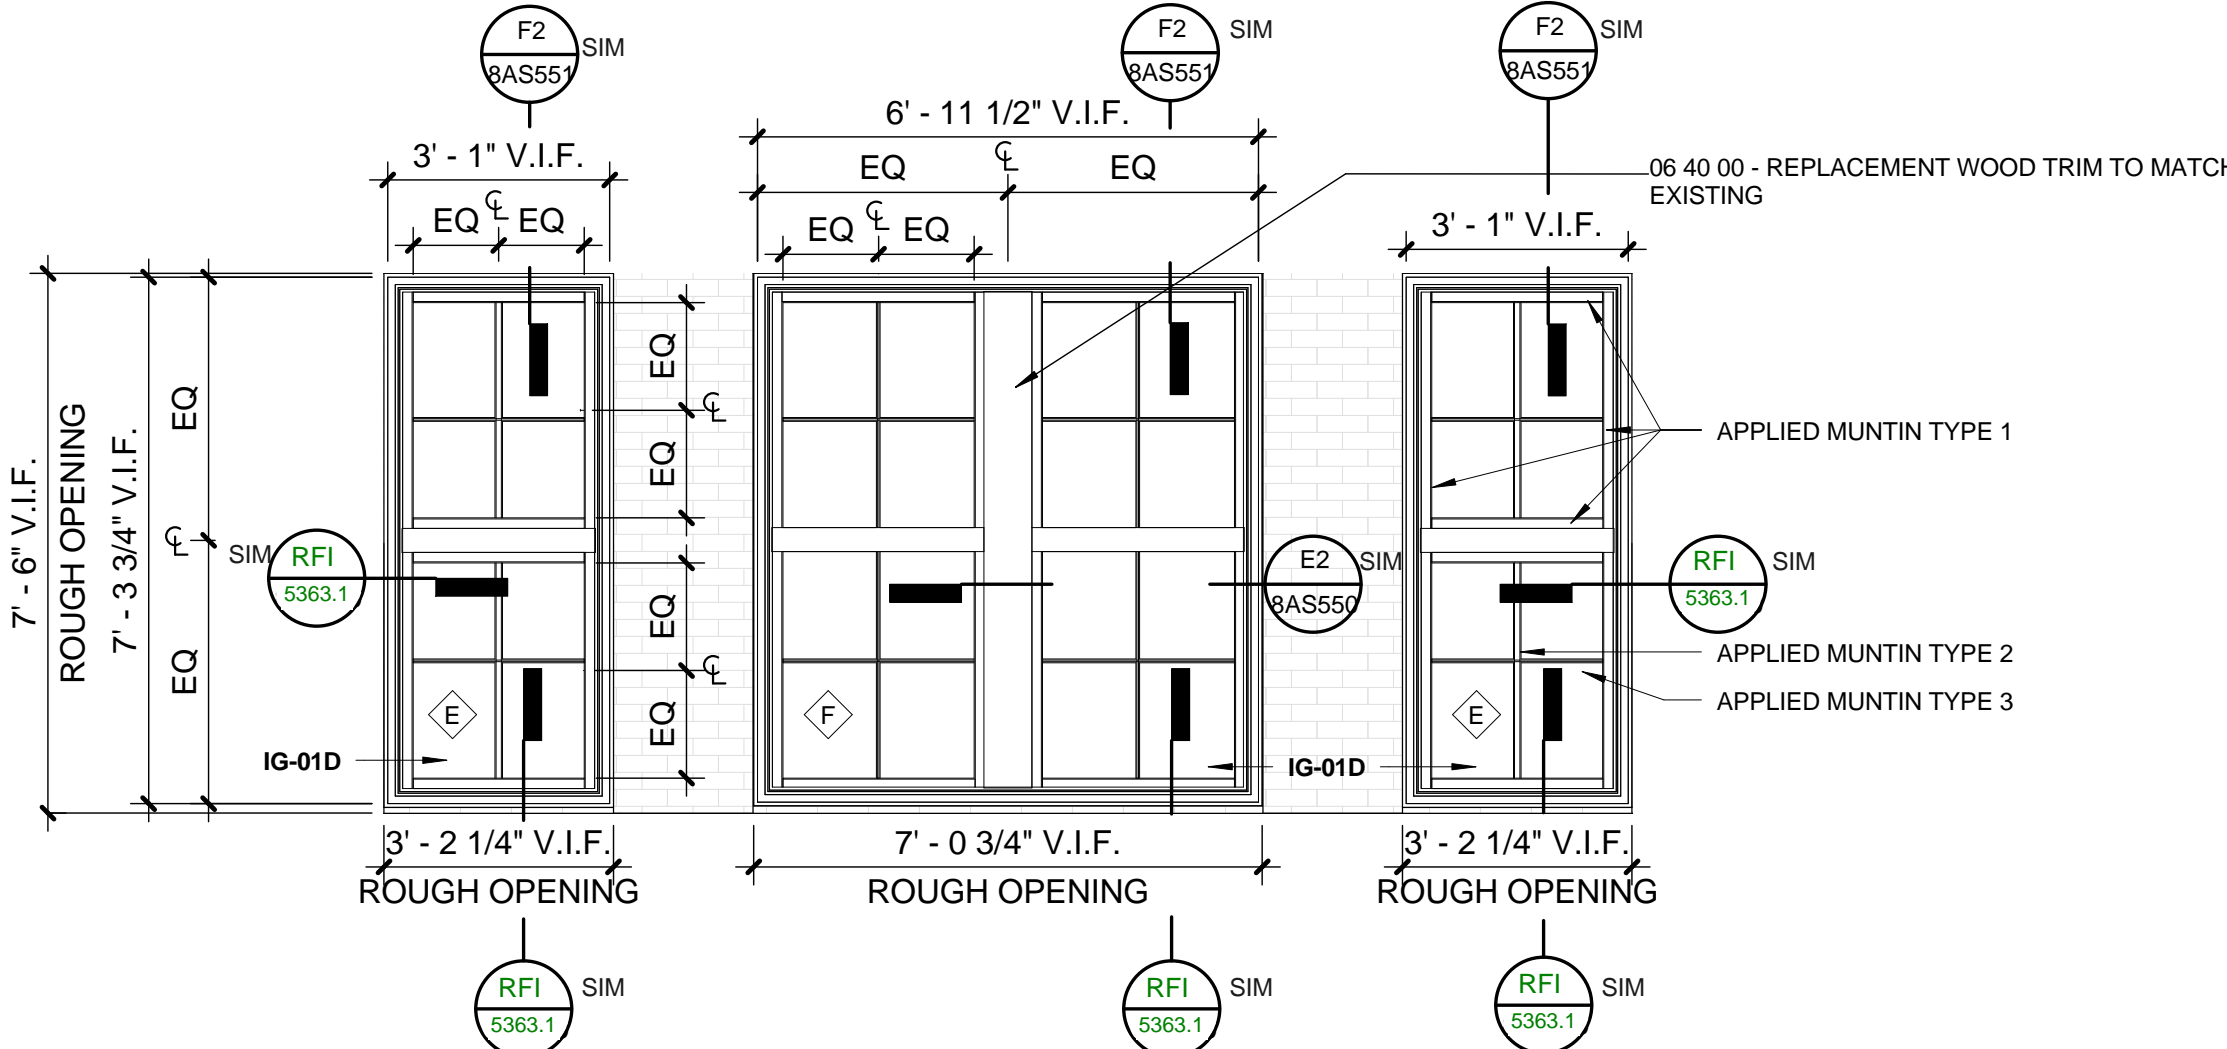


F5 DIXIE INFILL WINDOW AT SECOND FLOOR UNDER DOME
SCALE: 3/8" = 1'-0"

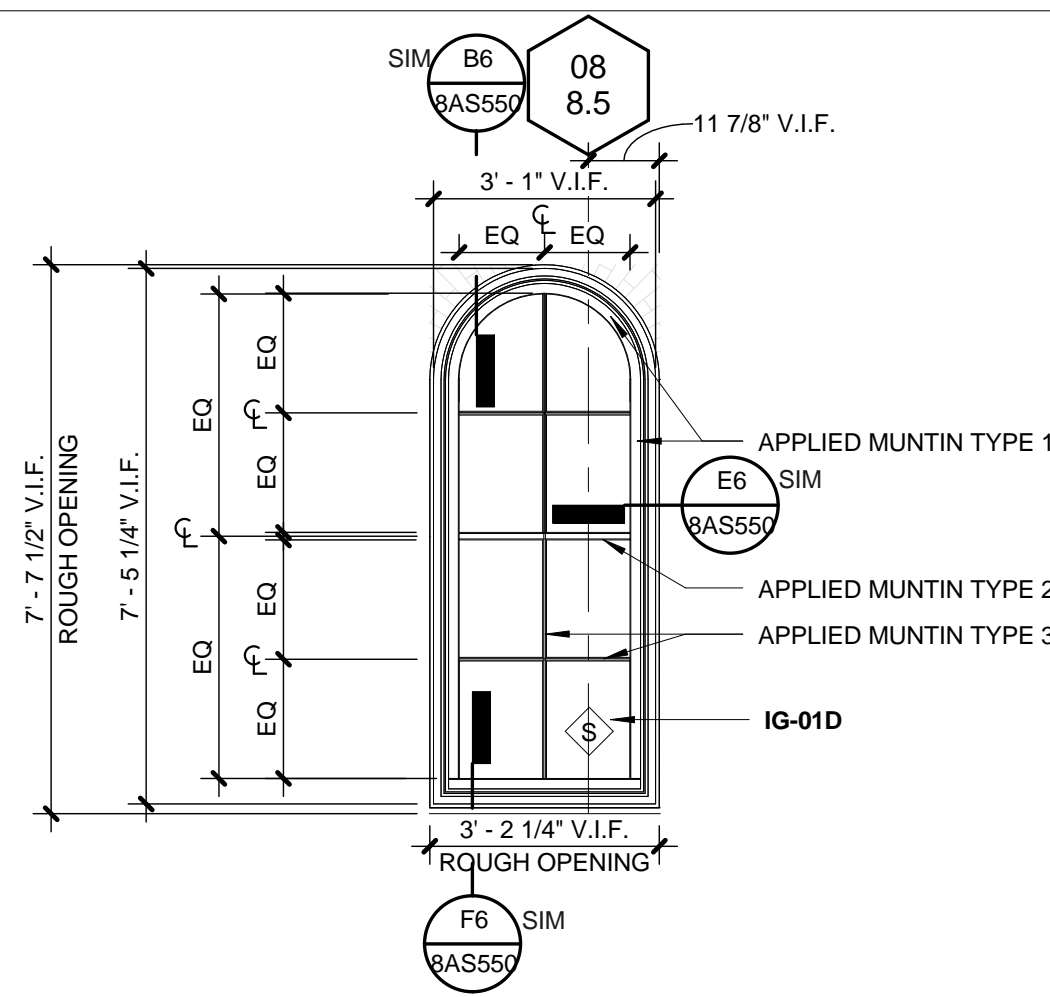

B3 DIXIE INFILL WINDOW AT FIFTH FLOOR TONTI WALL
SCALE: 3/8" = 1'-0"

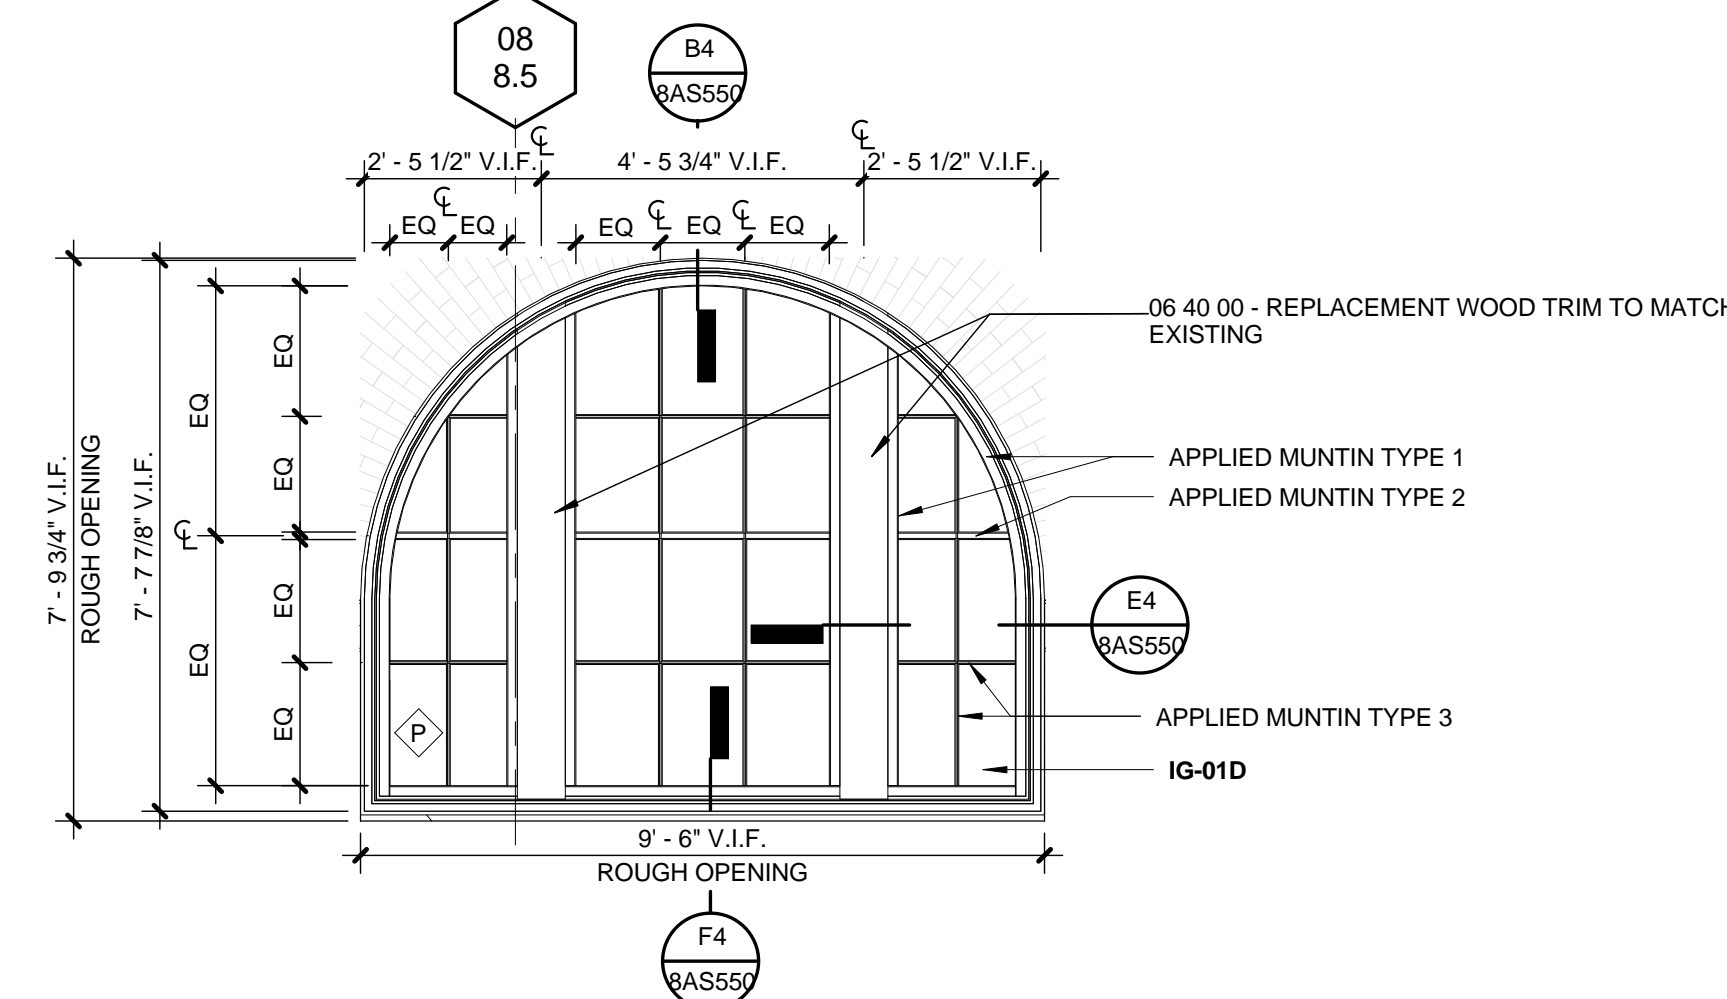

E3 DIXIE INFILL WINDOW AT SECOND FLOOR TONTI WALL
SIMILAR AT LEVEL 3 AND 3.5
SCALE: 3/8" = 1'-0"

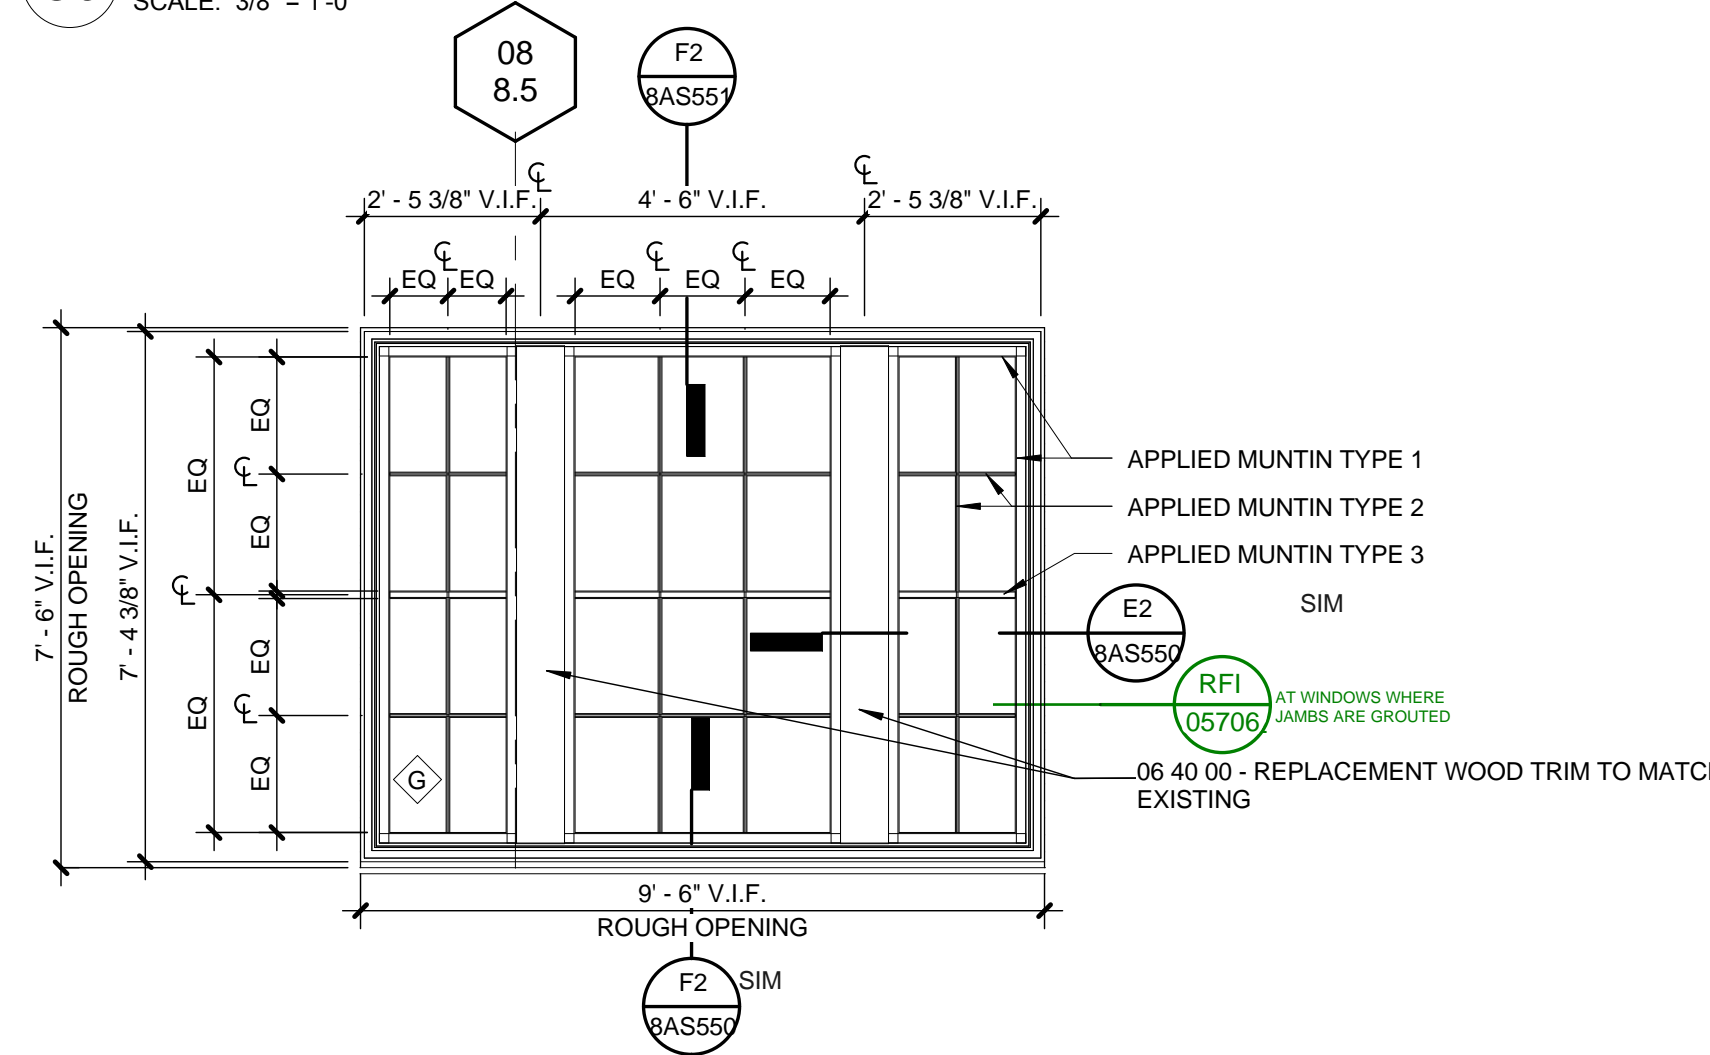


F3 DIXIE INFILL WINDOW AT FIRST FLOOR TONTI WALL
SCALE: 3/8" = 1'-0"

CLARIFICATION OF REFERENCE DESIGNATIONS FOR GLASS TYPES


IG-01D	INSULATED LAMINATED VISION IMPACT GLAZING (08 88 53)
IG-01TD	INSULATED LAMINATED VISION IMPACT SAFETY GLAZING (08 88 53)
SG-01D	INSULATED LAMINATED SPANDREL IMPACT GLAZING (08 88 53)
SLG-5	LAMINATED VISION IMPACT SAFETY GLAZING (08 88 53)

NOTES:


- DIXIE INFILL WINDOW LOCATIONS NOTED ON FLOOR PLANS
- MULLION AND APPLIED GRID LOCATIONS TO MATCH EXISTING, V.I.F.

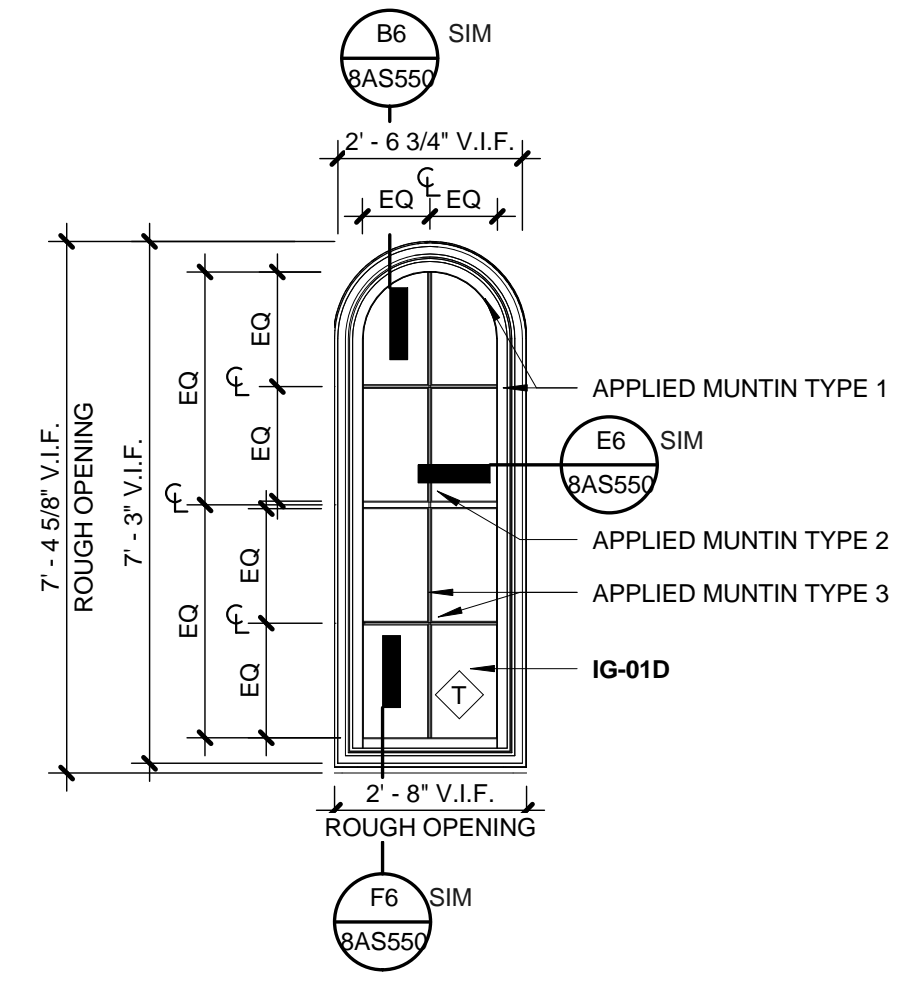

C2 DIXIE INFILL WINDOW AT FIFTH FLOOR TURRET
SCALE: 3/8" = 1'-0"

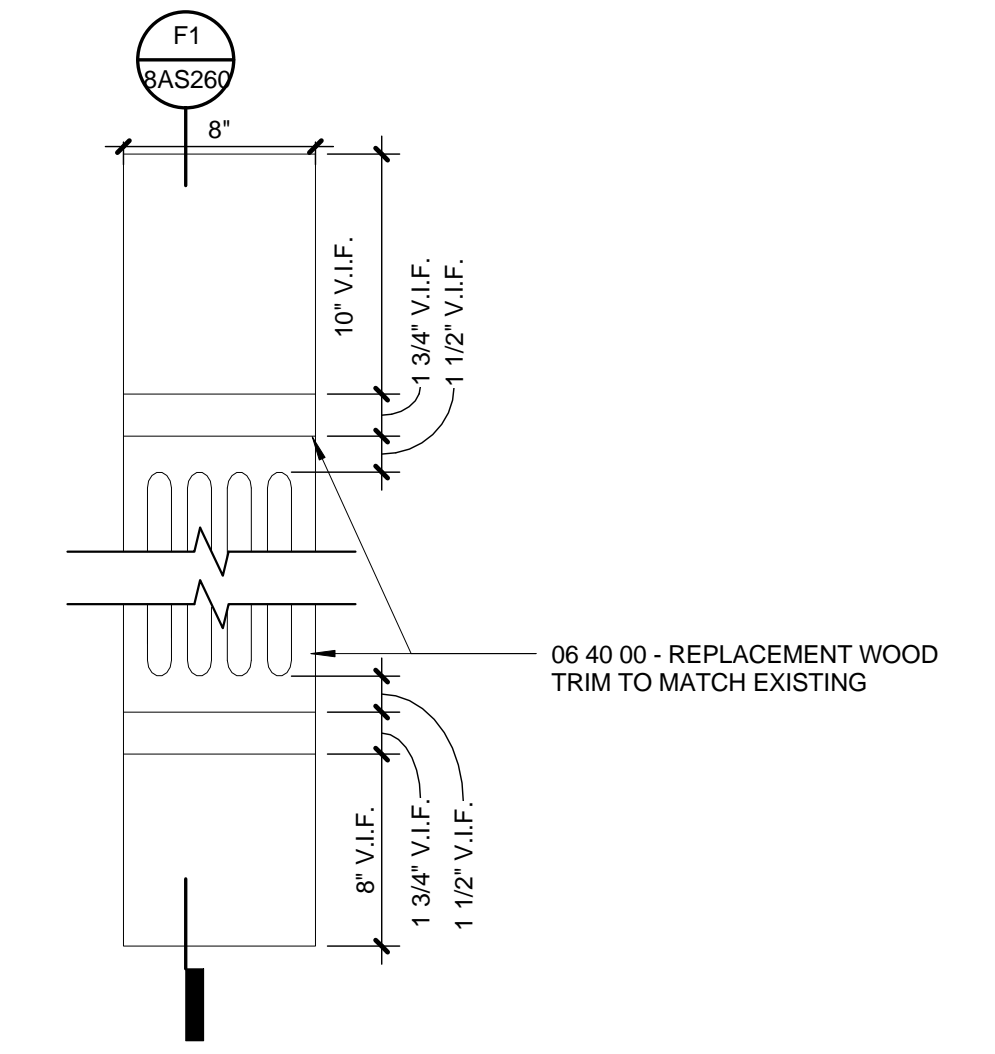

D1 ELEVATION OF REPLACEMENT WOOD TRIM AT VERTICAL CURTAIN WALL MULLION TYP.
SCALE: 1 1/2" = 1'-0"

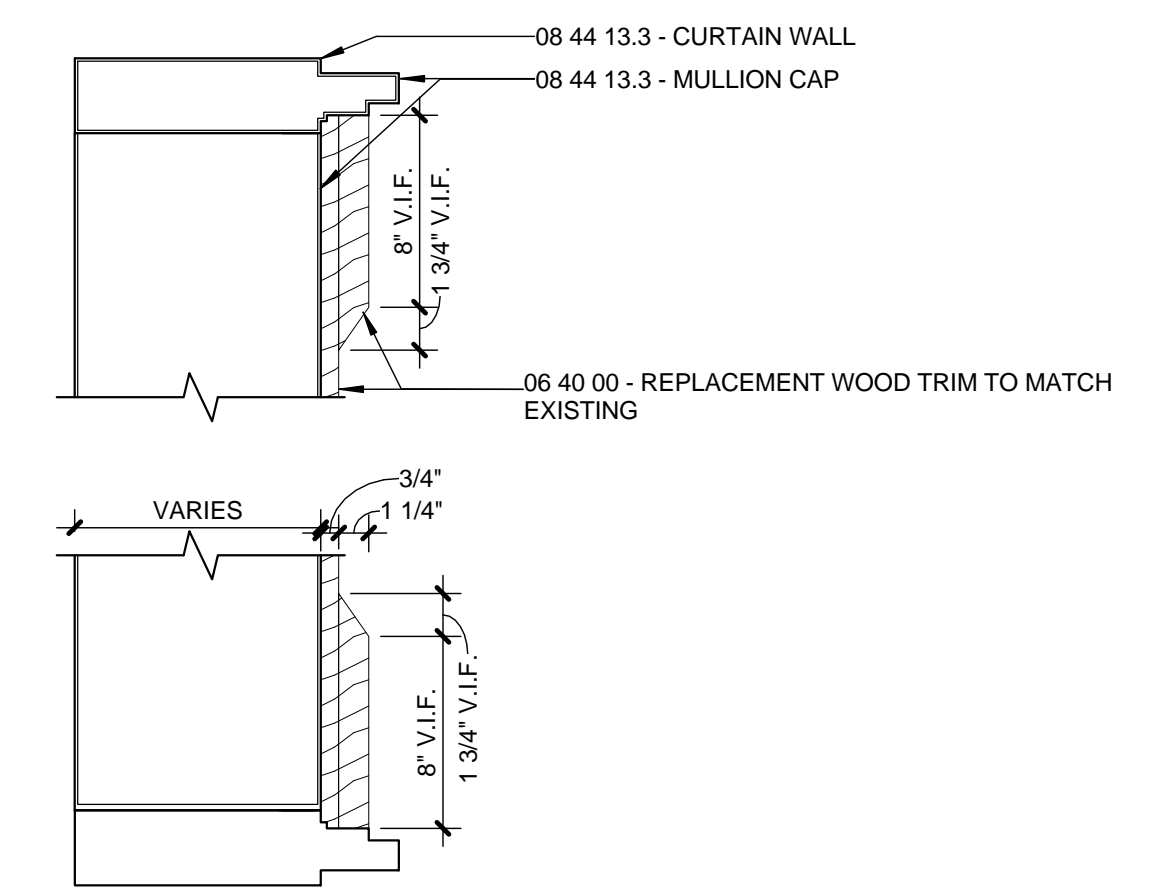

F1 SECTION THRU REPLACEMENT WOOD TRIM AT VERTICAL CURTAIN WALL MULLIONS TYP.
SCALE: 1 1/2" = 1'-0"

CONSULTANTS:

DESMAN ASSOCIATES / PARKING
CODE CONSULTANTS, INC / CODE CONSULTANT
THE SEXTANT GROUP / AV & ACOUSTICAL
HAMMER DESIGN ASSOCIATES / FOOD SERVICE
PYBURN & ODOM / ABATEMENT
TATA & HOWARD / TANK CONSULTANT
I.S.C. GROUP, INC / IRRIGATION
DAN EUSER WATER ARCHITECTURE, INC / WATER FEATURE

ARCHITECT/ENGINEERS:

studio **NOVA**
SCHRENK & PETERSON CONSULTING ENGINEERS / CIVIL
KORDA/NEMETH ENGINEERING / STRUCTURAL
BR+A CONSULTING ENGINEERS / MECH & ELEC
ARCHITECTURAL ENGINEERING / PLUMBING
SCALES ASSOCIATES / FIRE PROTECTION
COMMUNICATIONS DESIGN GROUP / LOW VOLTAGE

DRAWING TITLE
BLDG 8 DIXIE CURTAINWALL ELEVATIONS

APPROVED: PROJECT DIRECTOR

John J. Sanchez

PROJECT TITLE
SLVHCS REPLACEMENT MEDICAL CENTER PROJECT

LOCATION
NEW ORLEANS, LOUISIANA

DATE
July 16, 2012

CHECKED
CD

DRAWN
DD

PROJECT NUMBER
629-HS2-401

BUILDING NUMBER
8

DOCUMENT SET PACKAGE
WP_9B

DRAWING NUMBER

8AS260

OFFICE OF
CONSTRUCTION
AND FACILITIES
MANAGEMENT

Department of
Veterans Affairs