

CONSTRUCTION DOCUMENTS 1  
FULLY SPRINKLERED

OFFICE OF  
CONSTRUCTION  
AND FACILITIES  
MANAGEMENT



CONSULTANTS:

<p>DESMAN ASSOCIATES / PARKING</p> <p>CODE CONSULTANTS, INC. / CODE CONSULTANT</p> <p>THE SEXTANT GROUP / AV &amp; ACOUSTICAL</p> <p>HAMMER DESIGN ASSOCIATES / FOOD SERVICE</p> <p>PYBURN &amp; ODOM / ABATEMENT</p> <p>TATA &amp; HOWARD / TANK CONSULTANT</p> <p>I.S.C. GROUP, INC. / IRRIGATION</p> <p>DAN EUSER WATER ARCHITECTURE, INC. / WATER FEATURE</p>
---



ARCHITECT/ENGINEERS:

studio **NOVA**

SCHRENK & PETERSON CONSULTING ENGINEERS / CIVIL  
KORDA/NEMETH ENGINEERING / STRUCTURAL  
BR+A CONSULTING ENGINEERS / MECH, ELECT, PLUMBING, LOW VOLTAGE  
ARCHITECTURAL ENGINEERING/ PLUMBING  
SCALES ASSOCIATES / FIRE PROTECTION

DRAWING TITLE  
BUILDING 08 - SECURITY PARTIAL PLAN - CAFE  
ADD ALTERNATE #1

APPROVED: PROJECT DIRECTOR

Jadd Sanders

PROJECT TITLE  
SLVHCS REPLACEMENT MEDICAL  
CENTER PROJECT

LOCATION  
NEW ORLEANS, LOUISIANA

DATE  
July 16, 2012

CHECKED  
JLE


DRAWN  
JJP

PROJECT NUMBER 629-HS2-401	BUILDING NUMBER 08
DOCUMENT SET PACKAGE WP_09B	


DRAWING NUMBER

8TY500


VA FORM 08-6231

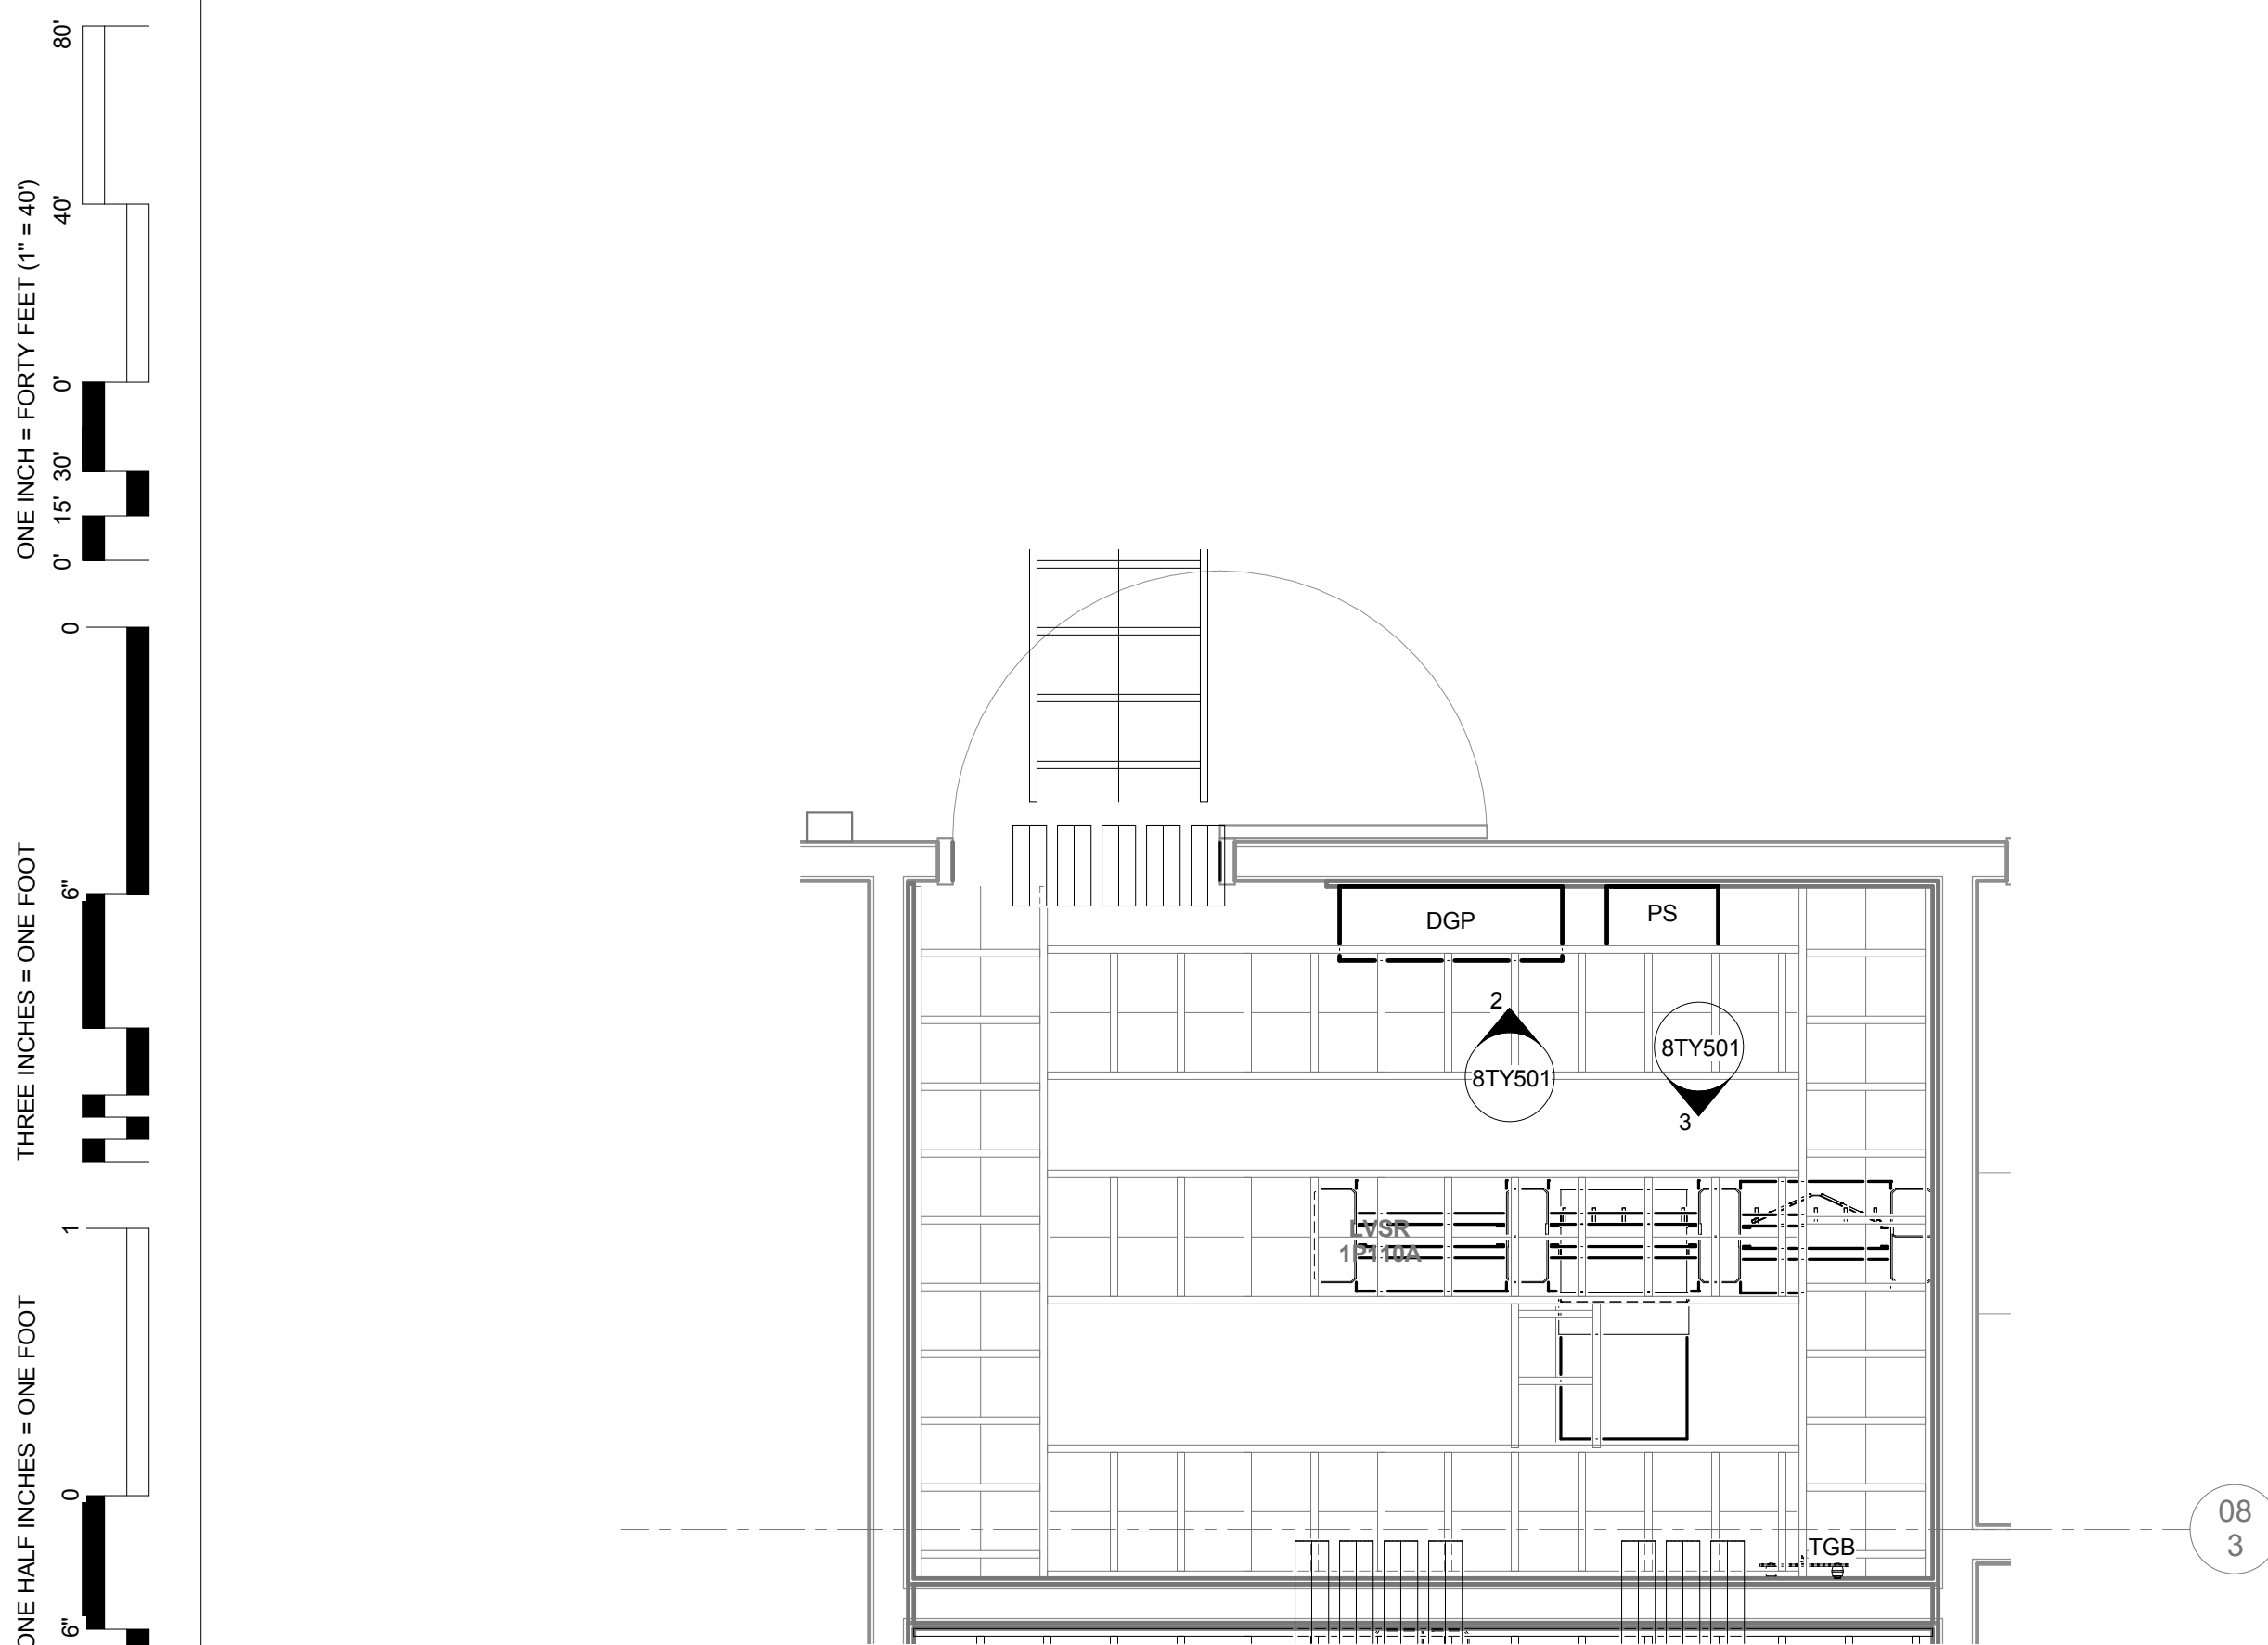


1 PART PLAN LVSR 1P110  
1/2" = 1'-0"

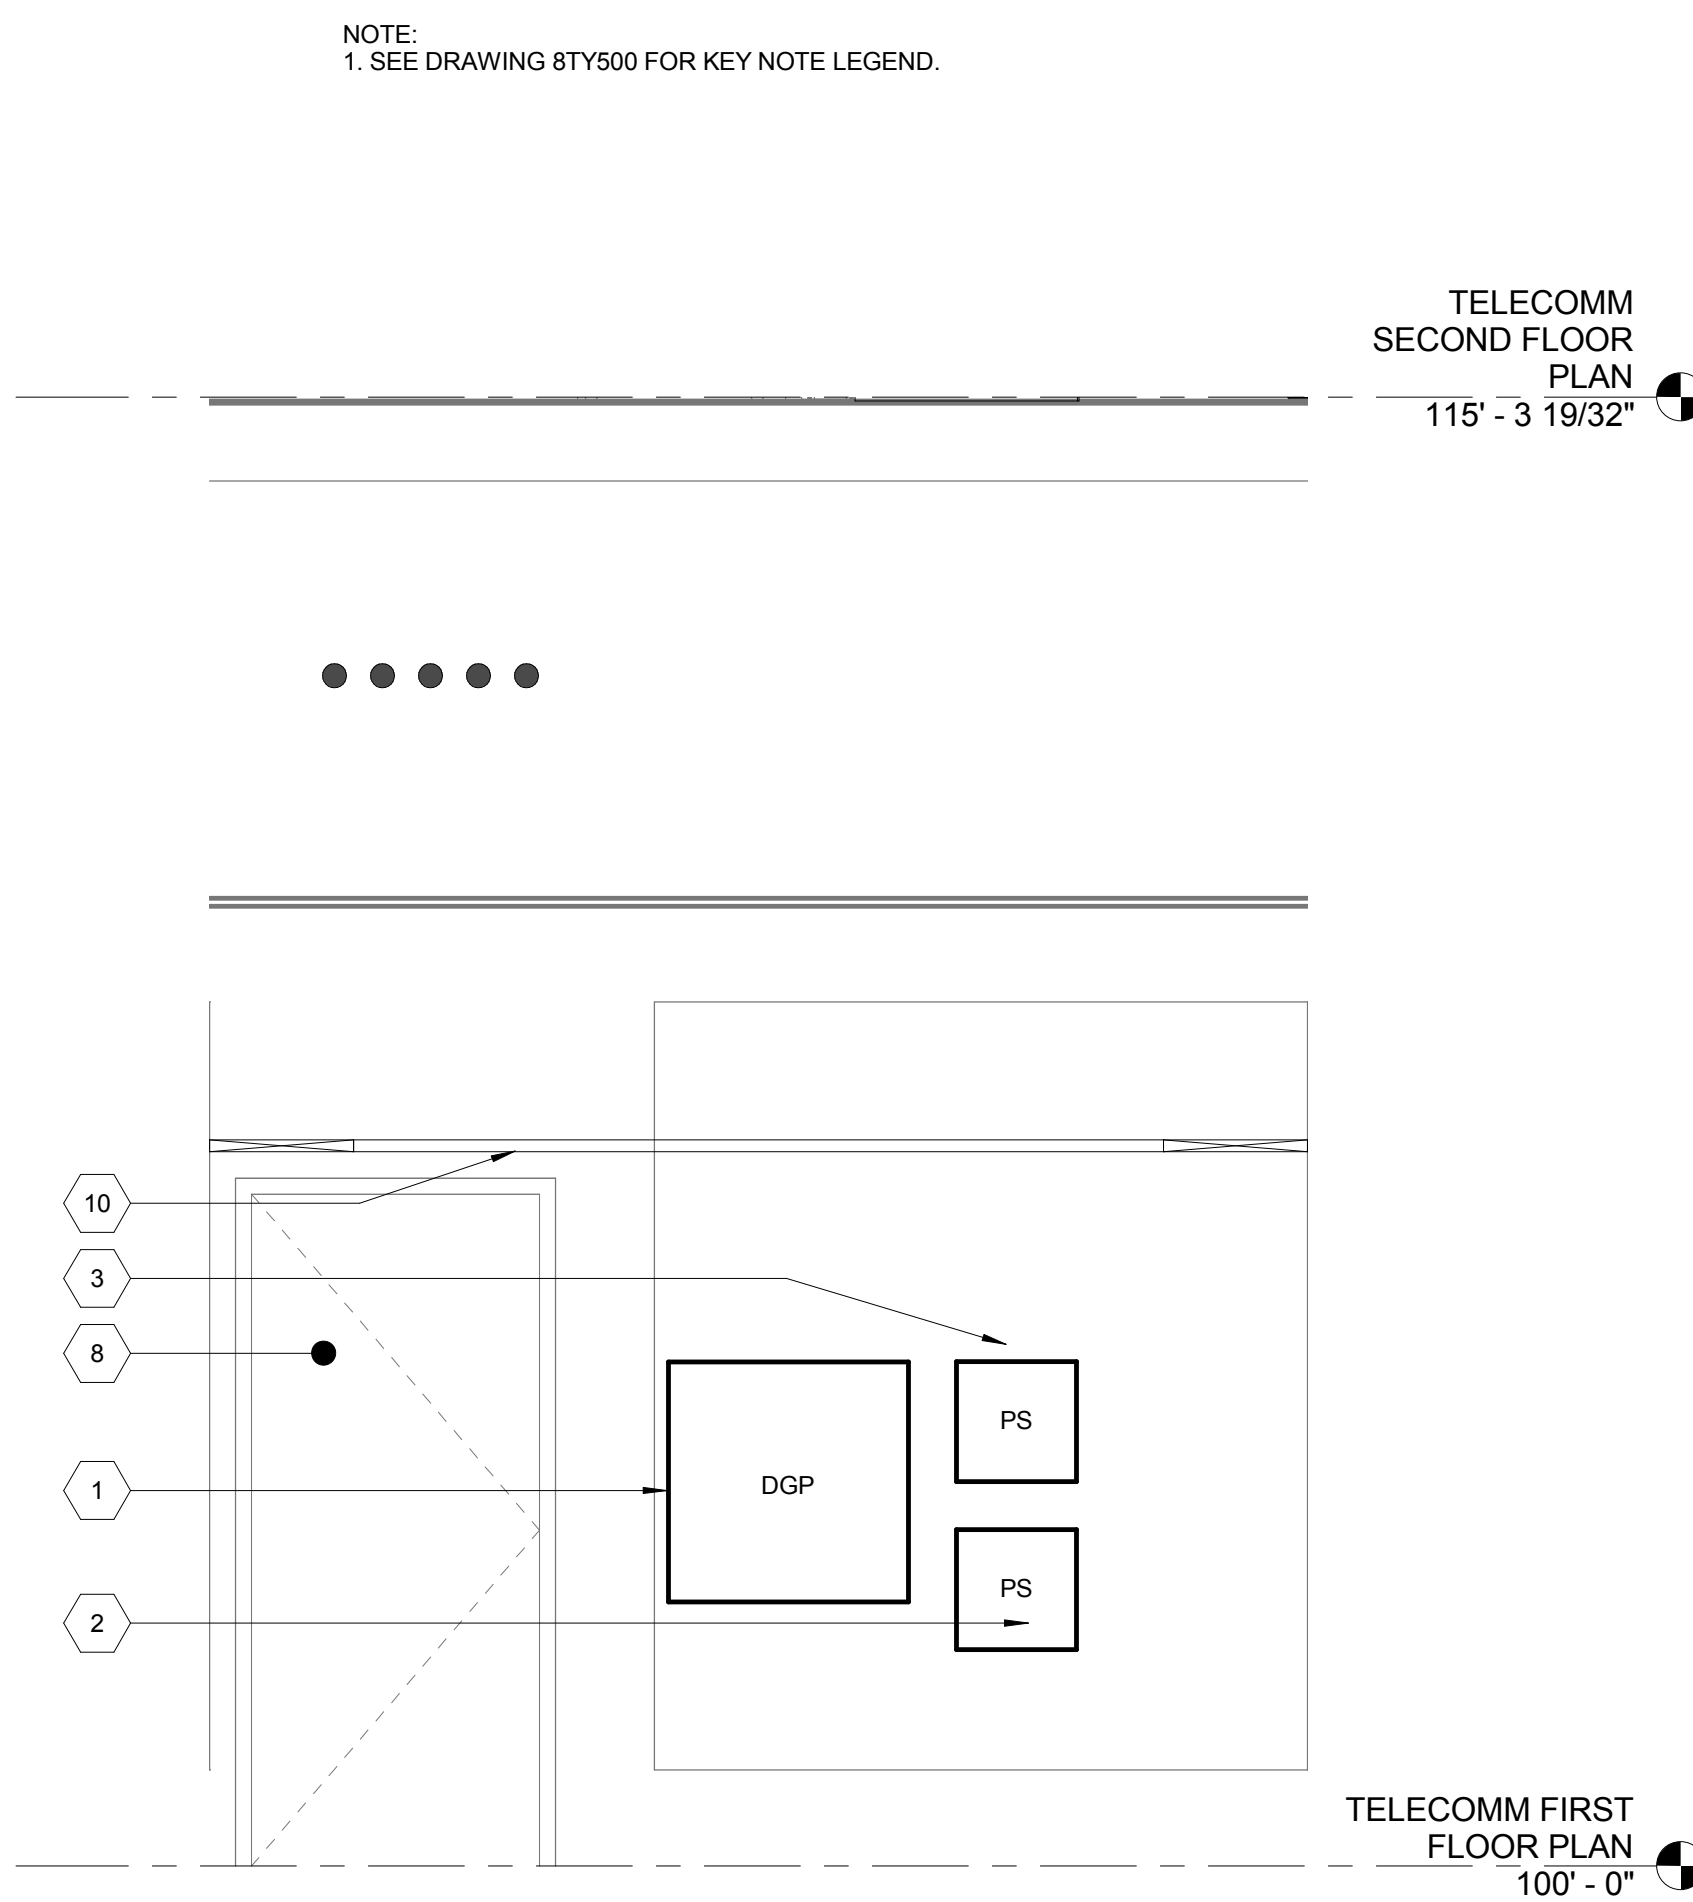


2 WALL ELEVATION LVSR 1P110  
1/2" = 1'-0"

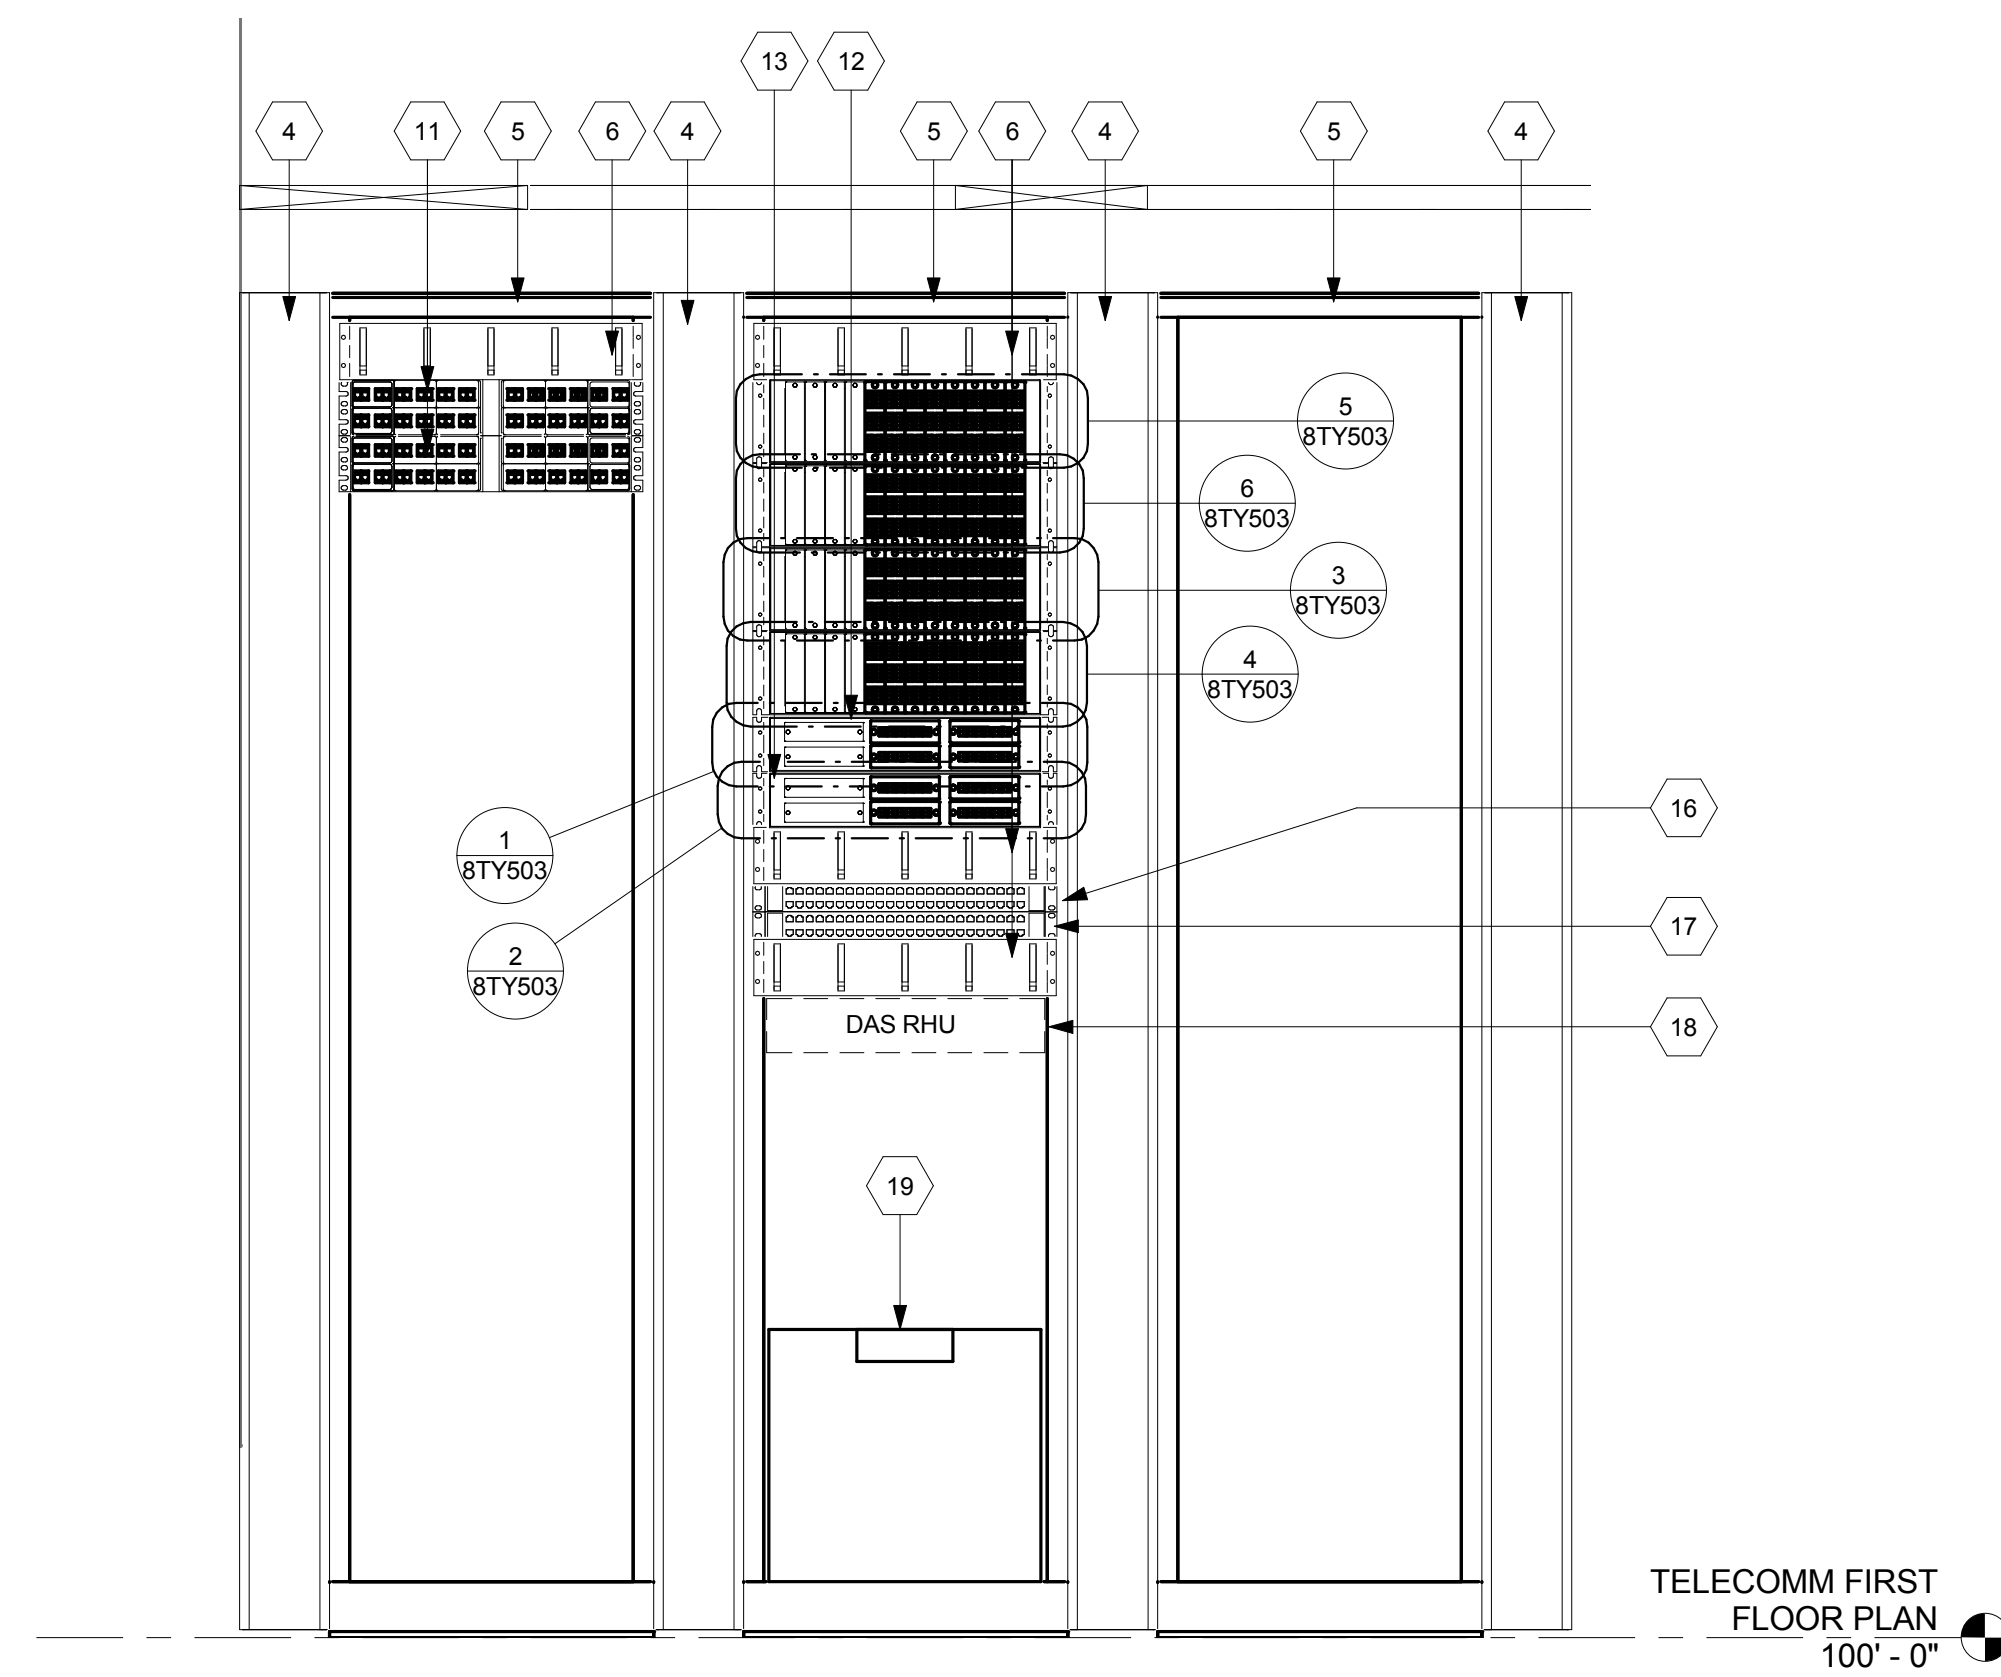


③ RACK ELEVATION LVSR 1P110  
1" = 1'-0"

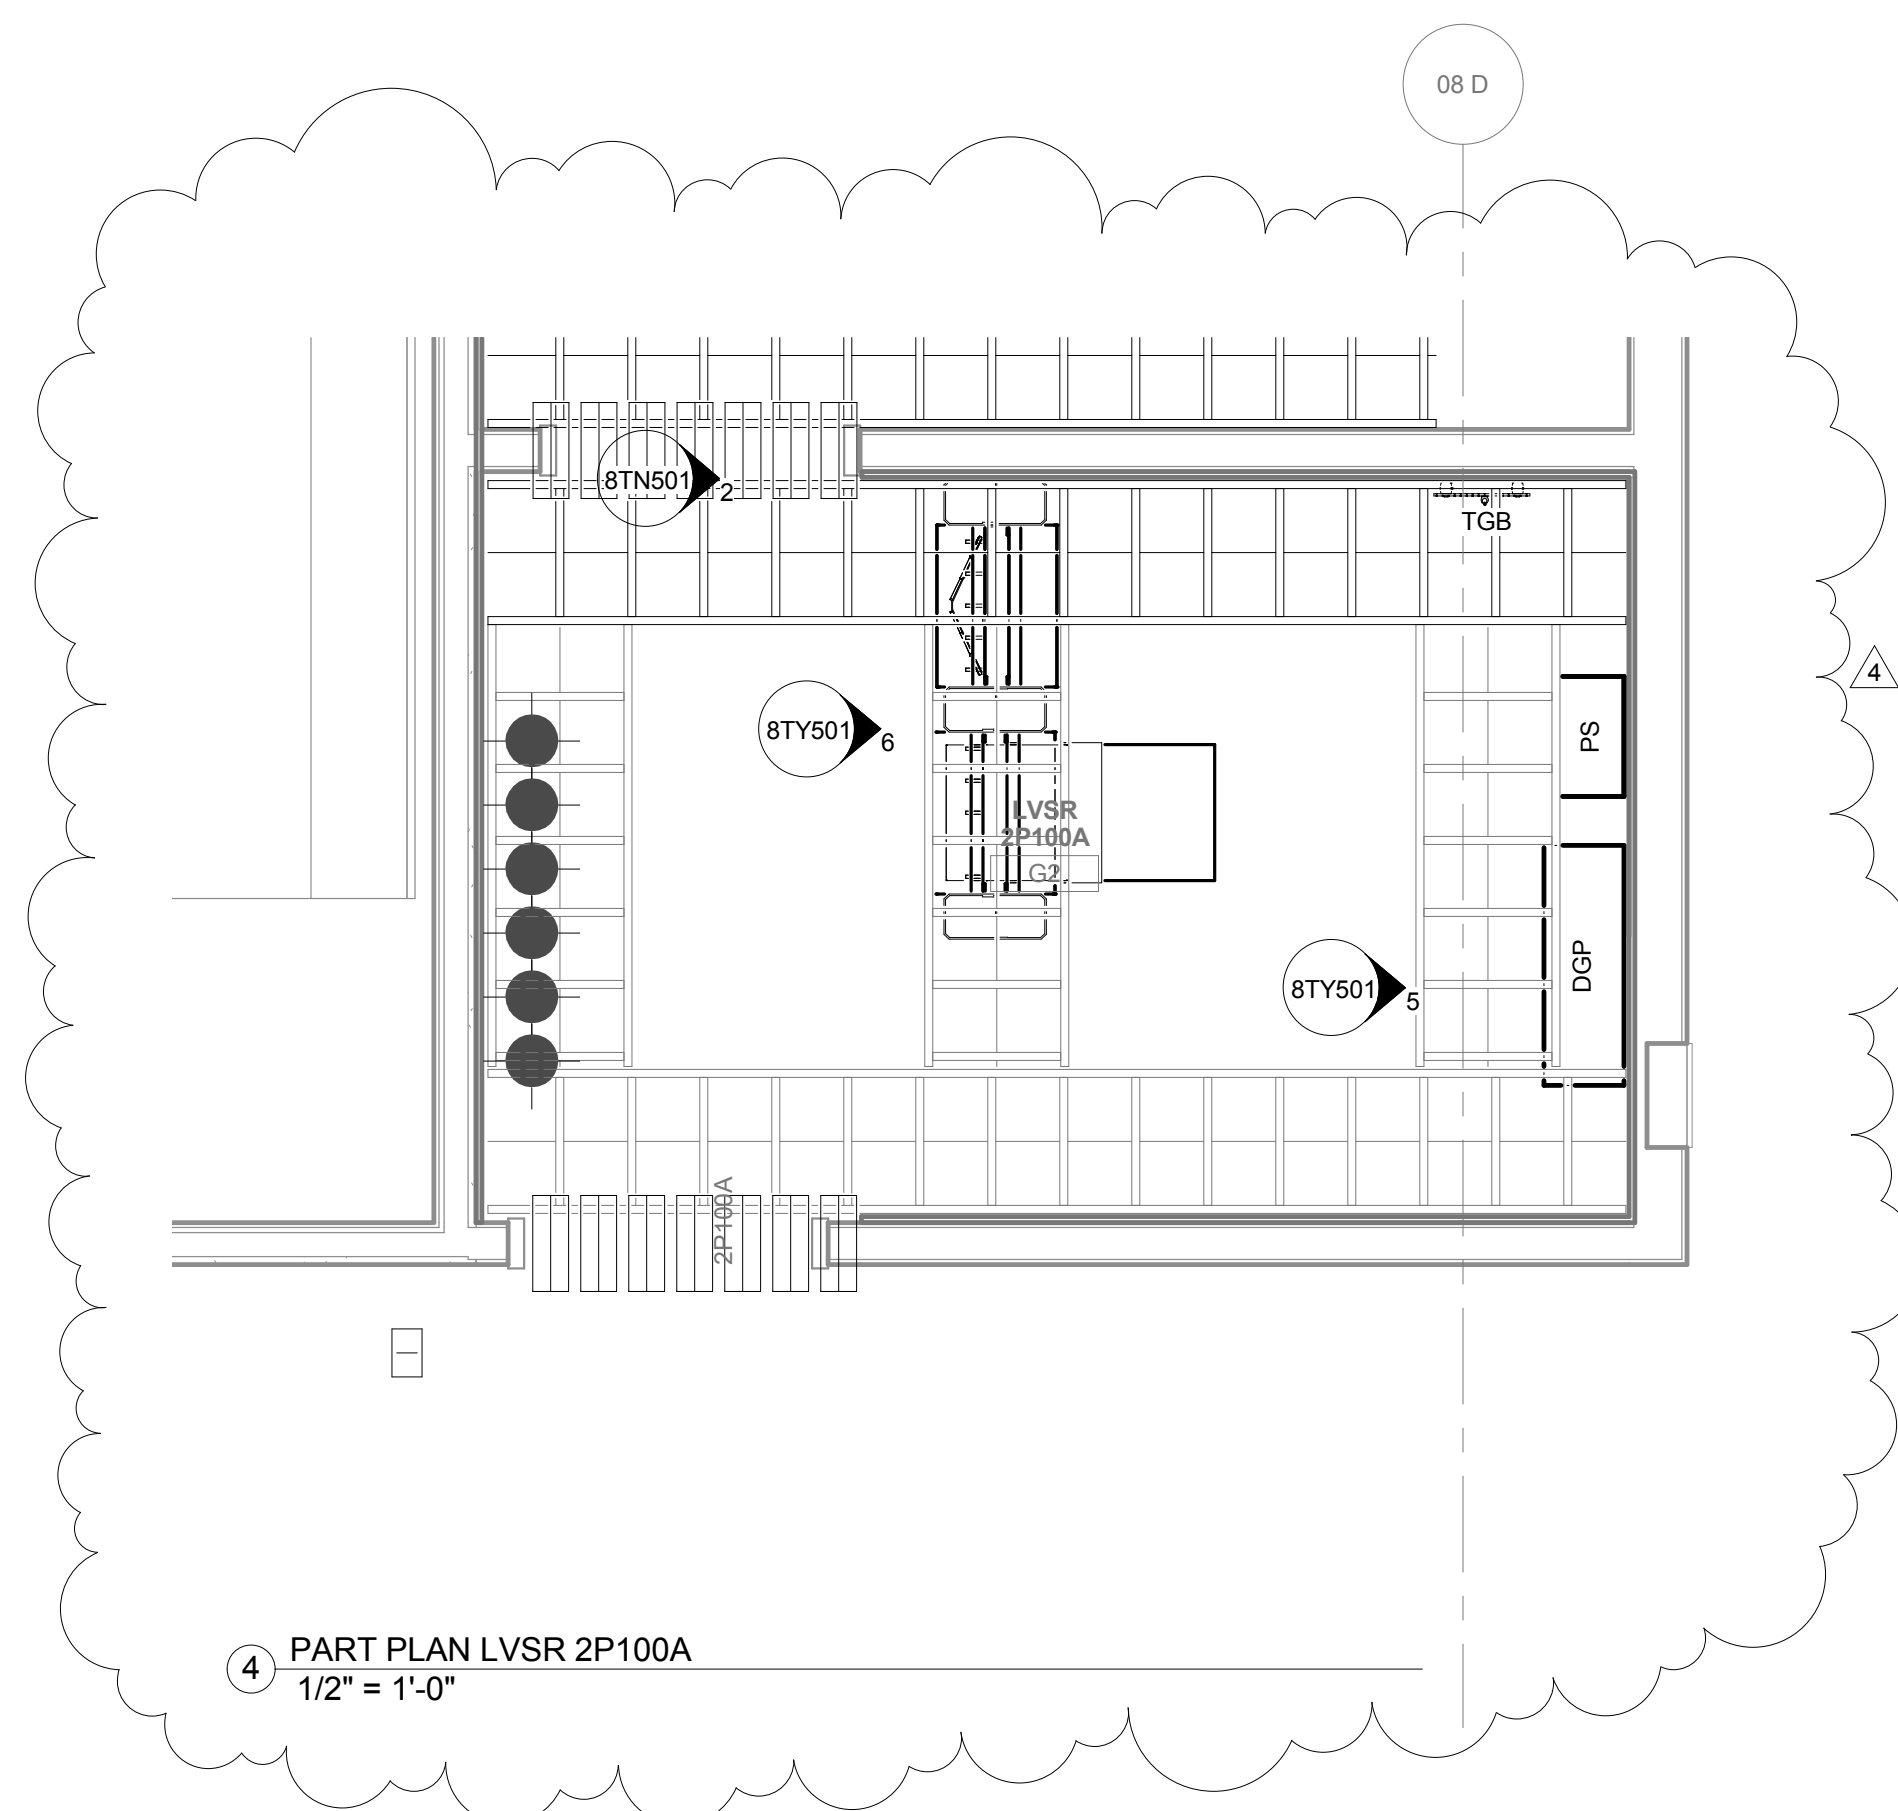

4 PART PLAN LVSR 2P100A  
1/2" = 1'-0"

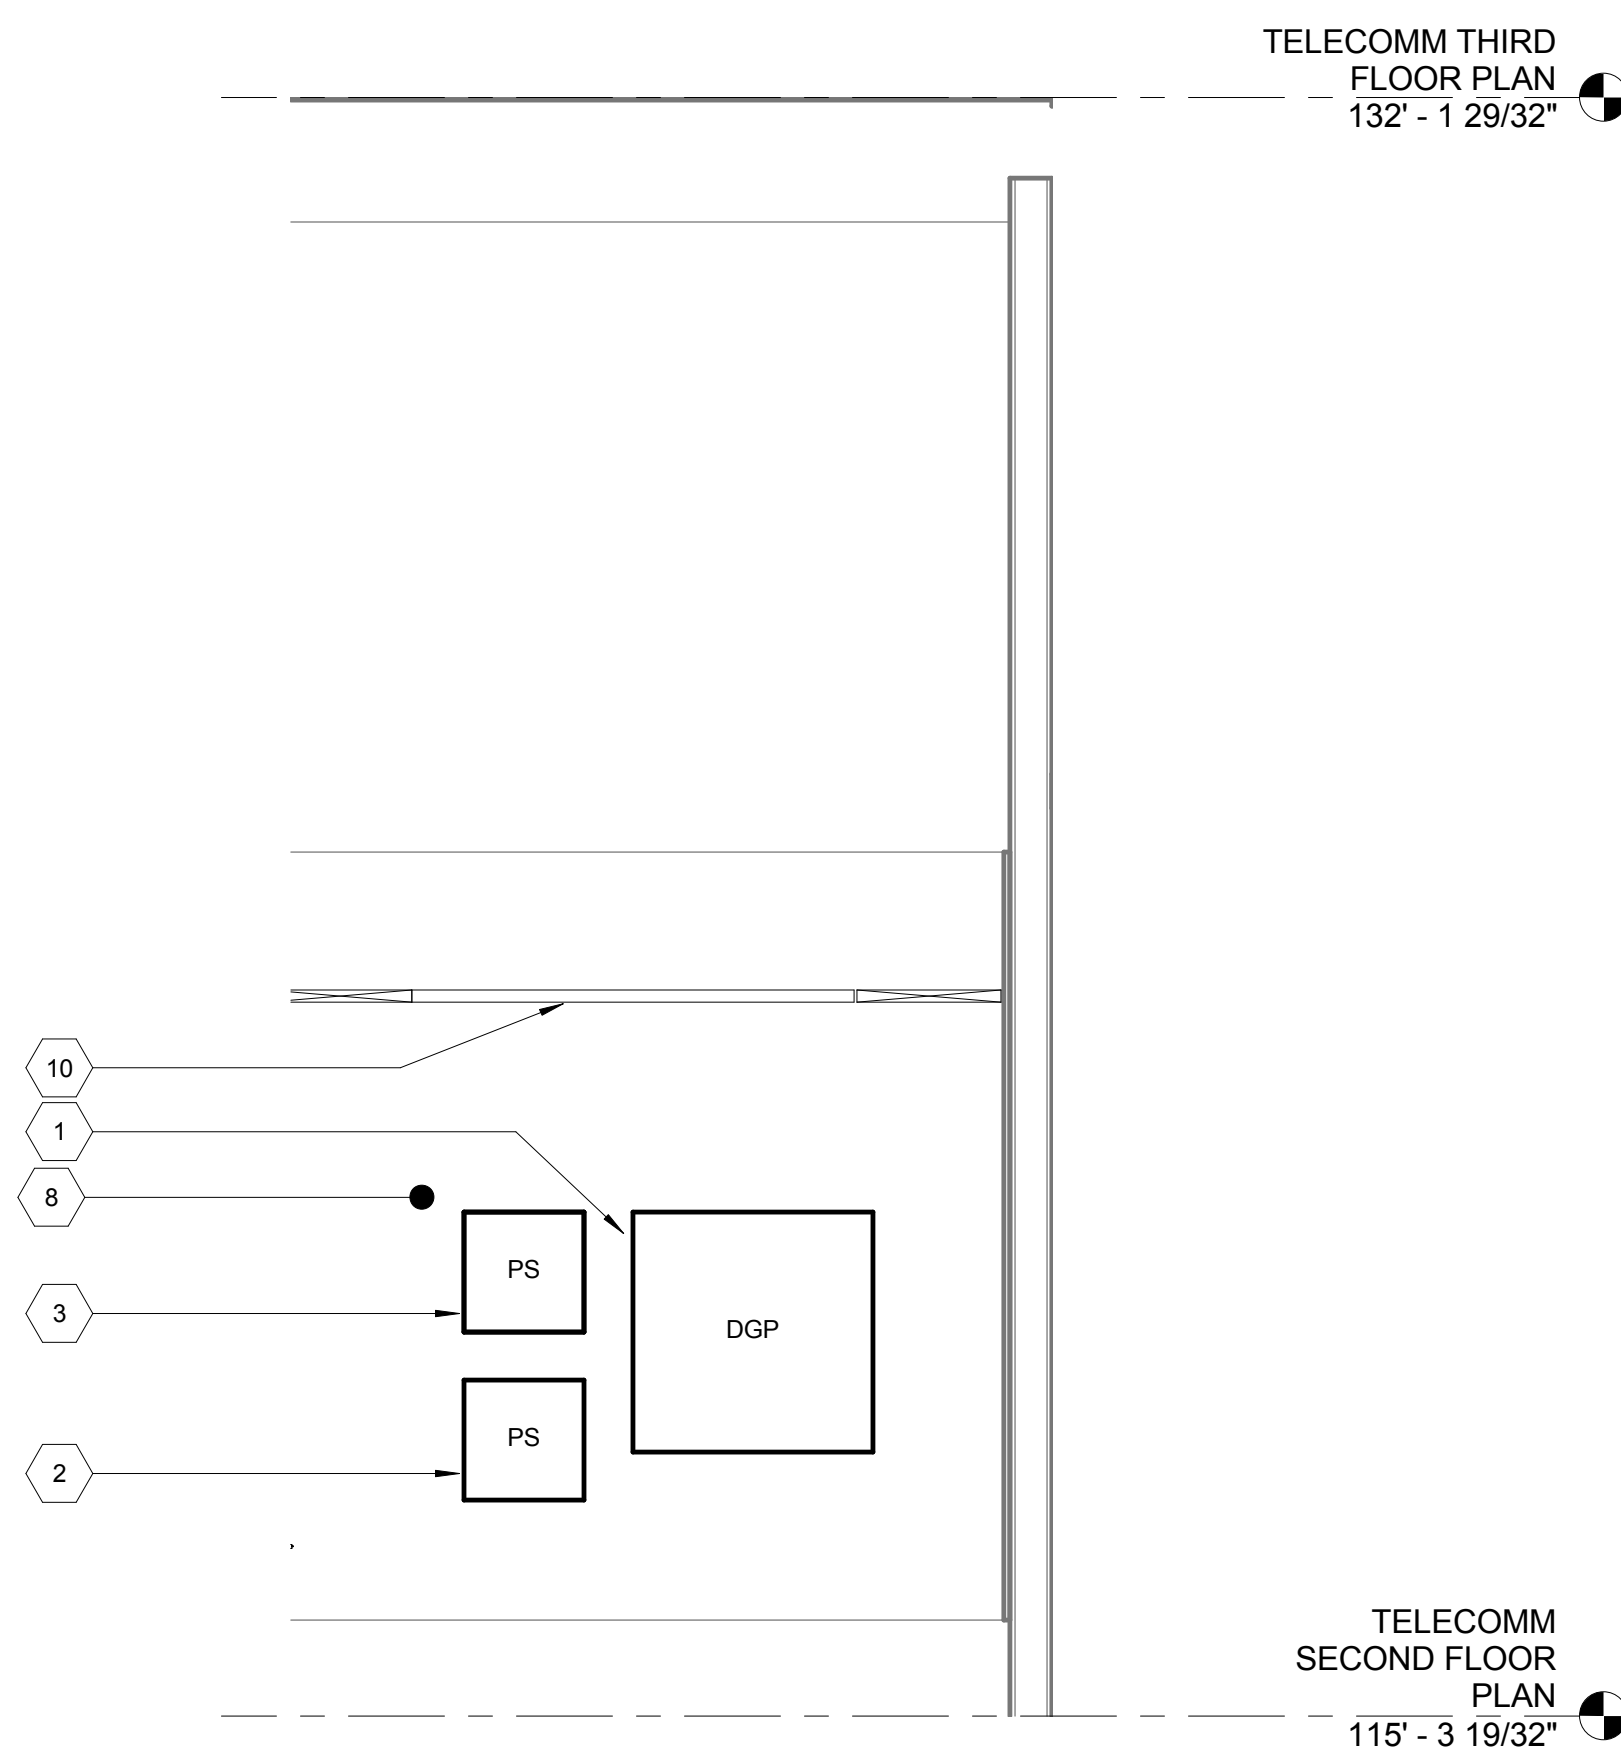

5 WALL ELEVATION LVSR 2P100A  
1/2" = 1'-0"

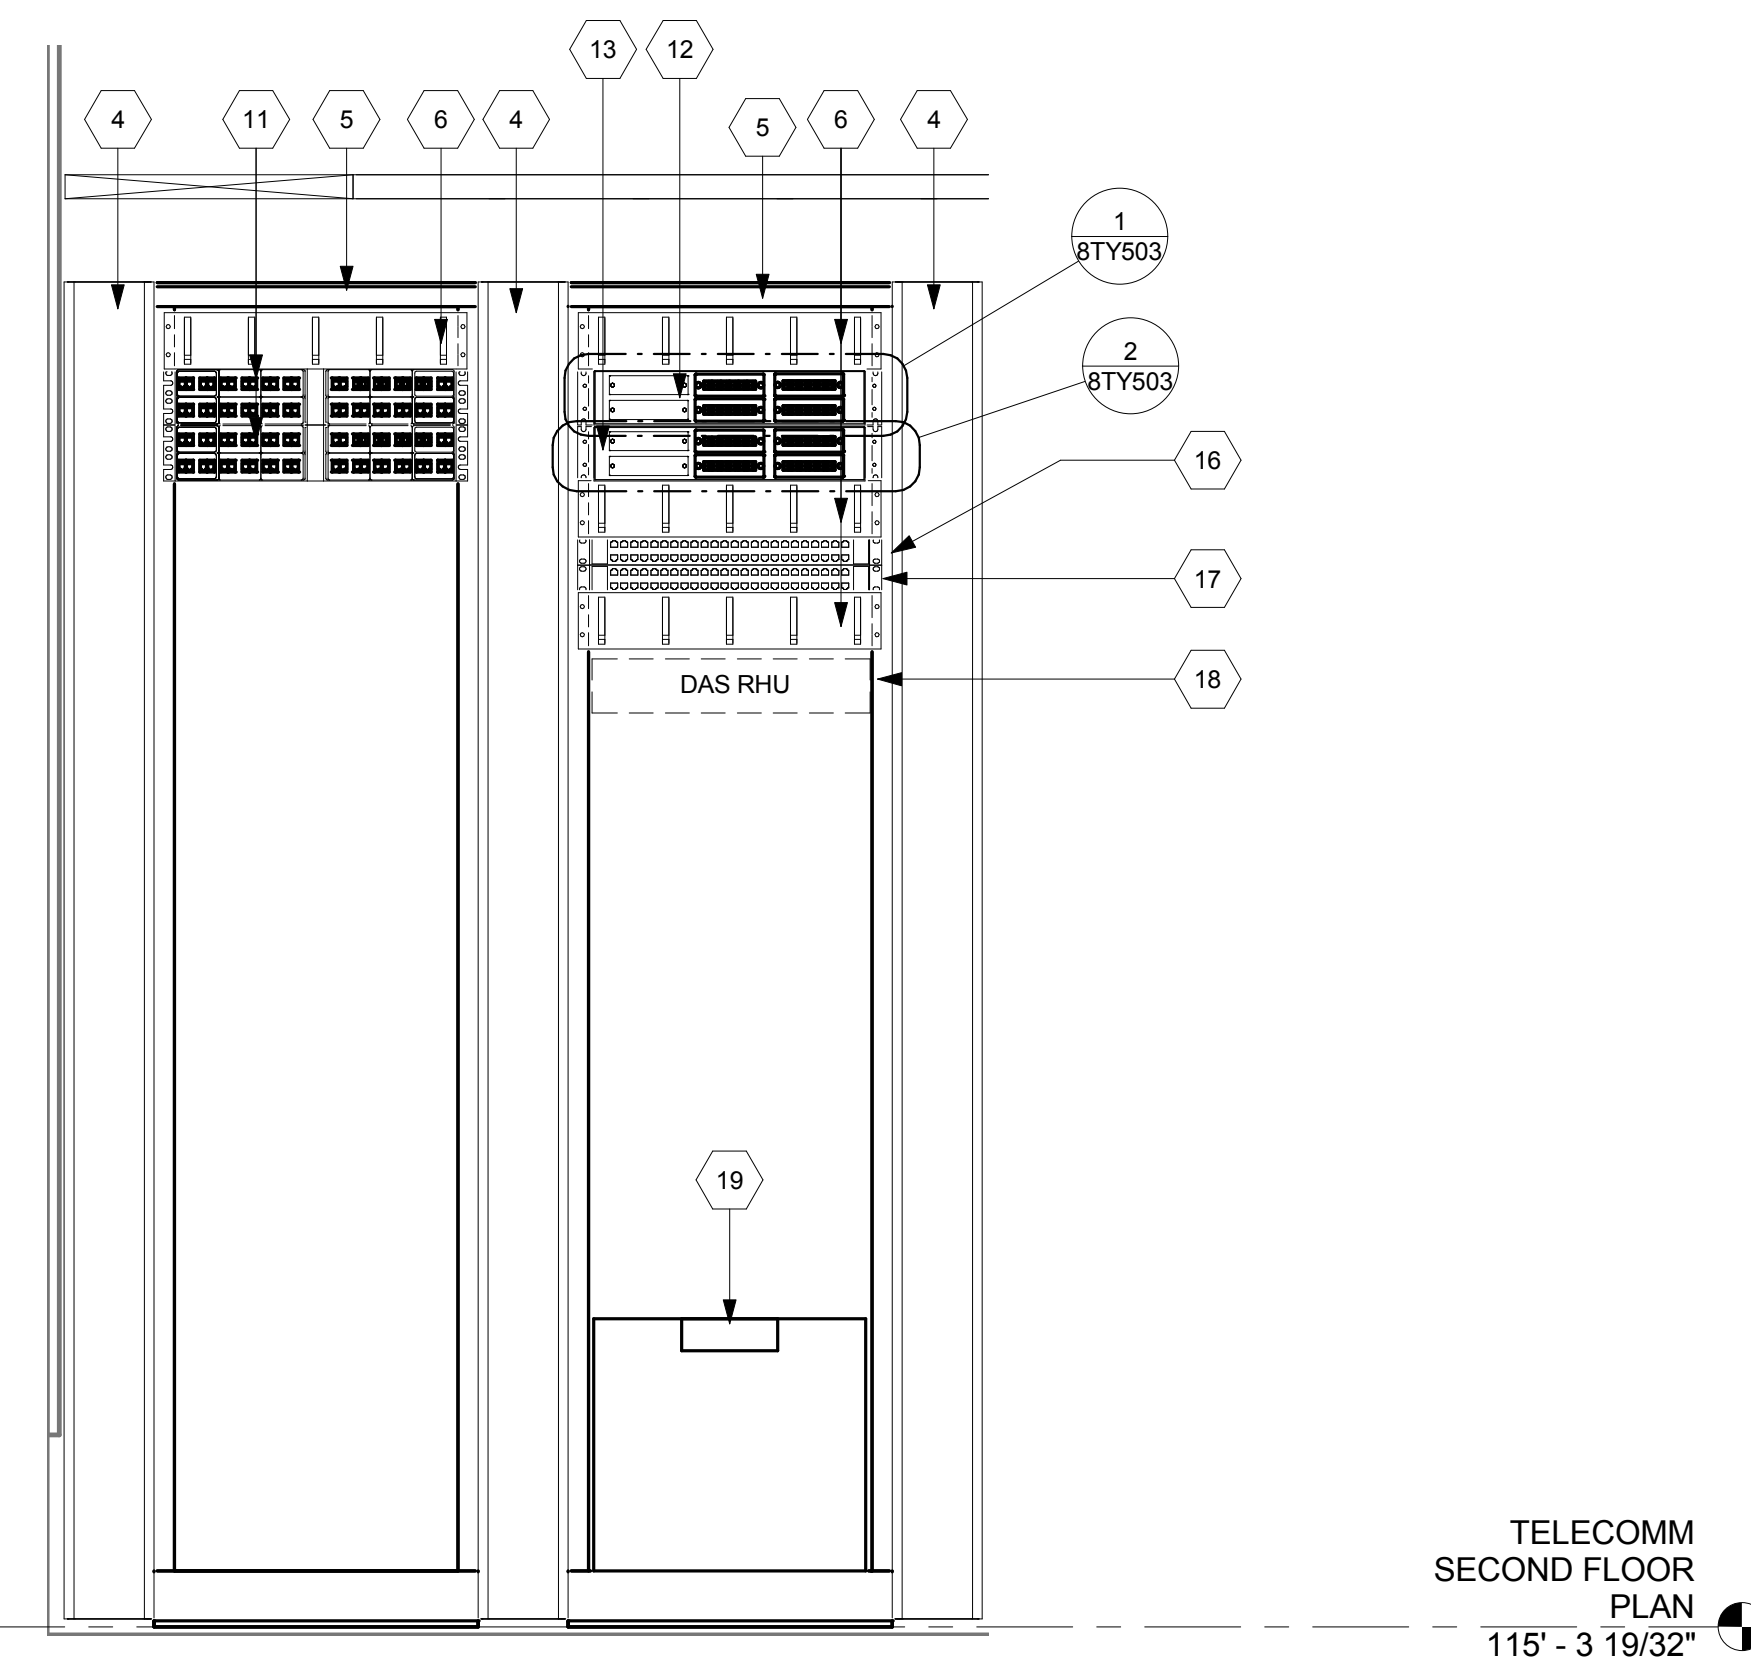

⑥ RACK ELEVATION LVSR 2P100A  
1" = 1'-0"

4	BULL 019 - PRE-AWARD	2/28/2014
REVISIONS:		DATE

CONSULTANTS:

DESMAN ASSOCIATES / PARKING  
CODE CONSULTANTS, INC. / CODE CONSULTANT  
THE SEXTANT GROUP / AV & ACOUSTICAL  
HAMMER DESIGN ASSOCIATES / FOOD SERVICE  
PYBURN & ODOM / ABATEMENT  
TATA & HOWARD / TANK CONSULTANT  
I.S.C. GROUP, INC. / IRRIGATION  
DAN EUSER WATER ARCHITECTURE, INC. / WATER FEATURE



ARCHITECT/ENGINEERS:

studio **NOVA**  
 SCHRENK & PETERSON CONSULTING ENGINEERS / CIVIL  
 KORDA/NEMETH ENGINEERING / STRUCTURAL  
 BR+A CONSULTING ENGINEERS / MECH, ELECT, PLUMBING, LOW VOLTAGE  
 ARCHITECTURAL ENGINEERING/ PLUMBING  
 SCALES ASSOCIATES / FIRE PROTECTION

DRAWING TITLE  
BUILDING 08 - LVSR PART PLAN AND  
ELEVATIONS

APPROVED: PROJECT DIRECTOR

PROJECT TITLE	SLVHCS REPLACEMENT MEDICAL CENTER PROJECT
---------------	---

LOCATION	NEW ORLEANS, LOUISIANA
----------	------------------------

DATE  
July 16, 2012

CHECKED
JLE

DRAWN  
JJP

PROJECT NUMBER 629-HS2-401	BUILDING NUMBER 08
DOCUMENT SET PACKAGE WP 09B	


	DRAWING NUMBER
--	----------------

8TY501


CONSTRUCTION DOCUMENTS 1  
FULLY SPRINKLERED

OFFICE OF  
CONSTRUCTION  
AND FACILITIES  
MANAGEMENT




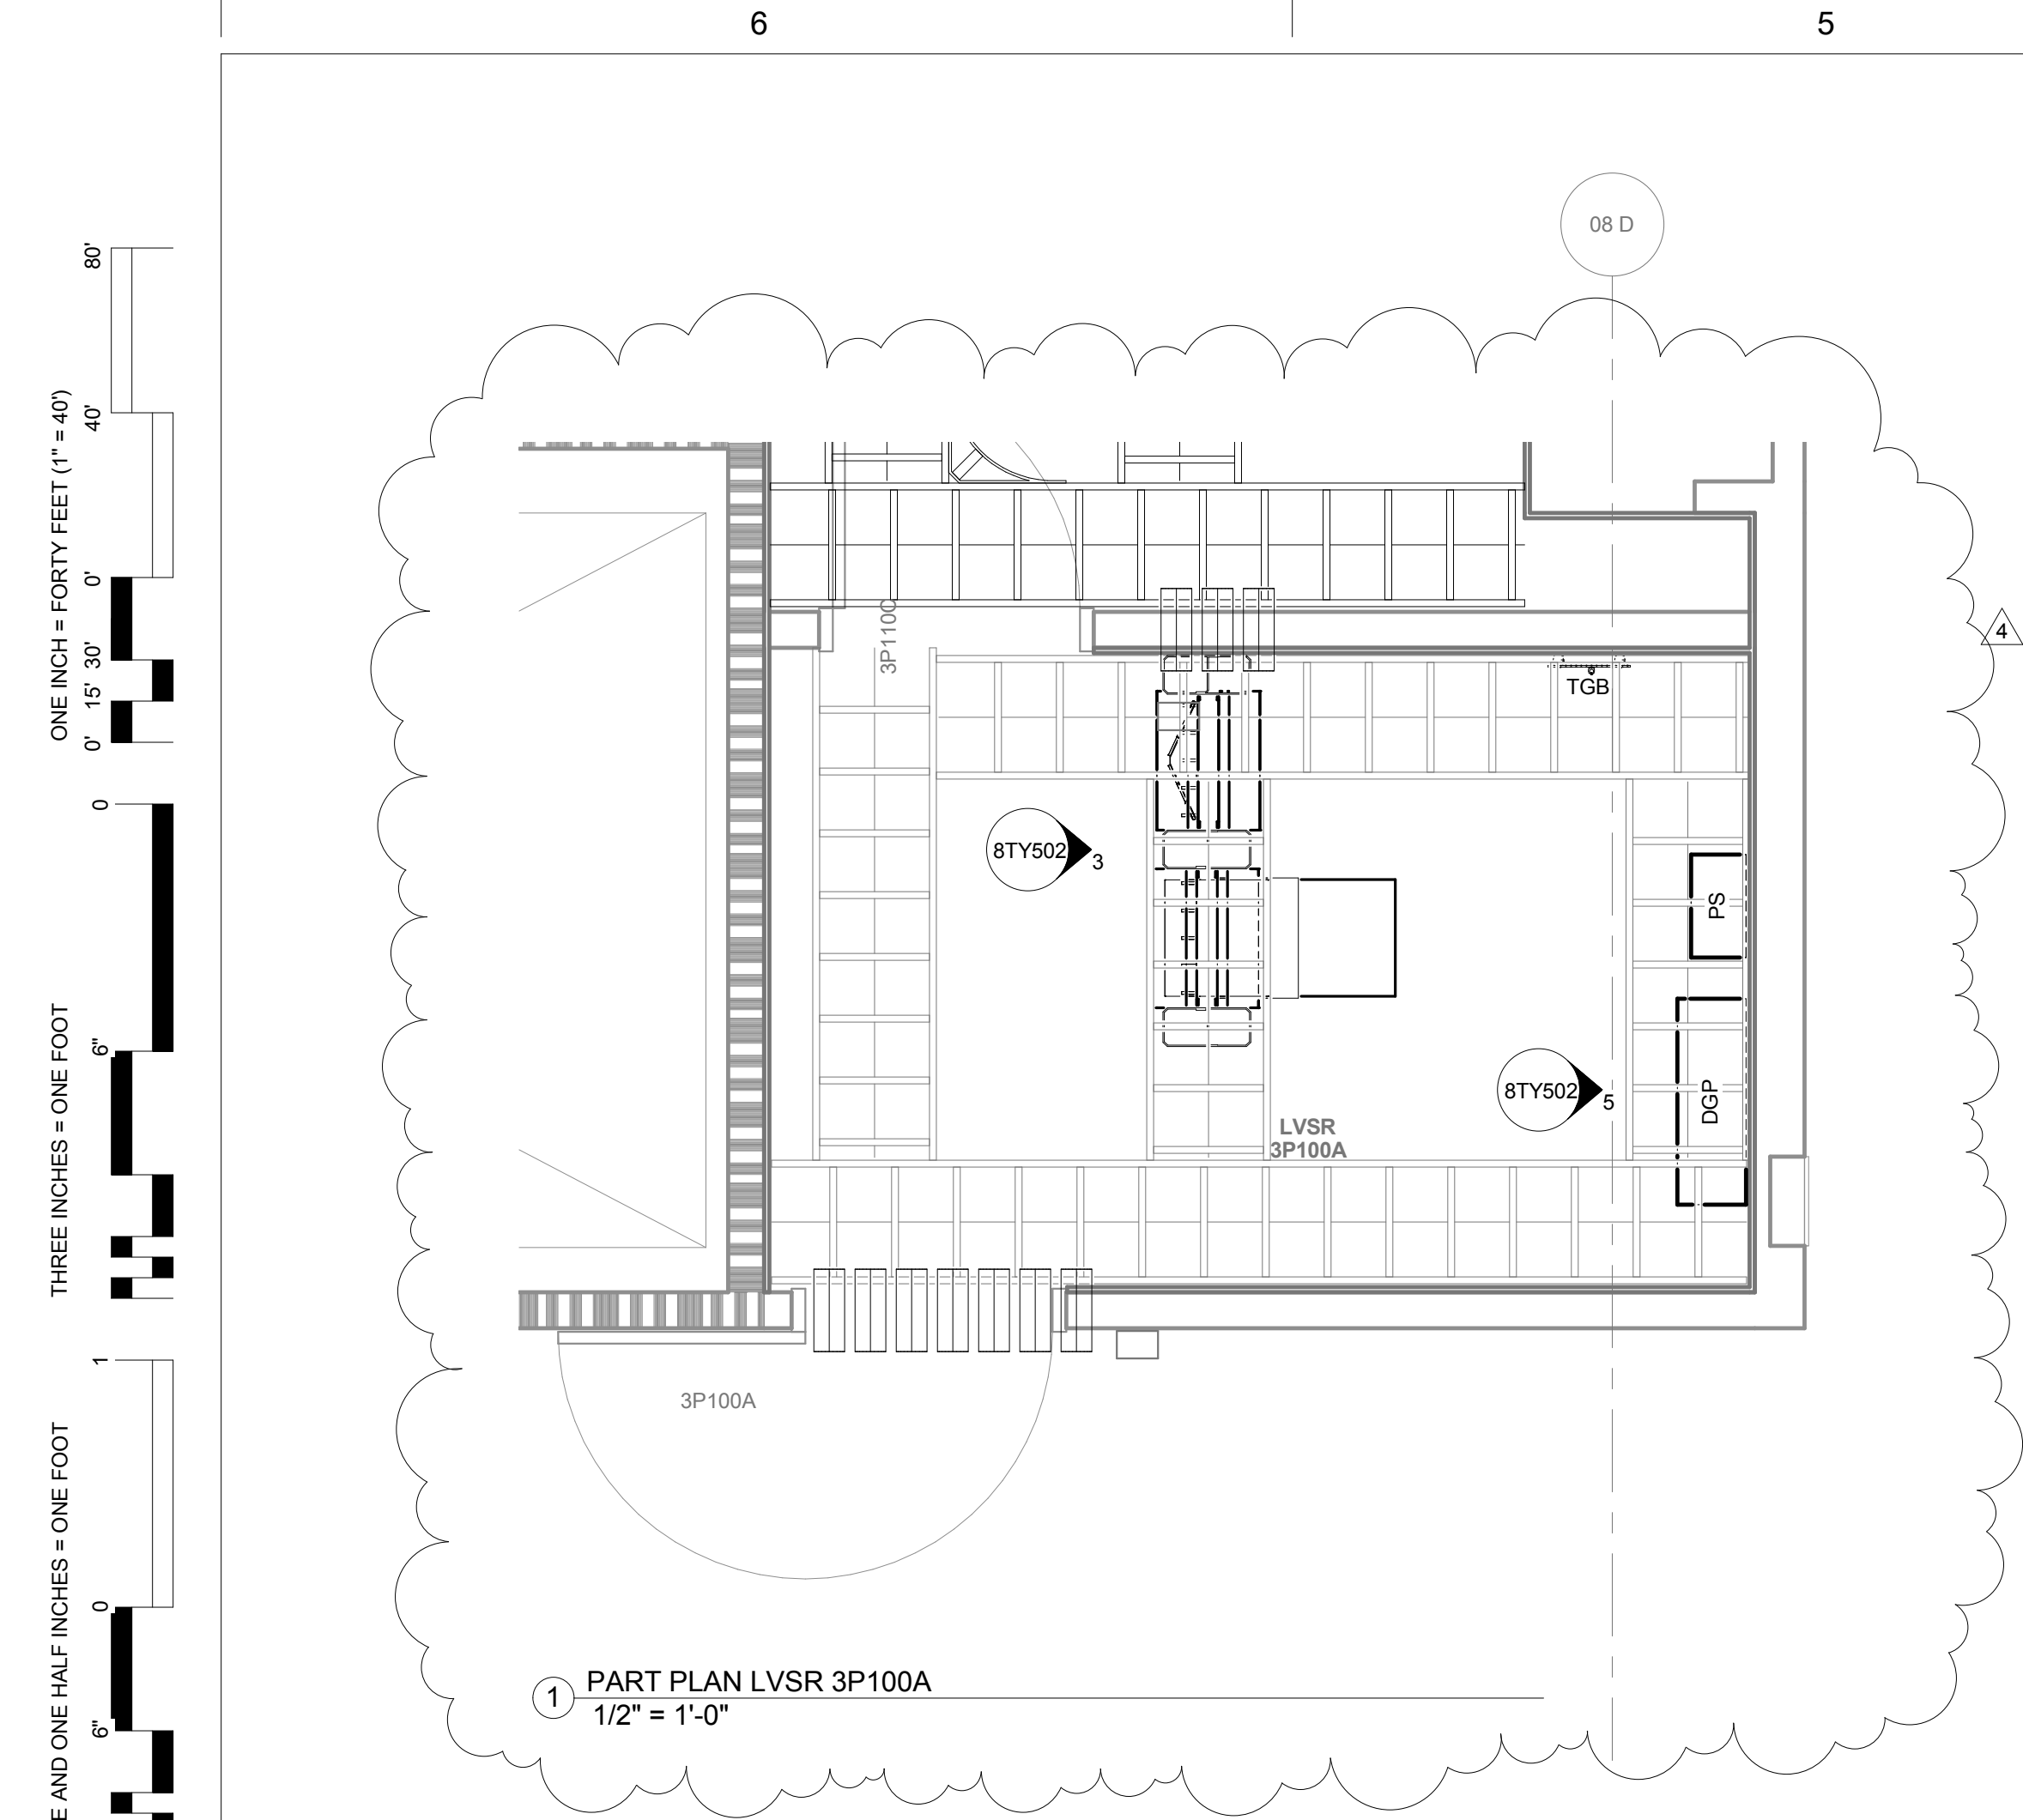




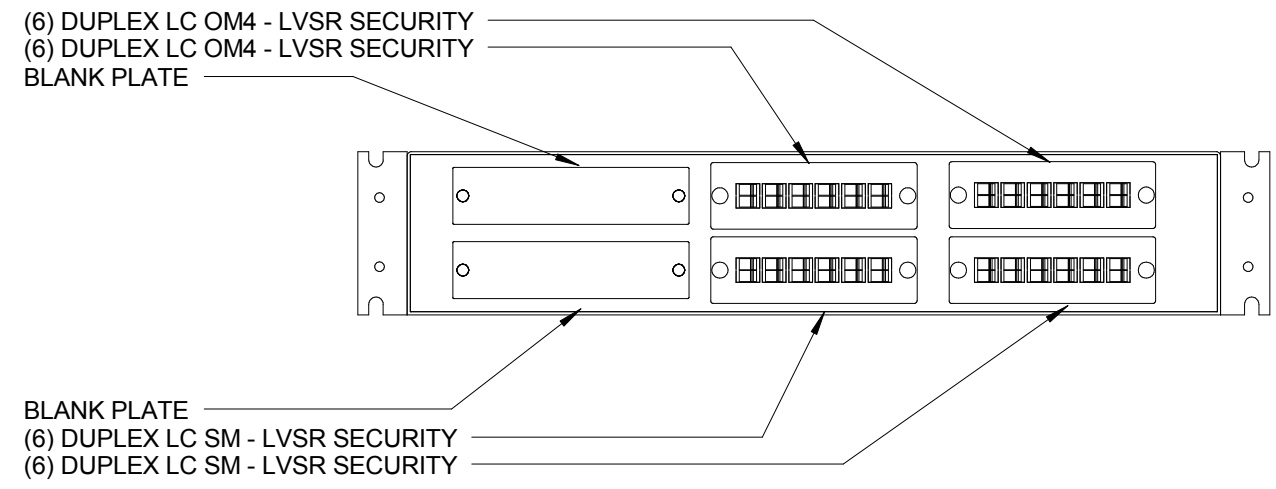


1 RESEARCH LVSR SECURITY LIU  
3" = 1'-0"

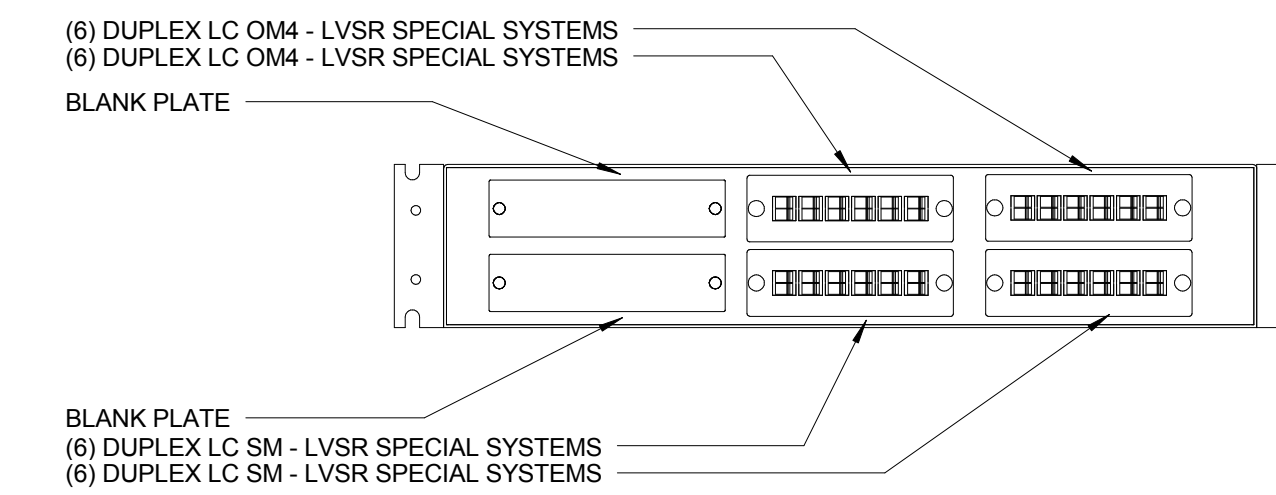


2 RESEARCH LVSR SPECIAL SYSTEMS LIU  
3" = 1'-0"

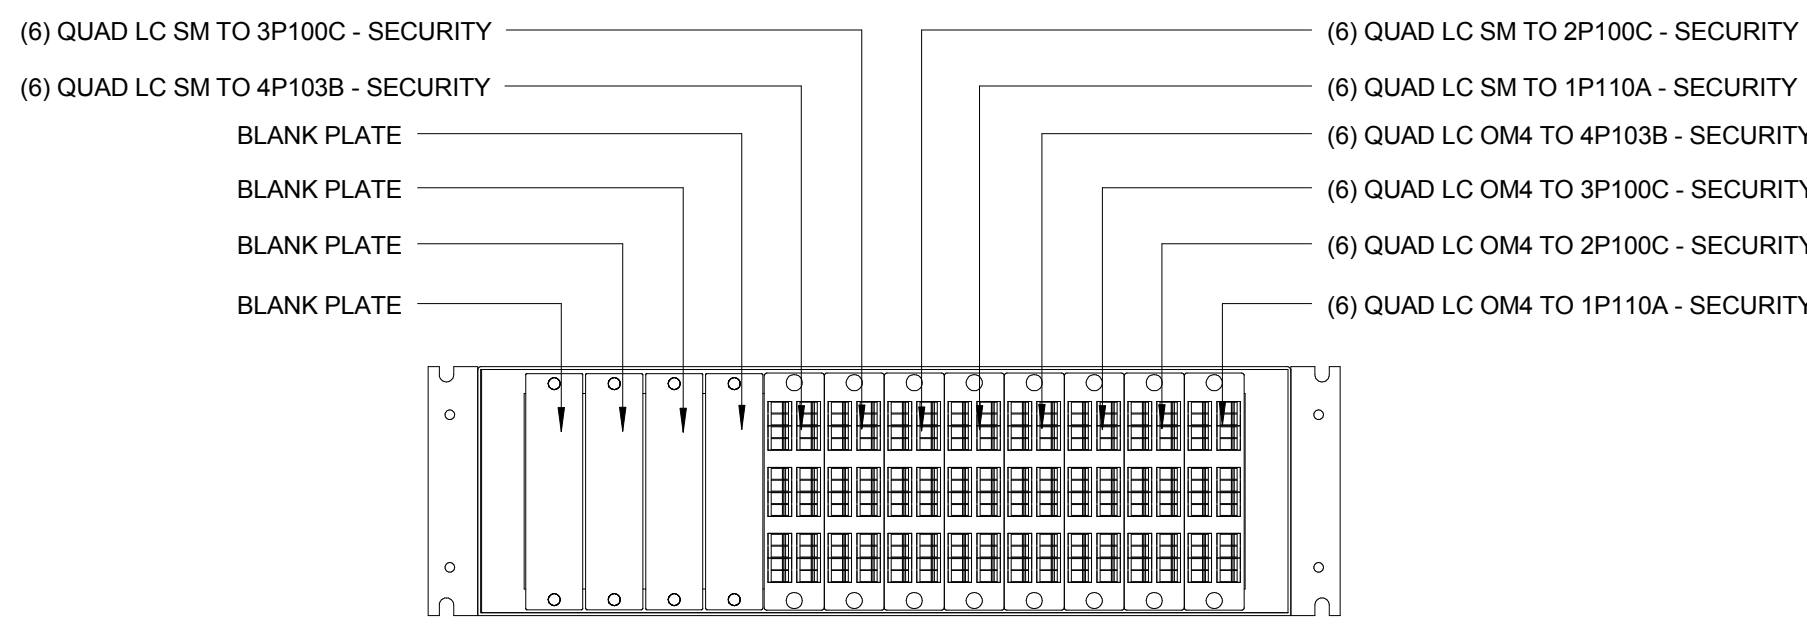


3 RESEARCH SECURITY RISER MCC LIU  
3" = 1'-0"

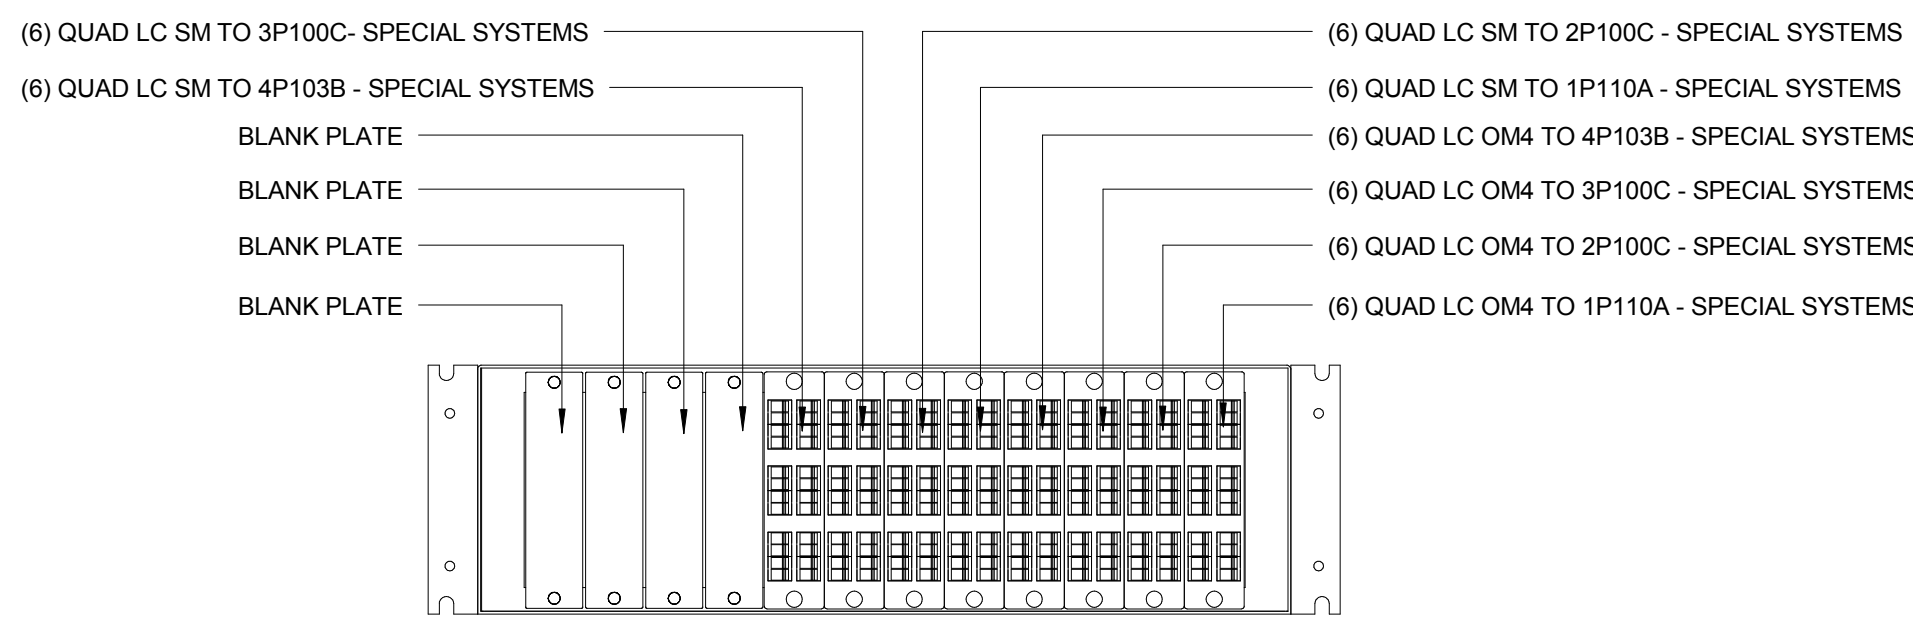

RESEARCH SPECIAL SYSTEMS RISER  
MCC LIU  
4 3" = 1'-0"

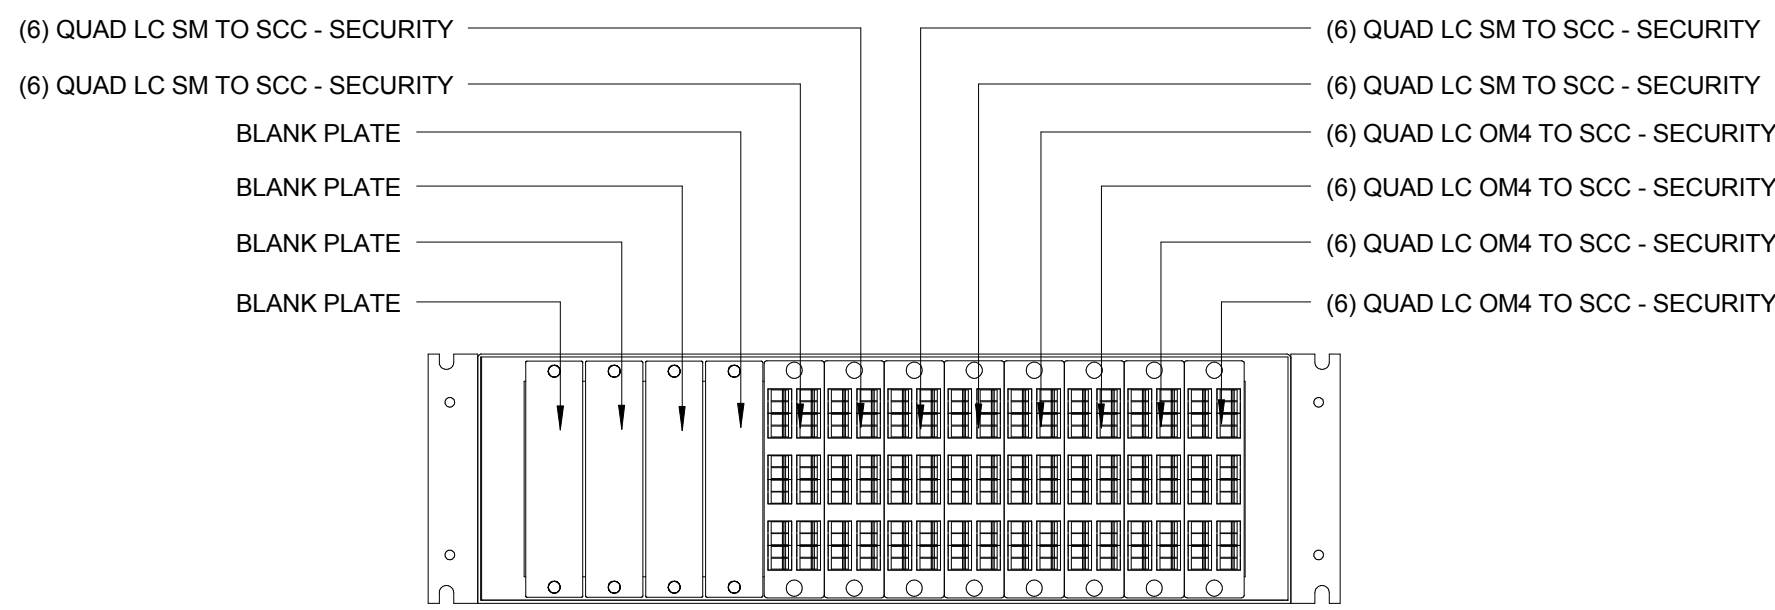


5 RESEARCH SECURITY MCC TO SCC LIU  
3" = 1'-0"

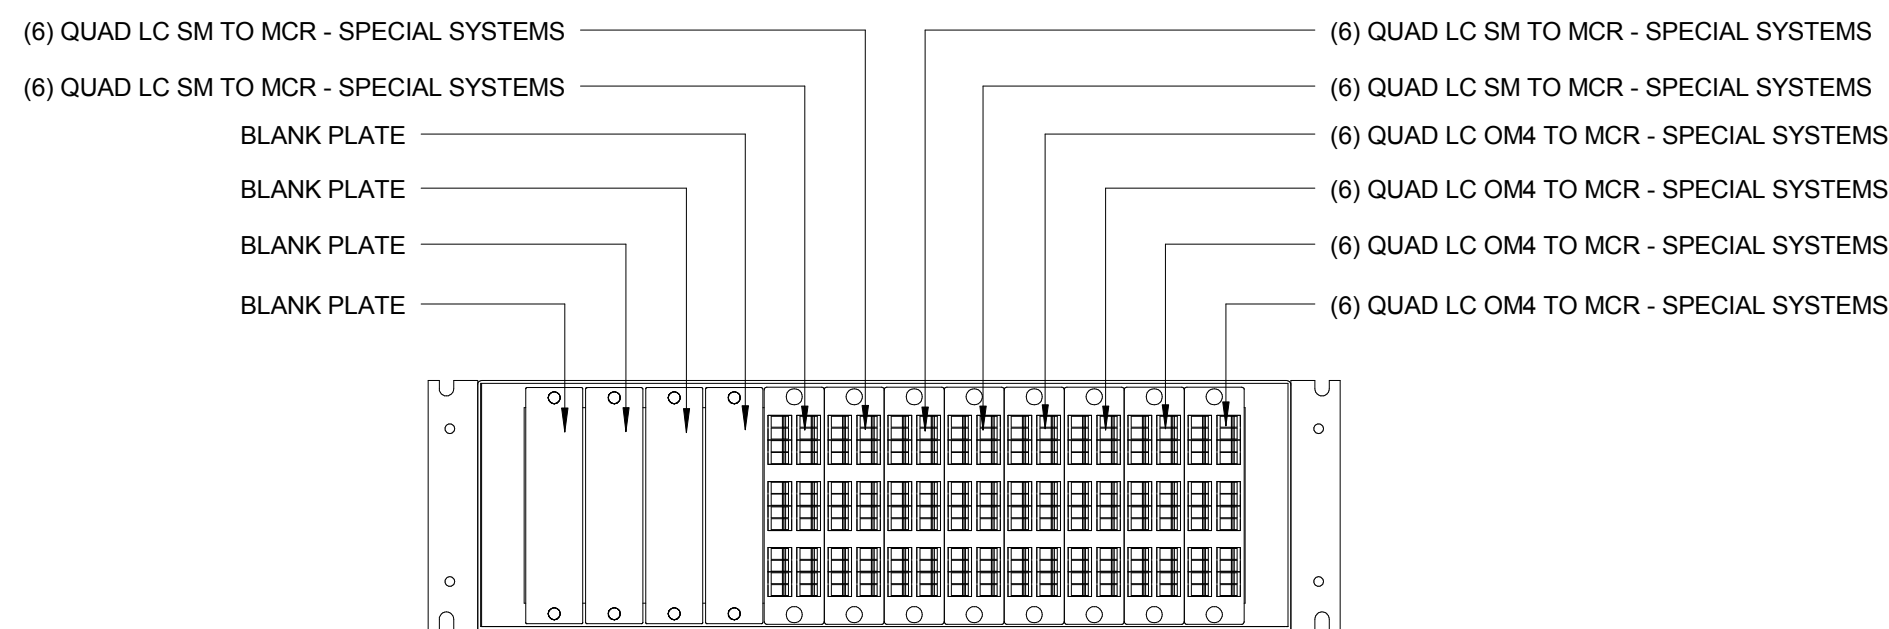

RESEARCH SPECIAL SYSTEMS MCC TO  
MCR LIU  
6 3" = 1'-0"

CONSULTANTS:

DESMAN ASSOCIATES / PARKING  
CODE CONSULTANTS, INC. / CODE CONSULTANT  
THE SEXTANT GROUP / AV & ACOUSTICAL  
HAMMER DESIGN ASSOCIATES / FOOD SERVICE  
PYBURN & ODOM / ABATEMENT  
TATA & HOWARD / TANK CONSULTANT  
I.S.C. GROUP, INC. / IRRIGATION  
DAN EUSER WATER ARCHITECTURE, INC. / WATER FEATURE

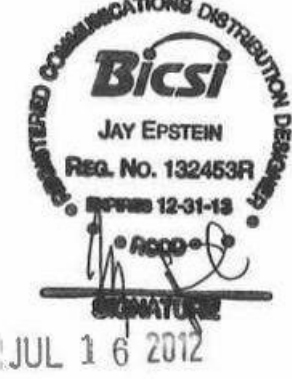

ARCHITECT/ENGINEERS:

studio **NOVA**  
SCHRENK & PETERSON CONSULTING ENGINEERS / CIVIL  
KORDA/NEMETH ENGINEERING / STRUCTURAL  
BR+A CONSULTING ENGINEERS / MECH, ELECT, PLUMBING, LOW VOLTAGE  
ARCHITECTURAL ENGINEERING/ PLUMBING  
SCALES ASSOCIATES / FIRE PROTECTION

DRAWING TITLE  
BUILDING 08 - SECURITY FIBER DETAILS

APPROVED: PROJECT DIRECTOR

*John Sandus*

PROJECT TITLE  
SLVHCS REPLACEMENT MEDICAL  
CENTER PROJECT

LOCATION  
NEW ORLEANS, LOUISIANA

DATE  
July 16, 2012

CHECKED  
JLE

DRAWN  
JJP

PROJECT NUMBER  
629-HS2-401

 
BUILDING NUMBER  
08

DOCUMENT SET PACKAGE  
WP\_09B


DRAWING NUMBER

8TY503

OFFICE OF  
CONSTRUCTION  
AND FACILITIES  
MANAGEMENT





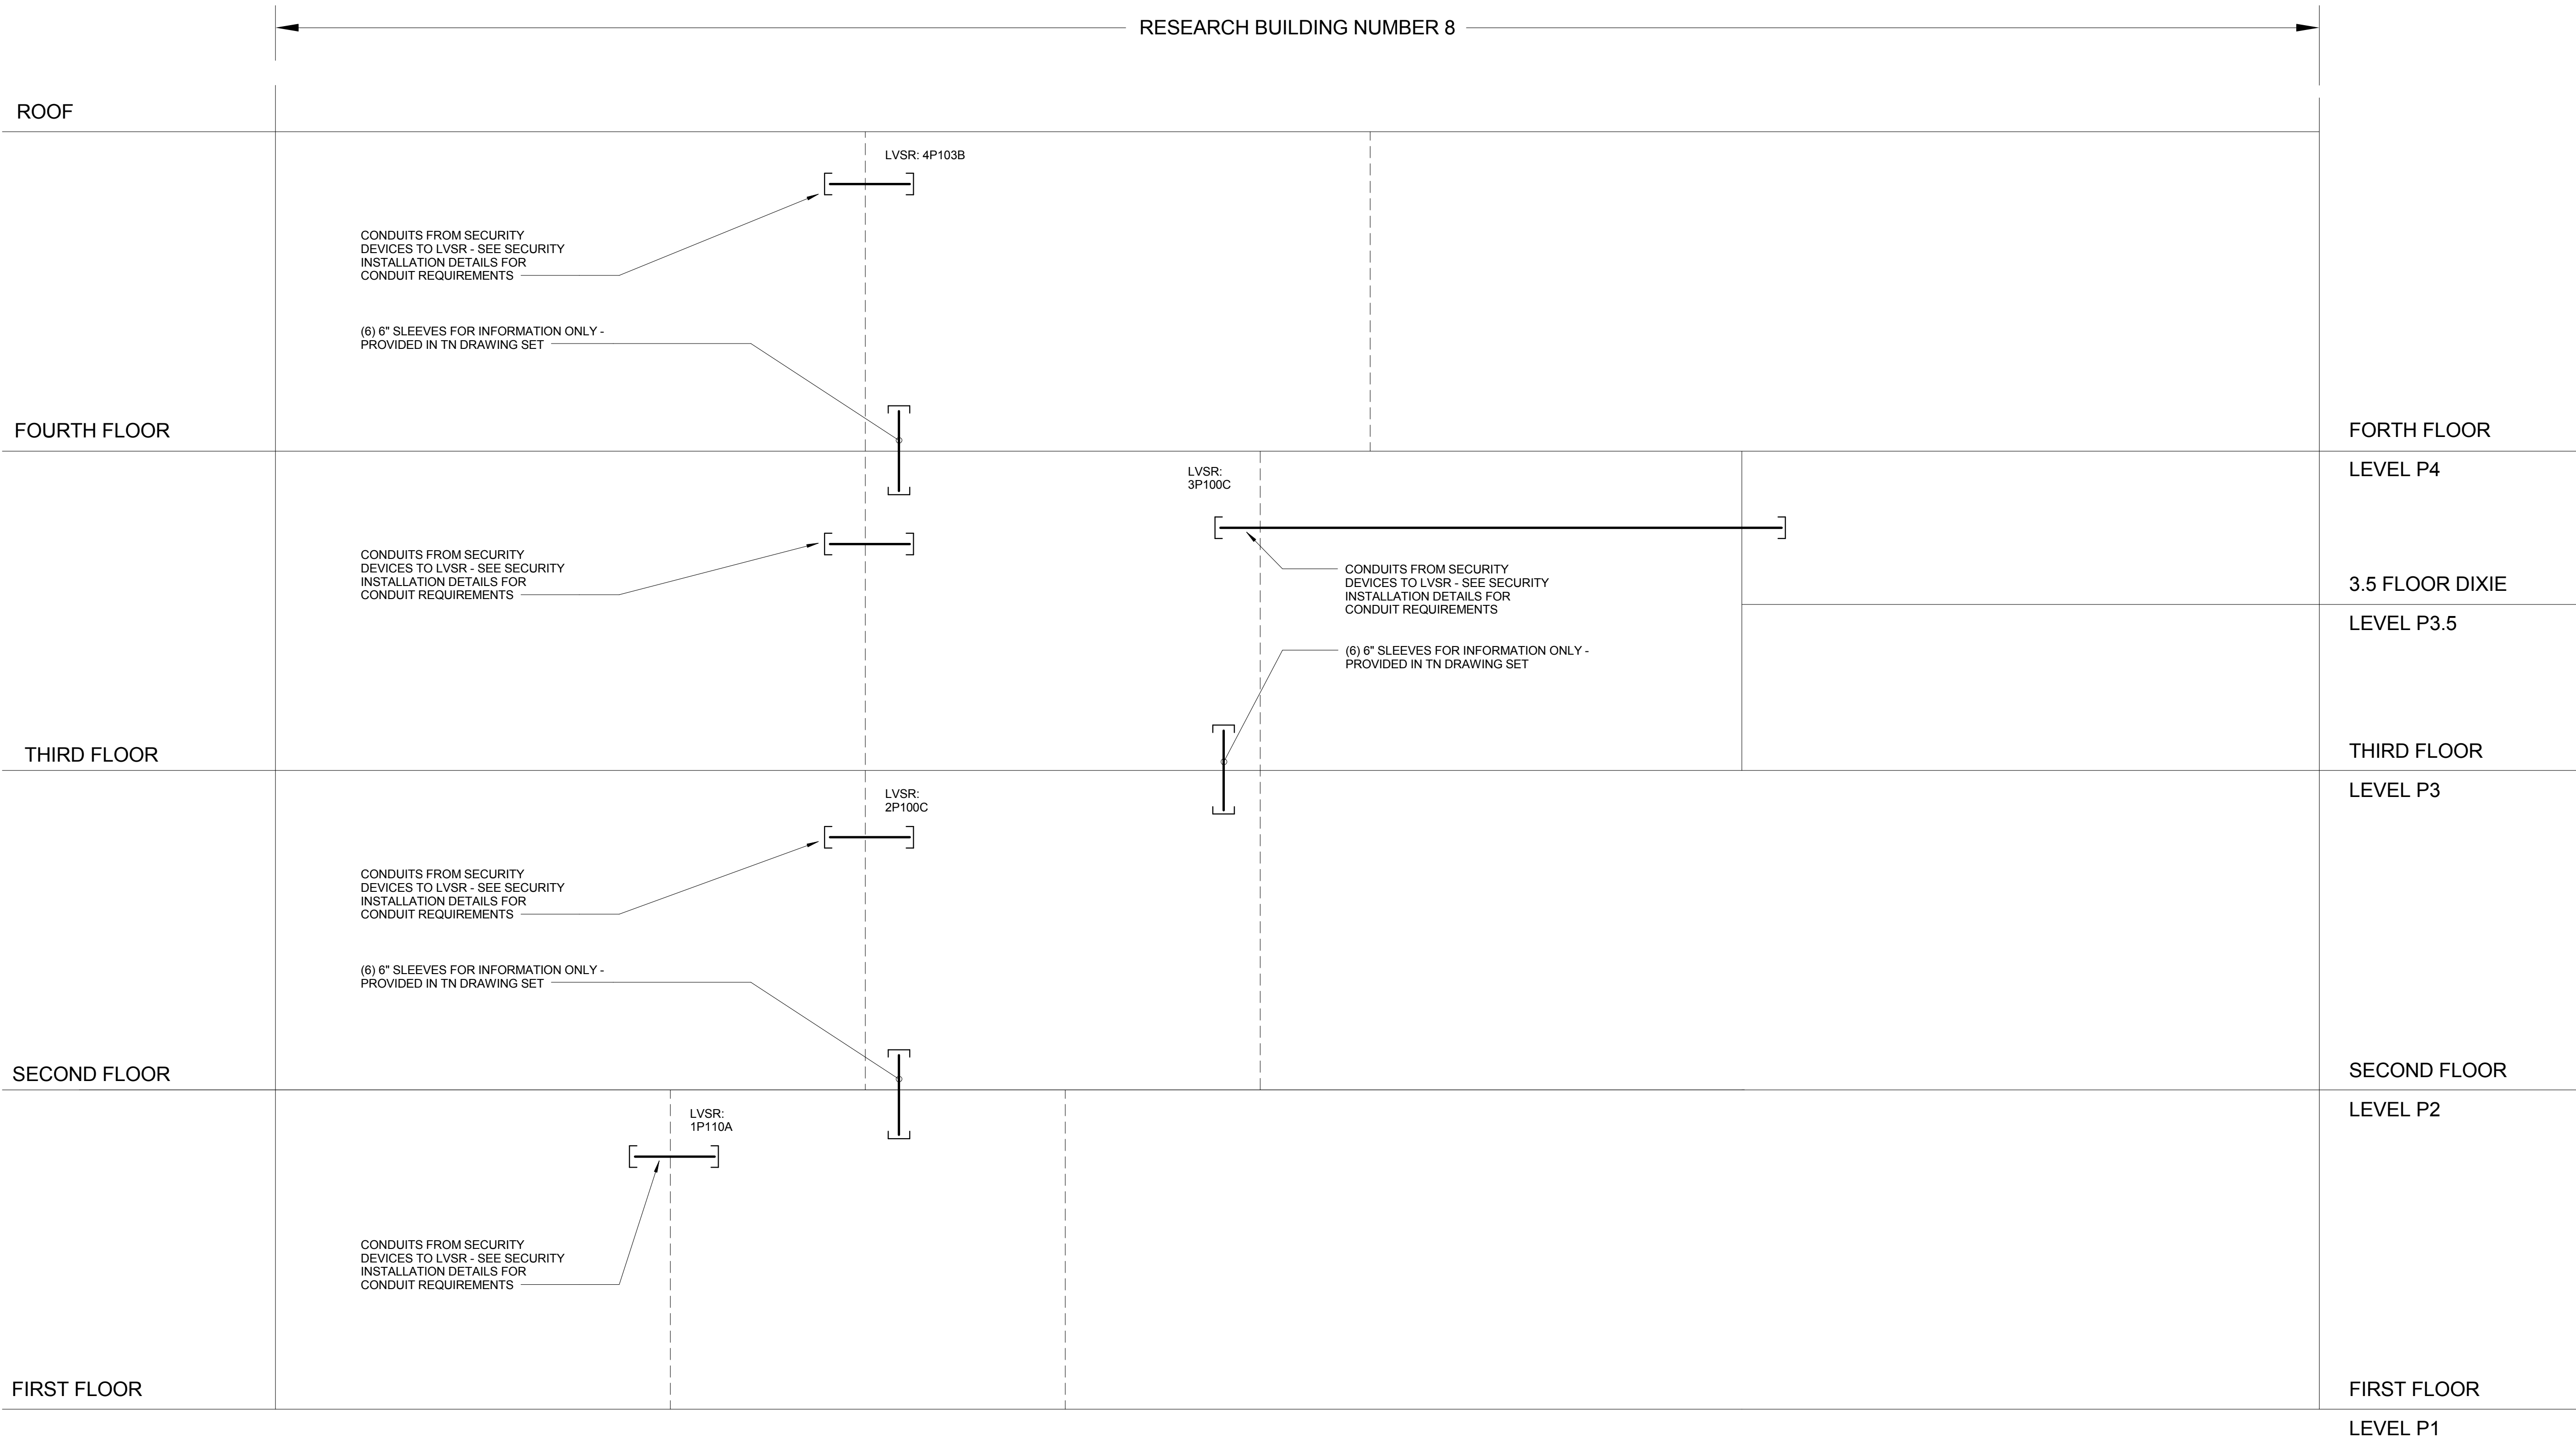


REVISIONS:

DATE

CONSULTANTS:

DESMAN ASSOCIATES / PARKING  
CODE CONSULTANTS, INC. / CODE CONSULTANT  
THE SEXTANT GROUP / AV & ACOUSTICAL  
HAMMER DESIGN ASSOCIATES / FOOD SERVICE  
PYBURN & ODOM / ABATEMENT  
TATA & HOWARD / TANK CONSULTANT  
I.S.C. GROUP, INC. / IRRIGATION  
DAN EUSER WATER ARCHITECTURE, INC. / WATER FEATURE



JUL 3 6 2012


ARCHITECT/ENGINEERS:

studio **NOVA**  
SCHRENK & PETERSON CONSULTING ENGINEERS / CIVIL  
KORDA/NEMETH ENGINEERING / STRUCTURAL  
BR+A CONSULTING ENGINEERS / MECH, ELECT, PLUMBING, LOW VOLTAGE  
ARCHITECTURAL ENGINEERING/ PLUMBING  
SCALES ASSOCIATES / FIRE PROTECTION

DRAWING TITLE

BUILDING 08 - SECURITY CONDUIT RISER  
DIAGRAM

APPROVED: PROJECT DIRECTOR



PROJECT TITLE

SLVHCS REPLACEMENT MEDICAL  
CENTER PROJECT

LOCATION

NEW ORLEANS, LOUISIANA

DATE

July 16, 2012

CHECKED

JLE

DRAWN

JJP

PROJECT NUMBER

629-HS2-401

DOCUMENT SET PACKAGE

WP\_09B

 
DRAWING NUMBER

8TY601


BUILDING NUMBER

08

OFFICE OF  
CONSTRUCTION  
AND FACILITIES  
MANAGEMENT





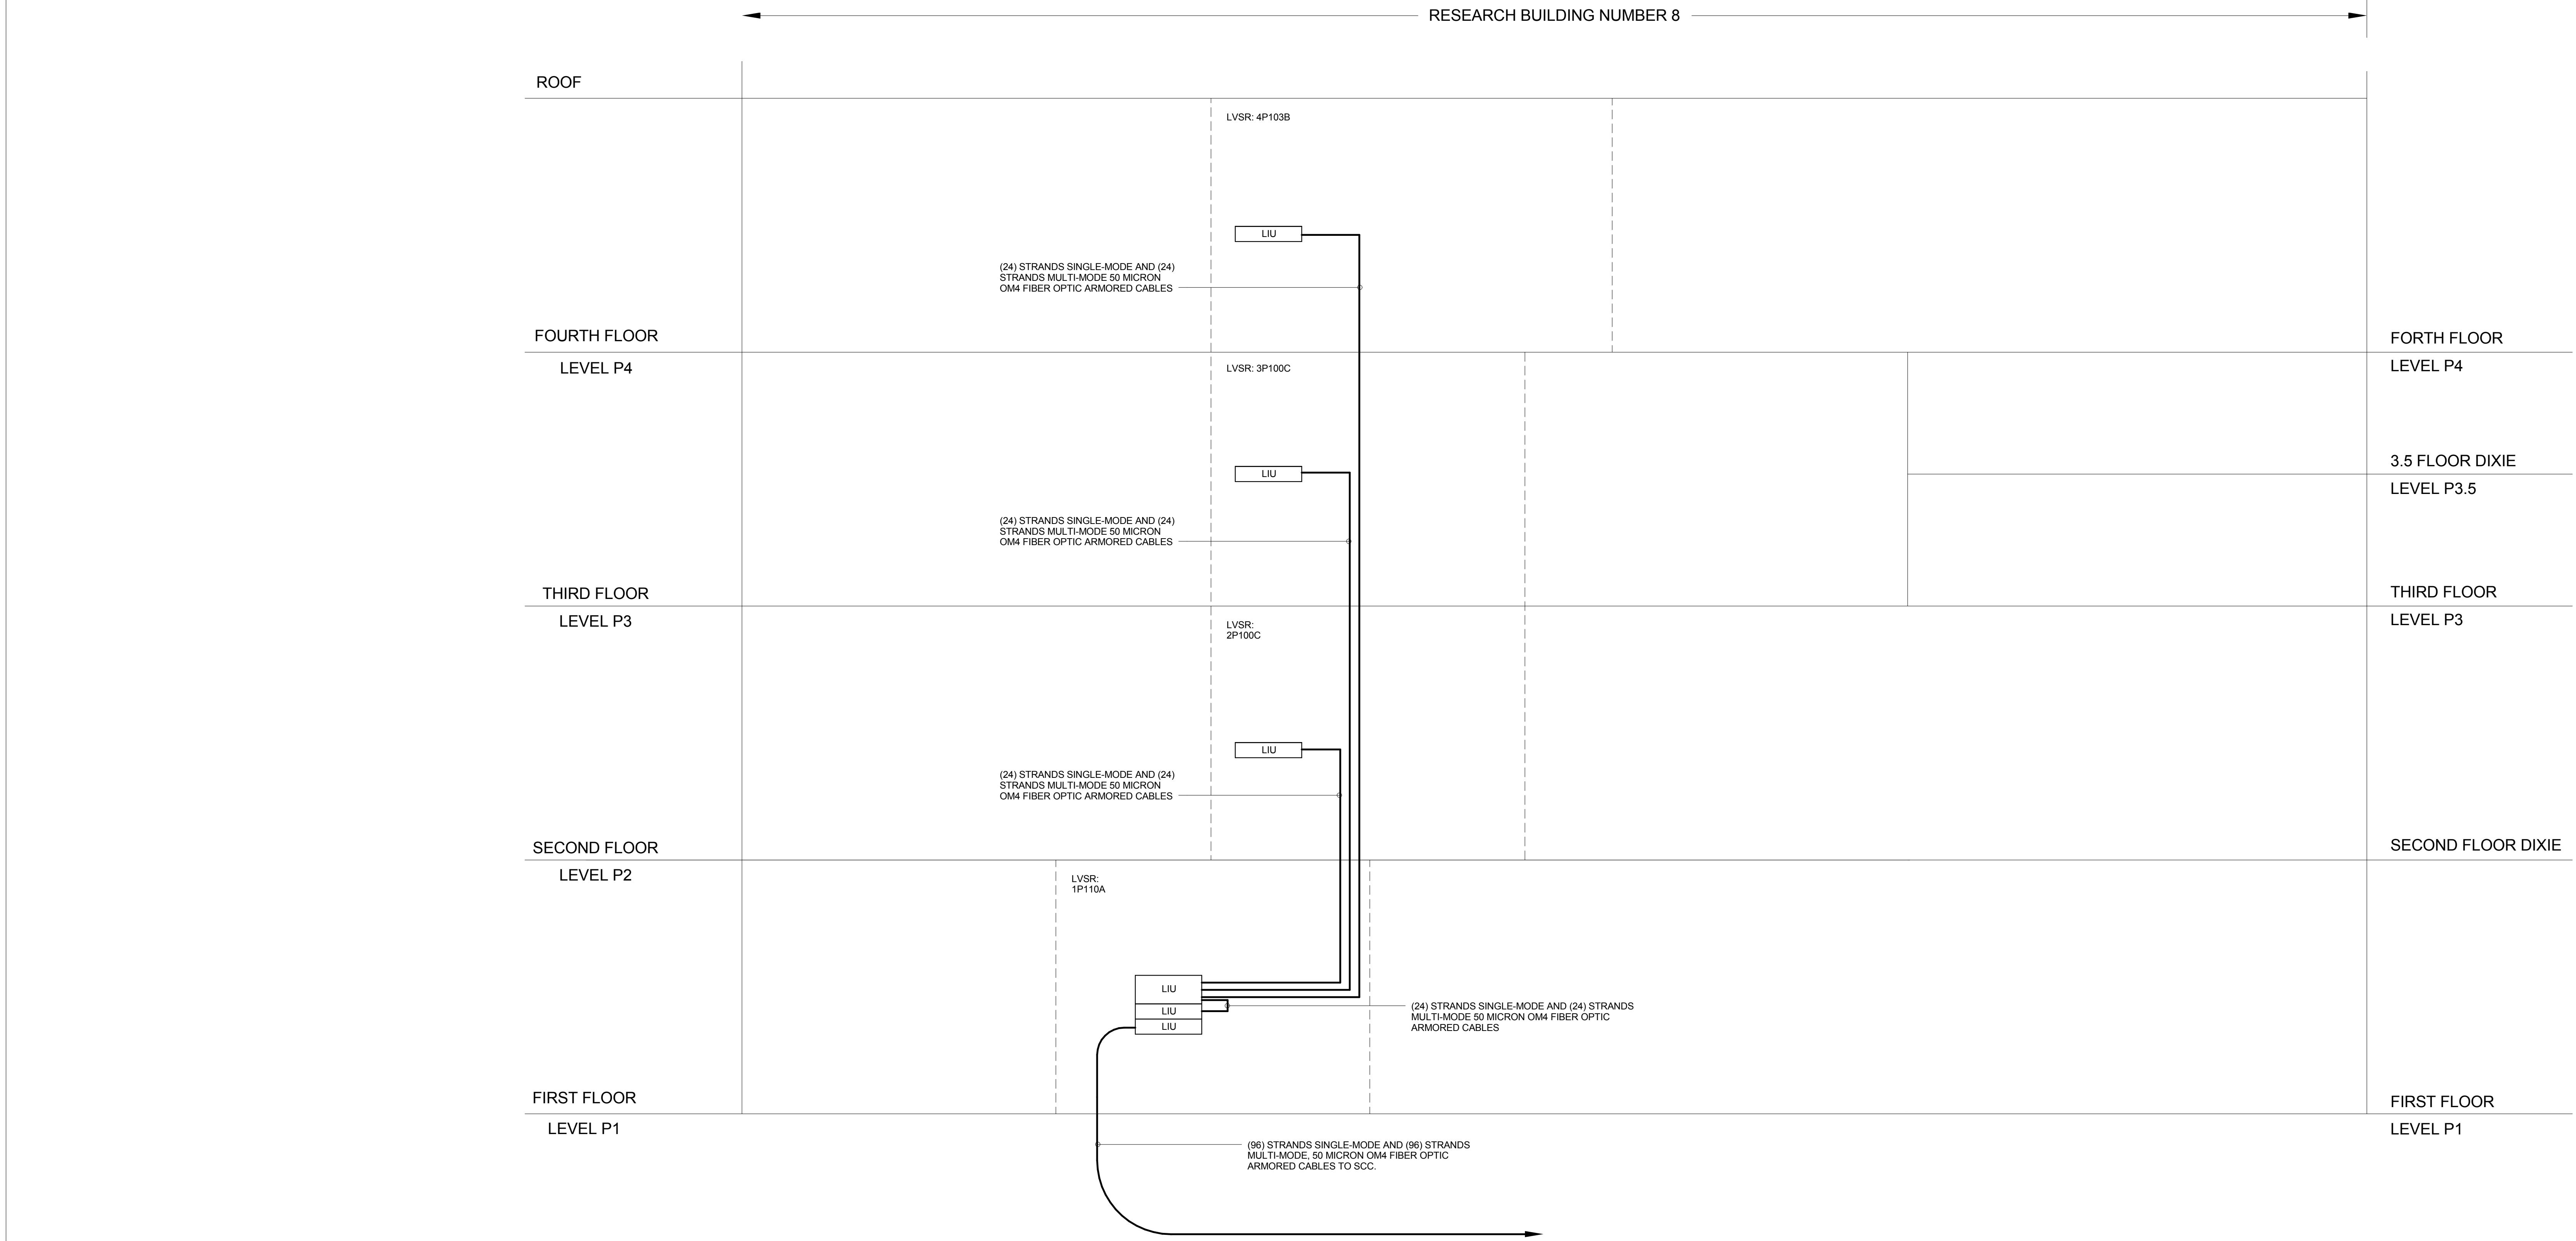


REVISIONS:

DATE

CONSULTANTS:

DESMAN ASSOCIATES / PARKING  
CODE CONSULTANTS, INC. / CODE CONSULTANT  
THE SEXTANT GROUP / AV & ACOUSTICAL  
HAMMER DESIGN ASSOCIATES / FOOD SERVICE  
PYBURN & ODOM / ABATEMENT  
TATA & HOWARD / TANK CONSULTANT  
I.S.C. GROUP, INC. / IRRIGATION  
DAN EUSER WATER ARCHITECTURE, INC. / WATER FEATURE



JUL 3 6 2012


ARCHITECT/ENGINEERS:

studio **NOVA**  
SCHRENK & PETERSON CONSULTING ENGINEERS / CIVIL  
KORDA/NEMETH ENGINEERING / STRUCTURAL  
BR+A CONSULTING ENGINEERS / MECH, ELECT, PLUMBING, LOW VOLTAGE  
ARCHITECTURAL ENGINEERING/ PLUMBING  
SCALES ASSOCIATES / FIRE PROTECTION

DRAWING TITLE

BUILDING 08 - SECURITY SYSTEMS FIBER OPTIC  
BACKBONE RISER DIAGRAM

APPROVED: PROJECT DIRECTOR

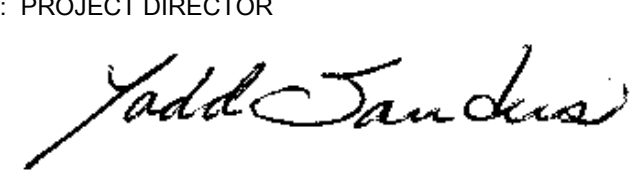

PROJECT TITLE

SLVHCS REPLACEMENT MEDICAL  
CENTER PROJECT

LOCATION

NEW ORLEANS, LOUISIANA

DATE

July 16, 2012

CHECKED

JLE

DRAWN

JJP

PROJECT NUMBER

629-HS2-401

DOCUMENT SET PACKAGE

WP\_09B


DRAWING NUMBER

8TY602

BUILDING NUMBER

08

OFFICE OF  
CONSTRUCTION  
AND FACILITIES  
MANAGEMENT



VA FORM 08-6231

6

5

4

3

2

1

ONE INCH = FORTY FEET (1" = 40')


ONE AND ONE HALF INCHES = ONE FOOT

ONE HALF INCH = ONE FOOT

ONE QUARTER INCH = ONE FOOT




ONE EIGHT INCH = ONE FOOT

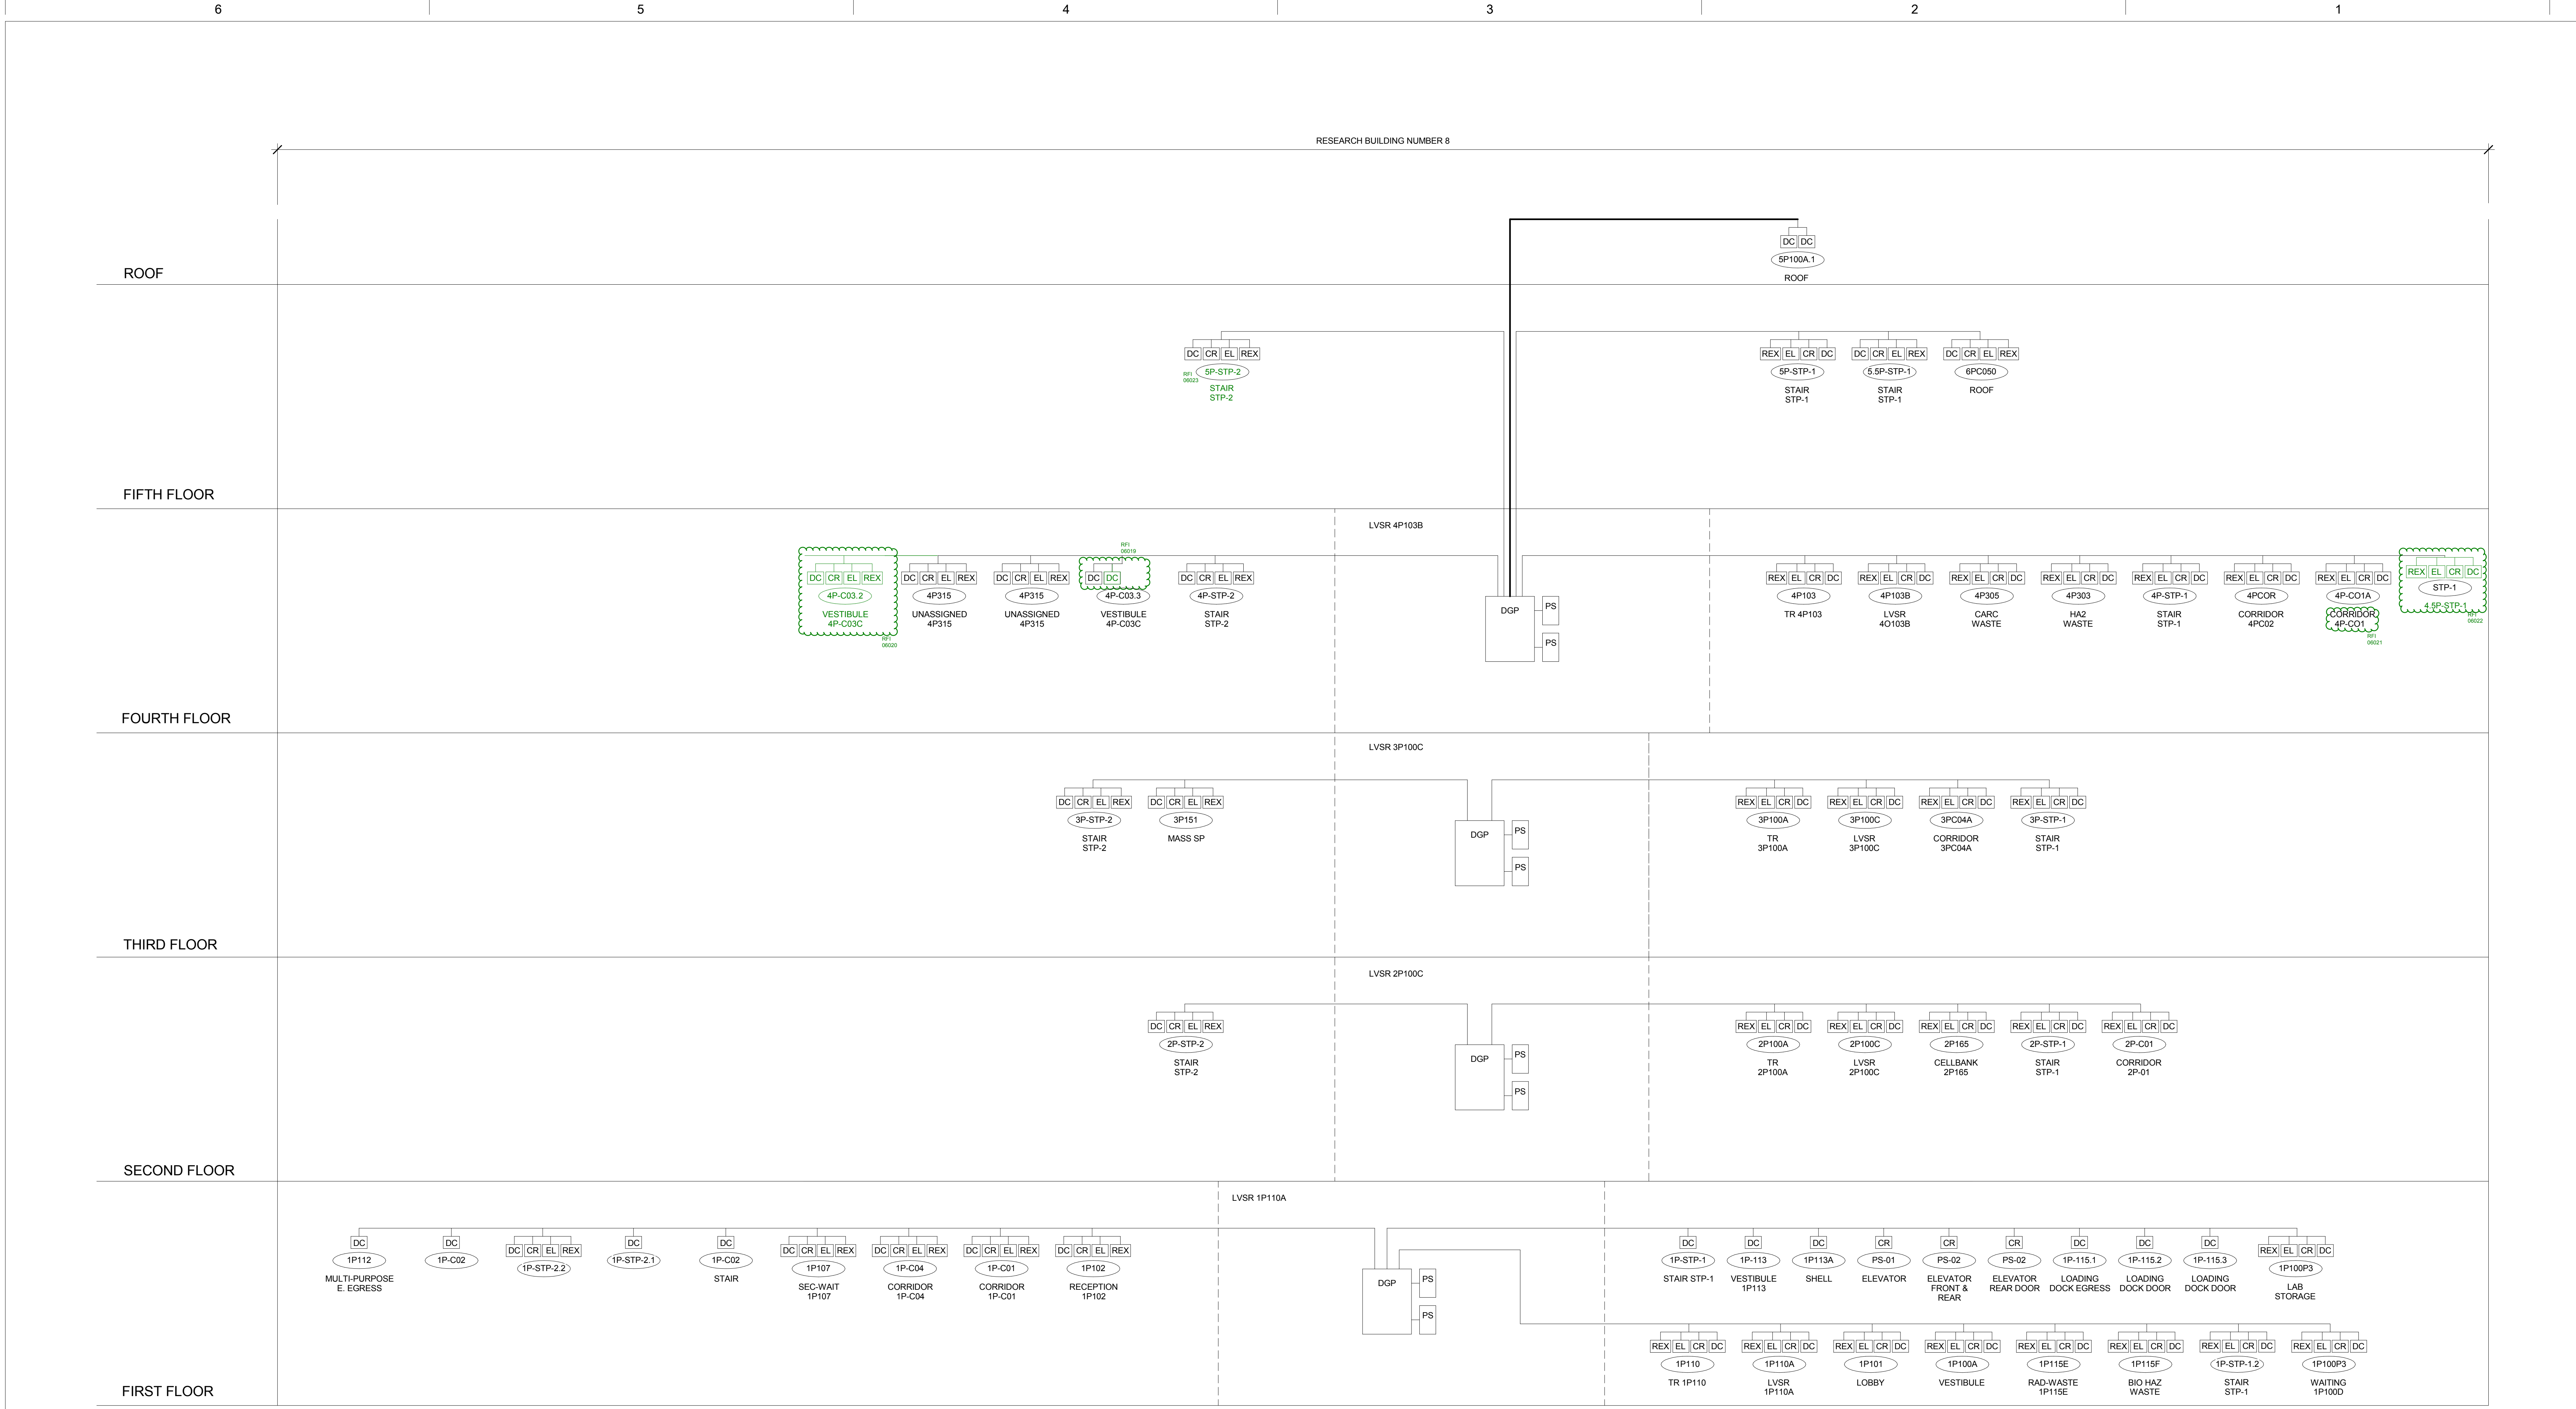ONE SIXTEENTH INCH = ONE FOOT




1 PHYSICAL ACCESS CONTROL SYSTEM  
12" = 1'-0"

NOTES:  
1. HARDWARE SETS, WHERE SHOWN, ARE FOR INFORMATION ONLY.  
2. RISER DIAGRAM IS REPRESENTATIVE OF NUMBER OF DOORS, DOOR NUMBERS AND ROOM NAMES ONLY.  
3. REFER TO FLOOR PLANS AND DOOR ELEVATION DETAILS FOR ACTUAL DEVICE AND WIRING REQUIREMENTS.

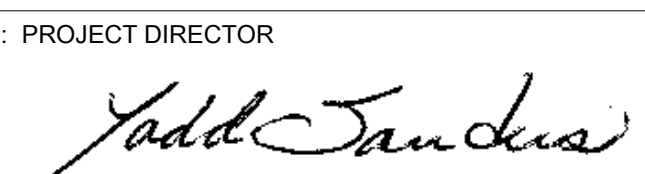
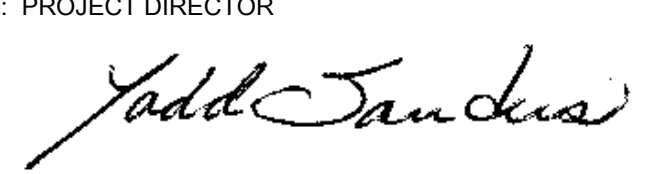

<b>CONSULTANTS:</b> DESMAN ASSOCIATES / PARKING CODE CONSULTANTS, INC. / CODE CONSULTANT THE SEXTANT GROUP / AV & ACOUSTICAL HAMMER DESIGN ASSOCIATES / FOOD SERVICE PYBURN & ODOM / ABATEMENT TATA & HOWARD / TANK CONSULTANT I.S.C. GROUP, INC. / IRRIGATION DAN EUSER WATER ARCHITECTURE, INC. / WATER FEATURE		 JUL 3 6 2012		<b>ARCHITECT/ENGINEERS:</b> studio <b>NOVA</b> SCHRENK & PETERSON CONSULTING ENGINEERS / CIVIL KORDA/NEMETH ENGINEERING / STRUCTURAL BR+A CONSULTING ENGINEERS / MECH, ELECT, PLUMBING, LOW VOLTAGE ARCHITECTURAL ENGINEERING/ PLUMBING SCALES ASSOCIATES / FIRE PROTECTION		<b>DRAWING TITLE</b> BUILDING 08 - PHYSICAL ACCESS CONTROL SYSTEM (PACS)		<b>PROJECT TITLE</b> SLVHCS REPLACEMENT MEDICAL CENTER PROJECT		<b>PROJECT NUMBER</b> 629-HS2-401 <b>BUILDING NUMBER</b> 08		<b>OFFICE OF CONSTRUCTION AND FACILITIES MANAGEMENT</b> 	
<b>REVISIONS:</b>		<b>DATE</b>		<b>APPROVED: PROJECT DIRECTOR</b> 		<b>LOCATION</b> NEW ORLEANS, LOUISIANA		<b>DATE</b> July 16, 2012		<b>CHECKED</b> JLE		<b>DRAWN</b> JJP	
										<b>DOCUMENT SET PACKAGE</b> WP_09B		<b>DRAWING NUMBER</b> 8TY603	





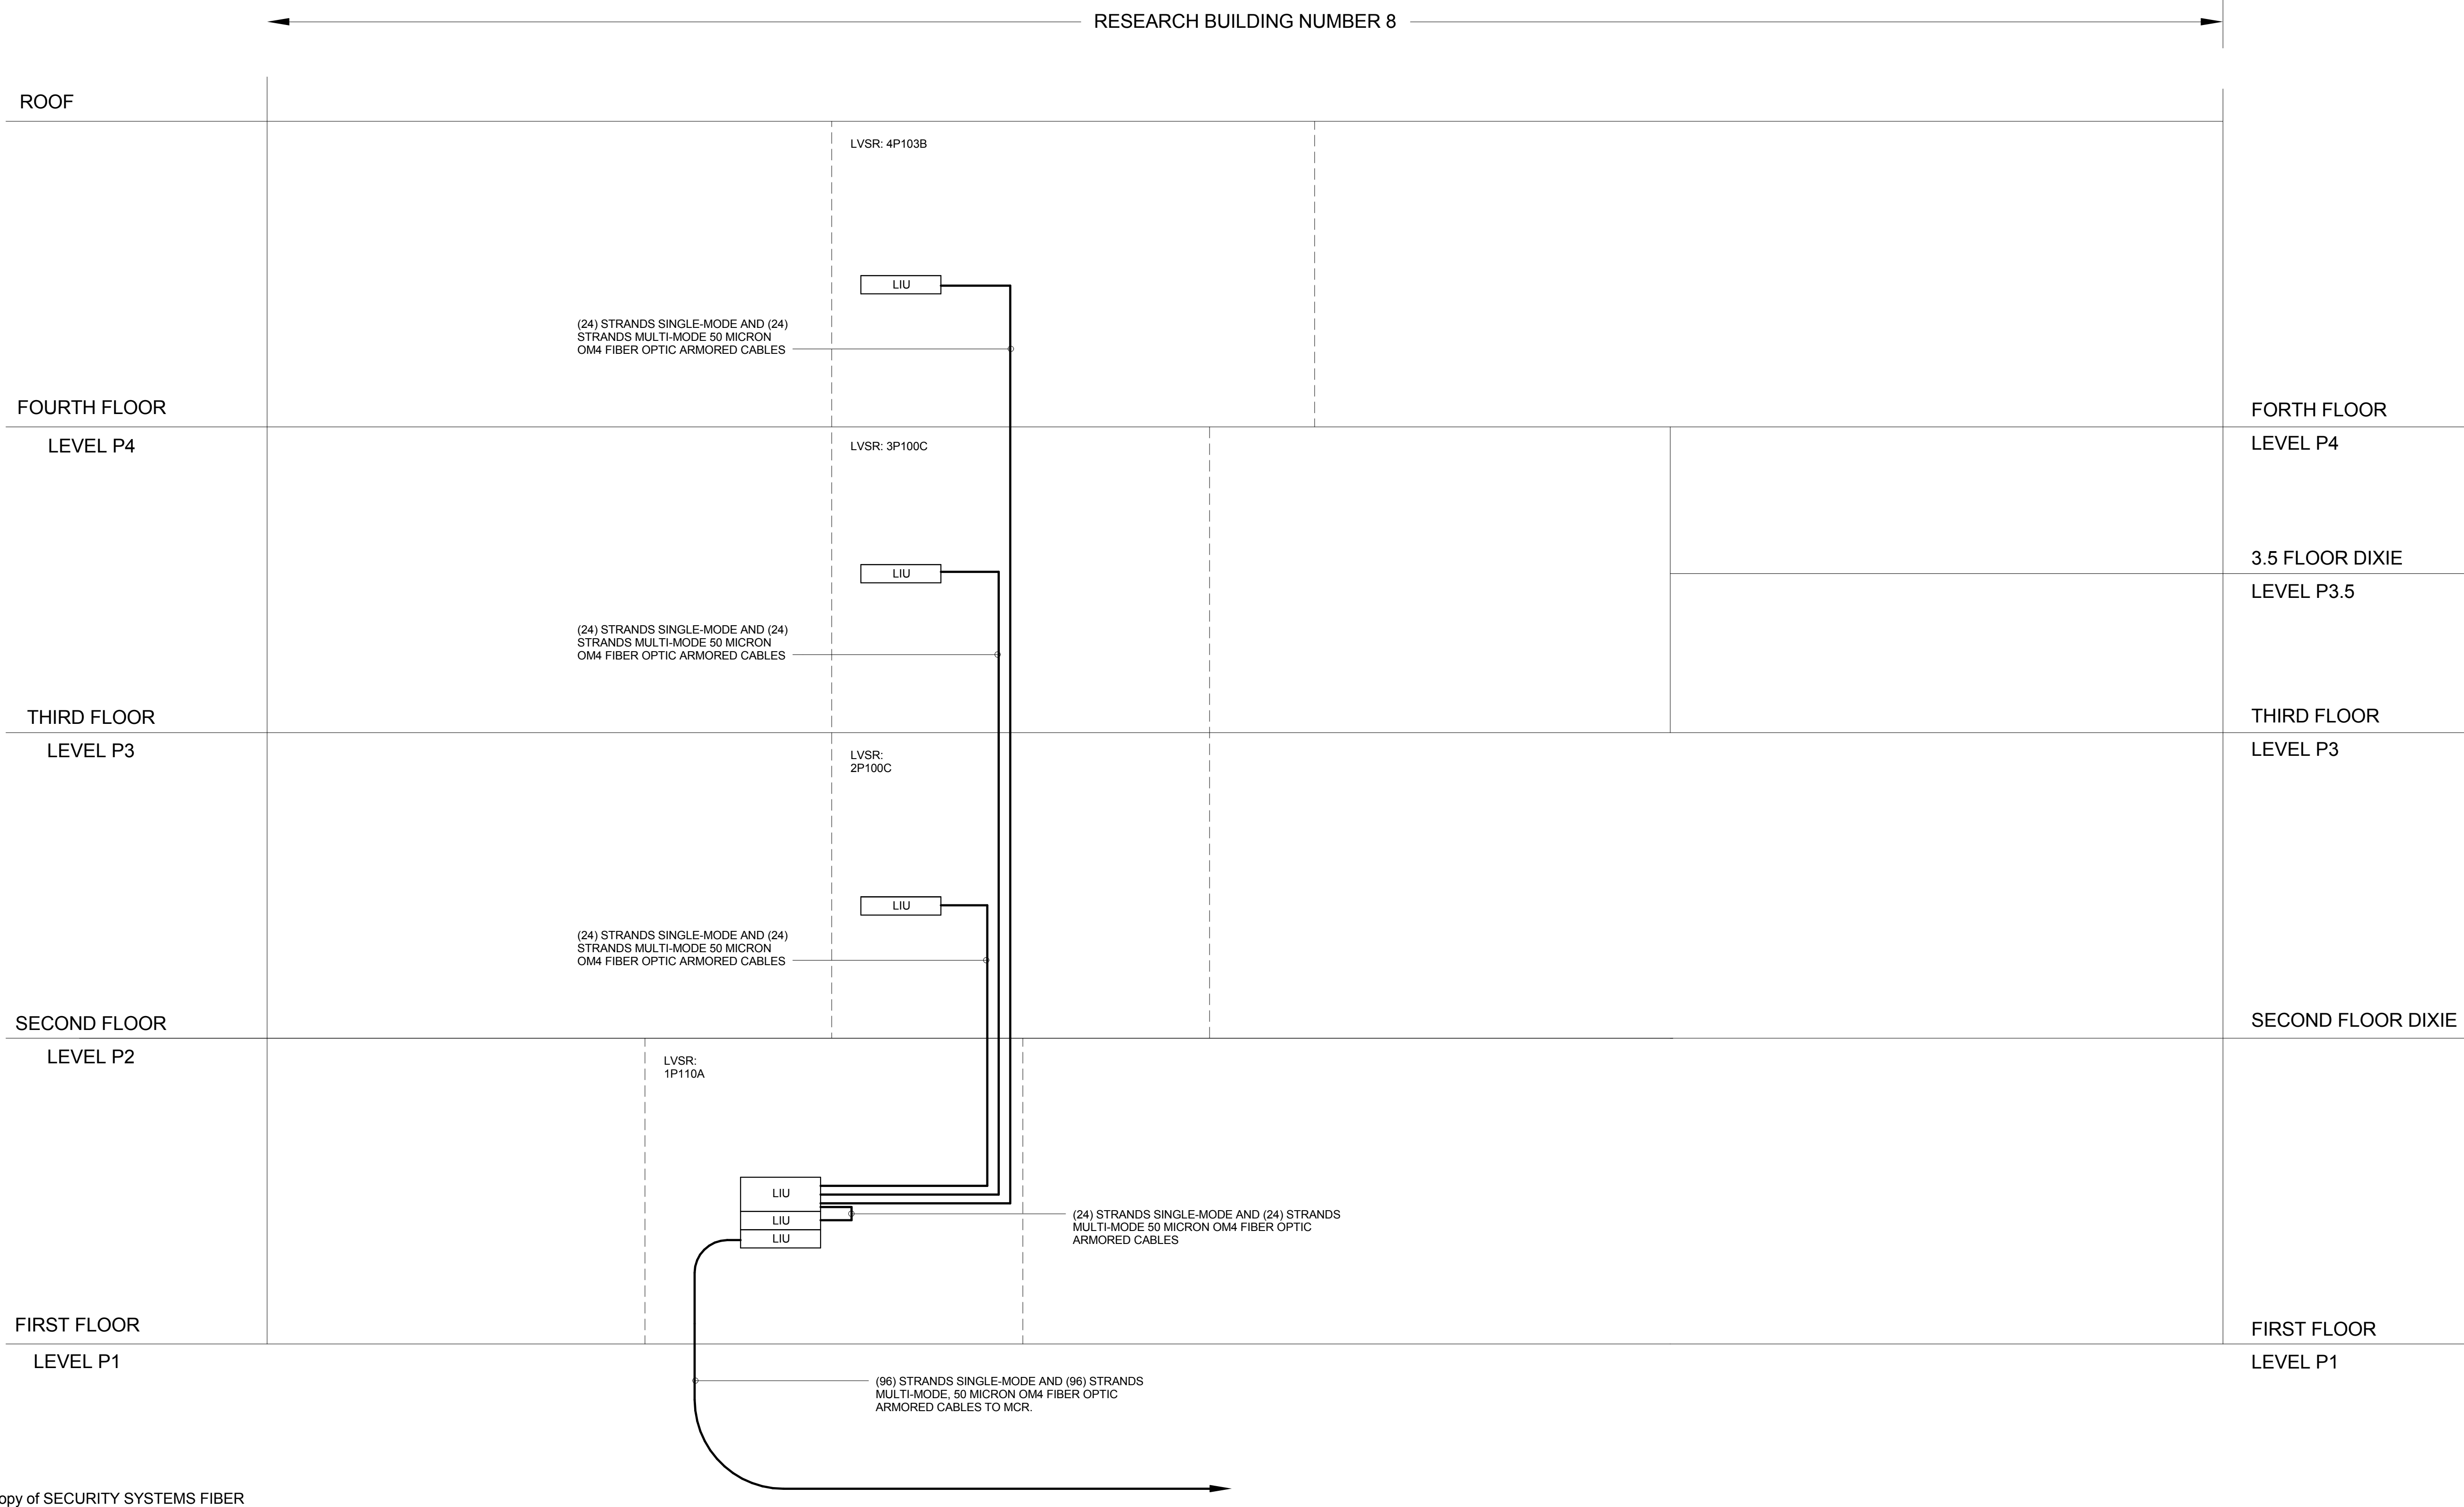

Copy of SECURITY SYSTEMS FIBER OPTIC BACKBONE RISER DIAGRAM  
12" = 1'-0"

<b>REVISIONS:</b>		<b>DATE</b>		<b>CONSULTANTS:</b> DESMAN ASSOCIATES / PARKING CODE CONSULTANTS, INC. / CODE CONSULTANT THE SEXTANT GROUP / AV & ACOUSTICAL HAMMER DESIGN ASSOCIATES / FOOD SERVICE PYBURN & ODOM / ABATEMENT TATA & HOWARD / TANK CONSULTANT I.S.C. GROUP, INC. / IRRIGATION DAN EUSER WATER ARCHITECTURE, INC. / WATER FEATURE	 JUL 3 6 2012	<b>ARCHITECT/ENGINEERS:</b> studio <b>NOVA</b> SCHRENK & PETERSON CONSULTING ENGINEERS / CIVIL KORDA/NEMETH ENGINEERING / STRUCTURAL BR+A CONSULTING ENGINEERS / MECH, ELECT, PLUMBING, LOW VOLTAGE ARCHITECTURAL ENGINEERING/ PLUMBING SCALES ASSOCIATES / FIRE PROTECTION	<b>DRAWING TITLE</b> BUILDING 08 - SPECIAL SYSTEMS BACKBONE RISER DIAGRAM  <b>APPROVED:</b> PROJECT DIRECTOR 	<b>PROJECT TITLE</b> SLVHCS REPLACEMENT MEDICAL CENTER PROJECT  <b>LOCATION</b> NEW ORLEANS, LOUISIANA <b>DATE</b> July 16, 2012	<b>PROJECT NUMBER</b> 629-HS2-401 <b>BUILDING NUMBER</b> 08 <b>DOCUMENT SET PACKAGE</b> WP-09B <b>DRAWING NUMBER</b> 8TY605	<b>OFFICE OF CONSTRUCTION AND FACILITIES MANAGEMENT</b> 
-------------------	--	-------------	--	---	---	---	---	---	--	--