

ONE INCH = FORTY FEET (1" = 40')

THREE INCHES = ONE FOOT

ONE AND ONE HALF INCHES = ONE FOOT


THREE QUARTERS INCH = ONE FOOT

ONE HALF INCH = ONE FOOT

ONE QUARTER INCH = ONE FOOT

ONE EIGHT INCH = ONE FOOT

ONE SIXTEENTH INCH = ONE FOOT

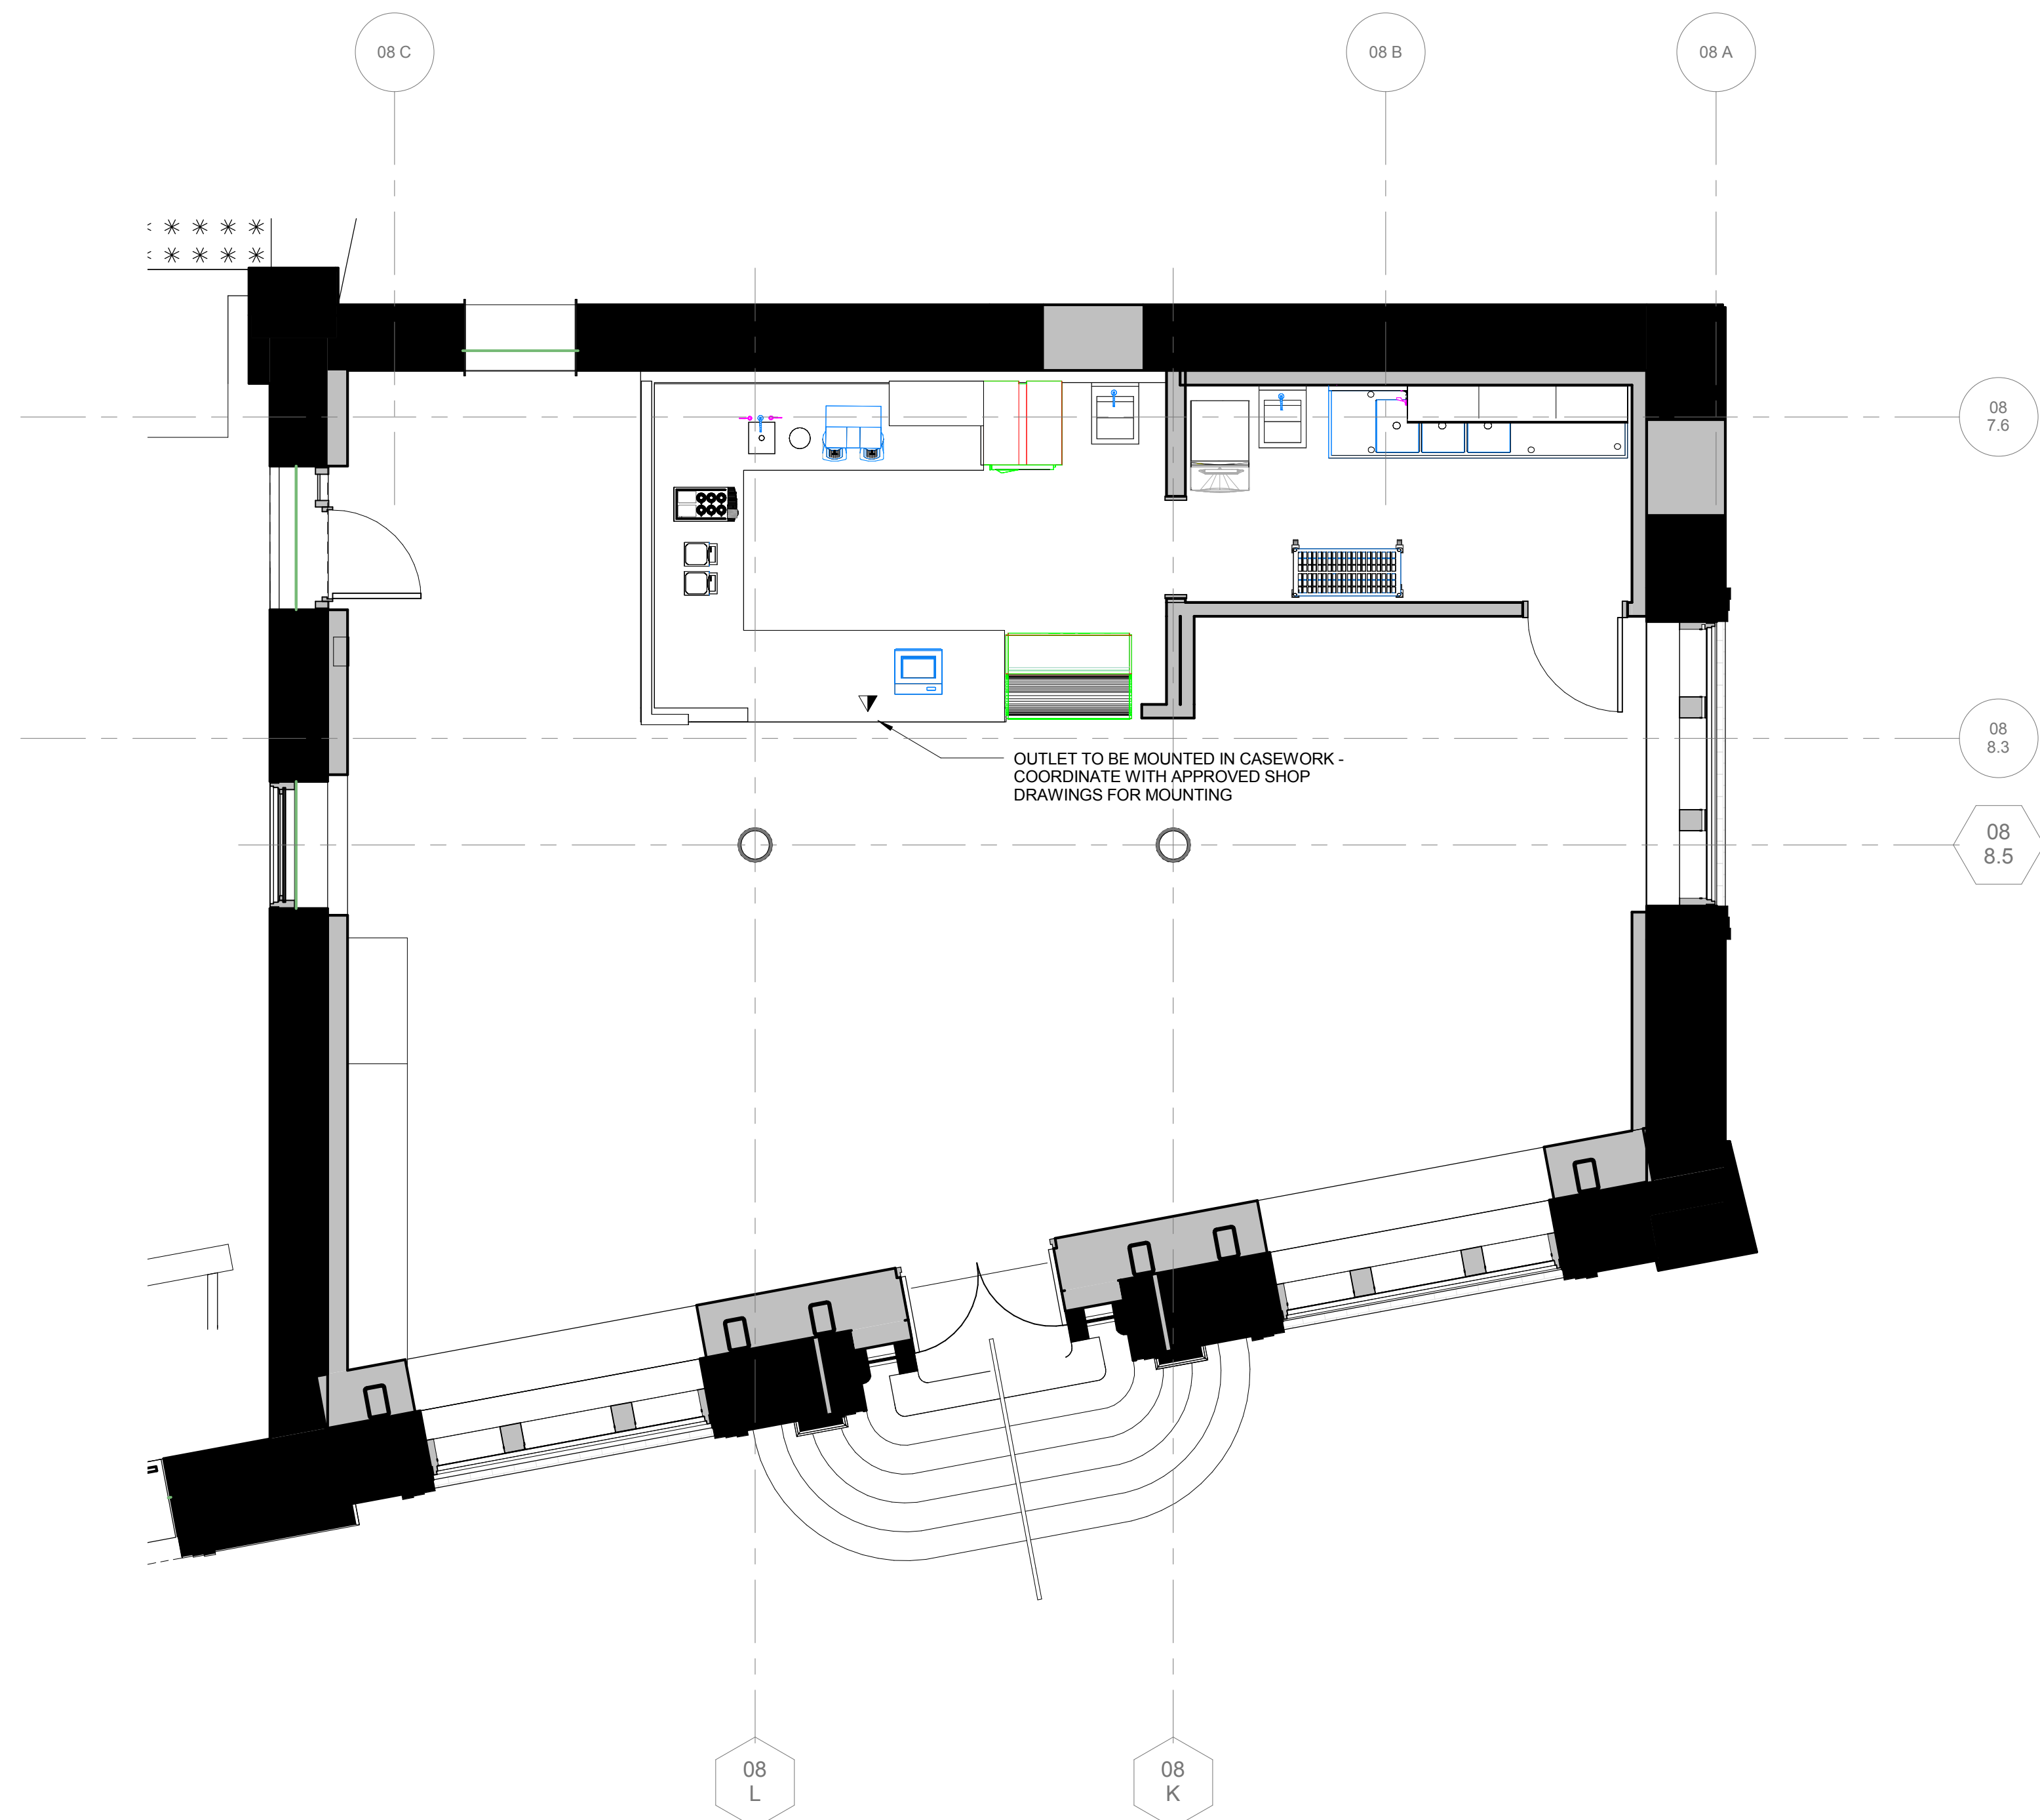

ADD-ALT #1 DEVICE COUNT FIRST FLOOR						
OUTLET	SUBSCRIPT	DATA PORTS	VOICE PORTS	OUTLET COUNT	DATA PANELS	VOICE PANELS
Standard						
STANDARD OUTLET		2	2	1	0.04	0.04
TV OUTLET	TV	1	0	1	0.02	0
2		3	2	2	0.06	0.04

② DIXIE CAFE - ADD ALTERNATE #1
1/4" = 1'-0"



			CONSULTANTS: DESMAN ASSOCIATES / PARKING CODE CONSULTANTS, INC. / CODE CONSULTANT THE SEXTANT GROUP / AV & ACOUSTICAL HAMMER DESIGN ASSOCIATES / FOOD SERVICE PYBURN & ODOM / ABATEMENT TATA & HOWARD / TANK CONSULTANT I.S.C. GROUP, INC./ IRRIGATION DAN EUSER WATER ARCHITECTURE, INC./ WATER FEATURE
REVISIONS:		DATE	













ARCHITECT/ENGINEERS:

studio **NOVA**

SCHRENK & PETERSON CONSULTING ENGINEERS / CIVIL
KORDA/NEMETH ENGINEERING / STRUCTURAL
BR+A CONSULTING ENGINEERS / MECH, ELECT, PLUMBING, LOW VOLTAGE
ARCHITECTURAL ENGINEERING/ PLUMBING
SCALES ASSOCIATES / FIRE PROTECTION


DRAWING TITLE BUILDING 08 - TELECOMMUNICATIONS PARTIAL PLAN - CAFE ADD ALTERNATE #1		PROJECT TITLE SLVHCS REPLACEMENT MEDICAL CENTER PROJECT		PROJECT NUMBER 629-HS2-401		BUILDING NUMBER 08		OFFICE OF CONSTRUCTION AND FACILITIES MANAGEMENT	
APPROVED: PROJECT DIRECTOR 		LOCATION NEW ORLEANS, LOUISIANA		DOCUMENT SET PACKAGE WP_09B		DRAWING NUMBER 8TN500			
		DATE July 16, 2012		CHECKED JLE	DRAWN JJP			 Department of Veterans Affairs	

 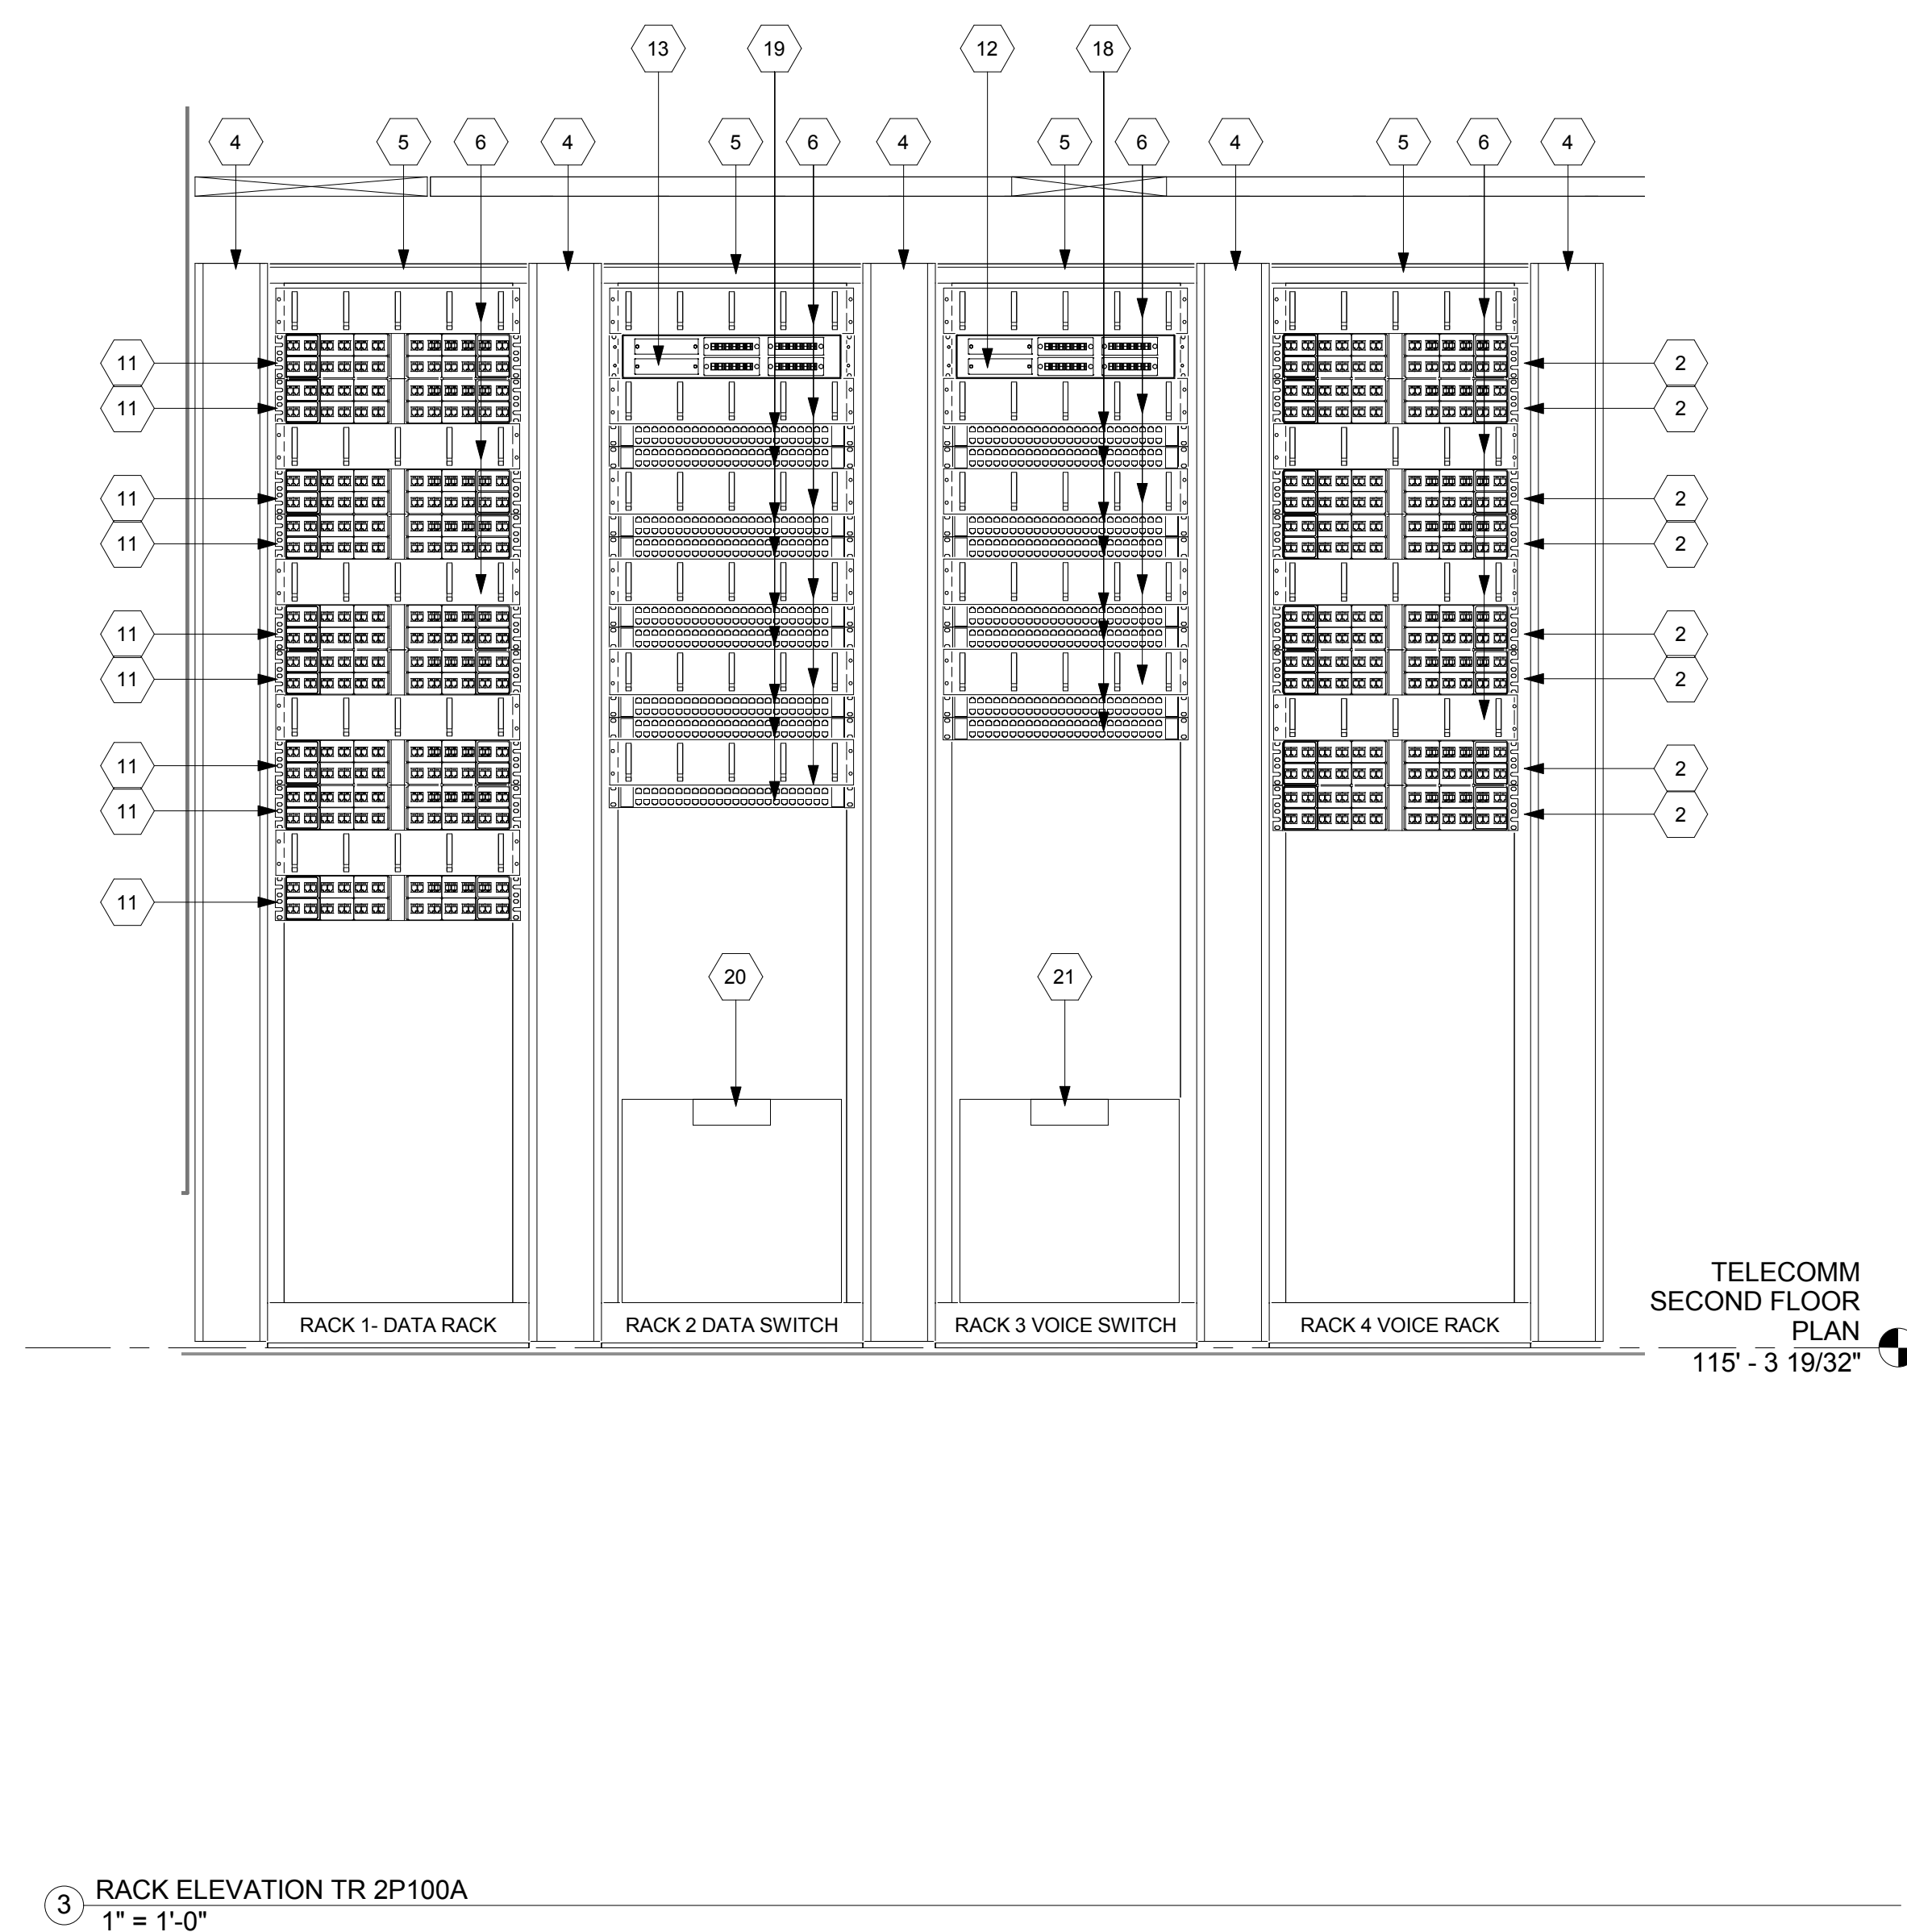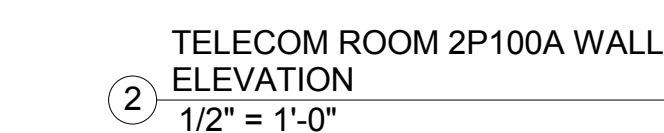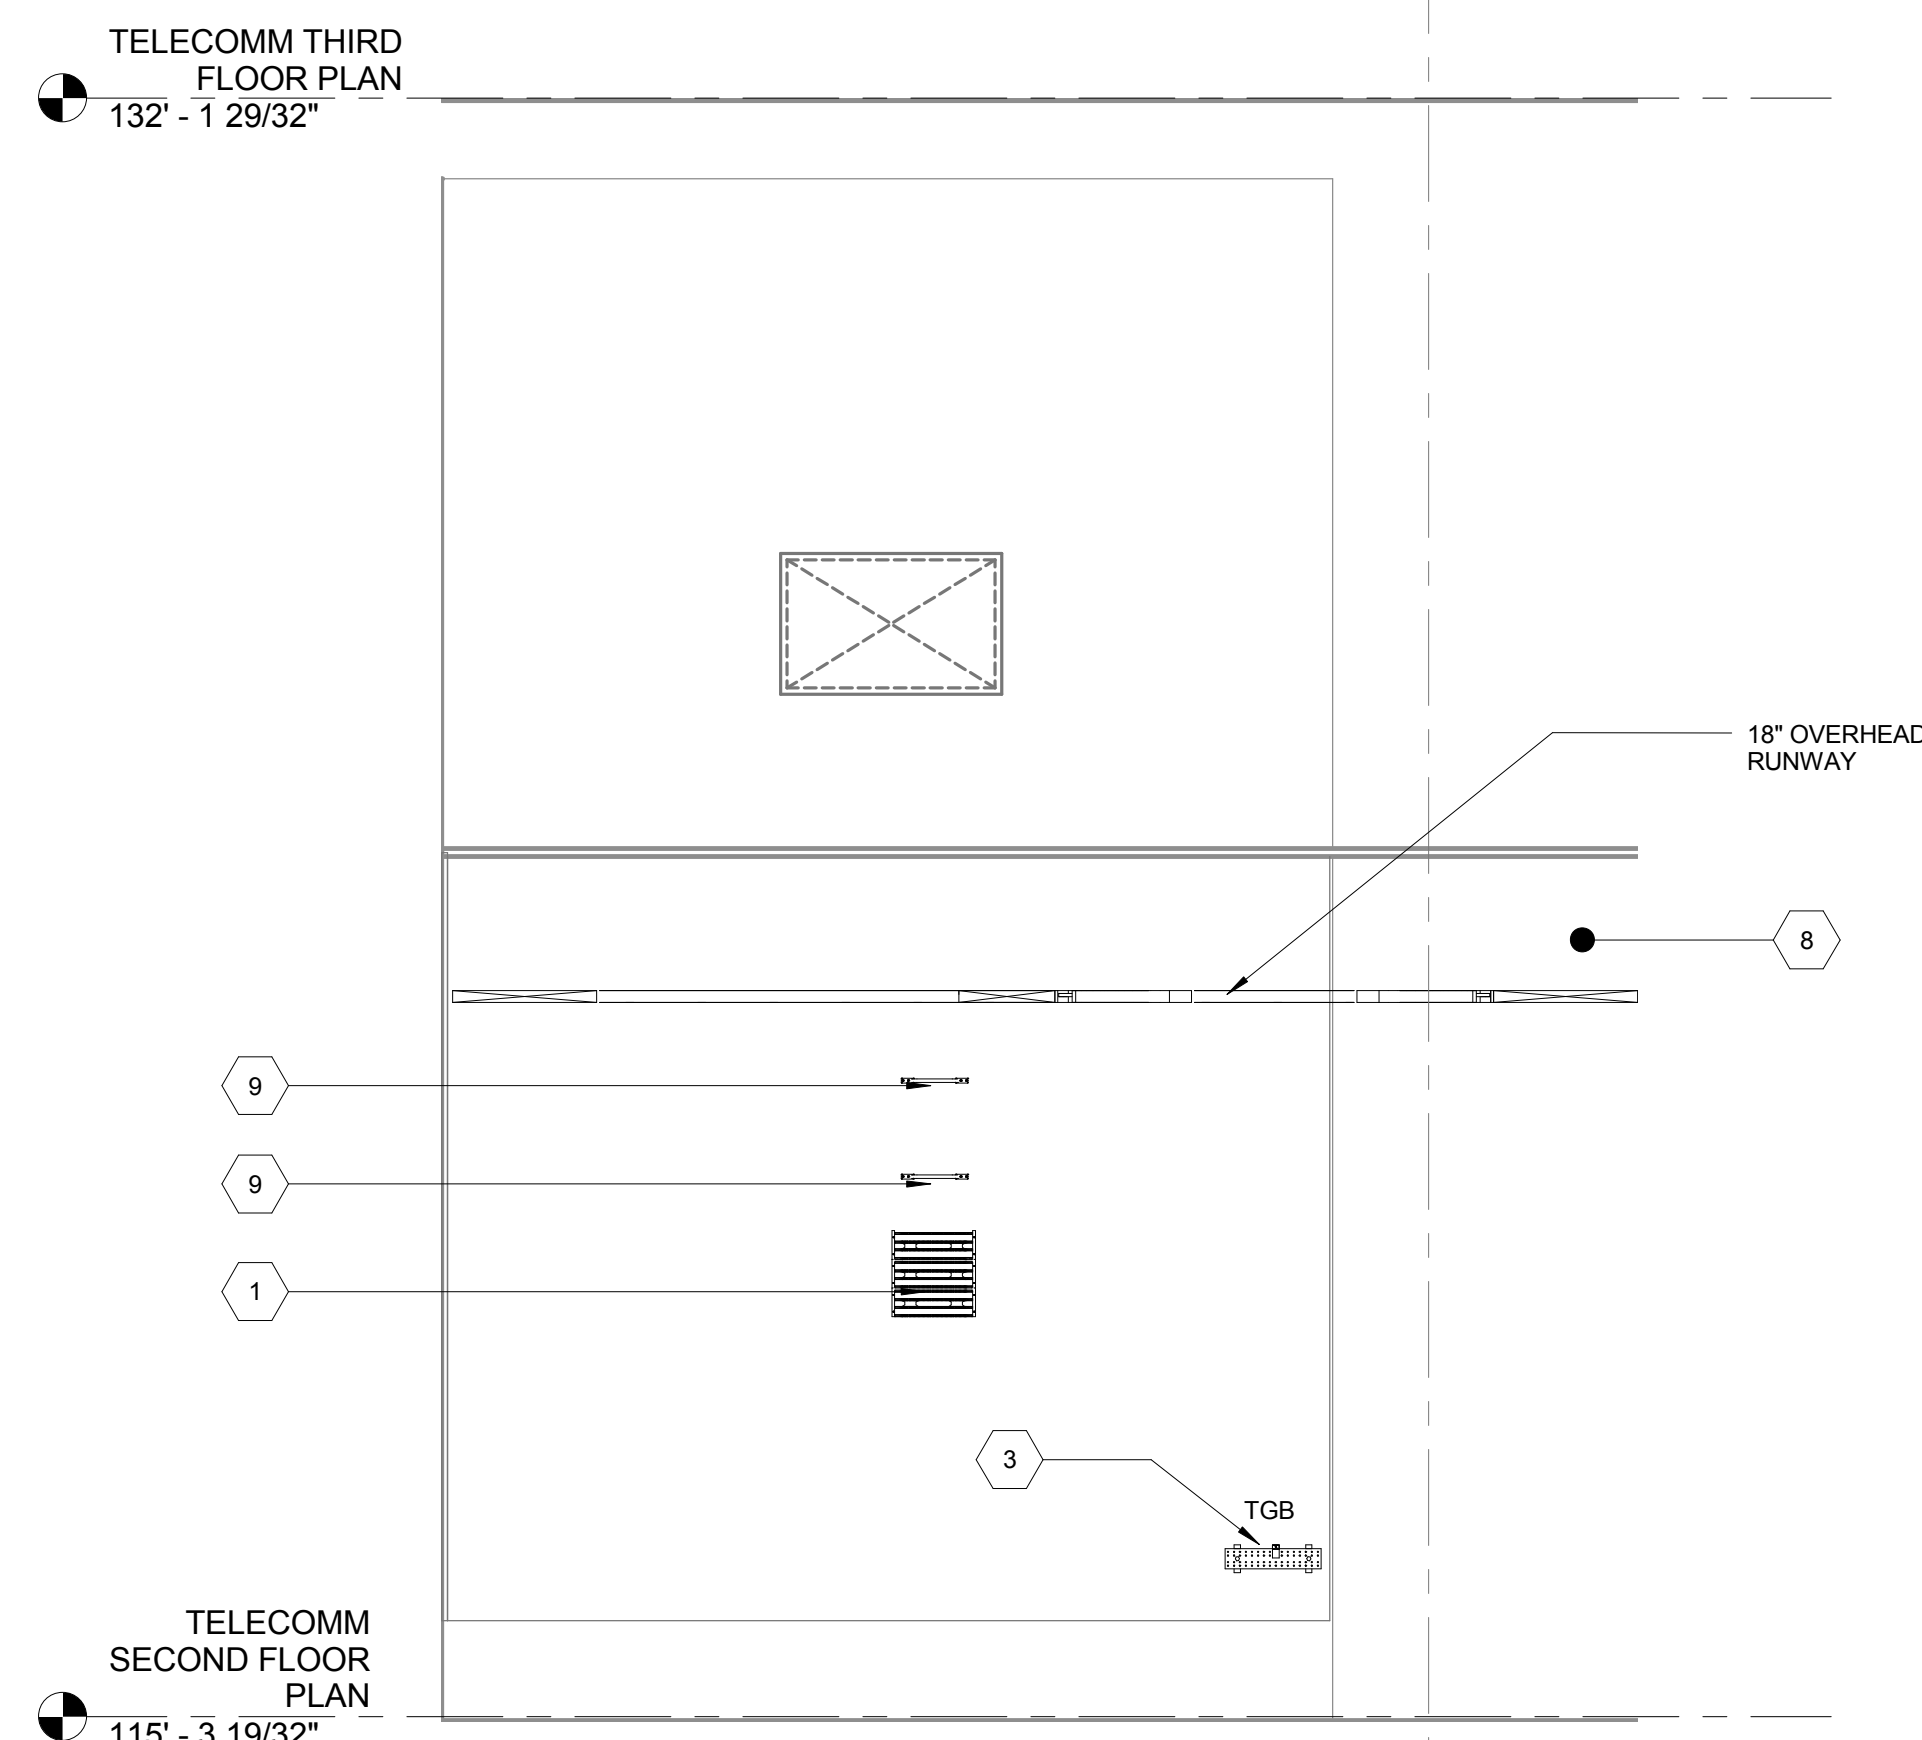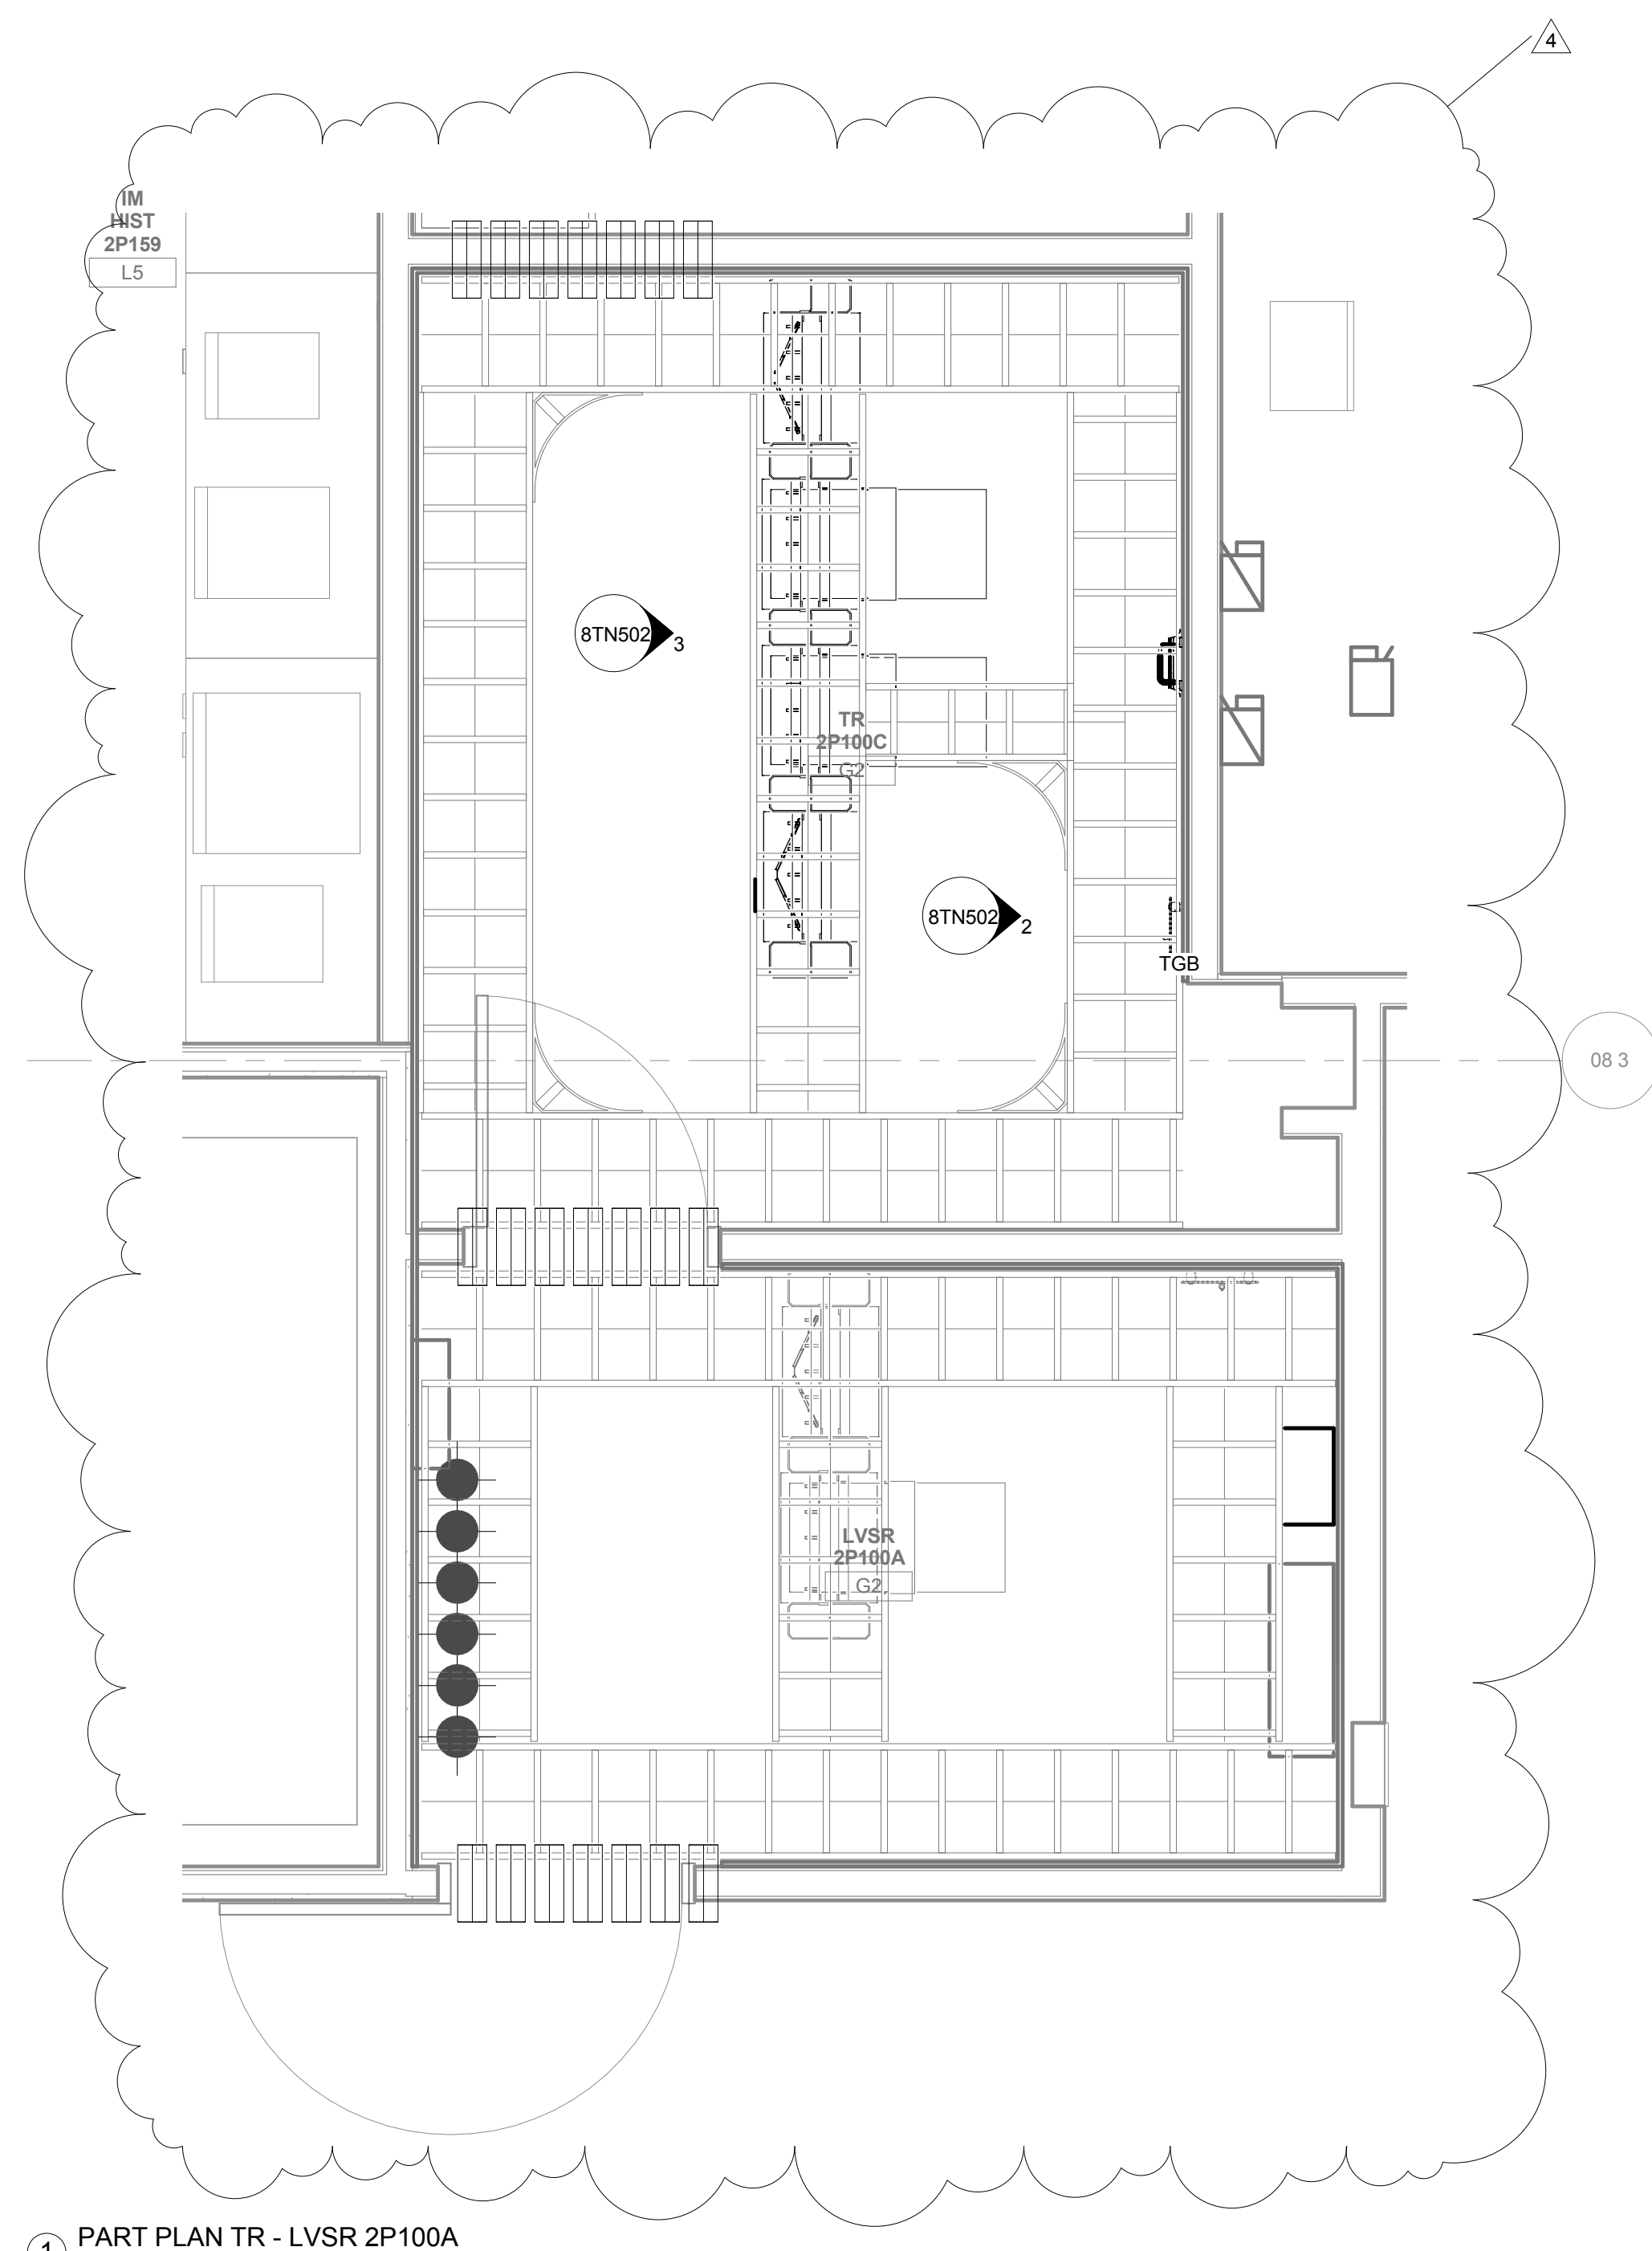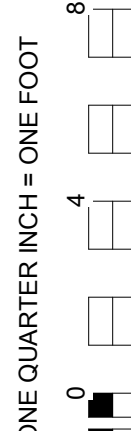    

4	BULL 019 - PRE-AWARD	2/28/2014
REVISIONS:		DATE


CONSULTANTS:

DESMAN ASSOCIATES / PARKING
CODE CONSULTANTS, INC. / CODE CONSULTANT
THE SEXTANT GROUP / AV & ACOUSTICAL
HAMMER DESIGN ASSOCIATES / FOOD SERVICE
PYBURN & ODOM / ABATEMENT
TATA & HOWARD / TANK CONSULTANT
I.S.C. GROUP, INC. / IRRIGATION
DAN EUSER WATER ARCHITECTURE, INC. / WATER FEATURE

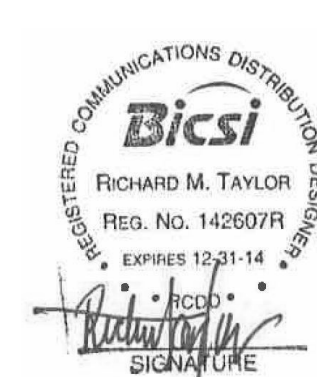

ARCHITECT/ENGINEERS:

studio **NOVA**
 SCHRENK & PETERSON CONSULTING ENGINEERS / CIVIL
 KORDANEMETH ENGINEERING / STRUCTURAL
 BR+A CONSULTING ENGINEERS / MECH, ELECT, PLUMBING, LOW VOLTAGE
 ARCHITECTURAL ENGINEERING/ PLUMBING
 SCALES ASSOCIATES / FIRE PROTECTION

DRAWING TITLE BUILDING 08 - TR - LVSR PART PLAN AND ELEVATIONS		PROJECT TITLE SLVHCS REPLACEMENT MEDICAL CENTER PROJECT		PROJECT NUMBER 629-HS2-401		BUILDING NUMBER 08	
APPROVED: PROJECT DIRECTOR		LOCATION NEW ORLEANS, LOUISIANA		DOCUMENT SET PACKAGE WP_09B		OFFICE OF CONSTRUCTION AND FACILITIES MANAGEMENT	
				DRAWING NUMBER 8TN502			
		DATE JUL 16, 2012	CHECKED JLE	DRAWN JJP	 Department of Veterans Affairs		

A

A

B

B

C

C

D


D

E


E

F


F

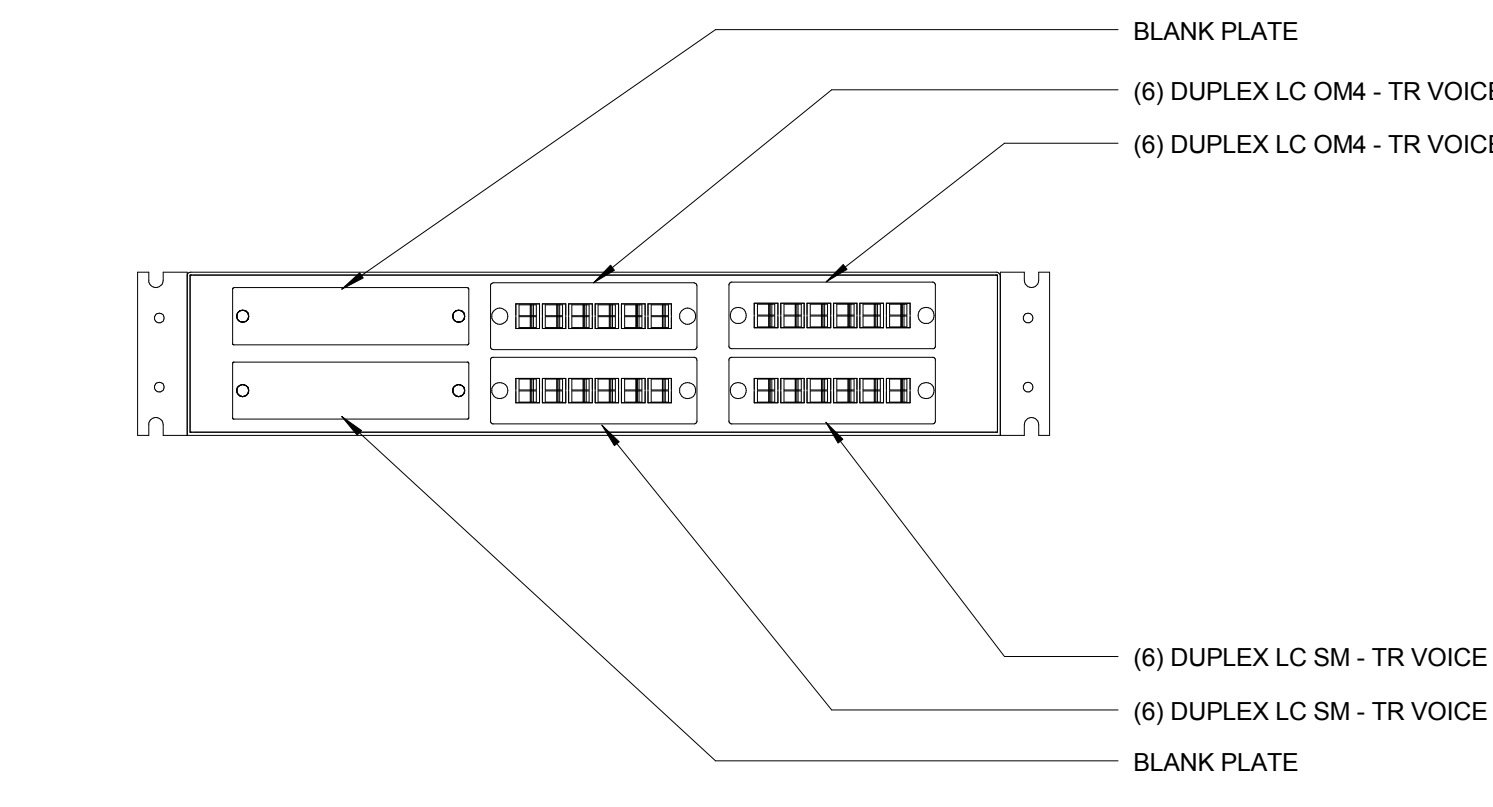


1 RESEARCH TR VOICE LIU
3" = 1'-0"

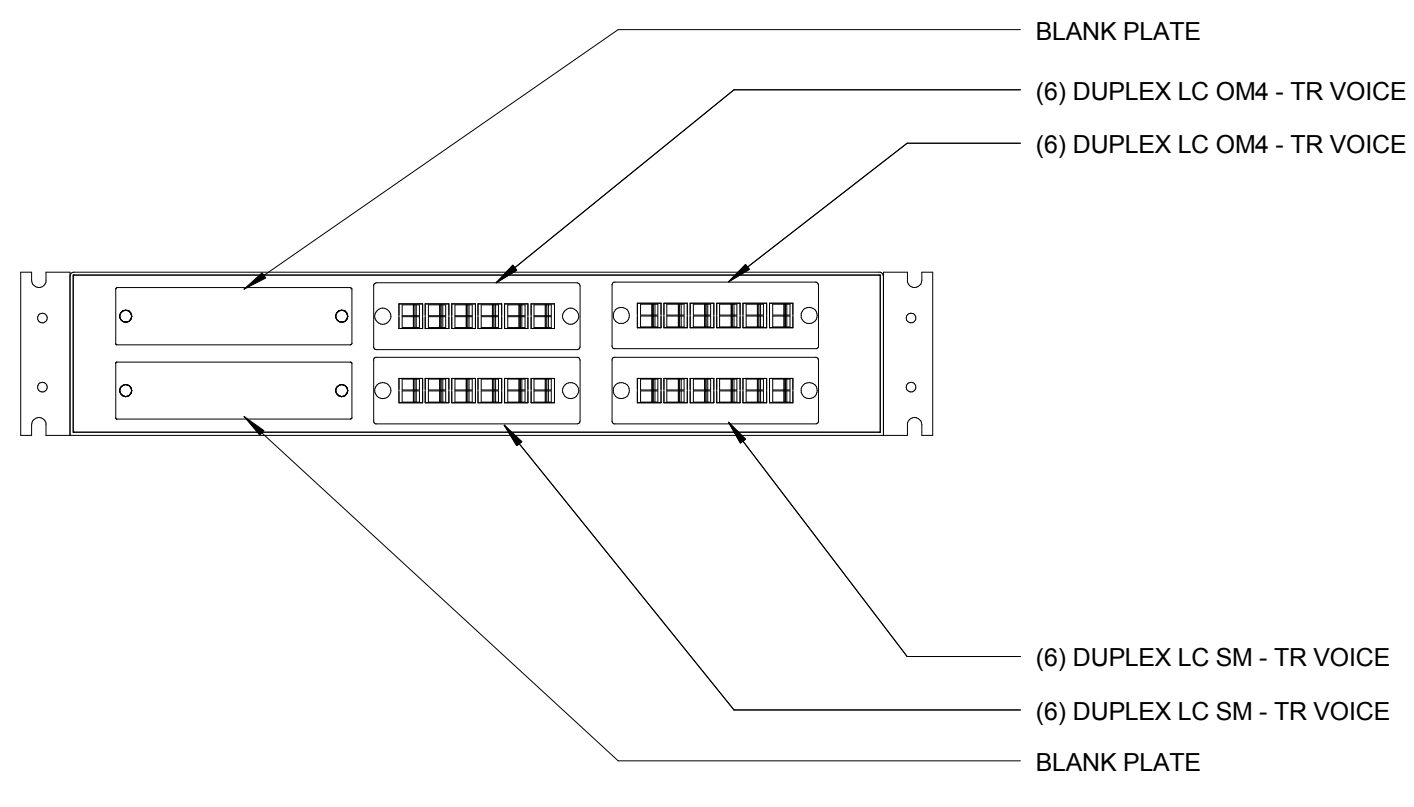


2 RESEARCH TR DATA LIU
3" = 1'-0"

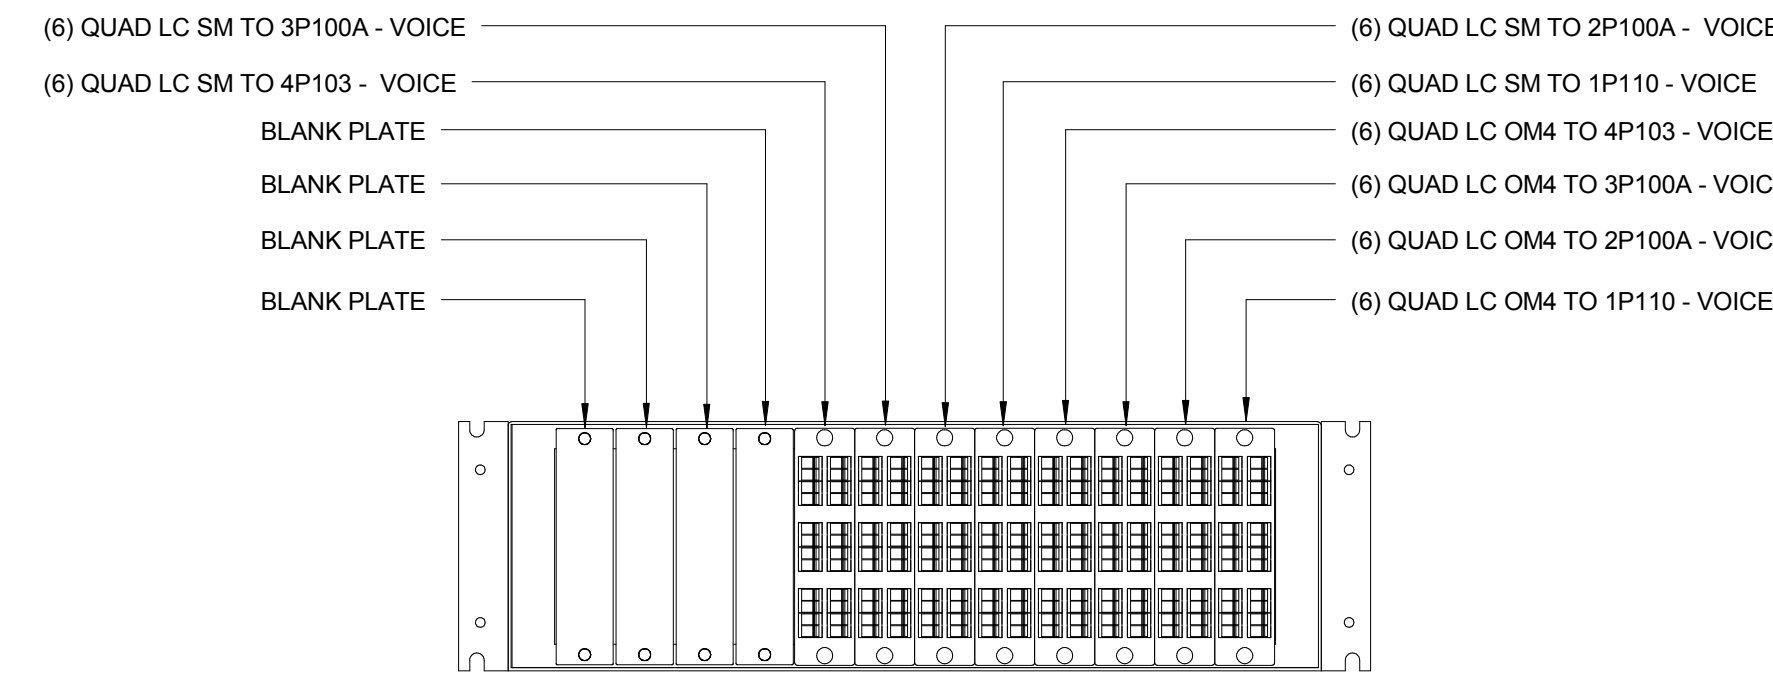


3 RESEARCH VOICE RISER MCC LIU
3" = 1'-0"

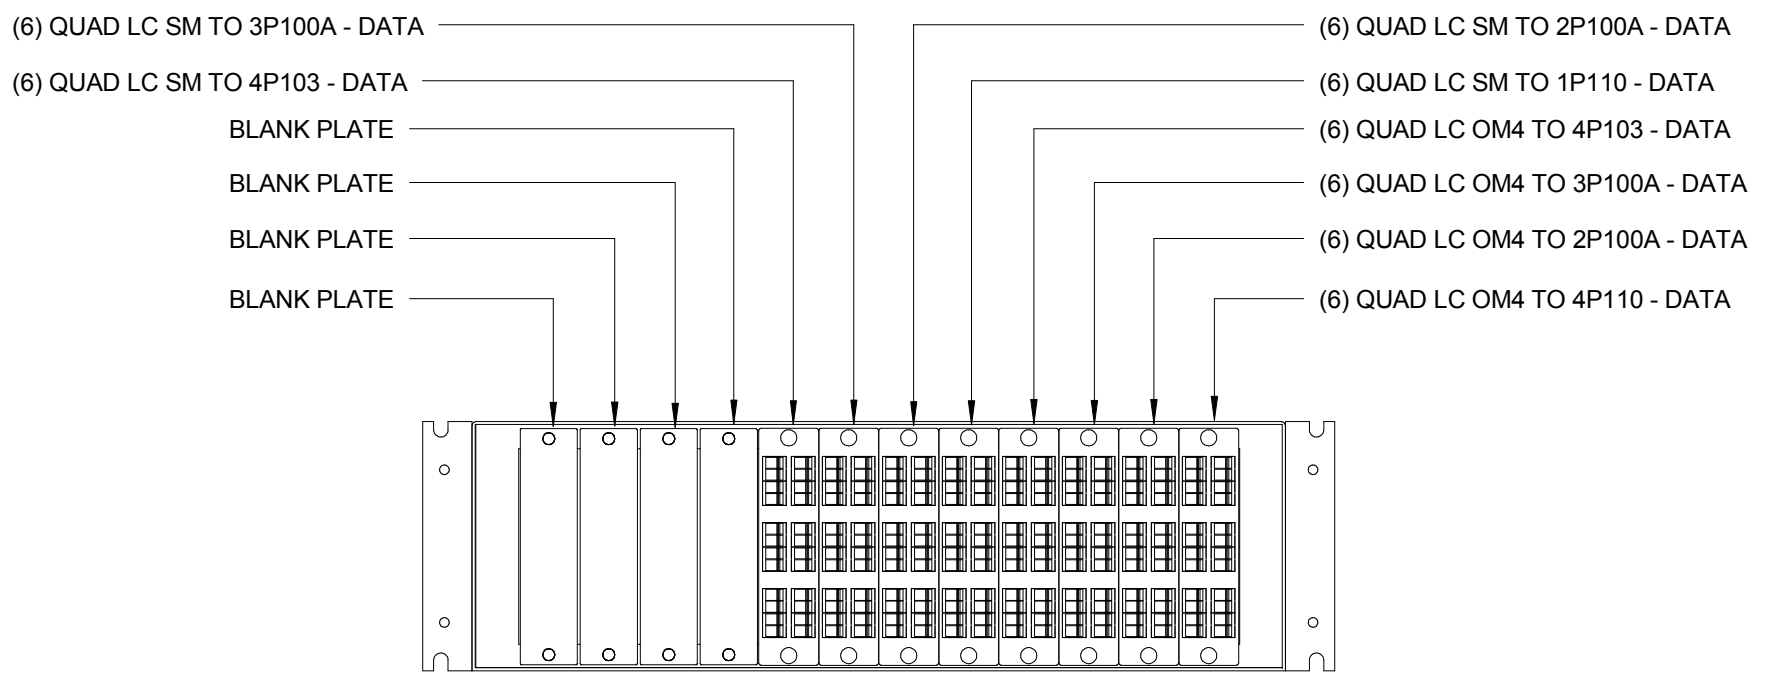


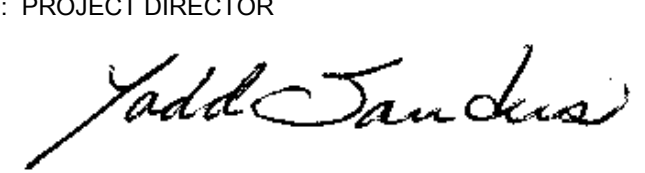
 
5 RESEARCH DATA RISER MCC LIU1
3" = 1'-0"

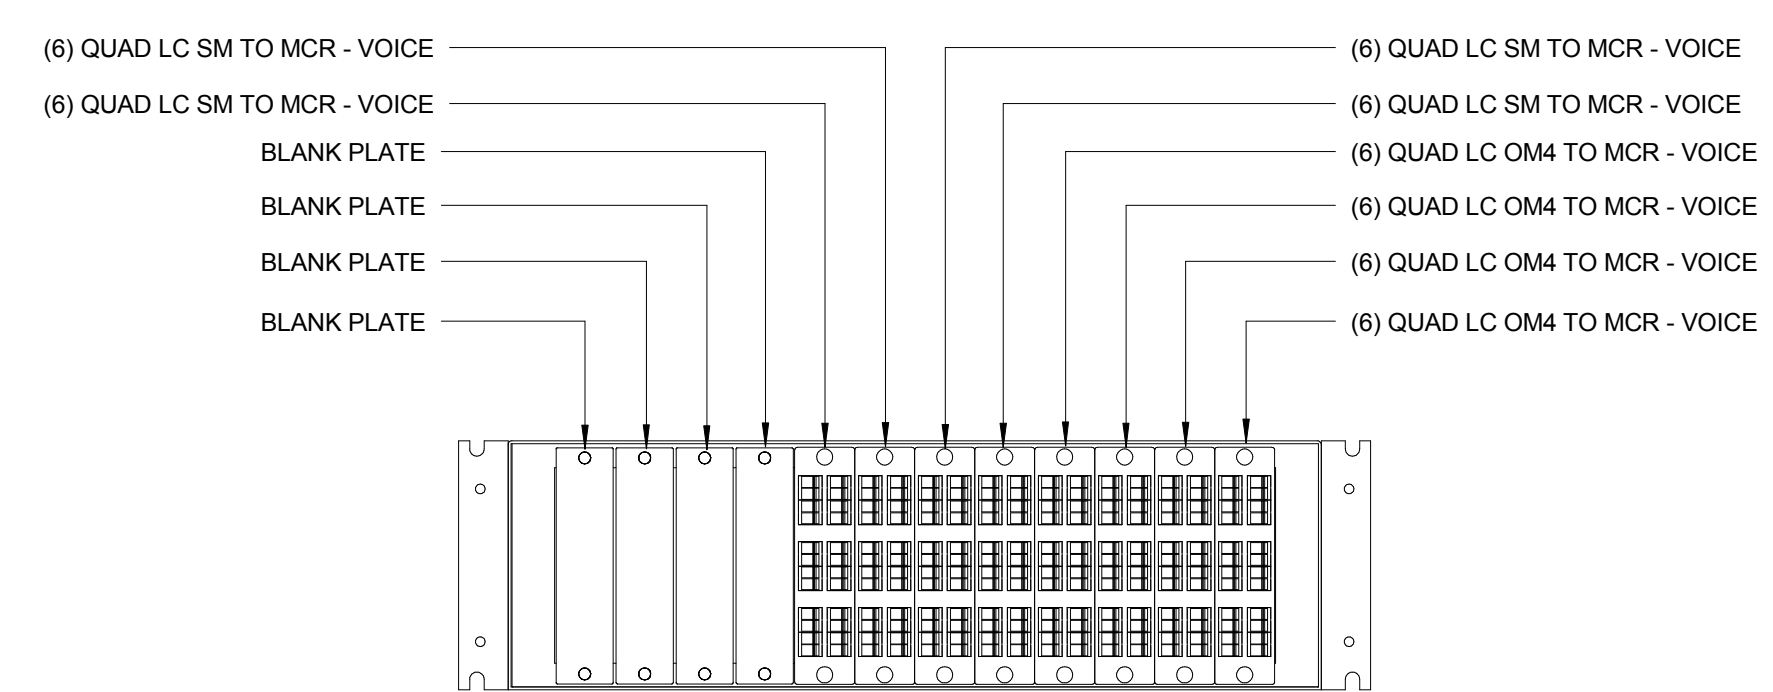



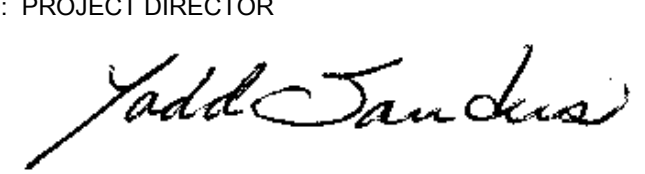

4 RESEARCH VOICE MCC TO MCR LIU
3" = 1'-0"

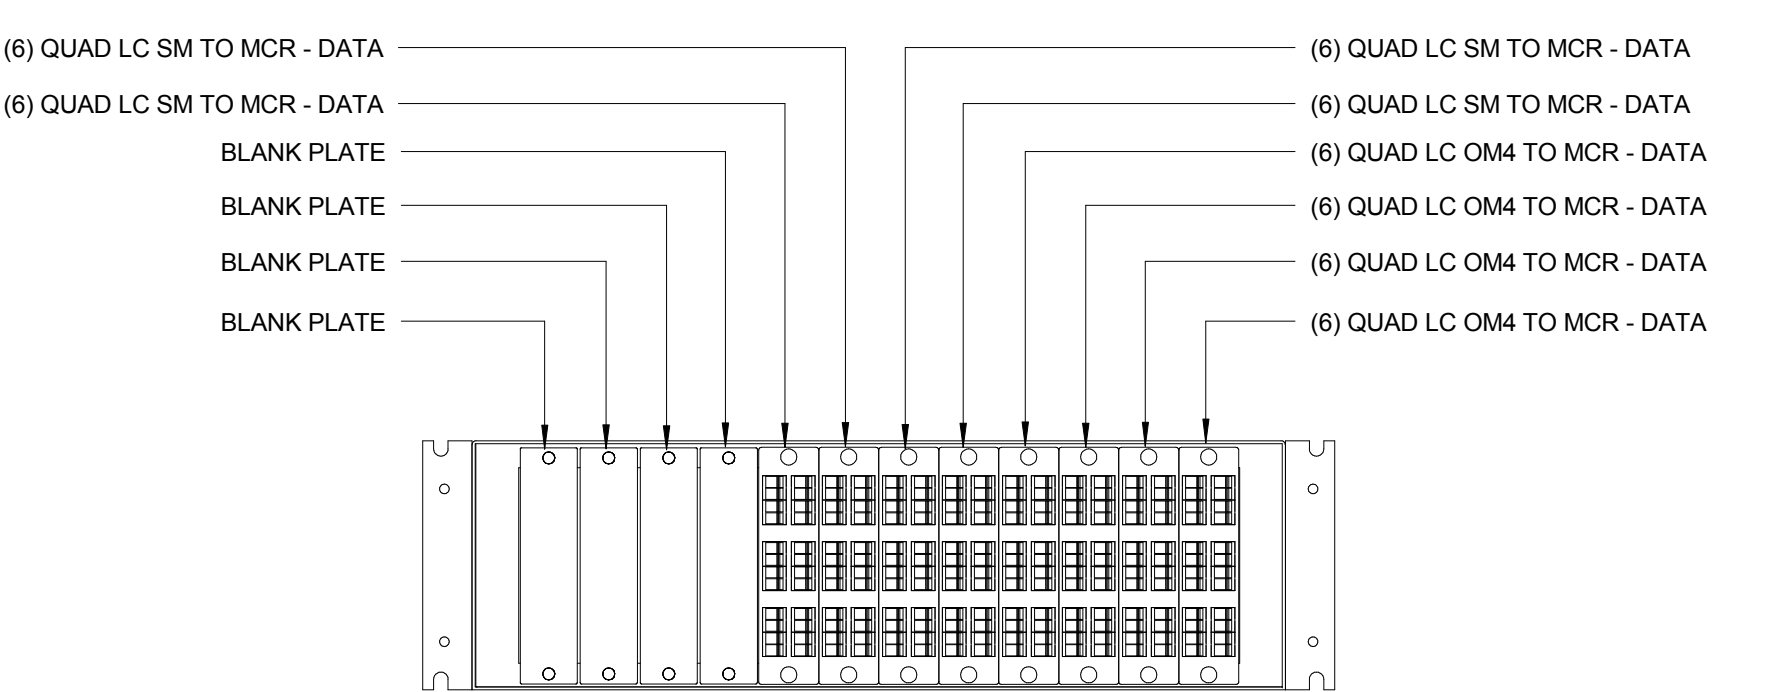

6 RESEARCH DATA MCC TO MCR LIU
3" = 1'-0"


REVISIONS:		DATE	
CONSULTANTS: DESMAN ASSOCIATES / PARKING CODE CONSULTANTS, INC. / CODE CONSULTANT THE SEXTANT GROUP / AV & ACOUSTICAL HAMMER DESIGN ASSOCIATES / FOOD SERVICE PYBURN & ODOM / ABATEMENT TATA & HOWARD / TANK CONSULTANT I.S.C. GROUP, INC. / IRRIGATION DAN EUSER WATER ARCHITECTURE, INC. / WATER FEATURE			
		ARCHITECT/ENGINEERS: studio NOVA SCHRENK & PETERSON CONSULTING ENGINEERS / CIVIL KORDA/NEMETH ENGINEERING / STRUCTURAL BR+A CONSULTING ENGINEERS / MECH, ELECT, PLUMBING, LOW VOLTAGE ARCHITECTURAL ENGINEERING/ PLUMBING SCALES ASSOCIATES / FIRE PROTECTION	
DRAWING TITLE BUILDING 08 - TELECOMMUNICATIONS FIBER DETAILS		PROJECT TITLE SLVHCS REPLACEMENT MEDICAL CENTER PROJECT	
APPROVED: PROJECT DIRECTOR 		LOCATION NEW ORLEANS, LOUISIANA	
DATE July 16, 2012		CHECKED JLE	DRAWN JJP
PROJECT NUMBER 629-HS2-401		BUILDING NUMBER 08	
DOCUMENT SET PACKAGE WP_09B		DRAWING NUMBER 8TN504	
		OFFICE OF CONSTRUCTION AND FACILITIES MANAGEMENT 	

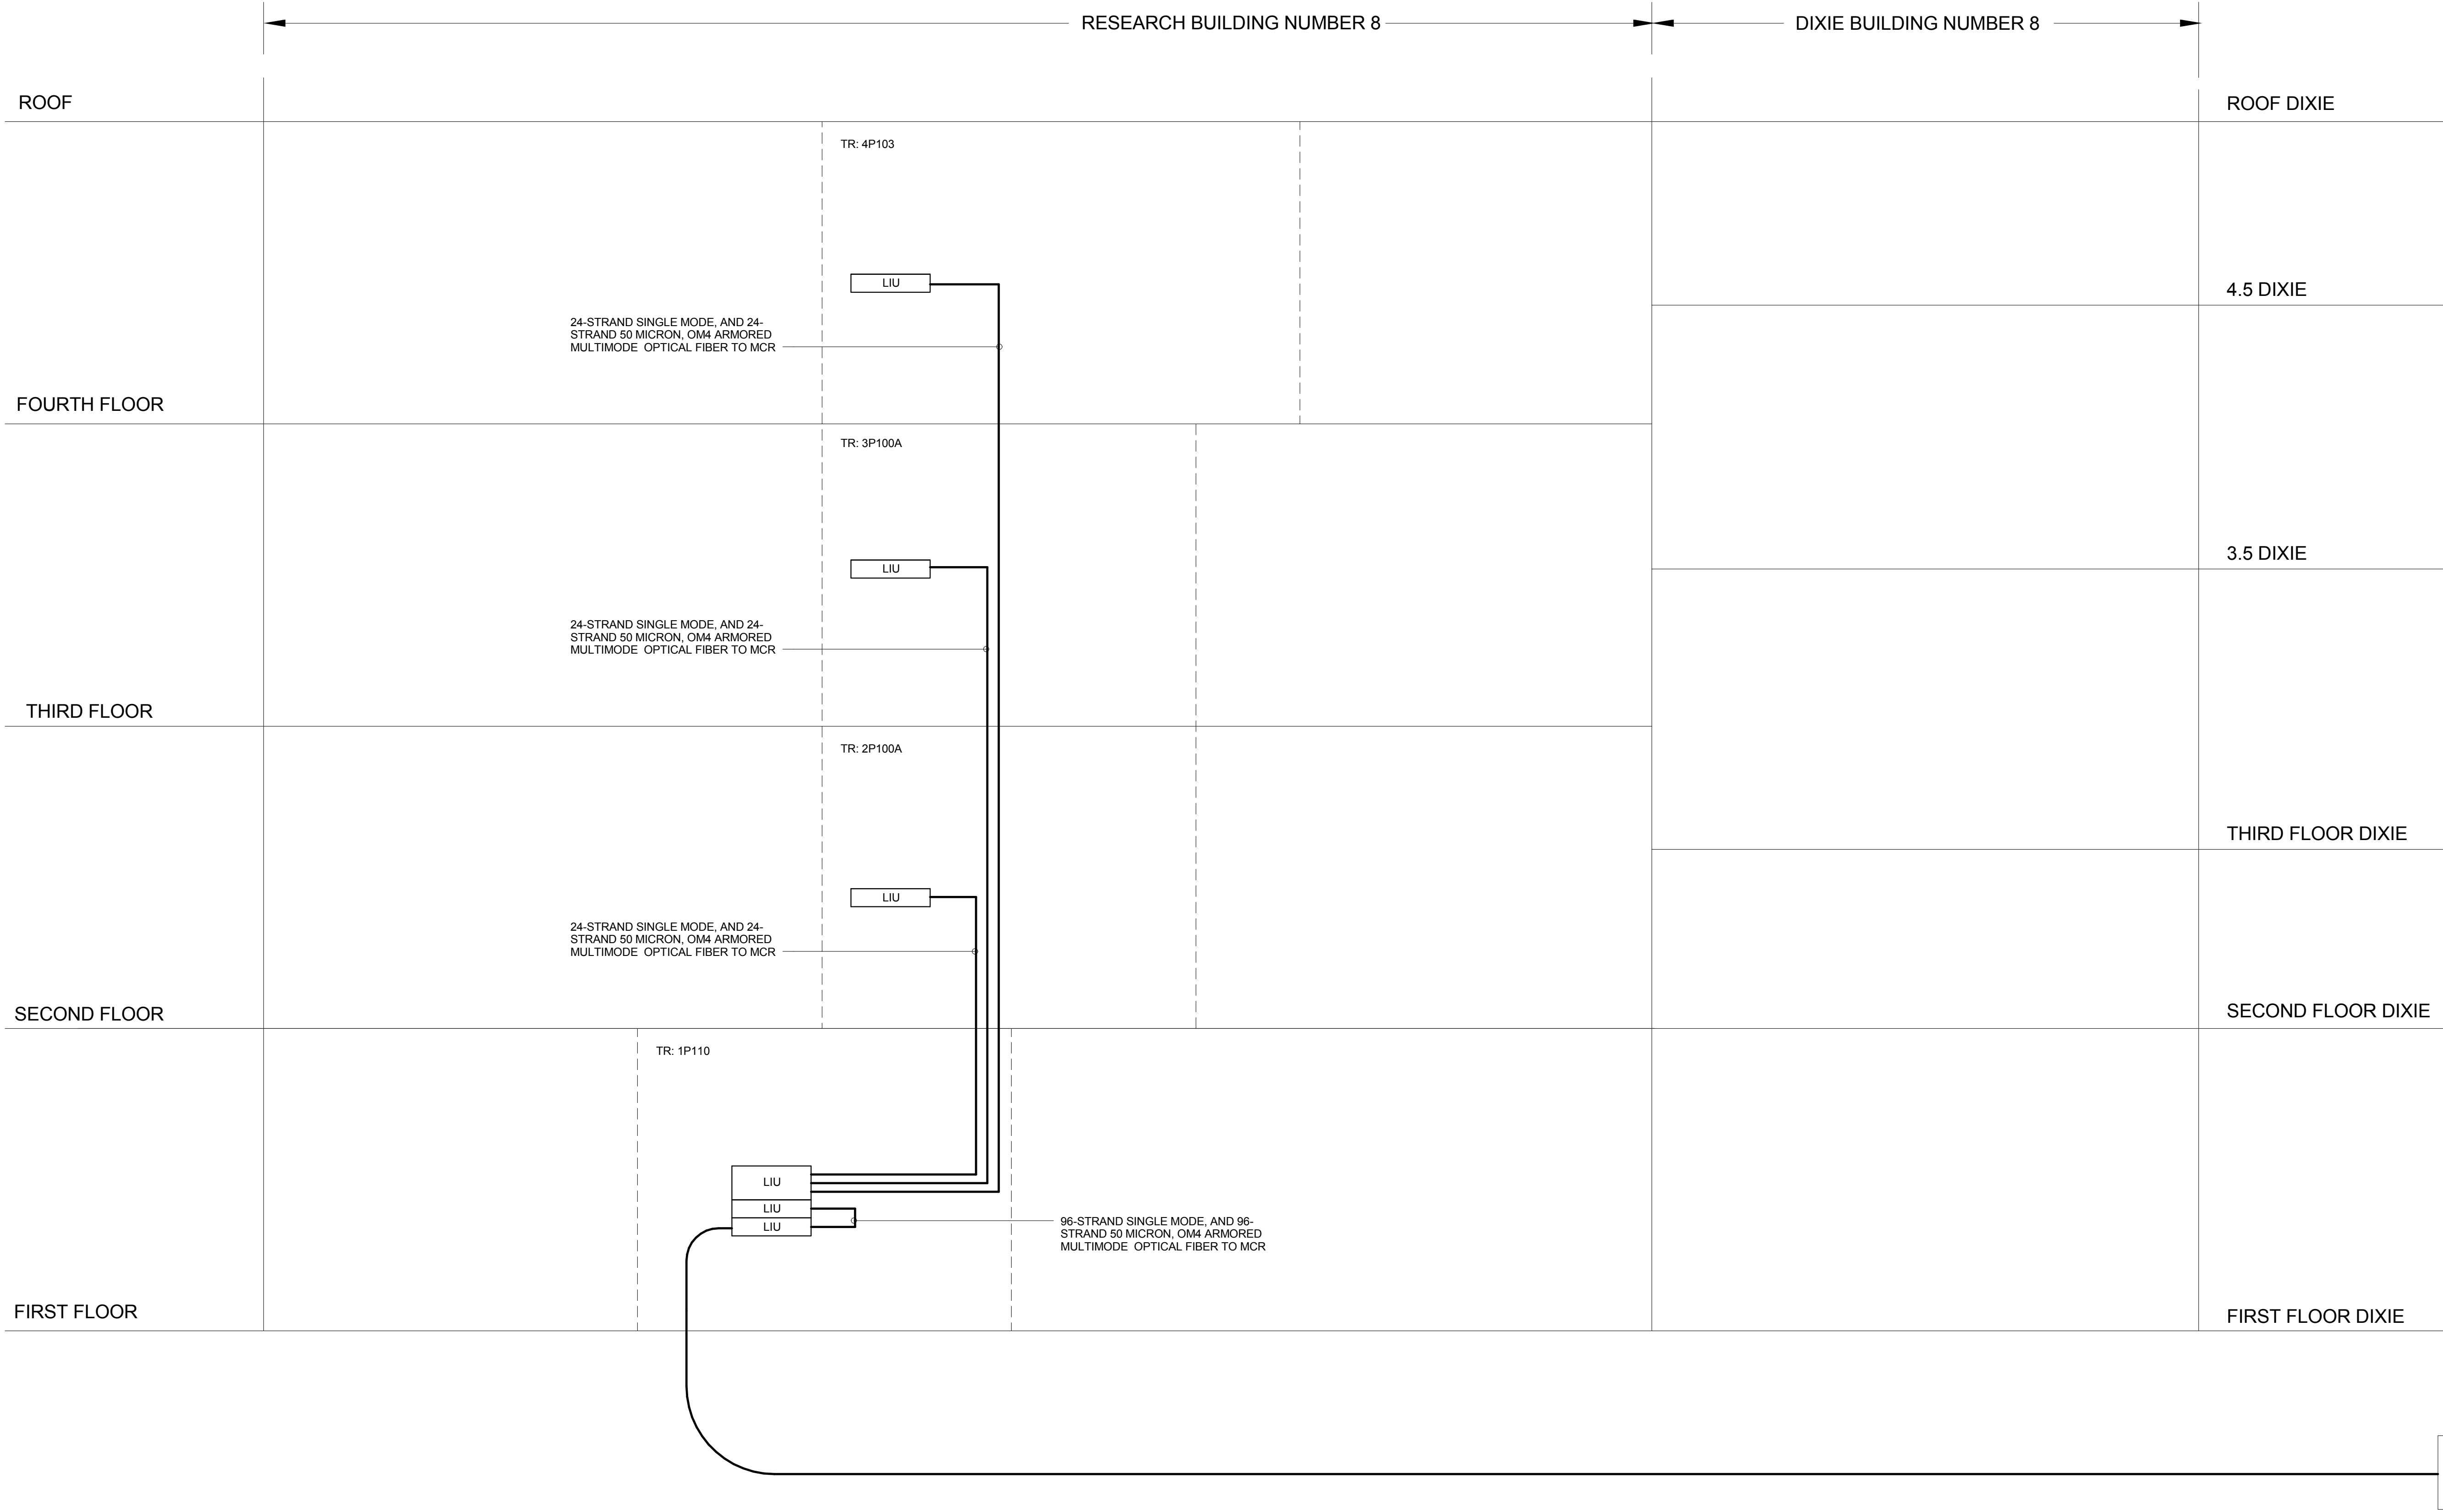

REVISIONS:		DATE		CONSULTANTS: DESMAN ASSOCIATES / PARKING CODE CONSULTANTS, INC. / CODE CONSULTANT THE SEXTANT GROUP / AV & ACOUSTICAL HAMMER DESIGN ASSOCIATES / FOOD SERVICE PYBURN & ODOM / ABATEMENT TATA & HOWARD / TANK CONSULTANT I.S.C. GROUP, INC. / IRRIGATION DAN EUSER WATER ARCHITECTURE, INC. / WATER FEATURE	 JUL 3 6 2012	ARCHITECT/ENGINEERS: studio NOVA SCHRENK & PETERSON CONSULTING ENGINEERS / CIVIL KORDA/NEMETH ENGINEERING / STRUCTURAL BR+A CONSULTING ENGINEERS / MECH, ELECT, PLUMBING, LOW VOLTAGE ARCHITECTURAL ENGINEERING/ PLUMBING SCALES ASSOCIATES / FIRE PROTECTION	DRAWING TITLE BUILDING 08 - TELECOMMUNICATIONS DATA BACKBONE RISER DIAGRAM APPROVED: PROJECT DIRECTOR 	PROJECT TITLE SLVHCS REPLACEMENT MEDICAL CENTER PROJECT LOCATION NEW ORLEANS, LOUISIANA DATE July 16, 2012	CHECKED JLE DRAWN JJP	PROJECT NUMBER 629-HS2-401 DOCUMENT SET PACKAGE WP_09B DRAWING NUMBER 8TN602	BUILDING NUMBER 08 OFFICE OF CONSTRUCTION AND FACILITIES MANAGEMENT 
-------------------	--	-------------	--	-------------------------------------------------------------------------------------------------------------------------------------------------------------------------------------------------------------------------------------------------------------------------------------------------------------------------------------------	-------------------------------------------------------------------------------------------------------	-----------------------------------------------------------------------------------------------------------------------------------------------------------------------------------------------------------------------------------------------------------------------------------------------	---------------------------------------------------------------------------------------------------------------------------------------------------------------------------------------------------------------------------	-----------------------------------------------------------------------------------------------------------------------------------------------------------	--------------------------------------------------	--------------------------------------------------------------------------------------------------------------------------	--------------------------------------------------------------------------------------------------------------------------------------------------------------------------------------

VA FORM 08-6231


A

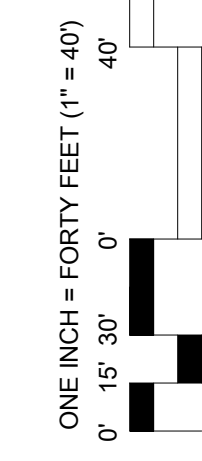


B




C

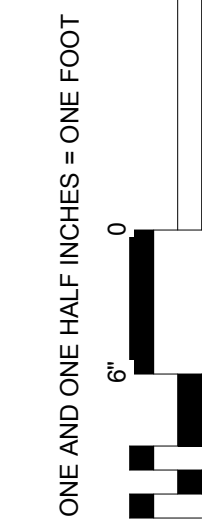


D

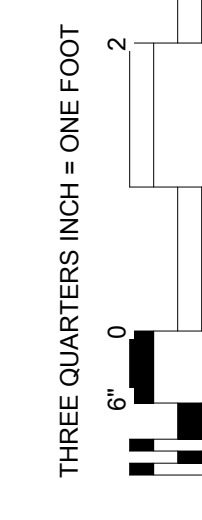

E

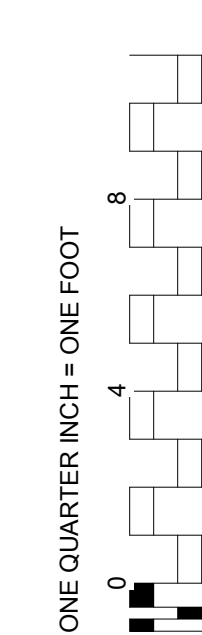

F

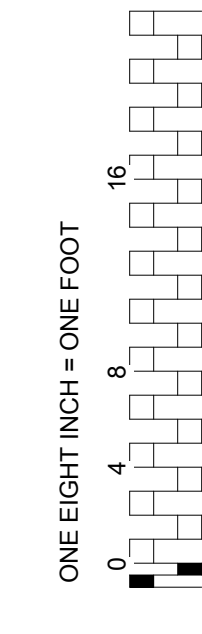

A


B

C


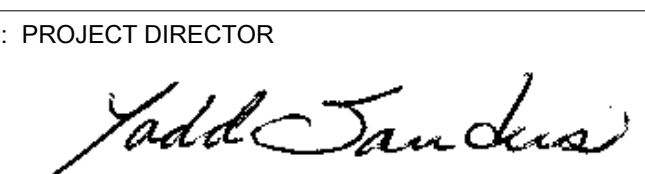

D

E

F

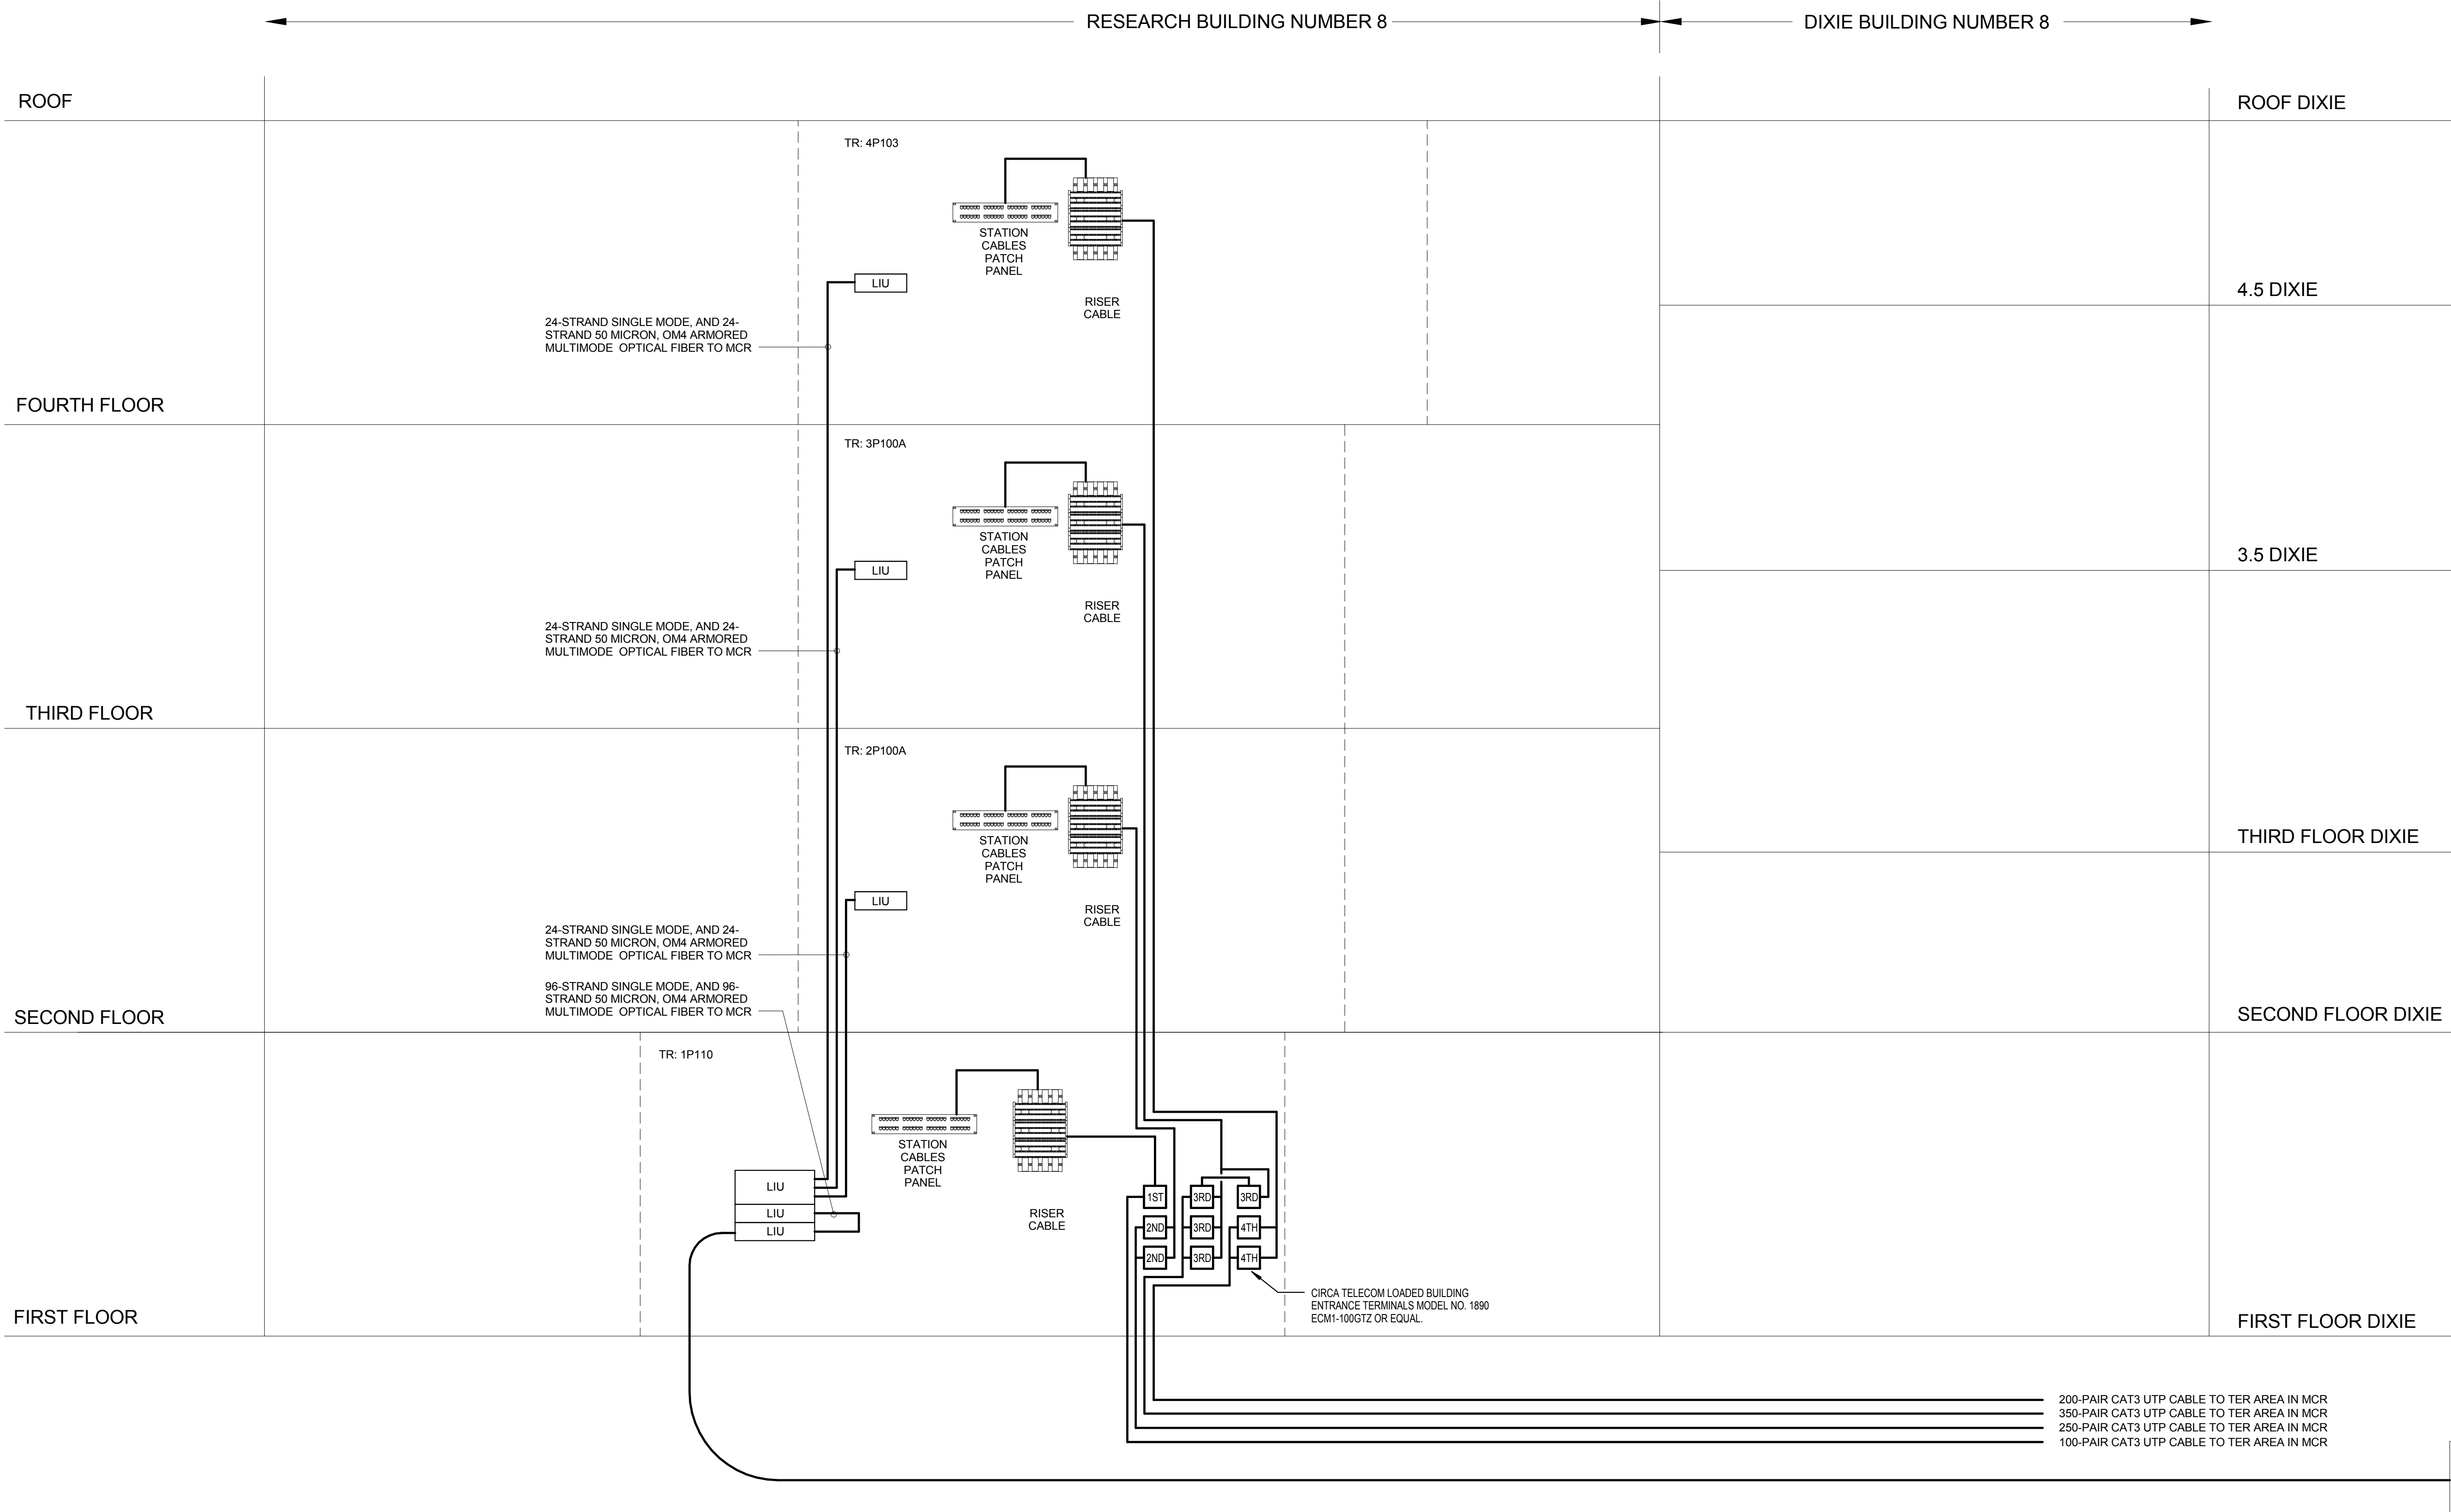

TELECOMM VOICE BACKBONE RISER
DIAGRAM
12" = 1'-0"

REVISIONS:		DATE		CONSULTANTS: DESMAN ASSOCIATES / PARKING CODE CONSULTANTS, INC. / CODE CONSULTANT THE SEXTANT GROUP / AV & ACOUSTICAL HAMMER DESIGN ASSOCIATES / FOOD SERVICE PYBURN & ODOM / ABATEMENT TATA & HOWARD / TANK CONSULTANT I.S.C. GROUP, INC. / IRRIGATION DAN EUSER WATER ARCHITECTURE, INC. / WATER FEATURE	 JUL 3 6 2012	ARCHITECT/ENGINEERS: studio NOVA SCHRENK & PETERSON CONSULTING ENGINEERS / CIVIL KORDA/NEMETH ENGINEERING / STRUCTURAL BR+A CONSULTING ENGINEERS / MECH, ELECT, PLUMBING, LOW VOLTAGE ARCHITECTURAL ENGINEERING/ PLUMBING SCALES ASSOCIATES / FIRE PROTECTION	DRAWING TITLE BUILDING 08 - TELECOMMUNICATIONS VOICE BACKBONE RISER DIAGRAM APPROVED: PROJECT DIRECTOR 	PROJECT TITLE SLVHCS REPLACEMENT MEDICAL CENTER PROJECT LOCATION NEW ORLEANS, LOUISIANA DATE July 16, 2012	CHECKED JLE DRAWN JJP	PROJECT NUMBER 629-HS2-401 BUILDING NUMBER 08 DOCUMENT SET PACKAGE WP_09B DRAWING NUMBER 8TN603	OFFICE OF CONSTRUCTION AND FACILITIES MANAGEMENT 
-------------------	--	-------------	--	-------------------------------------------------------------------------------------------------------------------------------------------------------------------------------------------------------------------------------------------------------------------------------------------------------------------------------------------	-------------------------------------------------------------------------------------------------------	-----------------------------------------------------------------------------------------------------------------------------------------------------------------------------------------------------------------------------------------------------------------------------------------------	----------------------------------------------------------------------------------------------------------------------------------------------------------------------------------------------------------------------------	-----------------------------------------------------------------------------------------------------------------------------------------------------------	--------------------------------------------------	-------------------------------------------------------------------------------------------------------------------------------------------------------------	--------------------------------------------------------------------------------------------------------------------------------------------------------------

ONE INCH = FORTY FEET (1" = 40')

ONE INCHES = ONE FOOT

ONE AND ONE HALF INCHES = ONE FOOT

THREE QUARTERS INCH = ONE FOOT


THREE QUARTERS INCH = ONE FOOT




ONE HALF INCH = ONE FOOT


ONE QUARTER INCH = ONE FOOT

ONE EIGHT INCH = ONE FOOT

ONE SIXTEENTH INCH = ONE FOOT

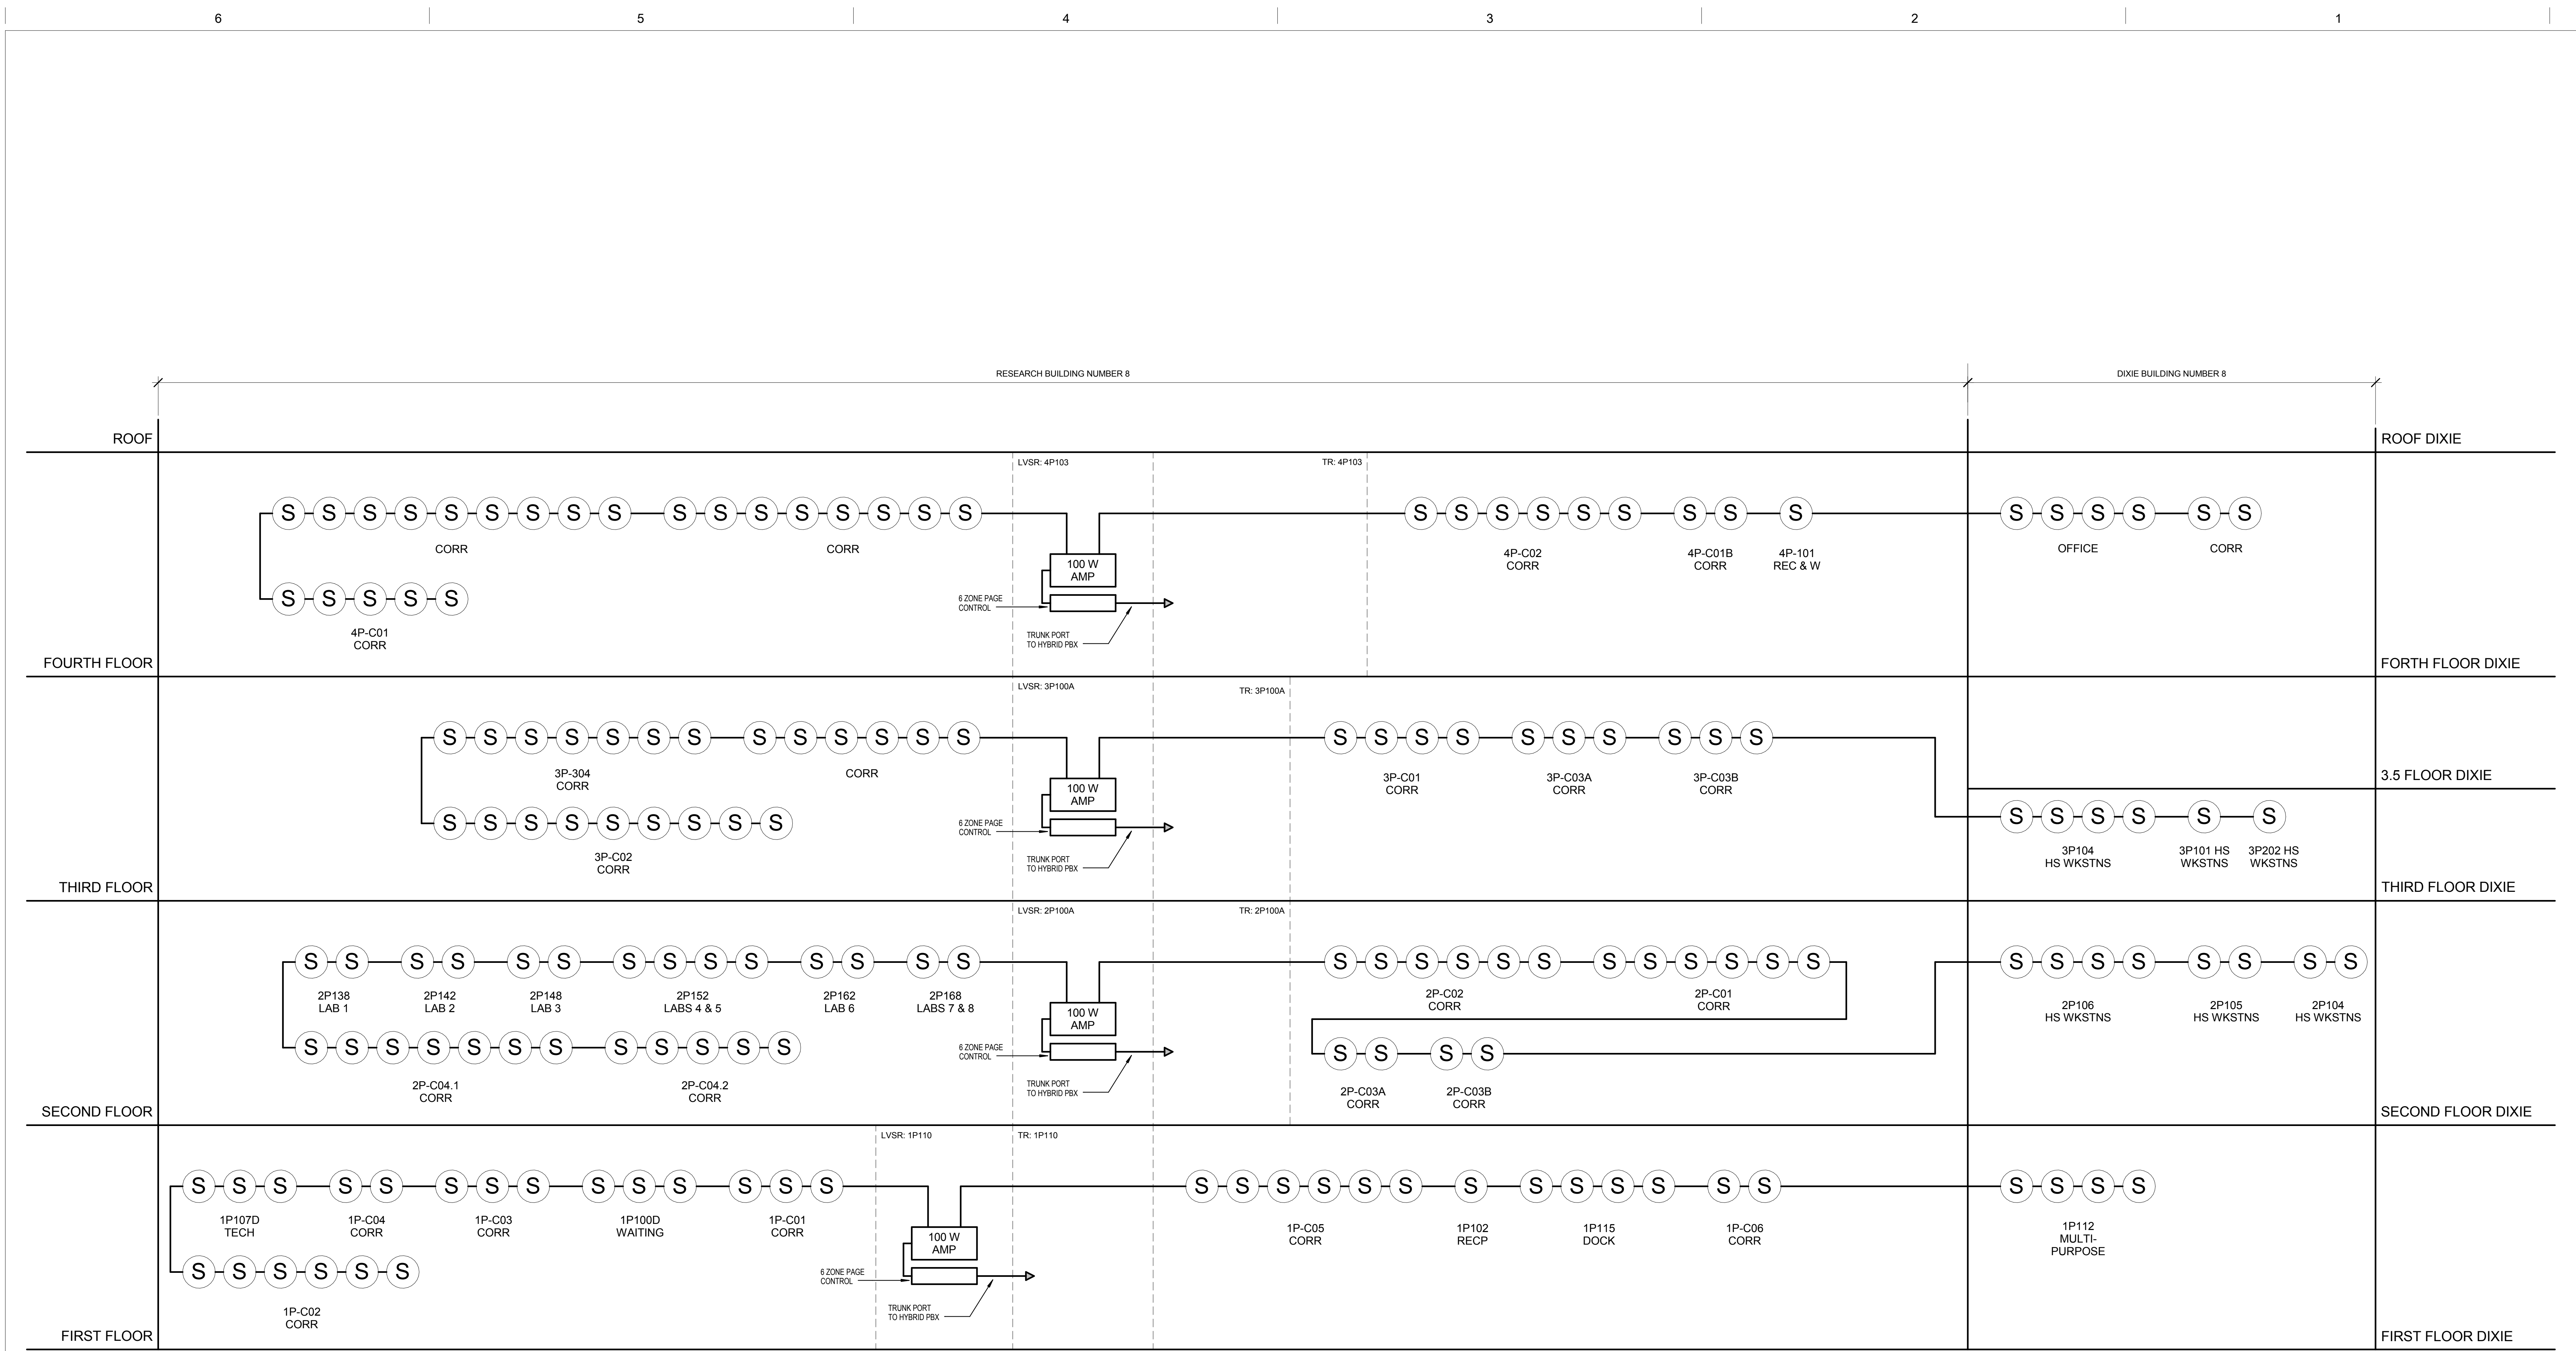

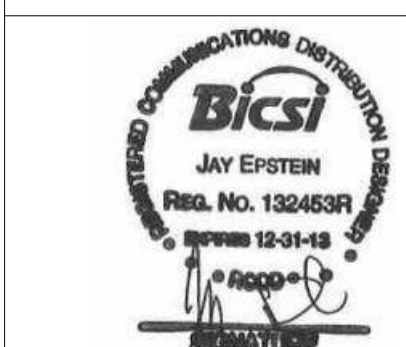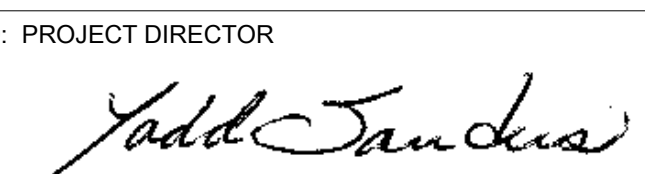REVISIONS:		DATE	
CONSULTANTS:		ARCHITECT/ENGINEERS:	
DESMAN ASSOCIATES / PARKING		studio NOVA	
CODE CONSULTANTS, INC. / CODE CONSULTANT		SCHRENK & PETERSON CONSULTING ENGINEERS / CIVIL	
THE SEXTANT GROUP / AV & ACOUSTICAL		KORDA/NEMETH ENGINEERING / STRUCTURAL	
HAMMER DESIGN ASSOCIATES / FOOD SERVICE		BR+A CONSULTING ENGINEERS / MECH, ELECT, PLUMBING, LOW VOLTAGE	
PYBURN & ODOM / ABATEMENT		ARCHITECTURAL ENGINEERING/ PLUMBING	
TATA & HOWARD / TANK CONSULTANT		SCALES ASSOCIATES / FIRE PROTECTION	
I.S.C. GROUP, INC. / IRRIGATION			
DAN EUSER WATER ARCHITECTURE, INC. / WATER FEATURE			
			
		DRAWING TITLE	
		BUILDING 08 - TELECOMMUNICATIONS	
		OVERHEAD PAGING SYSTEM RISER DIAGRAM	
		APPROVED: PROJECT DIRECTOR	
			
		PROJECT TITLE	
		SLVHCS REPLACEMENT MEDICAL	
		CENTER PROJECT	
		LOCATION	
		NEW ORLEANS, LOUISIANA	
		DATE	
		July 16, 2012	
		CHECKED	
		JLE	
		DRAWN	
		JJP	
		PROJECT NUMBER	
		629-HS2-401	
		BUILDING NUMBER	
		08	
		DOCUMENT SET PACKAGE	
		WP_09B	
		DRAWING NUMBER	
		8TN604	
		OFFICE OF CONSTRUCTION AND FACILITIES MANAGEMENT	
			

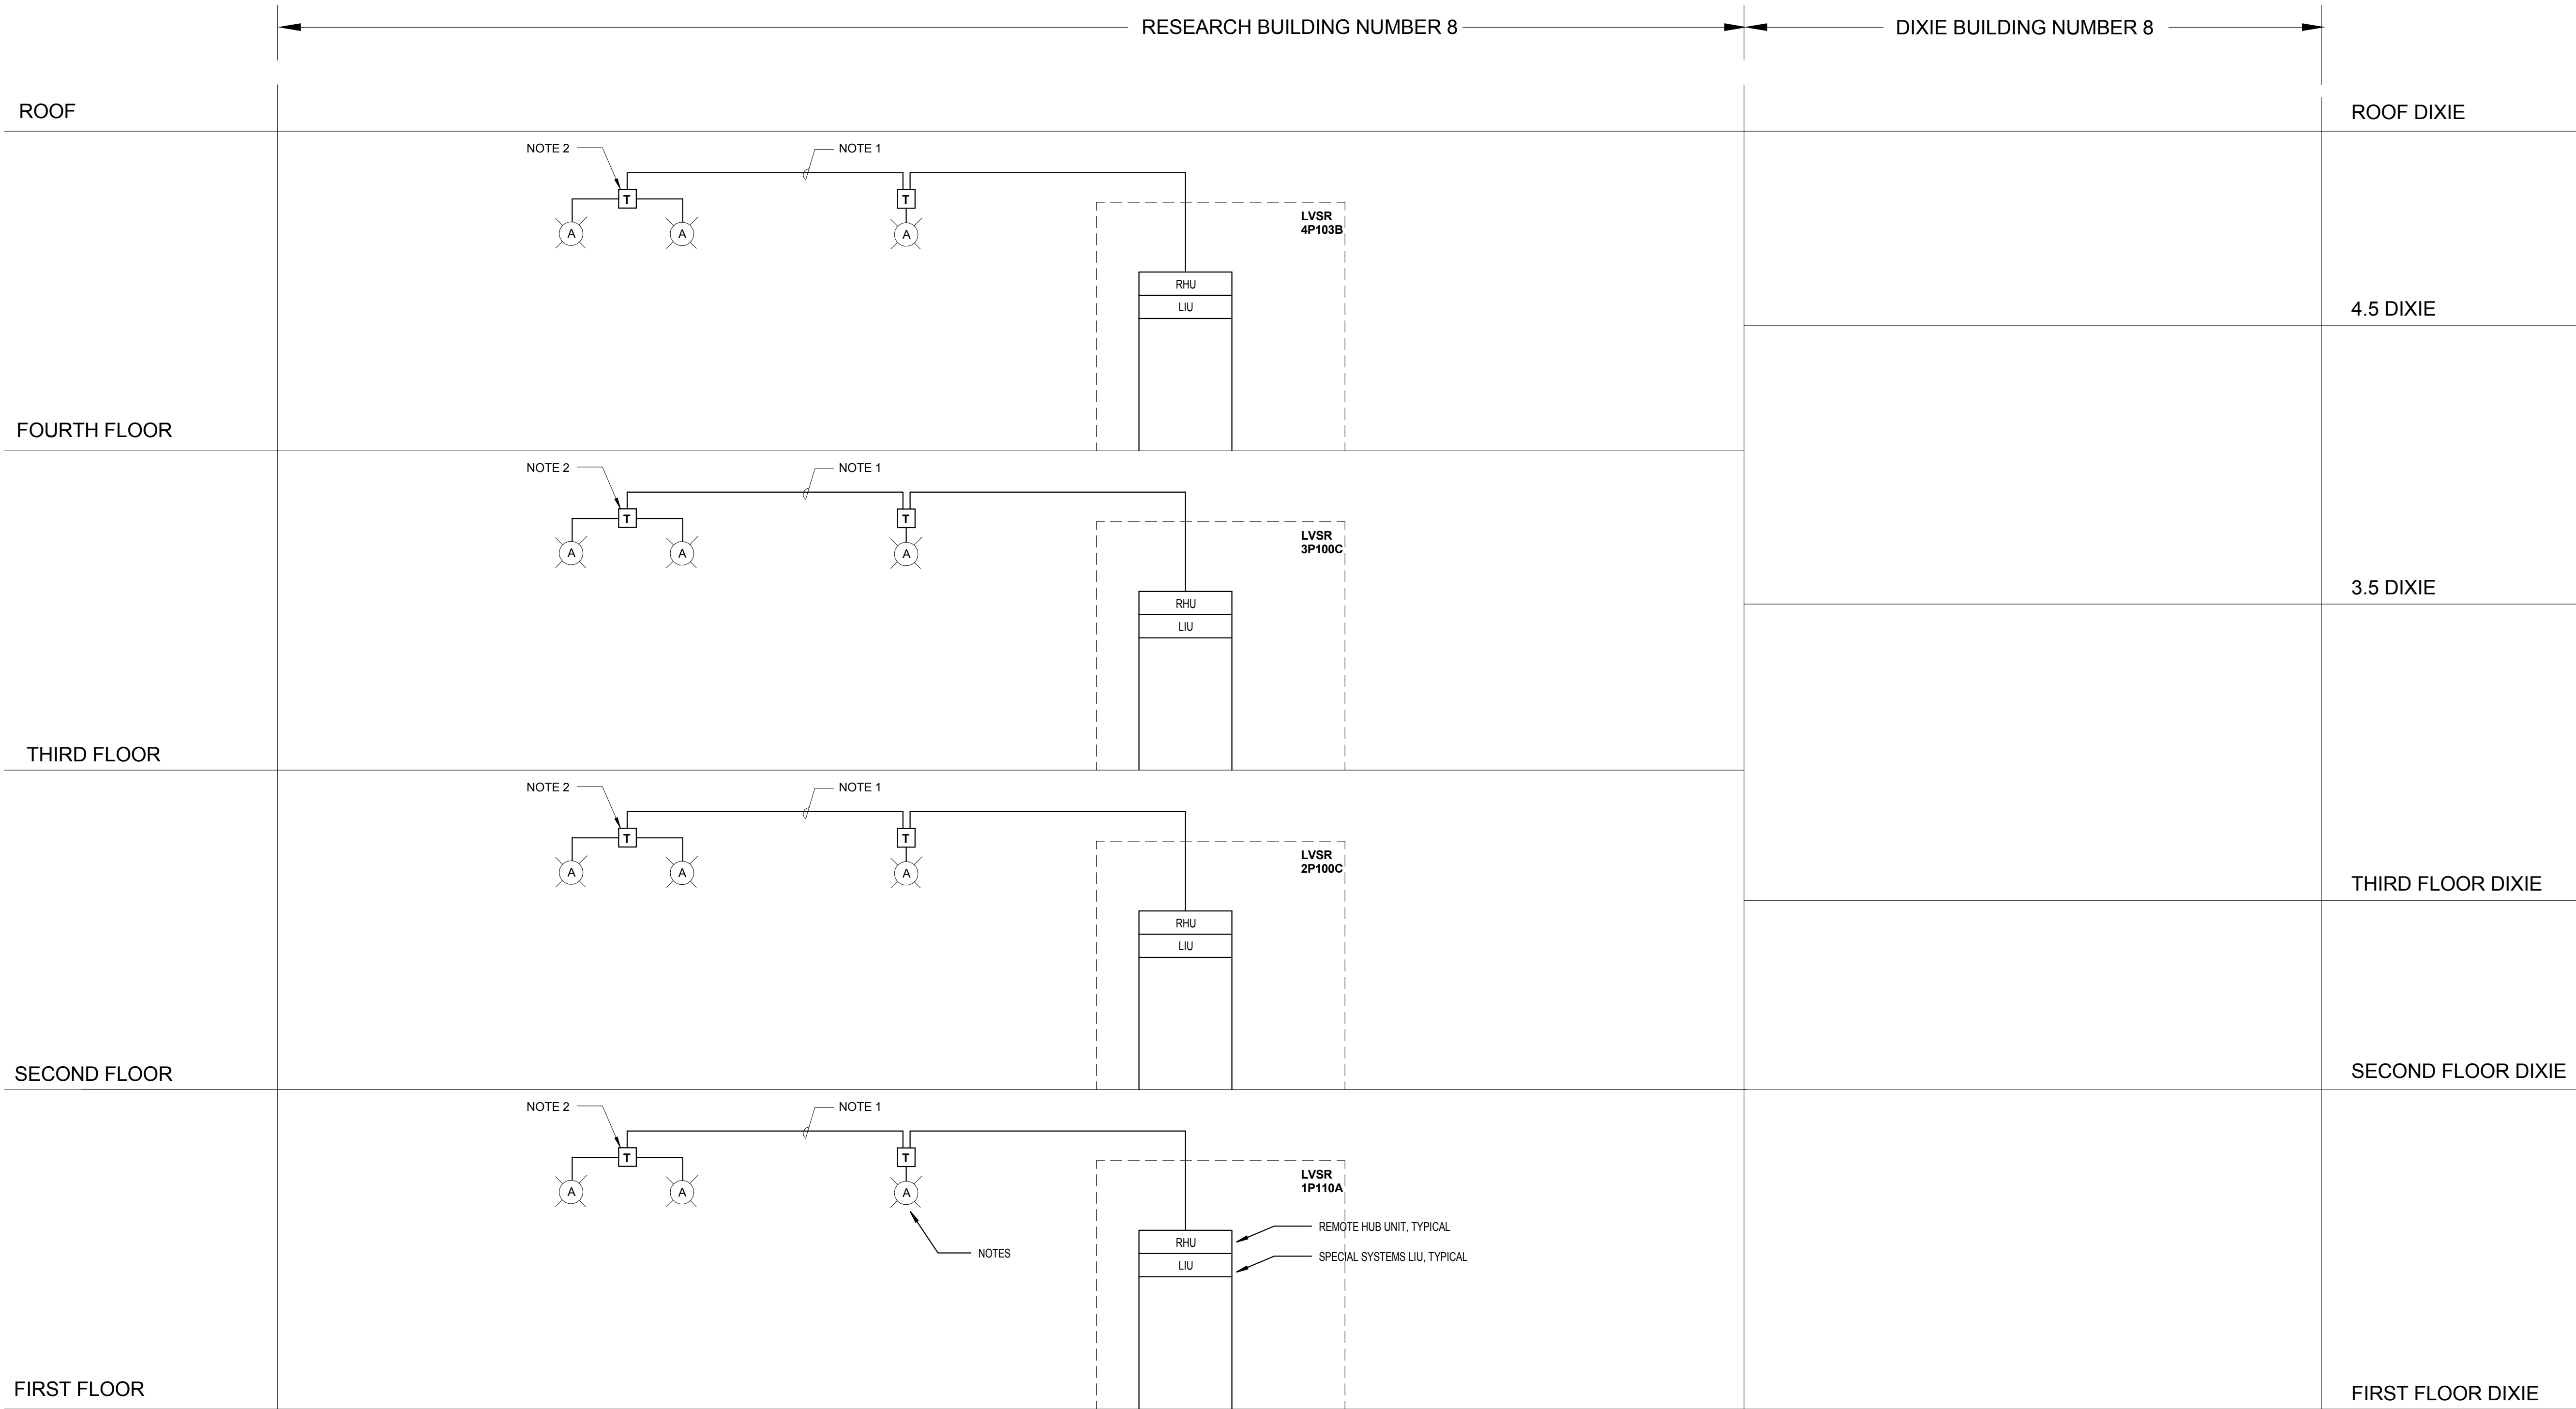


NOTES:
1. ALL COAX CABLE SHALL BE LMR-600 50 OHM OR EQUAL.
2. 1x2 TAP.
3. OMNI DIRECTIONAL ANTENNA.

REVISIONS:

DATE

CONSULTANTS:

DESMAN ASSOCIATES / PARKING
CODE CONSULTANTS, INC. / CODE CONSULTANT
THE SEXTANT GROUP / AV & ACOUSTICAL
HAMMER DESIGN ASSOCIATES / FOOD SERVICE
PYBURN & ODOM / ABATEMENT
TATA & HOWARD / TANK CONSULTANT
I.S.C. GROUP, INC. / IRRIGATION
DAN EUSER WATER ARCHITECTURE, INC. / WATER FEATURE



JUL 3 6 2012


ARCHITECT/ENGINEERS:

studio **NOVA**
SCHRENK & PETERSON CONSULTING ENGINEERS / CIVIL
KORDA/NEMETH ENGINEERING / STRUCTURAL
BR+A CONSULTING ENGINEERS / MECH, ELECT, PLUMBING, LOW VOLTAGE
ARCHITECTURAL ENGINEERING/ PLUMBING
SCALES ASSOCIATES / FIRE PROTECTION

DRAWING TITLE

BUILDING 08 - TELECOMMUNICATIONS
DISTRIBUTIVE ANTENNA SYSTEM RISER
DIAGRAM

APPROVED: PROJECT DIRECTOR

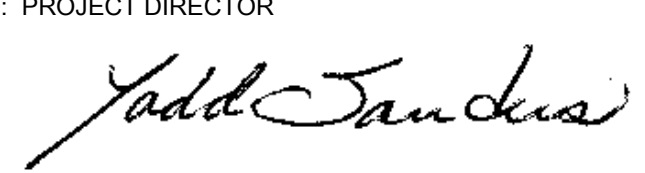

PROJECT TITLE

SLVHCS REPLACEMENT MEDICAL
CENTER PROJECT

LOCATION

NEW ORLEANS, LOUISIANA

DATE

July 16, 2012

CHECKED

JLE

DRAWN

JJP

PROJECT NUMBER

629-HS2-401

DOCUMENT SET PACKAGE


WP_09B


DRAWING NUMBER


 

8TN605

CONSTRUCTION DOCUMENTS 1
FULLY SPRINKLERED

OFFICE OF
CONSTRUCTION
AND FACILITIES
MANAGEMENT

 Department of
Veterans Affairs

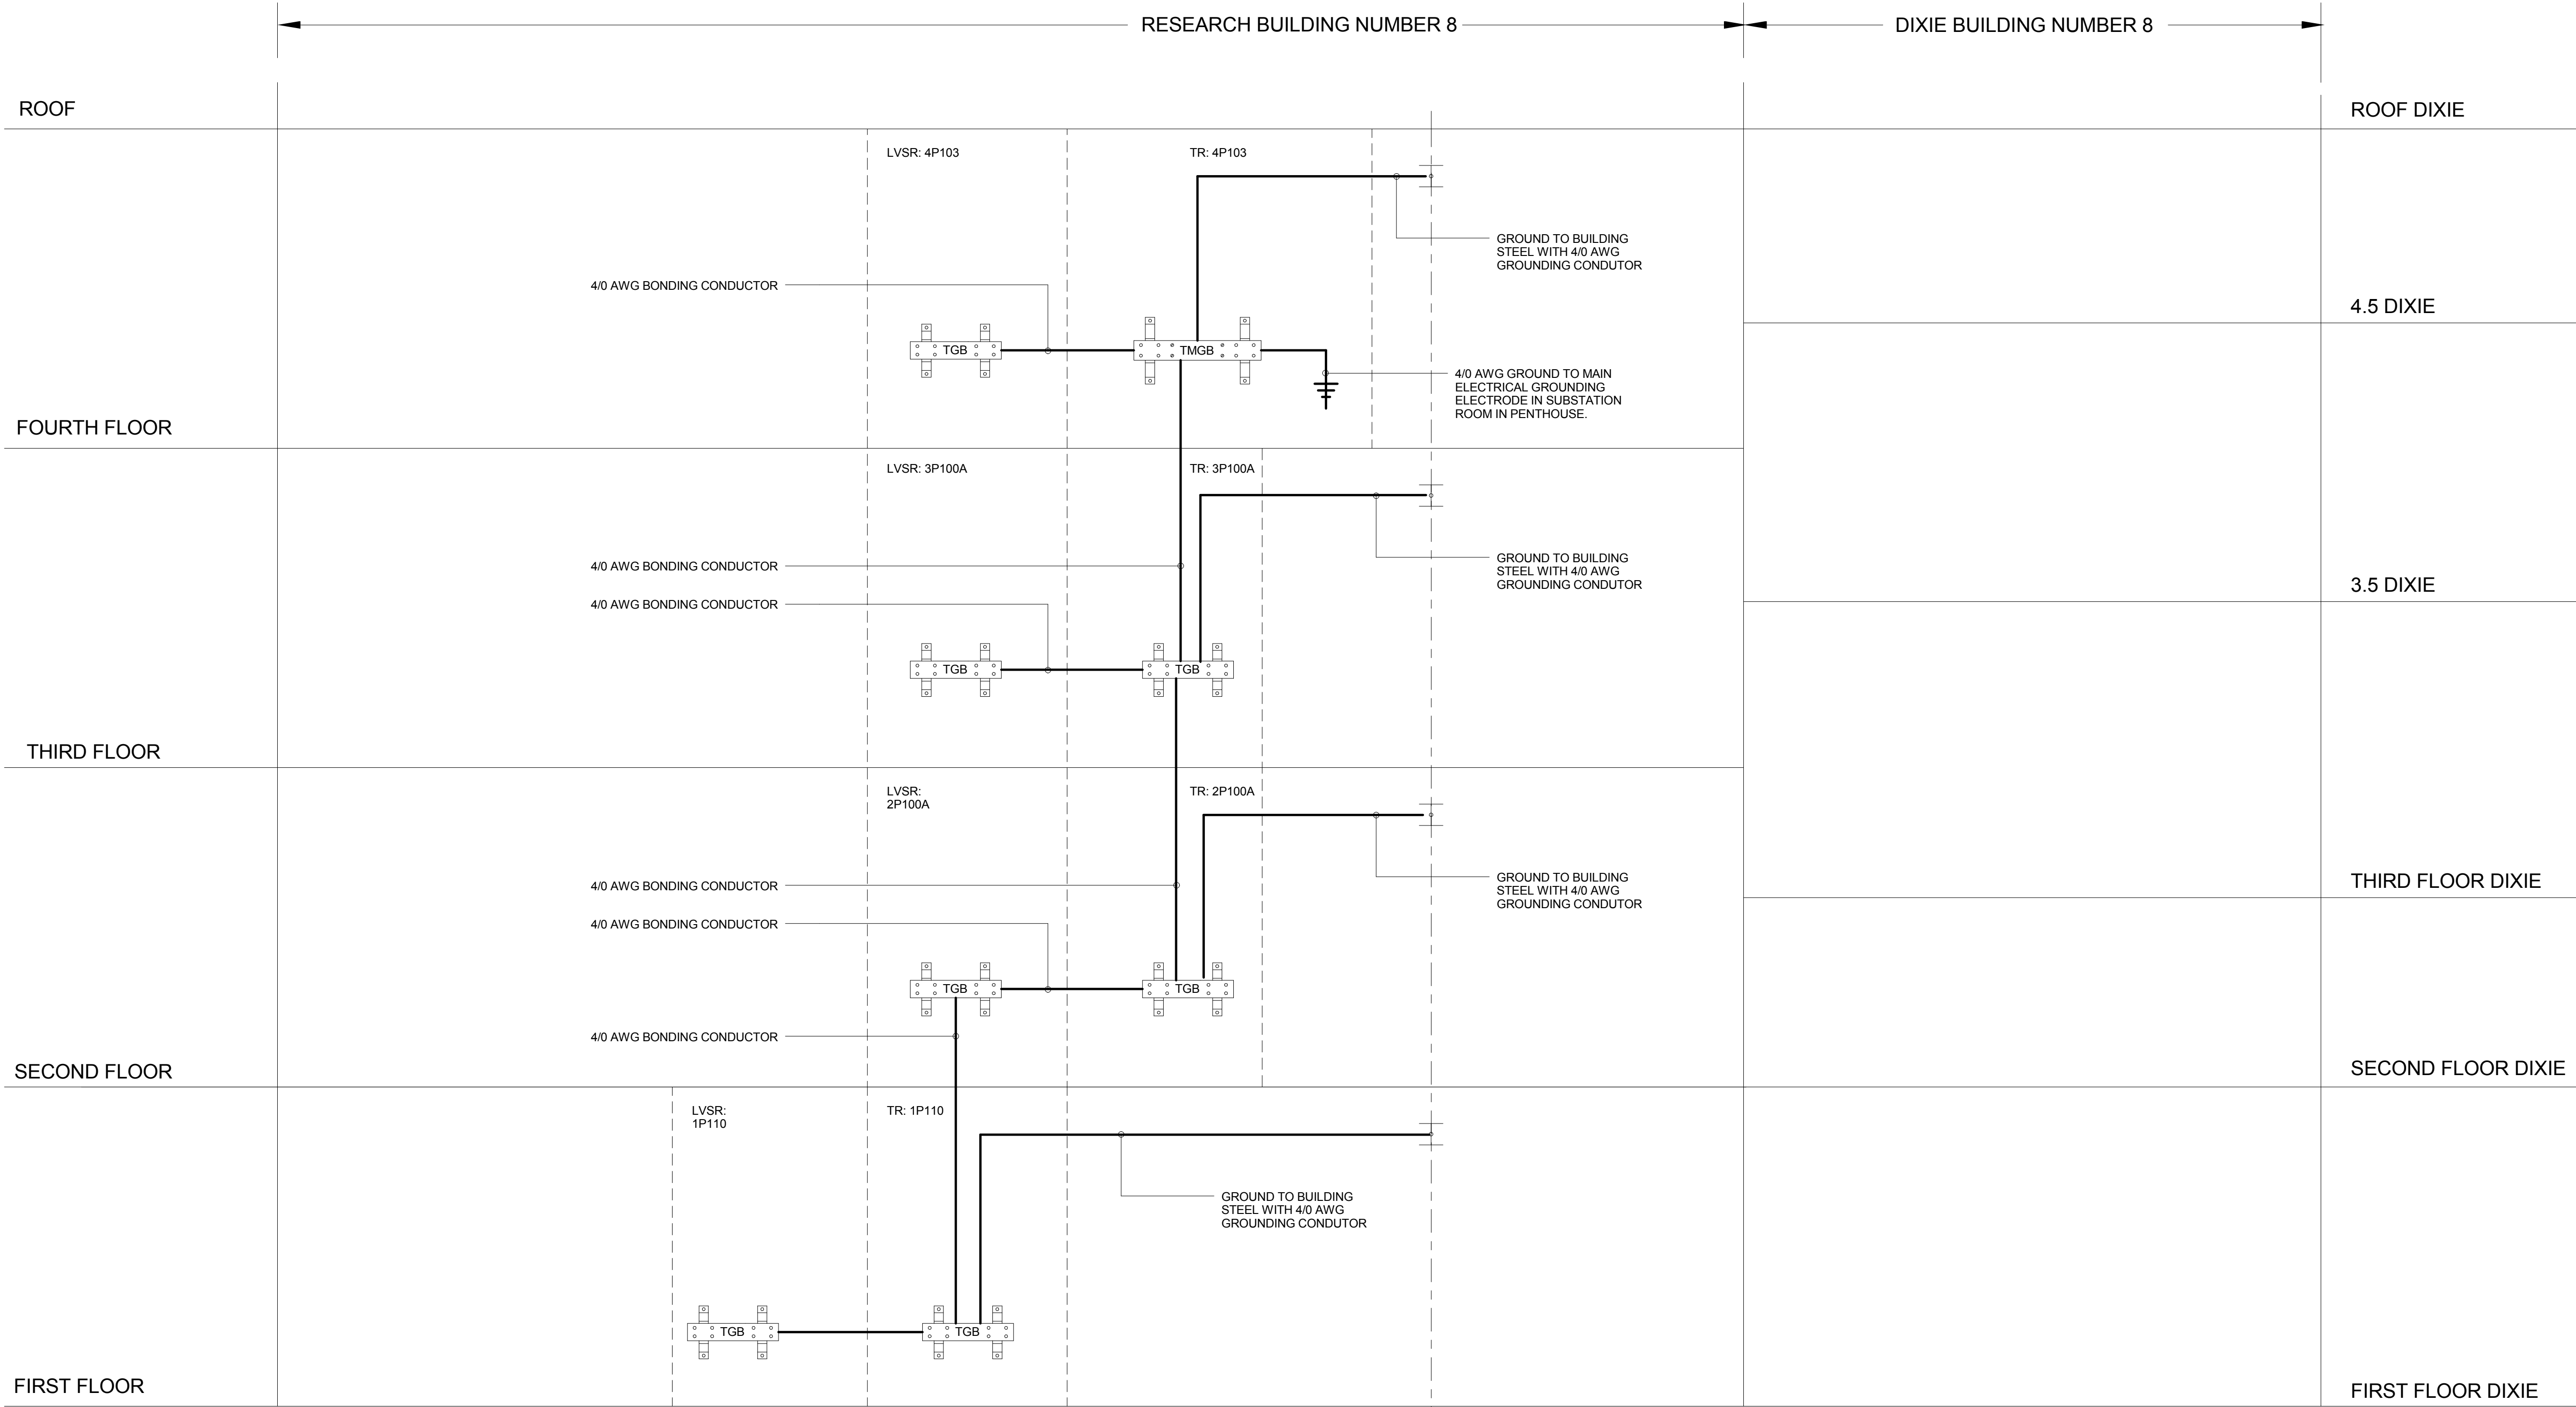

REVISIONS:		DATE		CONSULTANTS: DESMAN ASSOCIATES / PARKING CODE CONSULTANTS, INC. / CODE CONSULTANT THE SEXTANT GROUP / AV & ACOUSTICAL HAMMER DESIGN ASSOCIATES / FOOD SERVICE PYBURN & ODOM / ABATEMENT TATA & HOWARD / TANK CONSULTANT I.S.C. GROUP, INC. / IRRIGATION DAN EUSER WATER ARCHITECTURE, INC. / WATER FEATURE		 JUL 3 6 2012		ARCHITECT/ENGINEERS: studio NOVA SCHRENK & PETERSON CONSULTING ENGINEERS / CIVIL KORDA/NEMETH ENGINEERING / STRUCTURAL BR+A CONSULTING ENGINEERS / MECH, ELECT, PLUMBING, LOW VOLTAGE ARCHITECTURAL ENGINEERING/ PLUMBING SCALES ASSOCIATES / FIRE PROTECTION		DRAWING TITLE BUILDING 08 - TELECOMMUNICATIONS GROUNDING RISER DIAGRAM		PROJECT TITLE SLVHCS REPLACEMENT MEDICAL CENTER PROJECT		PROJECT NUMBER 629-HS2-401		BUILDING NUMBER 08		OFFICE OF CONSTRUCTION AND FACILITIES MANAGEMENT 			
										APPROVED: PROJECT DIRECTOR 		LOCATION NEW ORLEANS, LOUISIANA		DATE July 16, 2012		CHECKED JLE				DRAWN JJP	

VA FORM 08-6231