

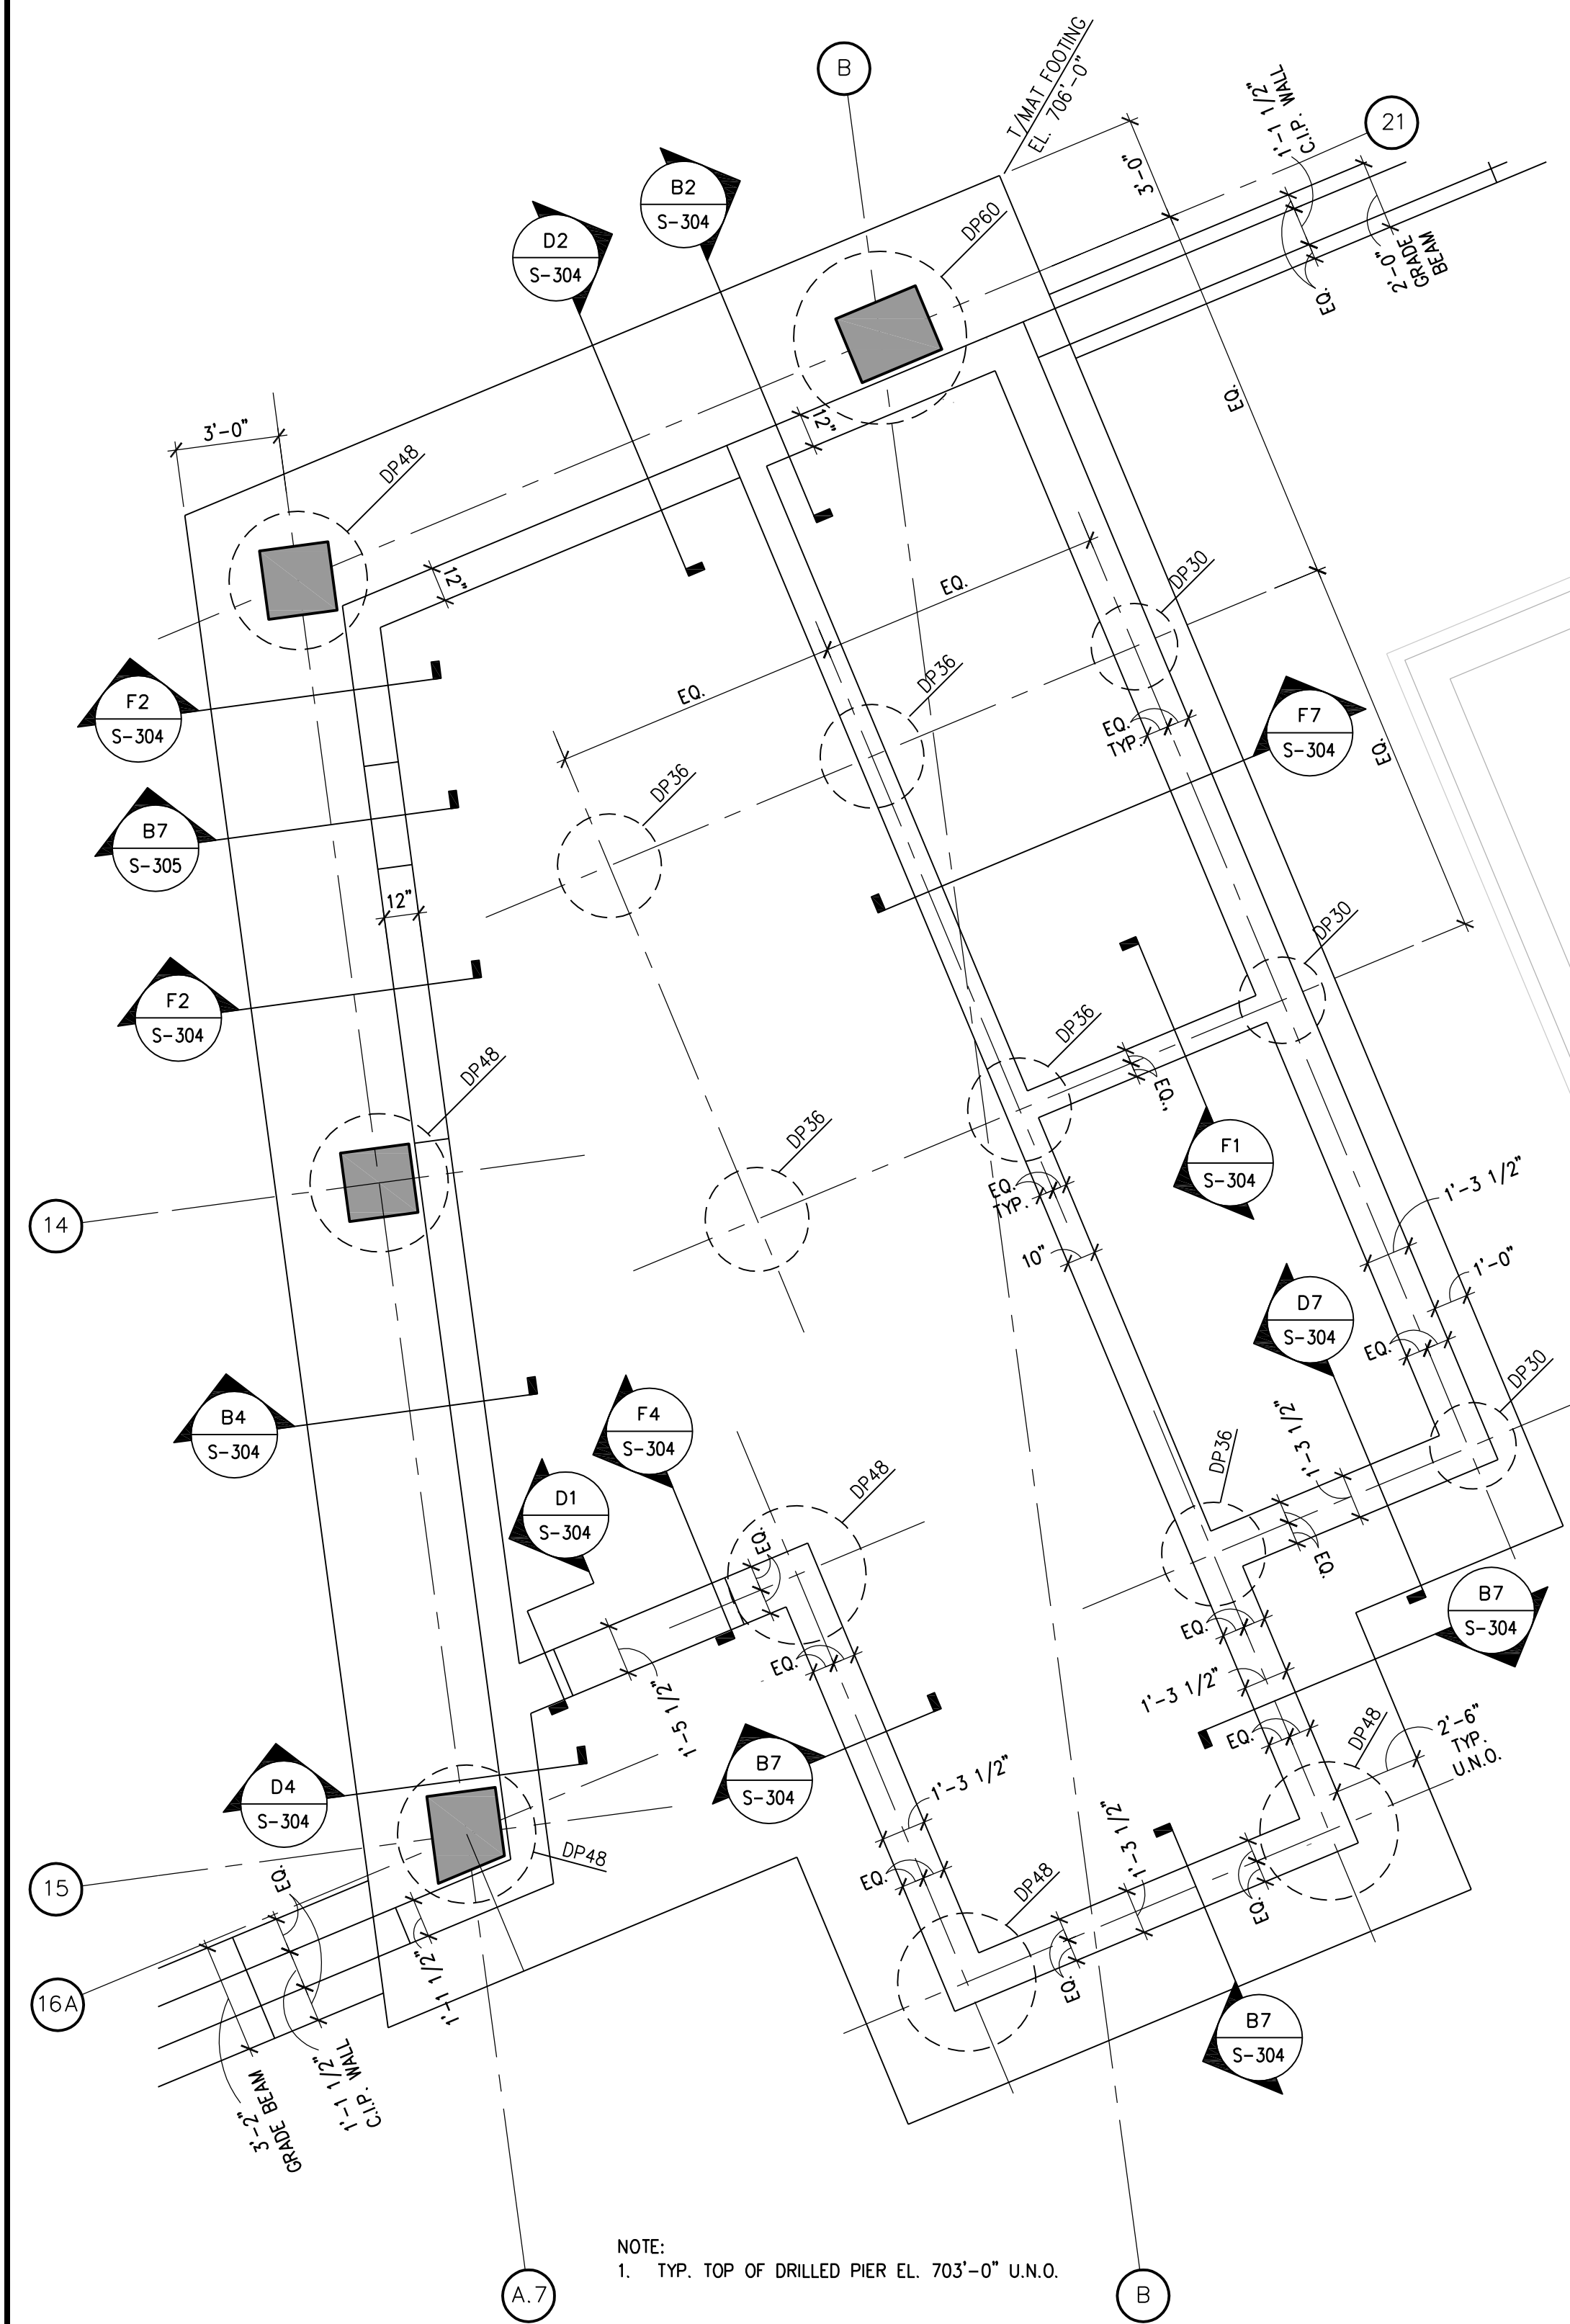




- SHEET NOTES:
1. FOR GENERAL NOTES, SEE SHEET S-001.
2. FOR S.O.G., SEE SHEET NOTE 12 ON SHEET S-101.
3. TYP. DIVIDER BEAM W10X19, SEE DETAIL F7/S-443 FOR CONNECTION DETAIL.
4. SEE ARCH. DWGS FOR DIMENSIONS AND OTHER INFORMATION NOT SHOWN.
5. SEE SHEET S-443 FOR BEAM SCHEDULE.
6. SEE SHEET S-411 FOR TYP. SECTIONS/DETAILS, U.N.O.

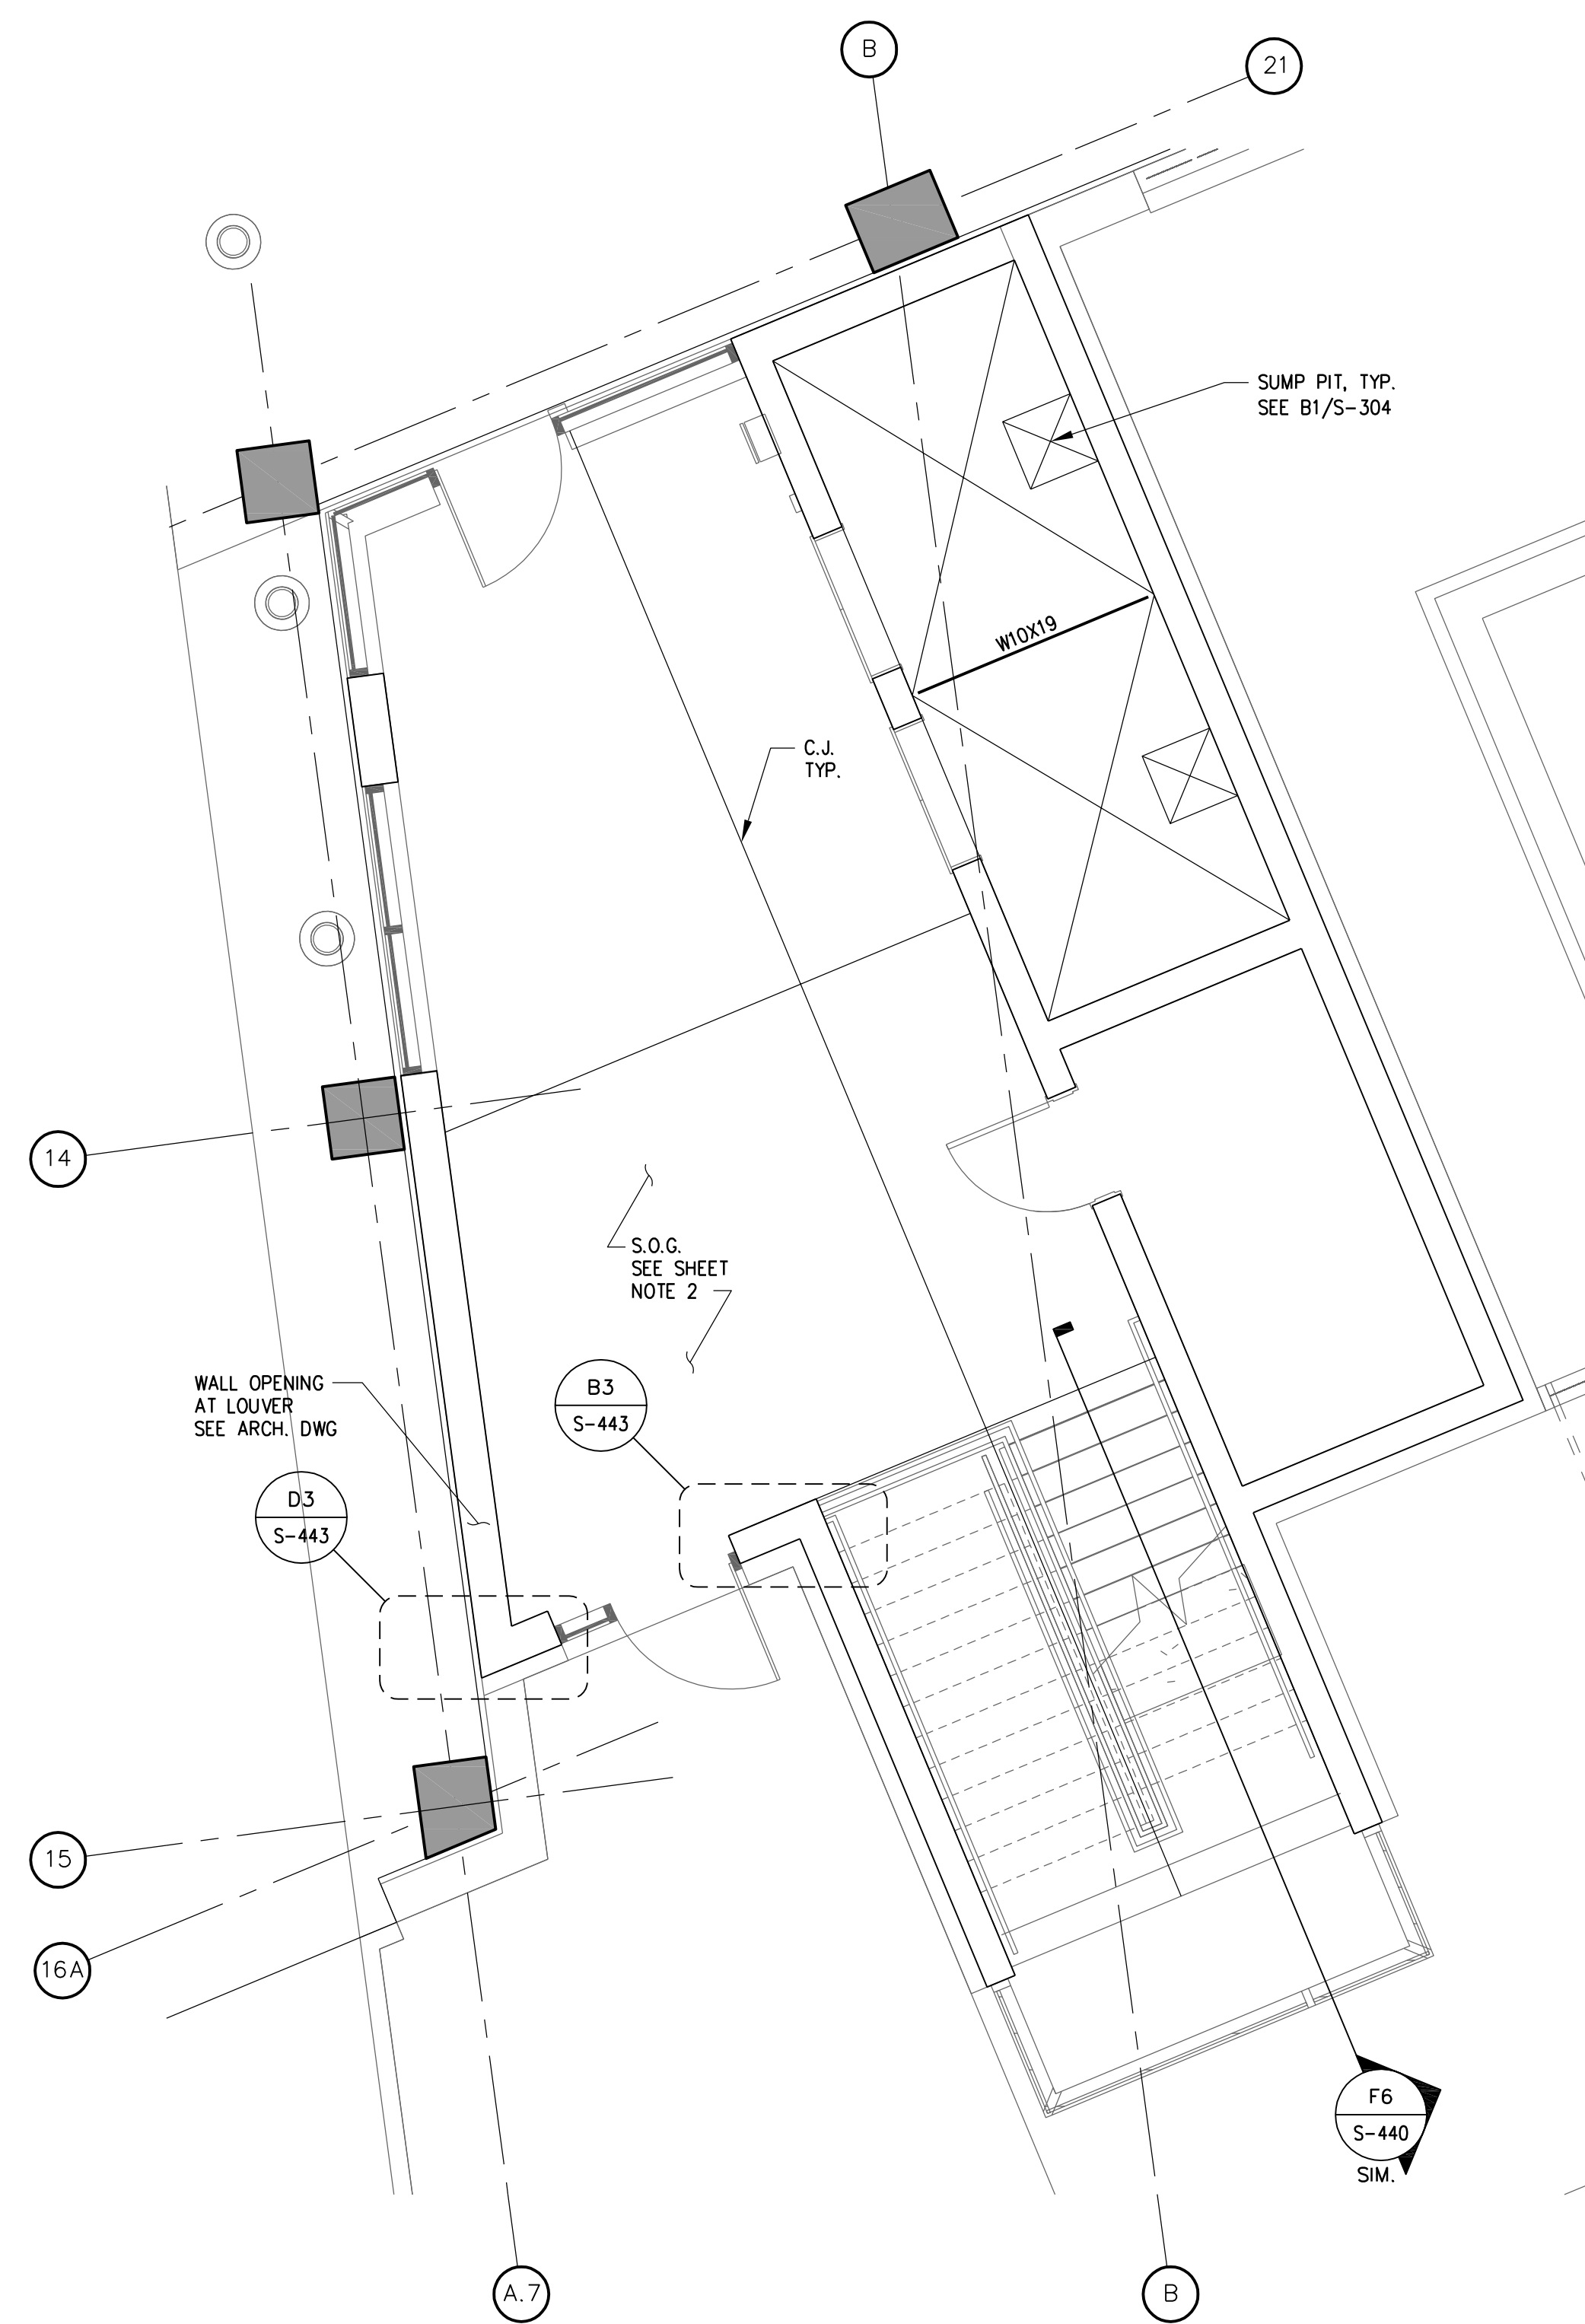


E1 SE STAIR/ELEV.
FOUNDATION PLAN

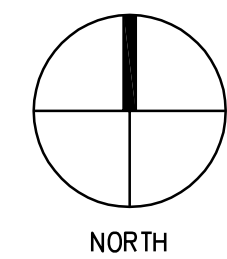

E4 SE STAIR/ELEV.
GROUND TIER PLAN

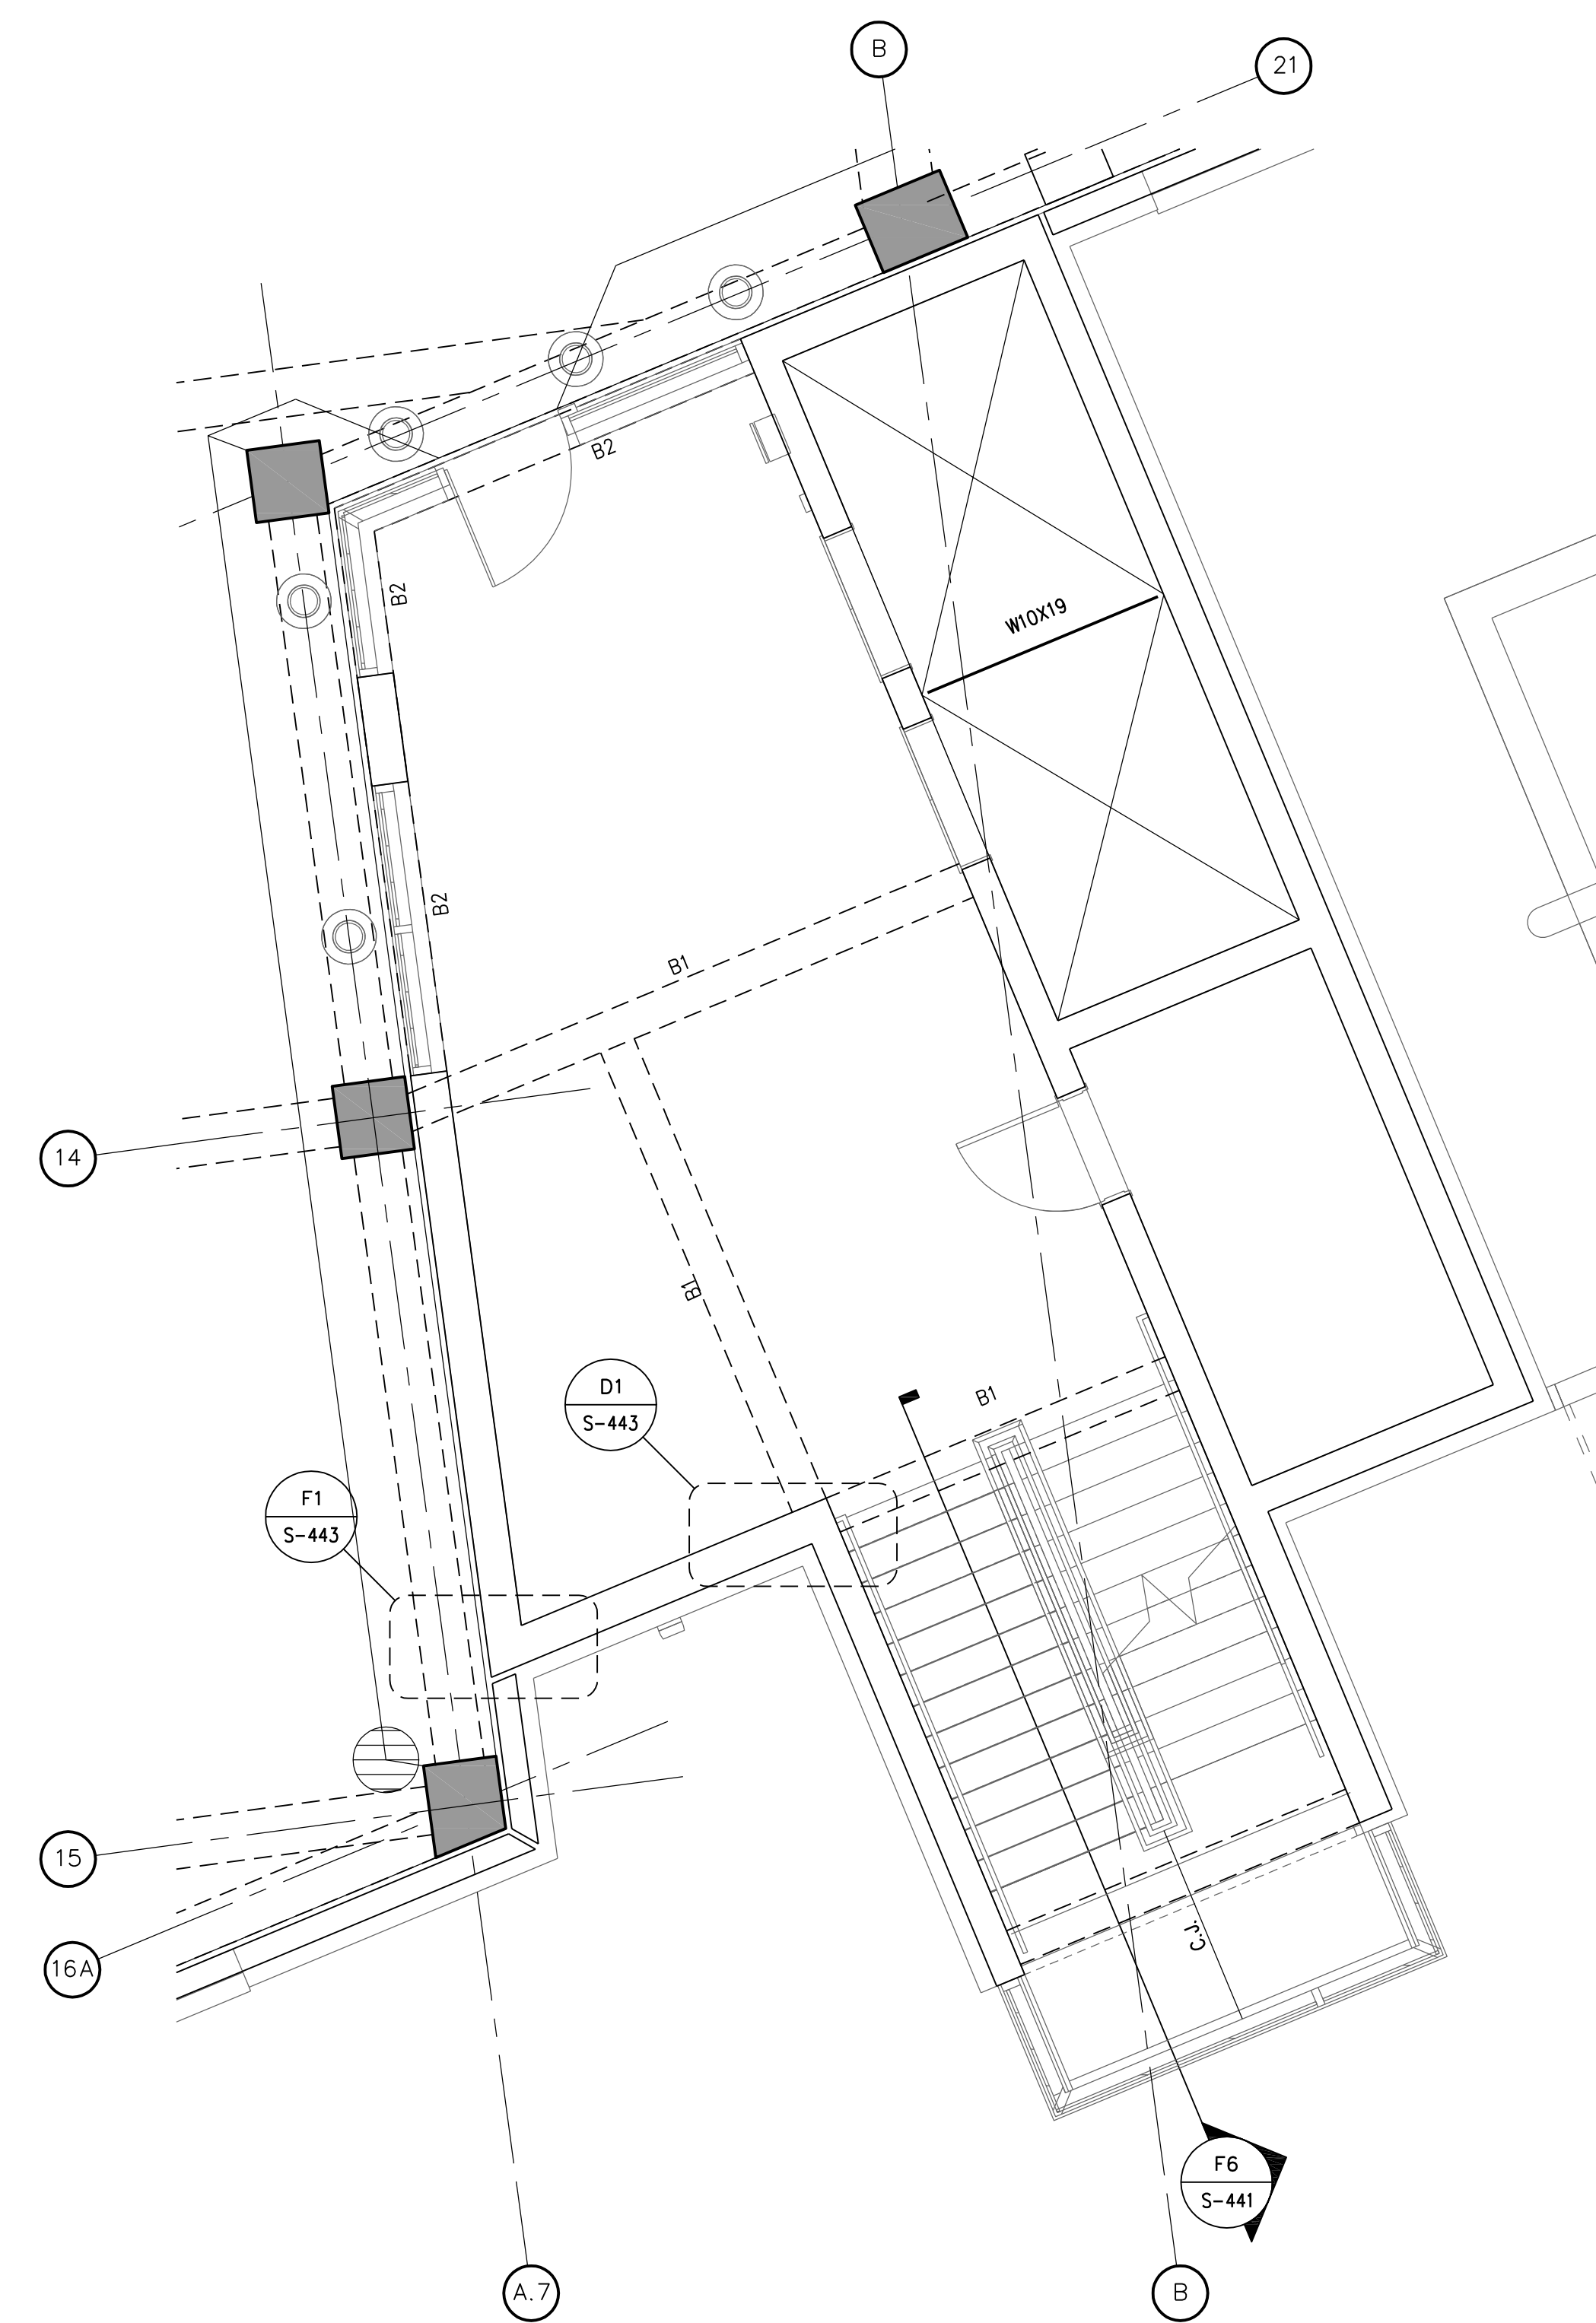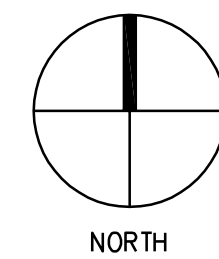

E7 SE STAIR/ELEV.
SECOND TIER PLAN

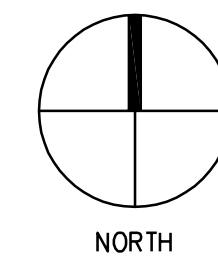

FINAL CONSTRUCTION DOCUMENTS	06/10/11
100% REVIEW SUBMISSION (NOT FOR CONSTRUCTION)	04/11/11
75% REVIEW SUBMISSION (NOT FOR CONSTRUCTION) - COST ESTIMATE	02/03/11
75% REVIEW SUBMISSION (NOT FOR CONSTRUCTION) - COST ESTIMATE	01/19/11
65% REVIEW SUBMISSION (NOT FOR CONSTRUCTION)	11/22/10
Revisions:	Date

CONSULTANTS/ENGINEERS:			
KJWW ENGINEERING CONSULTANTS Mechanical/Electrical/Plumbing Engineer 623 26TH AVENUE ROCK ISLAND, ILLINOIS 61201 309.788.0673 Telephone 309.786-5967 Fax	TERRACON Geotechnical Engineer 2640 12TH STREET SW CEDAR RAPIDS, IOWA 52404 319.366.8321 Telephone 319.366.0032 Fax	GRAF Civil Engineer/Landscape Architect 332 SOUTH MICHIGAN, SUITE 1400 CHICAGO, ILLINOIS 60604-4367 312.582.2020 Telephone 312.939.7014 Fax	WALKER PARKING CONSULTANTS Structural Engineer 305 DAVIS ROAD ELGIN, ILLINOIS 60123 847.697.2640 Telephone 847.697.7439 Fax
FAITHFUL+GOULD Cost Management 222 SOUTH RIVERSIDE PLAZA, SUITE 2240 CHICAGO, ILLINOIS 60606 312.612.6319 Telephone 312.655.9037 Fax			

ARCHITECT:	
Loebl Schlossman & Hackl Architecture • Planning • Interiors	233 North Michigan Avenue Suite 3000 Chicago, Illinois 60601
Copyright © 2011 Loebl Schlossman & Hackl Inc.	312.565.1800 Telephone 312.565.5912 Facsimile www.lshdesign.com

Drawing Title	SE STAIR/ELEVATOR PLANS
Approved: Project Director	Iowa City VA Healthcare System Department of Veterans Affairs Medical Center

Project Title	400 CAR PARKING GARAGE
Project Number	636-402
Building Number	43
Drawing Number	S-410
Date	06/10/2011
Checked	BFN
Drawn	MJK
Dwg. 95 of 152	

Office of Construction and Facilities Management
Department of Veterans Affairs