




three inches = one foot
one and one half inches = one foot
one inch = one foot
three quarters inch = one foot
one half inch = one foot
three eighths inch = one foot
one quarter inch = one foot
one eighth inch = one foot

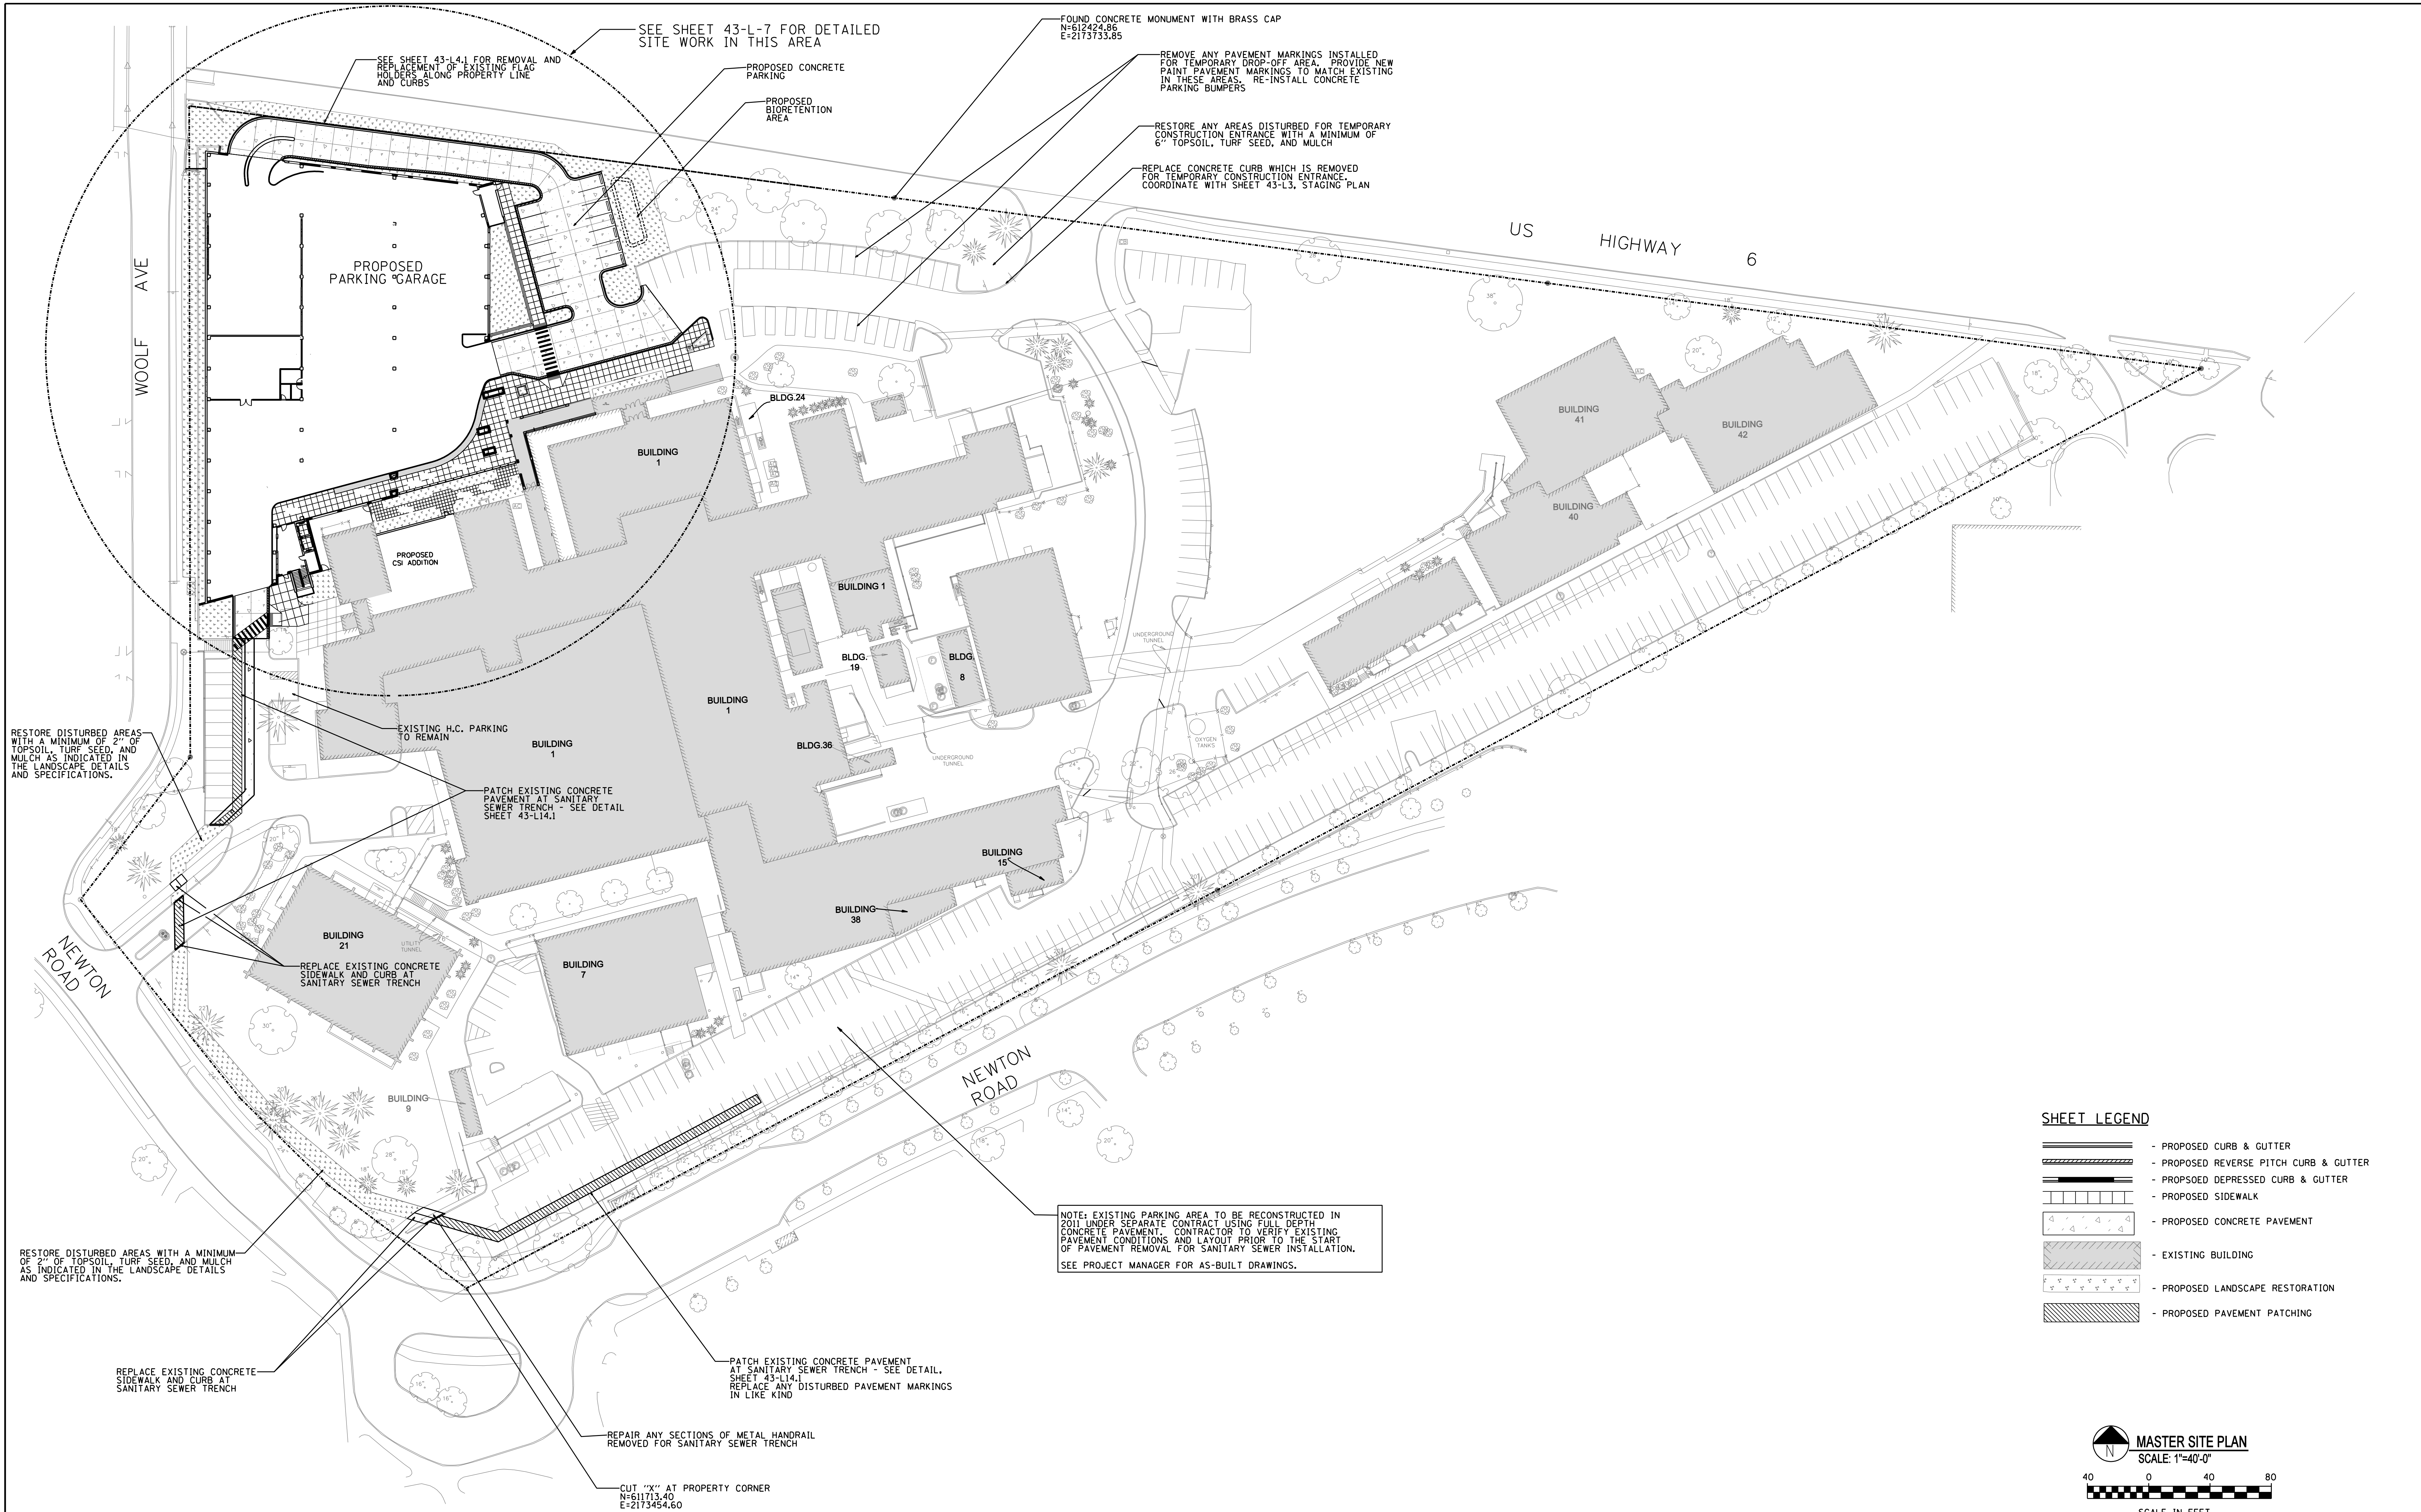

SHEET LEGEND	
	- PROPOSED CURB & GUTTER
	- PROPOSED REVERSE PITCH CURB & GUTTER
	- PROPOSED DEPRESSED CURB & GUTTER
	- PROPOSED SIDEWALK
	- PROPOSED CONCRETE PAVEMENT
	- EXISTING BUILDING
	- PROPOSED LANDSCAPE RESTORATION
	- PROPOSED PAVEMENT PATCHING

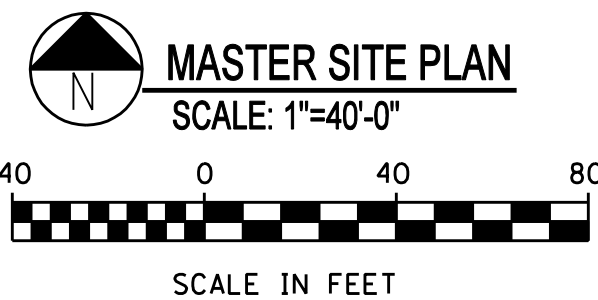

		CONSULTANTS/ENGINEERS:					ARCHITECT:		Drawing Title	Project Title	Project Number	Office of Construction and Facilities Management		
		KJWW ENGINEERING CONSULTANTS Mechanical/Electrical/Plumbing Engineer	TERRACON Geotechnical Engineer	GRAEF Civil Engineer/Landscape Architect	WALKER PARKING CONSULTANTS Structural Engineer	FAITHFUL + GOULD Cost Management	Loebl Schlossman & Hackl Architecture • Planning • Interiors <small>Copyright ©2010 Loebl Schlossman & Hackl Inc.</small>	MASTER SITE PLAN	233 North Michigan Avenue Suite 3000 Chicago, Illinois 60601 312.565.1800 Telephone 312.565.5912 Facsimile www.lshdesign.com	400 CAR PARKING GARAGE	636-402			
											Building Number			
											43			
FINAL CONSTRUCTION DOCUMENTS	06/10/11	623 26TH AVENUE ROCK ISLAND, ILLINOIS 61201 309.786.0673 Telephone 309.786.5967 Fax	2640 12TH STREET SW CEDAR RAPIDS, IOWA 52404 319.366.8321 Telephone 319.366.0032 Fax	332 SOUTH MICHIGAN, SUITE 1400 CHICAGO, ILLINOIS 60604-4367 312.582.2020 Telephone 312.939.7014 Fax	506 DAVIS ROAD ELGIN, ILLINOIS 60123 847.697.2640 Telephone 847.697.7439 Fax	222 SOUTH RIVERSIDE PLAZA, SUITE 2240 CHICAGO, ILLINOIS 60608 312.612.6319 Telephone 312.655.9037 Fax					Drawing Number			
100% REVIEW SUBMISSION (NOT FOR CONSTRUCTION)	04/11/11										43-L6			
75% REVIEW SUBMISSION (NOT FOR CONSTRUCTION)	02/03/11						Dwg. 11 of 152				 Department of Veterans Affairs			
75% REVIEW SUBMISSION (NOT FOR CONSTRUCTION) - COST ESTIMATE	01/19/11													
35% REVIEW SUBMISSION (NOT FOR CONSTRUCTION)	11/22/10													
Revisions:	Date								Approved: Project Director	Location IOWA CITY, IA	Date 06/10/2011	Checked MAY	Drawn IN	
									Iowa City VA Healthcare System Department of Veterans Affairs Medical Center					