




1 FIRE SPRINKLER RISER (CFA)
110-FP5 NOT TO SCALE

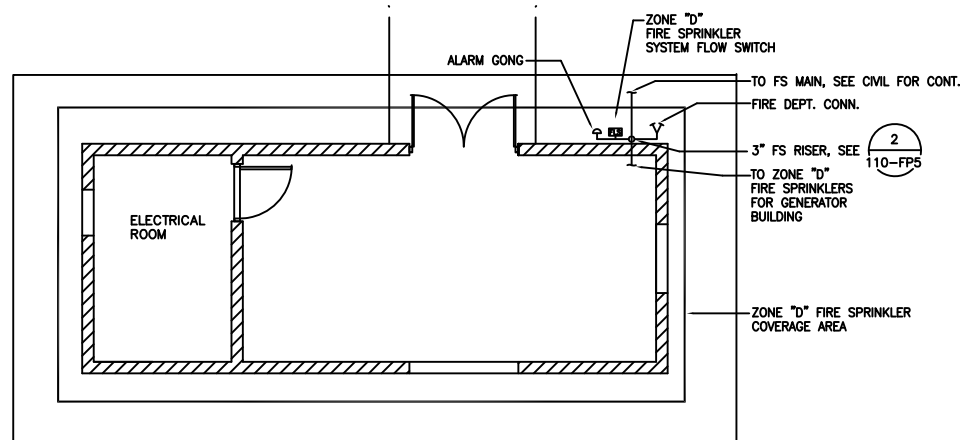


EMERGENCY GENERATOR FIRE SPRINKLER FLOOR PLAN
SCALE: 1" = 4'-0"

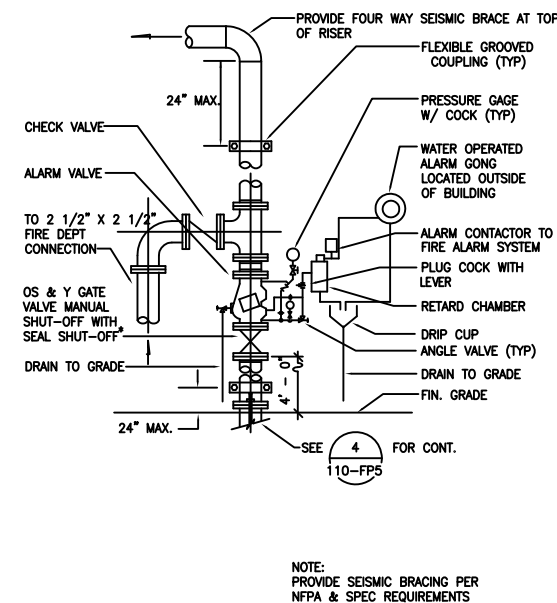

2 FIRE SPRINKLER RISER (GENERATOR BLDG.)
110-FP5 NOT TO SCALE

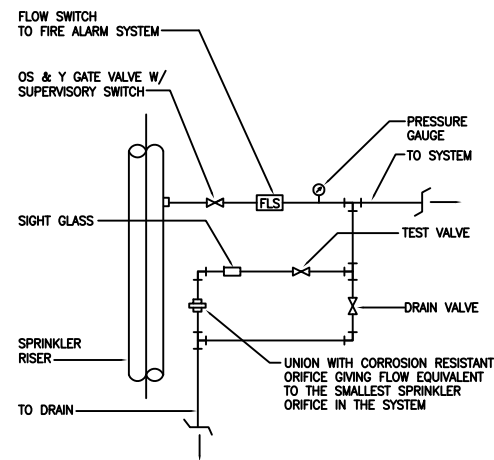

3 FIRE SPRINKLER ZONE VALVE
110-FP5 NOT TO SCALE

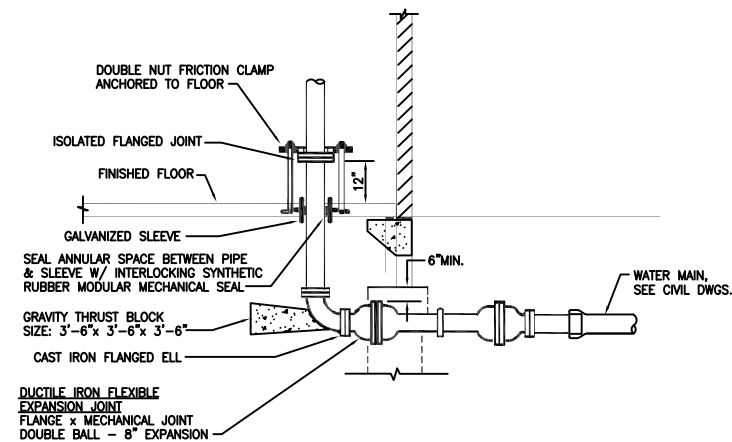

4 FIRE SPRINKLER SERVICE ENTRANCE DETAIL
110-FP5 NOT TO SCALE

RECORD DRAWINGS

5/29/98

**ARCHITECTS
HAWAII
LIMITED**
Pacific Tower, Suite 300
1001 Bishop Street
Honolulu, Hawaii 96813
Telephone: (808) 523-8636
FAX: (808) 521-3280

This work was prepared by me or under my supervision and construction of this project will be under my supervision.

Signature
NOTE: Contractor to check and verify all dimensions of job before proceeding with work.

Drawing Title
DETAILS, GENERATOR FLOOR FIRE SPRINKLER PLAN

Approved Area Project Manager

Project Title
NEW MEDICAL AND REGIONAL OFFICE CENTER, PHASE 1, CENTER FOR THE AGING

Building Number
100
Location
YAMOG, HONOLULU, HAWAII

Date
MAY 3, 1995

Project No.
459-001C

Drawing No.
110-FP5
Dep. Of



Department of
Water Affairs

CADD FILE: 2024/F4 091694