 


- ## GENERAL NOTES

- KEYED NOTES THIS SHEET

SYMBOL LEGEND




① LIGHTING PLAN - BASEMENT

SCALE: 1/8"=1'-0"



SCALE IN FEET

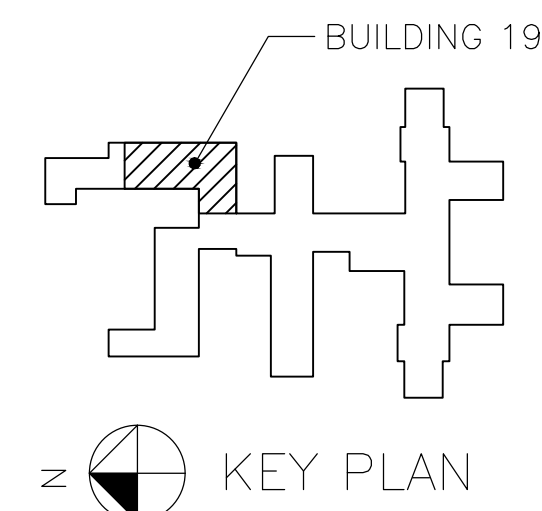VA FORM 08-6231

ARCHITECT/ENGINEERS:

ARCHITECT:

PDG Architects
333 12th Ave SE
Norman, Oklahoma 73071
OFFICE PHONE: 405-360-1102
OFFICE FAX: 405-360-0055
CONTACT: DONALD FRICK

ELECTRICAL ENGINEER:

ZRHD, P.C. Engineers
1318 N. Robinson
Oklahoma City, Oklahoma 73103
405-942-8475
CONTACT: Wayne Wright

LIGHTING PLAN
BASEMENT

RENOVATION BUILDING 19 VA
MEDICAL CENTER

19
Drawing Number

Drawn	SWW
-------	-----

E-400

Dwg. 64 of 71

Office of
Construction
and Facilities
Management

