

 
DEPARTMENT OF VETERANS AFFAIRS MEDICAL CENTER - WADE PARK

10701 EAST BLVD. CLEVELAND, OH. 44106

RENOVATE MENTAL HEALTH CLINIC

PROJECT NO. 541-13-101

Veterans Administration  
Medical Center



Fredrick, Fredrick & Heller Engineers, Inc.

Mechanical & Electrical Engineers 672 East Royalton Road Broadview Heights, Ohio 44147

Perspectus Architecture LLC

Architect 13212 Shaker Square Suite 204 Cleveland, Ohio 44120

Barber & Hoffman

Structural Engineer 1100 West 9th Street Cleveland, Ohio 44122

Stephen J. Sebesta & Associates

Asbestos Abatement 17830 Engelwood Drive Suite 16 Cleveland, Ohio 44130

DRAWING INDEX

1-X1 COVER SHEET

ARCHITECTURAL

- 1-01 SYMBOLS, ABBREVIATIONS AND SCHEDULES  
1-02 PARTIAL FIRST FLOOR LIFE SAFETY PLAN  
1-03 PARTIAL FIRST FLOOR SEQUENCING PLAN  
1-04 PARTIAL FIRST FLOOR DEMOLITION PLAN  
1-05 PARTIAL FIRST FLOOR PLAN  
1-05A PARTIAL ROOF AND PENTHOUSE PLAN - **NEW DRAWING**  
1-06 PARTIAL FIRST FLOOR REFLECTED CEILING PLAN  
1-07 INTERIOR ELEVATIONS  
1-08 DETAILS

INTERIORS

- 1-IF-01 PARTIAL FIRST FLOOR FINISH PLAN  
1-IF-02 ROOM FINISH SCHEDULE AND MATERIAL LEGEND

STRUCTURAL

- 1-S1 GENERAL NOTES AND DETAILS

FIRE PROTECTION

- 1-FP1 FIRE PROTECTION LEGEND, DETAILS AND NOTES  
1-FP2 PARTIAL FIRST FLOOR FIRE PROTECTION DEMOLITION PLAN  
1-FP3 PARTIAL FIRST FLOOR FIRE PROTECTION PLAN

PLUMBING

- 1-P1 PLUMBING SYMBOLS, SCHEDULES, AND DETAILS  
1-P2 PARTIAL BASEMENT PLUMBING DEMOLITION PLAN  
1-P3 PARTIAL FIRST FLOOR PLUMBING DEMOLITION PLAN  
1-P4 PARTIAL BASEMENT PLUMBING PLAN  
1-P5 PARTIAL FIRST FLOOR PLUMBING PLAN  
1-P6 PLUMBING STACK DIAGRAMS

HEATING, VENTILATION, AIR CONDITIONING AND REFRIGERATION

- 1-H1 HVAC SYMBOLS AND GENERAL NOTES  
1-H2 PARTIAL FIRST FLOOR HVAC DUCTWORK DEMOLITION PLAN  
1-H3 PARTIAL FIRST FLOOR HVAC PIPING DEMOLITION PLAN  
1-H4 PARTIAL ROOF AND PENTHOUSE HVAC DEMOLITION PLAN  
1-H5 PARTIAL FIRST FLOOR HVAC DUCTWORK PLAN  
1-H6 PARTIAL FIRST FLOOR HVAC PIPING PLAN  
1-H7 PARTIAL ROOF AND PENTHOUSE HVAC PLAN  
1-H8 HVAC DETAILS  
1-H9 TEMPERATURE CONTROLS  
1-H10 HVAC SCHEDULES

ELECTRICAL



- 1-E1 ELECTRICAL LEGEND AND GENERAL NOTES  
1-E2 LIGHTING FIXTURE SCHEDULE, NOTES, AND DETAILS  
1-E3 PARTIAL FIRST FLOOR ELECTRICAL KEY PLAN  
1-E4 PARTIAL FIRST FLOOR LIGHTING AND FIRE ALARM DEMOLITION PLAN  
1-E5 PARTIAL FIRST FLOOR POWER DEMOLITION PLAN  
1-E6 PARTIAL FIRST FLOOR LIGHTING AND FIRE ALARM PLAN  
1-E7 PARTIAL FIRST FLOOR POWER PLAN  
1-E8 POWER DISTRIBUTION PANELBOARD SCHEDULES  
1-E9 POWER DISTRIBUTION ONE-LINE DIAGRAM  
1-E10 BRANCH CIRCUIT RECONNECTION TABLE AND NOTES  
1-E11 FIRE ALARM RISER  
1-E12 ELECTRICAL DETAILS  
1-E13 ELECTRICAL DETAILS

TECHNOLOGY

- 1-T1 TECHNOLOGY LEGEND AND GENERAL NOTES  
1-T2 PARTIAL FIRST FLOOR TECHNOLOGY KEY PLAN  
1-T3 PARTIAL FIRST FLOOR TECHNOLOGY DEMOLITION PLAN  
1-T4 PARTIAL FIRST FLOOR TECHNOLOGY PLAN  
1-T5 TELECOMMUNICATION DETAILS  
1-T6 TELECOMMUNICATION DETAILS  
1-T7 SECURITY SYSTEM RISER


ASBESTOS ABATEMENT

- 1-AA1 PARTIAL FIRST FLOOR ASBESTOS ABATEMENT PLAN  
1-AA2 STANDARD ASBESTOS ABATEMENT DETAILS

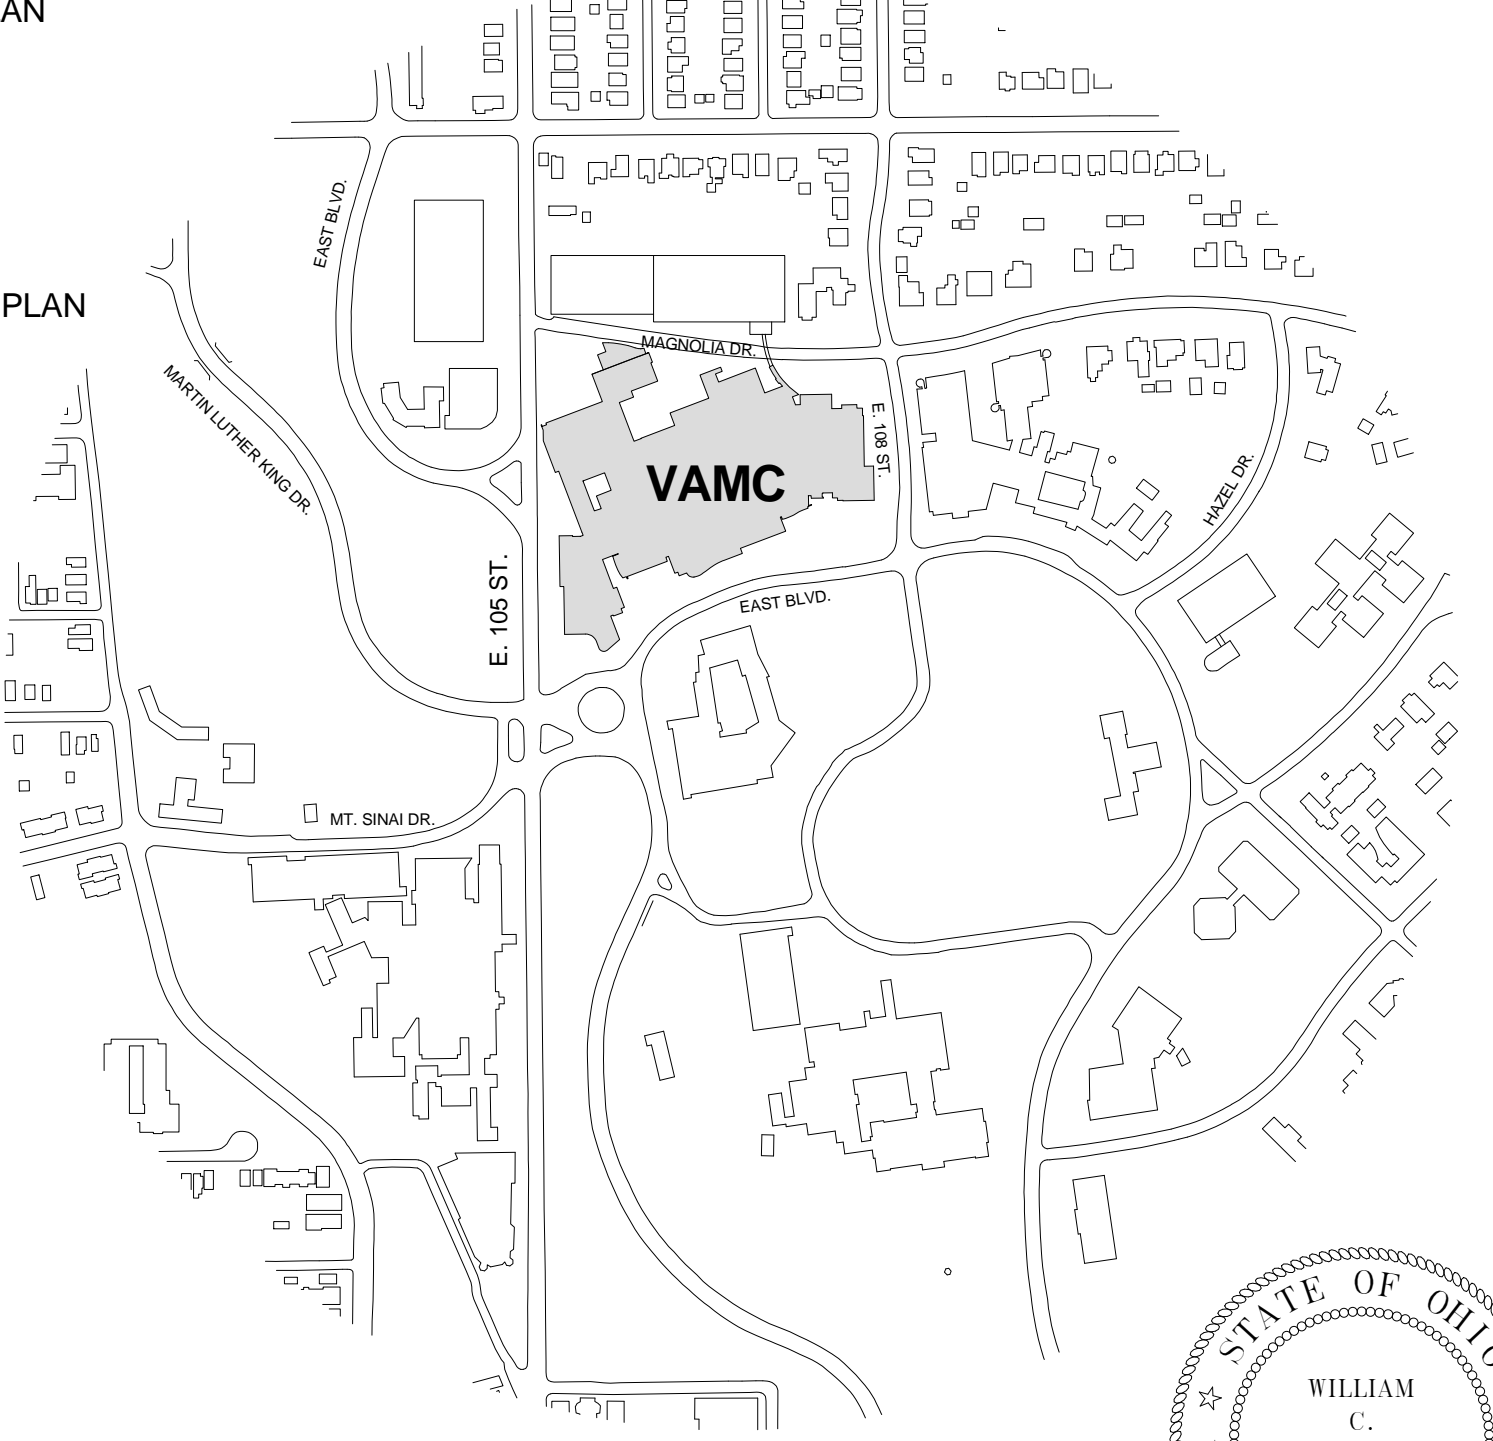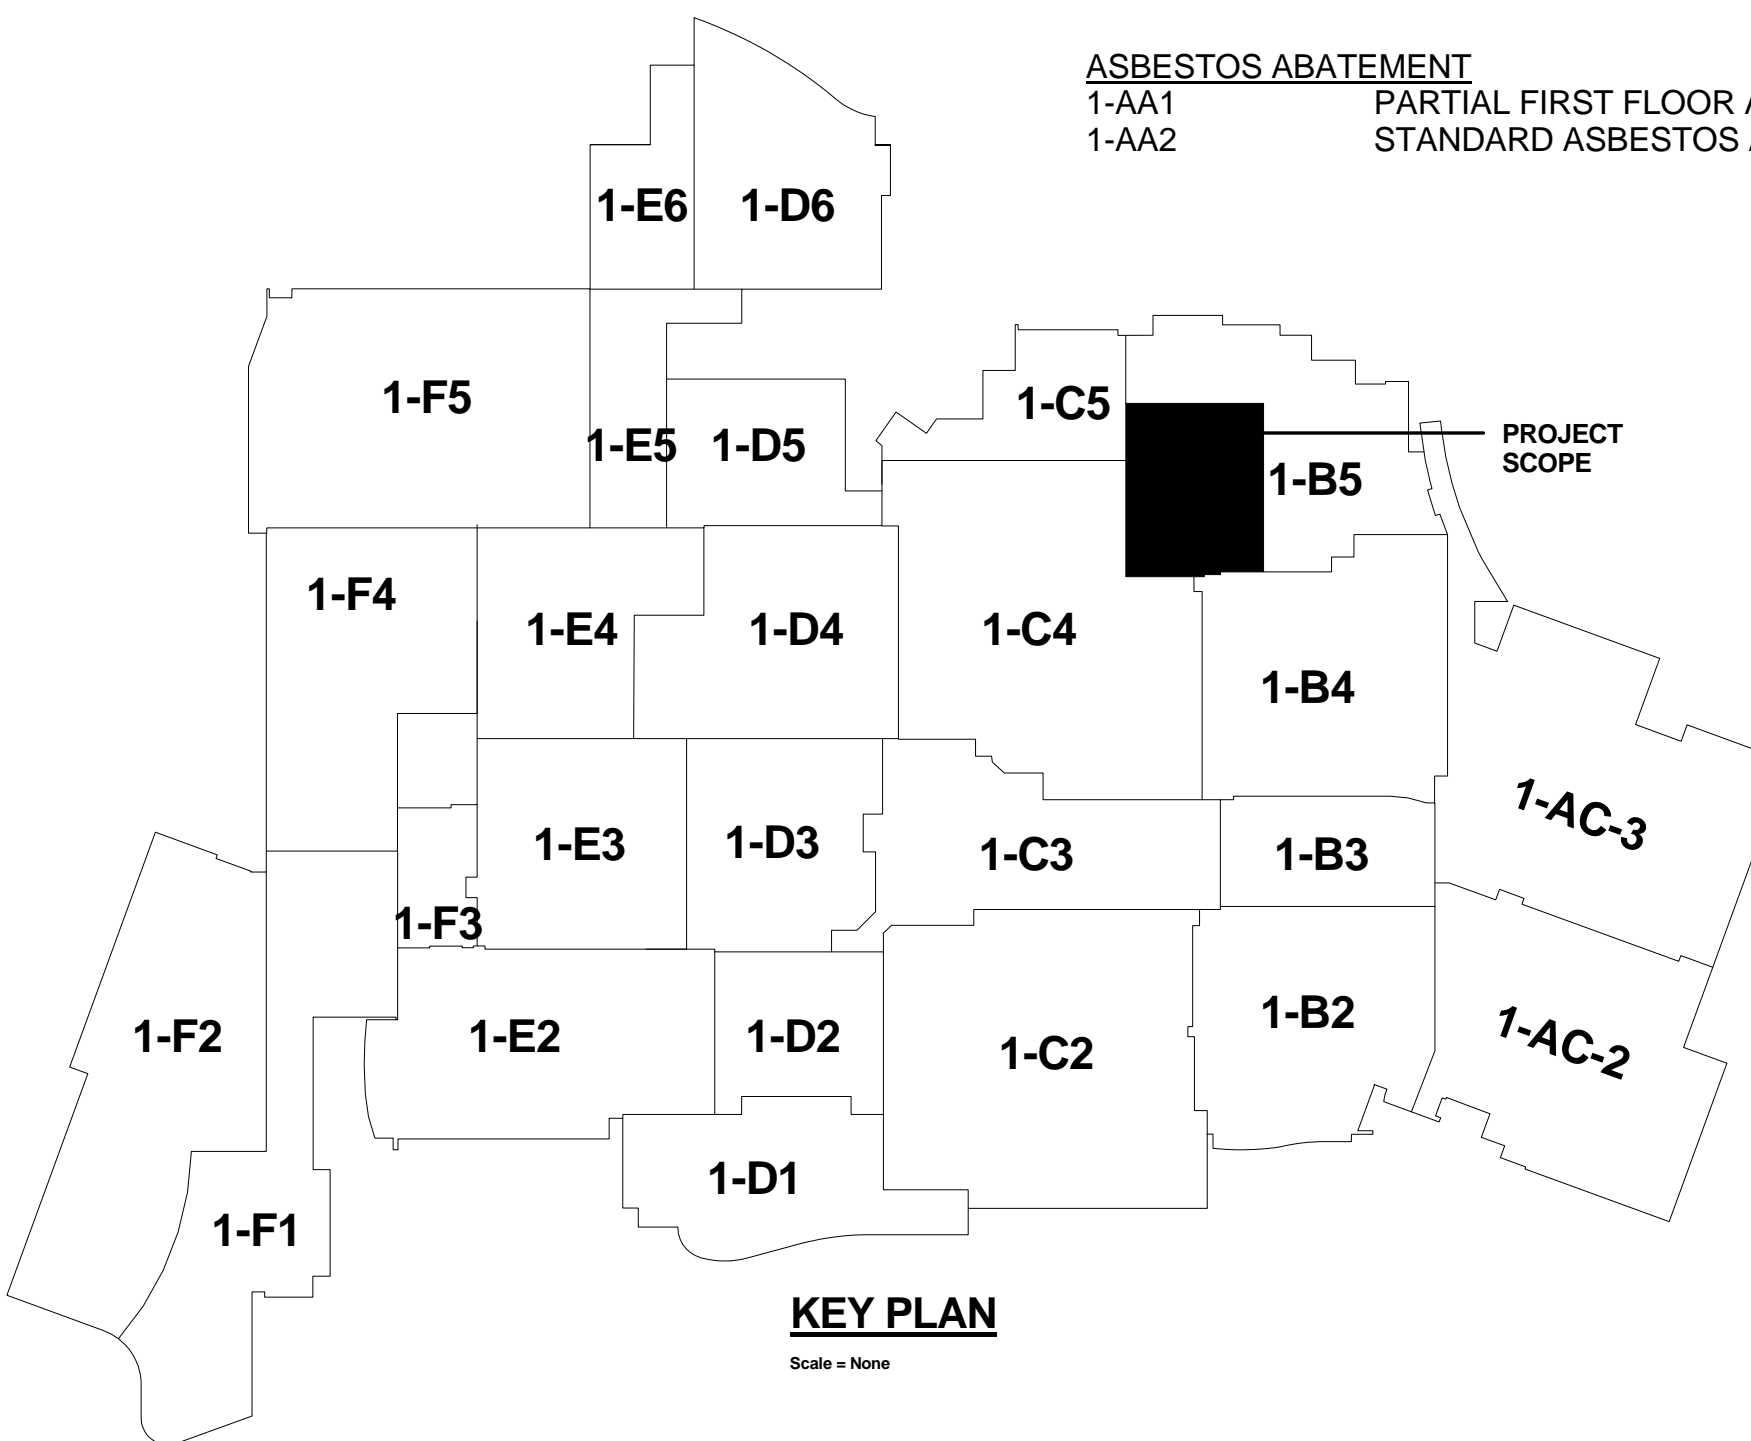

SITE PLAN

Scale = None  
ARCH JOB NO.: 11-044

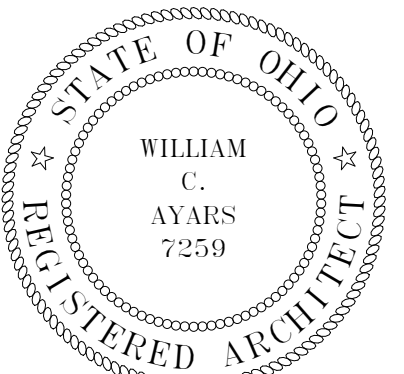

APPROVALS		DATE	APPROVALS		DATE	APPROVALS		DATE	Drawing Title		Project Title	Date	Office of Facilities Management	
DIRECTOR 00			CHIEF Planning and Construction			FACILITY MANAGER			<b>COVER SHEET</b>		<b>RENOVATE MENTAL HEALTH CLINIC</b>	4-26-2012	Department of Veterans Affairs	
ASSOCIATE DIRECTOR 00A (B)			CHIEF, Occupational Health & Safety			SHOP FOREMAN 138			Approved: Division Chief		Building Number 1	Checked RN		
CHIEF, ENGINEERING 138			CHIEF, IRM						Approved: Service Director		Location 10701 EAST BLVD. CLEVELAND OHIO	Drawing No. 1-X1		
												Dwg. of		