



DEPARTMENT OF VETERANS AFFAIRS MEDICAL CENTER
200 VETERANS AVENUE
BECKLEY, WV 25801
PROJECT NO. 517-12-102
Fourth & Sixth Floor Ceiling Tile Replacement

LOCATION MAP

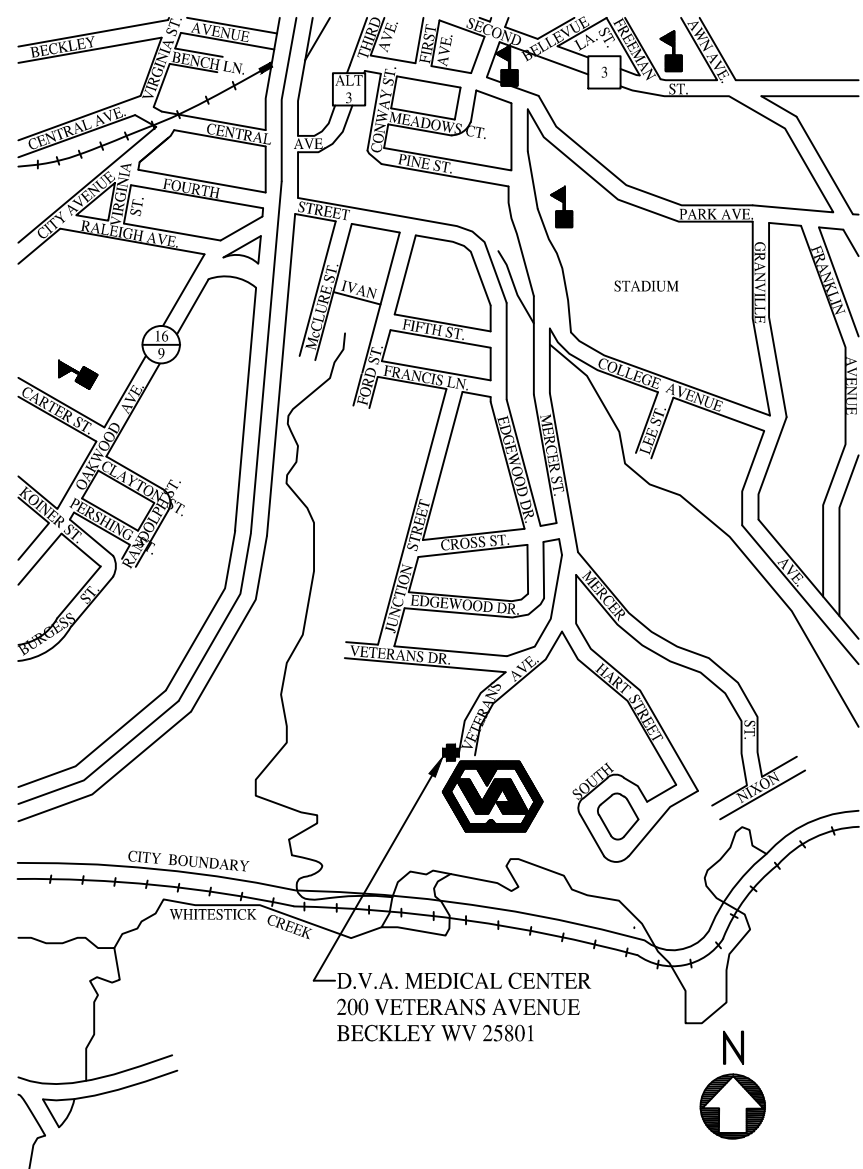

SITE PLAN

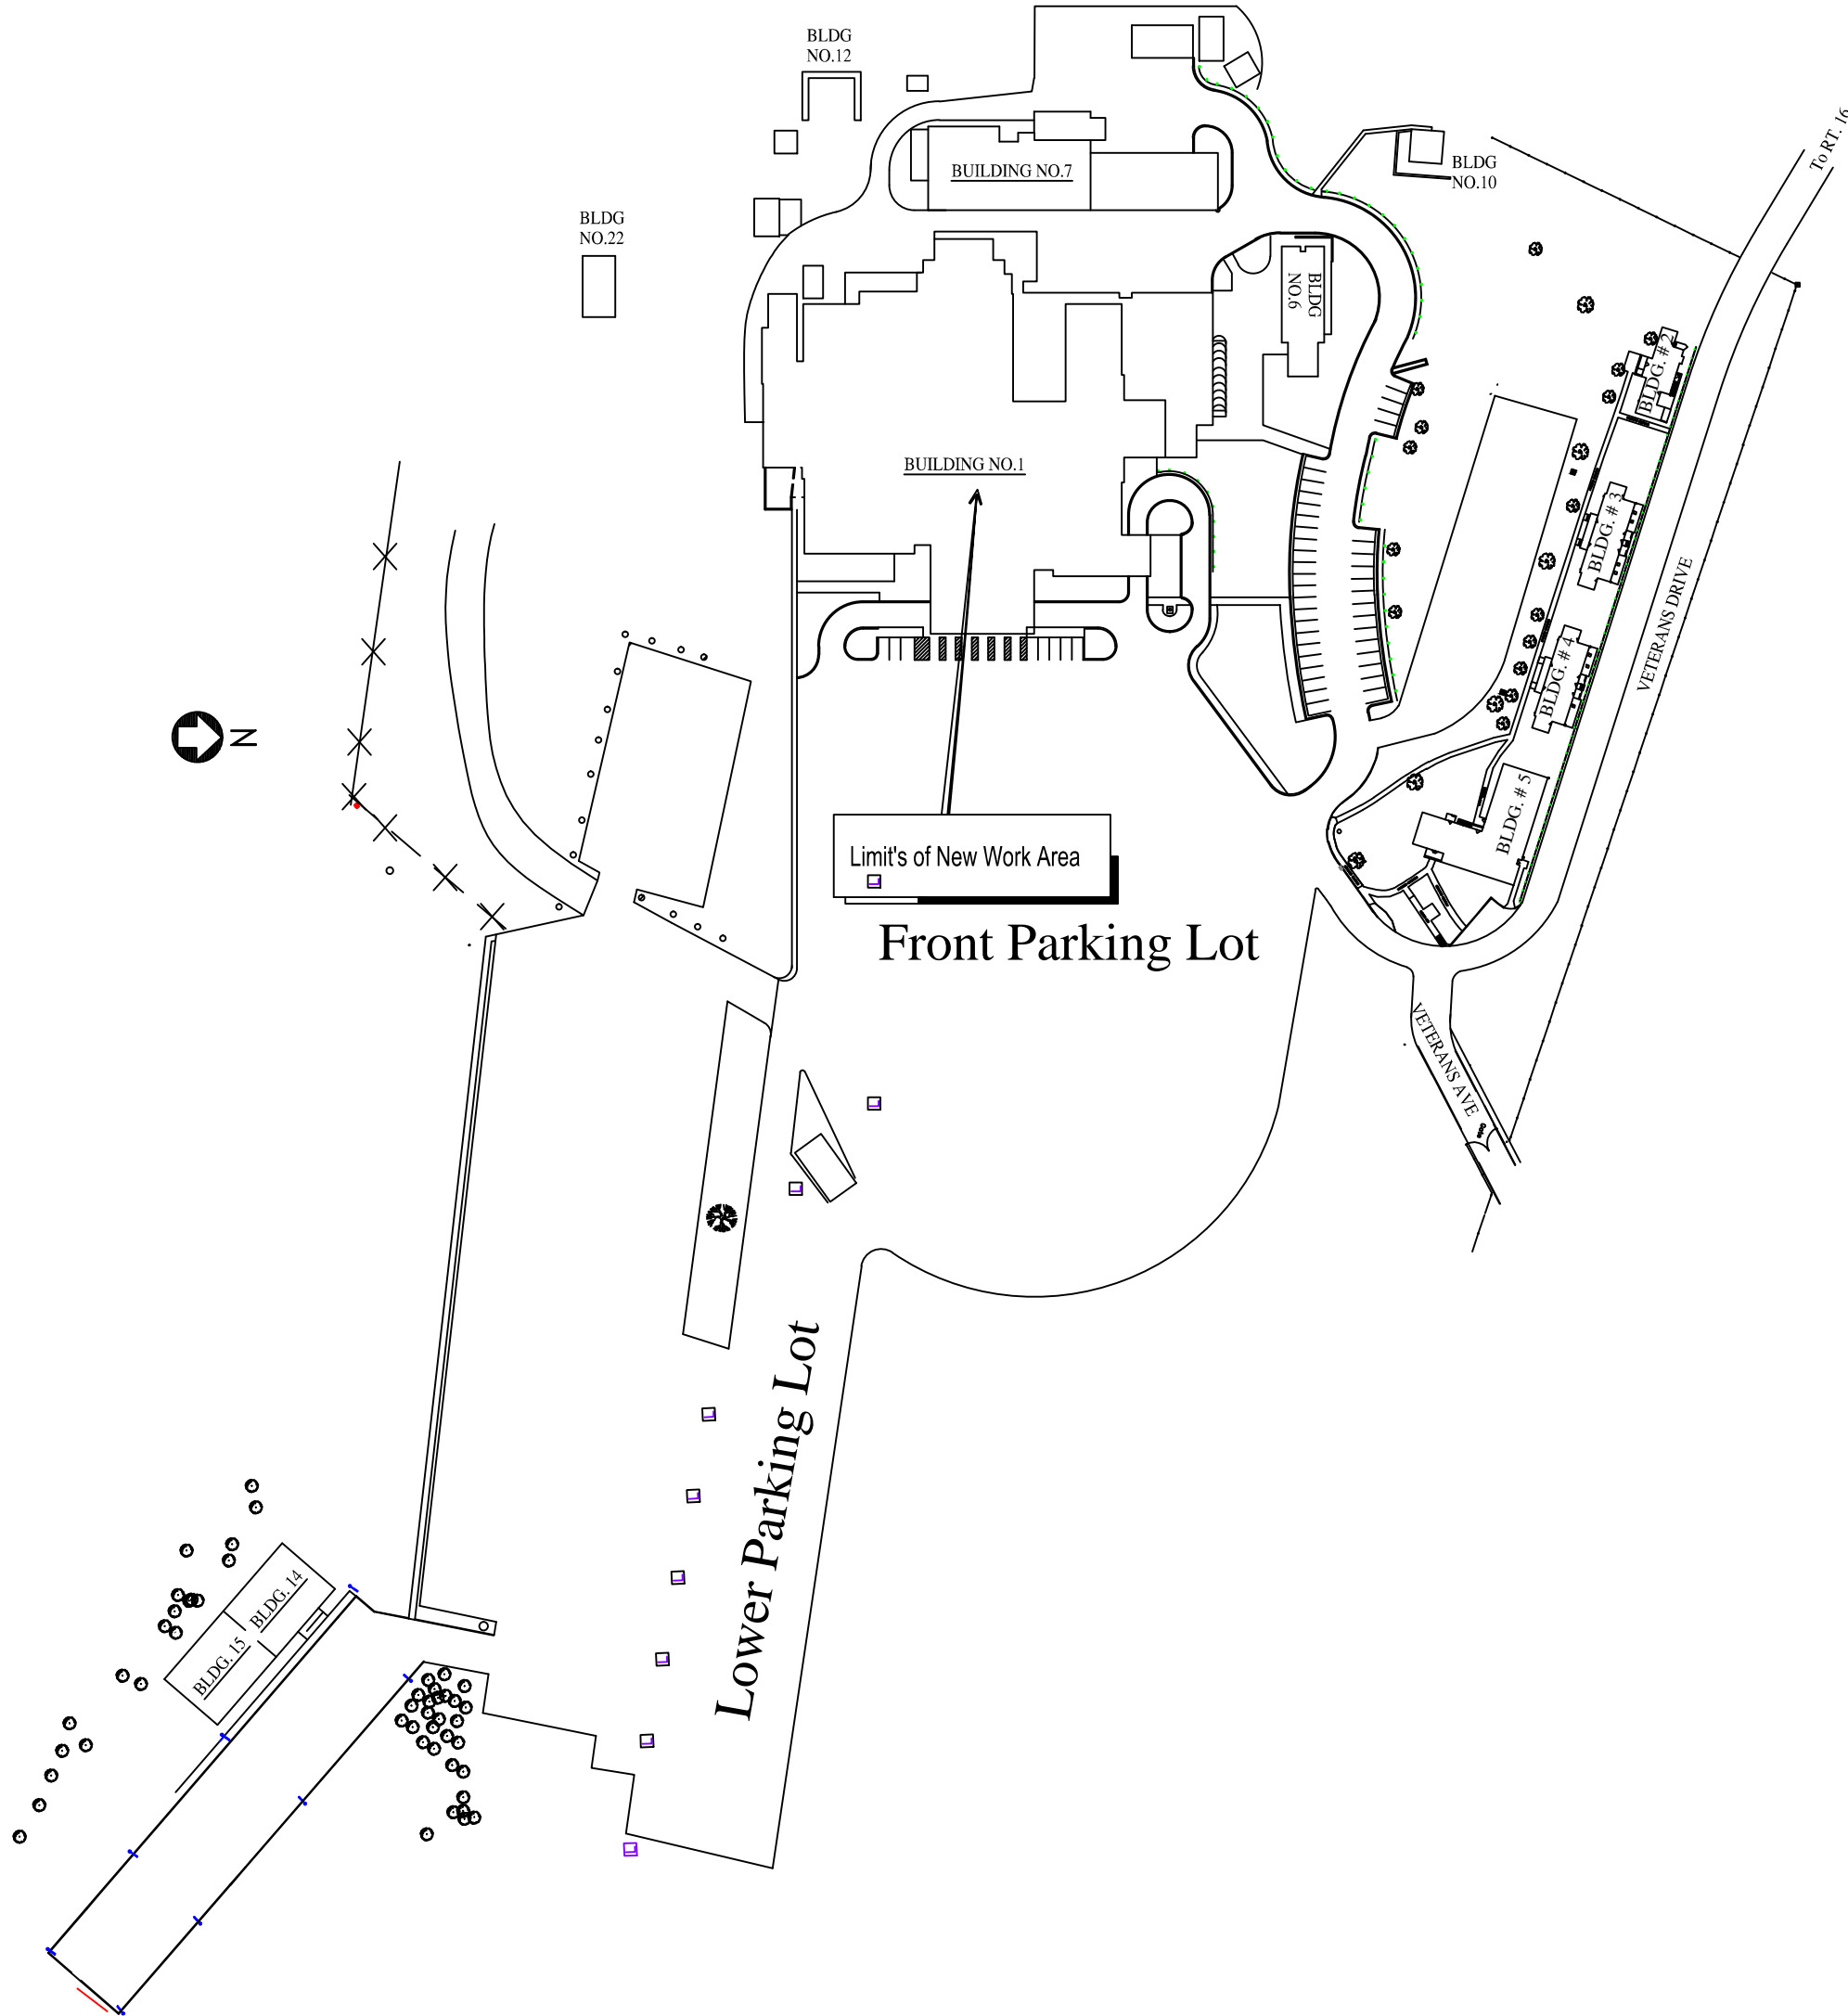


PROJECT DRAWING INDEX

DRAWING NUMBER	DRAWING TITLE
GI001	SITE PLAN & TITLE SHEET
AS101	Fourth Floor Ceiling Tile Replacement
AS102	Sixth Floor Ceiling Tile Replacement
MH101	Fan Coil Replacement Fourth Floor ECRC Offices

GENERAL NOTES

- ALL WORK SHALL COMPLY WITH ANY & ALL BUILDING CODES, REGULATIONS AND REQUIREMENTS ADOPTED BY THE AUTHORITIES HAVING JURISDICTION. IT IS THE RESPONSIBILITY OF THE CONTRACTORS TO COMPLY WITH THE APPROPRIATE SECTION OF THE CODE DURING EACH PHASE OF THE WORK.
- THE INFORMATION SHOWN REGARDING EXISTING CONDITIONS ON ALL DRAWINGS AND AS NOTED ELSEWHERE WERE BASED ON FIELD OBSERVATIONS AS OF FEBRUARY 2012. THE CONTRACTOR IS RESPONSIBLE TO FIELD VERIFY ANY AND ALL DIMENSIONS AND CONDITIONS PRIOR TO SUBMITTING A BID. DRAWINGS ARE NOT TO BE SCALED FOR LOCATIONS OR NEW WORK ITEMS.
- CONTRACTOR MUST HAVE PRIOR APPROVAL OF COR FOR ALL MATERIAL STORAGE, EQUIPMENT SETUP, AND STAGING FOR ALL DEMOLITION AND OR NEW WORK.
- NORMAL MEDICAL CENTER WORK HOURS ARE 8:00AM TO 4:30PM M-F. CONTRACTORS WORK IS TO BE PERFORMED DURING DUTY HOURS AS DIRECTED BY COR. ALL AND OR ANY UTILITY SHUT DOWNS MUST BE KEPT TO A MINIMUM AND COORDINATED WITH THE COR PRIOR TO AND IN ACCORDANCE WITH THE SPECIFICATIONS.
- CONTRACTORS ARE TO KEEP ALL ROADWAYS AND ENTRANCES TO THE MEDICAL CENTER OPEN AND OR ACCESSIBLE AT ALL TIMES, UNLESS APPROVED BY THE COR.
- CONTRACT DRAWINGS AND SPECIFICATIONS REPRESENT A FINISHED PROJECT. THEY DO NOT INDICATE METHODS OF CONSTRUCTION. THE CONTRACTORS SHALL PROVIDE ALL MEASURES NECESSARY TO PROTECT THE STRUCTURE AND PERSONNEL DURING CONSTRUCTION. CONTRACTORS ARE TO KEEP THE MEDICAL CENTER CLEAN AND FREE FROM DEBRIS AT ALL TIMES.
- THESE DRAWINGS ARE DIAGRAMMATICAL AND SHOW ONLY THE INTENT OF WORK TO BE COMPLETED. THE CONTRACTOR IS RESPONSIBLE FOR PROVIDING ALL LABOR AND OR MATERIALS FOR A COMPLETE WORKING SYSTEM AS REQUIRED. ANY ERRORS OR OMISSIONS SHOULD BE REPORTED TO THE COTR
- THE GOVERNMENT HAS SALVAGE RIGHTS TO ANY AND OR ALL EQUIPMENT OR MATERIAL BEING REMOVED UNDER THIS CONTRACT AS DIRECTED BY THE COR.

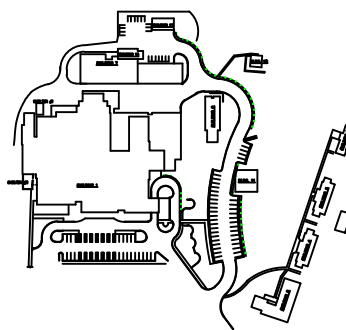

APPROVED:

APPROVED:

APPROVED:

APPROVED: INTERIM SAFETY MANAGER

JUSTIN GREENE

APPROVED: INFECTION CONTROL

SHAWN MILLS

APPROVED:

APPROVED: CHIEF, FACILITIES MANAGEMENT SERVICE LINE

CLAYTON HELMS

APPROVED: ASSOCIATE DIRECTOR for PATIENT CARE SERVICES/EXECUTIVE NURSE

DEBRA LEGG, RN, MSN

APPROVED: SERVICE LINE CHIEF

APPROVED: MEDICAL CENTER DIRECTOR

KARIN McGRAW, MSN, FACHE

APPROVED: ASSOCIATE DIRECTOR

BRIAN NIMMO, MS

APPROVED: CHIEF OF STAFF

JOHN D. BERRYMAN, M. D.

DRAWING TITLE:

Site Plan & Title Sheet

PROJECT TITLE:

Fourth & Sixth Floor, Ceiling Tile Replacement

DATE

3/6/2012

REV.

SCALE

NTS

DRAWING No.

GI-001

PROJECT No.

517-12-102

DRAWN BY:

JPP

CHECKED BY:

Veterans Affairs
Medical Center
200 Veterans Avenue
Beckley, WV.
25801

