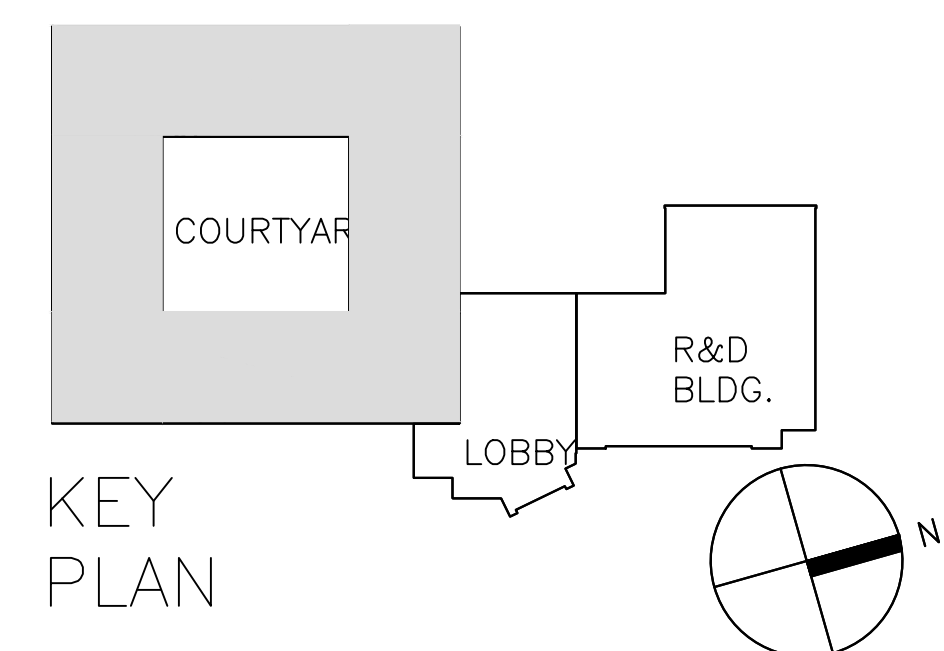

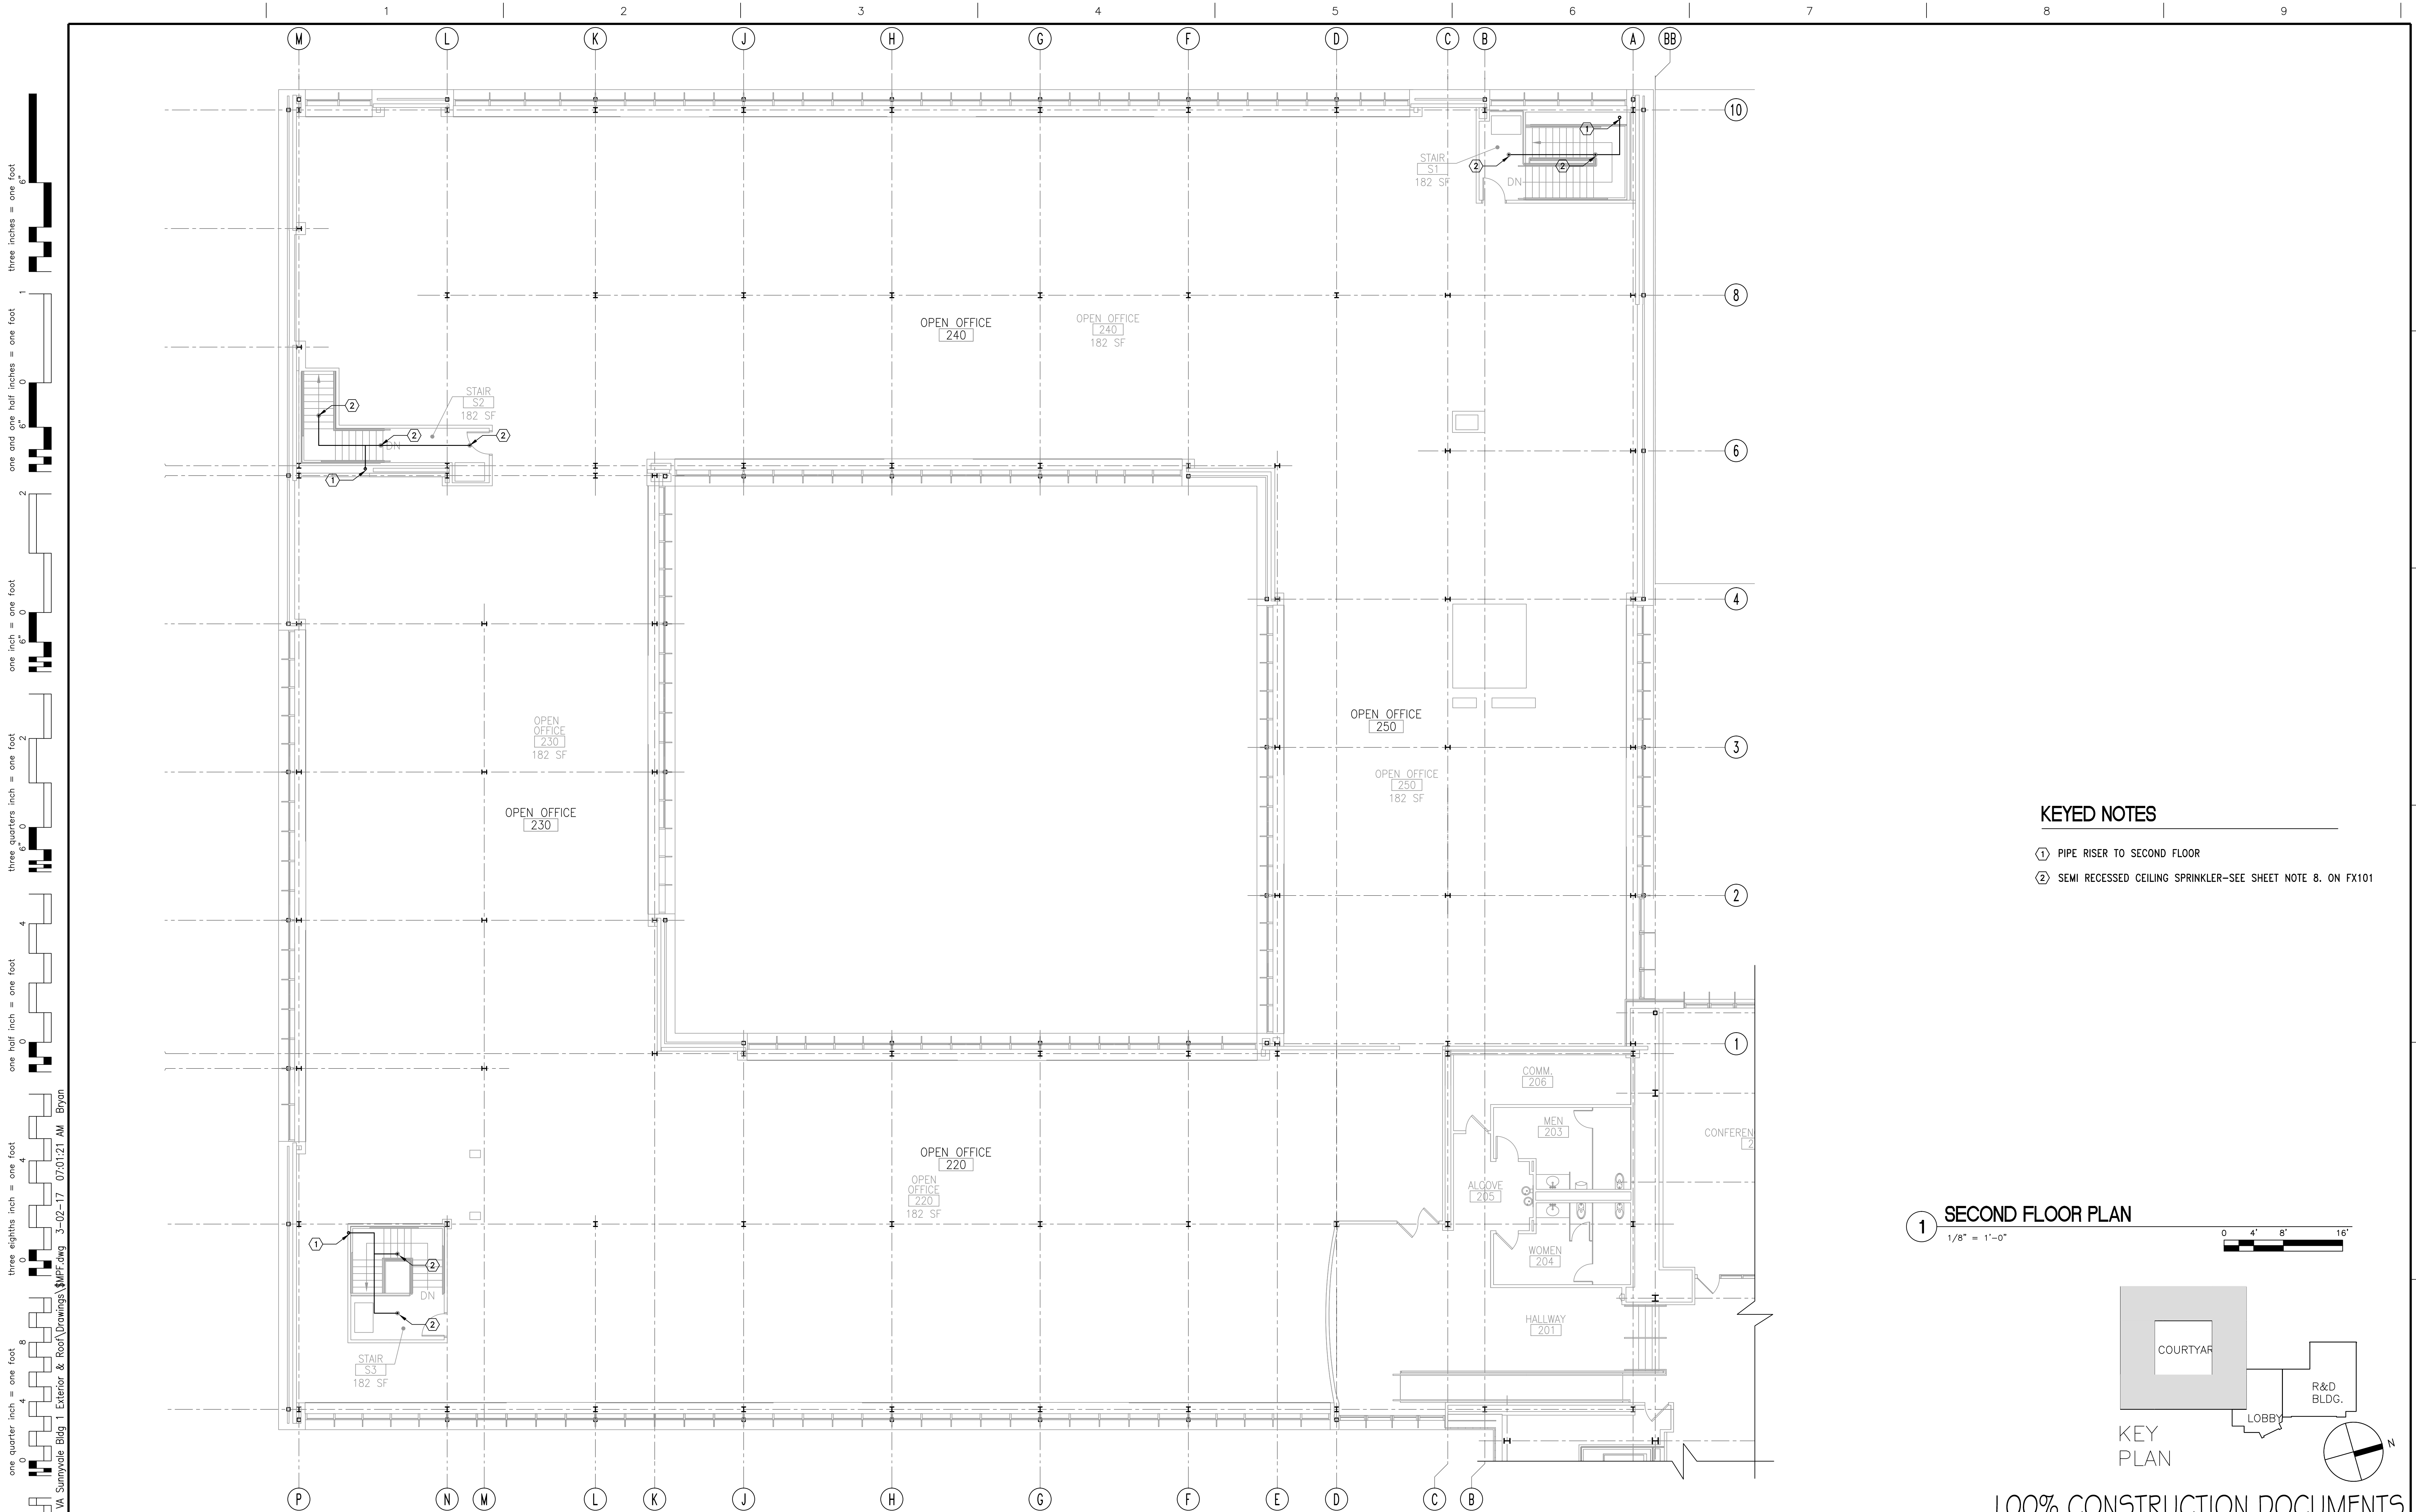


① ROOF DRAIN AND OVERFLOW DRAIN SHALL BE IN ACCORDANCE WITH SPECIFICATION SECTION 221400. JAY R SMITH 1850Y OR COR APPROVED EQUAL.

$$1/8'' = 1'-0''$$


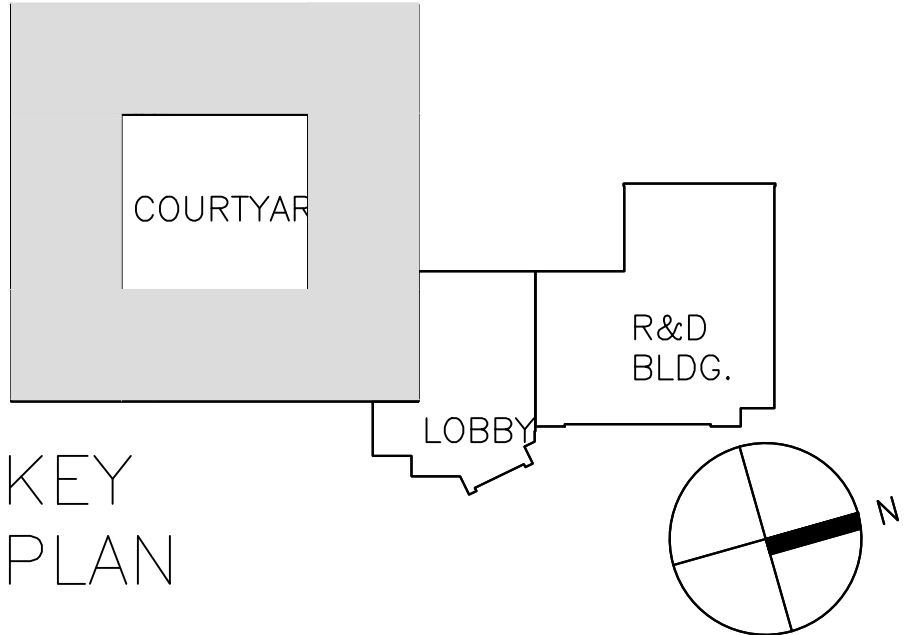
1	Project Number 640-16-121	Office of Construction and Facilities Management
	Building Number 1002	
	Drawing Number PL103	 Veterans Affairs Palo Alto Health Care System
	Dwg. of	

VA FORM 08-6231



- KEYED NOTES**
- ① PIPE RISER TO SECOND FLOOR
 - ② SEMI RECESSED CEILING SPRINKLER-SEE SHEET NOTE 8. ON FX101

1 SECOND FLOOR PLAN
1/8" = 1'-0"



100% CONSTRUCTION DOCUMENTS

<div>Revisions:</div> <table><tr><td> </td><td> </td></tr><tr><td> </td><td> </td></tr><tr><td> </td><td> </td></tr><tr><td> </td><td> </td></tr></table>									<div>CONSULTANTS:</div> <div><div><div>BRYAN BENNO BRAUER, P.E.</div><div>CONSULTING ENGINEER</div><div>PO BOX 2566, TRUCKEE, CA 96160 (530)582-8683</div><div>BRYAN@BBBRAUER.COM</div></div><div><div>ARSENIO ORTEGA, P.E.</div><div>CONSULTING ENGINEER</div><div>5 Third Street, Suite 716</div><div>San Francisco, CA 94103</div><div>(415) 546-0490 tel -0491 fax</div></div></div>	<div>Stamp and Signature</div> <div><div>REGISTERED PROFESSIONAL ENGINEER</div><div>BRYAN B. BRAUER</div><div>No. 18550</div><div>Exp. 9-30-2018</div><div>MECHANICAL</div><div>STATE OF CALIFORNIA</div></div>	<div>ARCHITECT/ENGINEERS:</div> <div><div><div>KPA</div><div>THE KPA GROUP</div></div><div><div>ENGINEERS ARCHITECTS</div><div>6700 KOLL CENTER PARKWAY SUITE 125</div><div>PLEASANTON, CALIFORNIA 94566</div><div>Tel. 925.223.8217 www.thekpagroup.com</div><div>©THE KPA GROUP 2017</div><div>KPA Project No. 630.00</div></div></div>	<div>Drawing Title</div> <div>SECOND FLOOR FIRE SPRINKLER PLAN</div> <div>Approved Project Director</div> <div>-</div> <div>VAPAHCS PLANNING AND ENGINEERING</div>	<div>Project Title</div> <div>REPLACE SUNNYVALE BLDG. 1 EXTERIOR AND ROOF</div> <div>Location</div> <div>1080 INNOVATION WAY, SUNNYVALE, CA 94089</div> <div>Date</div> <div>00/00/2016</div> <div>Checked</div> <div>PWP</div> <div>Drawn</div> <div>KPA TEAM</div>	<div>Project Number</div> <div>640-16-121</div> <div>Building Number</div> <div>1002</div> <div>Drawing Number</div> <div>FX102</div> <div>Dwg. of</div> <div> </div>	<div>Office of Construction and Facilities Management</div> <div><div>VAPAHCS</div><div>VA Palo Alto Health Care System</div></div>