



three inches = one foot  
one and one half inches = one foot  
one inch = one foot  
three quarters inch = one foot  
one half inch = one foot  
three eighths inch = one foot  
one quarter inch = one foot  
one eighth inch = one foot

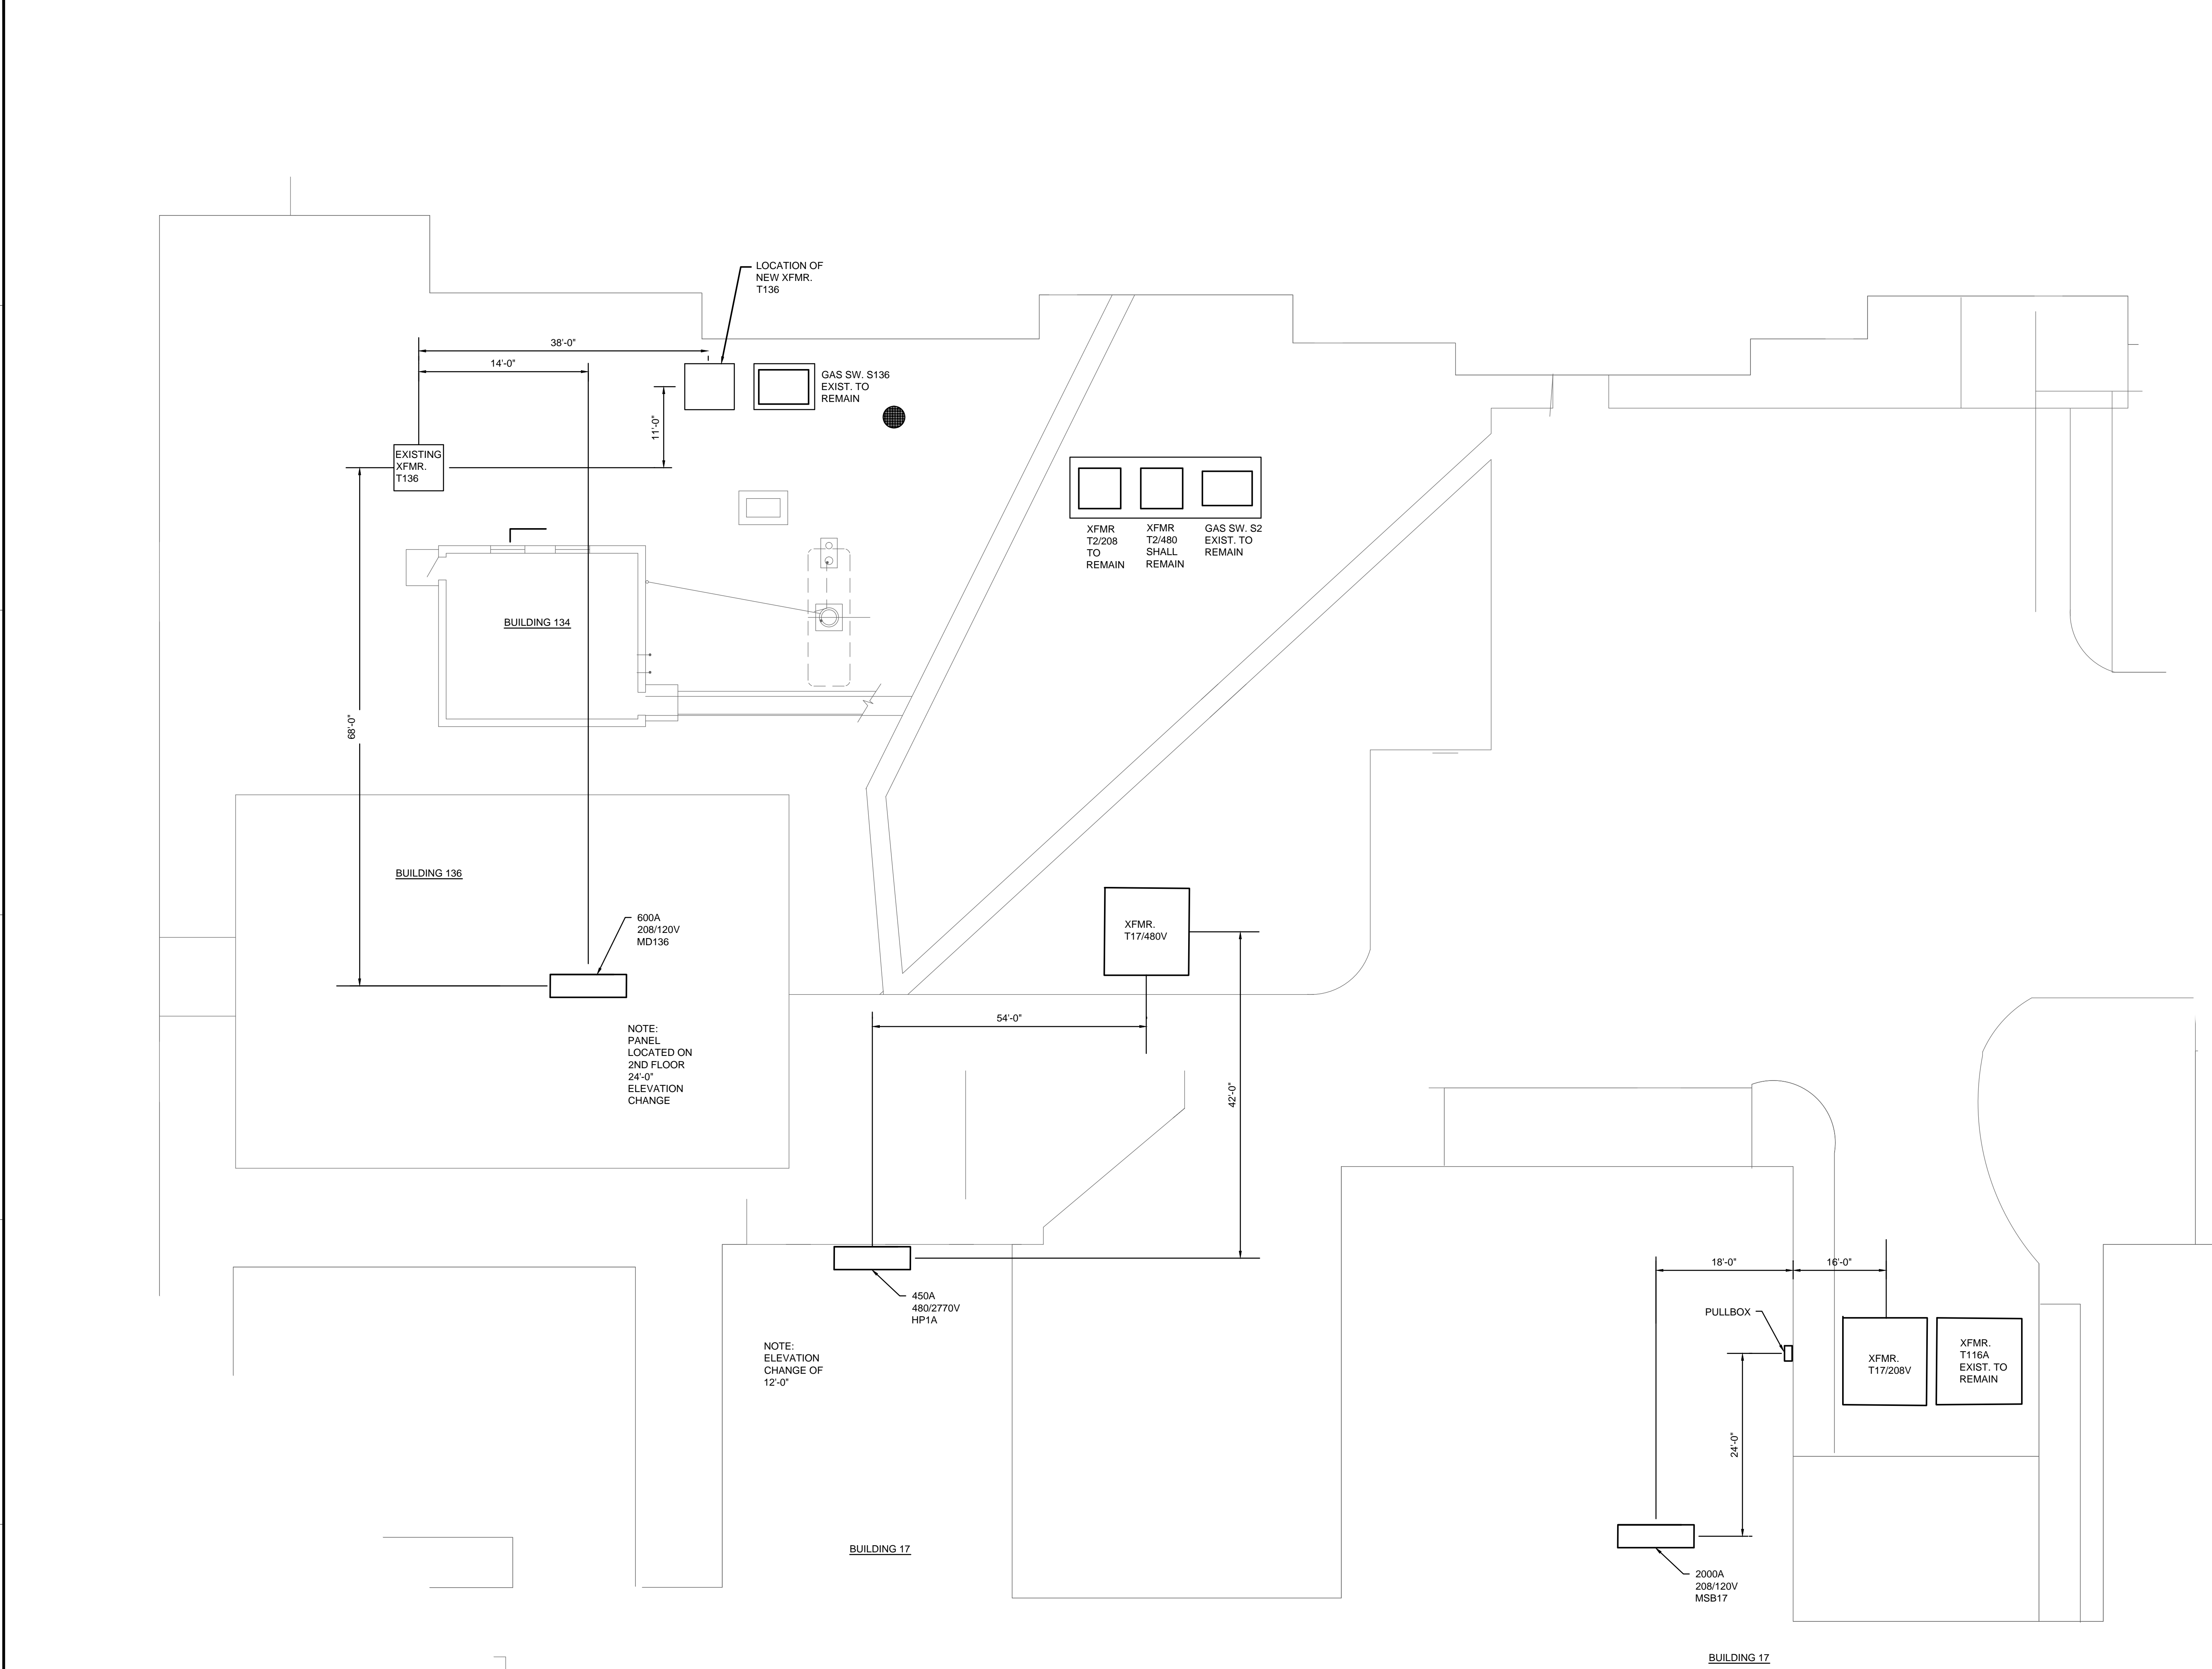

 
ALL DIMENSIONS ARE BASED ON CENTERLINES OF EQUIPMENT AND ARE APPROXIMATE. THE EQUIPMENT AND CONDUIT SHOWN ON PLANS ARE DIAGRAMMATIC. EC SHALL FIELD VERIFY PRIOR TO COMMENCEMENT OF WORK.

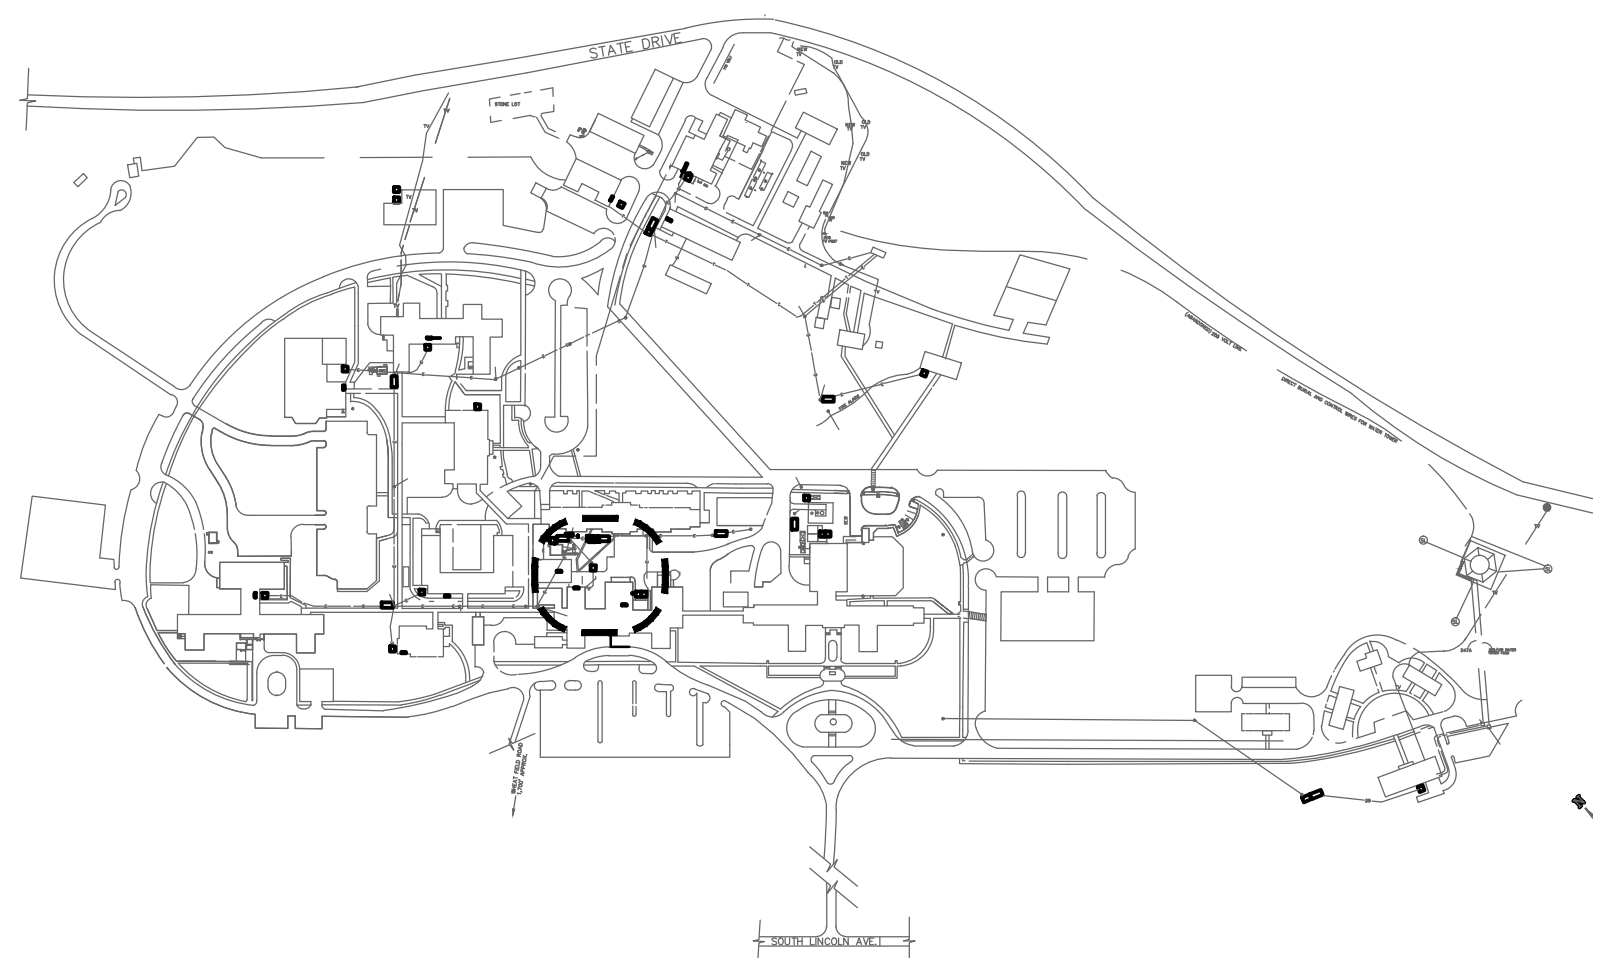

1 PARTIAL SITE PLAN  
SCALE: NTS

KEY PLAN  
NTS

CONSTRUCTION DOCUMENTS | 00%

		CONSULTANTS:				ARCHITECT/ENGINEERS:		Drawing Title SECONDARY DISTRIBUTION PLANS		Project Title REPLACE OIL SWITCH		Project Number # 595-11-134		Office of Construction and Facilities Management			
						<div>A E works</div> <div>101 W. STATION SQUARE DR. GATEHOUSE STE 401 PITTSBURGH, PENNSYLVANIA 15219-1196 PHONE: 412.287.7333 FAX: 412.287.7334 WWW.AE-WORKS.COM</div>				Building Number --		Drawing Number E15					
								Approved Project Director		Location 1700 South Lincoln Ave - Lebanon, PA 17042		Date 05/02/2012				Checked SK	
0 - ORIGINAL ISSUE		6/8/12														 Department of Veterans Affairs	
Revisions		Date															