


ING FLOOR PLAN
1/8" = 1'-0"

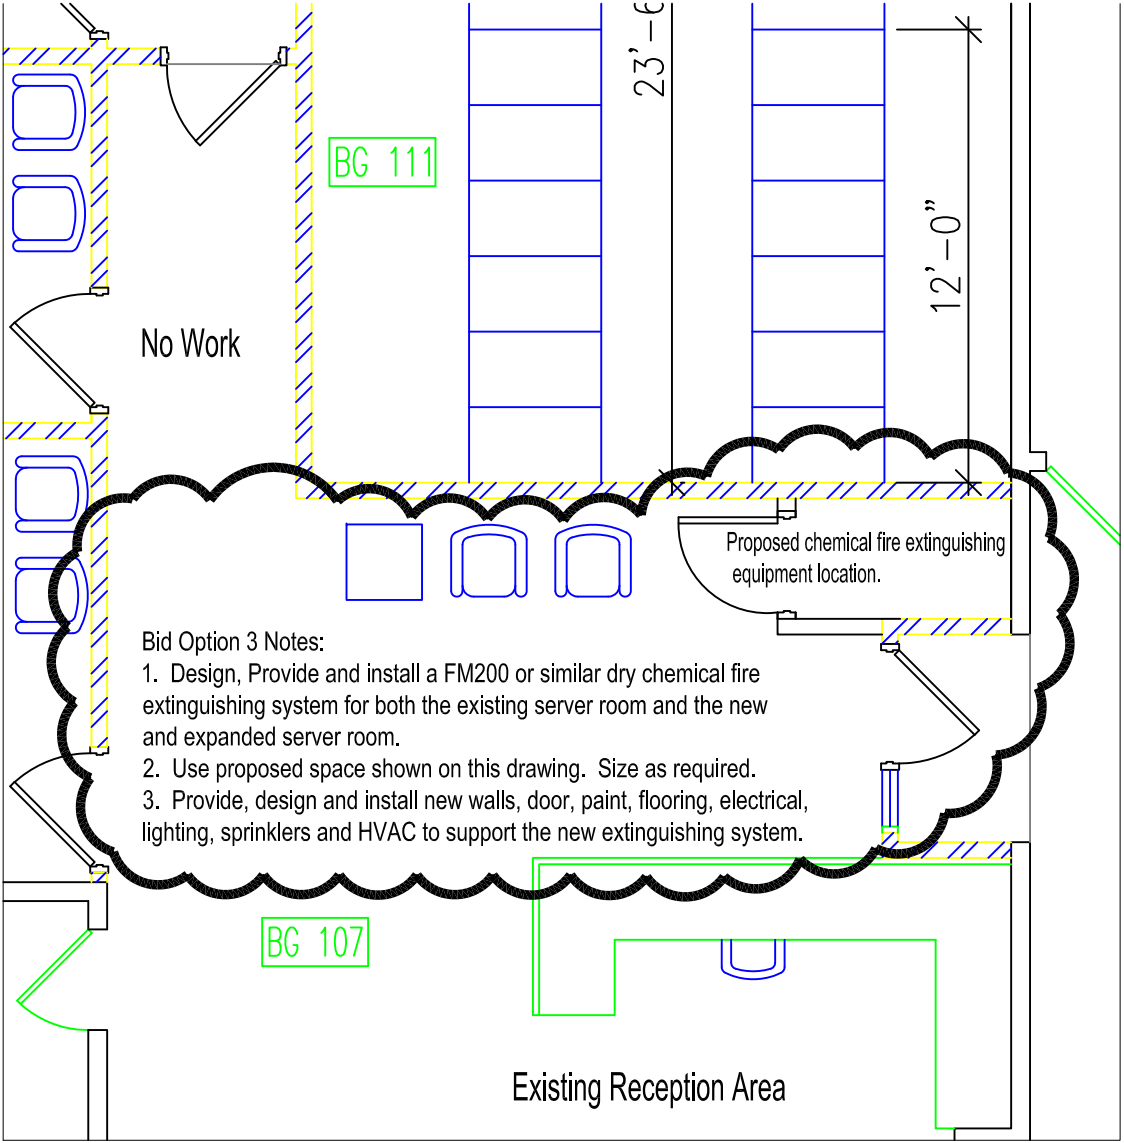

Bid Option 3 Notes:
1. Design, Provide and install a FM200 or similar dry chemical fire extinguishing system for both the existing server room and the new and expanded server room.
2. Use proposed space shown on this drawing. Size as required.
3. Provide, design and install new walls, door, paint, flooring, electrical, lighting, sprinklers and HVAC to support the new extinguishing system.

PROPOSED FLOOR PLAN
SCALE: No Scale

	ARCHITECT:	<p>HEREBY CERTIFY THAT THIS PLAN, SPECIFICATION OR REPORT WAS PREPARED BY ME OR UNDER MY DIRECT SUPERVISION AND THAT I AM A DULY REGISTERED ARCHITECT UNDER THE LAWS OF THE STATE OF MINNESOTA REGISTRATION NUMBER: 14707</p> <p>Drawing Scale SEE DRAWING</p> <p>Plot Scale</p>	<p>Drawing Title</p> <p>DRY CHEMICAL FIRE FIRE EXTINGUISHING</p> <p>Approved: See Sheet C1</p>	<p>Project Title</p> <p>EXPAND BIOMED INSTRUMENT RM</p>	<p>Project Number</p> <p>618-12-301</p>	<p>Office of Facilities Management</p>	
				<p>Location</p> <p>VA MEDICAL CENTER, MINNEAPOLIS, MN</p>	<p>Building Number</p> <p>70</p>		<p>Drawing Number</p> <p>Option 3</p>
				<p>Date</p> <p>06.6.12</p>	<p>Checked</p> <p>MAA</p>	<p>Drawn</p> <p>MAA</p>	<p>Dwg. 1 of 1</p>

FULLY SPRINKLERED

3

4

5

6

7

8

9