



75 INTERSTITIAL SPACE FOURTH FLOOR AREA A
SCALE 1/8" = 1'-0"

BY
DATE
1/8" = 1'-0"

NOTES
1. ON-OFF P.B. SW. TO CONTROL L.T.S. CONTACTOR; REFER TO
DRAWING 1-E-6 FOR LIGHTING CONTROL DIAGRAM.
2. REFER TO DWG. 1-E-6 FOR LIGHTING FIXTURE HANGER DETAILS.
3. ALL LIGHTING FIXTURES ARE TYPE "E-4" UNLESS
OTHER WISE NOTED.
4. REFER TO DWG. 1-E-6 FOR PANEL, CABINET, AND
EQUIPMENT MOUNTING.

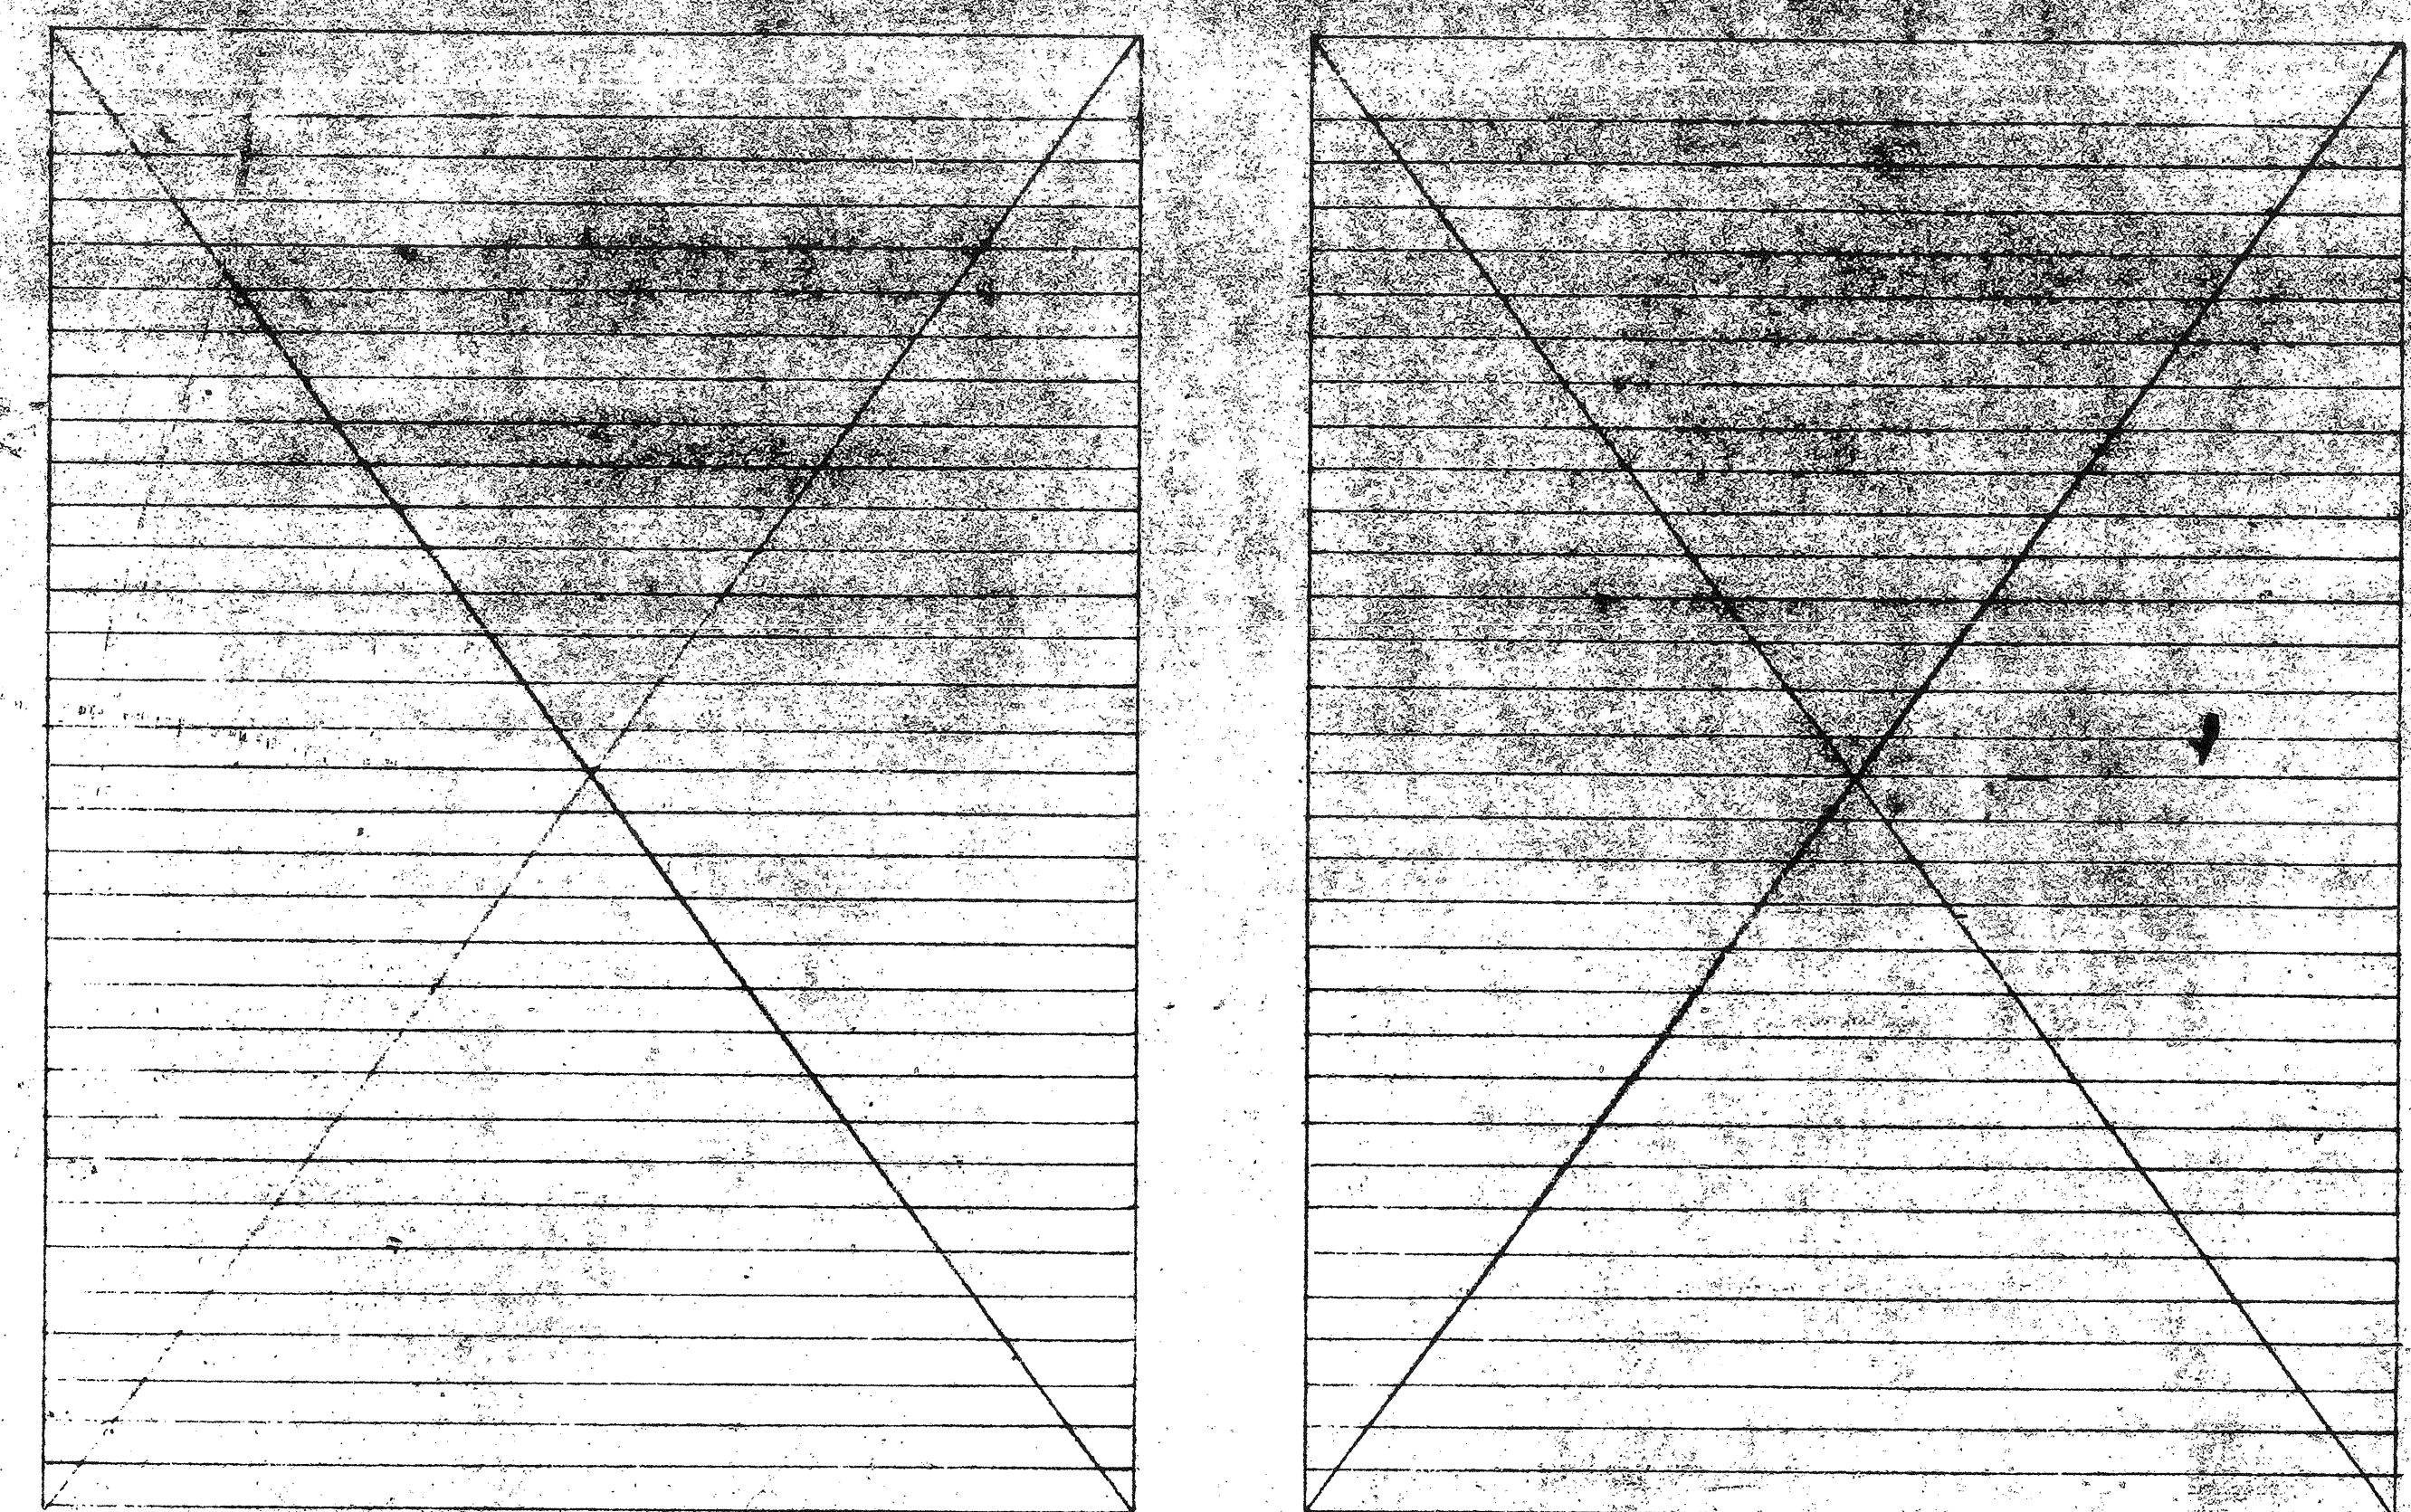

AS-BUILT DRAWING
OCT 9 1973

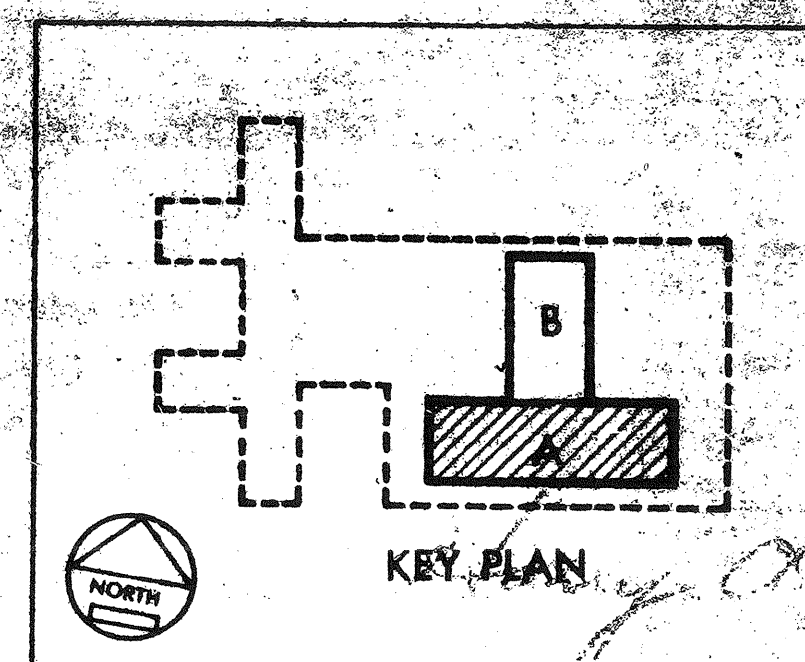

INTERST SPACE 4TH FLR. AREA A BUILDING NO. 1 SCALE 1/8" = 1'-0"	
760 BED M. S. & N. AND PSYCHIATRIC HOSPITAL	
VETERANS ADMINISTRATION SAN ANTONIO, TEXAS	
DESIGNED BY G. B. B. & R. A. R.	REVISIONS
DRAWN BY G. B. B. & R. A. R.	
CHECKED BY G. B. B. & R. A. R.	
APPROVED BY G. B. B. & R. A. R.	
GOLEMON & ROLFE ARCHITECTS SAN ANTONIO ASSOCIATED ARCHITECTS ARCHITECTS & ENGINEERS EDWARD R. GONDECK ARCHITECT WILLIAM E. PARRISH ARCHITECT ADAMS & ADAMS ARCHITECTS	
DRAWING NUMBER 1-E-75	
Sheet 72 of 164	
Proj. No. 42-5363	