





SHEET NOTES

- CONTRACTOR SHALL FURNISH & INSTALL ONE (1) 200A/1P, 277V CIRCUIT BREAKERS IN AVAILABLE SPACE TO MATCH EXISTING (CMT. #15). PROVIDE ALL NECESSARY MOUNTING HARDWARE AS REQUIRED.
- CONTRACTOR SHALL FURNISH & INSTALL ONE (1) 200A/1P, 277V CIRCUIT BREAKERS IN AVAILABLE SPACE TO MATCH EXISTING (CMT. #15). PROVIDE ALL NECESSARY MOUNTING HARDWARE AS REQUIRED.
- CONTRACTOR SHALL VERIFY EXISTING LIGHTING CONTROL PANEL (WAIT STOPPER) AND PANEL MANUFACTURER/SUPPLIER TO BE IDENTIFIED. EXISTING LIGHTING CONTROL PANEL AS REQUIRED TO INCORPORATE NEW ZONE (CIRCUIT) AS SHOWN ON SHEET ES1-3. CONTRACTOR SHALL PROVIDE ALL NECESSARY ACCESSORIES, CONDUIT & WIRING AS REQUIRED.

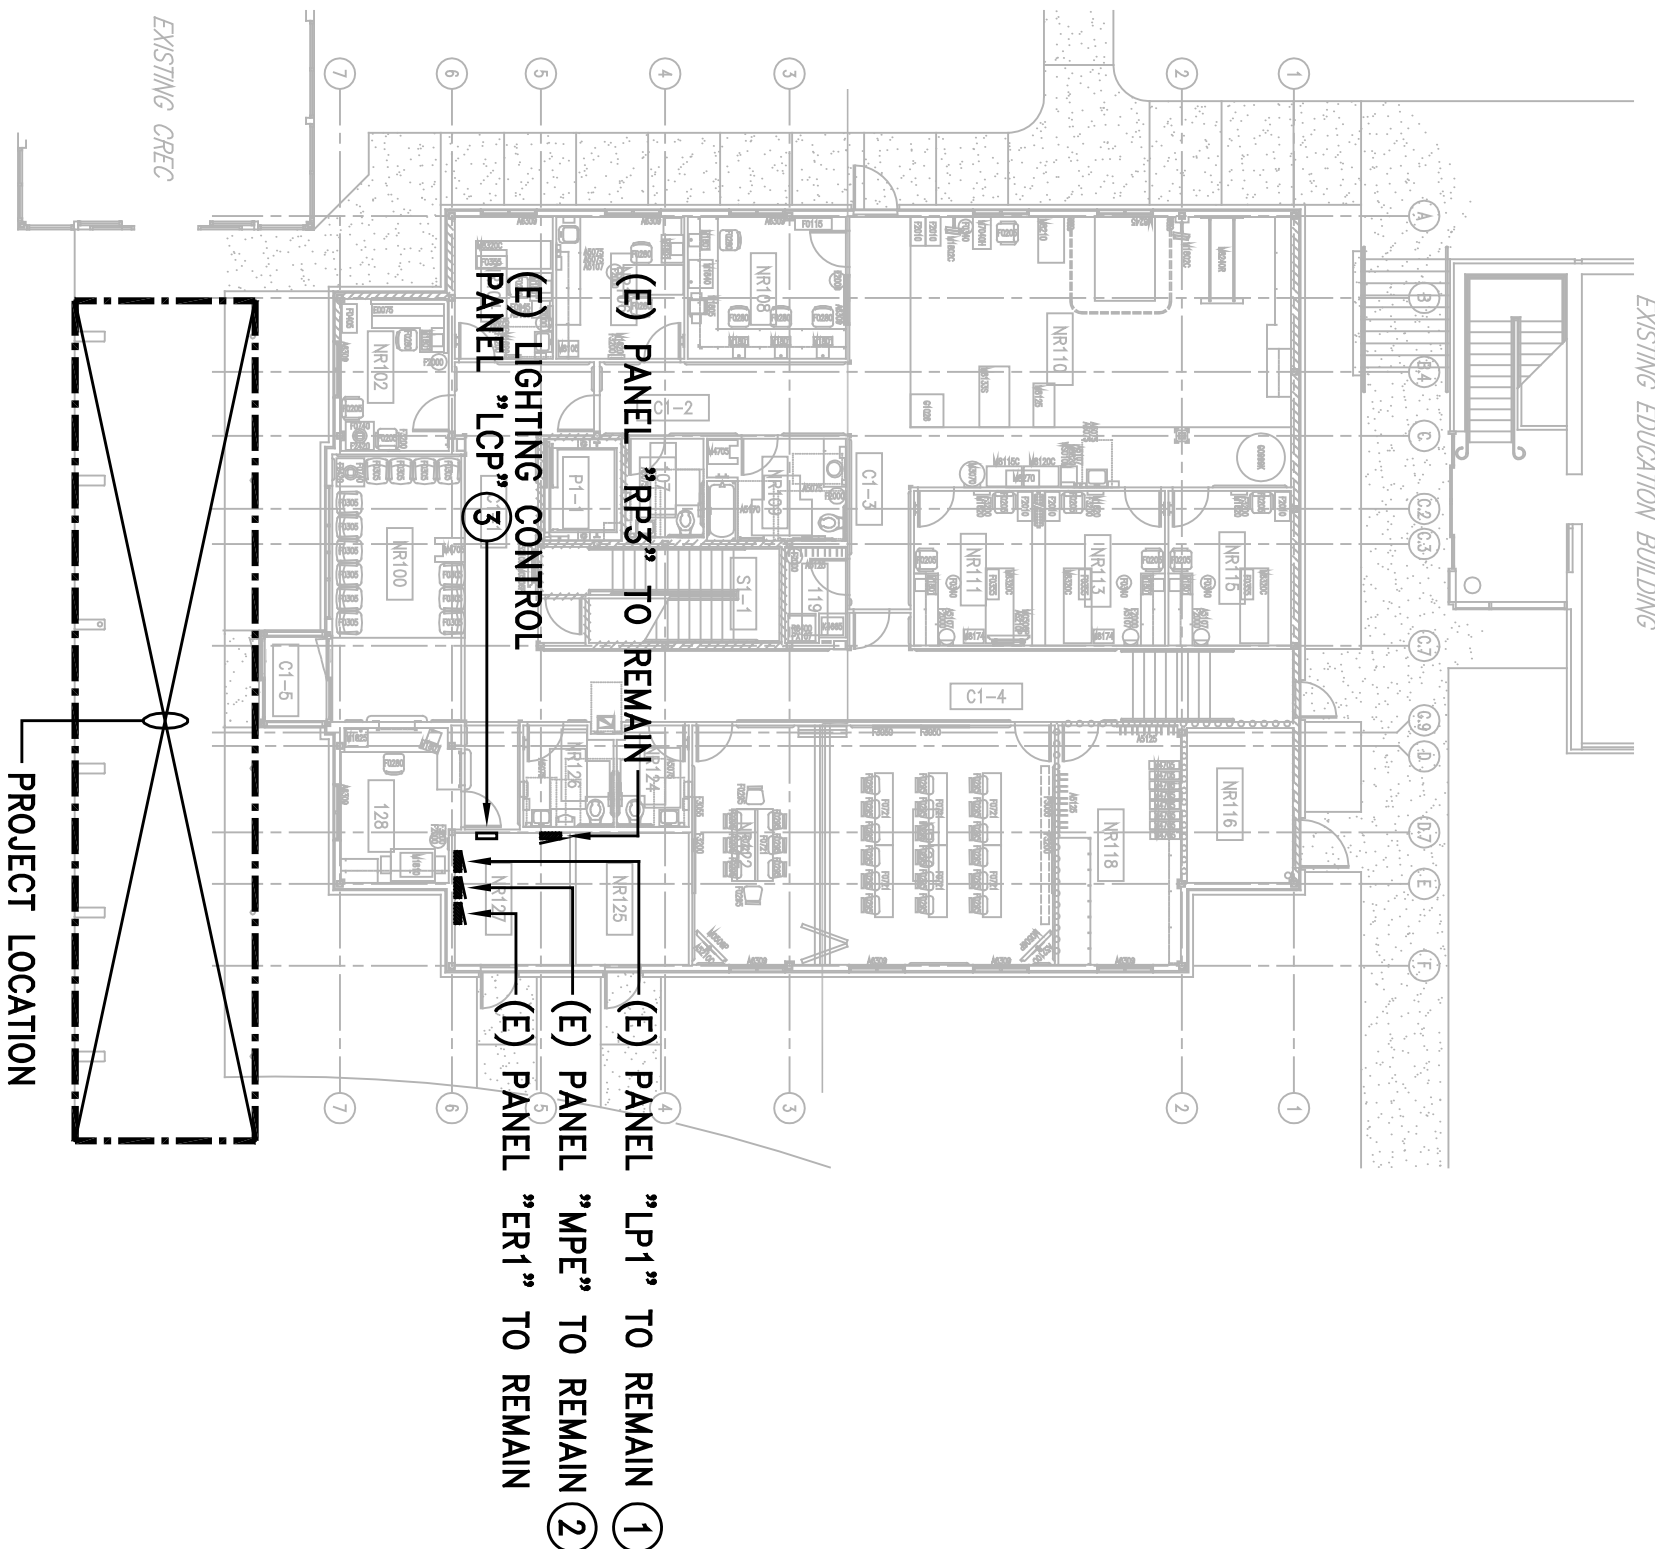

2 BUILDING 22 - ELECTRICAL PLAN

SCALE: 1/16"=1'-0"

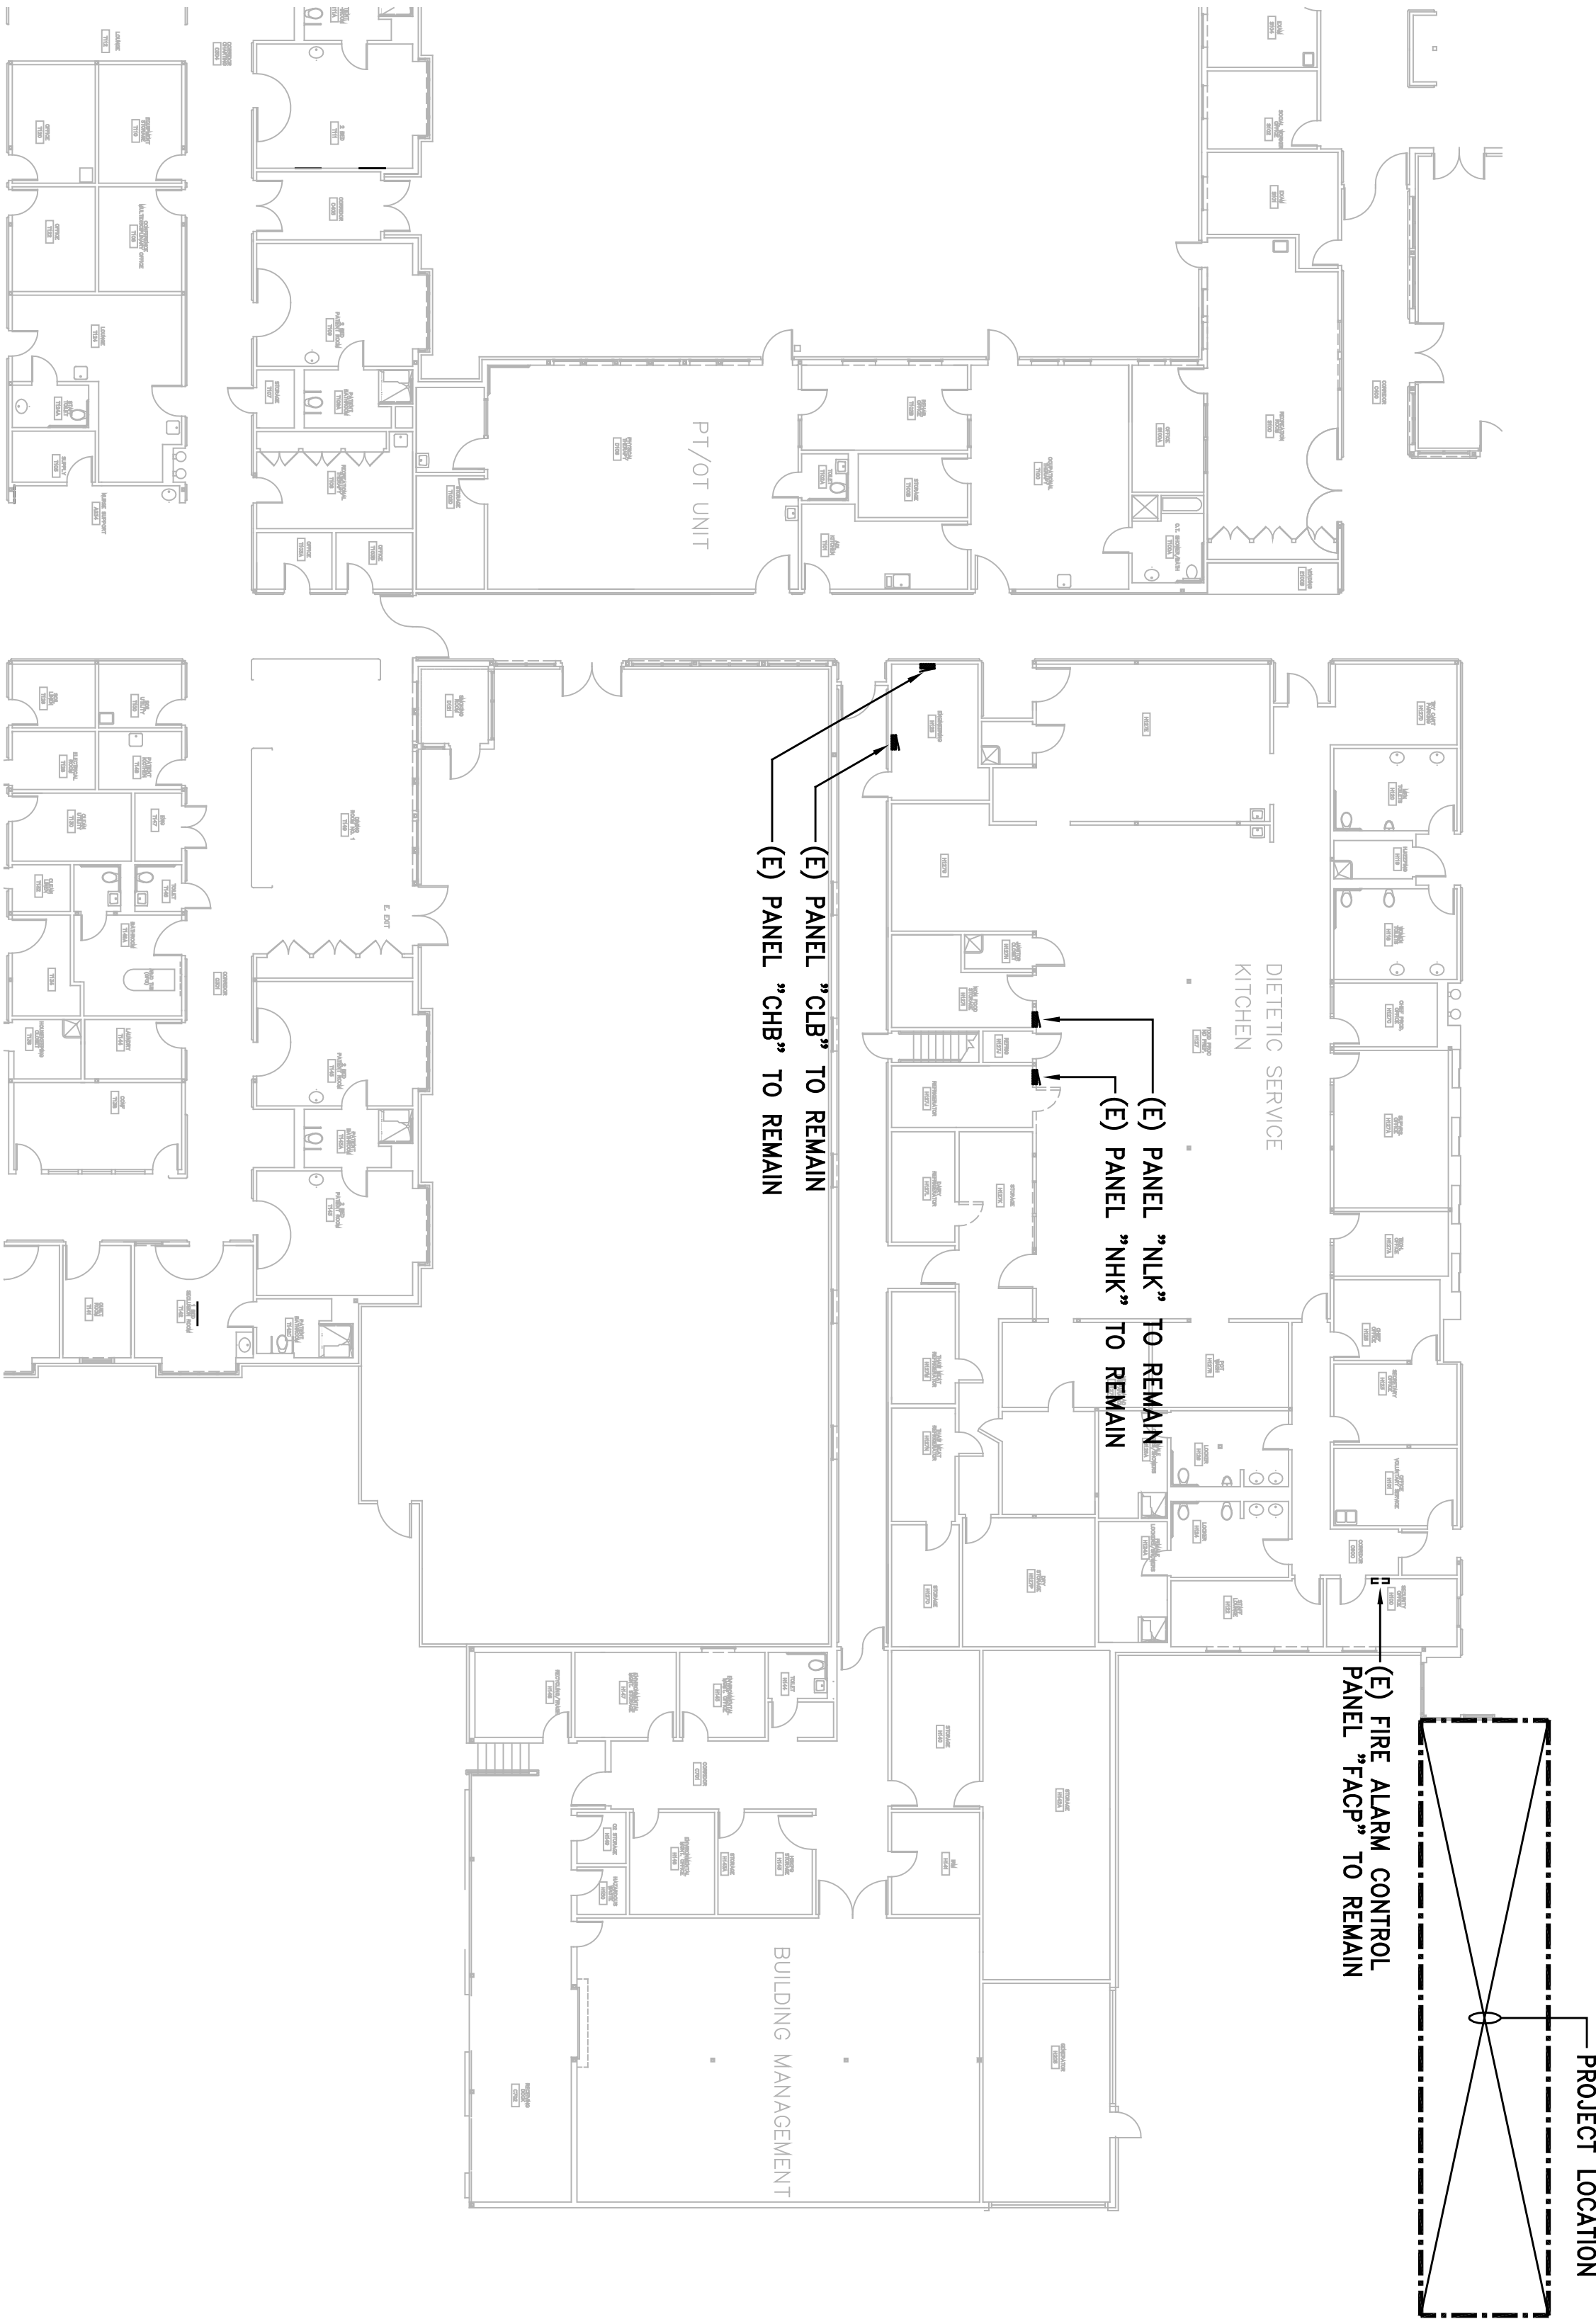


1 BUILDING 20 - ELECTRICAL PLAN

SCALE: 1/16"=1'-0"

Revisions:	Date
CONSTRUCTION DOCUMENTS BID SET	06.10.2011

CONSULTANTS:	STRUCTURAL	MECHANICAL & PLUMBING	ELECTRICAL
	E&A ENGINEERS 20906 E. VALLEY BLVD SUITE 110 WALNUT, CA 91782-2705 TEL: (909) 598-8565 FAX: (909) 598-8565	S&J ENGINEERS 300 FRANK OGDEN PLAZA, SUITE 308, OAKLAND, CA 94612 TEL: (510) 832-1597 FAX: (510) 832-1597	FVA INC. 330 FRANKLIN STREET, OAKLAND, CA 94612 TEL: (510) 765-7033 FAX: (510) 765-7033

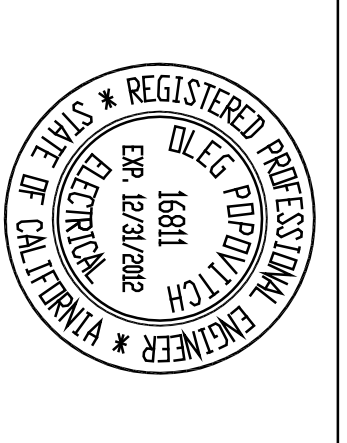

ARCHITECT/ENGINEERS:	WE architecture + interiors
	239 9TH STREET, Suite 201 SAN FRANCISCO, CA 94103 TEL: (415) 682-7236 FAX: (415) 682-7236 www.michaelmartinez.com

Drawing Title	Project Title	Project Number	Office of Facilities Management Department of Veterans Affairs
BUILDING 20 ELECTRICAL PLAN & BUILDING 22 ELECTRICAL PLAN	ENTRANCE VESTIBULES AND COVERED WALKWAY AT BLDGS. 20 AND 22	612-10-066	
Approved: Project Director	Location VANCHCS - MARTINEZ	Building Number BLDGS. 20 & 22	
Date JUNE 10, 2011	Checked ECM/F	Drawn FVA TEAM	Drawing Number ES1-4