


VA FORM 08-6231 PLOTTED: Thursday, April 20, 2017 1:15:50 PM


three eighths inch = one foot  
one eighth inch = one foot  
one quarter inch = one foot  
one half inch = one foot  
three quarters inch = one foot  
one inch = one foot  
one and one half inches = one foot  
two inches = one foot  
three inches = one foot  
four inches = one foot  
five inches = one foot  
six inches = one foot  
seven inches = one foot  
eight inches = one foot  
nine inches = one foot  
ten inches = one foot  
eleven inches = one foot  
twelve inches = one foot  
thirteen inches = one foot  
fourteen inches = one foot  
fifteen inches = one foot  
sixteen inches = one foot  
seventeen inches = one foot  
eighteen inches = one foot  
nineteen inches = one foot  
twenty inches = one foot  
twenty one inches = one foot  
twenty two inches = one foot  
twenty three inches = one foot  
twenty four inches = one foot  
twenty five inches = one foot  
twenty six inches = one foot  
twenty seven inches = one foot  
twenty eight inches = one foot  
twenty nine inches = one foot  
thirty inches = one foot  
thirty one inches = one foot  
thirty two inches = one foot  
thirty three inches = one foot  
thirty four inches = one foot  
thirty five inches = one foot  
thirty six inches = one foot  
thirty seven inches = one foot  
thirty eight inches = one foot  
thirty nine inches = one foot  
forty inches = one foot  
forty one inches = one foot  
forty two inches = one foot  
forty three inches = one foot  
forty four inches = one foot  
forty five inches = one foot  
forty six inches = one foot  
forty seven inches = one foot  
forty eight inches = one foot  
forty nine inches = one foot  
fifty inches = one foot  
fifty one inches = one foot  
fifty two inches = one foot  
fifty three inches = one foot  
fifty four inches = one foot  
fifty five inches = one foot  
fifty six inches = one foot  
fifty seven inches = one foot  
fifty eight inches = one foot  
fifty nine inches = one foot  
sixty inches = one foot  
sixty one inches = one foot  
sixty two inches = one foot  
sixty three inches = one foot  
sixty four inches = one foot  
sixty five inches = one foot  
sixty six inches = one foot  
sixty seven inches = one foot  
sixty eight inches = one foot  
sixty nine inches = one foot  
seventy inches = one foot  
seventy one inches = one foot  
seventy two inches = one foot  
seventy three inches = one foot  
seventy four inches = one foot  
seventy five inches = one foot  
seventy six inches = one foot  
seventy seven inches = one foot  
seventy eight inches = one foot  
seventy nine inches = one foot  
eighty inches = one foot  
eighty one inches = one foot  
eighty two inches = one foot  
eighty three inches = one foot  
eighty four inches = one foot  
eighty five inches = one foot  
eighty six inches = one foot  
eighty seven inches = one foot  
eighty eight inches = one foot  
eighty nine inches = one foot  
ninety inches = one foot  
ninety one inches = one foot  
ninety two inches = one foot  
ninety three inches = one foot  
ninety four inches = one foot  
ninety five inches = one foot  
ninety six inches = one foot  
ninety seven inches = one foot  
ninety eight inches = one foot  
ninety nine inches = one foot  
one hundred inches = one foot

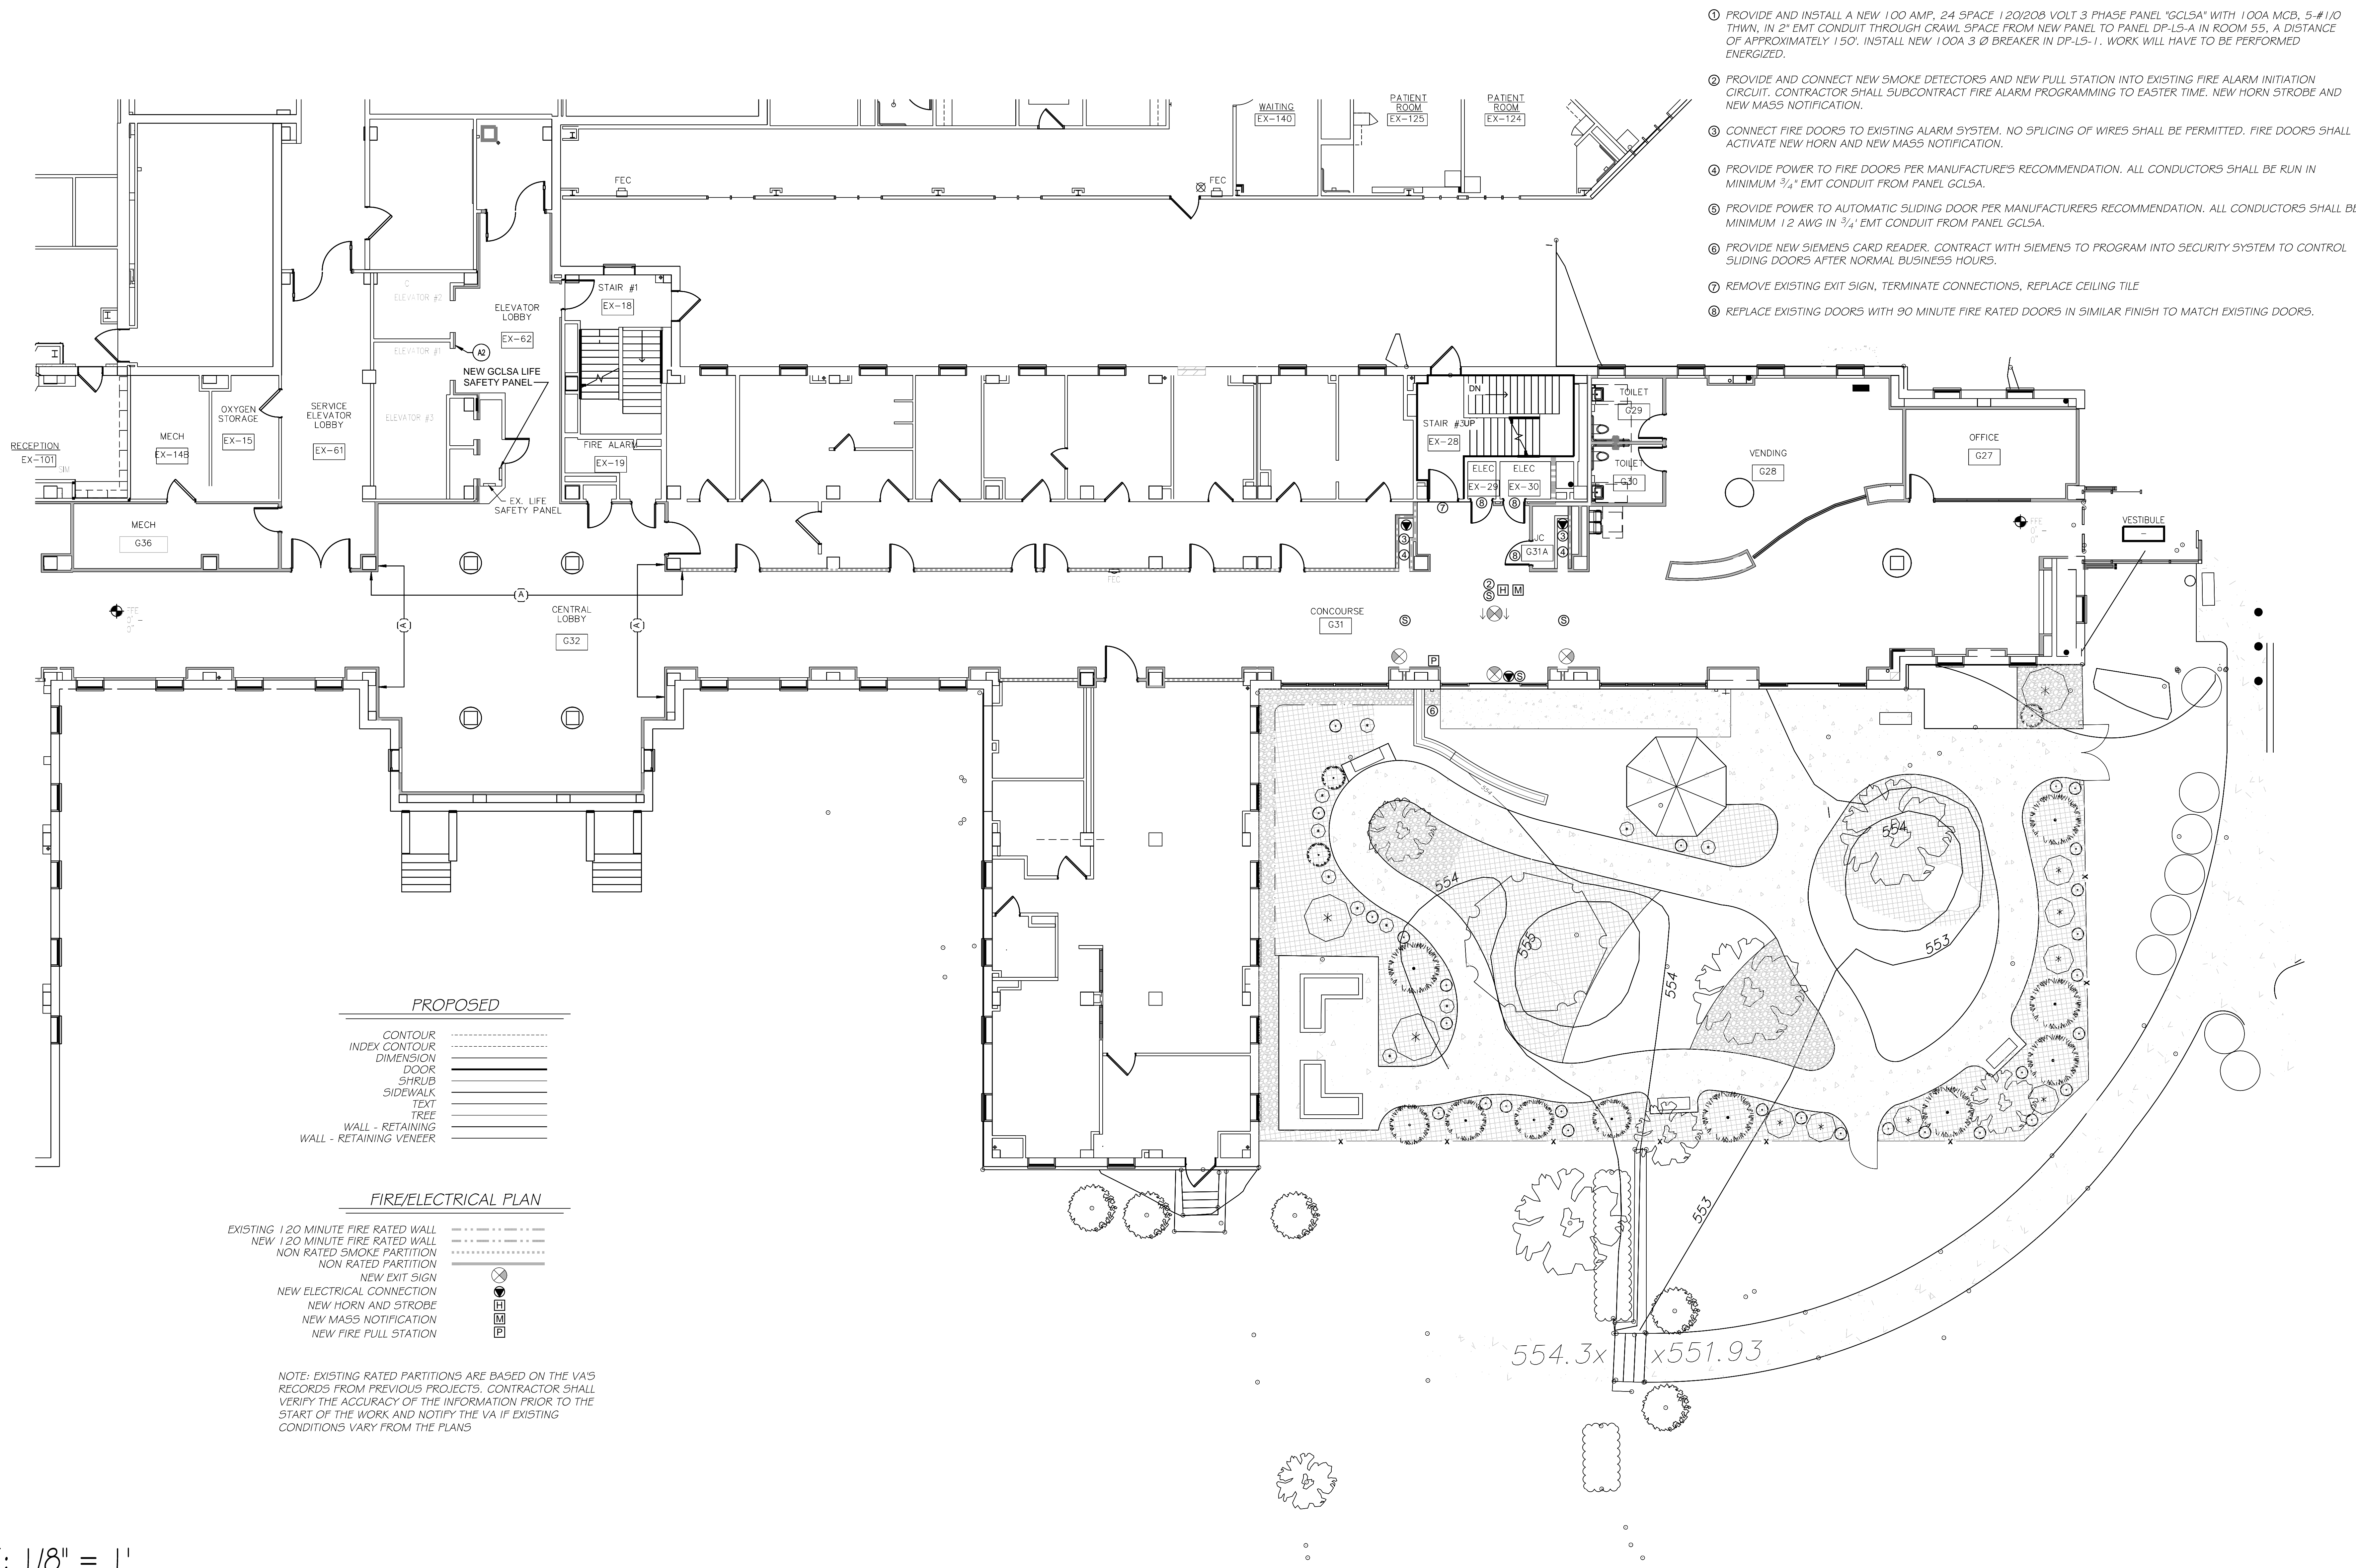

CONSULTANTS:		ARCHITECT/ENGINEERS:		Drawing Title FIRE/ELECTRICAL PLAN	Project Title BUILDING 1 LIFE SAFETY IMPROVEMENTS	Project Number 595-17-103	Office of Construction and Facilities Management	
				Approved Project Director THADDUS KOCUBA CHIEF ENGINEER VAPAFCS PLANNING AND ENGINEERING	Location LEBANON VAMC LEBANON, PA	Building Number 001		
Revisions:		Date		Date OCTOBER 12, 2016	Checked DCS	Drawn MPT	Drawing Number F1	
							Dwg 10 of 13	






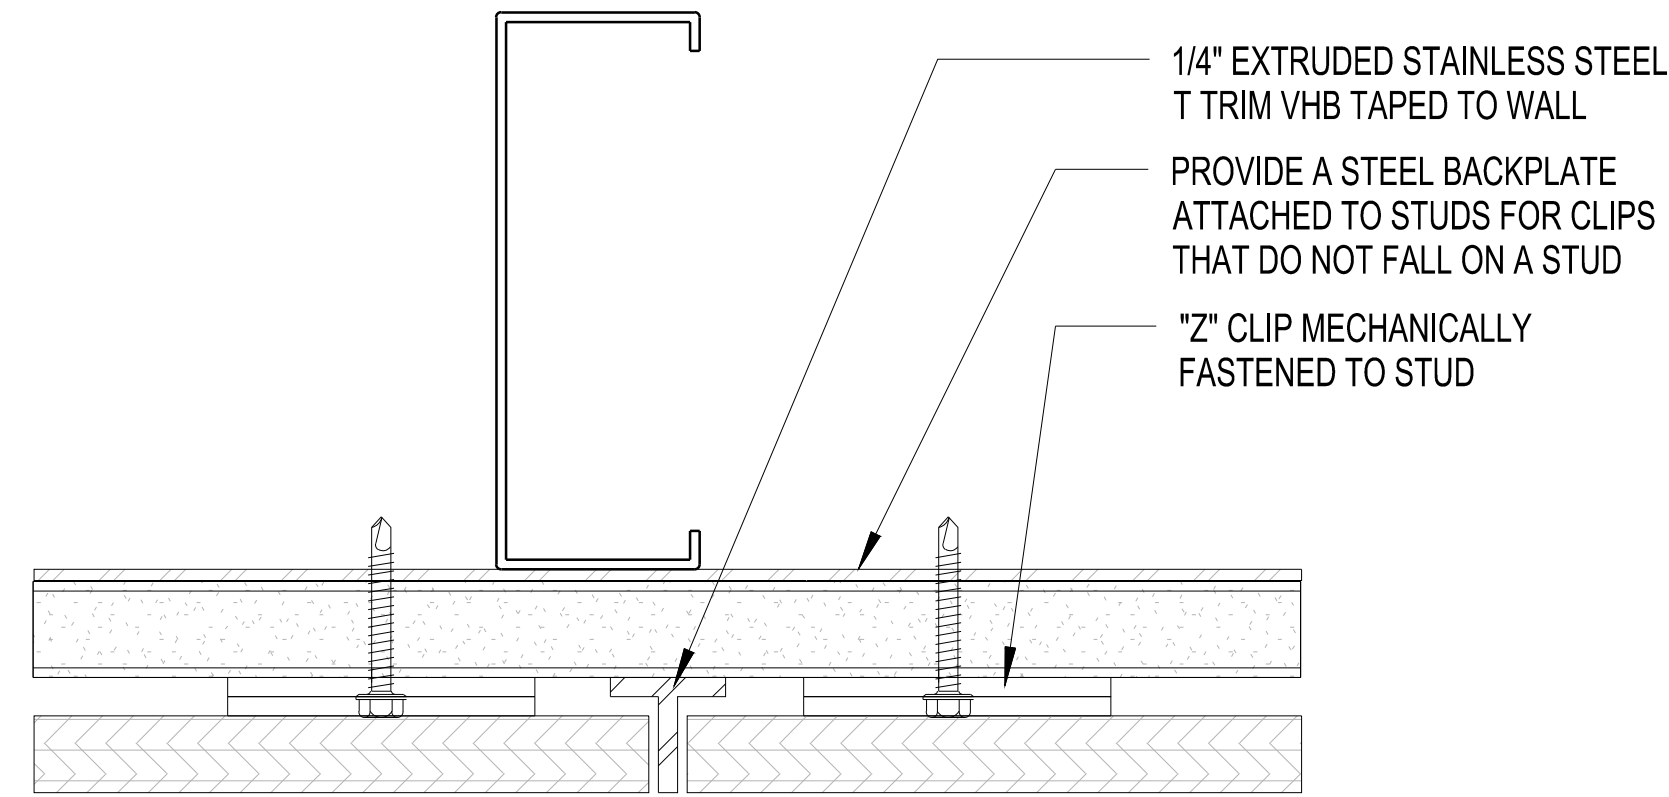


WOOD VENEER PANEL WALL DETAIL

NOT TO SCALE

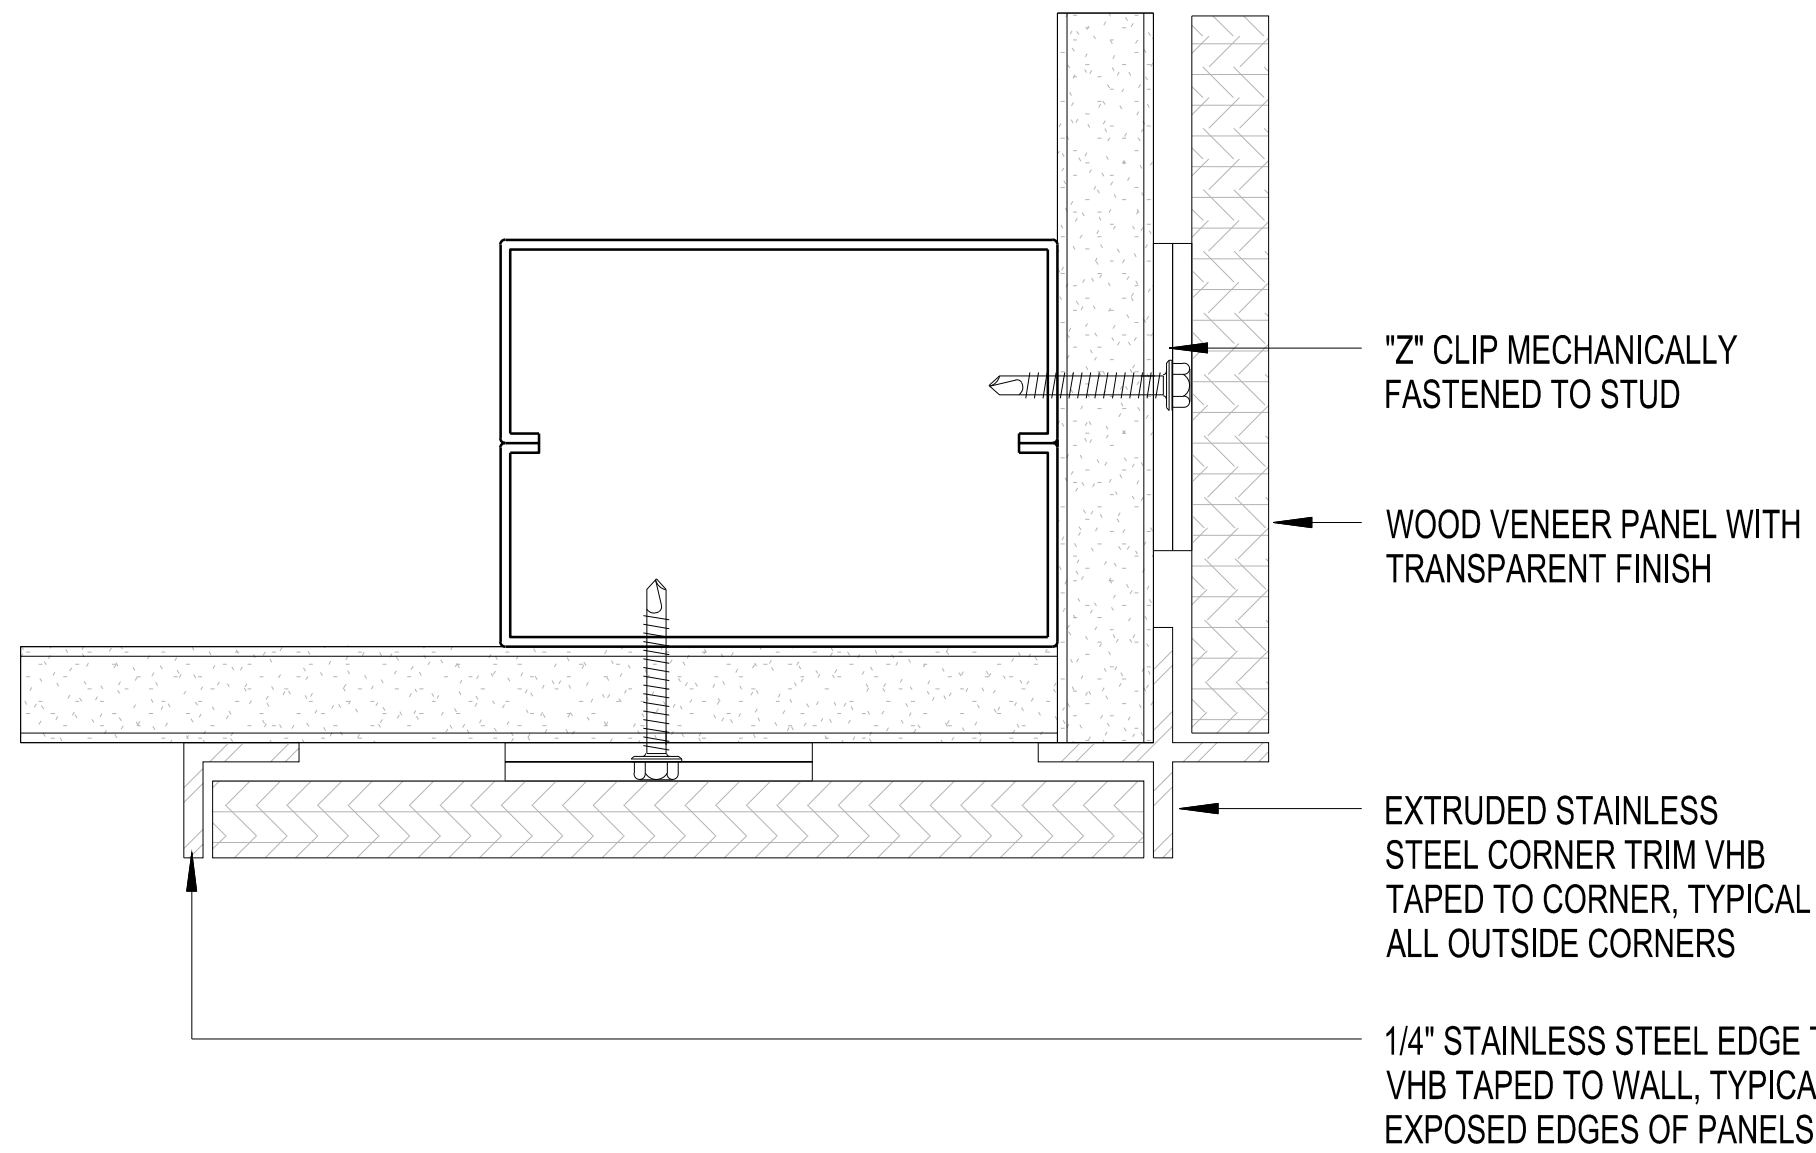


WOOD VENEER PANNEL CORNER DETAIL

NOT TO SCALE

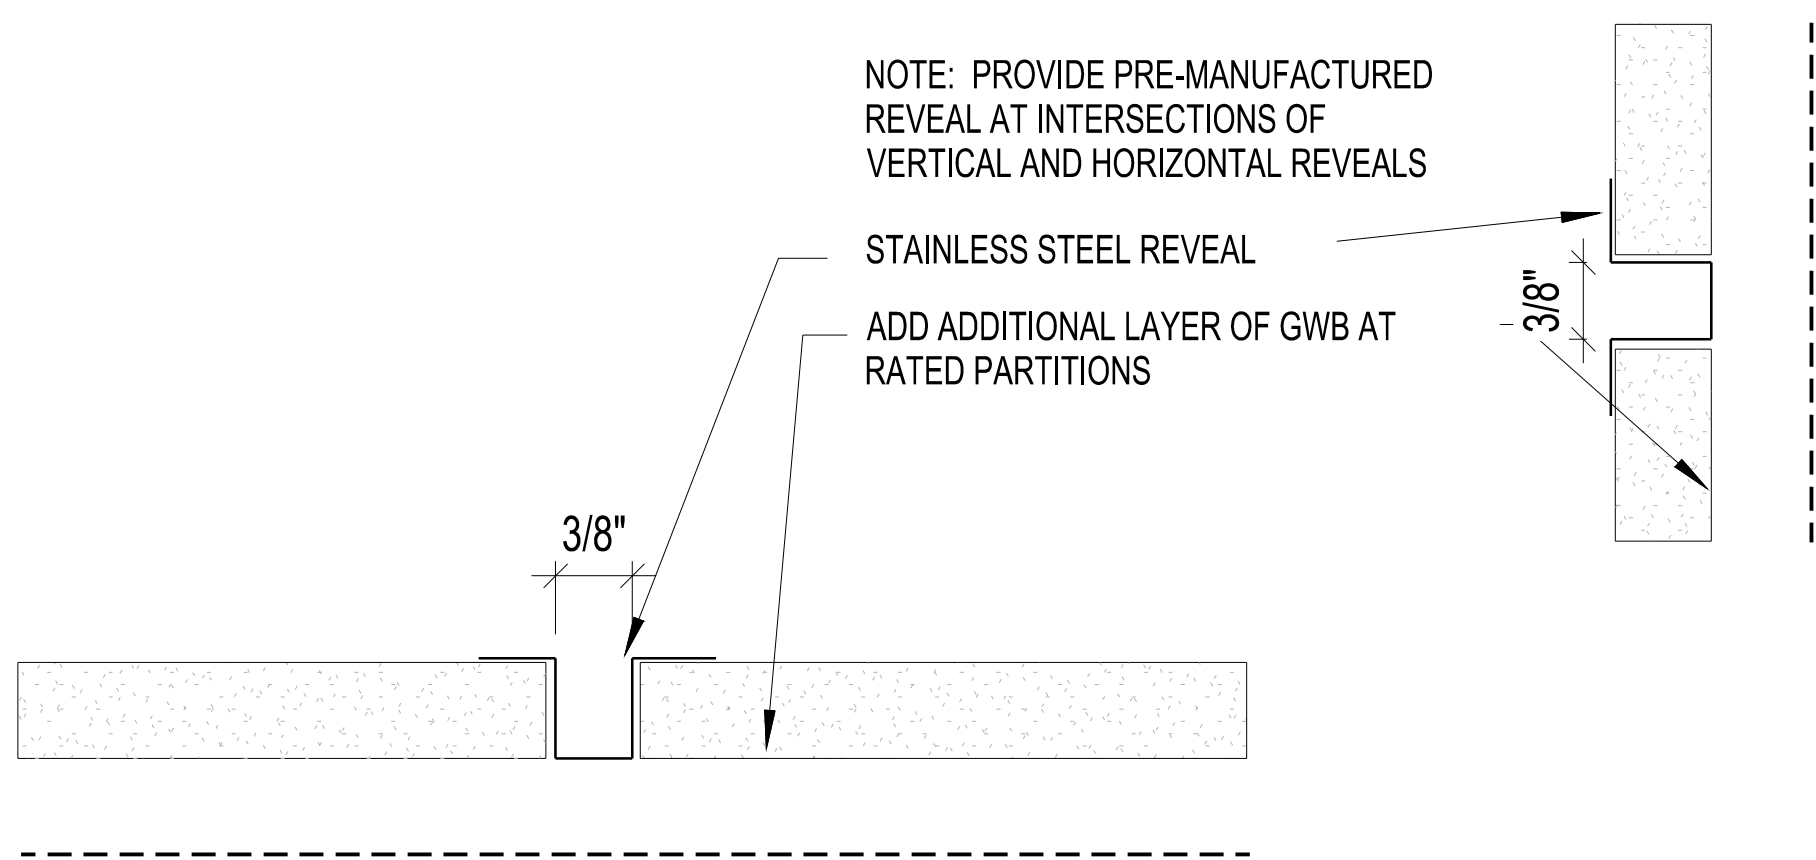


GYPSON WALL BOARD REVEAL

NOT TO SCALE

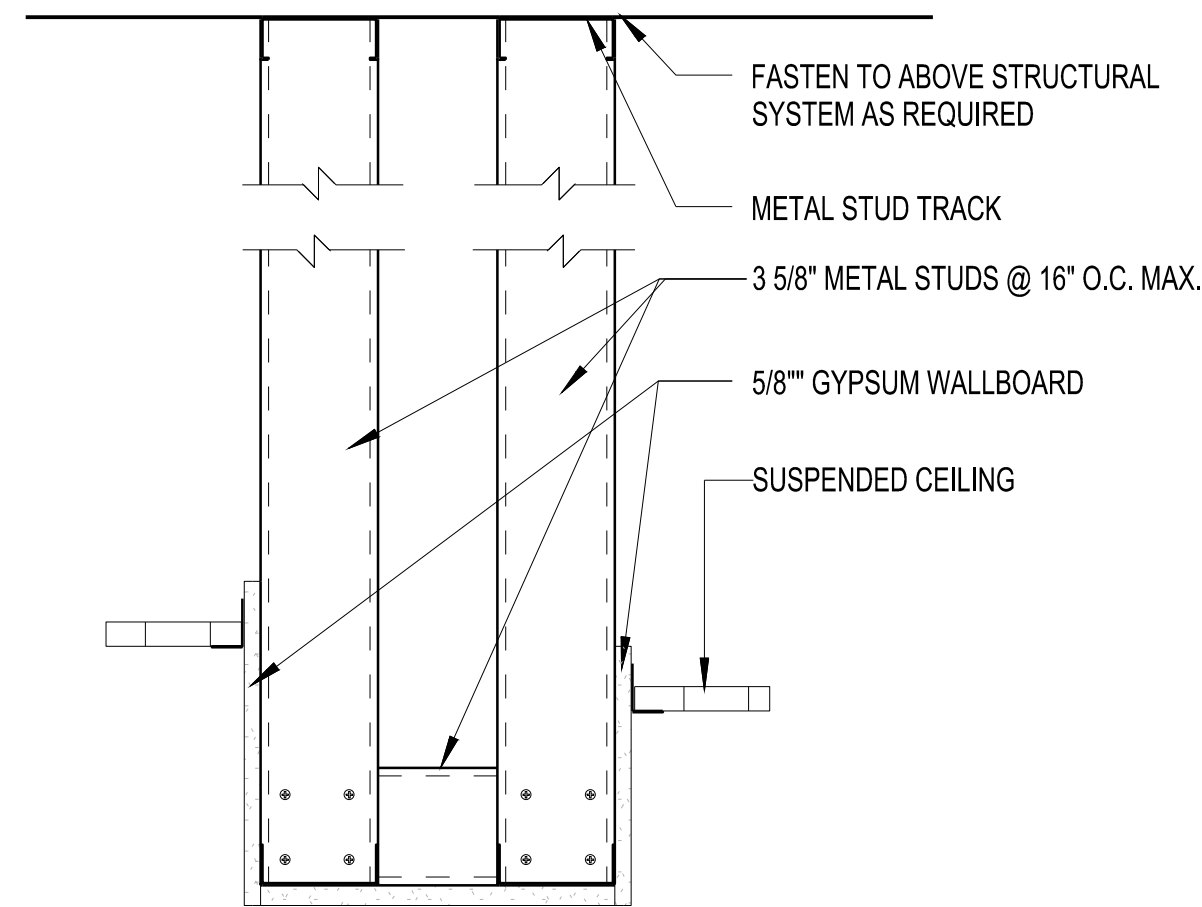


SOFFIT DETAIL AT EXTERIOR WALL

NOT TO SCALE

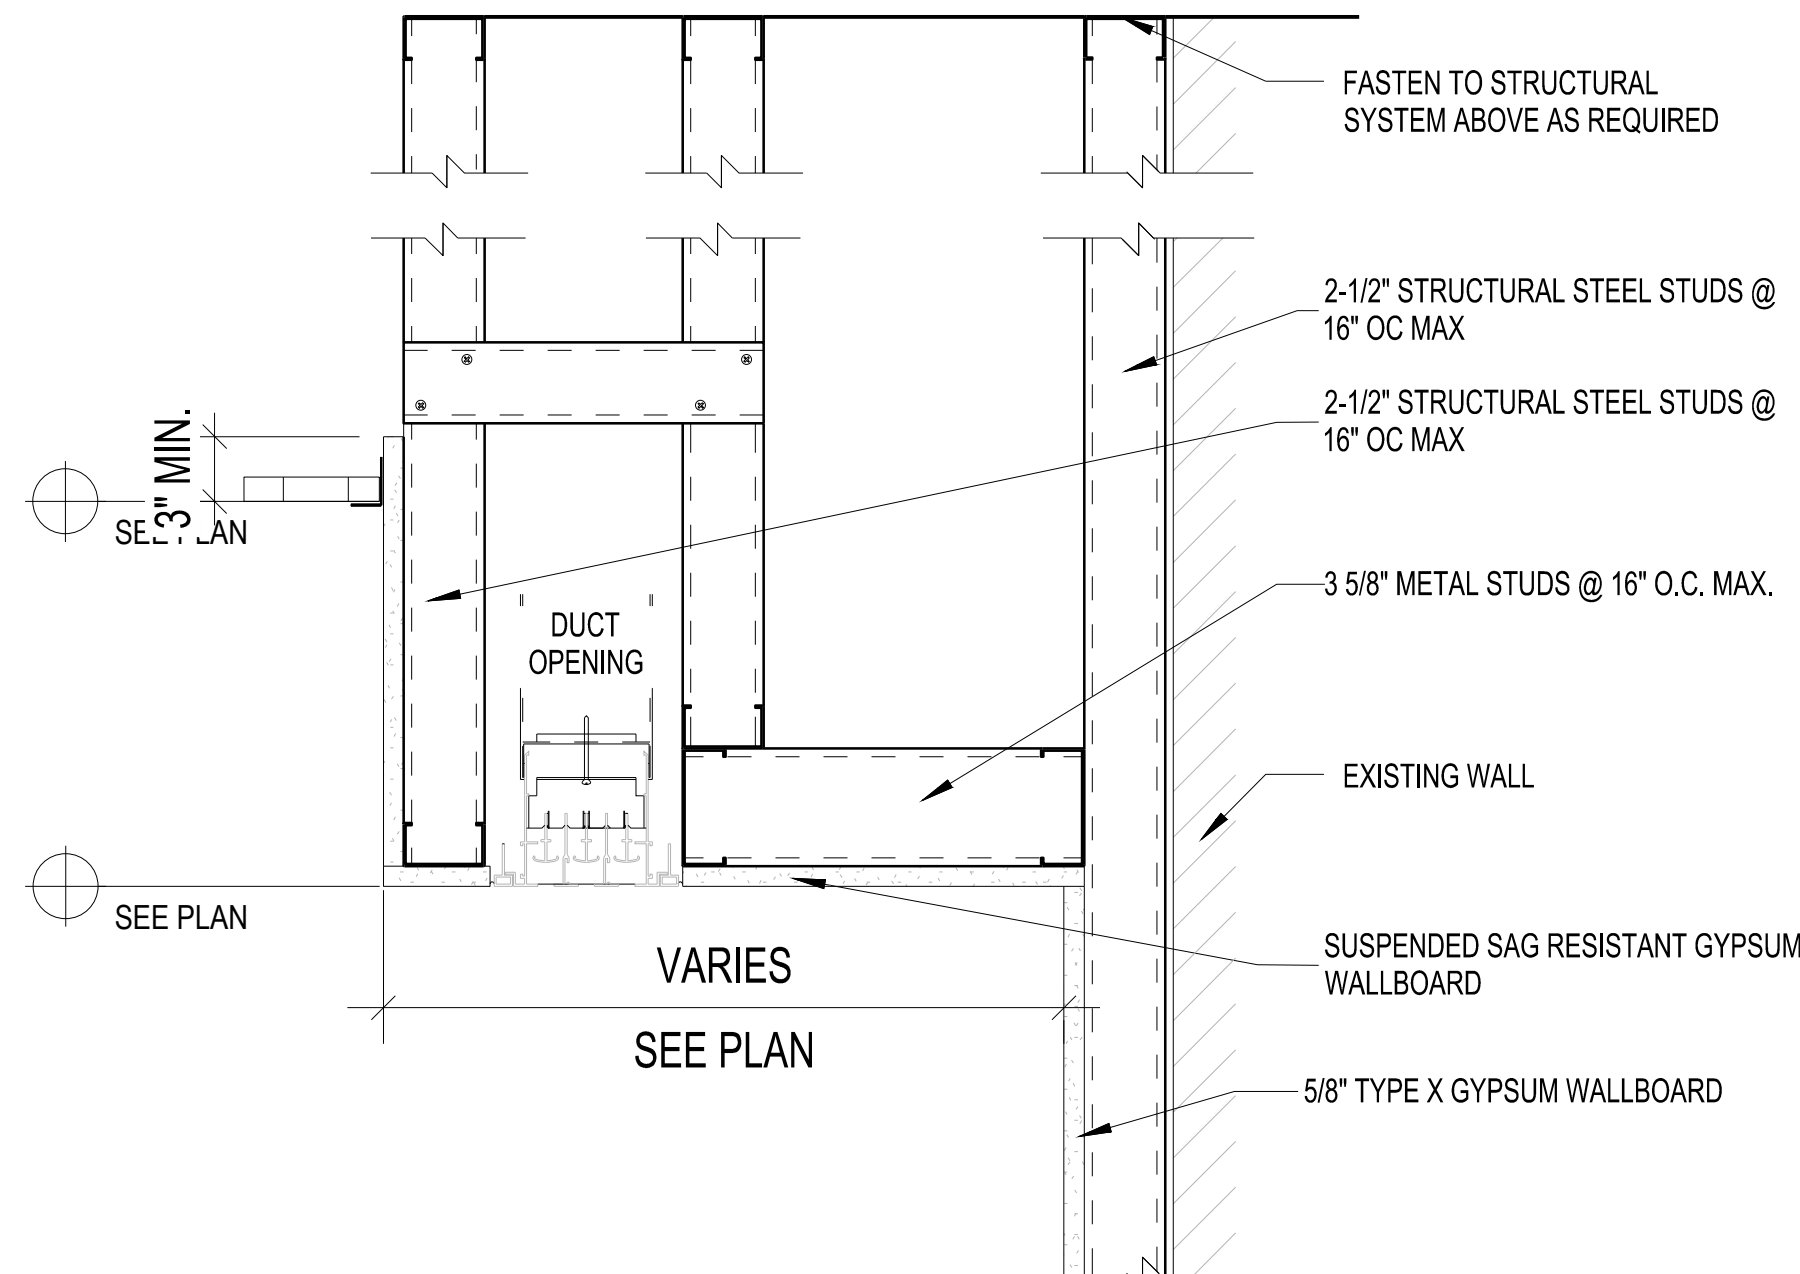


SOFFIT DETAIL AT EXTERIOR WALL

NOT TO SCALE

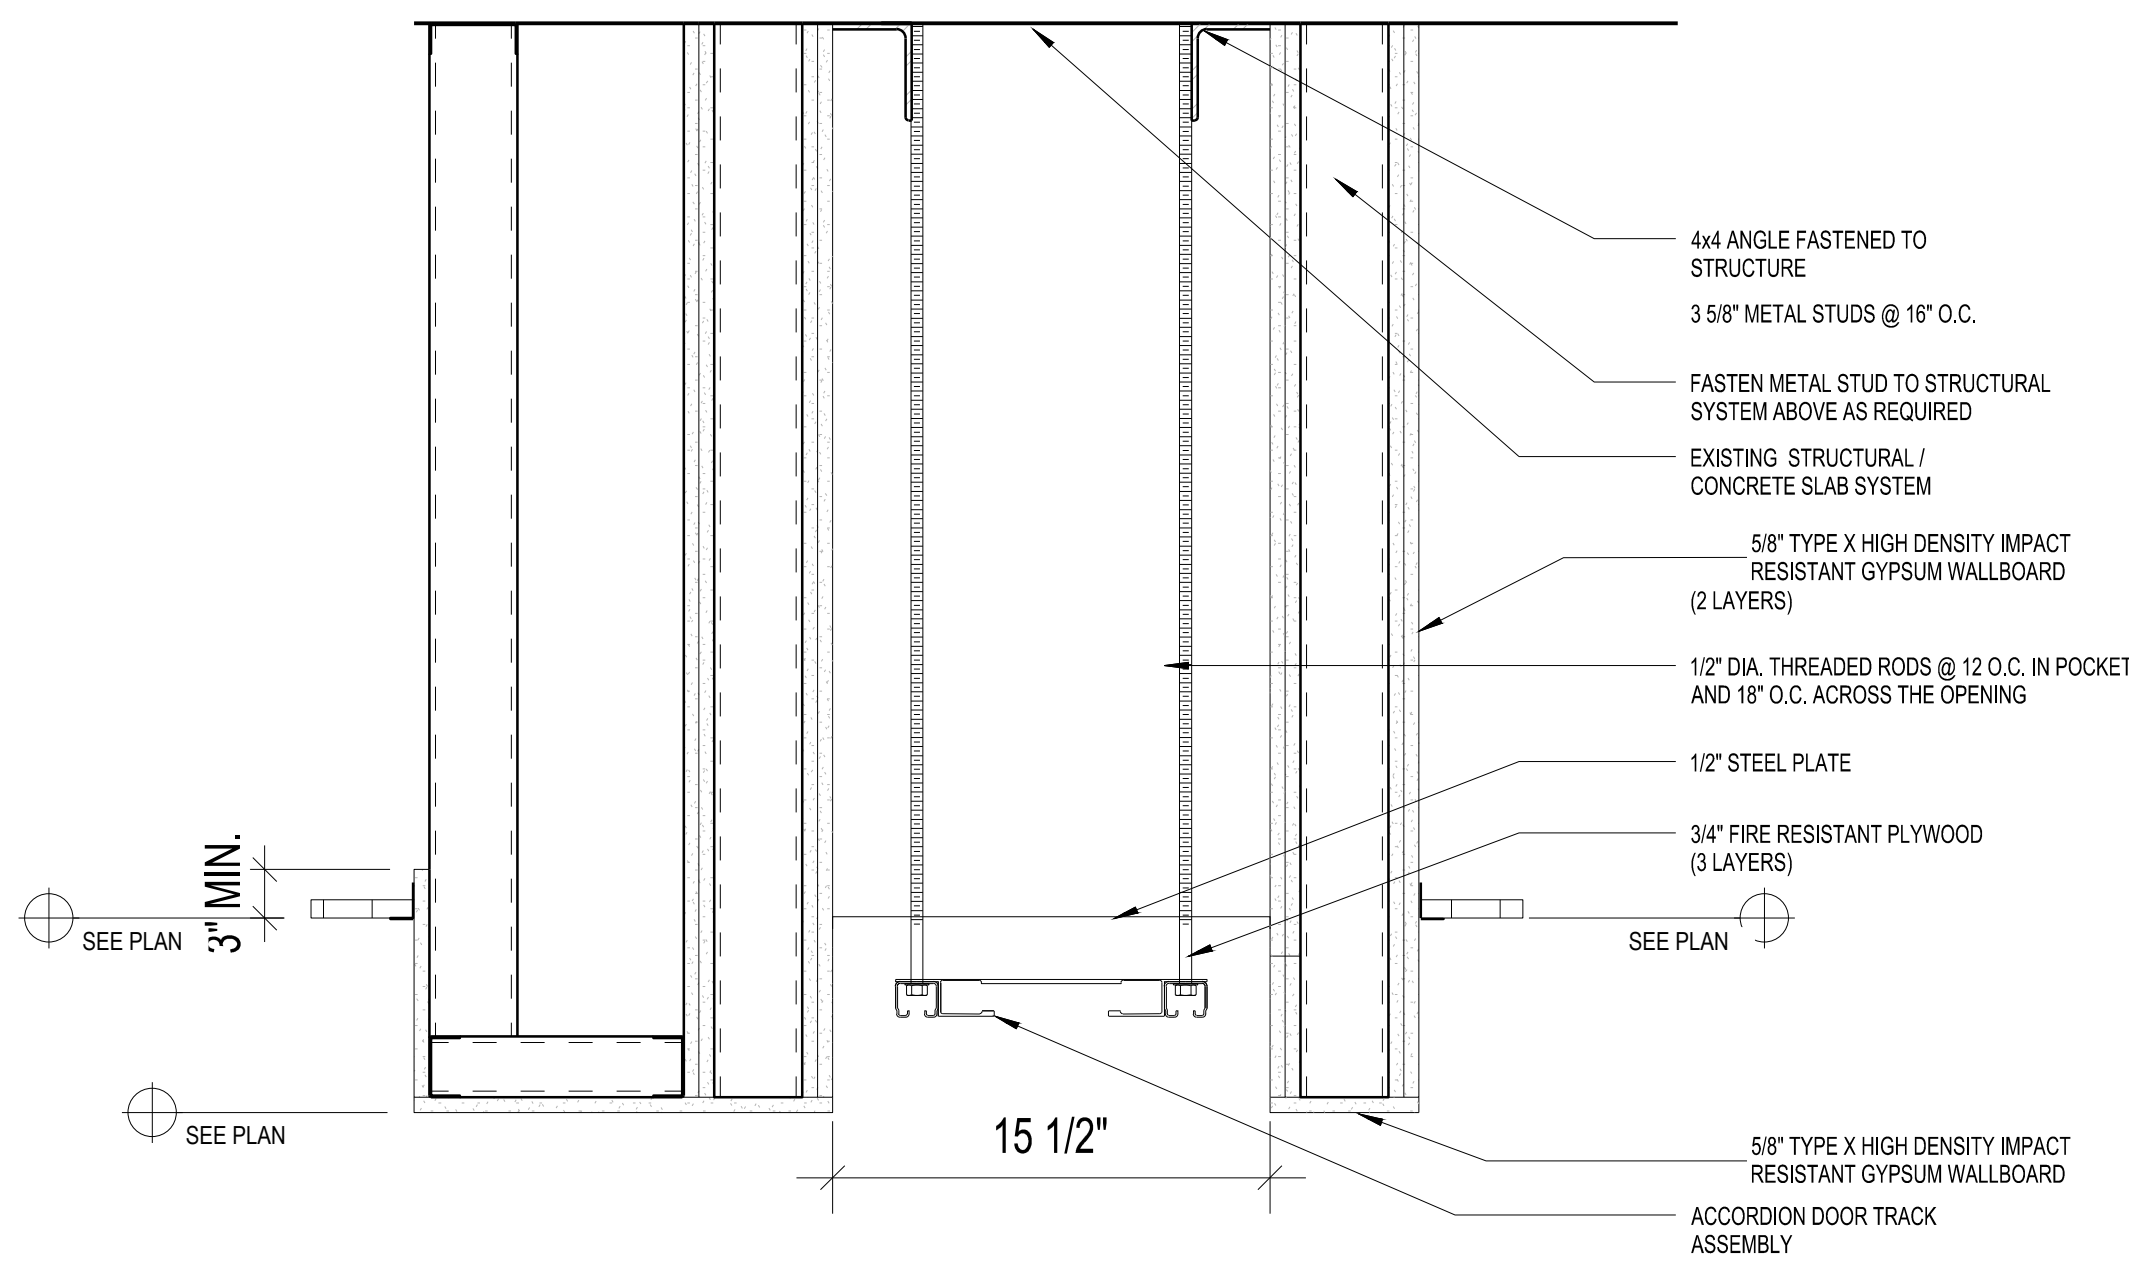

SOFFIT DETAIL AT ACCORDION DOOR

NOT TO SCALE

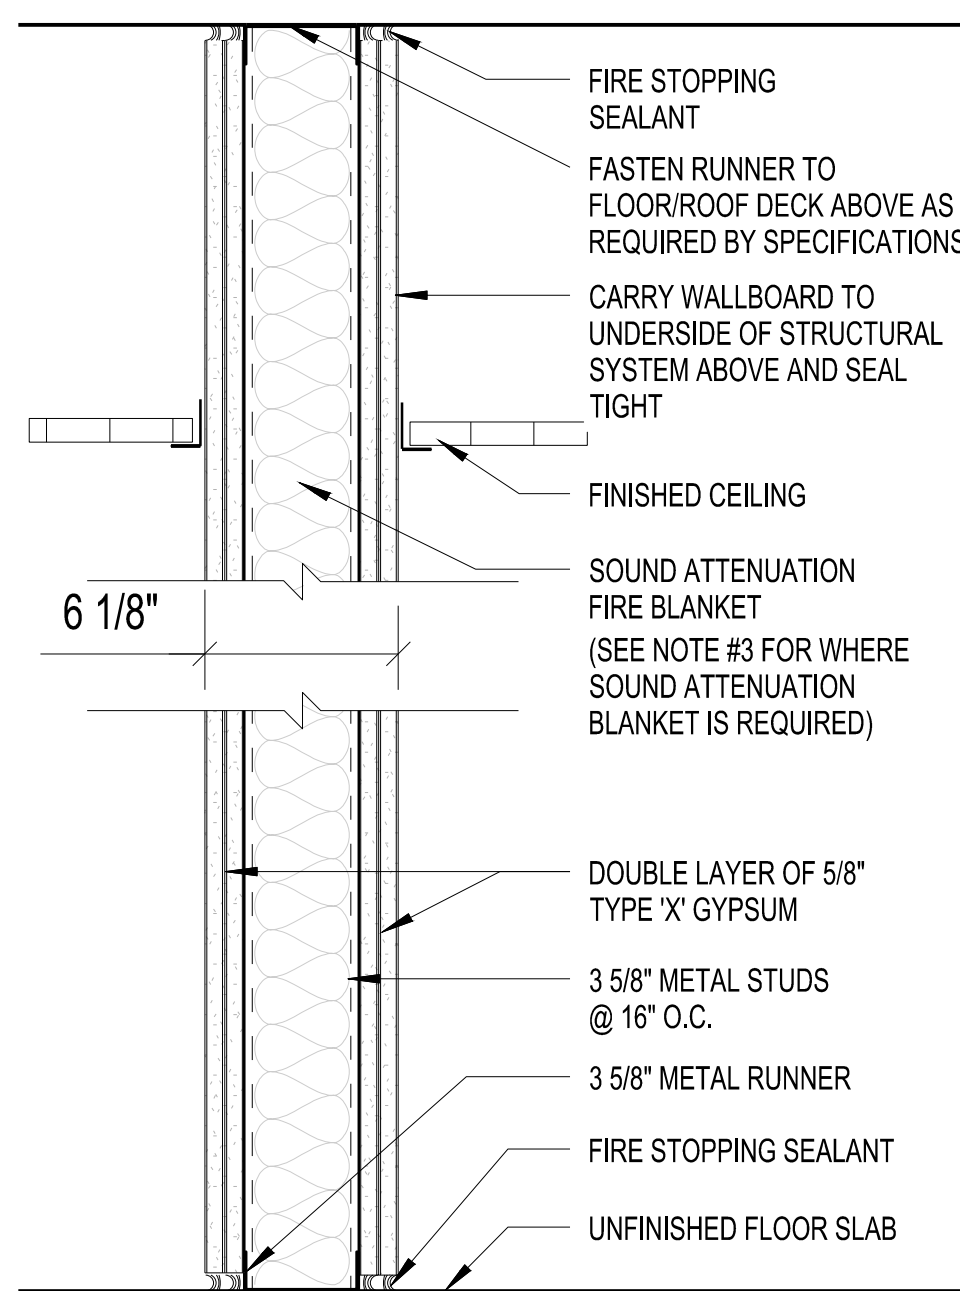

2 HOUR FIRE RATED WALL SECTION (UL DES U411/U419 STC 56)

NOT TO SCALE

CONSULTANTS:

ARCHITECT/ENGINEERS:

Drawing Title  
INTERIOR DETAILS

Project Title  
BUILDING 1 LIFE SAFETY  
IMPROVEMENTS

Project Number  
595-17-103

Building Number  
001

Office of  
Construction  
and Facilities  
Management

Approved Project Director  
THADDIUS KOCUBA  
CHIEF ENGINEER  
VAPAHCS PLANNING AND ENGINEERING

Location  
LEBANON VAMC      LEBANON, PA

Drawing Number  
D2

Date  
OCTOBER 12, 2016

Checked  
DCS


Drawn  
MPT

Dwg 12 of 13

DEPARTMENT OF  
VETERANS AFFAIRS


one eighth inch = one foot  
one quarter inch = one foot  
three eighths inch = one foot  
one half inch = one foot  
three quarters inch = one foot  
one inch = one foot  
one and one half inches = one foot  
two inches = one foot  
three inches = one foot  
four inches = one foot  
five inches = one foot  
six inches = one foot  
seven inches = one foot  
eight inches = one foot  
nine inches = one foot  
ten inches = one foot  
eleven inches = one foot  
twelve inches = one foot  
thirteen inches = one foot  
fourteen inches = one foot  
fifteen inches = one foot  
sixteen inches = one foot  
seventeen inches = one foot  
eighteen inches = one foot  
nineteen inches = one foot  
twenty inches = one foot  
twenty one inches = one foot  
twenty two inches = one foot  
twenty three inches = one foot  
twenty four inches = one foot  
twenty five inches = one foot  
twenty six inches = one foot  
twenty seven inches = one foot  
twenty eight inches = one foot  
twenty nine inches = one foot  
thirty inches = one foot  
thirty one inches = one foot  
thirty two inches = one foot  
thirty three inches = one foot  
thirty four inches = one foot  
thirty five inches = one foot  
thirty six inches = one foot  
thirty seven inches = one foot  
thirty eight inches = one foot  
thirty nine inches = one foot  
forty inches = one foot  
forty one inches = one foot  
forty two inches = one foot  
forty three inches = one foot  
forty four inches = one foot  
forty five inches = one foot  
forty six inches = one foot  
forty seven inches = one foot  
forty eight inches = one foot  
forty nine inches = one foot  
fifty inches = one foot  
fifty one inches = one foot  
fifty two inches = one foot  
fifty three inches = one foot  
fifty four inches = one foot  
fifty five inches = one foot  
fifty six inches = one foot  
fifty seven inches = one foot  
fifty eight inches = one foot  
fifty nine inches = one foot  
sixty inches = one foot  
sixty one inches = one foot  
sixty two inches = one foot  
sixty three inches = one foot  
sixty four inches = one foot  
sixty five inches = one foot  
sixty six inches = one foot  
sixty seven inches = one foot  
sixty eight inches = one foot  
sixty nine inches = one foot  
seventy inches = one foot  
seventy one inches = one foot  
seventy two inches = one foot  
seventy three inches = one foot  
seventy four inches = one foot  
seventy five inches = one foot  
seventy six inches = one foot  
seventy seven inches = one foot  
seventy eight inches = one foot  
seventy nine inches = one foot  
eighty inches = one foot  
eighty one inches = one foot  
eighty two inches = one foot  
eighty three inches = one foot  
eighty four inches = one foot  
eighty five inches = one foot  
eighty six inches = one foot  
eighty seven inches = one foot  
eighty eight inches = one foot  
eighty nine inches = one foot  
ninety inches = one foot  
ninety one inches = one foot  
ninety two inches = one foot  
ninety three inches = one foot  
ninety four inches = one foot  
ninety five inches = one foot  
ninety six inches = one foot  
ninety seven inches = one foot  
ninety eight inches = one foot  
ninety nine inches = one foot  
one hundred inches = one foot

1 2 3 4 5 6 7 8 9

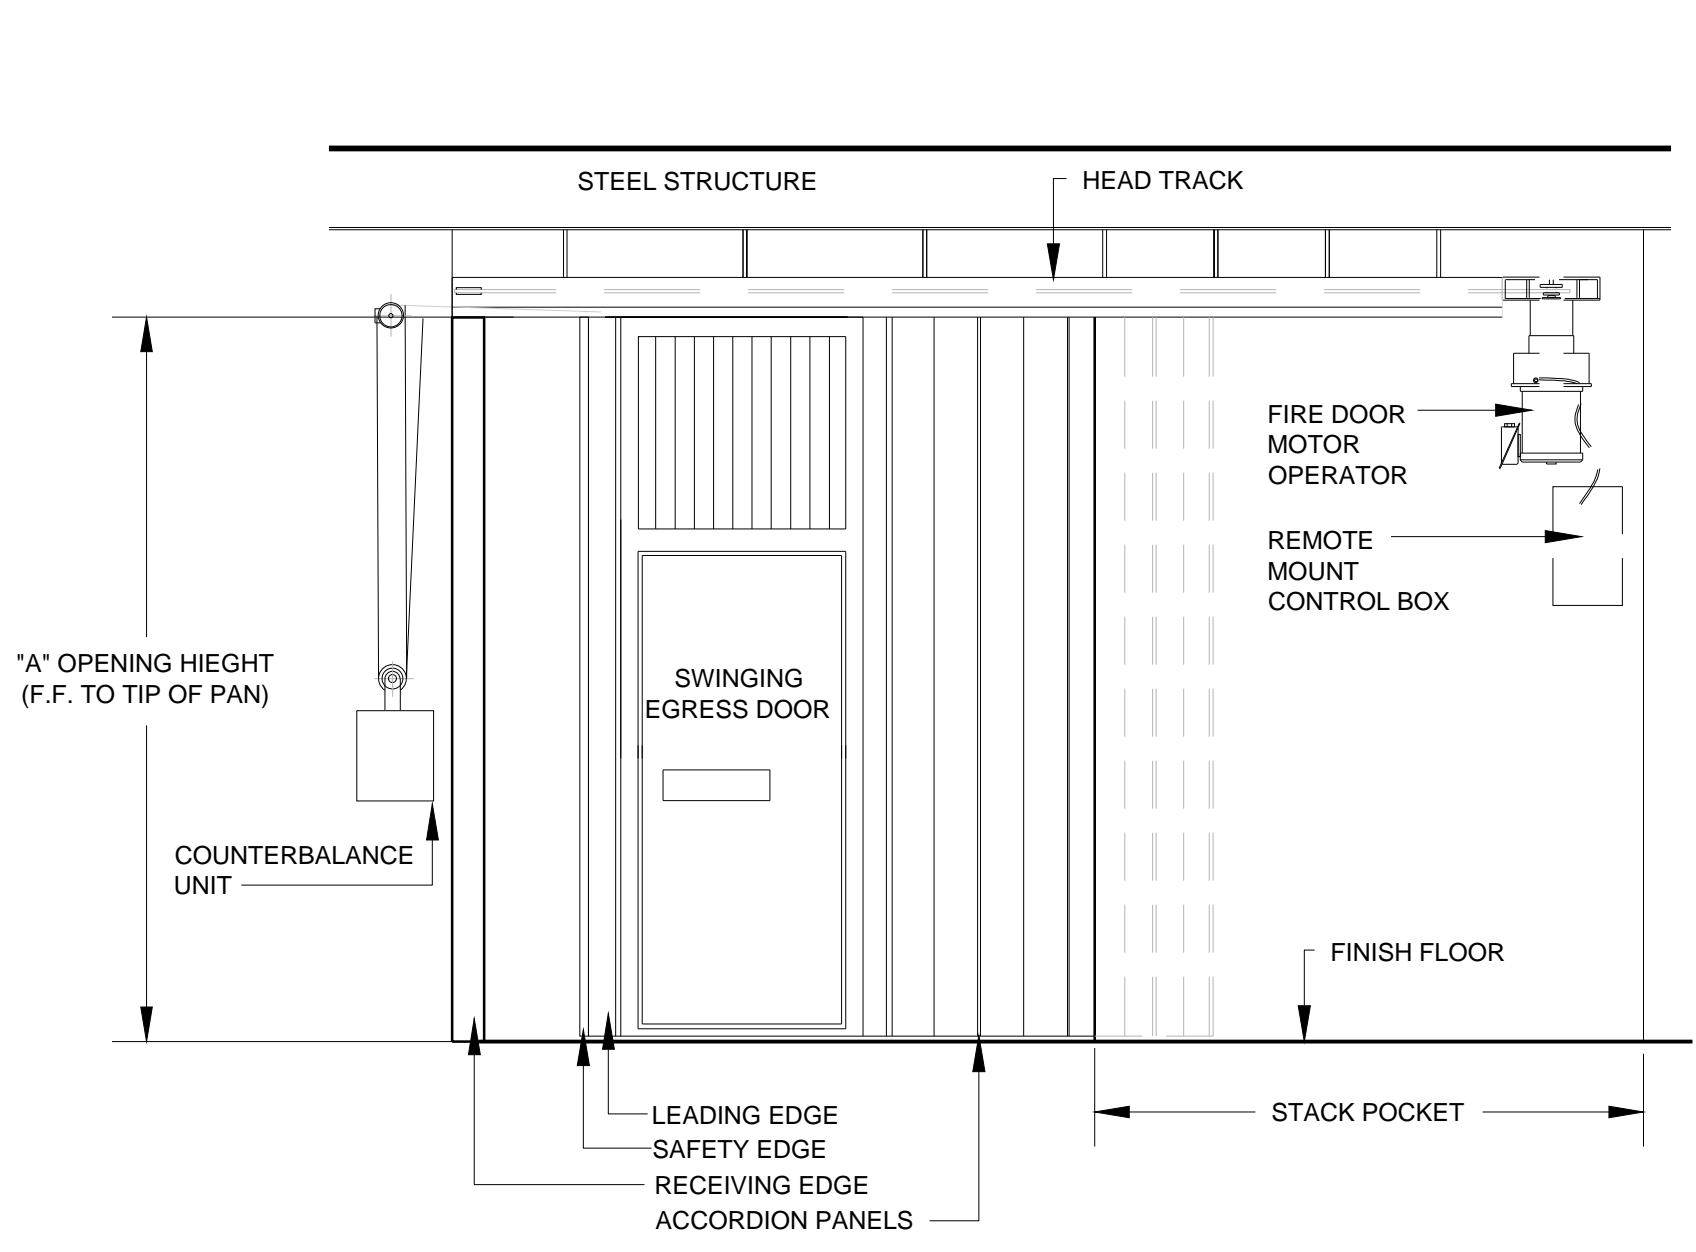


1  
D3  
ACCORDION DOOR WITH EGRESS – SECTION VIEW

NOT TO SCALE

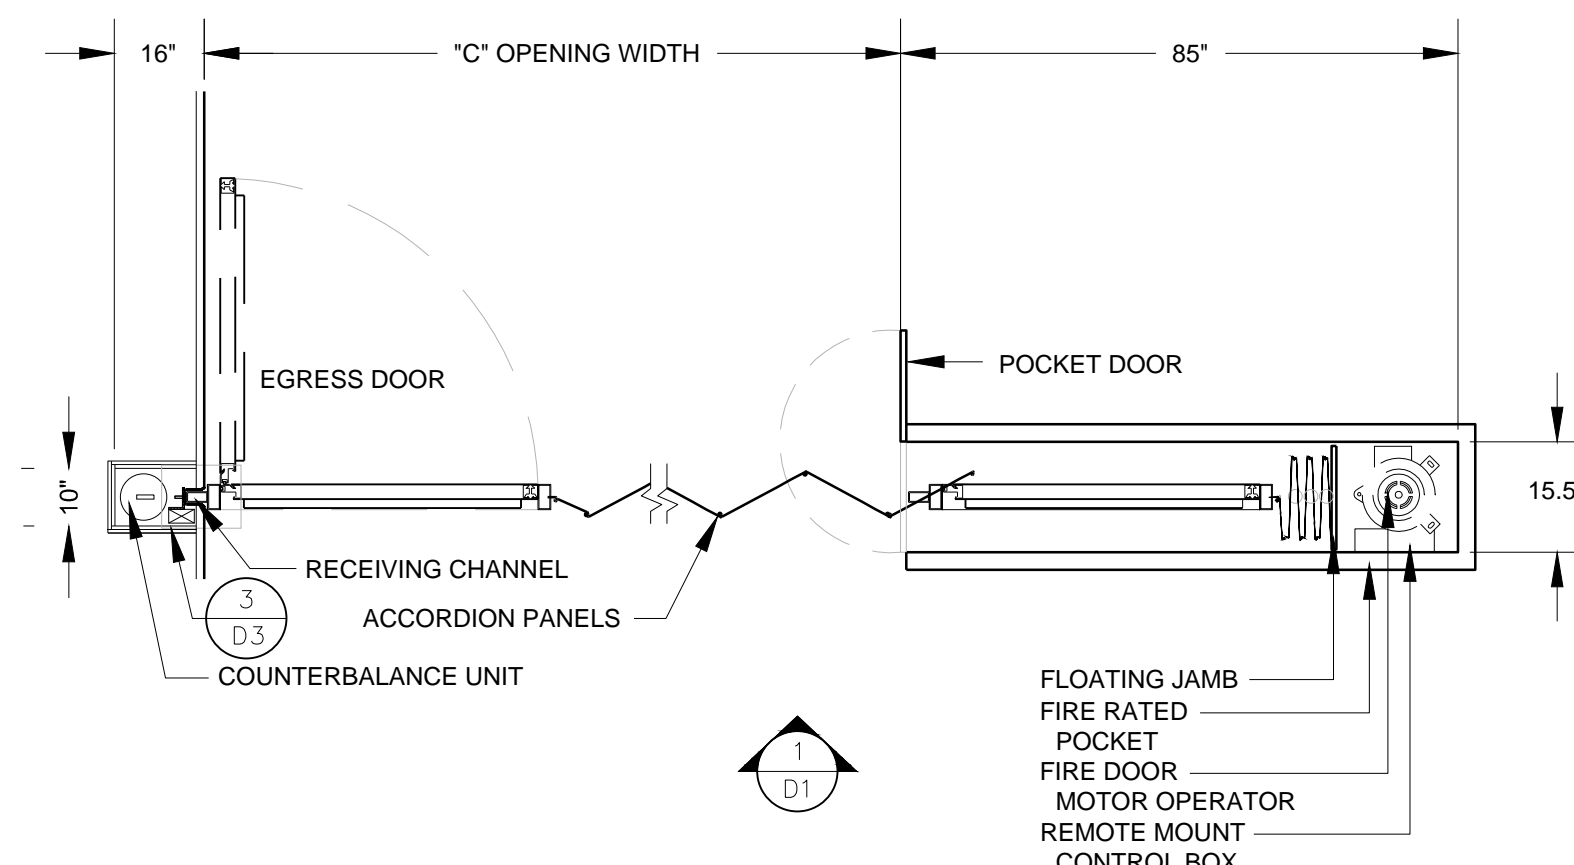


2  
D3  
ACCORDION DOOR WITH EGRESS – PLAN VIEW

NOT TO SCALE

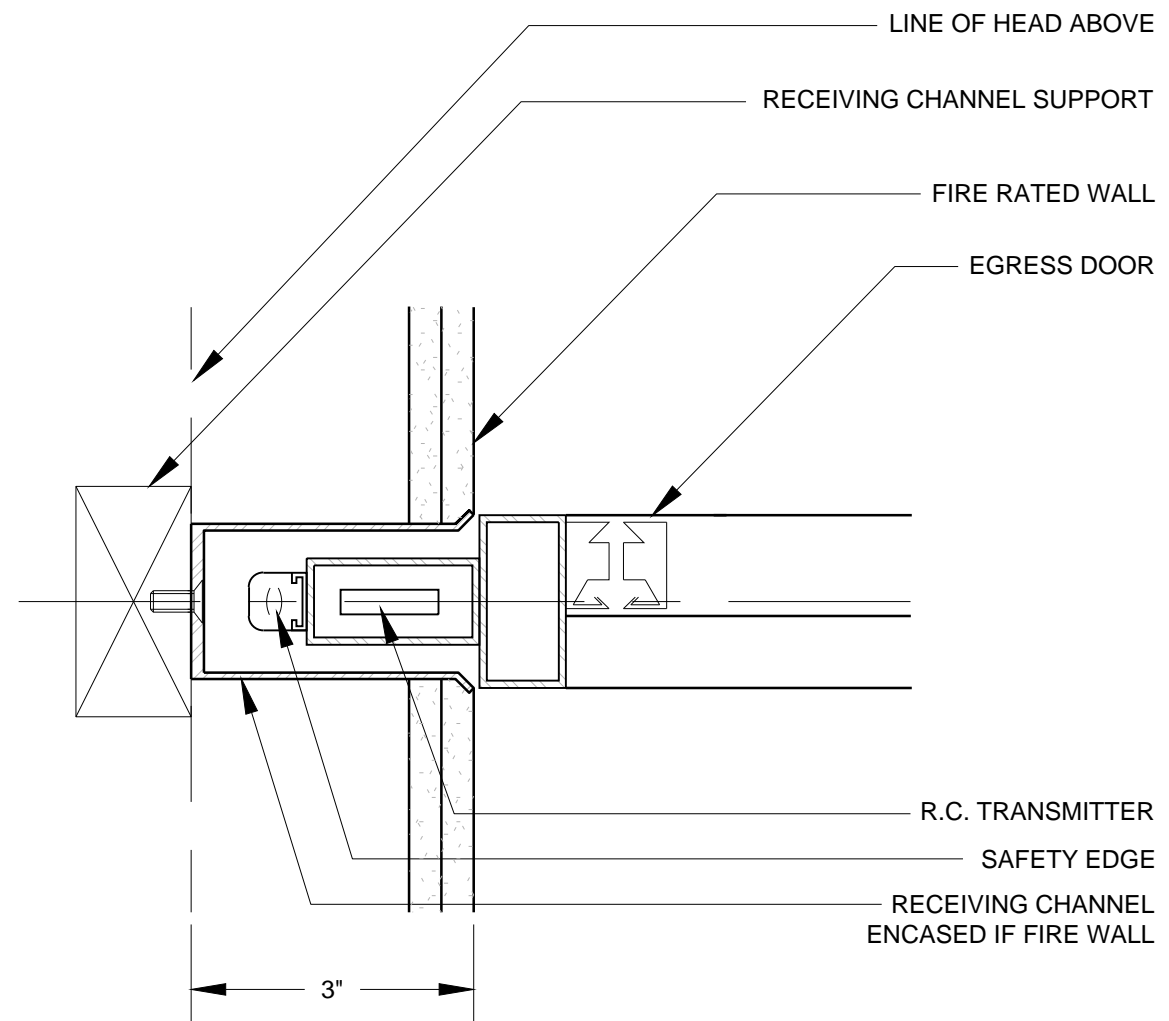


3  
D3  
ACCORDION DOOR RECEIVING EDGE POCKET

NOT TO SCALE

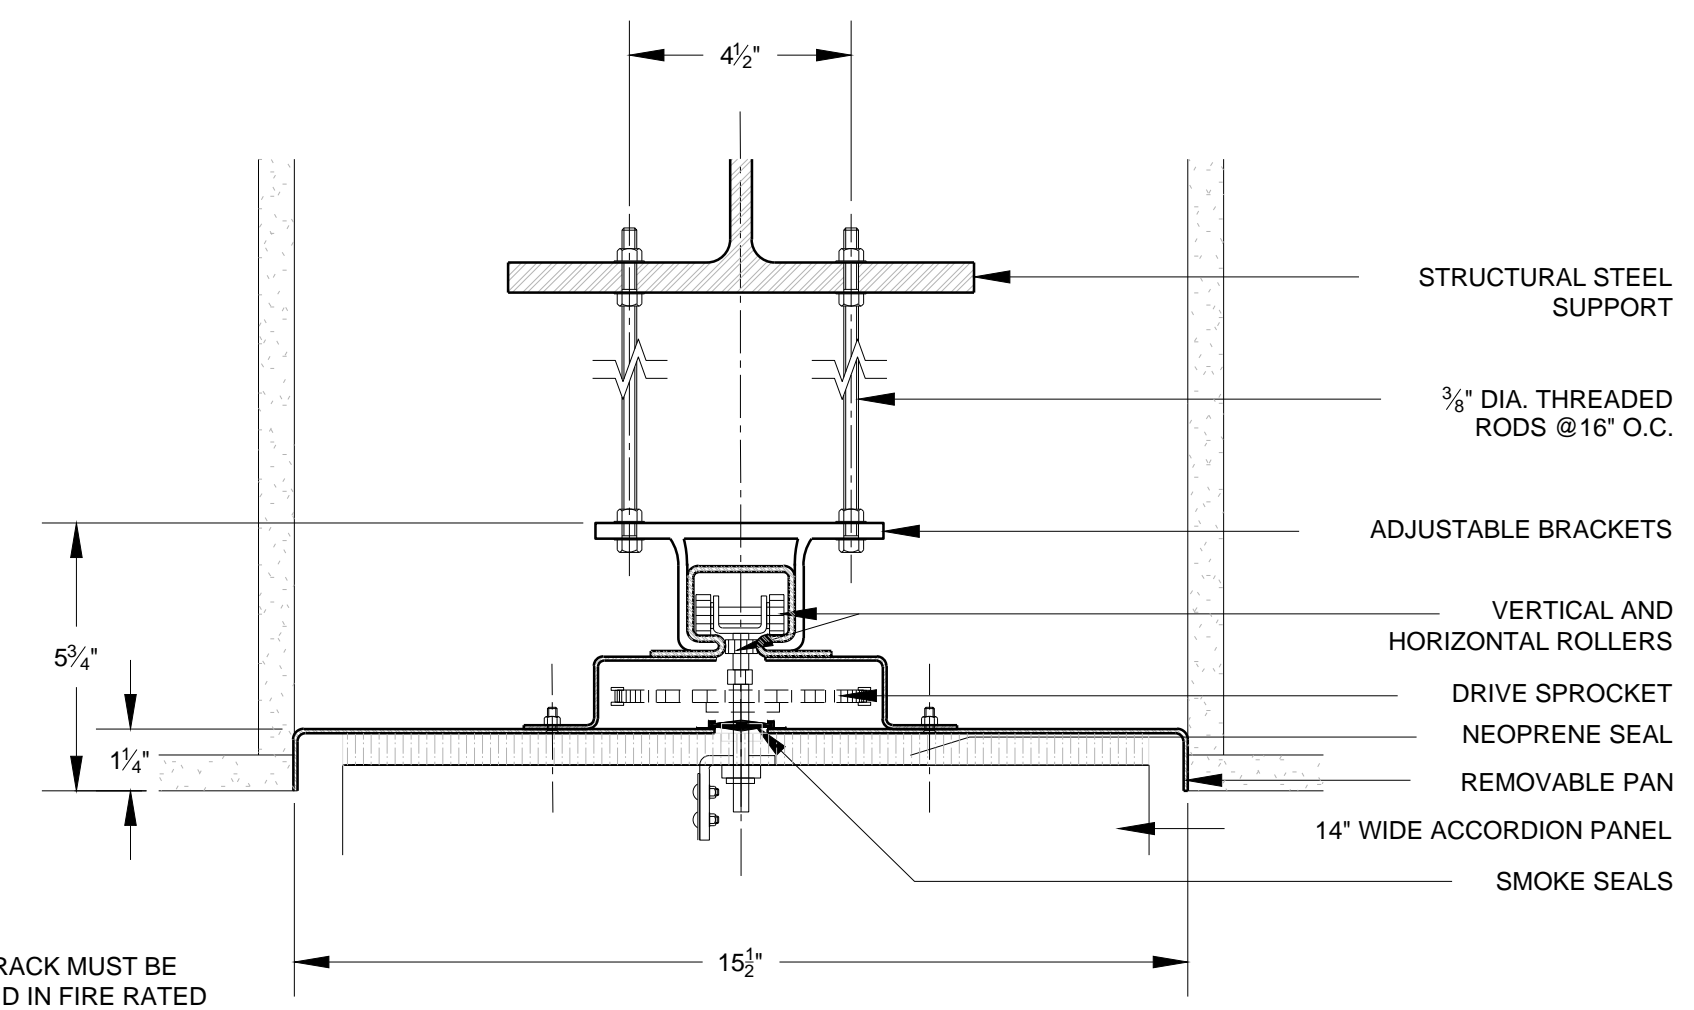

4  
D3  
ACCORDION FIRE DOOR SOFFIT CHANNEL

NOT TO SCALE

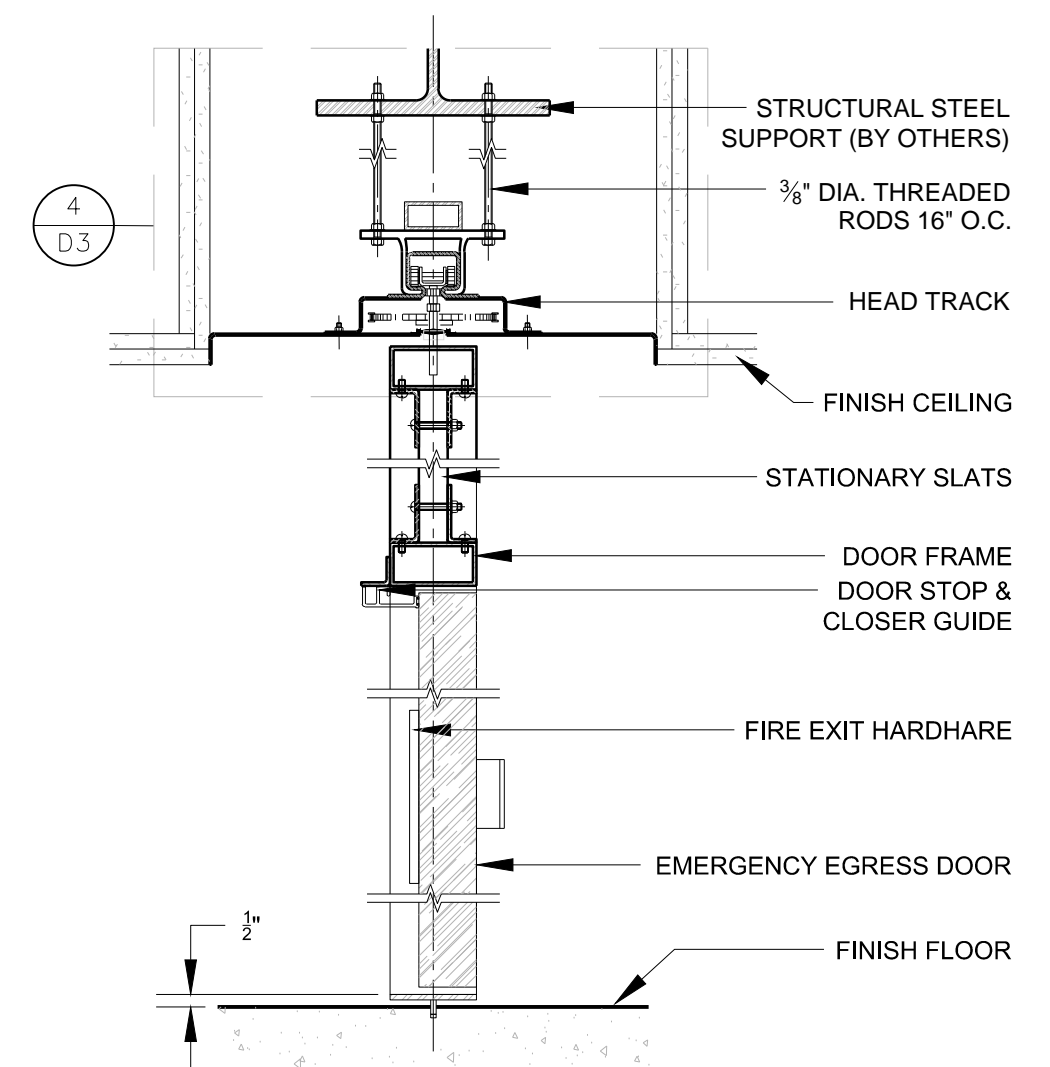

5  
D3  
ACCORDIAN FIRE DOOR SECTION VIEWS

NOT TO SCALE

CONSULTANTS:		ARCHITECT/ENGINEERS:		Drawing Title ACCORDIAN FIRE DOOR DETAILS	Project Title BUILDING 1 LIFE SAFETY IMPROVEMENTS	Project Number 595-17-103	Office of Construction and Facilities Management  DEPARTMENT OF VETERANS AFFAIRS	
				Approved Project Director THADDIUS KOCUBA CHIEF ENGINEER VAPAFCS PLANNING AND ENGINEERING	Location LEBANON VAMC LEBANON, PA	Building Number 001		
Revisions:		Date		Date OCTOBER 12, 2016	Checked DCS	Drawn MPT		
						D3	Dwg 13 of 13	

1 2 3 4 5 6 7 8 9