



 **FIRE PUMP ROOM - DEMOLITION PLAN**
SCALE: 1/4" = 1'-0" BUILDING 11

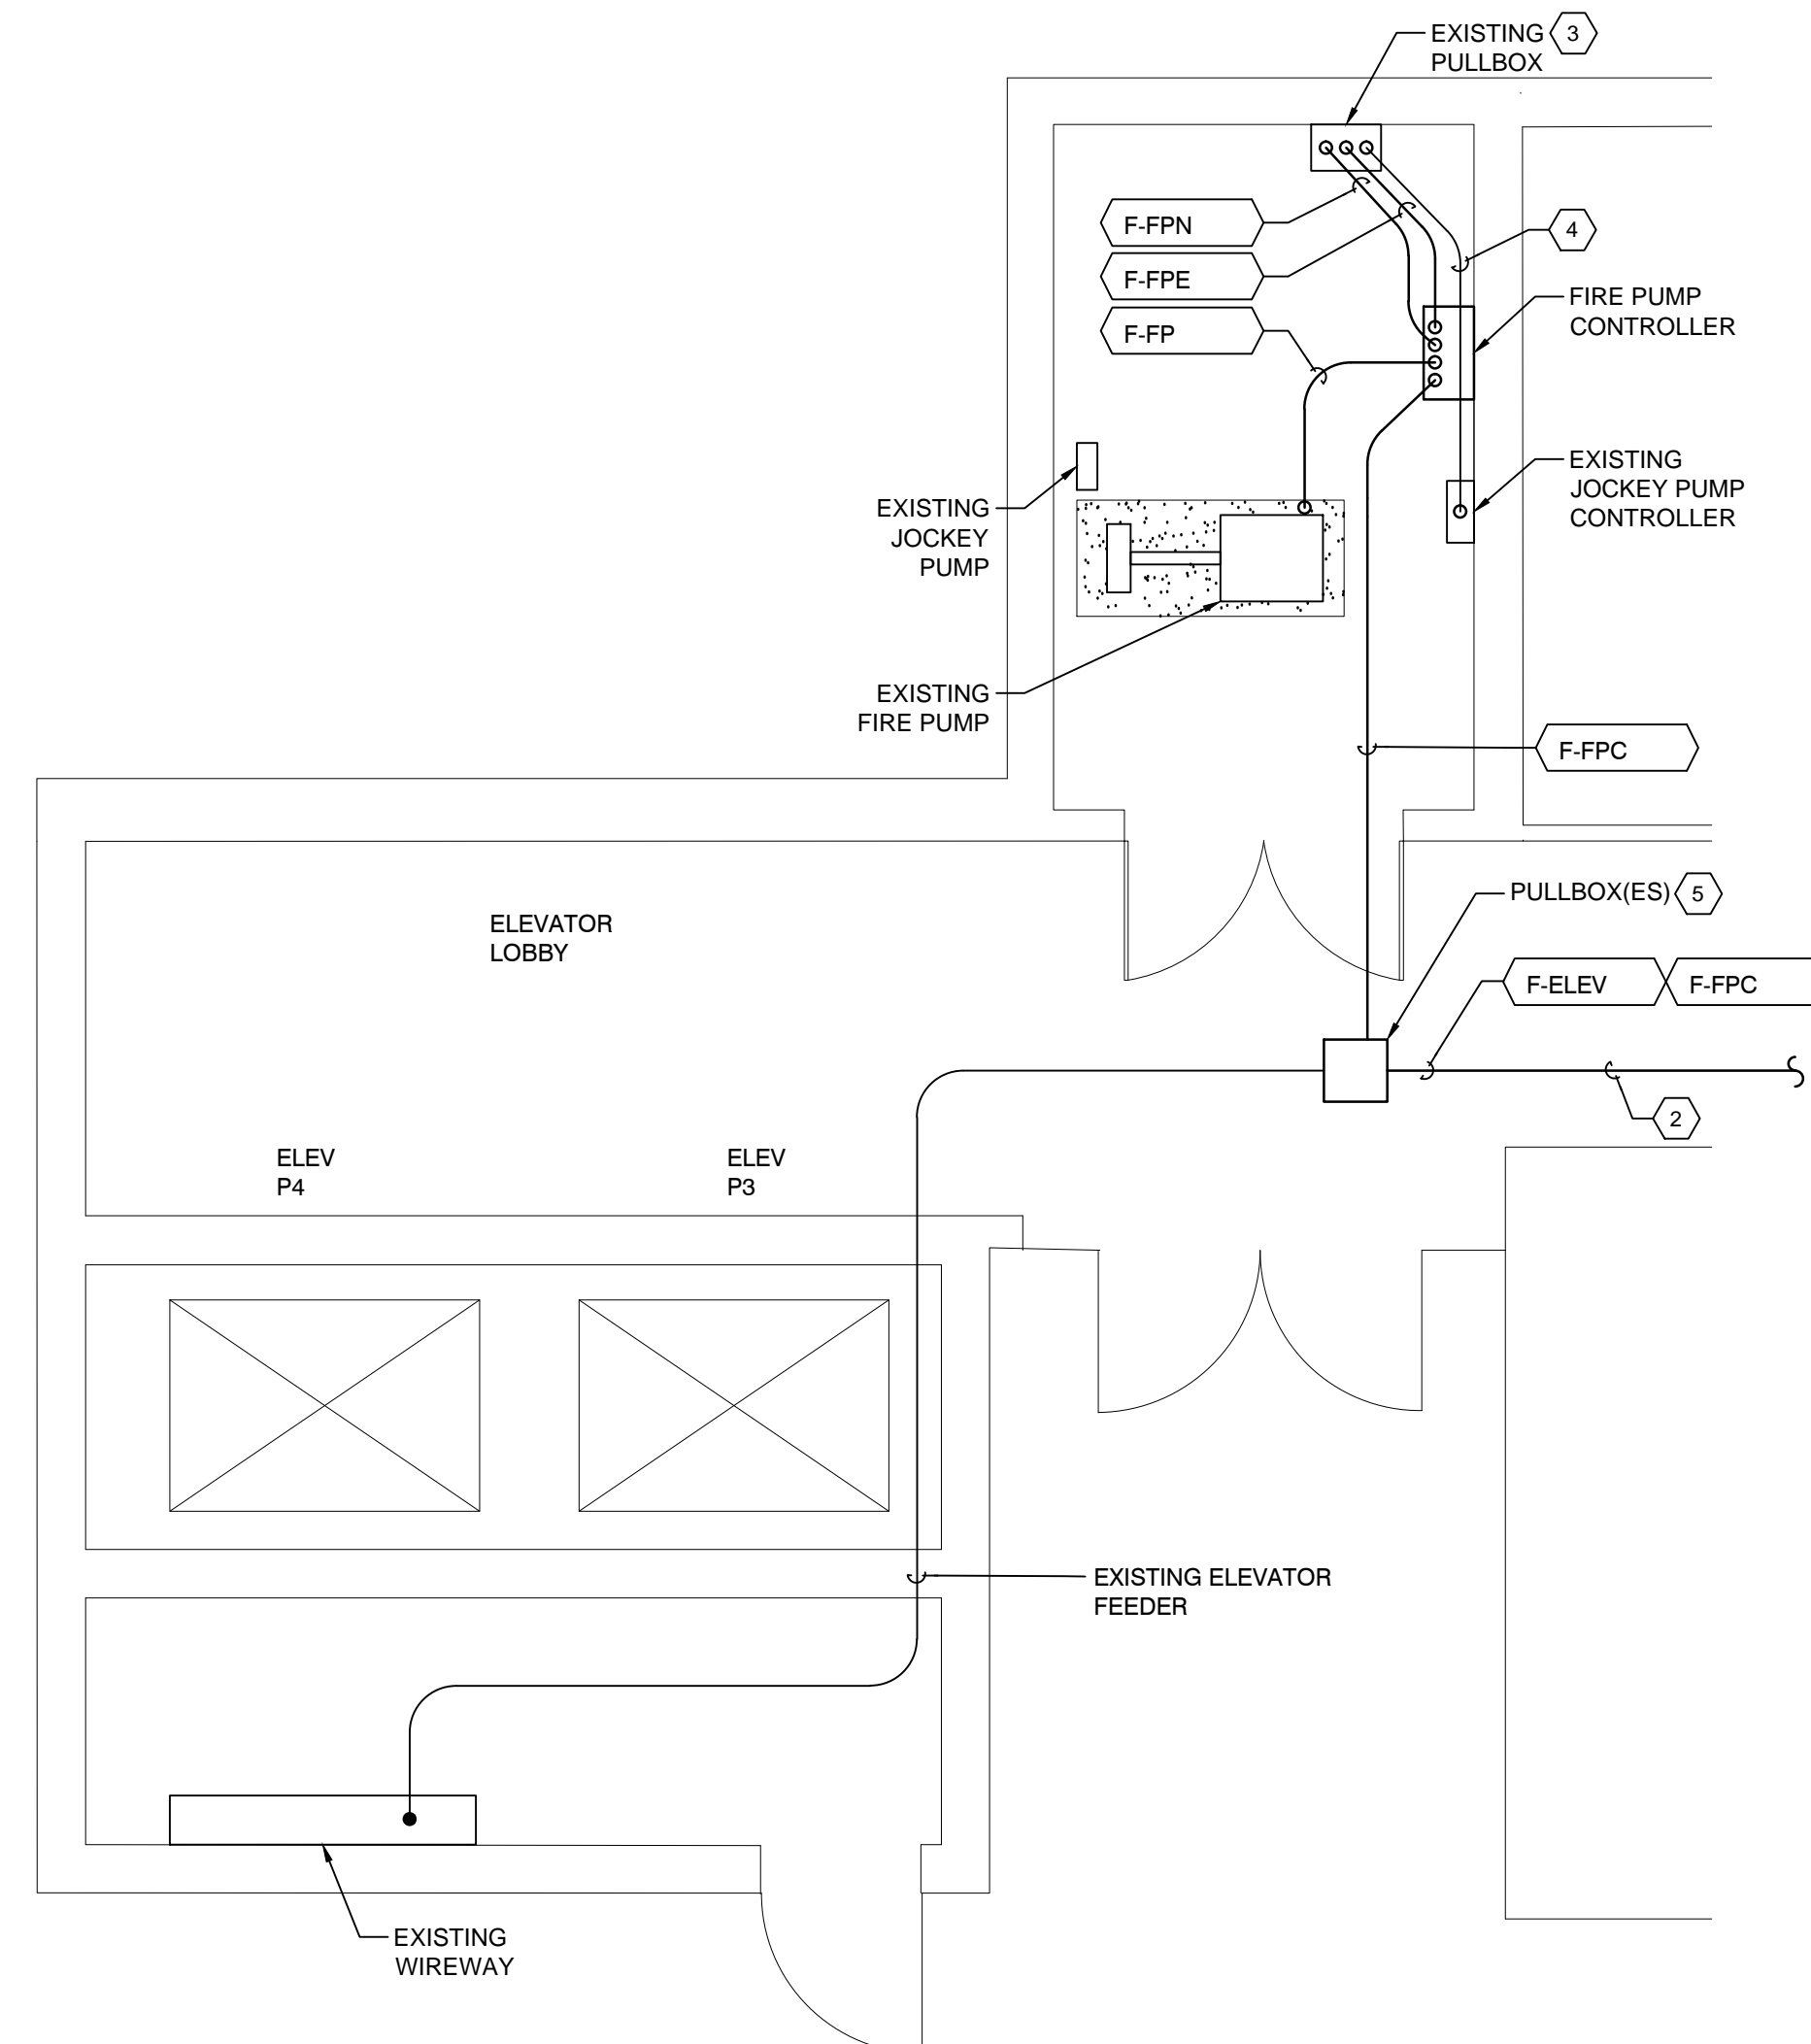

FIRE PUMP ROOM - POWER PLAN
SCALE: 1/4" = 1'-0" BUILDING 11

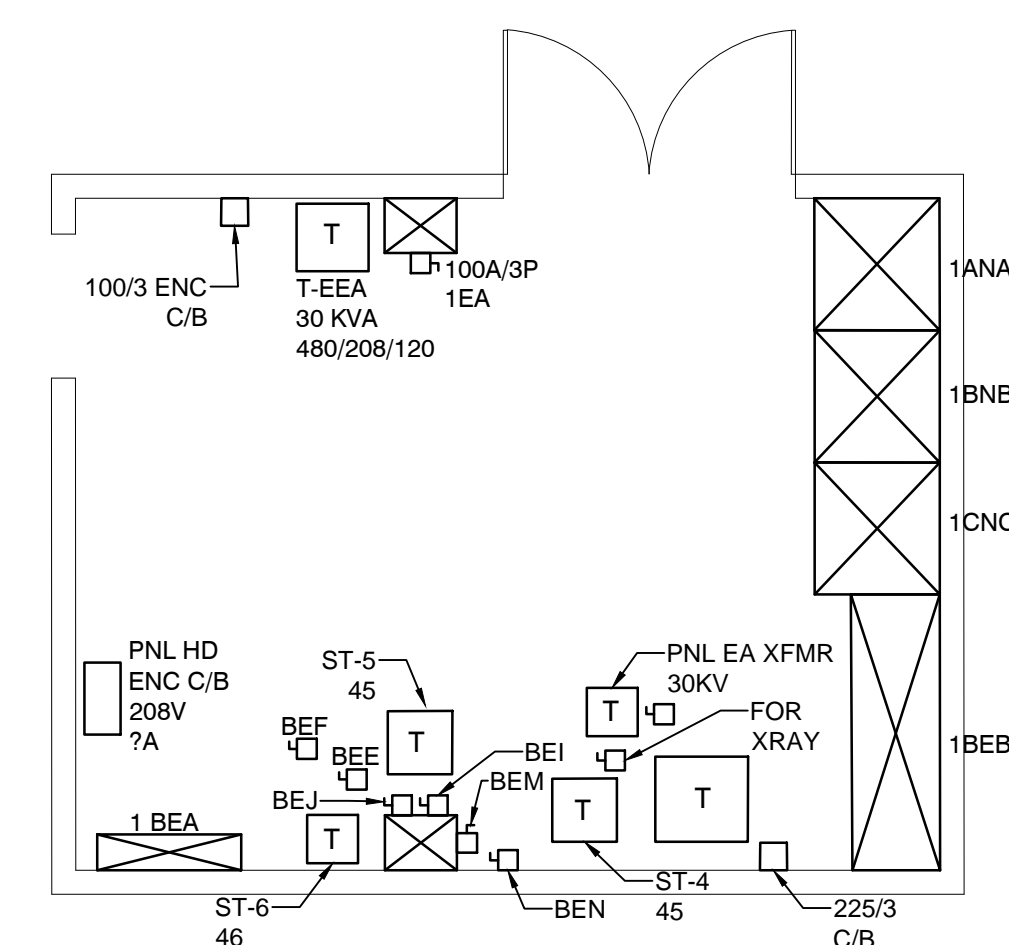

NOTE:

1. ALL EQUIPMENT SHOWN IS EXISTING TO REMAIN
UNLESS NOTED OTHERWISE.

 **FRONT VAULT - POWER PLAN**
SCALE: 1/4" = 1'-0" BUILDING 11

- NOTES BY SYMBOL: " "

1. PROVIDE TEMPORARY GENERATOR TO POWER FIRE PUMP AND JOCKEY PUMP DURING INSTALLATION OF NEW FIRE PUMP CONTROLLER AND ASSOCIATED FEEDERS.
2. SEE SHEET E2 FOR CONTINUATION.
3. PROVIDE VERTICAL BARRIER IN EXISTING PULLBOX TO SEPARATE THE FIRE PUMP NORMAL AND EMERGENCY POWER FEEDERS.
4. EXISTING JOCKEY PUMP FEEDER. SPLICE ONTO NEW FIRE PUMP EMERGENCY POWER FEEDER.
5. SPLICE NEW AND EXISTING ELEVATOR FEEDER IN NEW PULLBOX.

[illegible]

CONSTRUCTION SET

Office of
Construction
and Facilities
Management

