

ALUMINUM DISK IN CONCRETE
BENCHMARK PHC #2
ELEV=87.58' NAVD88



J	6" Bench on Concrete Pad	
K	Columbarium Wall	
L	Turf/Lawn Area	Refer to Planting Plans (L-900 Series)


PHASE 1A EXISTING IMPROVEMENTS


 
ADD-ALTERNATE #4
P.O.W. FLAG AREA &
MEMORIAL WALK -
SEE SHEET L-304



CONSTRUCTION DOCUMENTS

 

[illegible]

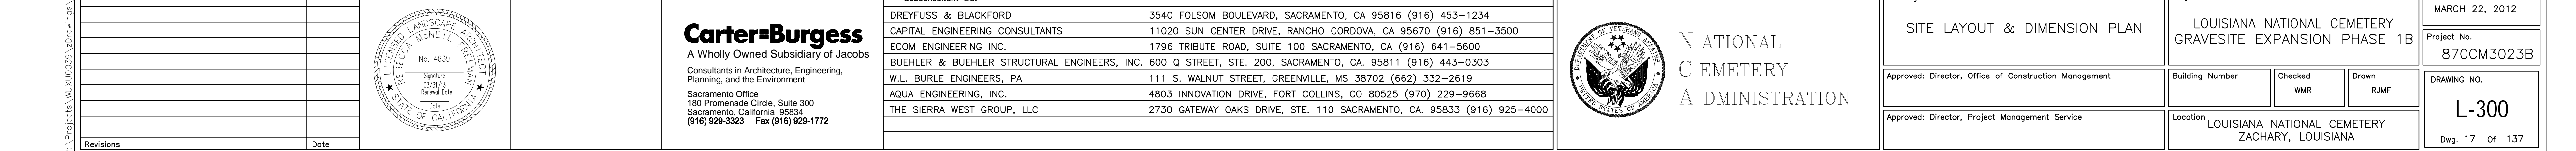

	Carter Burgess A Wholly Owned Subsidiary of Jacobs Consultants in Architecture, Engineering, Planning, and the Environment Sacramento Office 180 Frontenac Circle, Suite 300 Sacramento, California 95834 (916) 929-3323 Fax (916) 929-1772	DREYFUSS & BLACKFORD 3540 FOLSOM BOULEVARD, SACRAMENTO, CA 95816 (916) 453-1234 CAPITAL ENGINEERING CONSULTANTS 11020 SUN CENTER DRIVE, RANCHO CORDOVA, CA 95670 (916) 851-3500 ECOM ENGINEERING INC. 1796 TRIBUTE ROAD, SUITE 100 SACRAMENTO, CA (916) 641-5600 BUEHLER & BUEHLER STRUCTURAL ENGINEERS, INC. 600 Q STREET, STE. 200, SACRAMENTO, CA. 95811 (916) 443-0303 W.L. BURLE ENGINEERS, PA 111 S. WALNUT STREET, GREENVILLE, MS 38702 (662) 332-2619 AQUA ENGINEERING, INC. 4803 INNOVATION DRIVE, FORT COLLINS, CO 80525 (970) 229-9668 THE SIERRA WEST GROUP, LLC 2730 GATEWAY OAKS DRIVE, STE. 110 SACRAMENTO, CA. 95833 (916) 925-4000	 NATIONAL CEMETERY ADMINISTRATION	SITE LAYOUT & DIMENSION PLAN Approved: Director, Office of Construction Management Approved: Director, Project Management Service	LOUISIANA NATIONAL CEMETERY GRAVESITE EXPANSION PHASE 1B Building Number _____ Checked <input type="checkbox"/> NMR Drawn <input type="checkbox"/> R/MF Location LOUISIANA NATIONAL CEMETERY ZACHARY, LOUISIANA	MARCH 22, 2012 Project No. 870CM3023B DRAWING NO. L-300 Dwg. 17 of 137
		Revisions _____ Date _____				




	Carter Burgess A Wholly Owned Subsidiary of Jacobs Consultants in Architecture, Engineering, Planning, and the Environment Sacramento Office 180 Frontenac Circle, Suite 300 Sacramento, California 95834 (916) 929-3323 Fax (916) 929-1772	DREYFUSS & BLACKFORD 3540 FOLSOM BOULEVARD, SACRAMENTO, CA 95816 (916) 453-1234 CAPITAL ENGINEERING CONSULTANTS 11020 SUN CENTER DRIVE, RANCHO CORDOVA, CA 95670 (916) 851-3500 ECOM ENGINEERING INC. 1796 TRIBUTE ROAD, SUITE 100 SACRAMENTO, CA (916) 641-5600 BUEHLER & BUEHLER STRUCTURAL ENGINEERS, INC. 600 Q STREET, STE. 200, SACRAMENTO, CA. 95811 (916) 443-0303 W.L. BURLE ENGINEERS, PA 111 S. WALNUT STREET, GREENVILLE, MS 38702 (662) 332-2619 AQUA ENGINEERING, INC. 4803 INNOVATION DRIVE, FORT COLLINS, CO 80525 (970) 229-9668 THE SIERRA WEST GROUP, LLC 2730 GATEWAY OAKS DRIVE, STE. 110 SACRAMENTO, CA. 95833 (916) 925-4000		NATIONAL C E M E T E R Y A D M I N I S T R A T I O N	SITE LAYOUT & DIMENSION PLAN Approved: Director, Office of Construction Management Approved: Director, Project Management Service	LOUISIANA NATIONAL CEMETERY GRAVESITE EXPANSION PHASE 1B Building Number _____ Checked <input type="checkbox"/> NMR Drawn <input type="checkbox"/> R/MF Location LOUISIANA NATIONAL CEMETERY ZACHARY, LOUISIANA	MARCH 22, 2012 Project No. 870CM3023B DRAWING NO. L-300 Dwg. 17 of 137
		Revisions _____ Date _____					



PROJECT NO. _____ DATE _____ REVISIONS _____		Carter Burgess A Wholly Owned Subsidiary of Jacobs <small>Consultants in Architecture, Engineering, Planning, and the Environment Sacramento Office 180 Promenade Circle, Suite 300 Sacramento, California 95834 (916) 929-3523 Fax (916) 929-1772</small>	SUBCONSULTANT LIST DREYFUSS & BLACKFORD 3540 FOLSOM BOULEVARD, SACRAMENTO, CA 95816 (916) 453-1234 CAPITAL ENGINEERING CONSULTANTS 11020 SUN CENTER DRIVE, RANCHO CORDOVA, CA 95670 (916) 851-3500 ECOM ENGINEERING INC. 1796 TRIBUTE ROAD, SUITE 100 SACRAMENTO, CA (916) 641-5600 BUEHLER & BUEHLER STRUCTURAL ENGINEERS, INC. 600 Q STREET, STE. 200, SACRAMENTO, CA. 95811 (916) 443-0303 W.L. BURLE ENGINEERS, PA 111 S. WALNUT STREET, GREENVILLE, MS 38702 (662) 332-2619 AQUA ENGINEERING, INC. 4803 INNOVATION DRIVE, FORT COLLINS, CO 80525 (970) 229-9668 THE SIERRA WEST GROUP, LLC 2730 GATEWAY OAKS DRIVE, STE. 110 SACRAMENTO, CA. 95833 (916) 925-4000	 NATIONAL CEMETERY ADMINISTRATION	Drawing Title <p style="text-align: center; font-weight: bold;">SITE LAYOUT & DIMENSION PLAN</p> Approved: Director, Office of Construction Management Approved: Director, Project Management Service	Project Title <p style="text-align: center;">LOUISIANA NATIONAL CEMETERY GRAVESITE EXPANSION PHASE 1B</p> Building Number Location LOUISIANA NATIONAL CEMETERY ZACHARY, LOUISIANA	Date: MARCH 22, 2012 Project No. 870CM3023B DRAWING NO. <h2 style="margin: 0;">L-300</h2> Dwg. 17 Of 137



Projects: WUXUD030 No. 4639 Signature _____ Date _____ Revisions _____ Date _____		Consultants in Architecture, Engineering, Planning, and the Environment Sacramento Office 180 Promenade Circle, Suite 300 Sacramento, California 95834 (916) 929-3323 Fax (916) 929-1772	BUEHLER & BUEHLER STRUCTURAL ENGINEERS, INC. 600 Q STREET, STE. 200, SACRAMENTO, CA. 95811 (916) 443-0303 W.L. BURLE ENGINEERS, PA 111 S. WALNUT STREET, GREENVILLE, MS 38702 (662) 332-2619 AQUA ENGINEERING, INC. 4803 INNOVATION DRIVE, FORT COLLINS, CO 80525 (970) 229-9668 THE SIERRA WEST GROUP, LLC 2730 GATEWAY OAKS DRIVE, STE. 110 SACRAMENTO, CA. 95833 (916) 925-4000		CEMETERY ADMINISTRATION	Approved: Director, Office of Construction Management Approved: Director, Project Management Service	Building Number _____ Location LOUISIANA NATIONAL CEMETERY ZACHARY, LOUISIANA	Checked WMR Drawn RUMF	DRAWING NO. L-300 Dwg. 17 Of 137
---	---	---	---	---	----------------------------	---	---	---------------------------	--


PROJECT NO.: DATE: REVISIONS:		THE SIERRA WEST GROUP, LLC 180 Promenade Circle, Suite 300 Sacramento, California 95834 (916) 929-3523 Fax (916) 929-1772	THE SIERRA WEST GROUP, LLC 2730 GATEWAY OAKS DRIVE, STE. 110 SACRAMENTO, CA. 95833 (916) 925-4000		A ADMINISTRATION	Approved: Director, Project Management Service	Location	L-300
							LOUISIANA NATIONAL CEMETERY ZACHARY, LOUISIANA	Dwg. 17 of 137



[illegible]

Projects: WUXUD030 No. 4639 RECEIVED OFFICE OF THE SECRETARY OF THE STATE OF CALIFORNIA Signature: 03/29/13 Received Date: _____ Date: _____	Consultants in Architecture, Engineering, Planning, and the Environment Sacramento Office 180 Promenade Circle, Suite 300 Sacramento, California 95834 (916) 929-3323 Fax (916) 929-1772	BUEHLER & BUEHLER STRUCTURAL ENGINEERS, INC. 600 Q STREET, STE. 200, SACRAMENTO, CA. 95811 (916) 443-0303 W.L. BURLE ENGINEERS, PA 111 S. WALNUT STREET, GREENVILLE, MS 38702 (662) 332-2619 AQUA ENGINEERING, INC. 4803 INNOVATION DRIVE, FORT COLLINS, CO 80525 (970) 229-9668 THE SIERRA WEST GROUP, LLC 2730 GATEWAY OAKS DRIVE, STE. 110 SACRAMENTO, CA. 95833 (916) 925-4000	 CEMETERY ADMINISTRATION	Approved: Director, Office of Construction Management Approved: Director, Project Management Service	Building Number Checked WMR Drawn RUMF	DRAWING NO. L-300 Dwg. 17 Of 137
	Revisions	Date				

Revisions 		Carter Burgess A Wholly Owned Subsidiary of Jacobs Consultants in Architecture, Engineering, Planning, and the Environment Sacramento Office 180 Promenade Circle, Suite 300 Sacramento, California 95834 (916) 929-3523 Fax (916) 929-1772	Subconsultant List			NATIONAL CEMETERY ADMINISTRATION	Drawing Title	Project Title		Date:	
							SITE LAYOUT & DIMENSION PLAN		LOUISIANA NATIONAL CEMETERY GRAVESITE EXPANSION PHASE 1B		MARCH 22, 2012
			Approved: Director, Office of Construction Management				Building Number	Checked WMR	Drawn JUMF	Project No. 870CM3023B	
			Approved: Director, Project Management Service				Location LOUISIANA NATIONAL CEMETERY ZACHARY, LOUISIANA		DRAWING NO. L-300		
									Dwg. 17 of 137		

	Carter-Burgess A Wholly Owned Subsidiary of Jacobs Consultants in Architecture, Engineering, Planning, and the Environment Sacramento Office 180 Promenade Circle, Suite 300 Sacramento, California 95834 (916) 929-3323 Fax (916) 929-1772	CAPITAL ENGINEERING CONSULTANTS 11020 SUN CENTER DRIVE, RANCHO CORDOVA, CA 95670 (916) 851-3500 ECOM ENGINEERING INC. 1796 TRIBUTE ROAD, SUITE 100 SACRAMENTO, CA (916) 641-5600 BUEHLER & BUEHLER STRUCTURAL ENGINEERS, INC. 600 Q STREET, STE. 200, SACRAMENTO, CA. 95811 (916) 443-0303 W.L. BURLIE ENGINEERS, PA 111 S. WALNUT STREET, GREENVILLE, MS 38702 (662) 332-2619 AQUA ENGINEERING, INC. 4803 INNOVATION DRIVE, FORT COLLINS, CO 80525 (970) 229-9668 THE SIERRA WEST GROUP, LLC 2730 GATEWAY OAKS DRIVE, STE. 110 SACRAMENTO, CA. 95833 (916) 925-4000		NATIONAL CEMETERY ADMINISTRATION	SITE LAYOUT & DIMENSION PLAN Approved: Director, Office of Construction Management	LOUISIANA NATIONAL CEMETERY GRAVESITE EXPANSION PHASE 1B Building Number _____ Checked <u>WMR</u> Drawn <u>RMMF</u> Location LOUISIANA NATIONAL CEMETERY ZACHARY, LOUISIANA	Project No. 870CM3023B DRAWING No. L-300 Dwg. 17 of 137
		Approved: Director, Project Management Service					

Projects: WUXUD030 No. 4639 REBELLION ESTATE No. 4639 Signature 03/29/13 Issued Date Date	Consultants in Architecture, Engineering, Planning, and the Environment Sacramento Office 180 Promenade Circle, Suite 300 Sacramento, California 95834 (916) 929-3323 Fax (916) 929-1772	BUEHLER & BUEHLER STRUCTURAL ENGINEERS, INC. 600 Q STREET, STE. 200, SACRAMENTO, CA. 95811 (916) 443-0303 W.L. BURLE ENGINEERS, PA 111 S. WALNUT STREET, GREENVILLE, MS 38702 (662) 332-2619 AQUA ENGINEERING, INC. 4803 INNOVATION DRIVE, FORT COLLINS, CO 80525 (970) 229-9668 THE SIERRA WEST GROUP, LLC 2730 GATEWAY OAKS DRIVE, STE. 110 SACRAMENTO, CA. 95833 (916) 925-4000	 CEMETERY ADMINISTRATION	Approved: Director, Office of Construction Management Approved: Director, Project Management Service	Building Number Checked WMR Drawn RUMF	DRAWING NO. L-300 Dwg. 17 Of 137
	Revisions	Date	Location LOUISIANA NATIONAL CEMETERY ZACHARY, LOUISIANA	Approved: Director, Office of Construction Management	Building Number	DRAWING NO.
	Revisions	Date	Location	Approved: Director, Office of Construction Management	Building Number	DRAWING NO.
	Revisions	Date	Location	Approved: Director, Office of Construction Management	Building Number	DRAWING NO.
	Revisions	Date	Location	Approved: Director, Office of Construction Management	Building Number	DRAWING NO.

3. Project Revisions	Date	 (916) 929-3323 Fax (916) 929-1772		Approved: Director, Project Management Service	Location LOUISIANA NATIONAL CEMETERY ZACHARY, LOUISIANA	E 500 Dwg. 17 Of 137

	1	2	3	4	5	6	7	8	9	
<div style="display: flex; justify-content: space-between; align-items: center;"> <div> <p>–</p> </div> <div> <p>SITE LEGEND</p> </div> <div> </div> </div>										

W MT. PLEASANT - (ZACHARY ROAD) (PAVED)

ALUMINUM DISK IN CONCRETE
BENCHMARK PNC #2
ELEV=87.55' NAVD83


P.I.C./ADMINISTRATION
SEE ENLARGEMENT PLAN
SHEET L-303

PHASE 1A EXISTING

KEY	SITE ELEMENT	DETAIL REFERENCE
[A]	Asphalt Roadway Paving	Refer to Plan & Profile (88) (507) Sheets (L-400 Series)
[B]	Mountable Curb and Gutter	(81) (803)
[C]	Flush Concrete Curb	(81) (803)
[C]	Control Joint	(F8) (803)
[D]	Barrier Curb	(81) (803)
[E]	Reversed Mountable Curb	(81) (803)
[E]	Expansion Joint	(F8) (803)
[F]	Wheel Stop	(A7) (803)
[G]	Concrete Walk Paving and Joints	(F8) (803) (E8) (507)
[H]	Gravel Drainage Rock at Admin/PIC	(F4) (804)
[I]	Concrete Housekeeping Pad	(11) (100-22) Refer to Structural Details
[J]	6' Bench on Concrete Pad	(F7) (806) (B5) (806) (B8) (806)
[K]	Columbarium Wall	(F2) (804)
[L]	Turf/Lawn Area	Refer to Planting Plans (L-900 Series)
[M]	Section Marker	(E1) (703)
[N]	Sign - Directional, Traffic Regulatory, Identification	Refer to Signage Plans & Details (L-700 Series)
[O]	Watering Station with Curb Transition	(C1) (805) (F1) (805) (F4) (805)
[P]	Planter Area - Shrubs, Groundcover & Bark Mulch	Refer to Planting Plans (L-900 Series)
[Q]	80' Flag Pole (Flag Assembly Area)	(C1) (804)
[R]	30' Flag Pole (MIA/POW)	(F5) (804) Add-Alternate #4 (Relocated from Sections 1 & 2)
[S]	Concrete Stairs at Assembly Area	(A1) (C1) (F3) (804) (804) (804) Add-Alternate #3
[T]	Handrails	(C1) (804) Add-Alternate #3
[U]	Cheekwalls	(C1) (804) (C4) (804)
[V]	Curb transition	(A1) (803)
[W]	Curb Cut	(B7) (803)
[X]	Vee (Valley) Gutter	(B1) (803)
[Y]	Concrete Mow Curb	(F4) (803)
[Z]	Steel Bollard - See Arch Sheet 3000-1 for Layout Locations	(F8) (801-2)
[AA]	4" White Painted Stripe	Refer to Specifications
[AB]	Accessible Parking Area	(B4) (803)
[AC]	HVAC Condensing Units & Pads	Refer to Mechanical Plans
[AD]	Screen Wall	Refer to Architectural Plans
[AE]	8' Bench	(F3) (806)
[AF]	10' Bench	(F3) (806)
[AG]	12' Bench	(F3) (806)
[AH]	8' Bench - Backless	(F1) (806)
[AI]	Gravesite Grid Monument	(F3) (703)
[AJ]	Cortege Lane Number (Painted)	Refer to Specifications



KEY PLAN

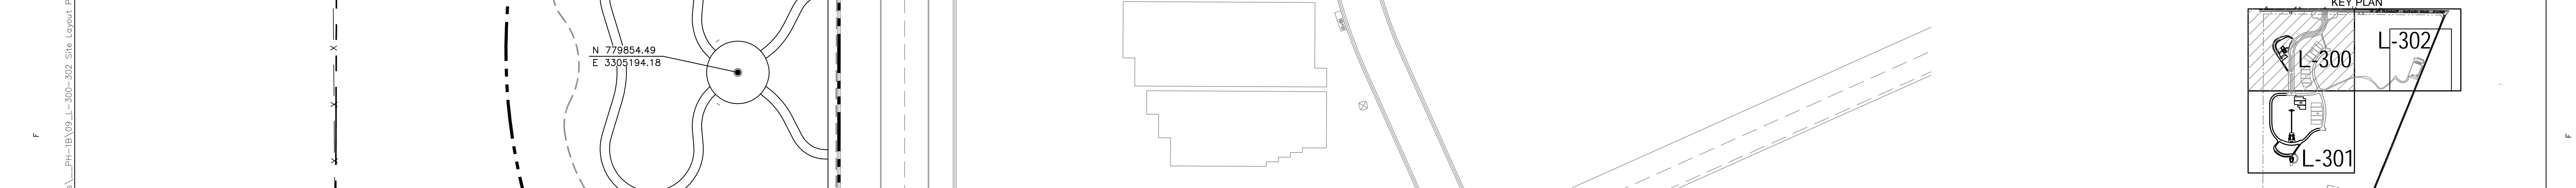

CONSTRUCTION DOCUMENTS