
 
 




CEILING LEGEND


- 


SURFACE MOUNTED FLUORESCENT LIGHT FIXTURE - SEE ELECTRICAL DRAWINGS
- 

 
2'x2' RECESSED FLUORESCENT LIGHT FIXTURE - SEE ELECTRICAL DRAWINGS
- 


2'x4' RECESSED FLUORESCENT LIGHT FIXTURE - SEE ELECTRICAL DRAWINGS
- 


1' x 4' FLUORESCENT LIGHT
- 


RECESSED DOWNLIGHT FIXTURE - SEE ELECTRICAL DRAWINGS
- 

 
TUBE SKYLIGHT DIFFUSER WITHOUT DIMMER, U.O.N.
- 

 
PAINTED GYPSUM BOARD CEILING ON CEILING JOISTS, SEE STRUCTURAL
- 

ACOUSTICAL CEILING PANELS AND GRID SUSPENSION SYSTEM
- 

24'x24' ACCESS PANEL, COORDINATE LOCATION WITH DIMMERS
- 

MECHANICAL DIFFUSER - SEE MECHANICAL DRAWINGS
- 


MECHANICAL EXHAUST VENT - SEE MECHANICAL DRAWINGS
- 

SOFFIT VENT
- 

CEMENT BOARD SOFFIT


GENERAL NOTES:

1. GRIDS SHALL BE LOCATED SO MECHANICAL DIFFUSER BOXES DO NOT CONFLICT WITH TRUSSES
2. DIMENSIONS ARE TO FACE OF FINISH, U.O.N.
3. ALL GRIDS ARE CENTERED IN BOTH DIRECTIONS, U.O.N.
4. ELECTRICAL AND MECHANICAL FIXTURES AND DEVICES ARE SHOWN ON REFLECTED CEILING MECHANICAL DRAWINGS FOR SPECIFIC DEVICE AND FIXTURE TYPE DESIGNATIONS.
5. FOR TYPICAL CEILING DETAILS SEE SHEET 1400-14
6. FOR CEILING JOINTS SEE STRUCTURAL.

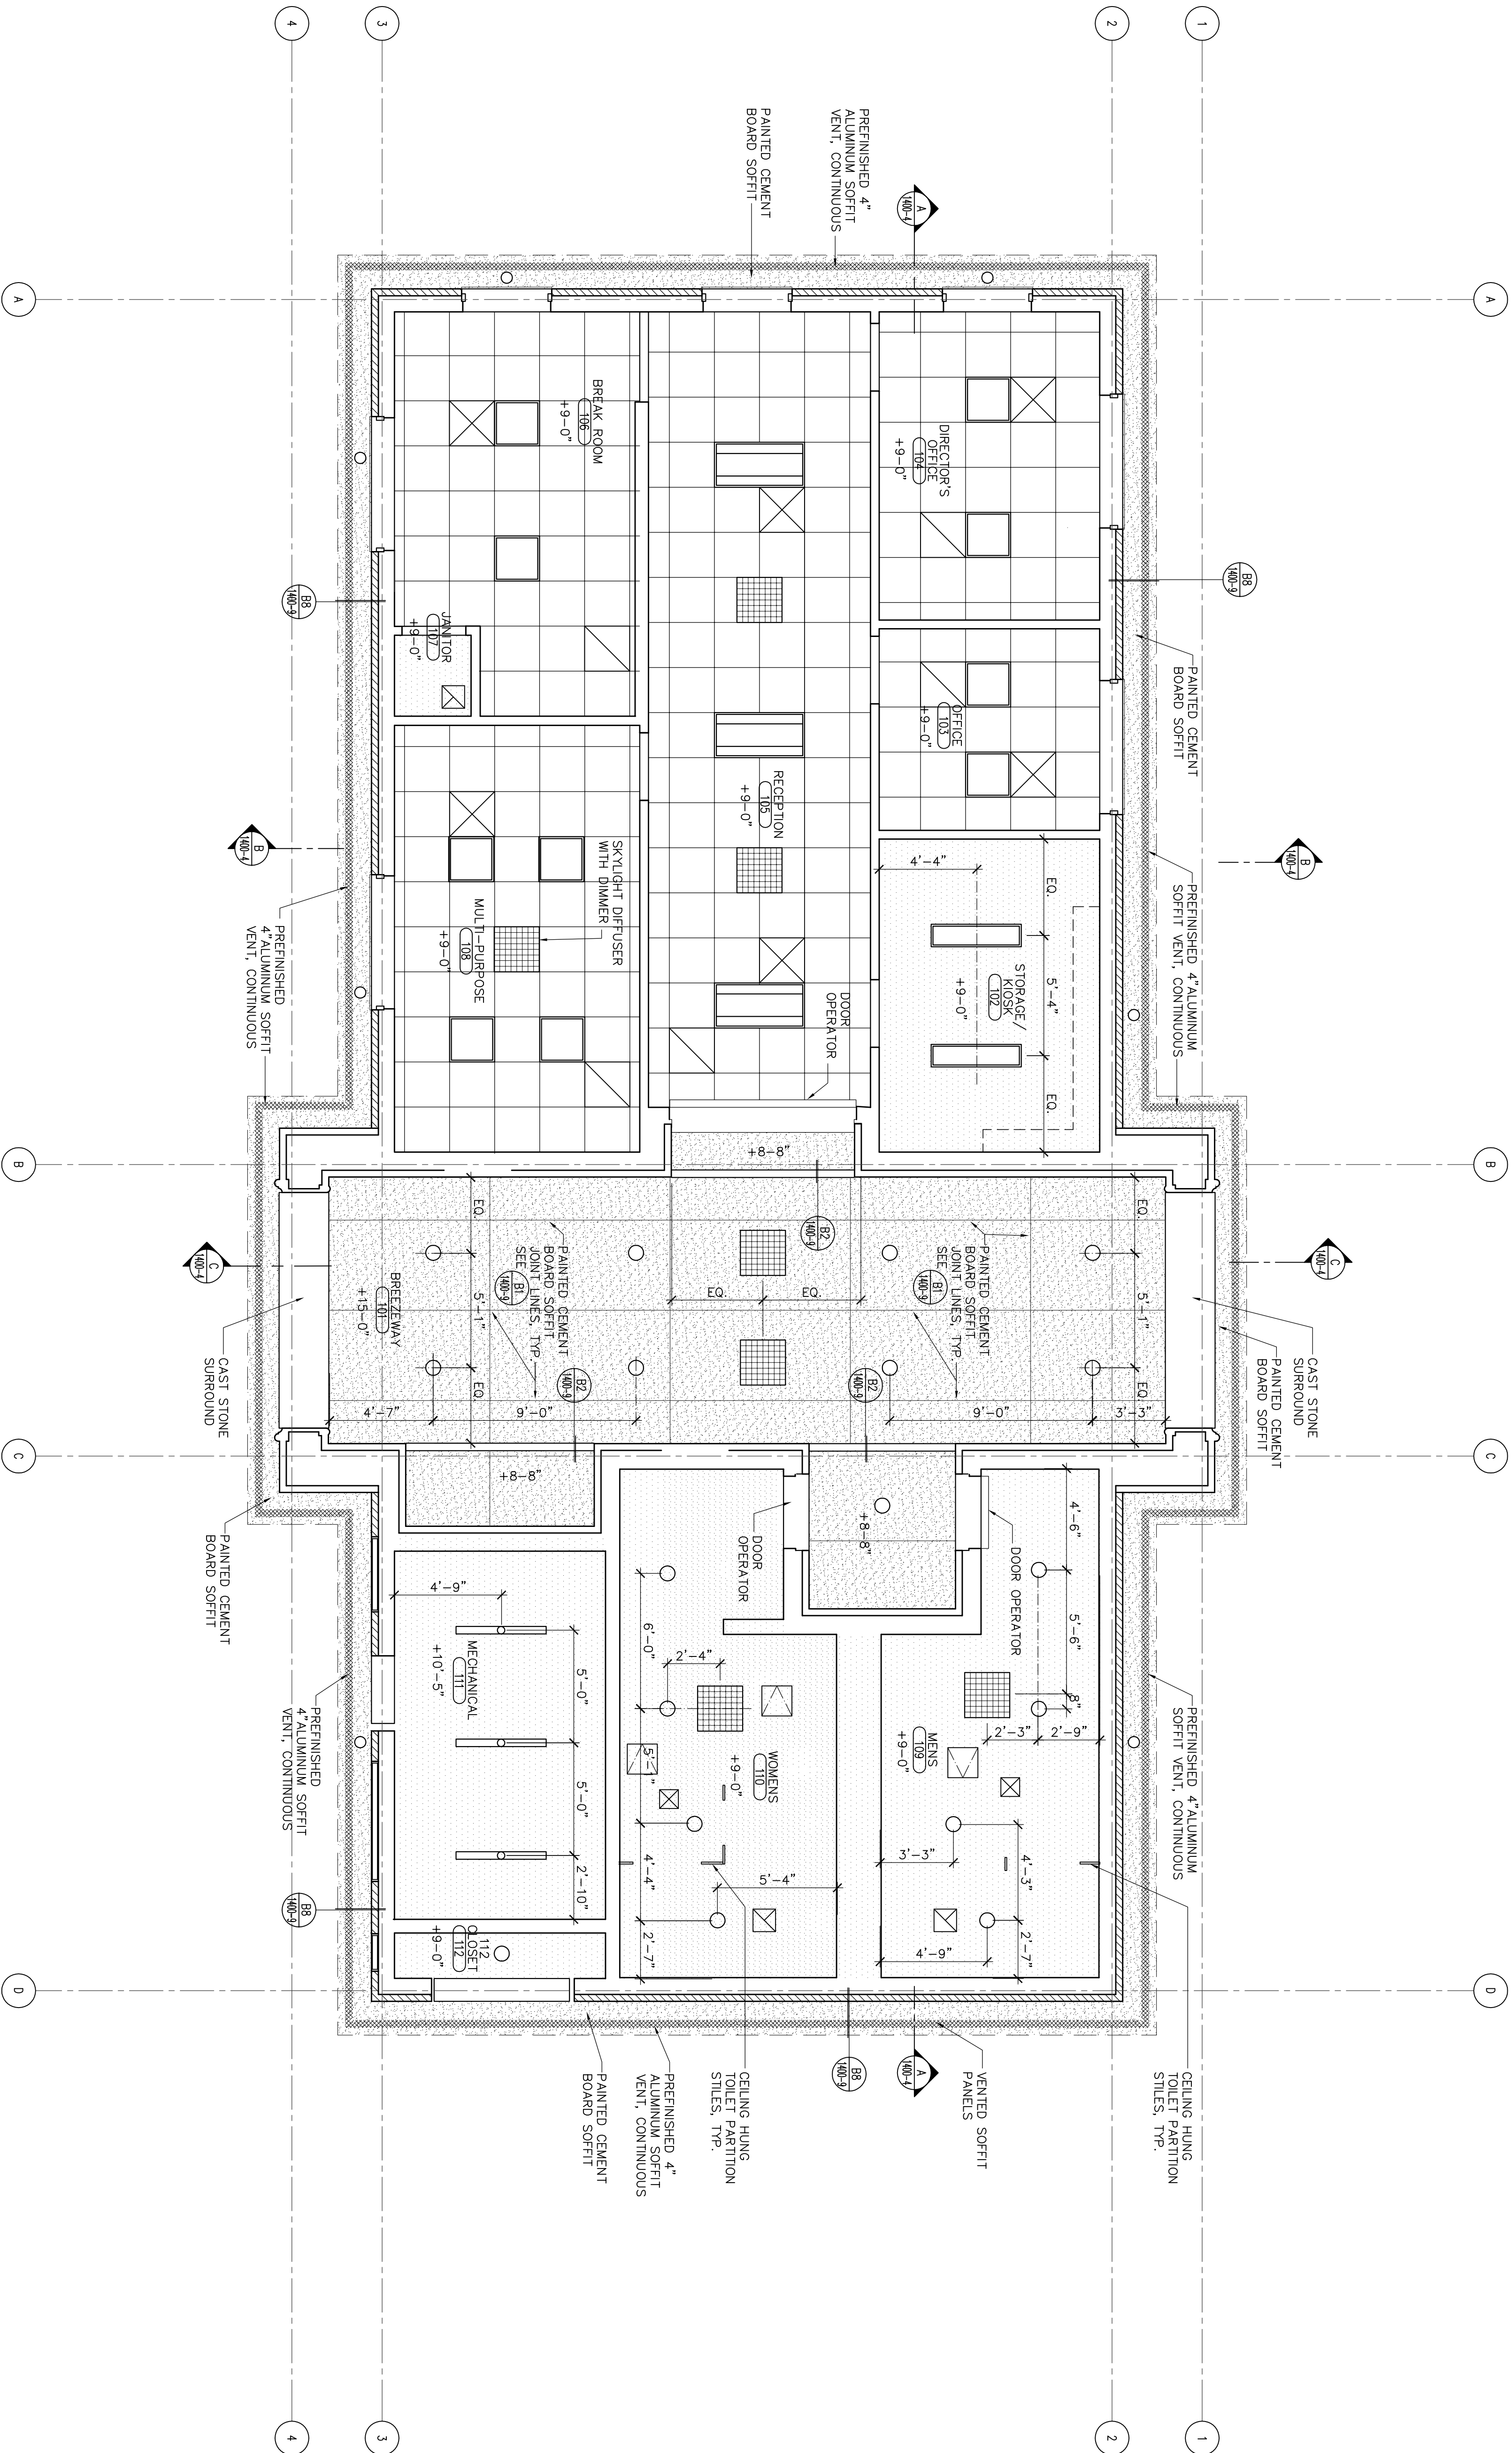

1 REFLECTED CEILING PLAN

1/4"=1'-0"

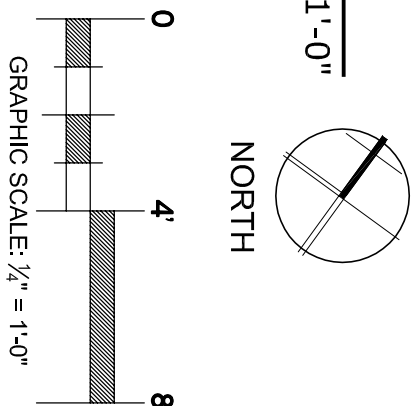


CONSTRUCTION DOCUMENTS

Subconsultant List	
DREYFUS & BLACKFORD	3540 TOLSON BOULEVARD, SACRAMENTO, CA 95816 (916) 453-1234
CAPITAL ENGINEERING CONSULTANTS	11020 SUN CENTER DRIVE, RANCHO CORDOVA, CA 95670 (916) 851-3500
ECOM ENGINEERING, INC.	1796 TRIBUNE ROAD, SUITE 100, SACRAMENTO, CA (916) 641-5600
BUETLER & BUETLER STRUCTURAL ENGINEERS, INC.	600 Q STREET, STE. 200, SACRAMENTO, CA 95811 (916) 443-0303
W.L. BURE ENGINEERS, PA	111 S. WALNUT STREET, GREENVILLE, MS 38702 (662) 332-2619
ADVA ENGINEERING, INC.	4803 INNOVATION DRIVE, FORT COLLINS, CO 80525 (970) 229-9668
THE SIERRA WEST GROUP, LLC	2730 GATEWAY OAKS DRIVE, STE. 110, SACRAMENTO, CA 95833 (916) 925-4000

Drawing Title	
P.I.C./ADMINISTRATION REFLECTED CEILING PLAN	
Approved: Director, Office of Construction Management	Building Number
Approved: Director, Project Management Service	Location

Project Title	
LOUISIANA NATIONAL CEMETERY GRAVESITE EXPANSION PHASE 1B	
Date: MARCH 22, 2012	Project No. 870CM3023B
DRAWING NO. 1400-7	Dwg. 73 of 137

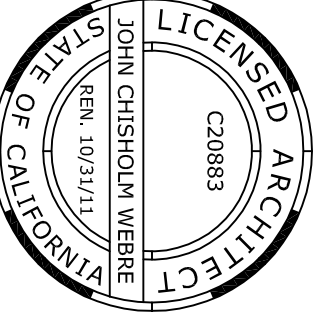

Carter Burgess
A Wholly Owned Subsidiary of Jacobs
Consultants in Architecture, Engineering,
Planning, and the Environment
Sacramento Office
1000 Capitol Mall, Suite 300
Sacramento, California 95834
(916) 924-5323 Fax (916) 924-1772