


QC	
INI	%


A
B
C
D
E
F

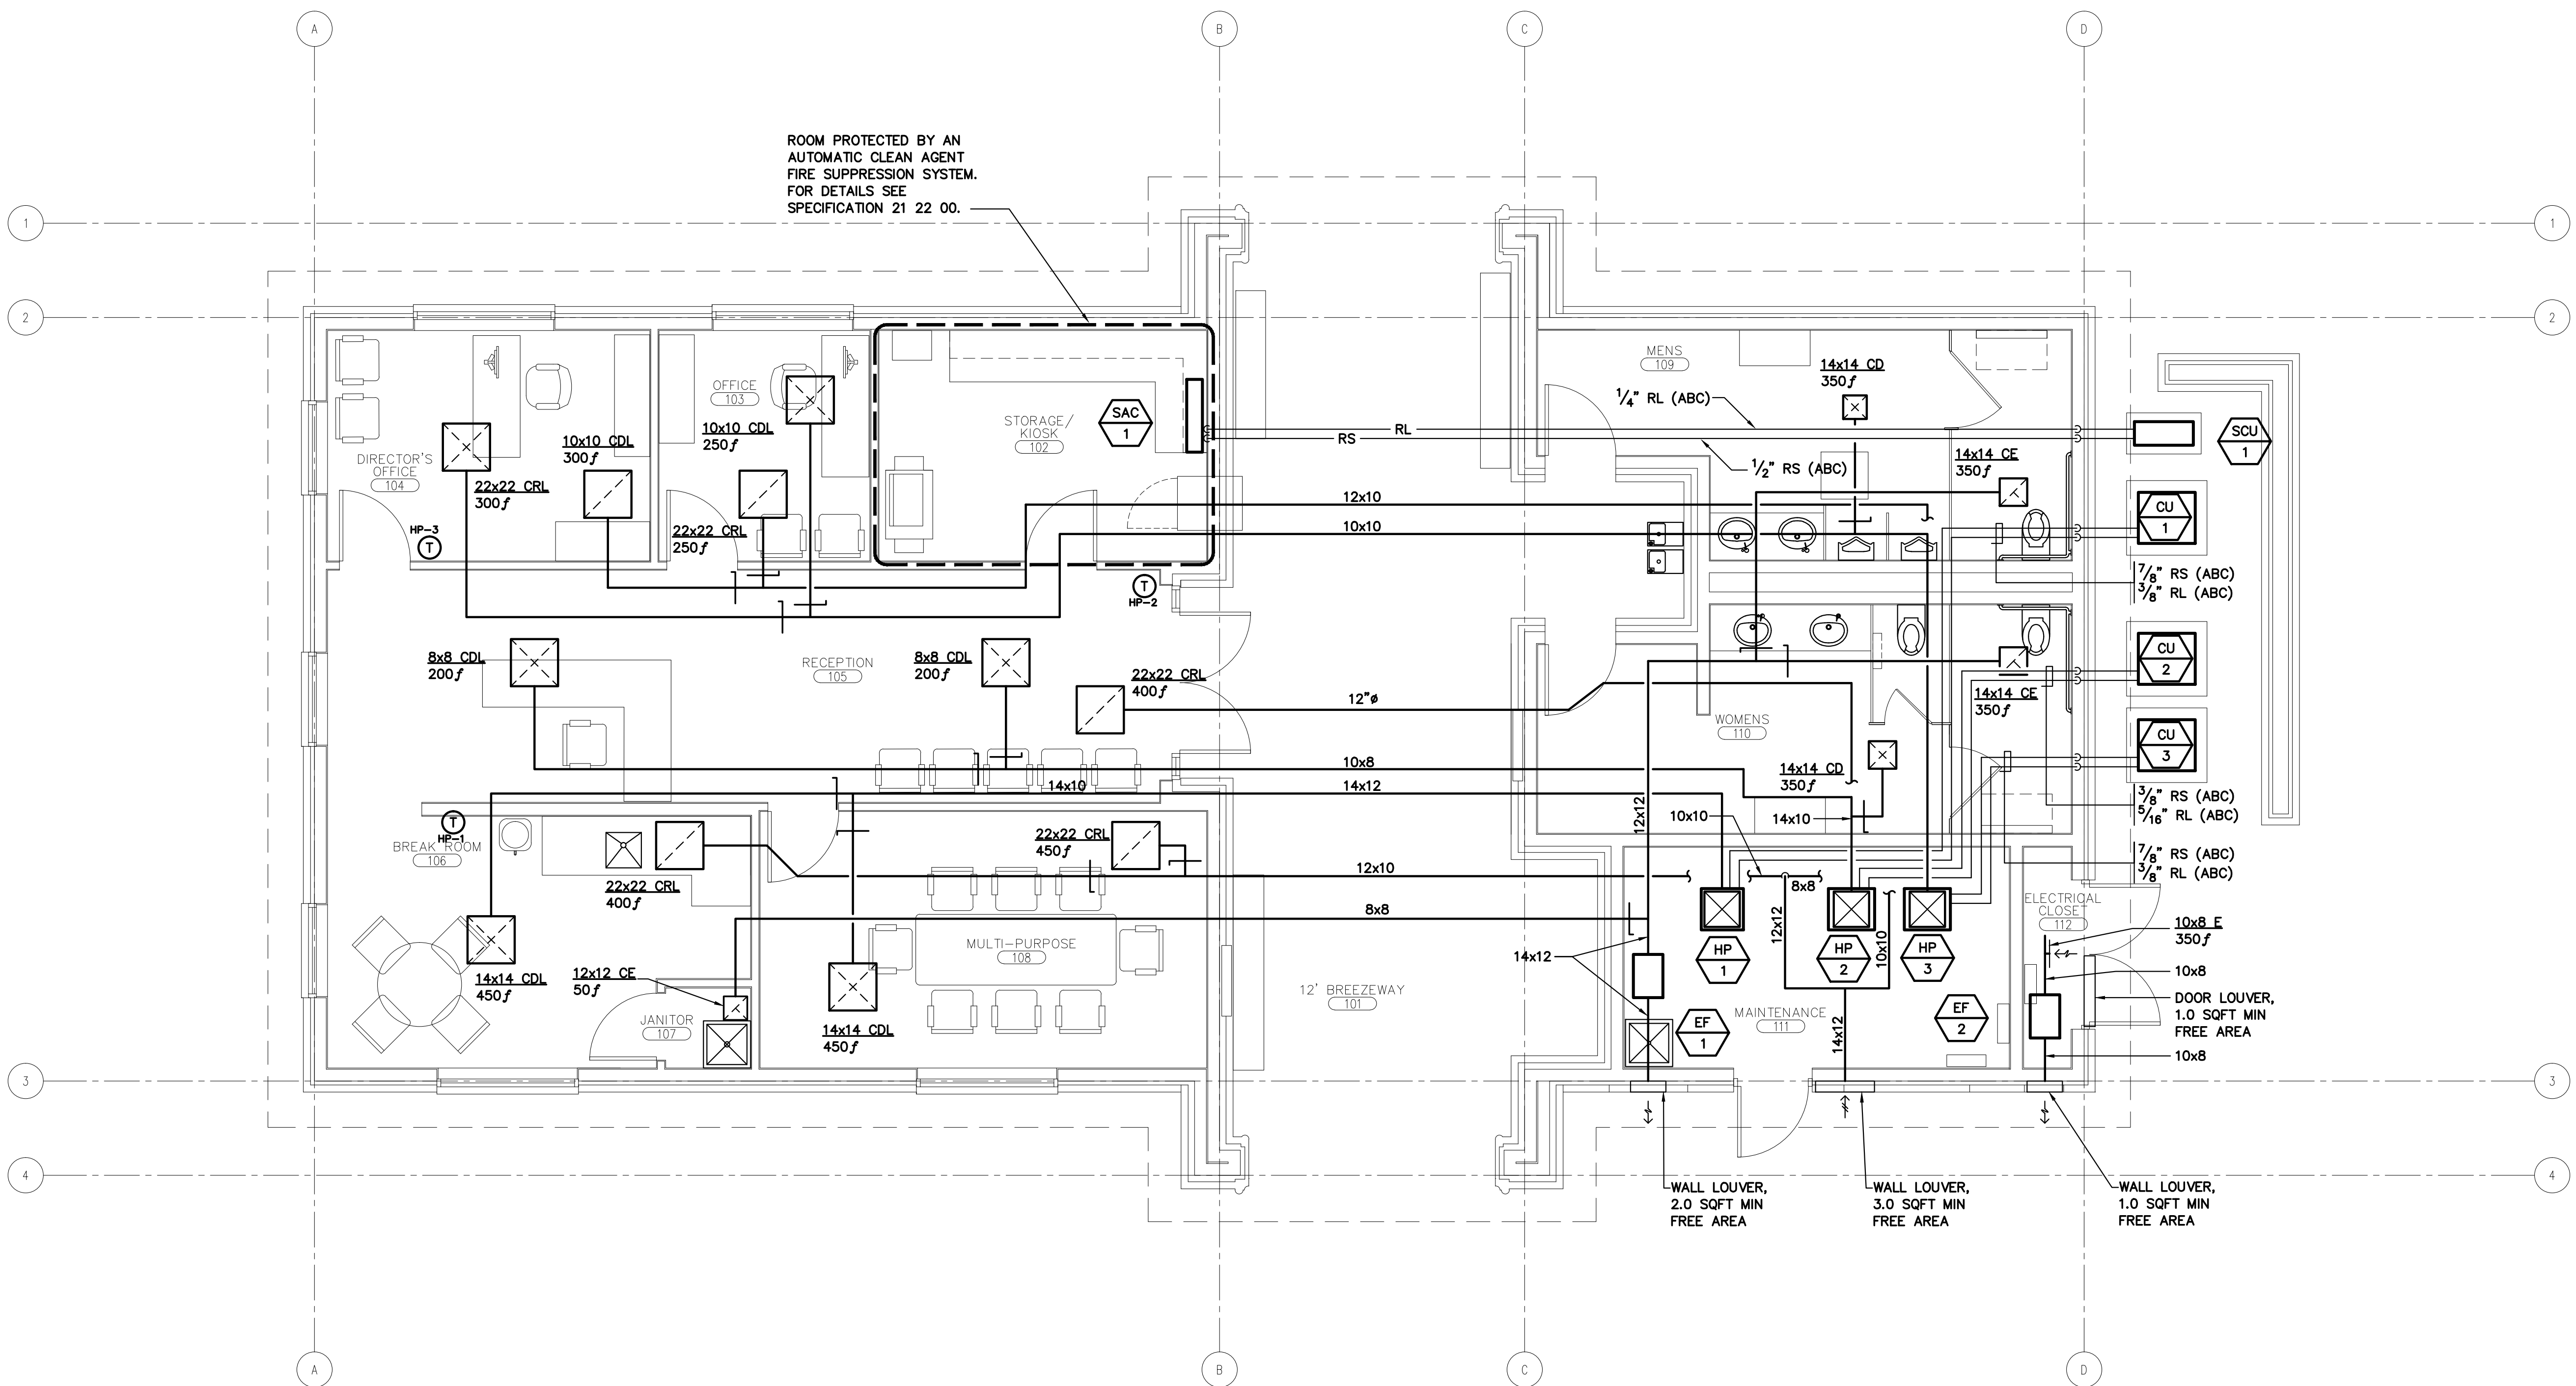

- GENERAL NOTES:**
- FOR HEAT PUMP MOUNTING, FILTER RACK, AND DUCT CONNECTION DETAILS, SEE 1/H-3 & 2/H-3.
 - CAREFULLY COORDINATE DUCT ROUTING THROUGH CUSTOM TRUSSES WITH TRUSS MANUFACTURER AND STRUCTURAL PLANS.
 - SEE DUCT BRANCH TABLE ON SHEET H-1 FOR DUCT SIZES TO INDIVIDUAL DIFFUSERS AND GRILLES.

HVAC FLOOR PLAN - P.I.C./ADMINISTRATION
SCALE : 1/4" = 1'-0"

1
1400-H1

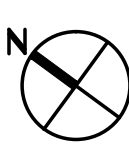

Revisions	Date



CAPITAL ENGINEERING CONSULTANTS, INC.
RANCHO CORDOVA, CALIFORNIA
BZ/AD
DESIGNER/DRAWN
10/03/00
PROJECT NO.



Carter-Burgess
A Wholly Owned Subsidiary of Jacobs
Consultants in Architecture, Engineering, Planning, and the Environment
Sacramento Office
180 Promenade Circle, Suite 300
Sacramento, California 95834
(916) 929-3323 Fax (916) 929-1772

Subconsultant List	
DREYFUS & BLACKFORD	3540 FOLSOM BOULEVARD, SACRAMENTO, CA 95816 (916) 453-1234
CAPITAL ENGINEERING CONSULTANTS	11020 SUN CENTER DRIVE, RANCHO CORDOVA, CA 95670 (916) 851-3500
ECOM ENGINEERING INC.	1796 TRIBUTE ROAD, SUITE 100 SACRAMENTO, CA (916) 641-5600
BUEHLER & BUEHLER ASSOCIATES	600 Q STREET, STE. 200, SACRAMENTO, CA. 95814 (916) 443-0303
W.L. BURLE ENGINEERS, PA	111 S. WALNUT STREET, GREENVILLE, MS 38702 (662) 332-2619
AQUA ENGINEERING, INC.	4803 INNOVATION DRIVE, FORT COLLINS, CO 80525 (970) 229-9668
THE SIERRA WEST GROUP, LLC	2730 GATEWAY OAKS DRIVE, STE. 110 SACRAMENTO, CA. 95833 (916) 925-4000



N ATIONAL
C EMETERY
A DMINISTRATION

Drawing Title HVAC FLOOR PLAN - P.I.C./ADMINISTRATION	
Approved: Director, Office of Construction Management	
Approved: Director, Project Management Service	

Project Title LOUISIANA NATIONAL CEMETERY GRAVESITE EXPANSION PHASE 1B	
Building Number 1400	Checked
Location LOUISIANA NATIONAL CEMETERY ZACHARY, LOUISIANA	Drawn

Date: MARCH 22, 2012
Project No. 870CM3023B
DRAWING NO. 1400-H1
Dwg. 114 of 137

CONSTRUCTION DOCUMENTS

A
B
C
D
E
F