


QC	
INI	%

GENERAL NOTES:  
1. SEE FIXTURE CONNECTION SCHEDULE ON SHEET P-2 FOR PIPE SIZE TO INDIVIDUAL FIXTURES SHOWN ON PLAN UNLESS OTHERWISE NOTED.


CONSTRUCTION DOCUMENTS

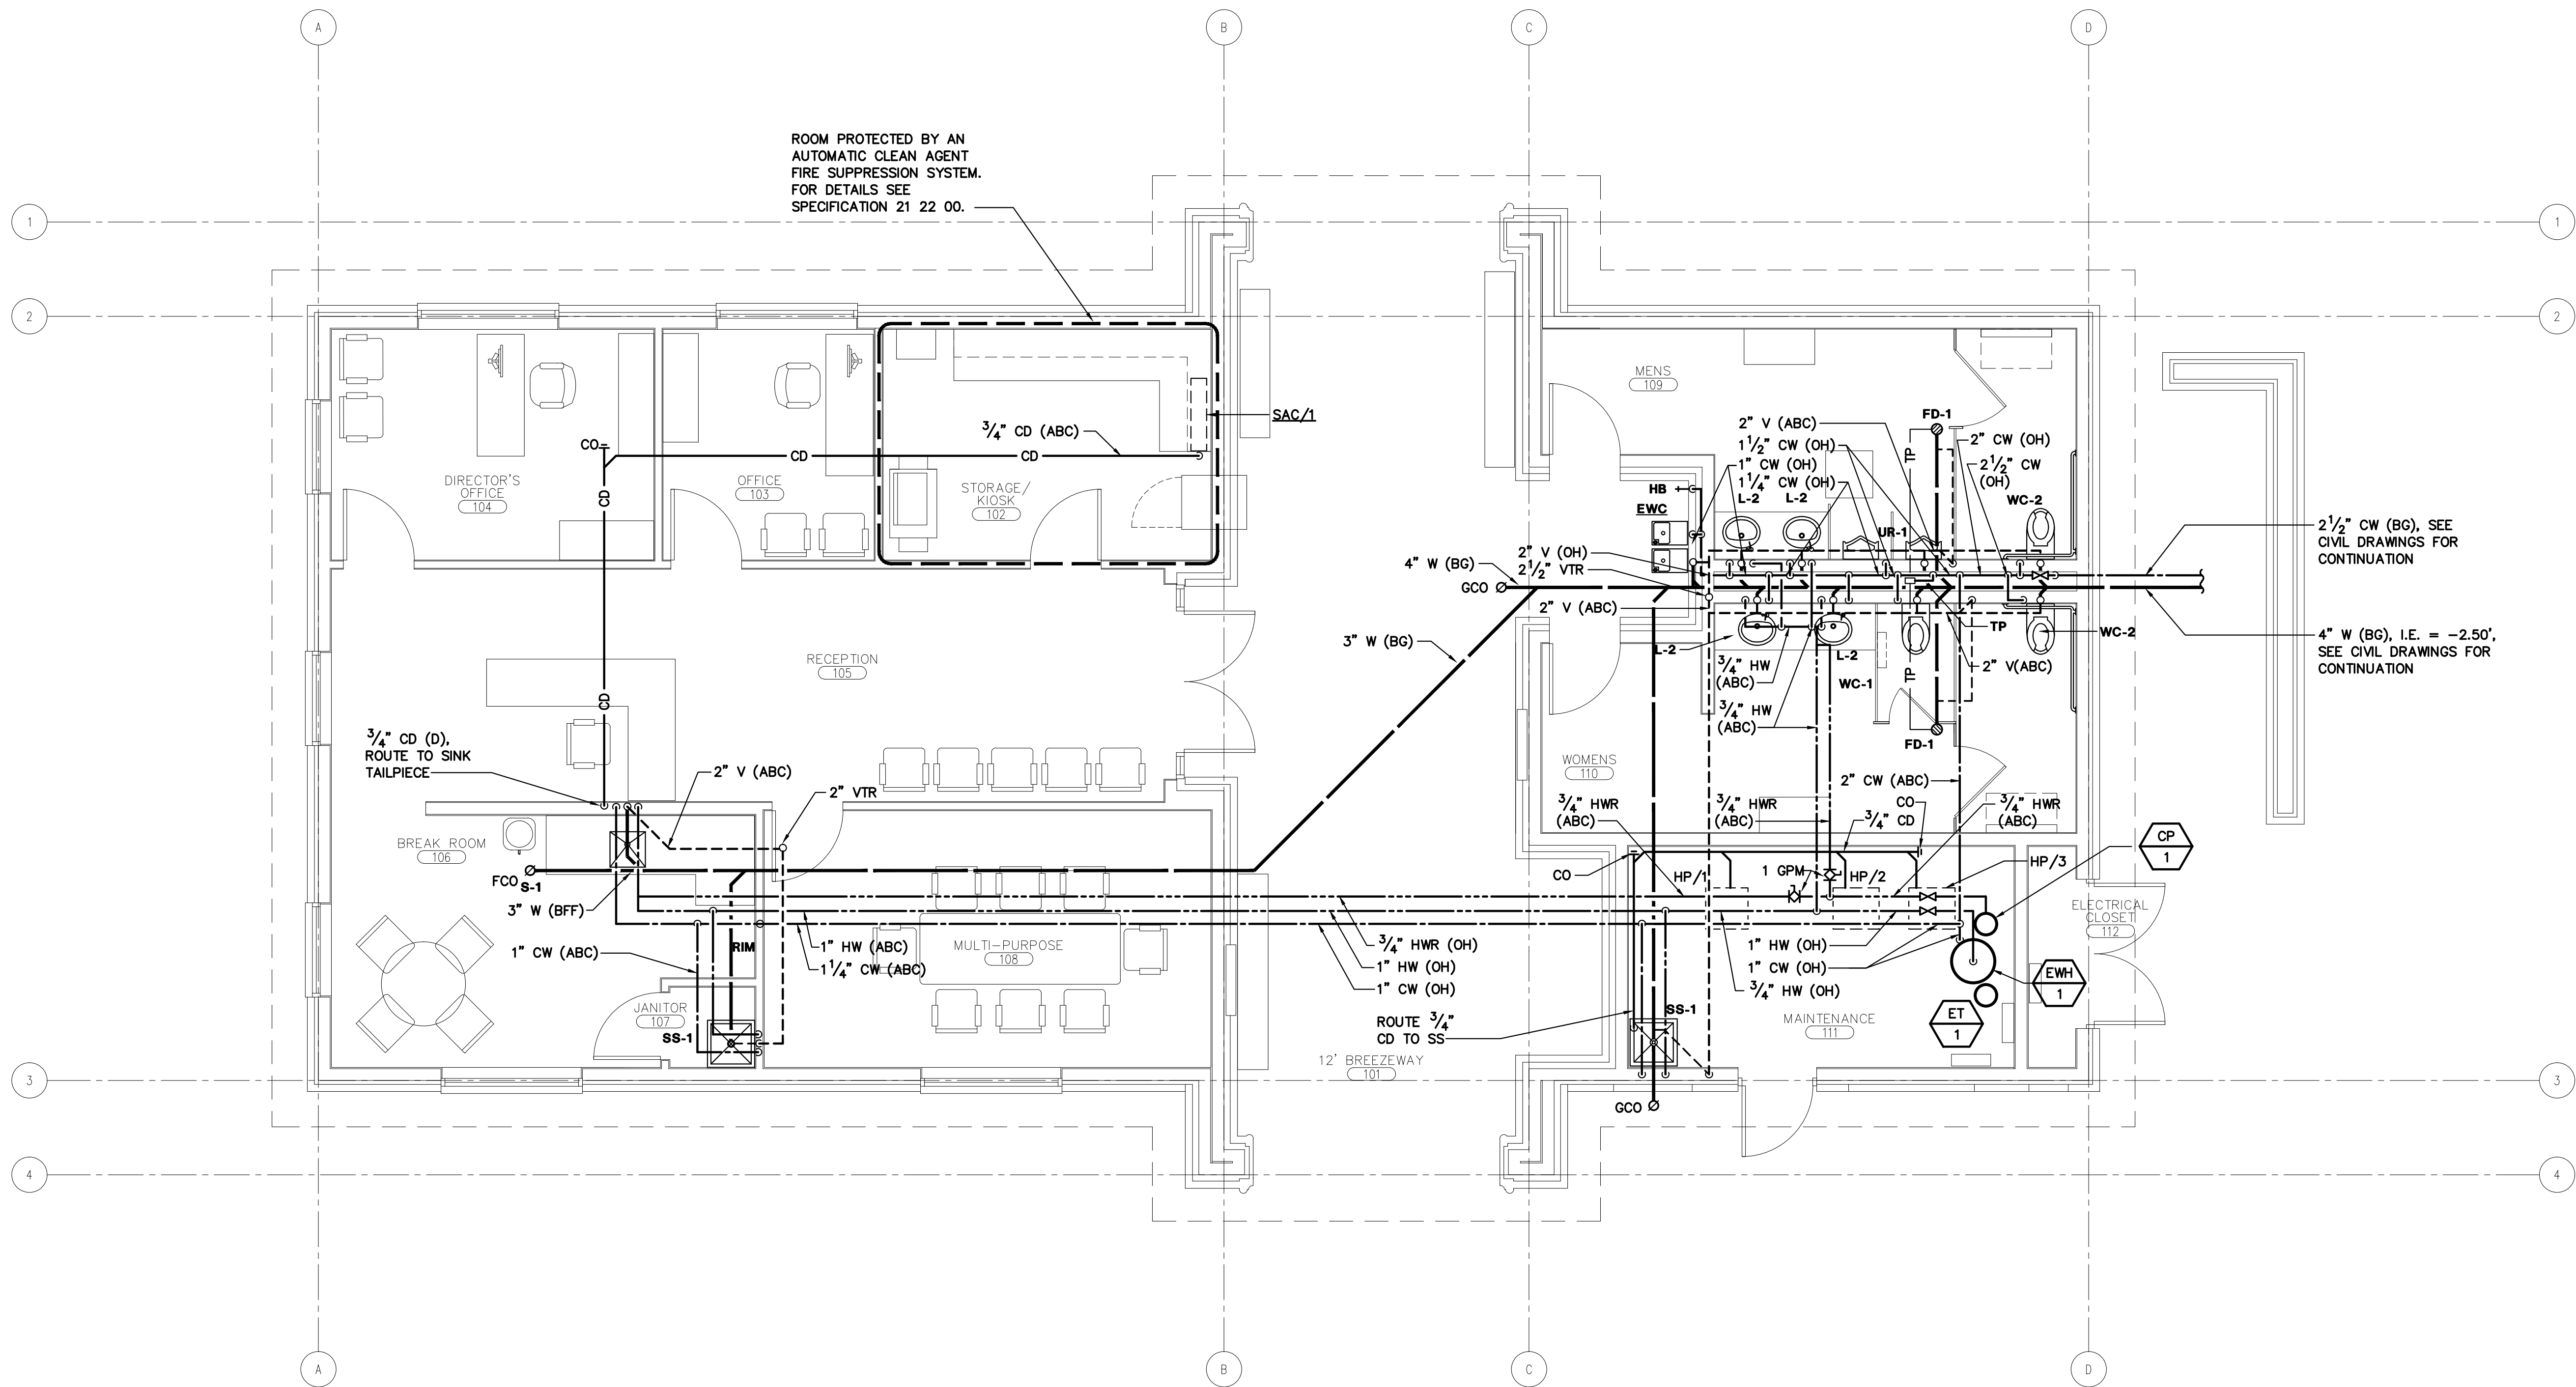

PLUMBING FLOOR PLAN - P.I.C./ADMINISTRATION

SCALE : 1/4" = 1'-0"

1  
1400-P1

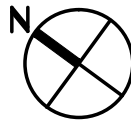

CONSTRUCTION DOCUMENTS

Revisions	Date



**CAPITAL ENGINEERING  
CONSULTANTS, INC.**  
RANCHO CORDOVA, CALIFORNIA  
BZ/AD  
DESIGNER/DRAWN  
10/03/00  
PROJECT NO.



**Carter-Burgess**  
A Wholly Owned Subsidiary of Jacobs  
Consultants in Architecture, Engineering,  
Planning, and the Environment  
Sacramento Office  
180 Promenade Circle, Suite 300  
Sacramento, California 95834  
(916) 929-3323 Fax (916) 929-1772

Subconsultant List	
DREYFUS & BLACKFORD	3540 FOLSOM BOULEVARD, SACRAMENTO, CA 95816 (916) 453-1234
CAPITAL ENGINEERING CONSULTANTS	11020 SUN CENTER DRIVE, RANCHO CORDOVA, CA 95670 (916) 851-3500
ECOM ENGINEERING INC.	1796 TRIBUTE ROAD, SUITE 100 SACRAMENTO, CA (916) 641-5600
BUEHLER & BUEHLER ASSOCIATES	600 Q STREET, STE. 200, SACRAMENTO, CA. 95814 (916) 443-0303
W.L. BURLE ENGINEERS, PA	111 S. WALNUT STREET, GREENVILLE, MS 38702 (662) 332-2619
AQUA ENGINEERING, INC.	4803 INNOVATION DRIVE, FORT COLLINS, CO 80525 (970) 229-9668
THE SIERRA WEST GROUP, LLC	2730 GATEWAY OAKS DRIVE, STE. 110 SACRAMENTO, CA. 95833 (916) 925-4000



N ATIONAL  
C EMETERY  
A DMINISTRATION

Drawing Title PLUMBING FLOOR PLAN - P.I.C./ADMINISTRATION	
Approved: Director, Office of Construction Management	
Approved: Director, Project Management Service	

Project Title LOUISIANA NATIONAL CEMETERY GRAVESITE EXPANSION PHASE 1B	
Building Number 1400	Checked 
Location LOUISIANA NATIONAL CEMETERY ZACHARY, LOUISIANA	Drawn 

Date: MARCH 22, 2012
Project No. 870CM3023B
DRAWING NO. 1400-P1
Dwg. 120 of 137