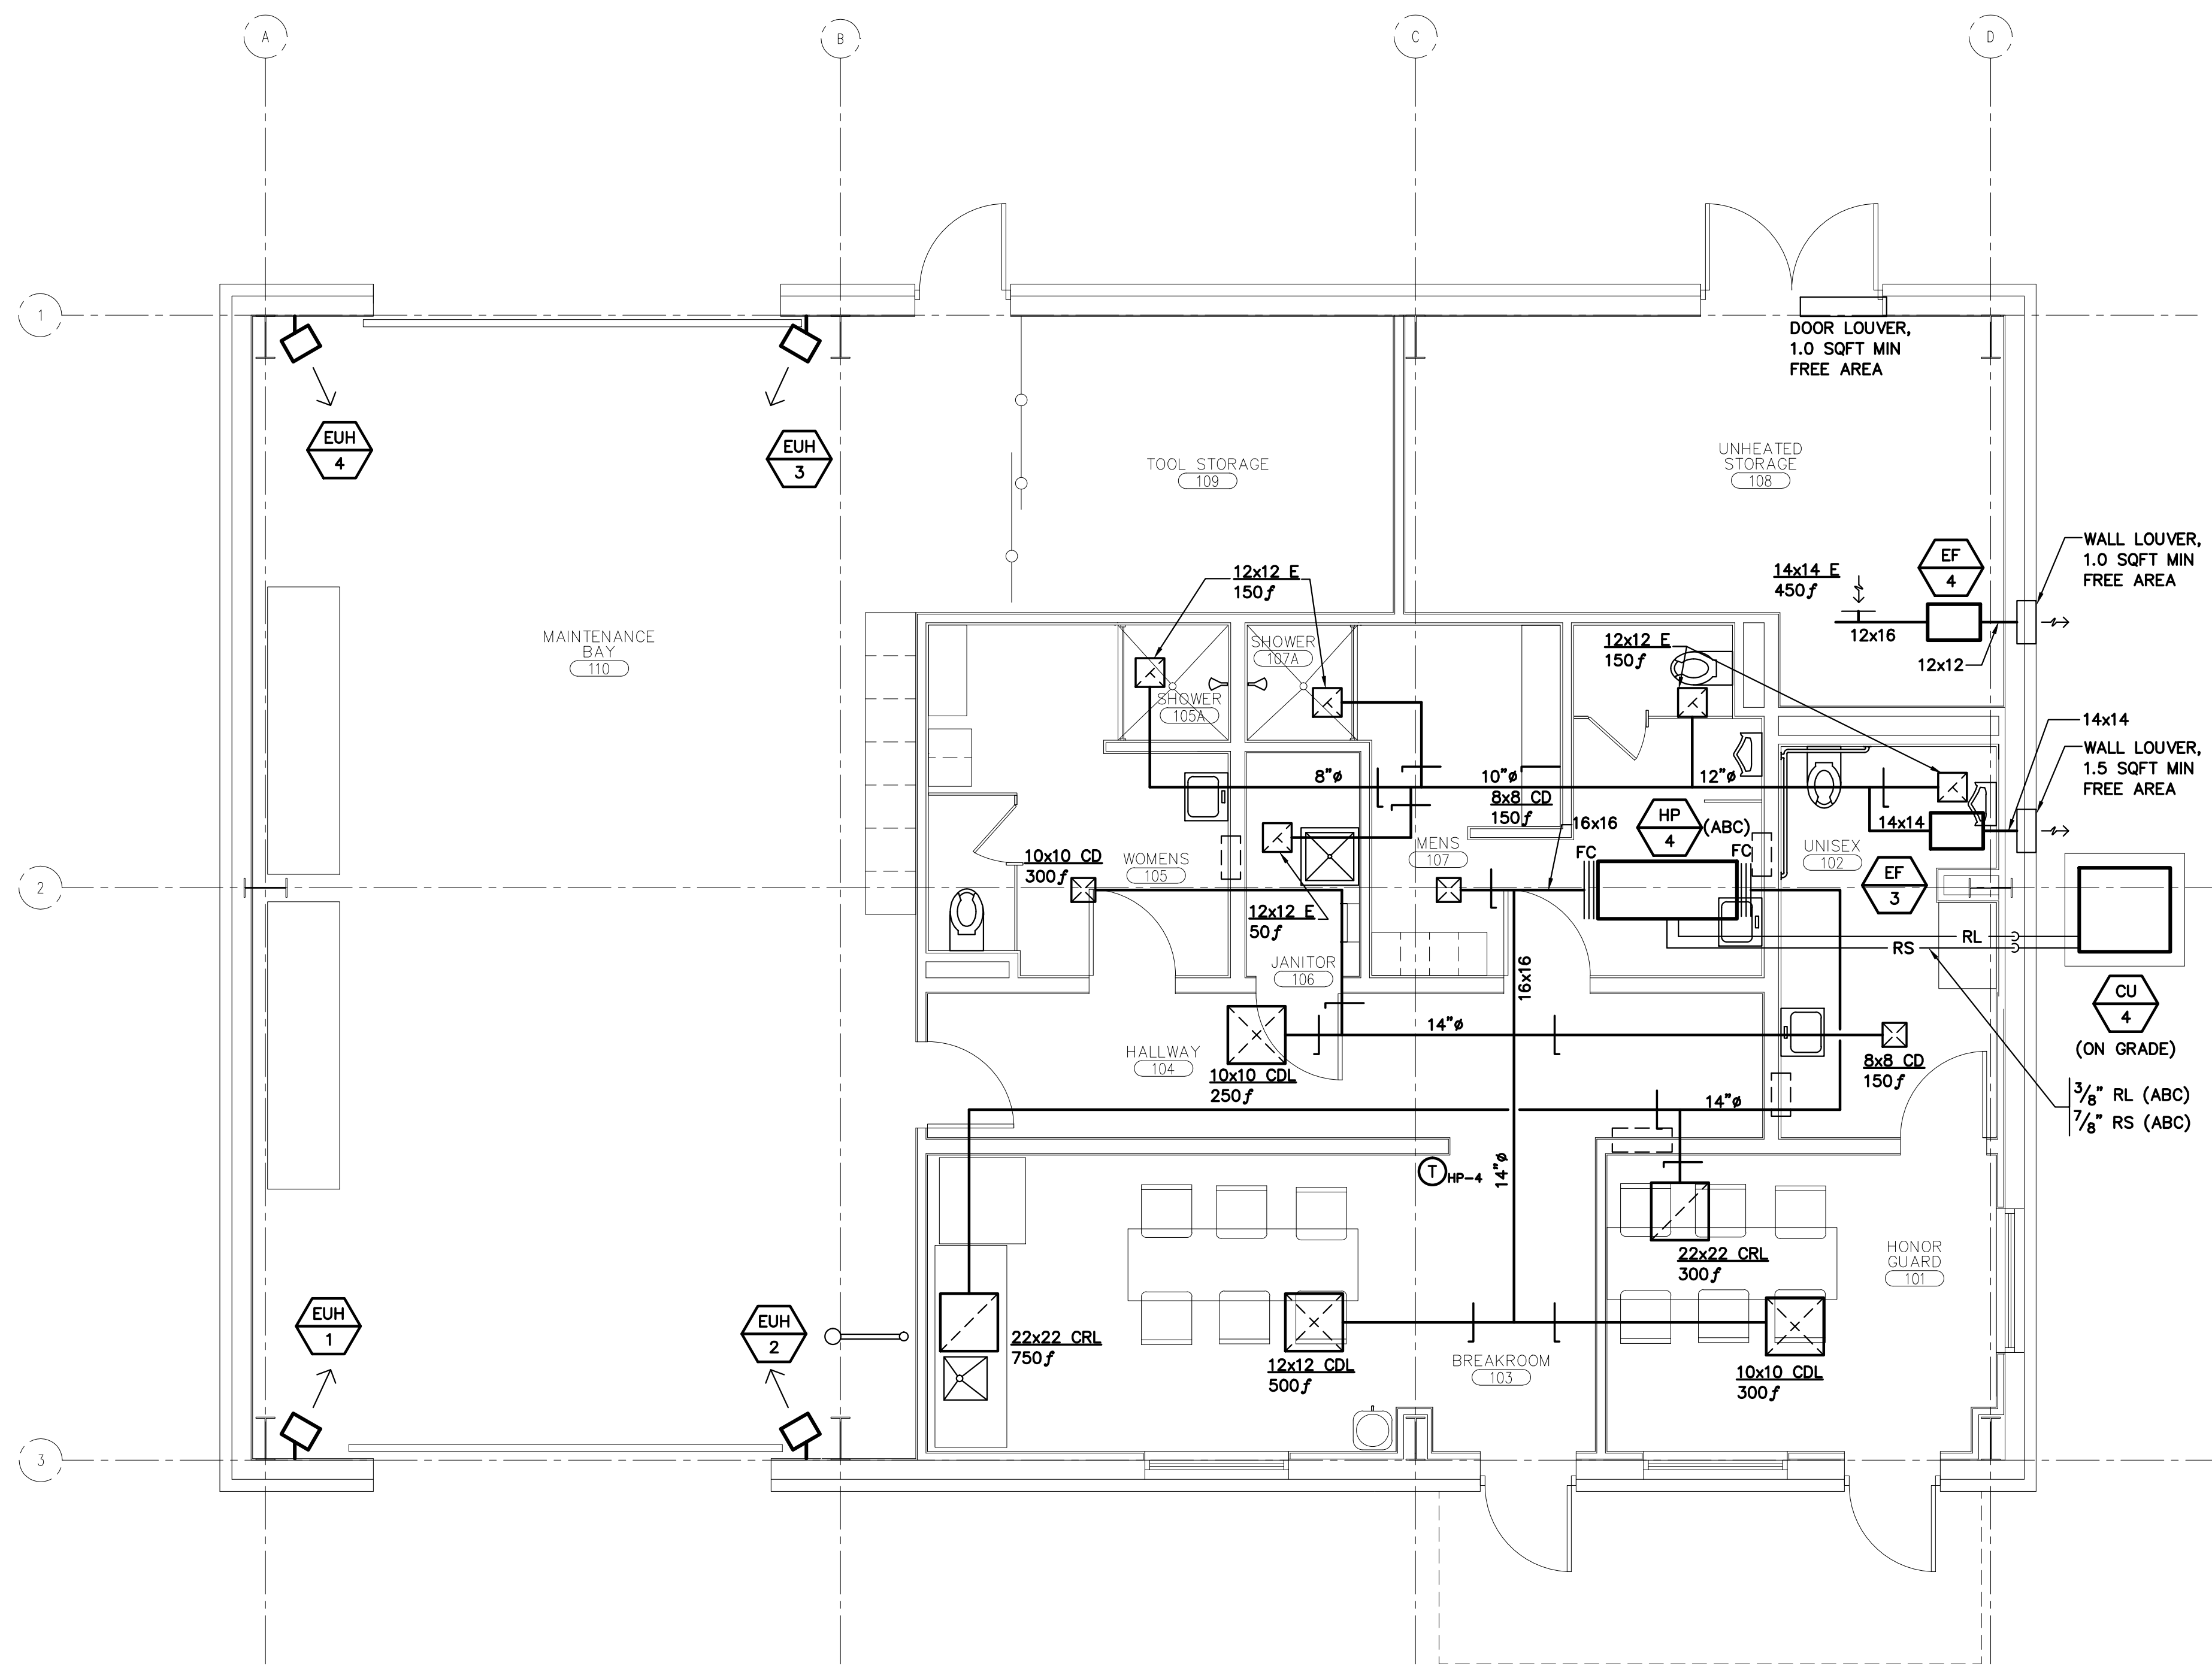


L:\2011\110103.00\1200 Drawings\1205 AutoCAD Project Files\3000-H1.FB20 - March 14, 2012 - BZ - 40

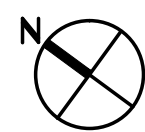

CONSTRUCTION DOCUMENTS

- GENERAL NOTES:**
1. CAREFULLY COORDINATE DUCT ROUTING THROUGH CUSTOM TRUSSES WITH TRUSS MANUFACTURER AND STRUCTURAL PLANS.
  2. SEE DUCT BRANCH TABLE ON SHEET H-1 FOR DUCT SIZES TO INDIVIDUAL DIFFUSERS AND GRILLES.
  3. PROVIDE ALUMINUM EXHAUST GRILLES AND DUCTWORK CONNECTING TO EF-3.



## HVAC FLOOR PLAN - MAINTENANCE

**SCALE : 1/4" = 1'-0"**

[illegible]