

A

B

C

D

E

F

G

A

B


C

D


E

F

G

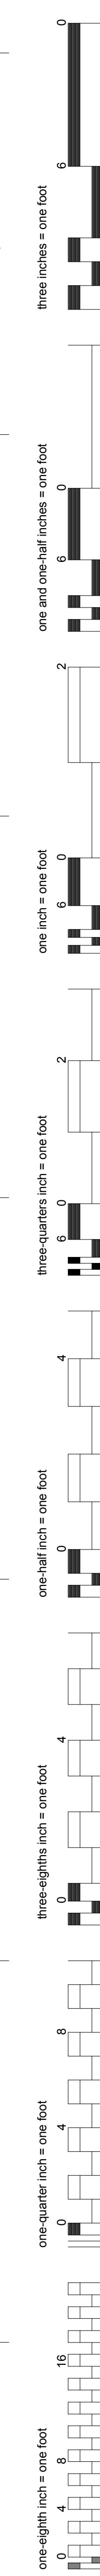

FULLY SPRINKLERED

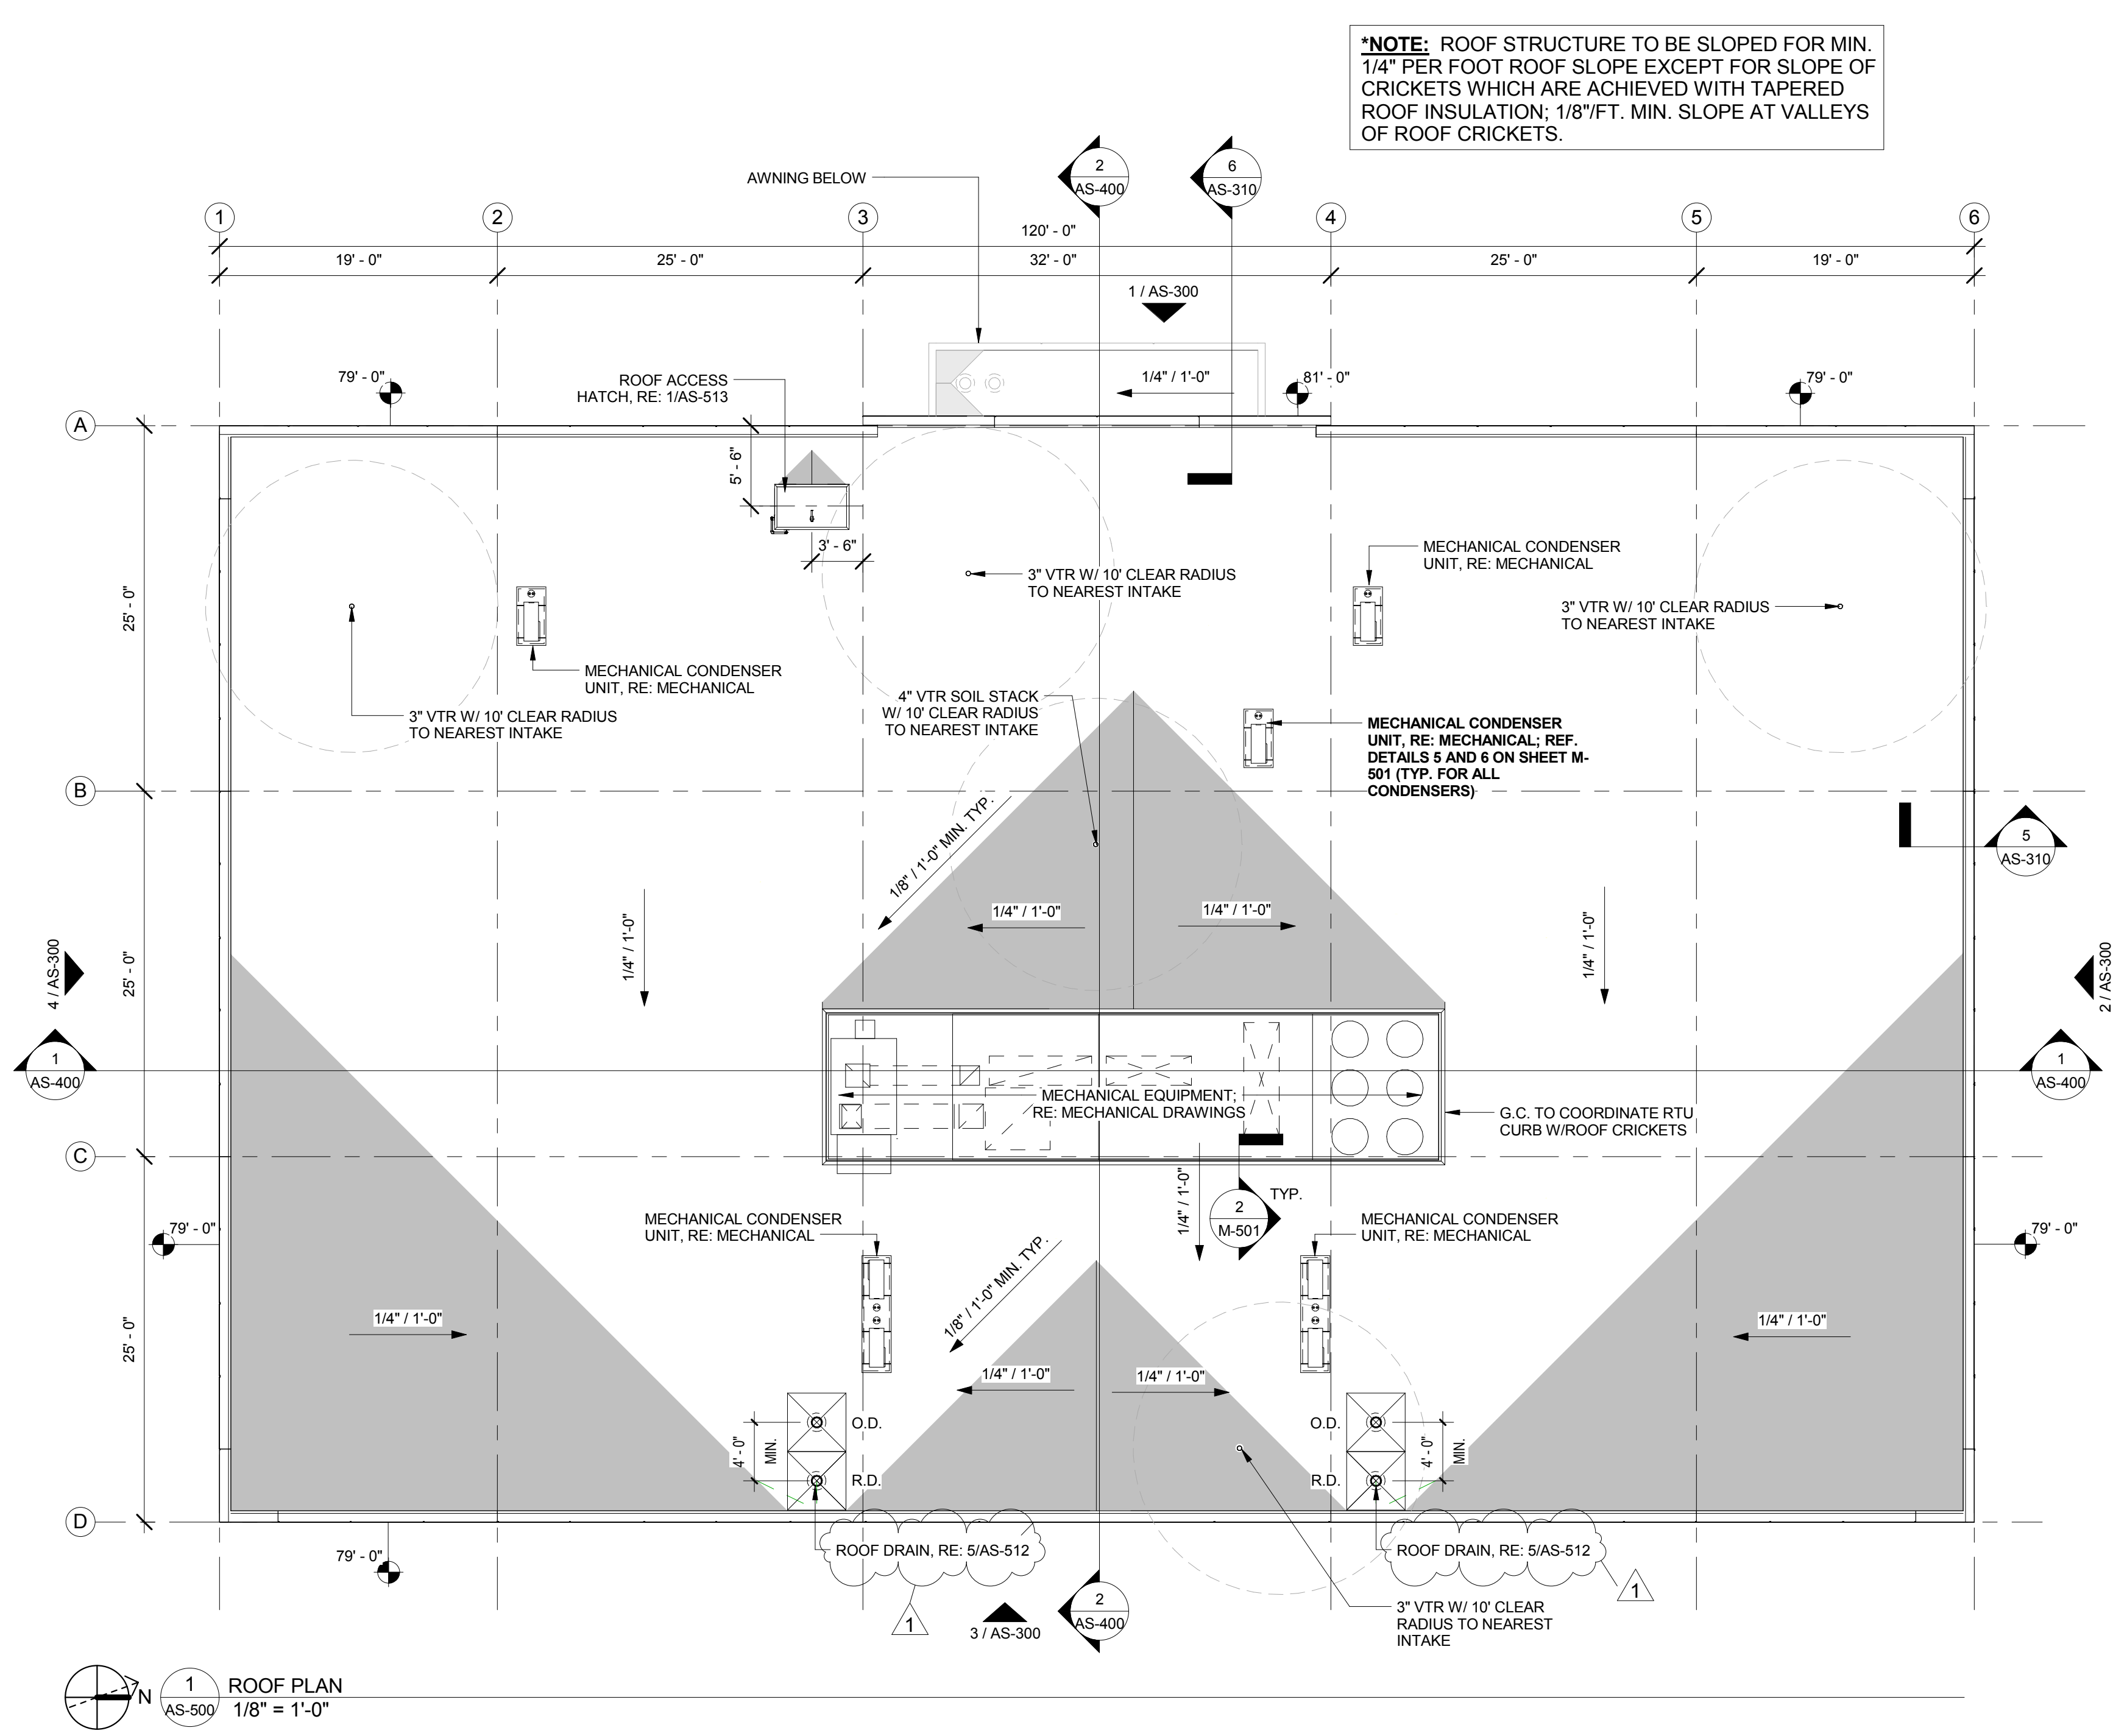

<div>17/27/17</div> <div>Revision #Date</div>		<div>CONSULTANTS</div> <div><div>H2B, INC. 1225 N. LOOP WEST, SUITE 900 HOUSTON, TX 77008 (713) 864-2300</div><div>FIRE PROTECTION / TELECOM ENGINEER PAGE 400 W. CESAR CHAVEZ STREET, SUITE 500 AUSTIN, TX 78701 (512) 472-6721</div></div>		<div>ARCHITECT &amp; M.E.P. ENGINEER</div> <div><div><div>310 NEW YORK ST. SUITE A HOUSTON, TX 77002 spurdesign.com</div><div>1515 Westpark Road Houston, TX 77041 spurdesign.com</div></div><div></div></div>		<div>APPROVED: DIRECTOR</div> <div>APPROVED: ASSOCIATE DIRECTOR</div> <div>APPROVED: ASSISTANT DIRECTOR</div> <div>APPROVED: CHIEF ENGINEER</div>		<div>SHEET TITLE</div> <div>ROOF PLAN</div> <div>APPROVED: CHIEF ENGINEER</div>		<div>PROJECT TITLE</div> <div>NEW ADMINISTRATION BUILDING</div> <div>PROJECT LOCATION</div> <div>2002 HOLCOMBE BOULEVARD HOUSTON, TX 77030</div> <div>DATE</div> <div>06-27-17</div> <div>CHECKED</div> <div>SAC</div> <div>DRAWN</div> <div>MEB</div>		<div>VA PROJECT NUMBER</div> <div>580-CSI-110</div> <div>BUILDING NUMBER</div> <div></div> <div>DRAWING NUMBER</div> <div>AS-500</div> <div>Dwg. 46 OF 95</div>		<div>BID DOCUMENTS</div> <div><div>Office of Construction and Facilities Management</div><div> U.S. Department of Veterans Affairs</div></div>	
---	--	--	--	--	--	---	--	---	--	--	--	---	--	--	--