


Revisions	Date

[illegible]

ANSWER: 1. ☐ A 2. ☐ B 3. ☐ C 4. ☐ D 5. ☐ E 6. ☐ F 7. ☐ G 8. ☐ H 9. ☐ I 10. ☐ J 11. ☐ K 12. ☐ L 13. ☐ M 14. ☐ N 15. ☐ O 16. ☐ P 17. ☐ Q 18. ☐ R 19. ☐ S 20. ☐ T 21. ☐ U 22. ☐ V 23. ☐ W 24. ☐ X 25. ☐ Y 26. ☐ Z

Drawing Title THIRD FLOOR PLAN FIRE PROTECTION	Project Title			Date 10-20-2004
				Project No.
Approved: Project Manager	Building Number 01	Checked	Drawn	Drawing No.
Approved: Service Chief	Location VAMC, MILKES BARRE PENNSYLVANIA			

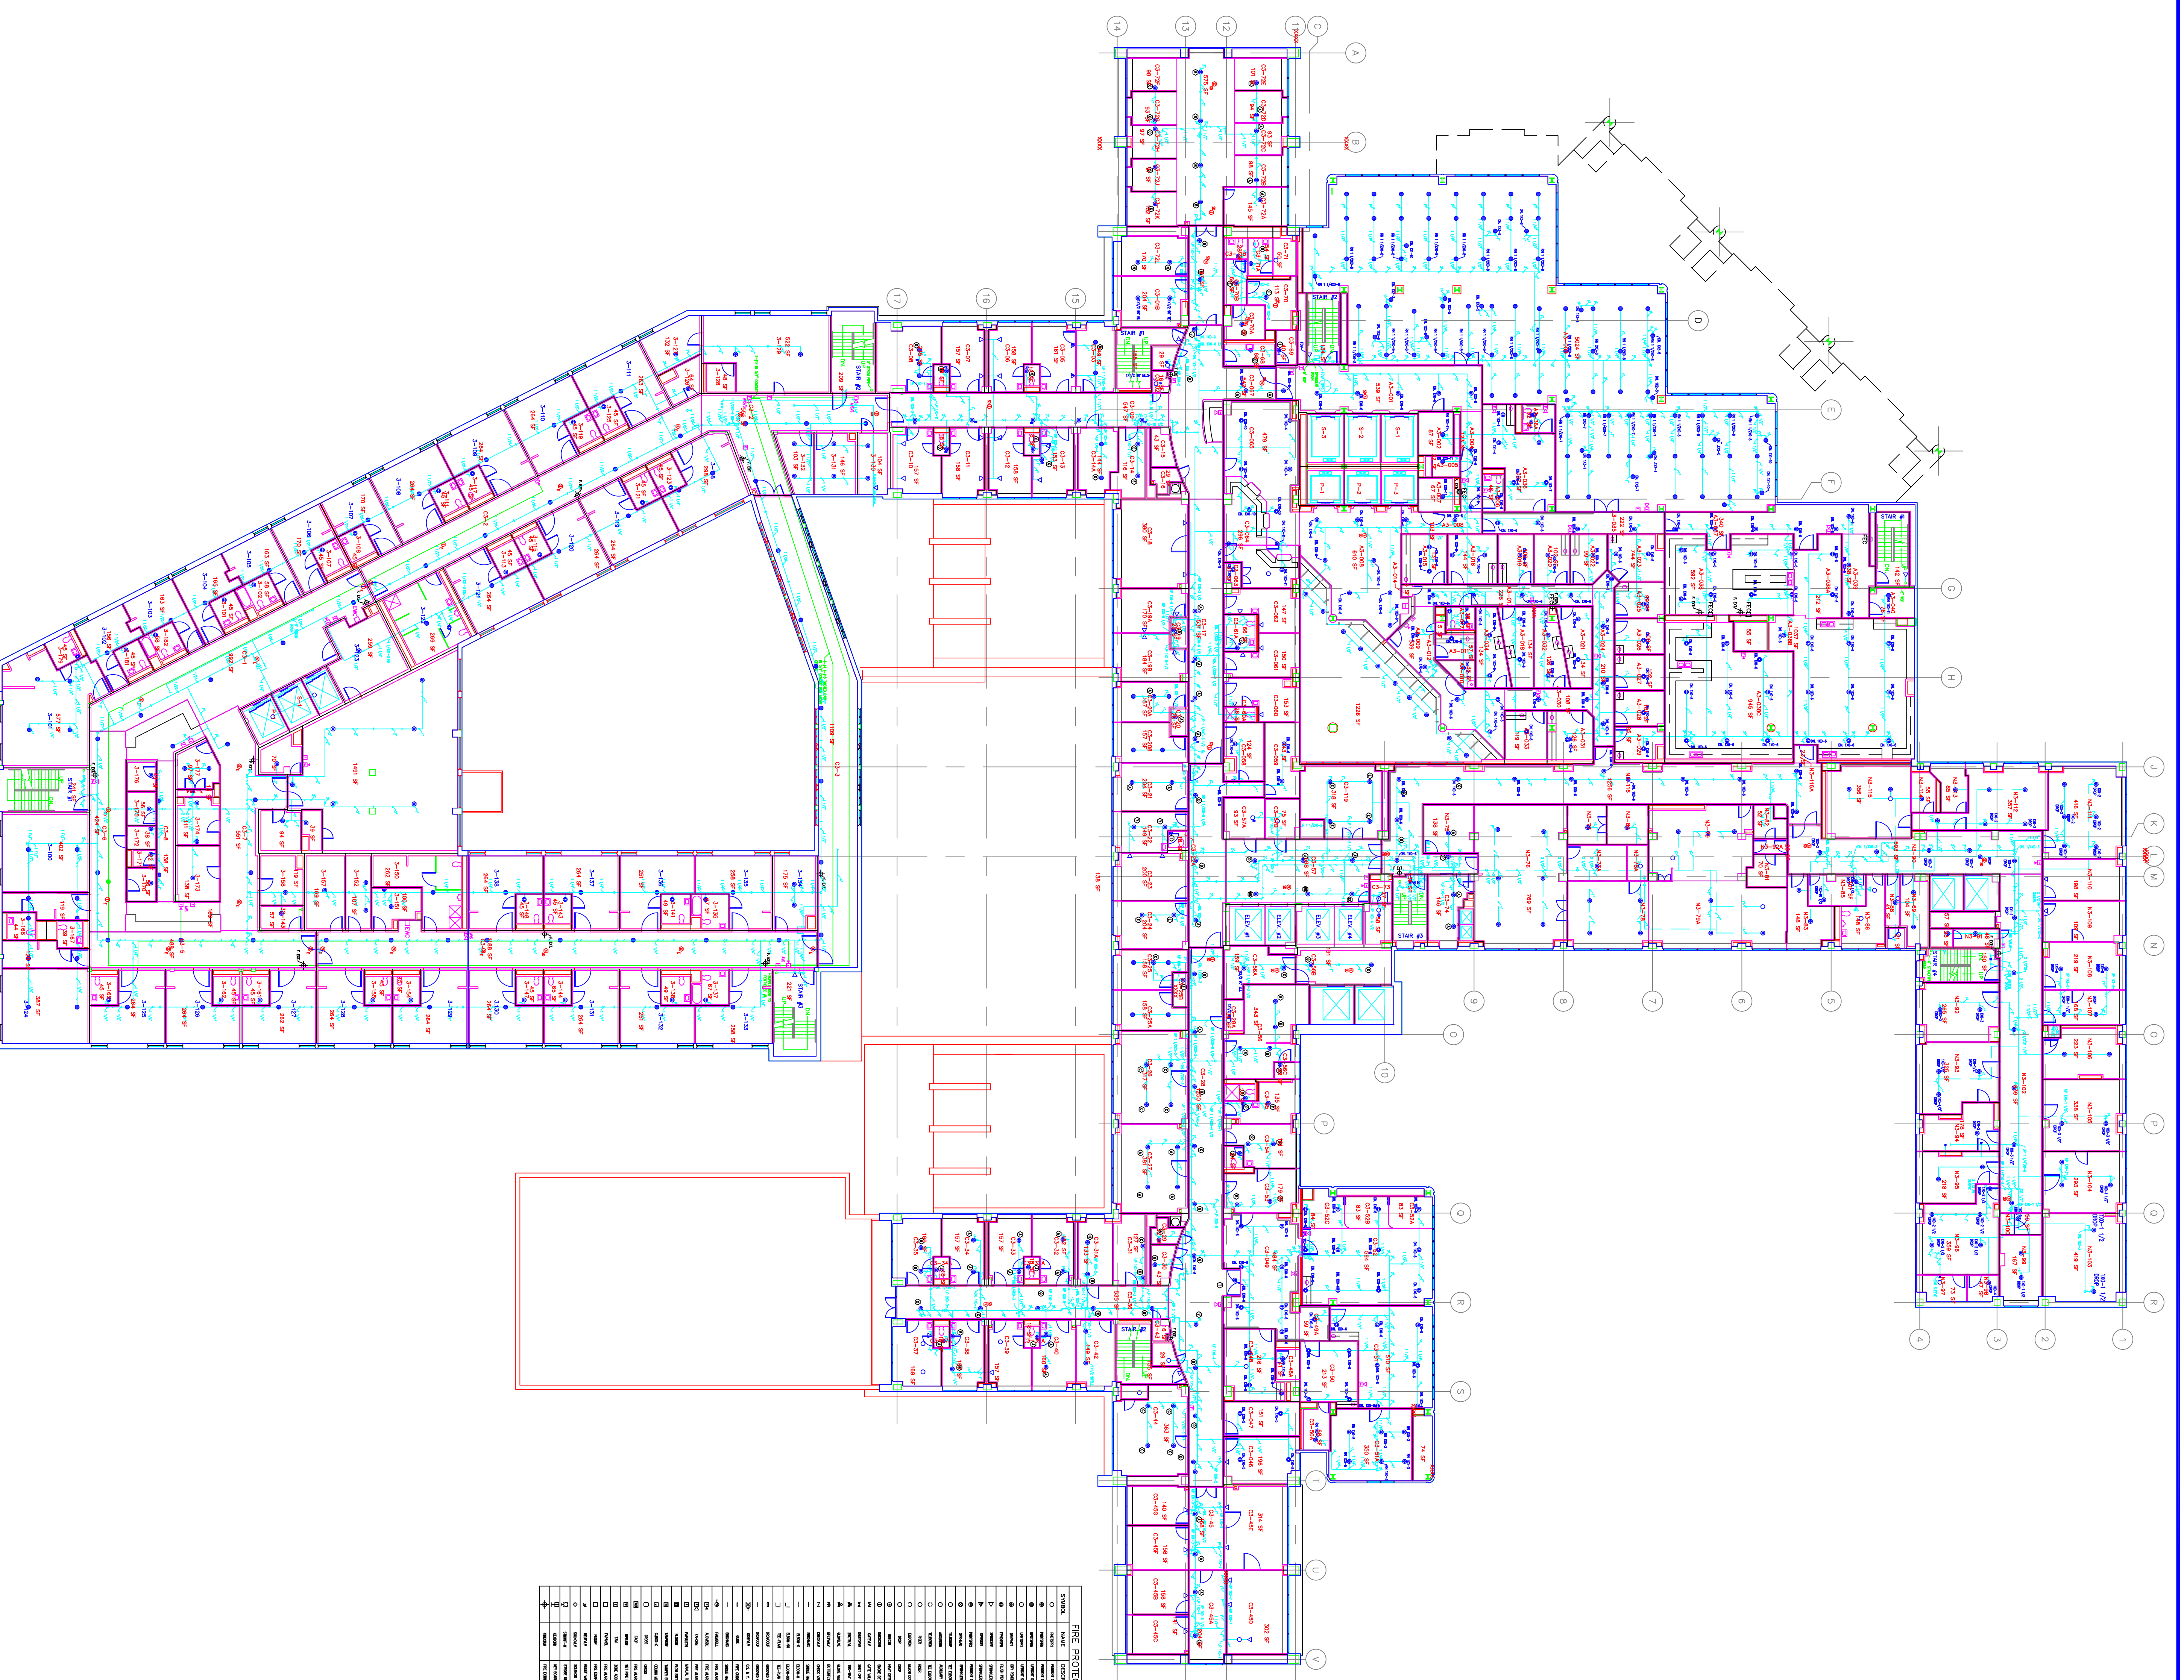