

A

B

C

D

E

F

A



B

C



D

E


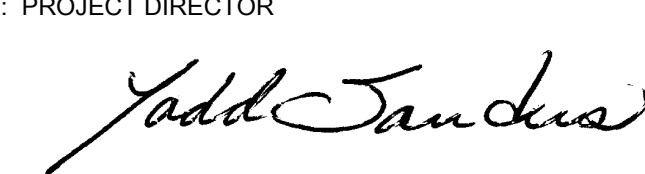

F

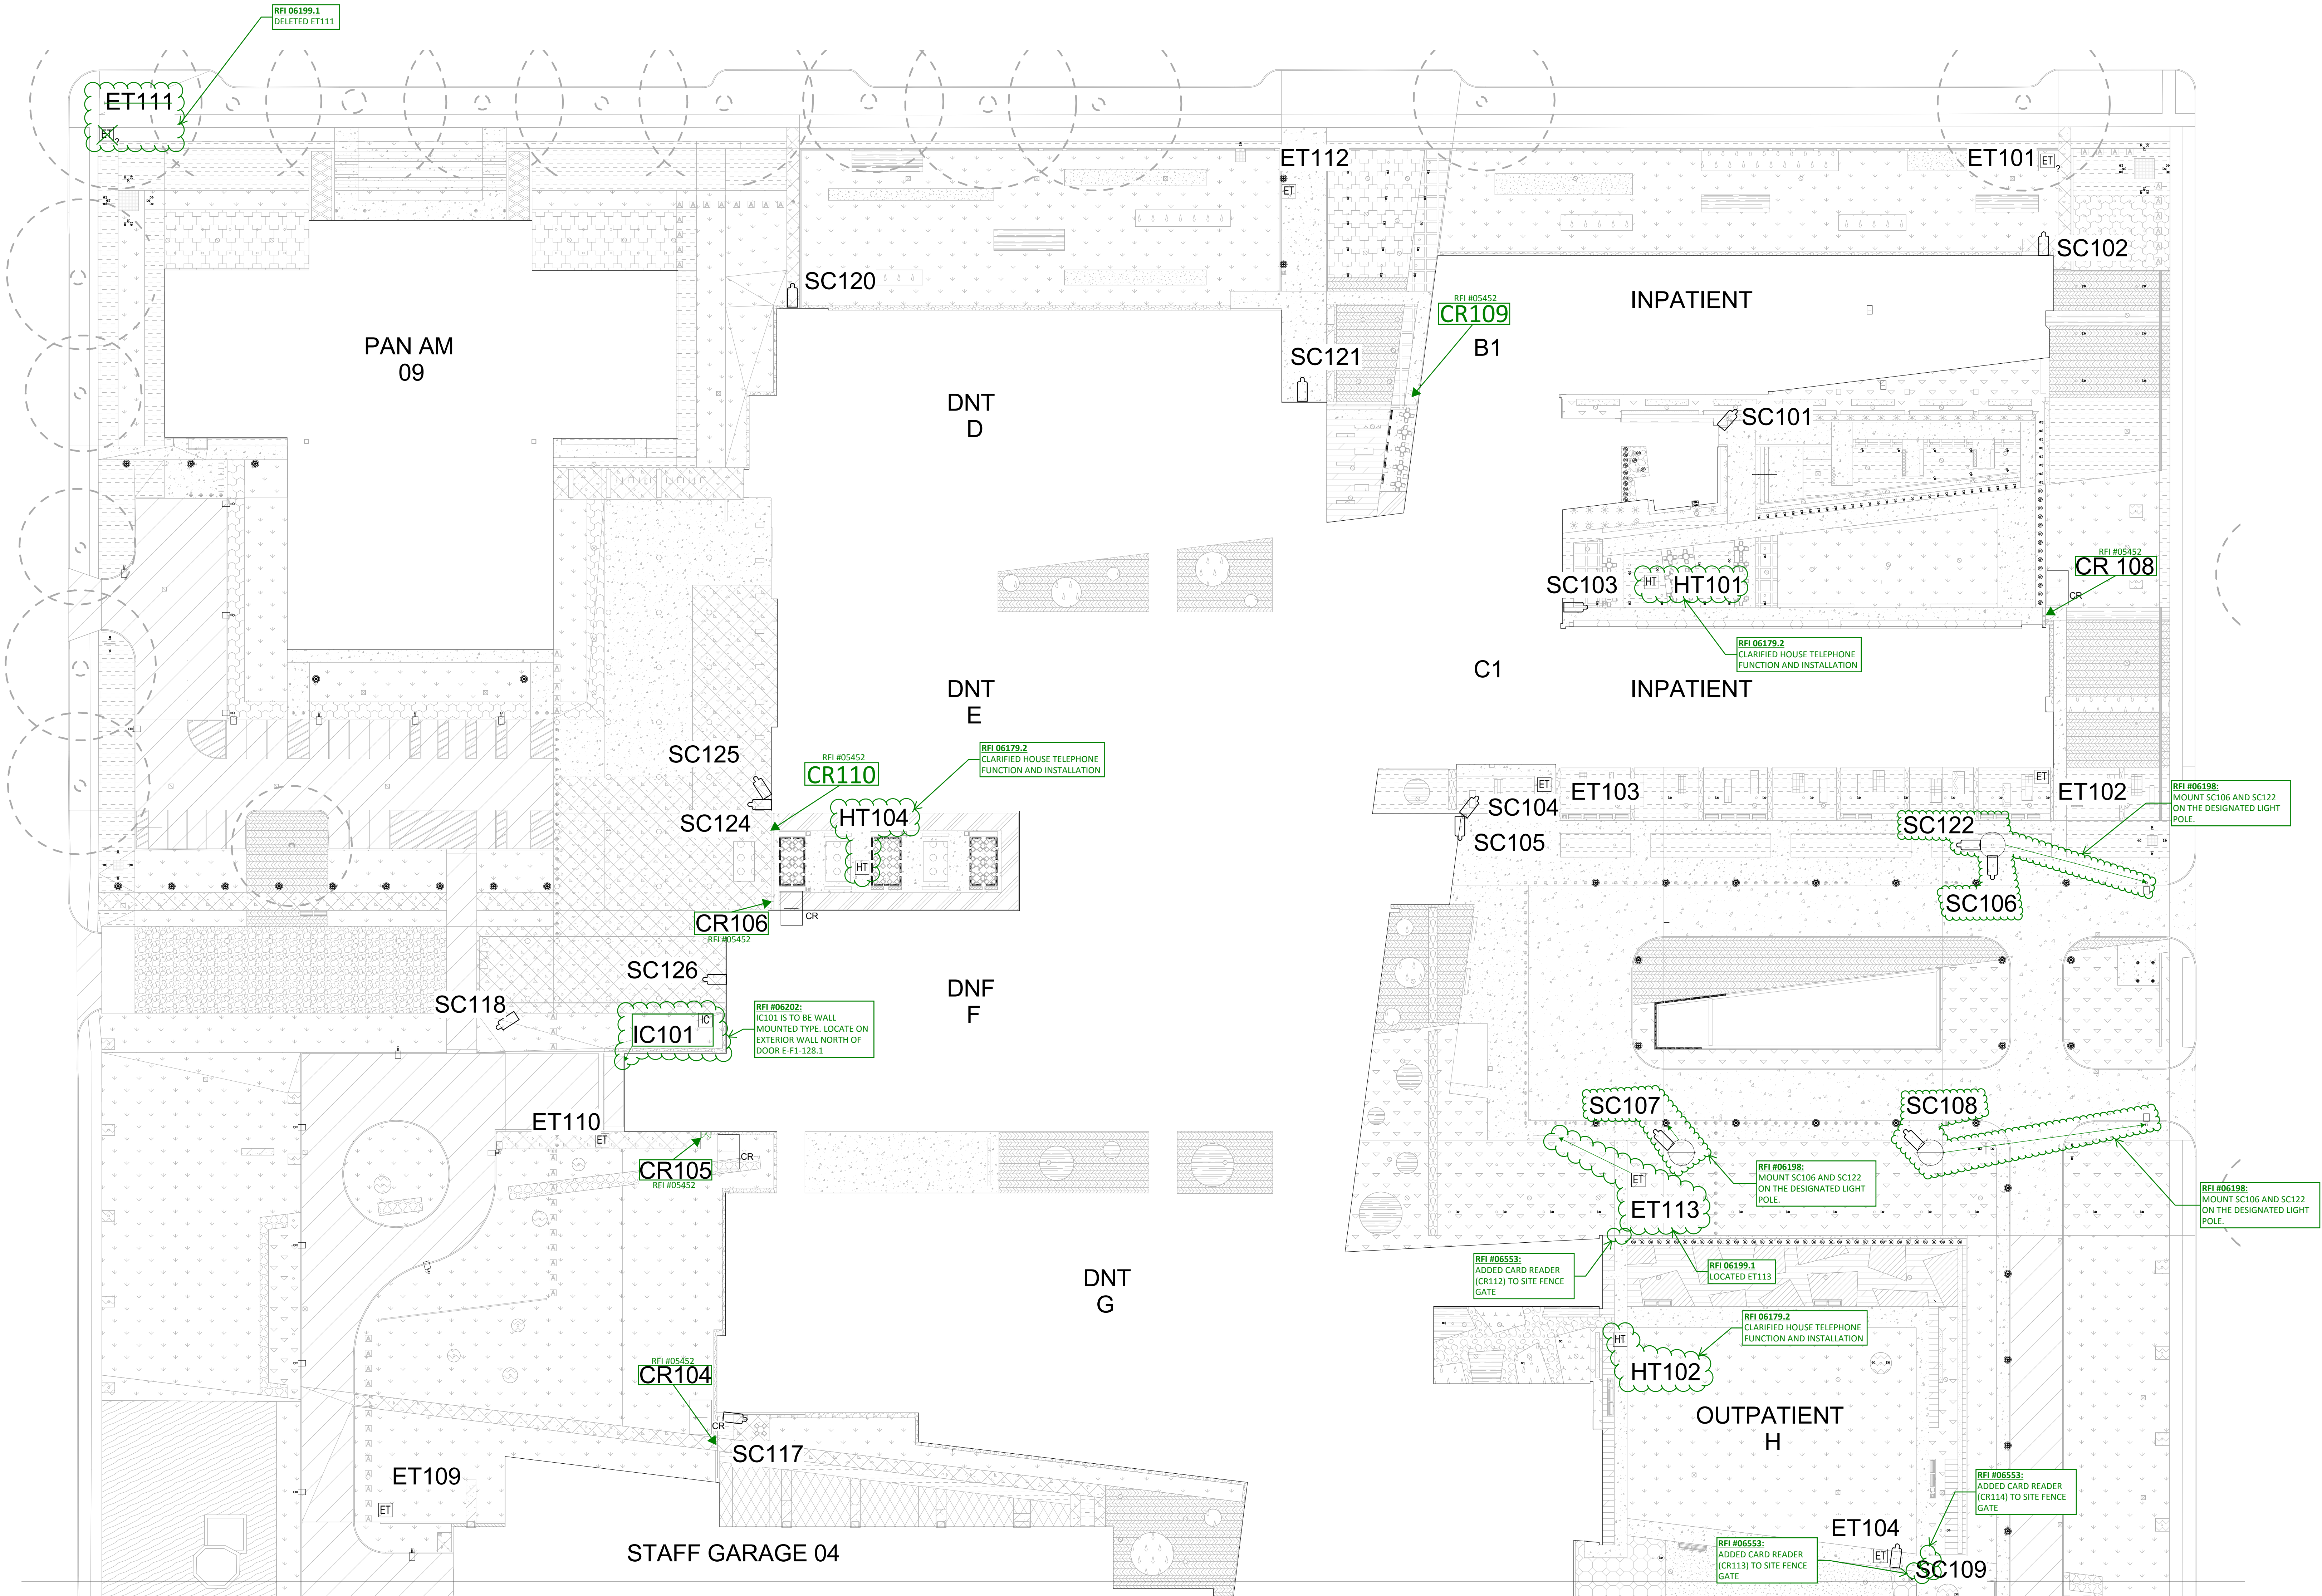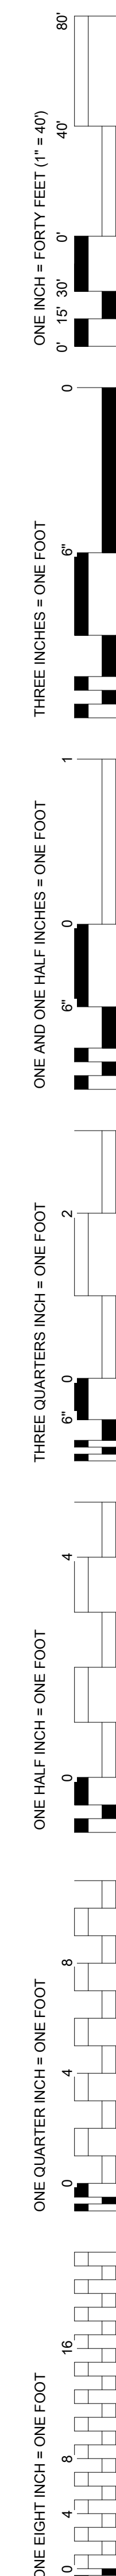

1 CAMPUS SECURITY PLAN NORTH
1/32" = 1'-0"

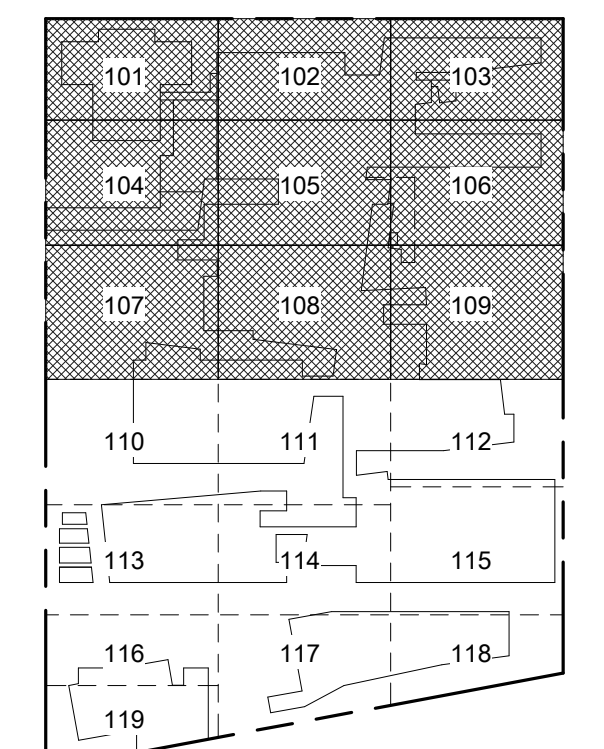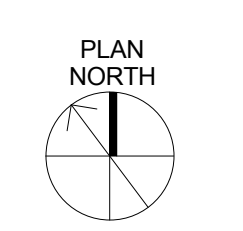

CONSTRUCTION DOCUMENTS 1
FULLY SPRINKLERED

REVISIONS:		DATE		CONSULTANTS: DESMAN ASSOCIATES / PARKING CODE CONSULTANTS, INC. / CODE CONSULTANT THE SEXTANT GROUP / AV & ACOUSTICAL HAMMER DESIGN ASSOCIATES / FOOD SERVICE PYBURN & ODOM / ABATEMENT TATA & HOWARD / TANK CONSULTANT I.S.C. GROUP, INC. / IRRIGATION DAN EUSER WATER ARCHITECTURE, INC. / WATER FEATURE		 JAY EPSTEIN REG. NO. 120435R EXPIRES 12-31-18 FEB 29 2012		ARCHITECT/ENGINEERS: studio NOVA SCHRENK & PETERSON CONSULTING ENGINEERS / CIVIL KORDA/NEMETH ENGINEERING / STRUCTURAL BR+A CONSULTING ENGINEERS / MECH, ELECT, PLUMBING, LOW VOLTAGE ARCHITECTURAL ENGINEERING/ PLUMBING SCALES ASSOCIATES / FIRE PROTECTION		DRAWING TITLE CAMPUS SECURITY SITE PLAN - NORTH 1/32" = 1'-0" APPROVED: PROJECT DIRECTOR 		PROJECT TITLE SLVHCS REPLACEMENT MEDICAL CENTER PROJECT LOCATION NEW ORLEANS, LOUISIANA DATE February 29, 2012 CHECKED JLE DRAWN JAY		PROJECT NUMBER 629-HS2-401 DOCUMENT SET PACKAGE WP-08 DRAWING NUMBER 0TY0S1		OFFICE OF CONSTRUCTION AND FACILITIES MANAGEMENT 	
-------------------	--	-------------	--	---	--	---	--	---	--	--	--	---	--	--	--	--	--