

1 CAMPUS SECURITY PLAN SOUTH  
1/32" = 1'-0"



REVISIONS:		DATE


**CONSULTANTS:**  
DESMAN ASSOCIATES / PARKING  
CODE CONSULTANTS, INC. / CODE CONSULTANT  
THE SEXTANT GROUP / AV & ACOUSTICAL  
HAMMER DESIGN ASSOCIATES / FOOD SERVICE  
PYBURN & ODOM / ABATEMENT  
TATA & HOWARD / TANK CONSULTANT  
I.S.C. GROUP, INC. / IRRIGATION  
DAN EUSER WATER ARCHITECTURE, INC. / WATER FEATURE



JOY EPSTEIN  
REG. NO. 124435  
EXPIRES 12-31-18  
FEB 29 2012

**ARCHITECT/ENGINEERS:**  
**studio NOVA**  
SCHRENK & PETERSON CONSULTING ENGINEERS / CIVIL  
KORDA/NEMETH ENGINEERING / STRUCTURAL  
BR+A CONSULTING ENGINEERS / MECH, ELECT, PLUMBING, LOW VOLTAGE  
ARCHITECTURAL ENGINEERING/ PLUMBING  
SCALES ASSOCIATES / FIRE PROTECTION

DRAWING TITLE CAMPUS SECURITY SITE PLAN - SOUTH  1/32" = 1'-0"		PROJECT TITLE SLVHCS REPLACEMENT MEDICAL CENTER PROJECT		PROJECT NUMBER 629-HS2-401	SITE AREA
APPROVED: PROJECT DIRECTOR  		LOCATION NEW ORLEANS, LOUISIANA		DOCUMENT SET PACKAGE WP-08	
DATE February 29, 2012		CHECKED JLE	DRAWN JAY	DRAWING NUMBER  0TY0S2	
OFFICE OF CONSTRUCTION AND FACILITIES MANAGEMENT					
 Department of Veterans Affairs					

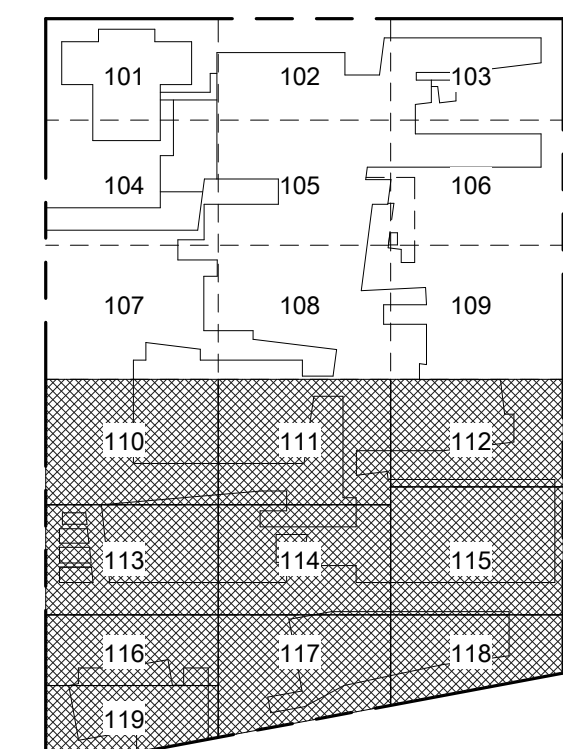

CONSTRUCTION DOCUMENTS 1  
FULLY SPRINKLERED