

JESSE BROWN
VA MEDICAL CENTER

CHICAGO, ILLINOIS

FIRE ALARM SYSTEM UPGRADE

Submitted By:

SIEMENS

Industry

Siemens Building Technologies, Inc.

Fire Safety Division

585 SLAWIN COURT
MOUNT PROSPECT, IL 60056

Tel: (847) 803-2700
Fax: (847) 803-2733

THE DRAWING AND DESIGN HEREIN SHALL NOT BE DUPLICATED,
USED OR DISCLOSED TO OTHERS FOR PROCUREMENT OR OTHER
PURPOSE (EXCEPT AS OTHERWISE AUTHORIZED BY CONTRACT)
WITHOUT WRITTEN PERMISSION OF SIEMENS INDUSTRY INC.
ALL REPRODUCTIONS SHALL BEAR THIS NOTICE.

REVISIONS

No.	Revision	By	Date
1			
2			
3			
4			
5			
6			
7			
8			
9			

PROFESSIONAL ENGINEERS APPROVAL STAMP:

DESIGN ENGINEERS:

CONTRACTOR'S NAME & ADDRESS:

PRODUCT MANUFACTURER:

Siemens Industry, Inc.
Building Technologies Division
Fire Safety and Security

CHICAGO BRANCH
585 SLAWIN COURT
Mount Prospect, Illinois 60056
Tel (847) 803-2700 Fax (847) 803-2733

WB NAME & LOCATION (STREET ADDRESS)

JESSE BROWN
VA MEDICAL CENTER
XLS MIGRATION

CHICAGO, IL

MEET CONTENTS:

FIRE ALARM
COVER

STALLATION TYPE

- ☐ NEW INSTALLATION
☐ DESIGN/BUILD
☐ PER CONTRACT DOCUMENT
☐ EXISTING BASE JOB # N/A
☐ OTHERS _____

SYSTEM SALES REP.: BRIAN CULLEN

PROJECT MANAGER: TIM COSTELLO

RAWN BY: SCOTT ANDERSON

NO SCALE


DATE DRAWN:
10/00/00

ED BY


DB NUMBER
40P-203246

ET
FA



5602799

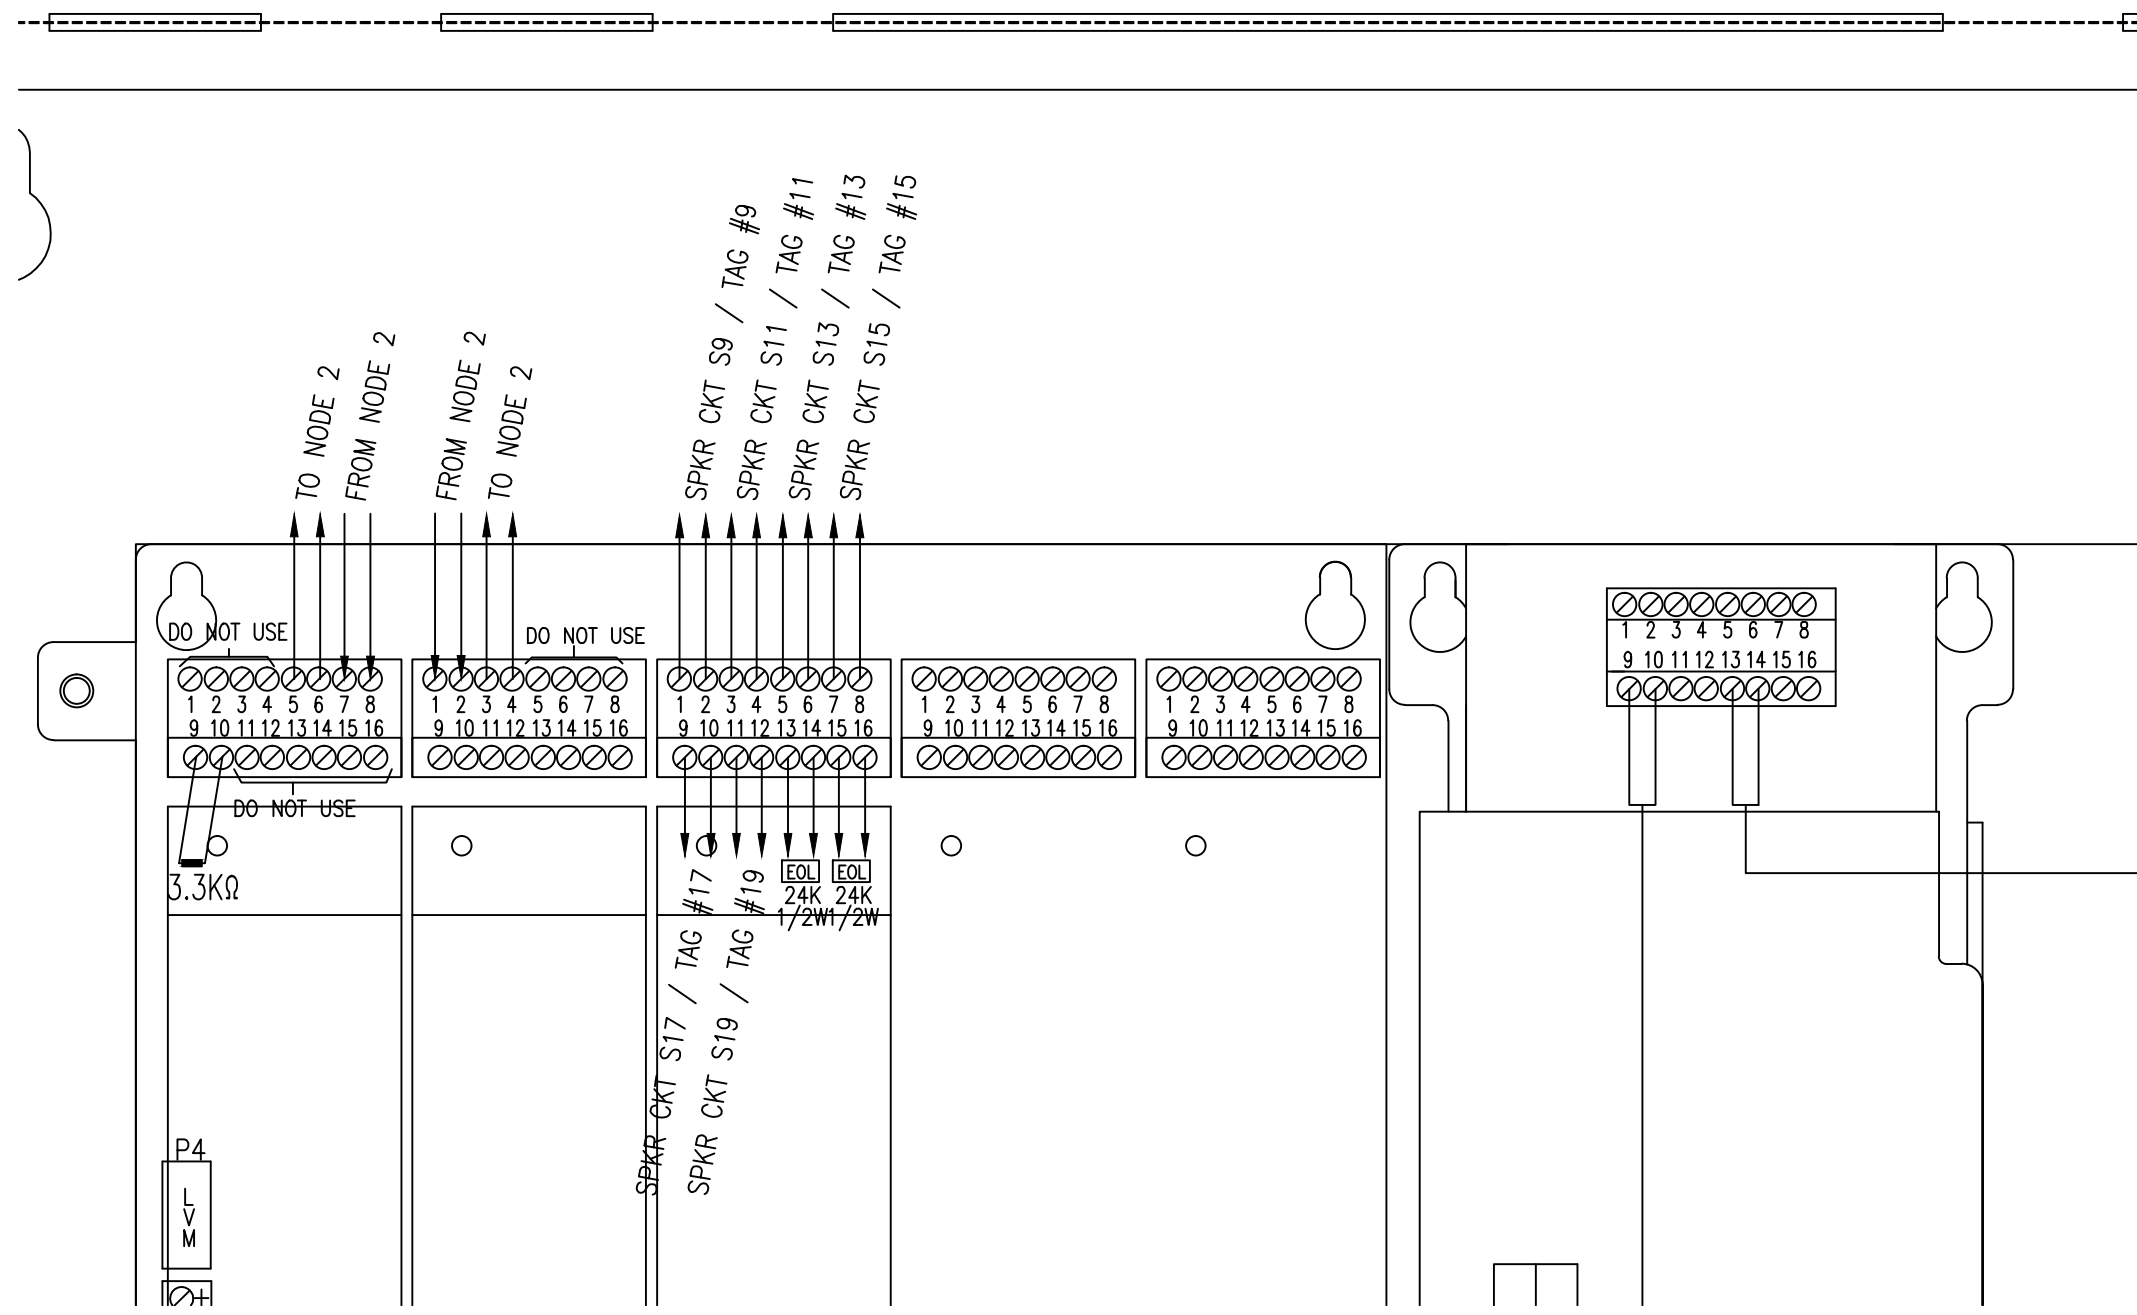

DETAIL 'A'

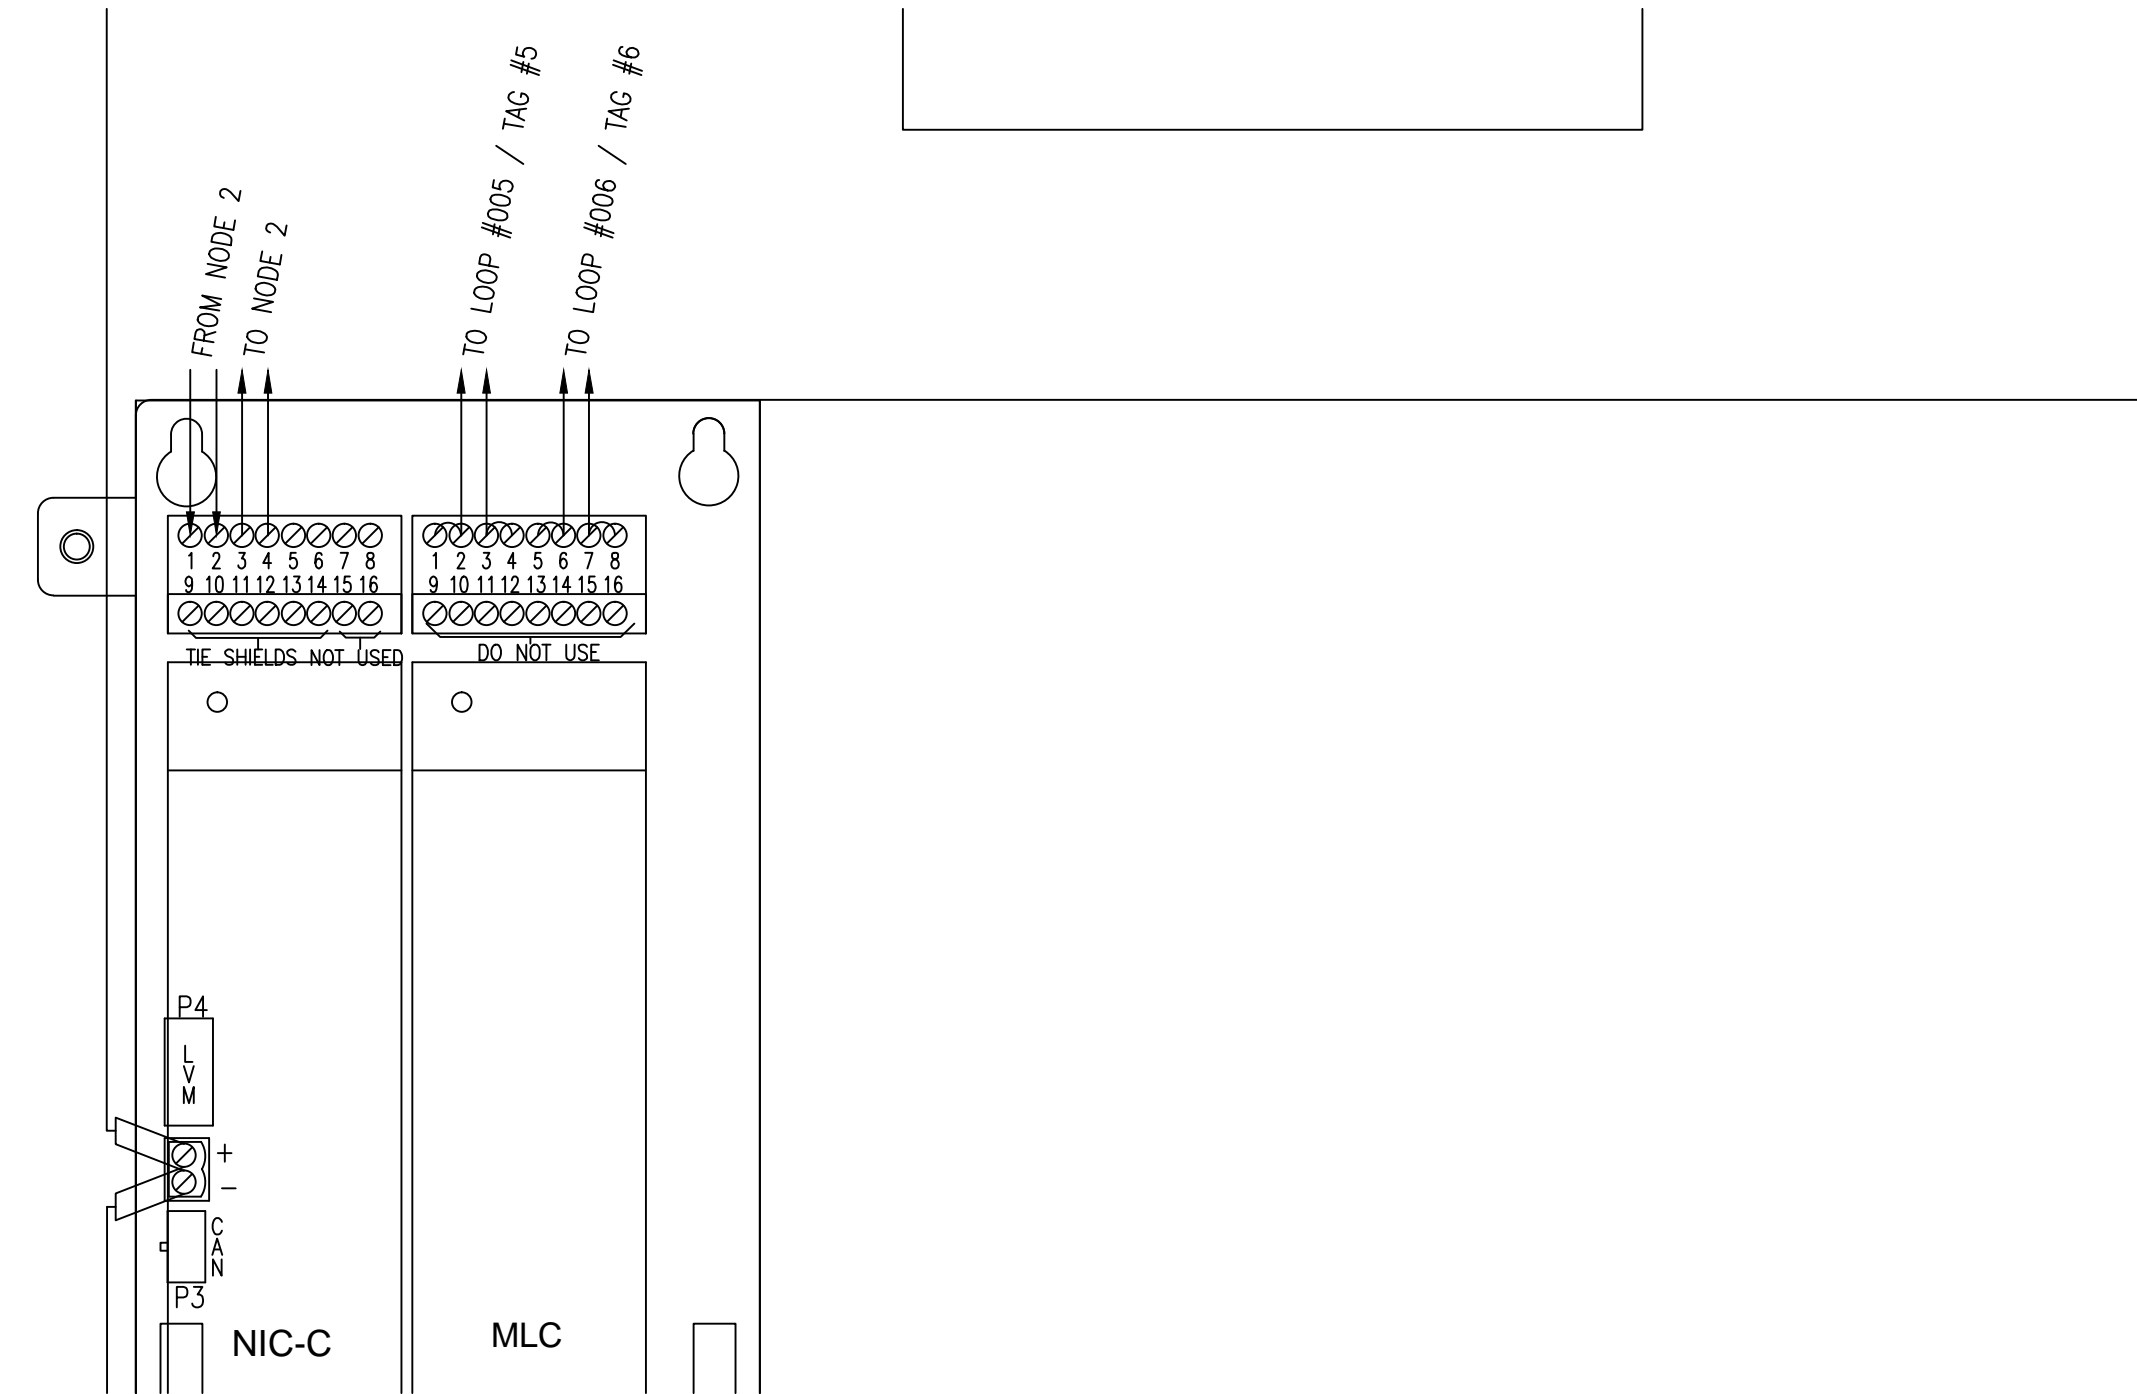


DETAIL 'B'

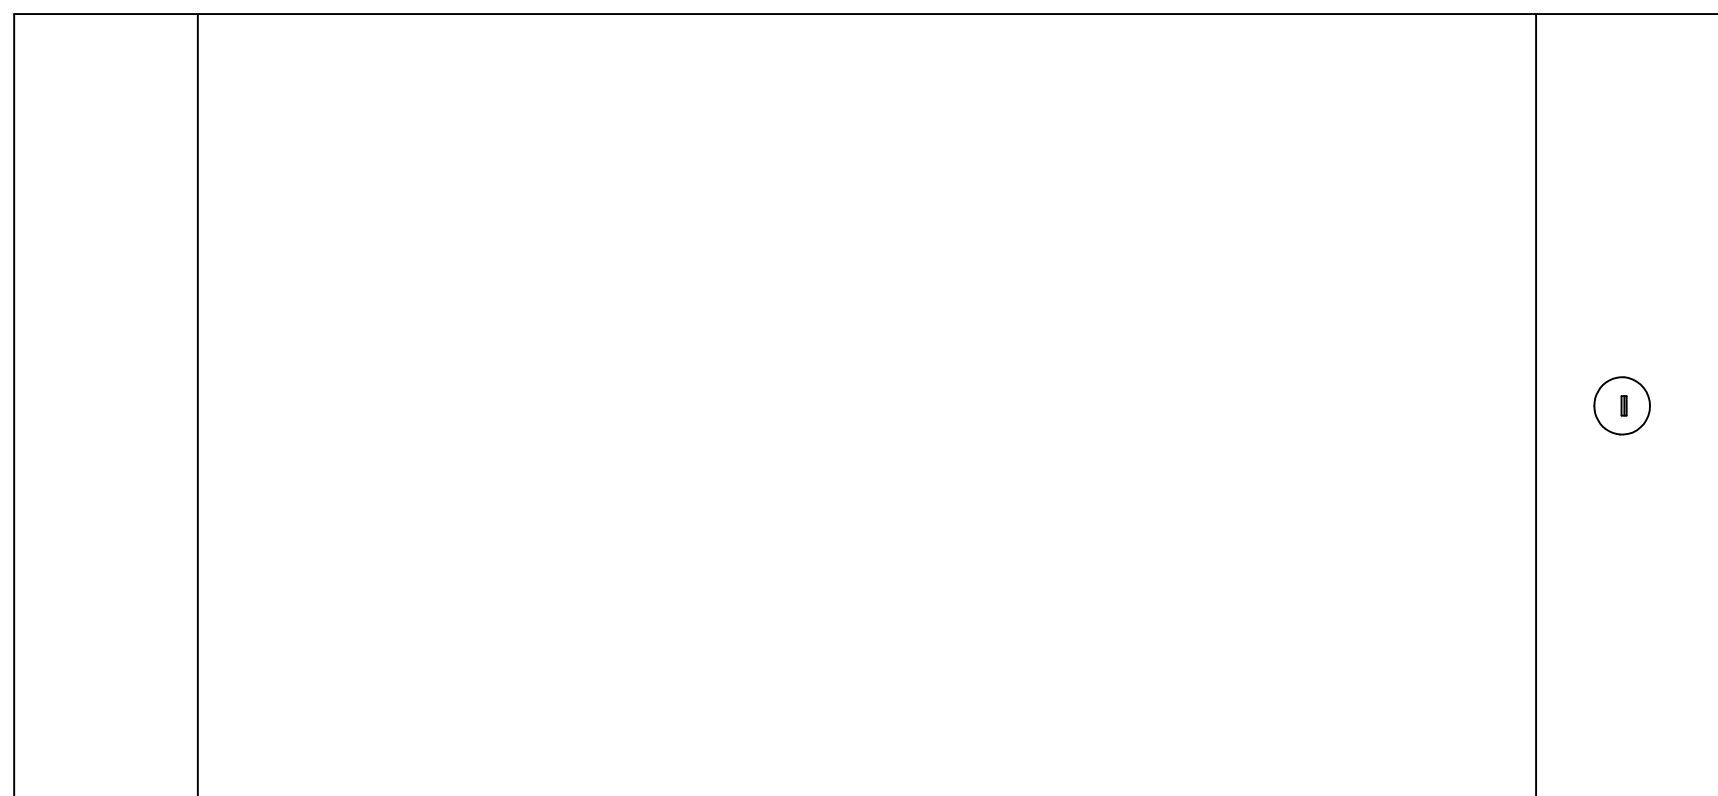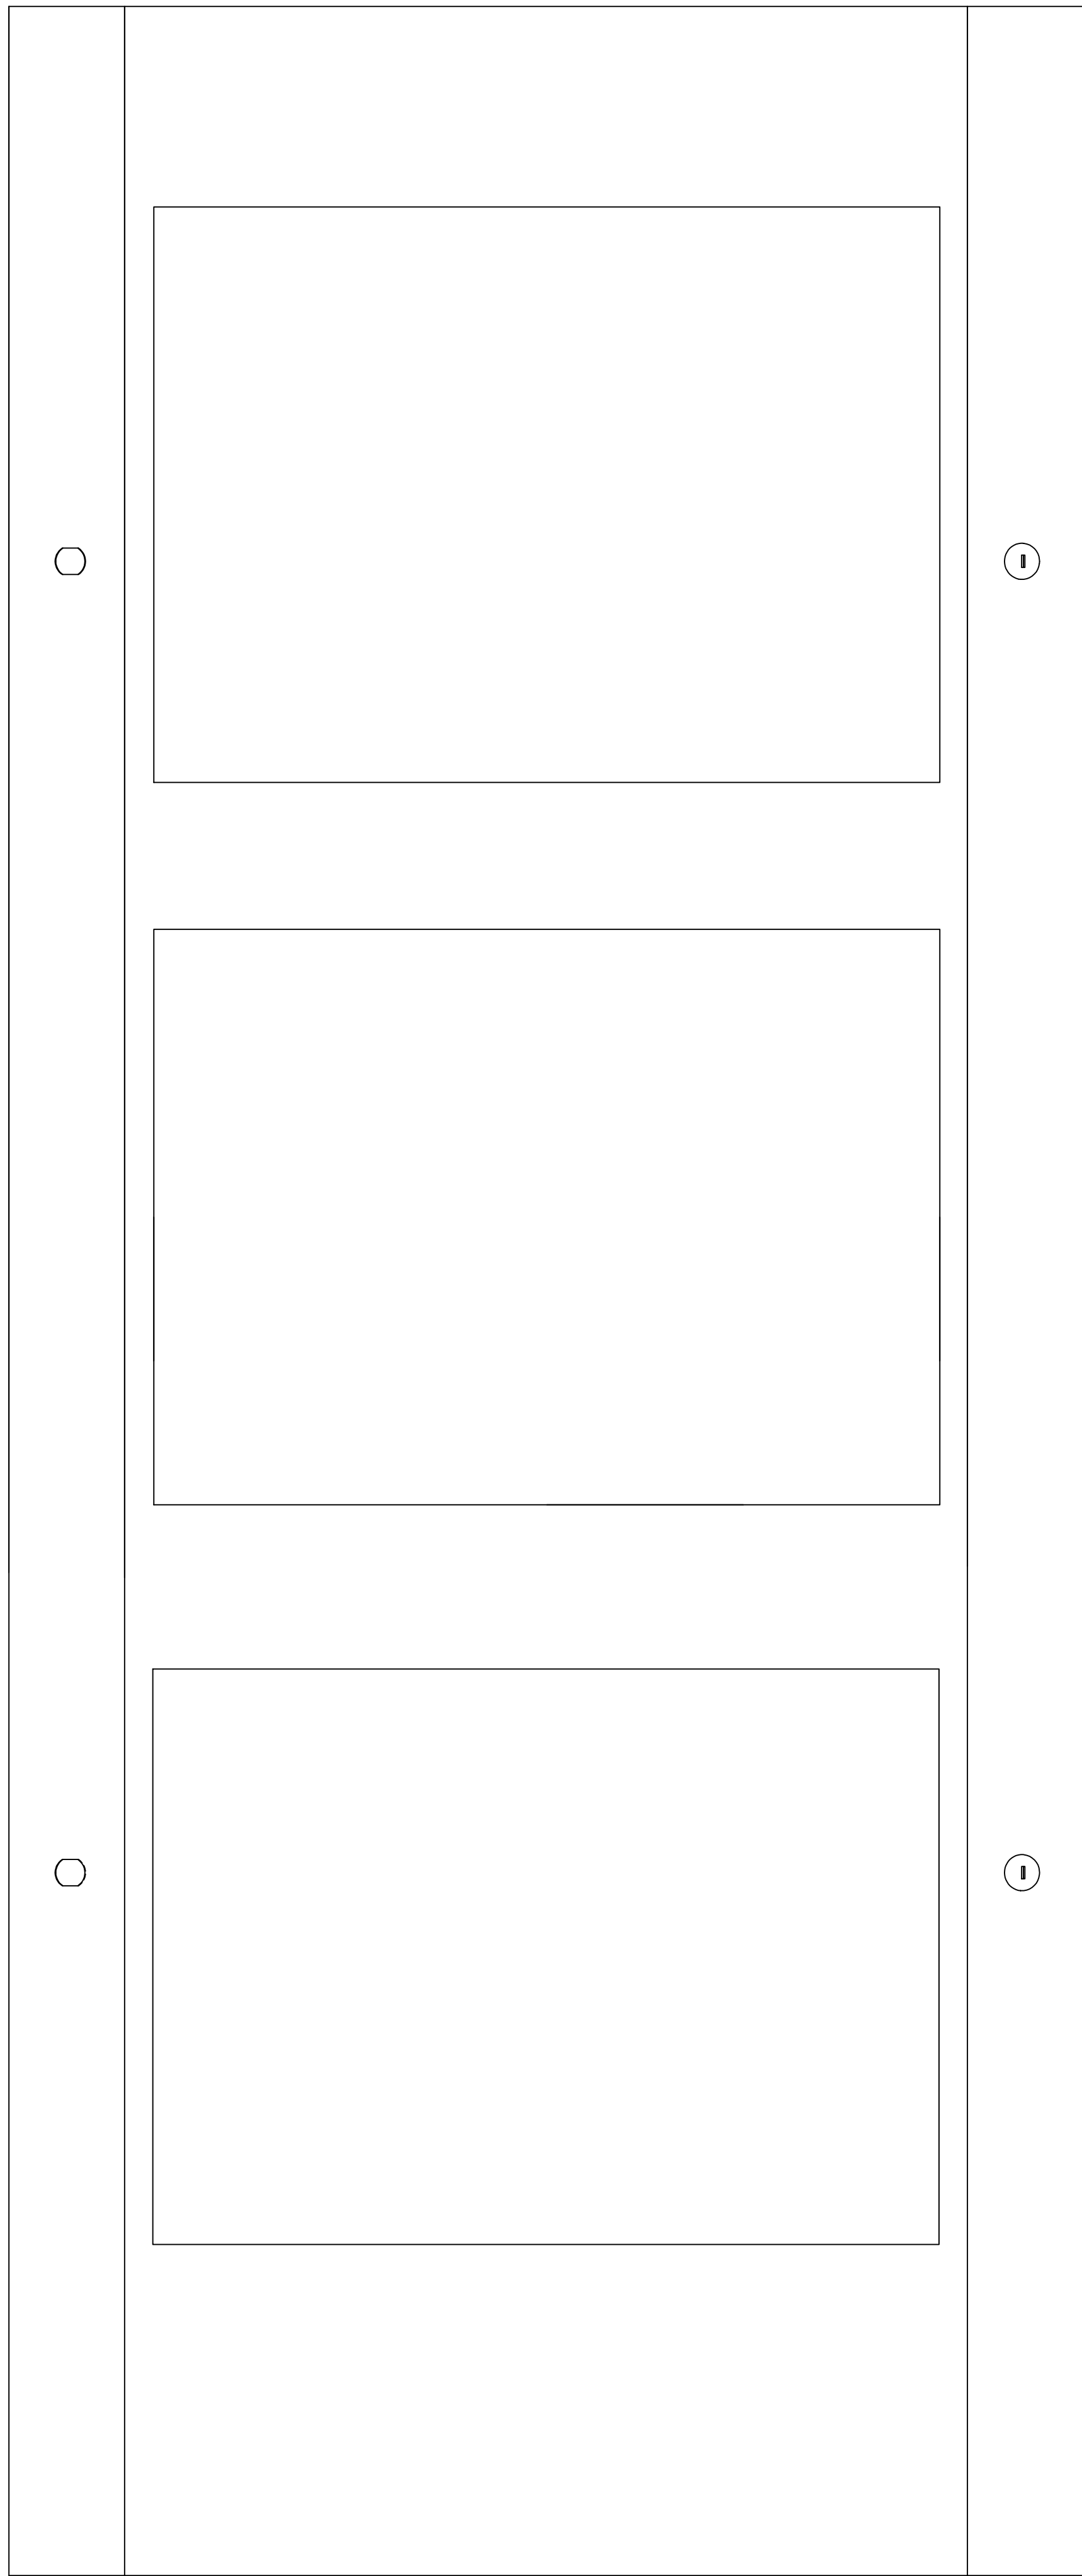

NODE 1

VOICE COMMUNICATION CONTROL PANEL VCP-10
LOCATED BLDG 11A 5TH FLR STAIR 11

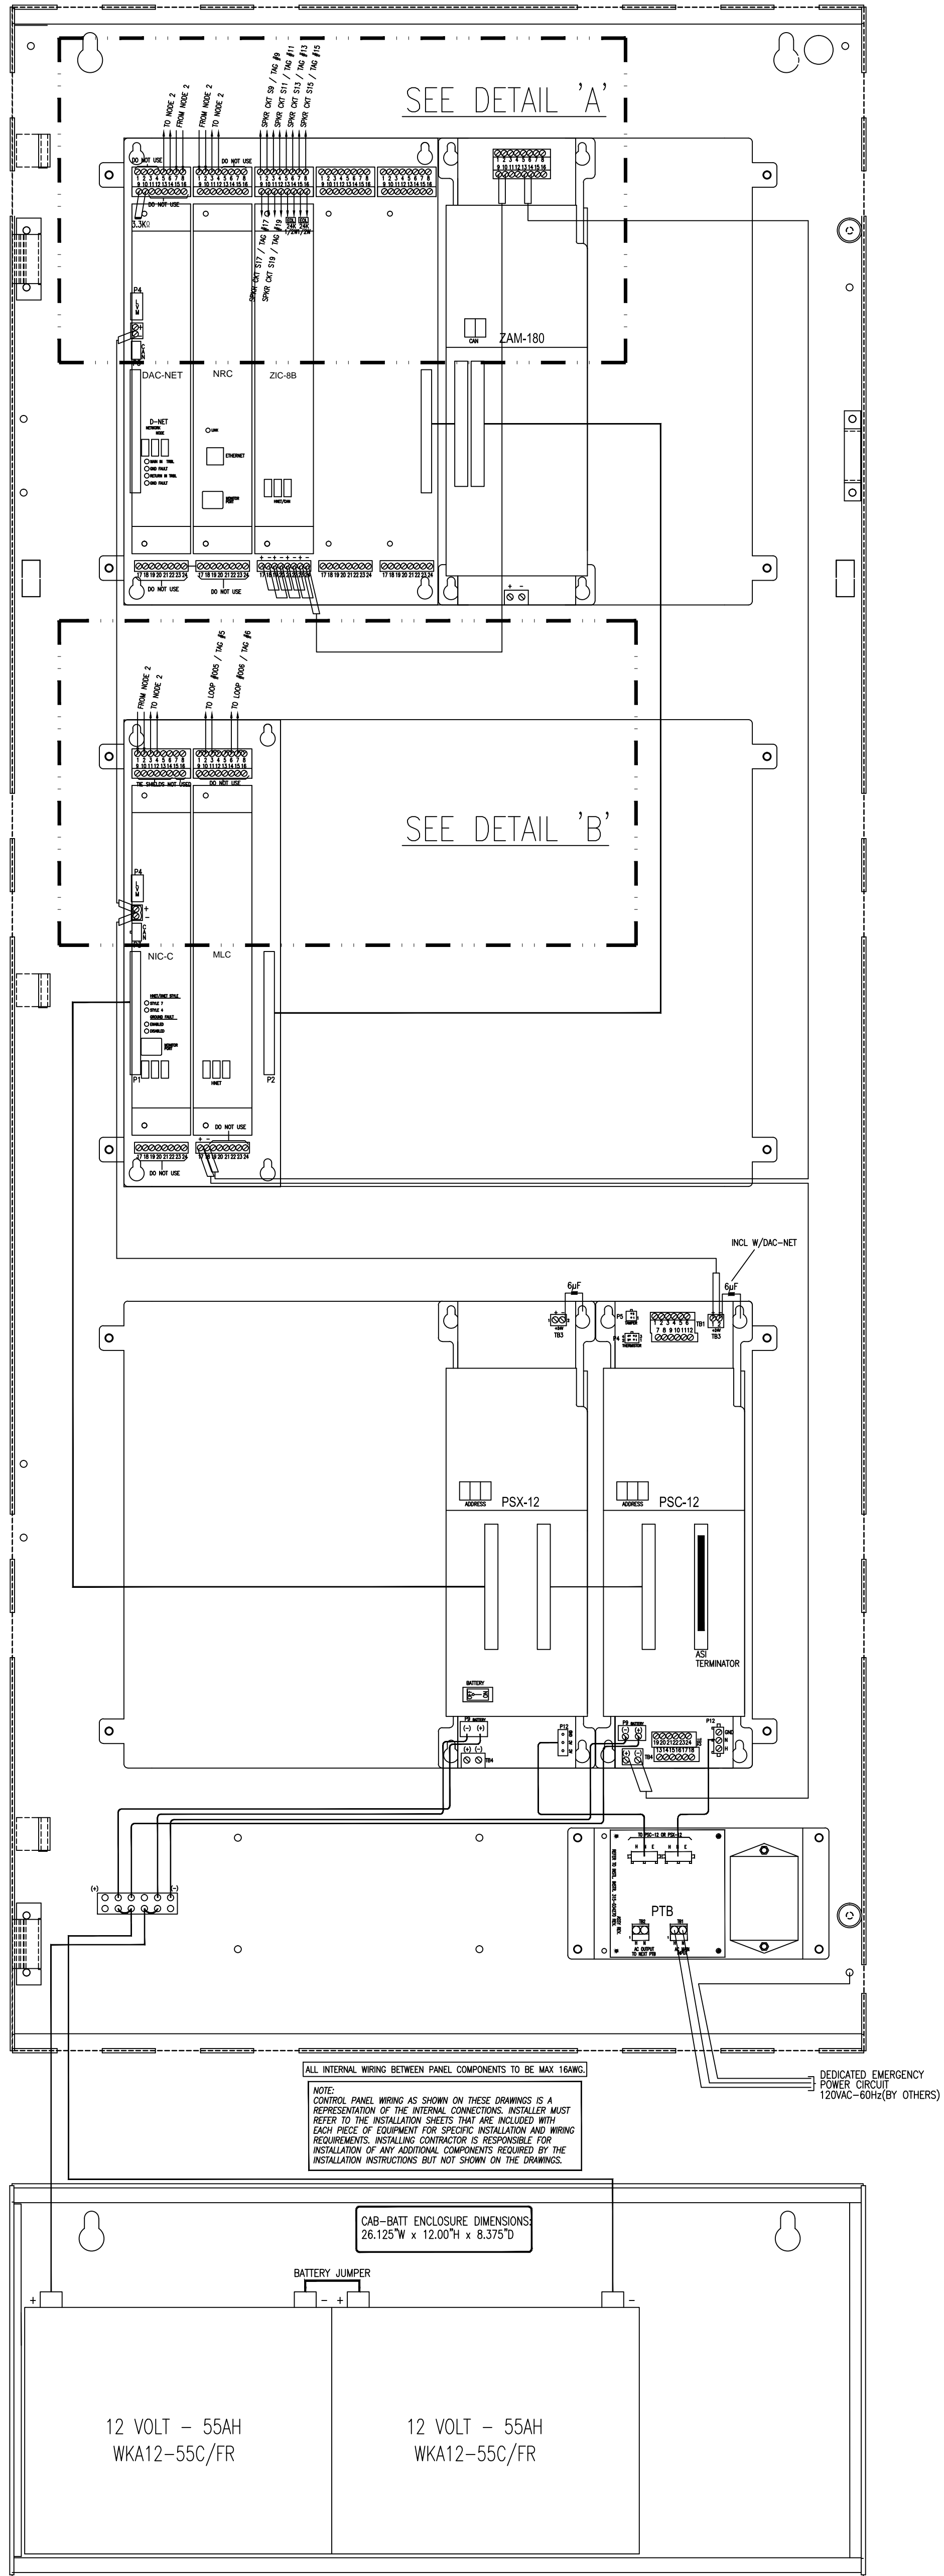

THE DRAWING AND DESIGN HEREIN SHALL NOT BE DUPLICATED, USED OR DISCLOSED TO OTHERS FOR PROCUREMENT OR OTHER PURPOSE (EXCEPT AS OTHERWISE AUTHORIZED BY CONTRACT) WITHOUT WRITTEN PERMISSION OF SIEMENS INDUSTRY INC. ALL REPRODUCTIONS SHALL BEAR THIS NOTICE.

REVISIONS

No.	Revision	By	Date
1			
2			
3			
4			
5			
6			
7			
8			
9			

PROFESSIONAL ENGINEERS APPROVAL STAMP:

DESIGN ENGINEERS:

CONTRACTOR'S NAME & ADDRESS:

PRODUCT MANUFACTURER:
Siemens Industry, Inc.
Building Technologies Division
Fire Safety and Security
CHICAGO BRANCH
585 SLAWIN COURT
Mount Prospect, Illinois 60056
Tel (847) 803-2700 Fax (847) 803-2733

JOB NAME & LOCATION (STREET ADDRESS)

**JESSE BROWN
VA MEDICAL CENTER
XLS MIGRATION**

CHICAGO, IL

SHEET CONTENTS:

**FIRE ALARM
NODE 1
VCP-10**

INSTALLATION TYPE

- ☐ NEW INSTALLATION
☐ DESIGN/BUILD
☐ PER CONTRACT DOCUMENT
☐ EXISTING BASE JOB # N/A
☐ OTHERS

SYSTEM SALES REP: BRIAN CULLEN

PROJECT MANAGER: TIM COSTELLO

DRAWN BY: SCOTT ANDERSON

CAD FILENAME:

SCALE: NO SCALE

DATE DRAWN:

12/2016

CHECKED BY:

JOB NUMBER



440P-203246

NETWORK #


5602799

SHEET

FA-03

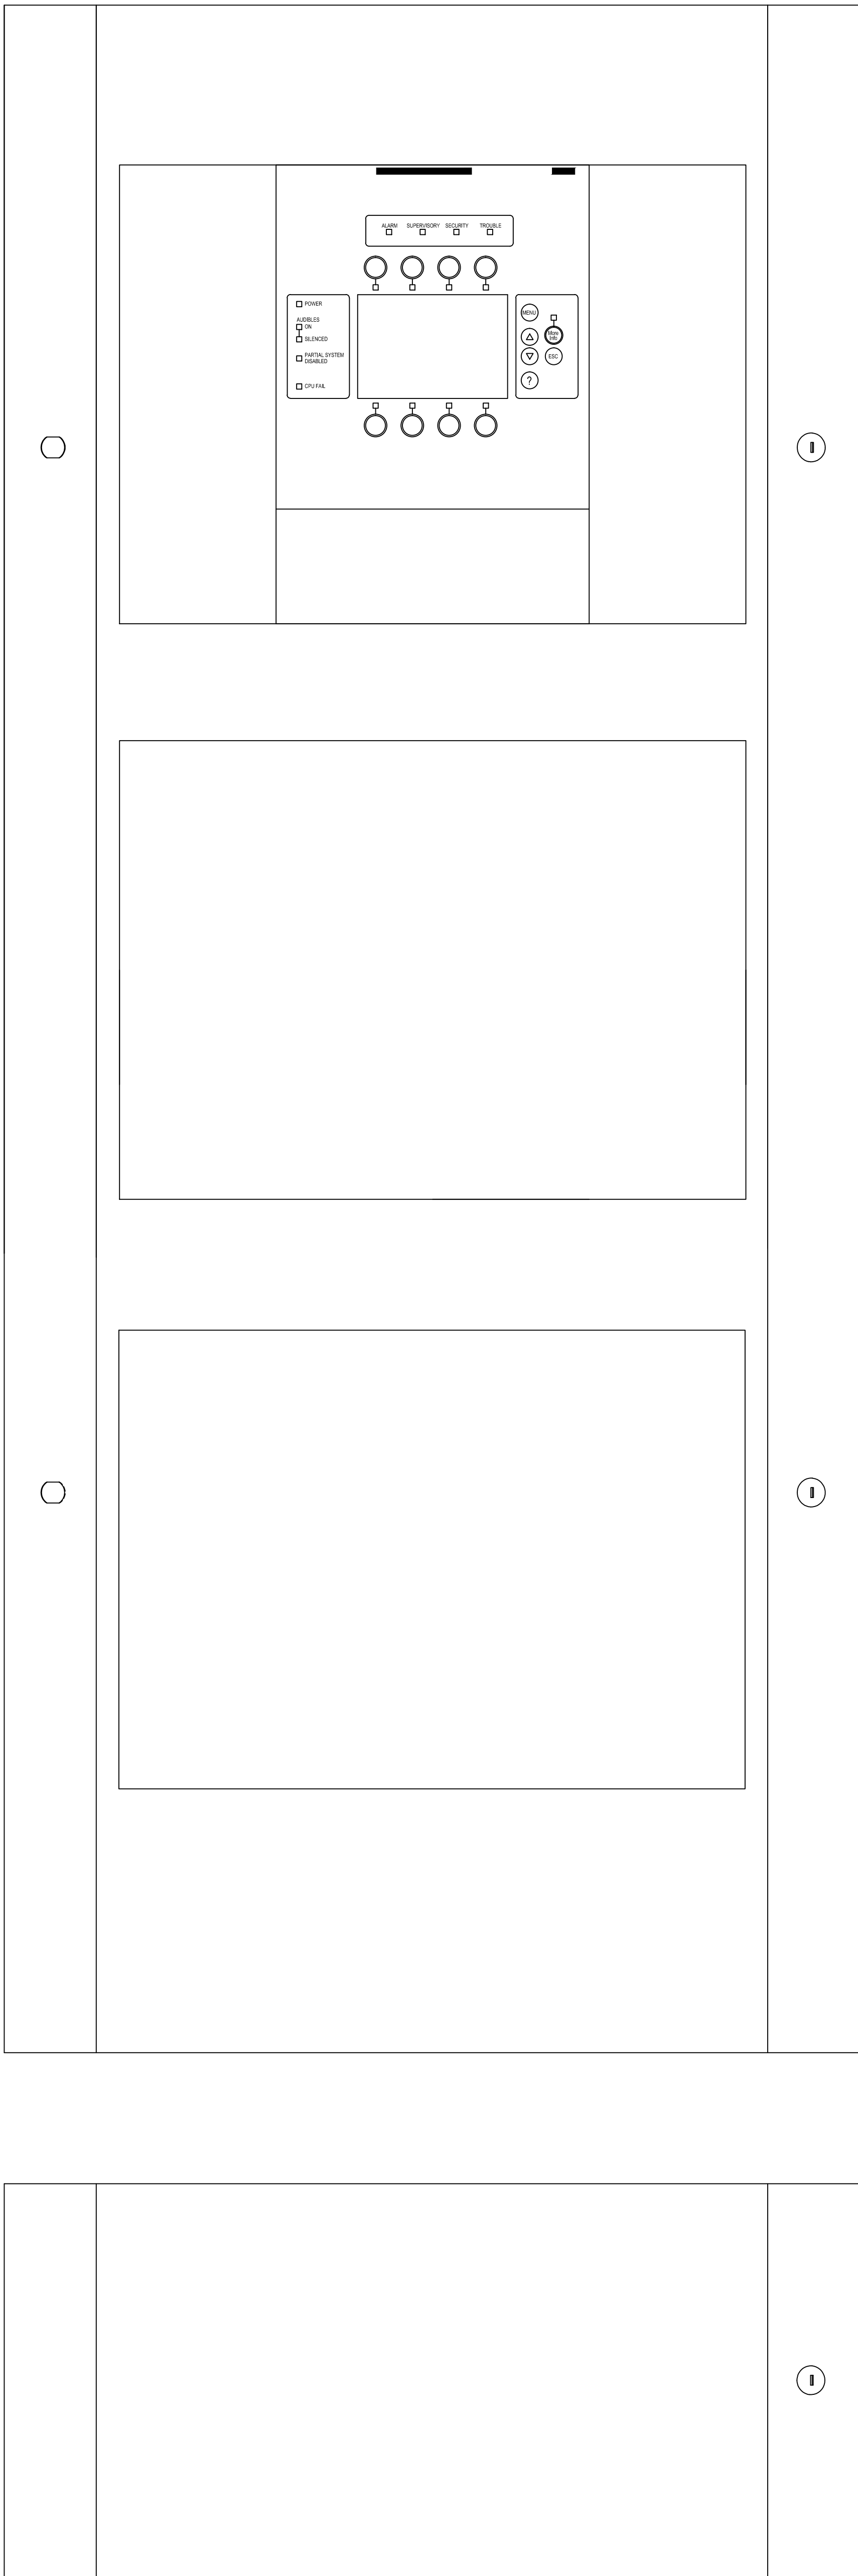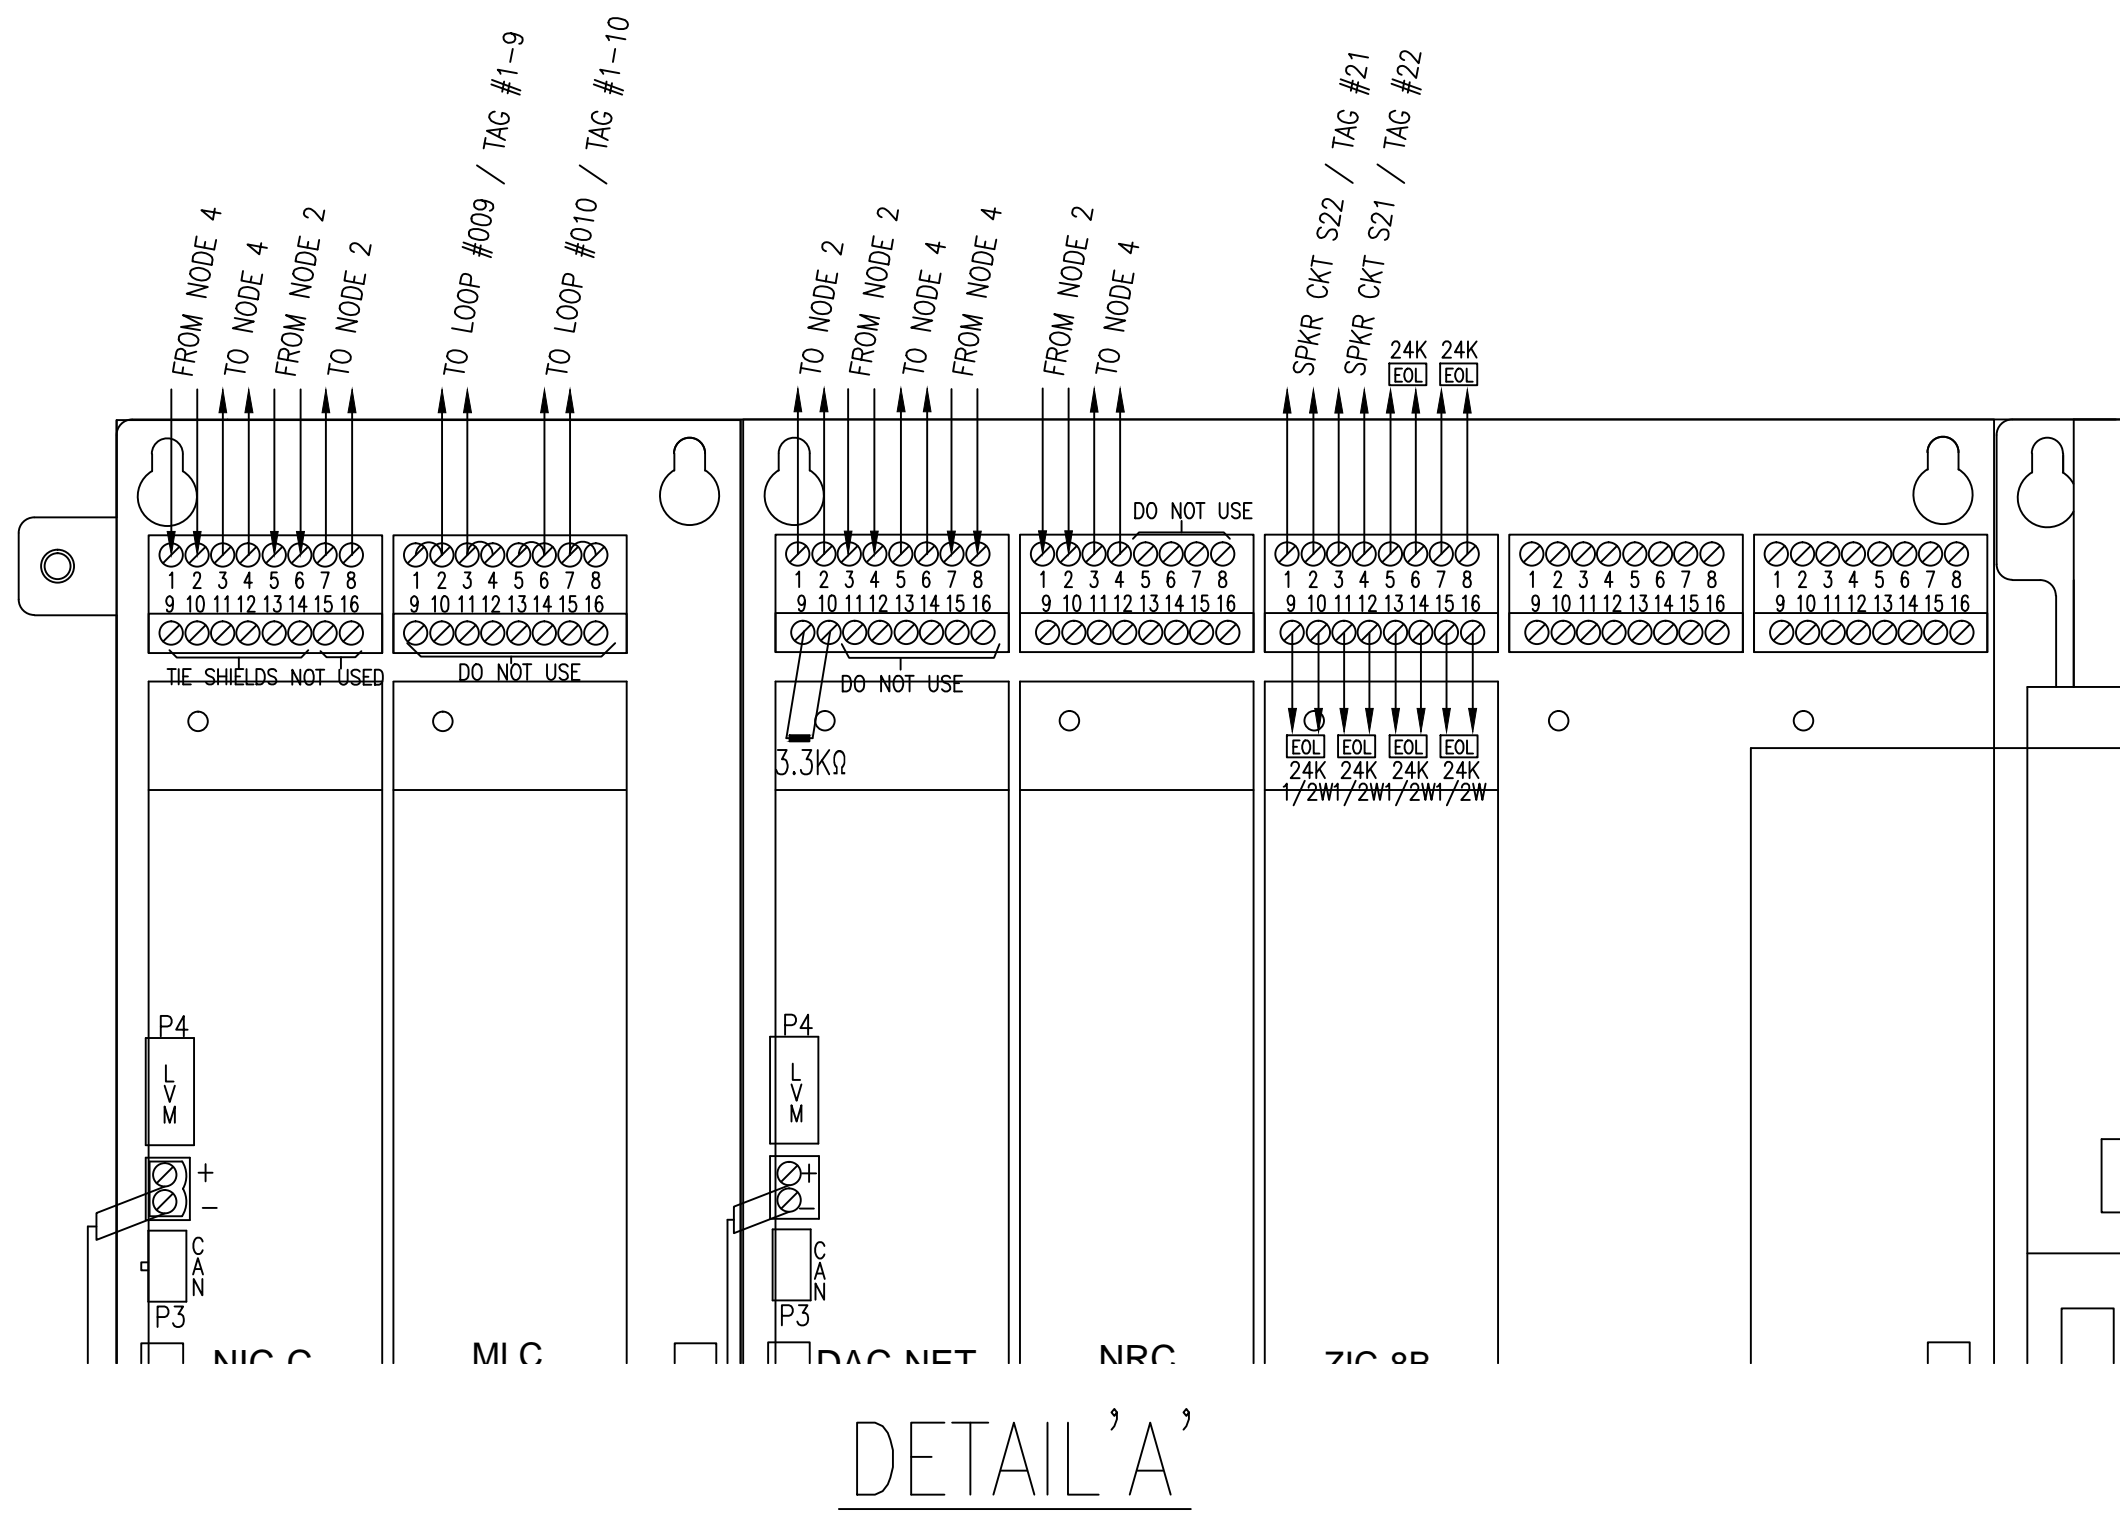

VOICE COMMUNICATION CONTROL PANEL VCP-9
LOCATED BLDG 30 1ST FLR RM 1103

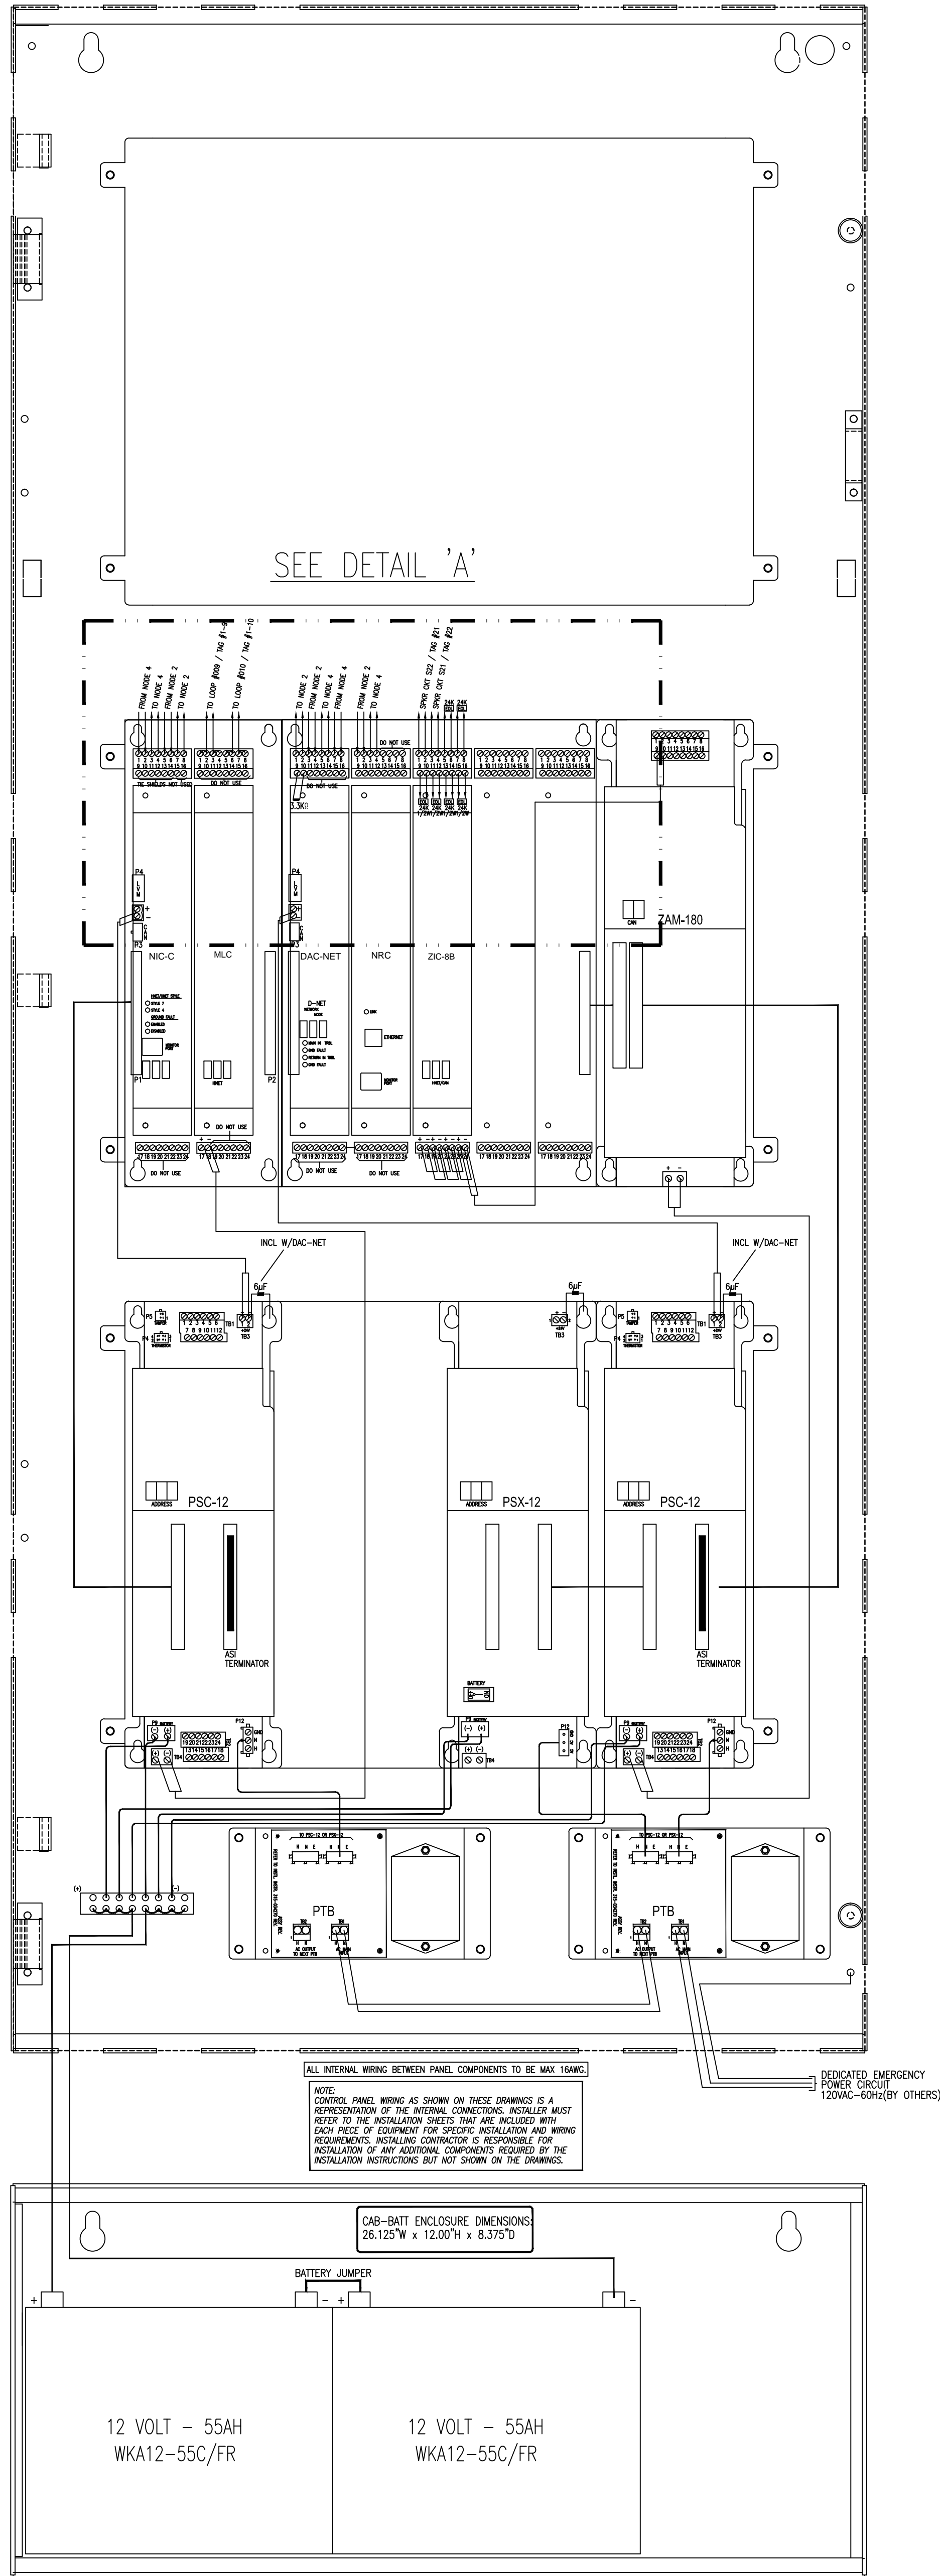

THE DRAWING AND DESIGN HEREIN SHALL NOT BE DUPLICATED, USED OR DISCLOSED TO OTHERS FOR PROCUREMENT OR OTHER PURPOSE, (EXCEPT AS OTHERWISE AUTHORIZED BY CONTRACT) WITHOUT WRITTEN PERMISSION OF SIEMENS INDUSTRY INC. ALL REPRODUCTIONS SHALL BEAR THIS NOTICE.

REVISIONS

No.	Revision	By	Date
1			
2			
3			
4			
5			
6			
7			
8			
9			

PROFESSIONAL ENGINEERS APPROVAL STAMP:

DESIGN ENGINEERS:

CONTRACTOR'S NAME & ADDRESS:

PRODUCT MANUFACTURER:
Siemens Industry, Inc.
Building Technologies Division
Fire Safety and Security
CHICAGO BRANCH
585 SLAWIN COURT
Mount Prospect, Illinois 60056
Tel (847) 803-2700 Fax (847) 803-2733

JOB NAME & LOCATION (STREET ADDRESS):

**JESSE BROWN
VA MEDICAL CENTER
XLS MIGRATION**

CHICAGO, IL

SHEET CONTENTS:

**FIRE ALARM
NODE 3
VCP-9**

INSTALLATION TYPE:

- ☐ NEW INSTALLATION
☐ DESIGN/BUILD
☐ PER CONTRACT DOCUMENT
☐ EXISTING BASE JOB # N/A
☐ OTHERS

SYSTEM SALES REP: **BRIAN CULLEN**

PROJECT MANAGER: **TIM COSTELLO**

DRAWN BY: **SCOTT ANDERSON**

CAD FILENAME:

SCALE: **NO SCALE**

DATE DRAWN:

12/2016

CHECKED BY:

JOB NUMBER:


440P-203246

SHEET


NETWORK:

5602799

FA-05

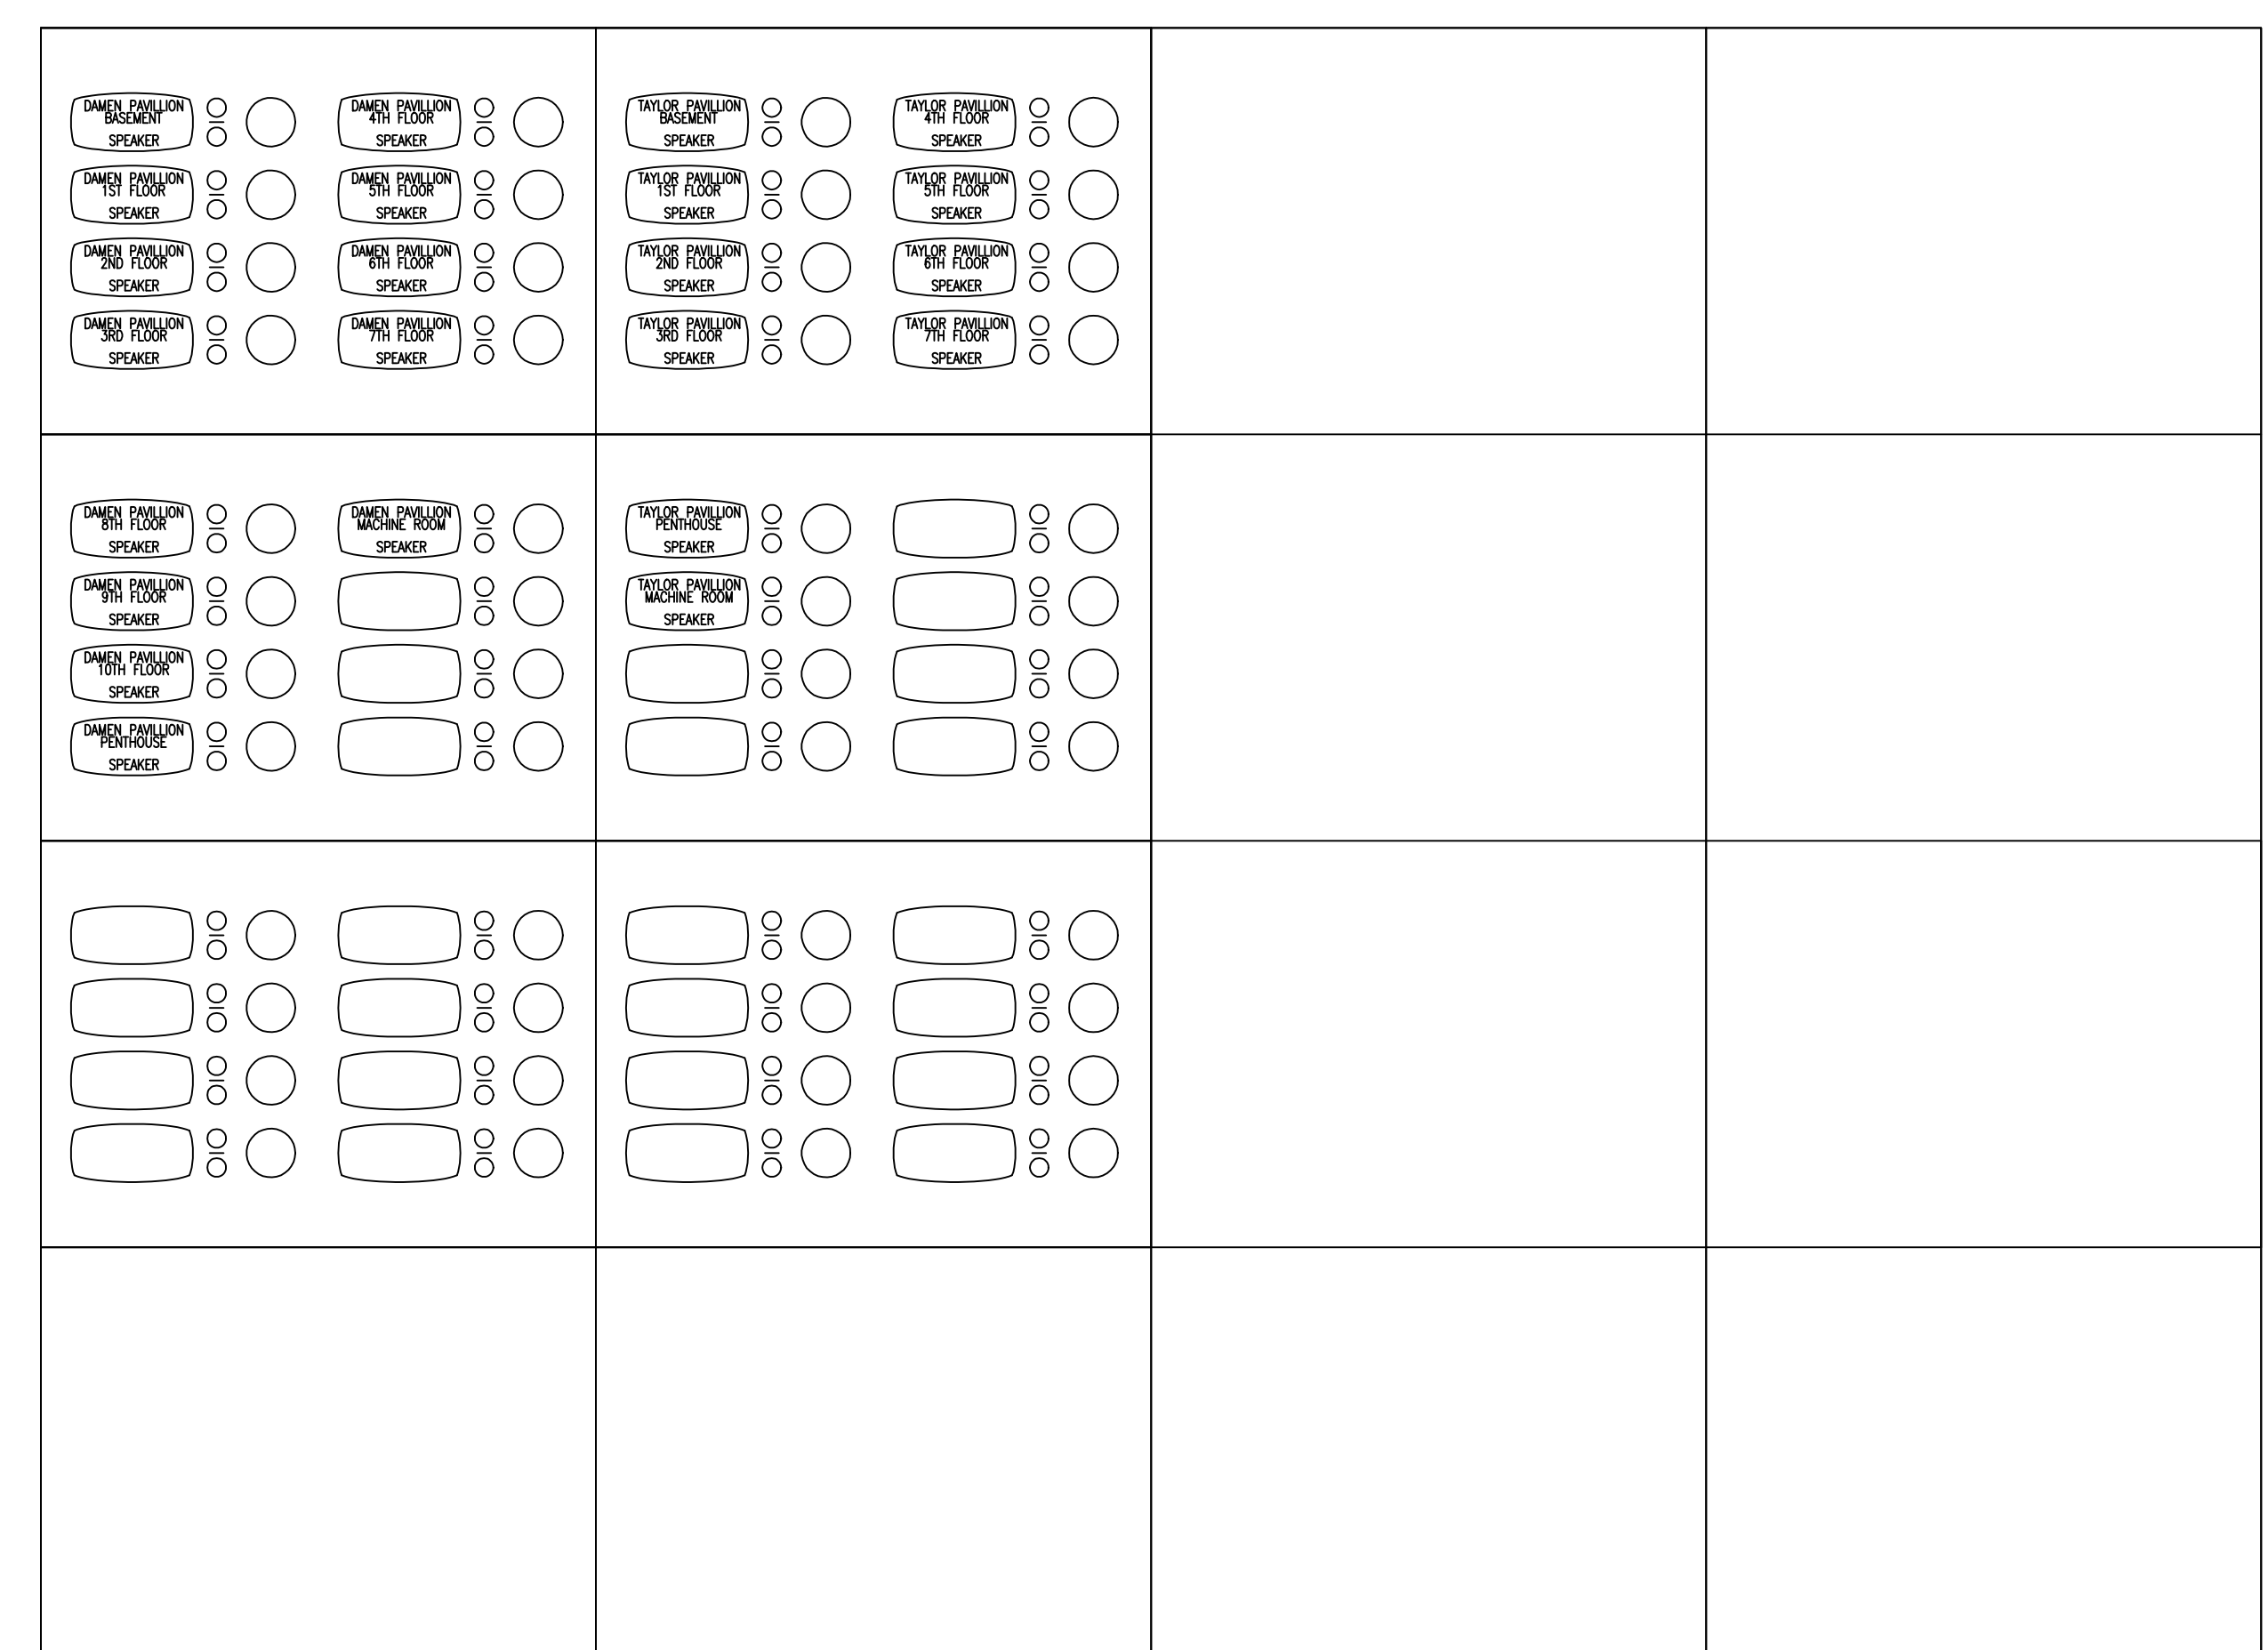

SEE DETAIL 'B'

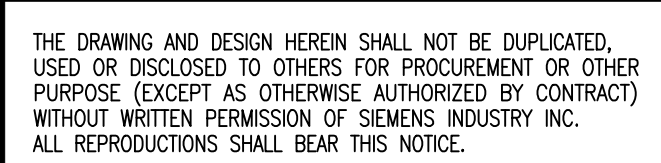

No.	Revision	By	Date
1			
2			
3			
4			
5			
6			
7			
8			
9			

DESIGN ENGINEERS:

CONTRACTOR'S NAME & ADDRESS

PRODUCT MANUFACTURER:	
-----------------------	--

CHICAGO BRANCH
585 SLAWIN COURT
Mt Prospect, Illinois 60056
800-327-2700 Fax (847) 803-2733

JOB NAME & LOCATION (STREET ADDRESS)

CHICAGO, IL

SHEET CONTENTS:

INSTALLATION TYPE

☐ NEW INSTALLATION

☐ DESIGN/BUILD

☐ PER CONTRACT DOCUMENTS

☐ EXISTING BASE JOBS

☐ OTHERS

SYSTEM SALES REP.: BRIAN CULLEN

PROJECT MANAGER: TIM COSTELLO

DRAWN BY: SCOTT ANDERSON

CAD FILENAME:

SCALE: NO SCALE


DATE DRAWN:

CHECKED BY



JOB NUMBER
44OP-203246

	SWEET
--	-------

FA-06

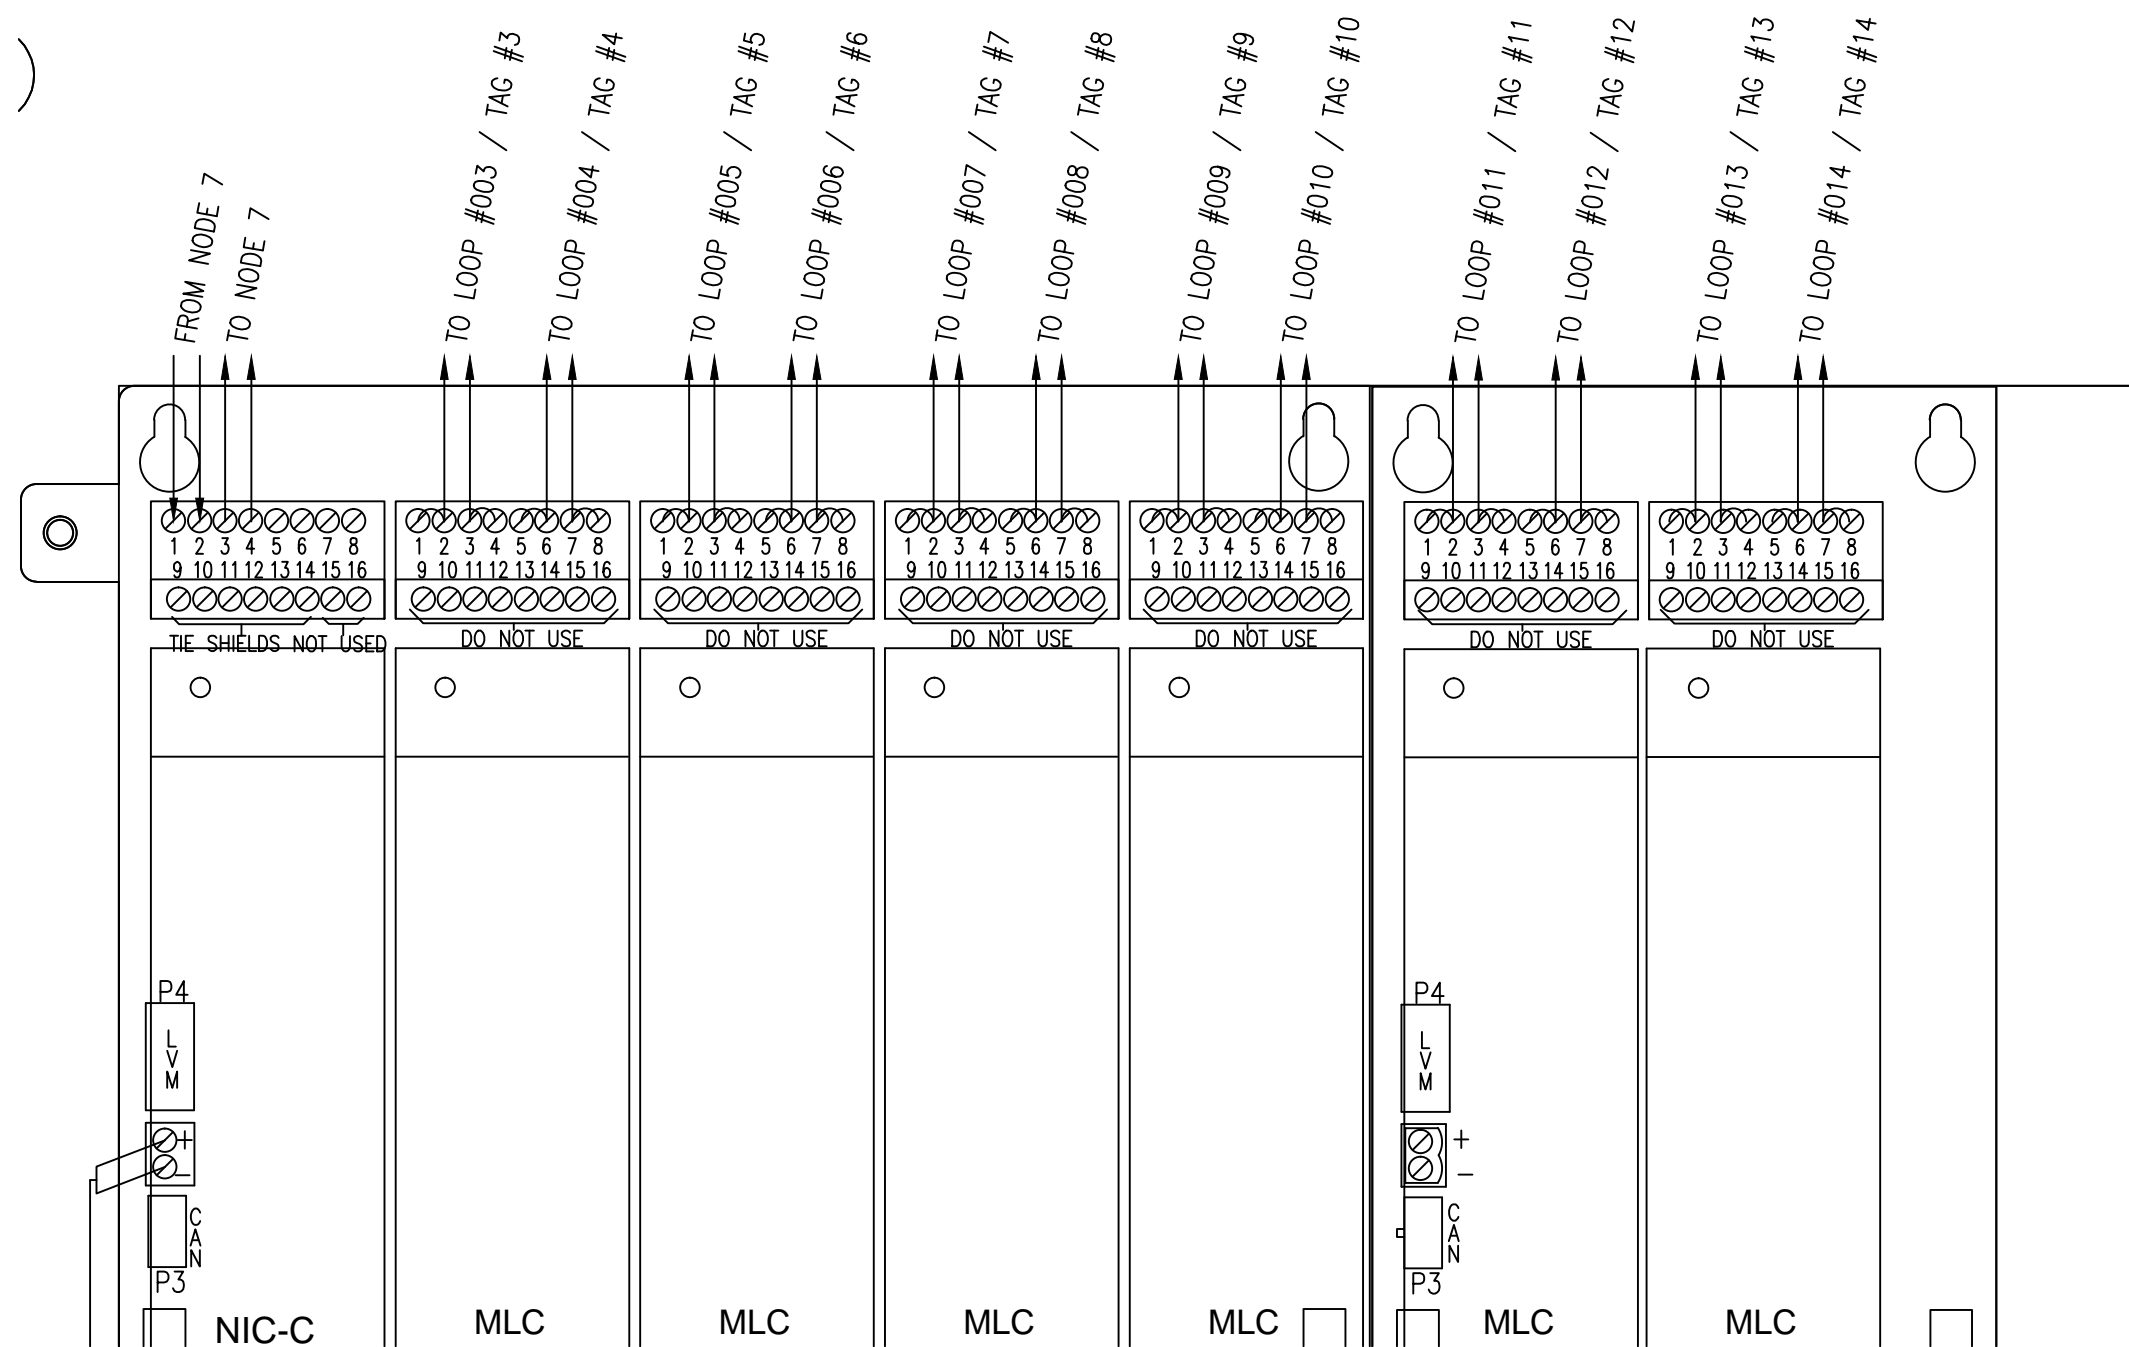

DETAIL 'A'

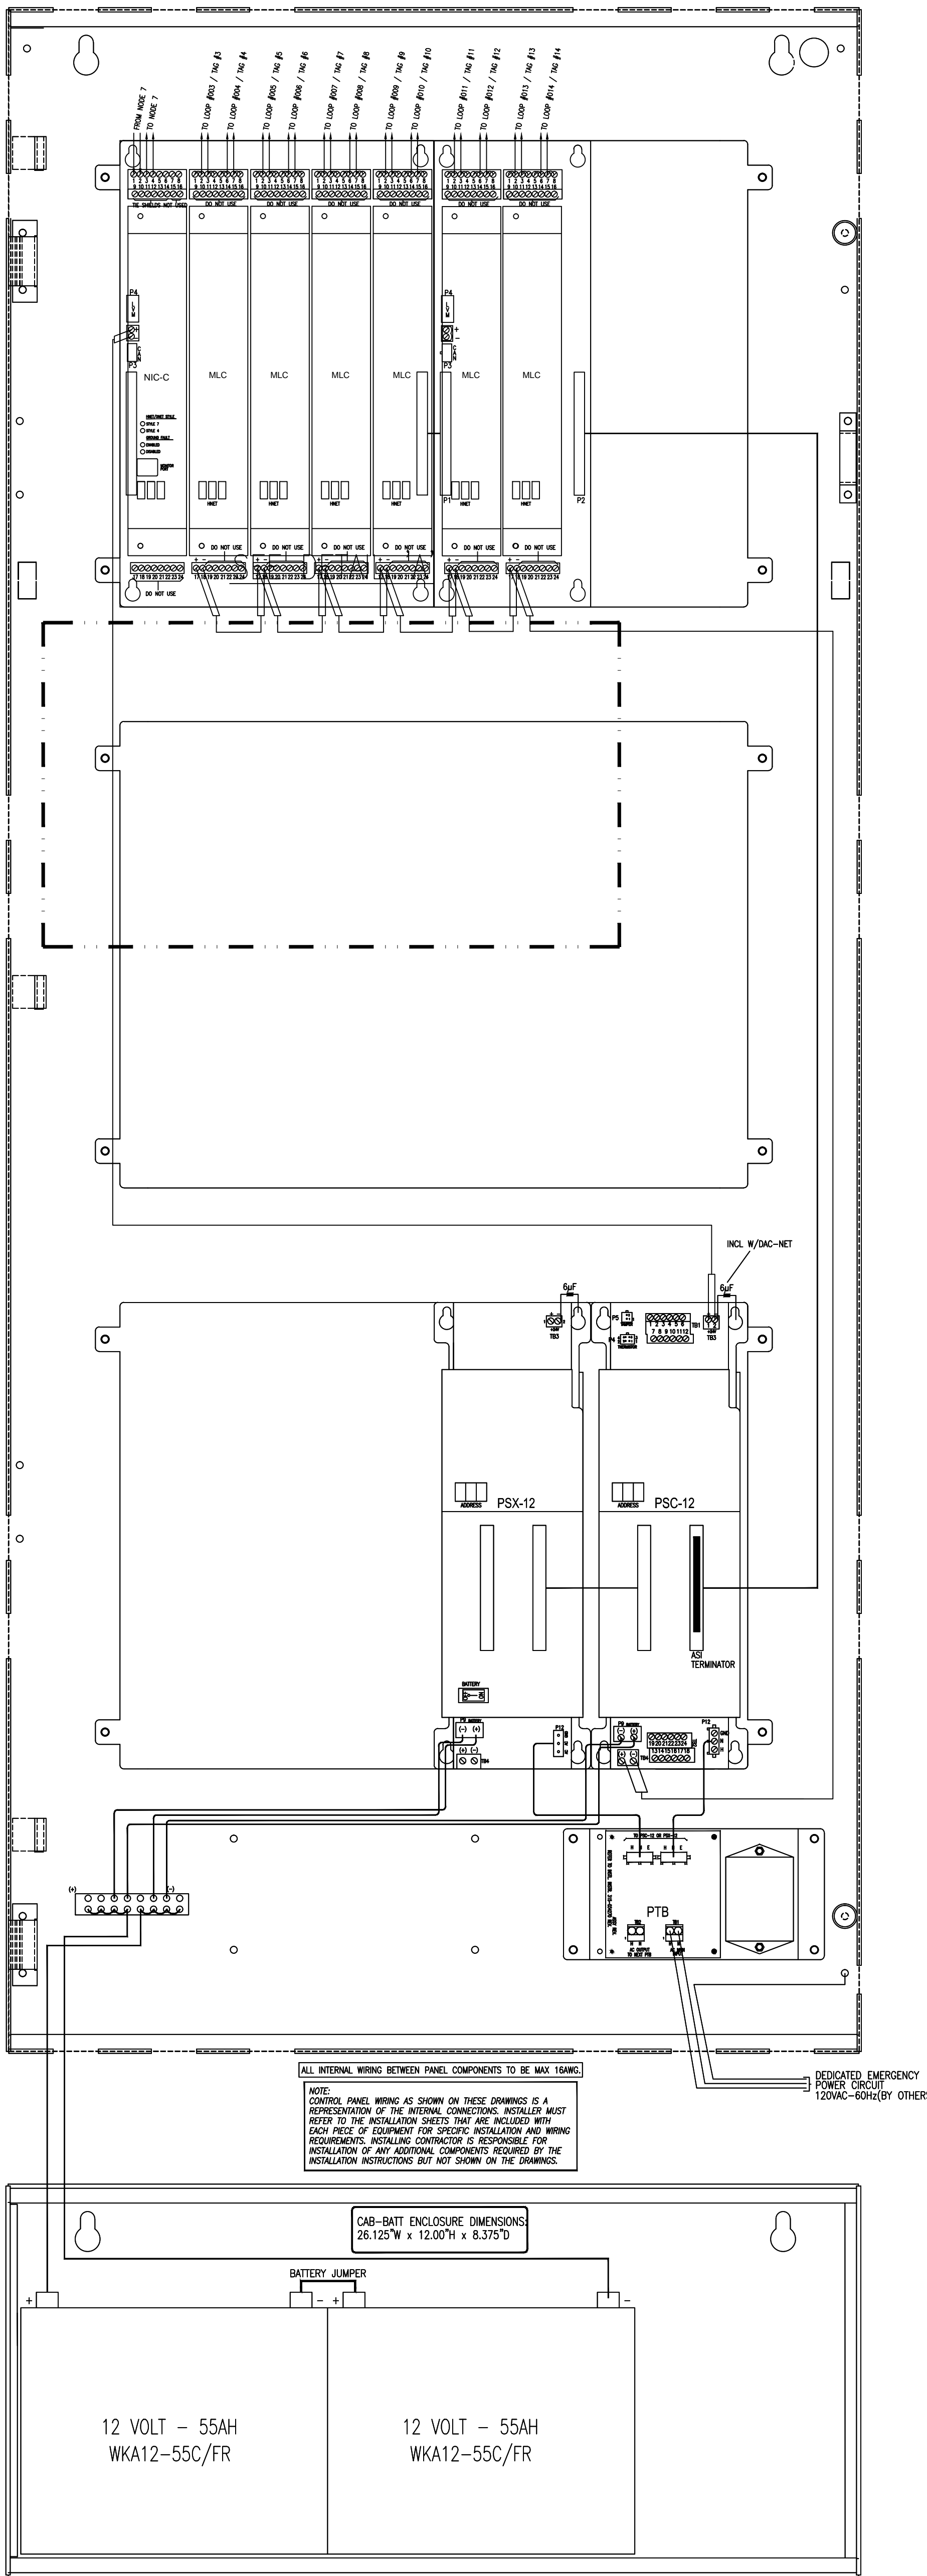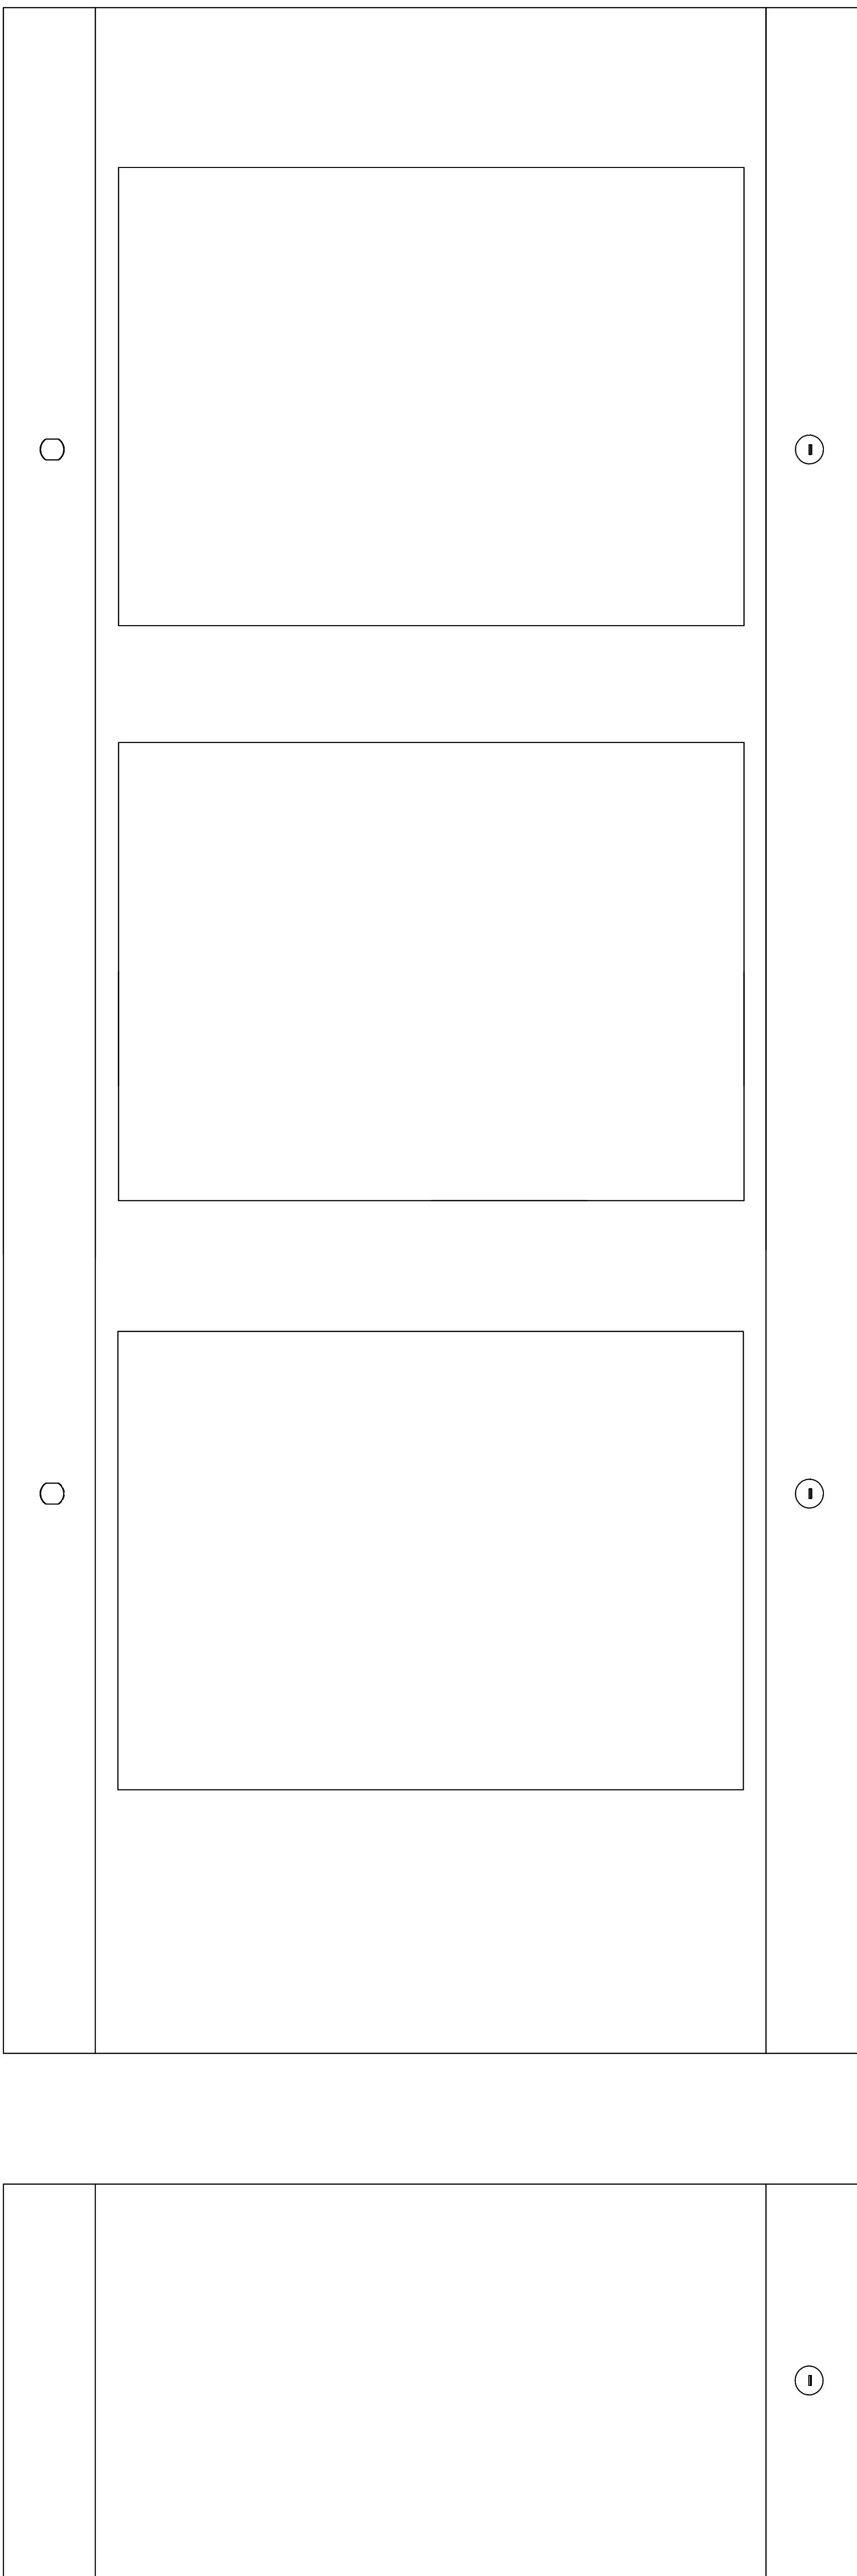

VOICE COMMUNICATION CONTROL PANEL VCP-4
LOCATED BLDG 1 2ND FLR STAIR #1

THE DRAWING AND DESIGN HEREIN SHALL NOT BE DUPLICATED, USED OR DISCLOSED TO OTHERS FOR PROCUREMENT OR OTHER PURPOSE (EXCEPT AS OTHERWISE AUTHORIZED BY CONTRACT) WITHOUT WRITTEN PERMISSION OF SIEMENS INDUSTRY INC. ALL REPRODUCTIONS SHALL BEAR THIS NOTICE.

REVISIONS

No.	Revision	By	Date
1			
2			
3			
4			
5			
6			
7			
8			
9			

PROFESSIONAL ENGINEERS APPROVAL STAMP:

DESIGN ENGINEERS:

CONTRACTOR'S NAME & ADDRESS:

PRODUCT MANUFACTURER:
Siemens Industry, Inc.
Building Technologies Division
Fire Safety and Security
CHICAGO BRANCH
585 SLAWIN COURT
Mount Prospect, Illinois 60056
Tel (847) 803-2700 Fax (847) 803-2733

JOB NAME & LOCATION (STREET ADDRESS)

**JESSE BROWN
VA MEDICAL CENTER
XLS MIGRATION**

CHICAGO, IL

SHEET CONTENTS:

FIRE ALARM

VCP-4

INSTALLATION TYPE

- ☐ NEW INSTALLATION
☐ DESIGN/BUILD
☐ PER CONTRACT DOCUMENT
☐ EXISTING BASE JOB # N/A
☐ OTHERS

SYSTEM SALES REP: **BRIAN CULLEN**

PROJECT MANAGER: **TIM COSTELLO**

DRAWN BY: **SCOTT ANDERSON**

CAD FILENAME:

SCALE: **NO SCALE**

DATE DRAWN:

12/2016

JOB NUMBER

440P-203246


NETWORK

5602799


SHEET

FA-07



FA-08

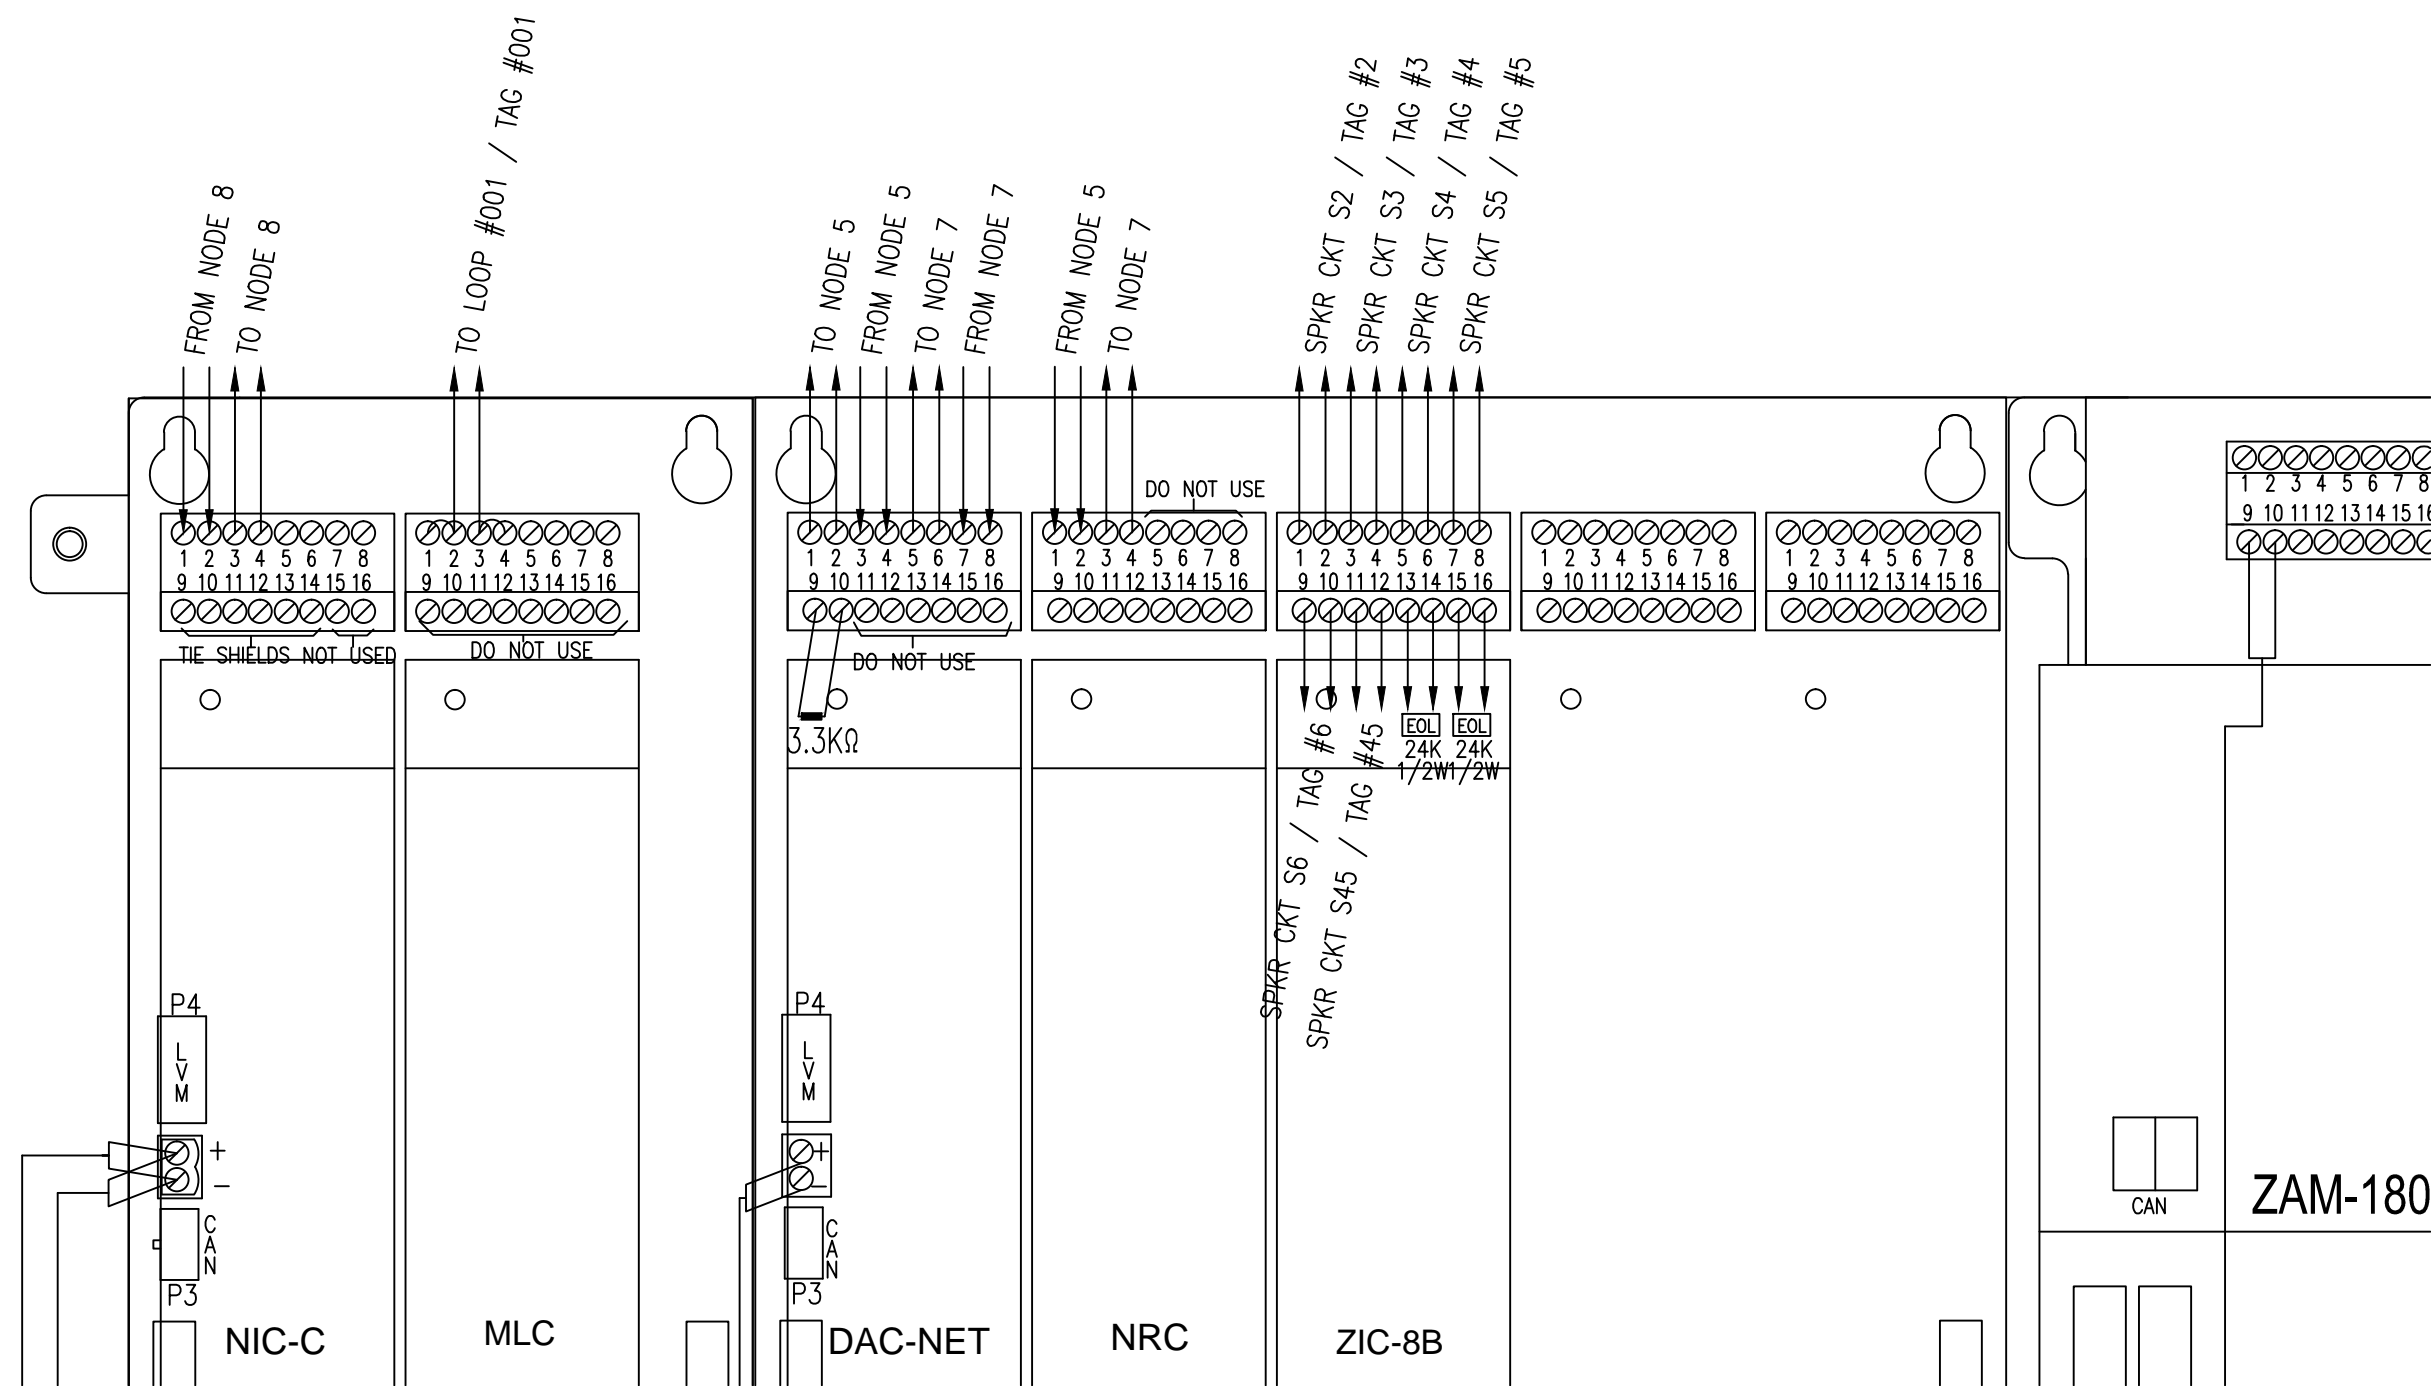


DETAIL 'A'

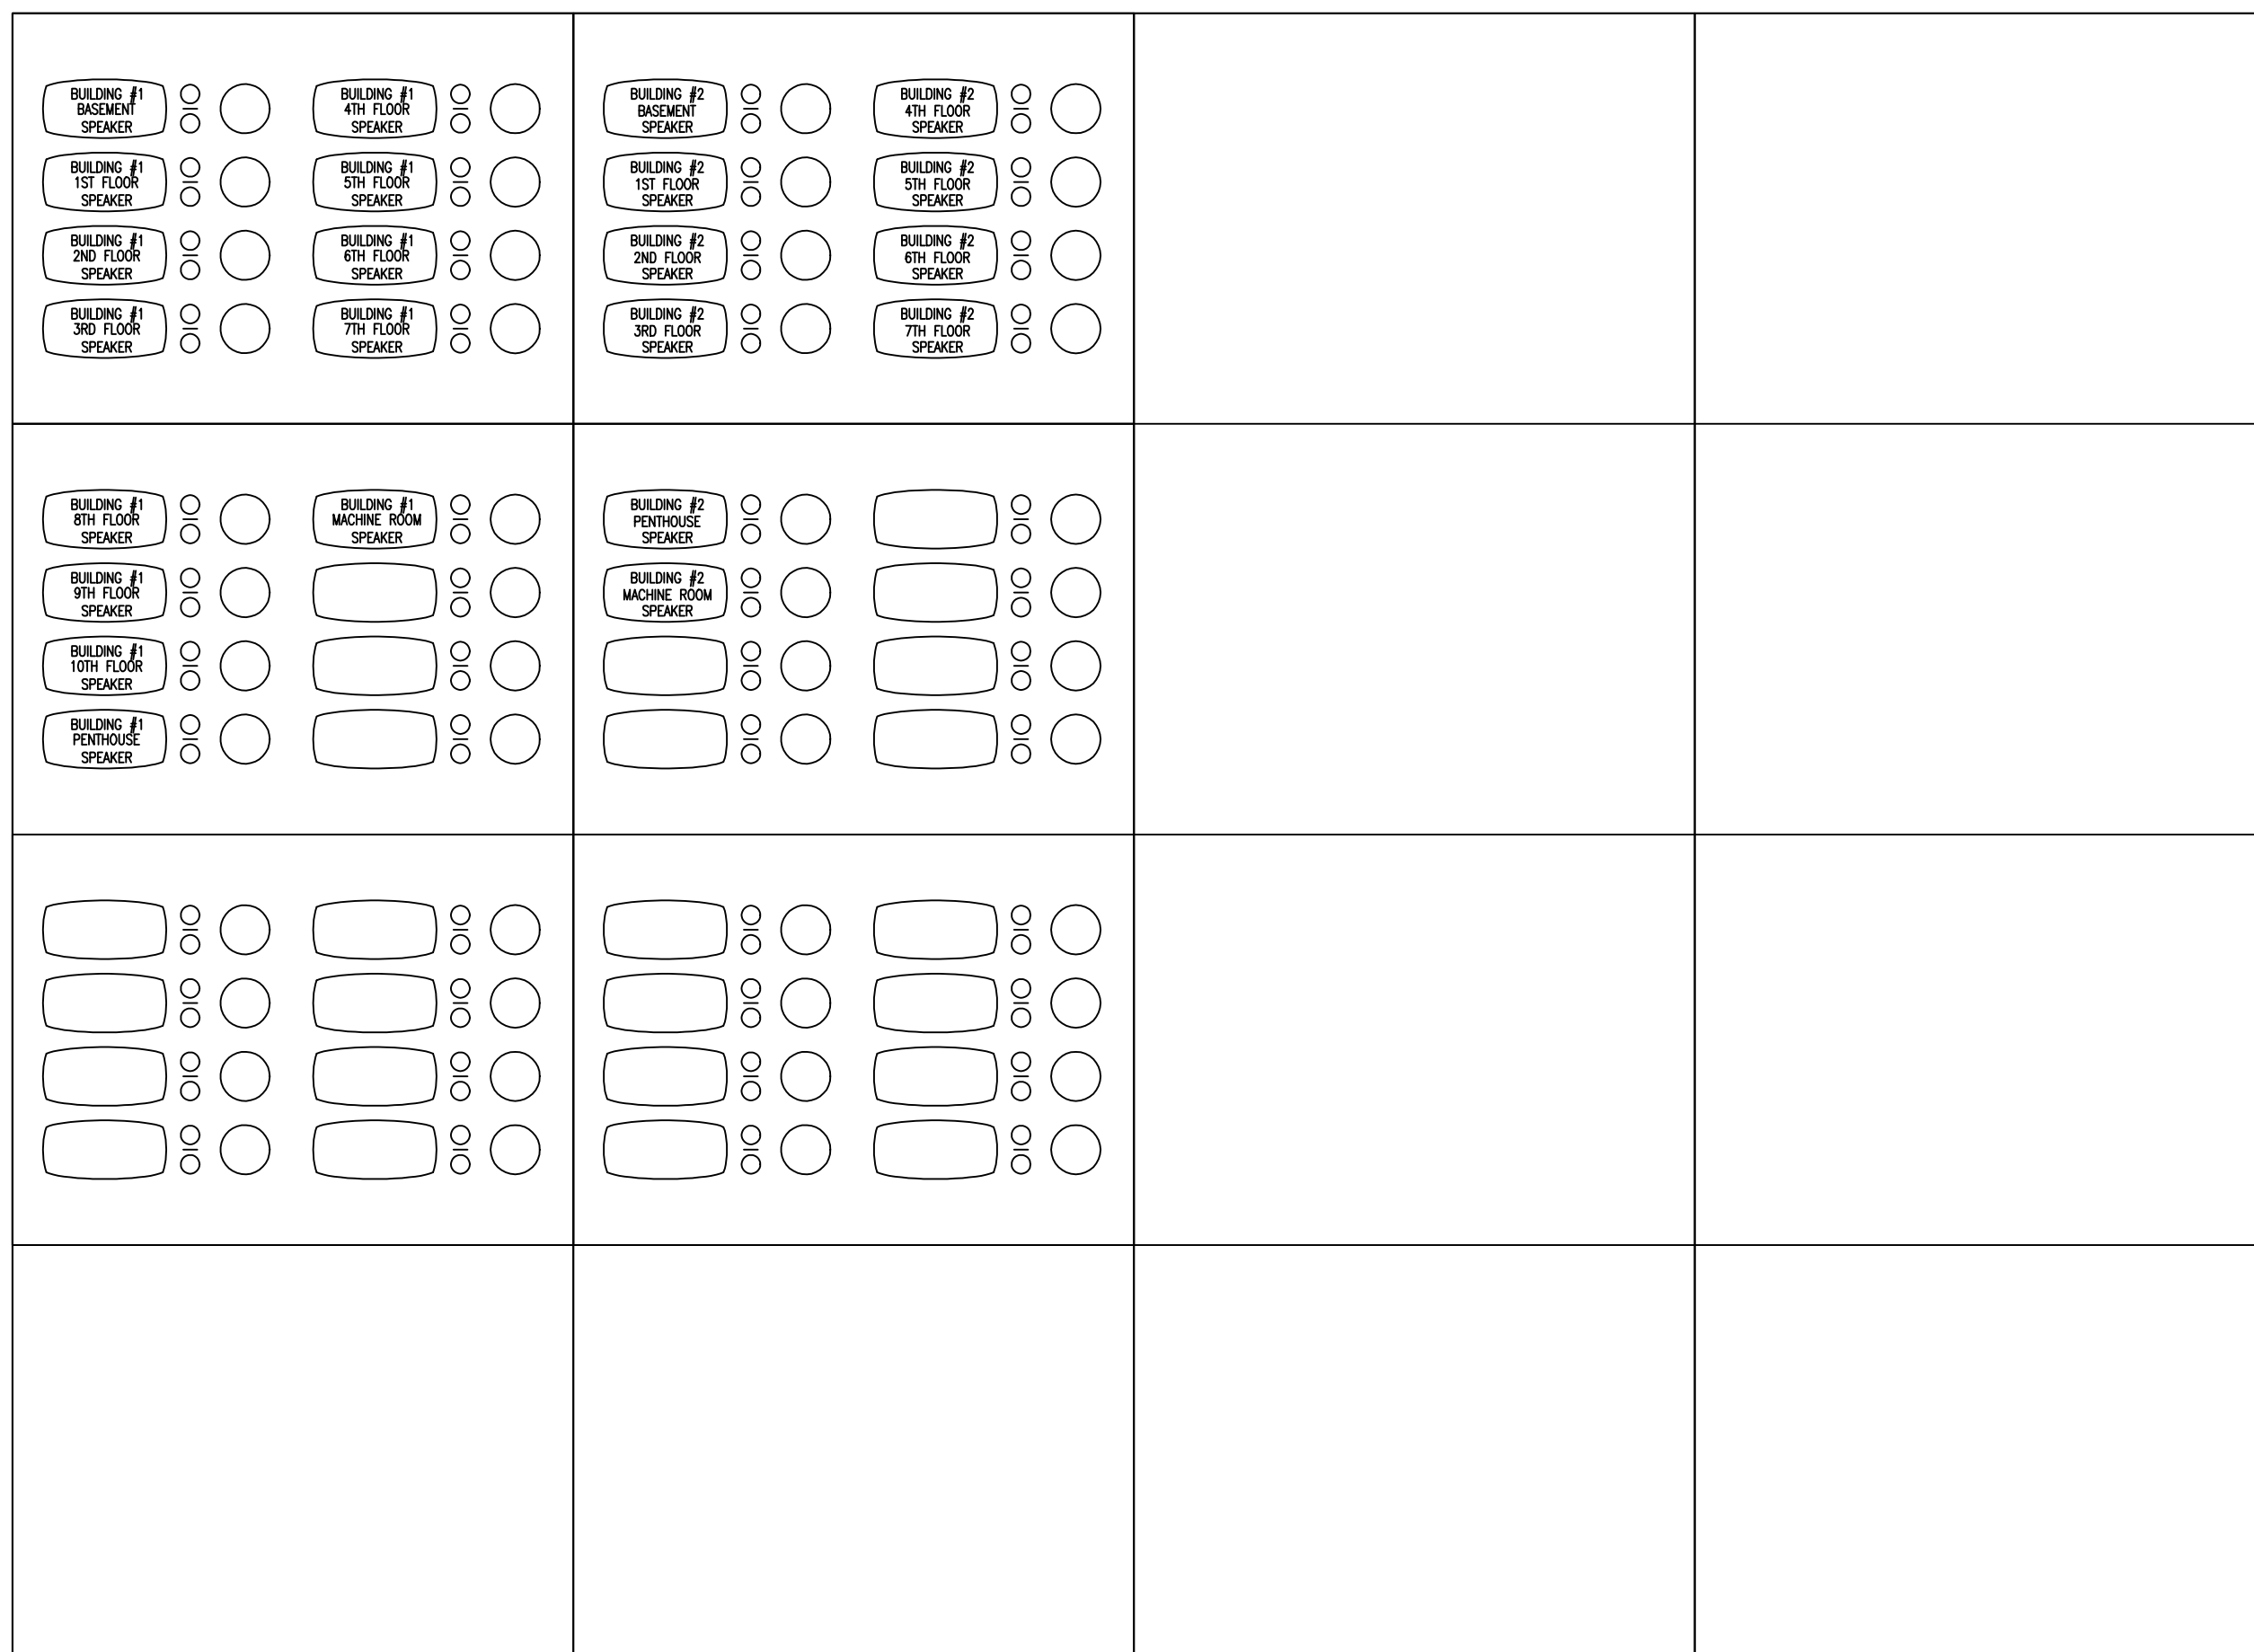

DETAIL 'B'

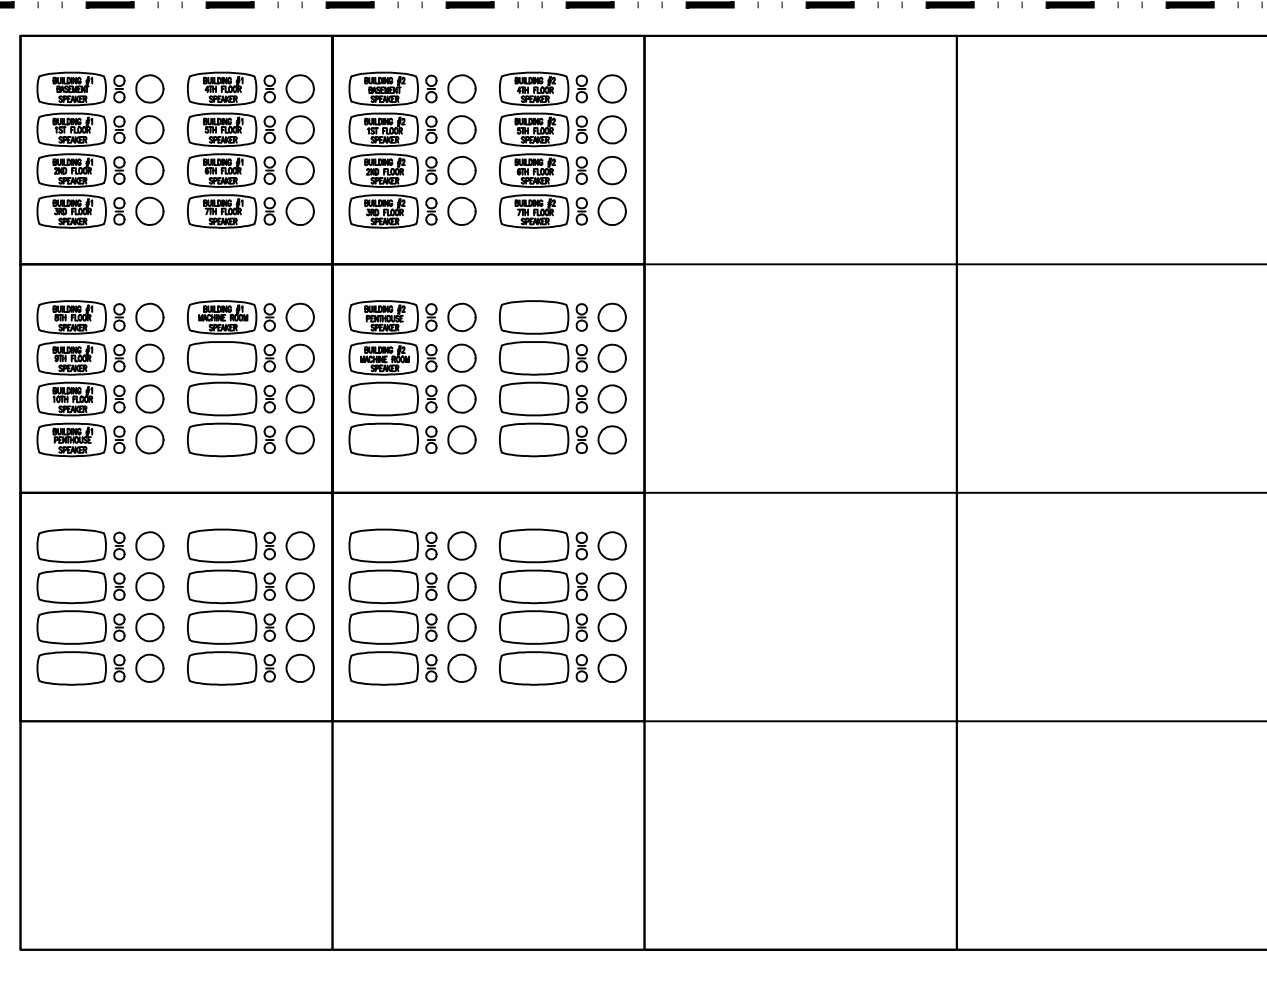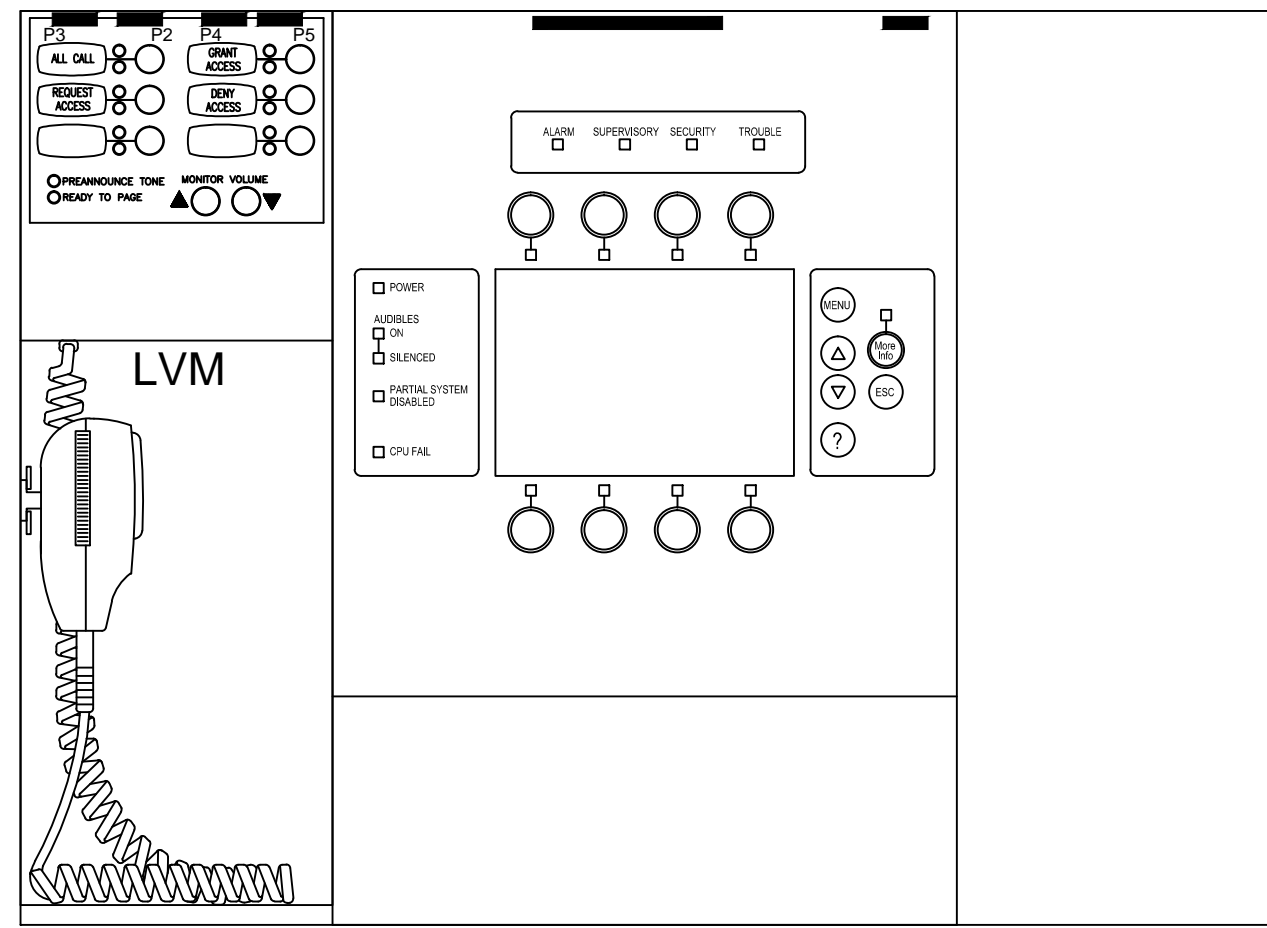


SEE DETAIL 'B'

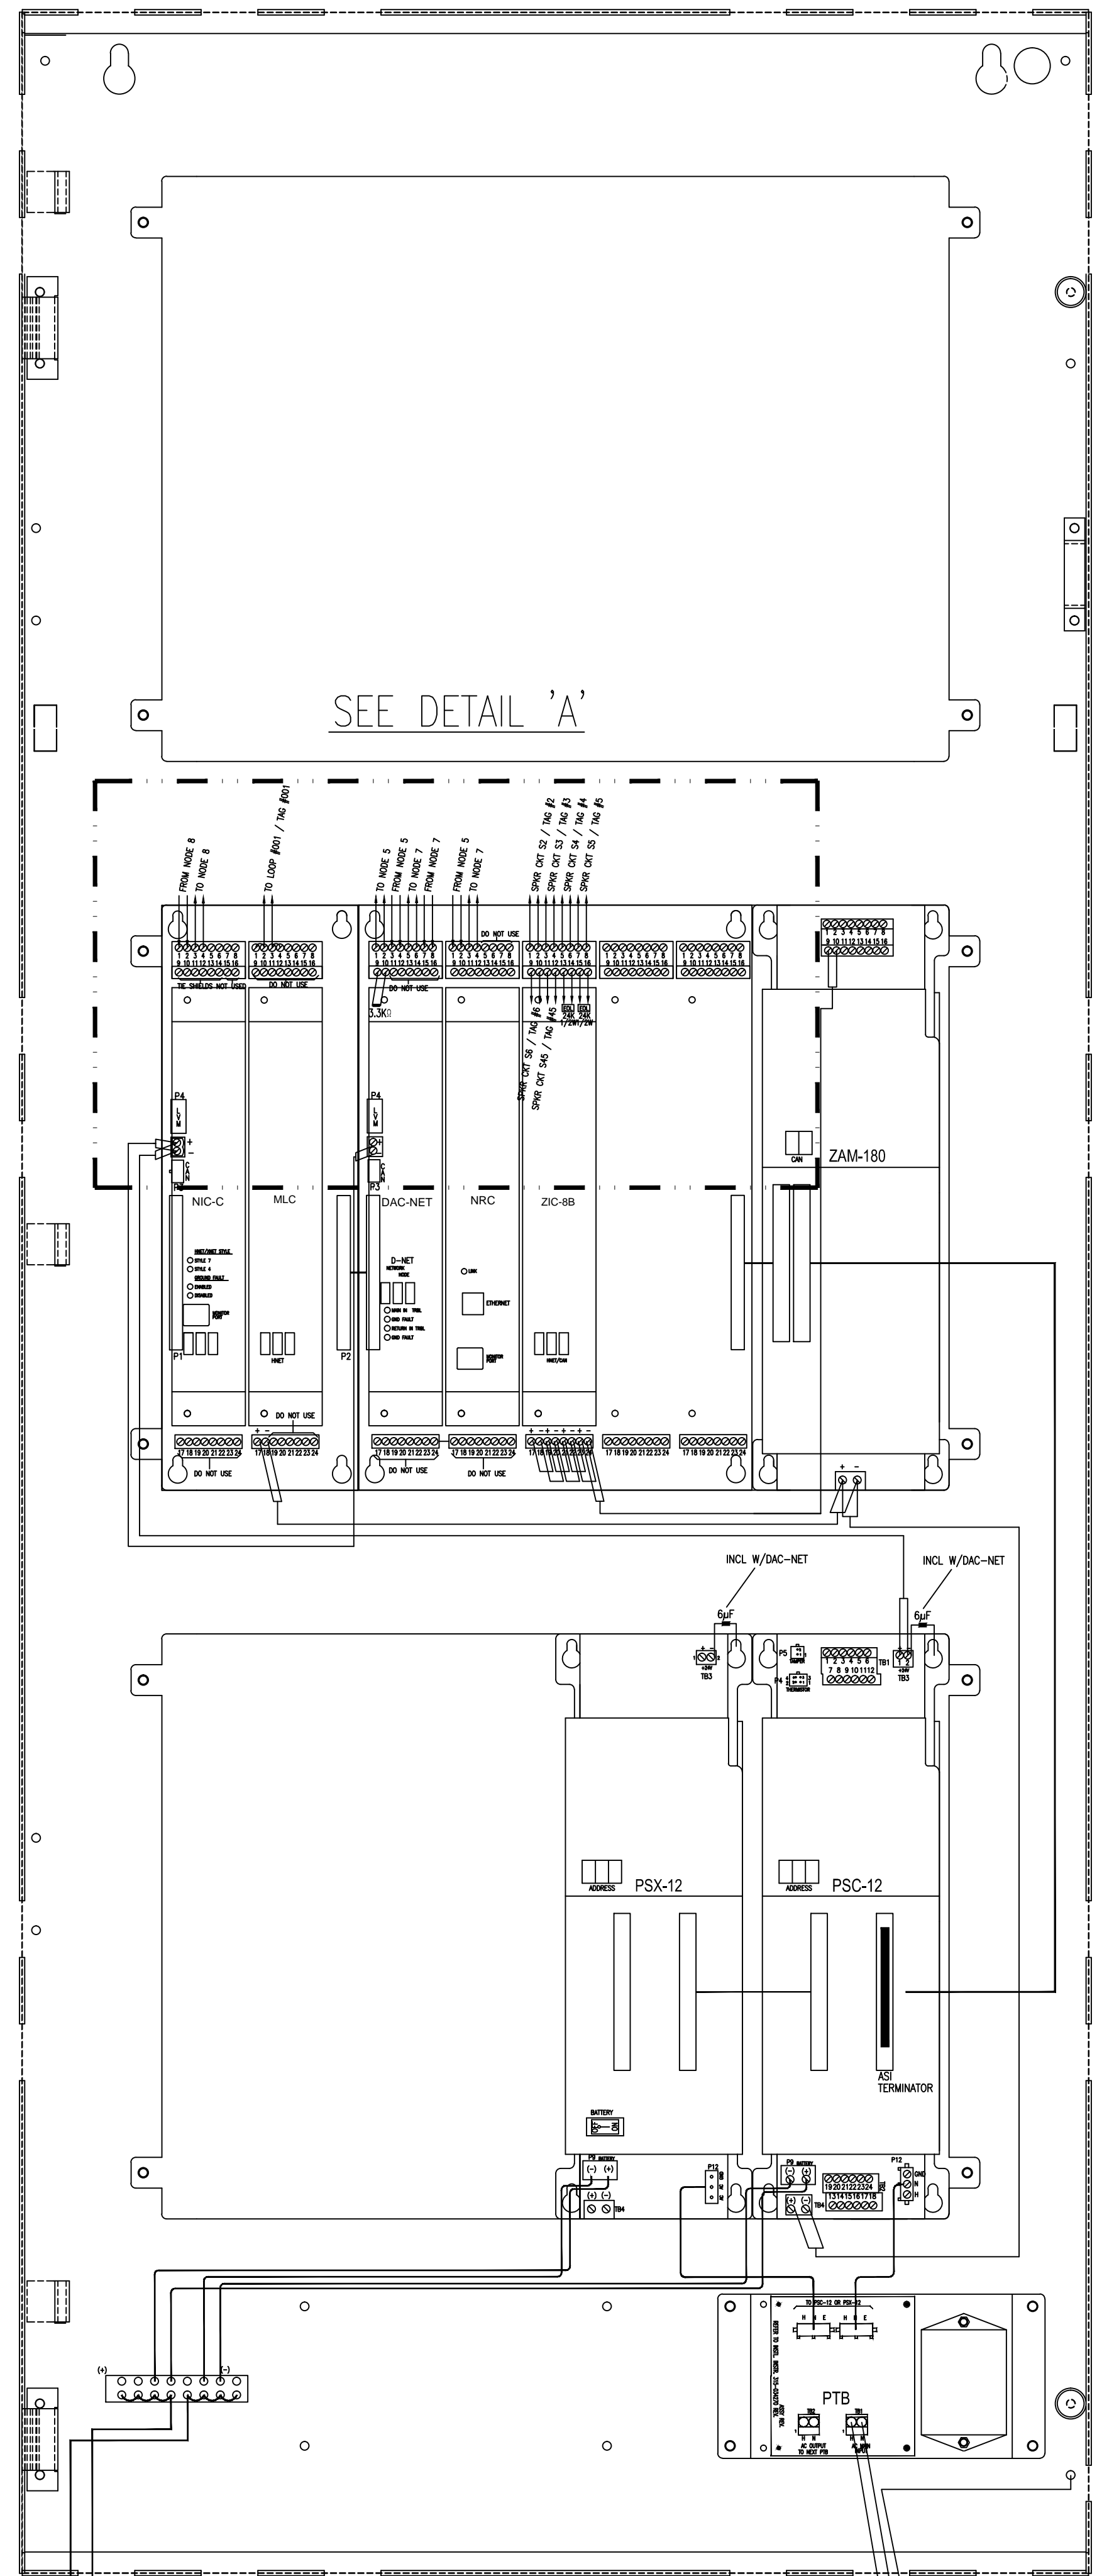

NOTE:
CONTROL PANEL WIRING AS SHOWN ON THESE DRAWINGS IS A REPRESENTATION OF THE INTERNAL CONNECTIONS. INSTALLER MUST REFER TO THE INSTALLATION SHEETS THAT ARE INCLUDED WITH EACH PIECE OF EQUIPMENT FOR SPECIFIC INSTALLATION AND WIRING REQUIREMENTS. INSTALLING CONTRACTOR IS RESPONSIBLE FOR INSTALLATION OF ANY ADDITIONAL COMPONENTS REQUIRED BY THE INSTALLATION INSTRUCTIONS BUT NOT SHOWN ON THE DRAWINGS.

DEDICATED EMERGENCY POWER CIRCUIT (120VAC-60Hz)(BY OTHERS)

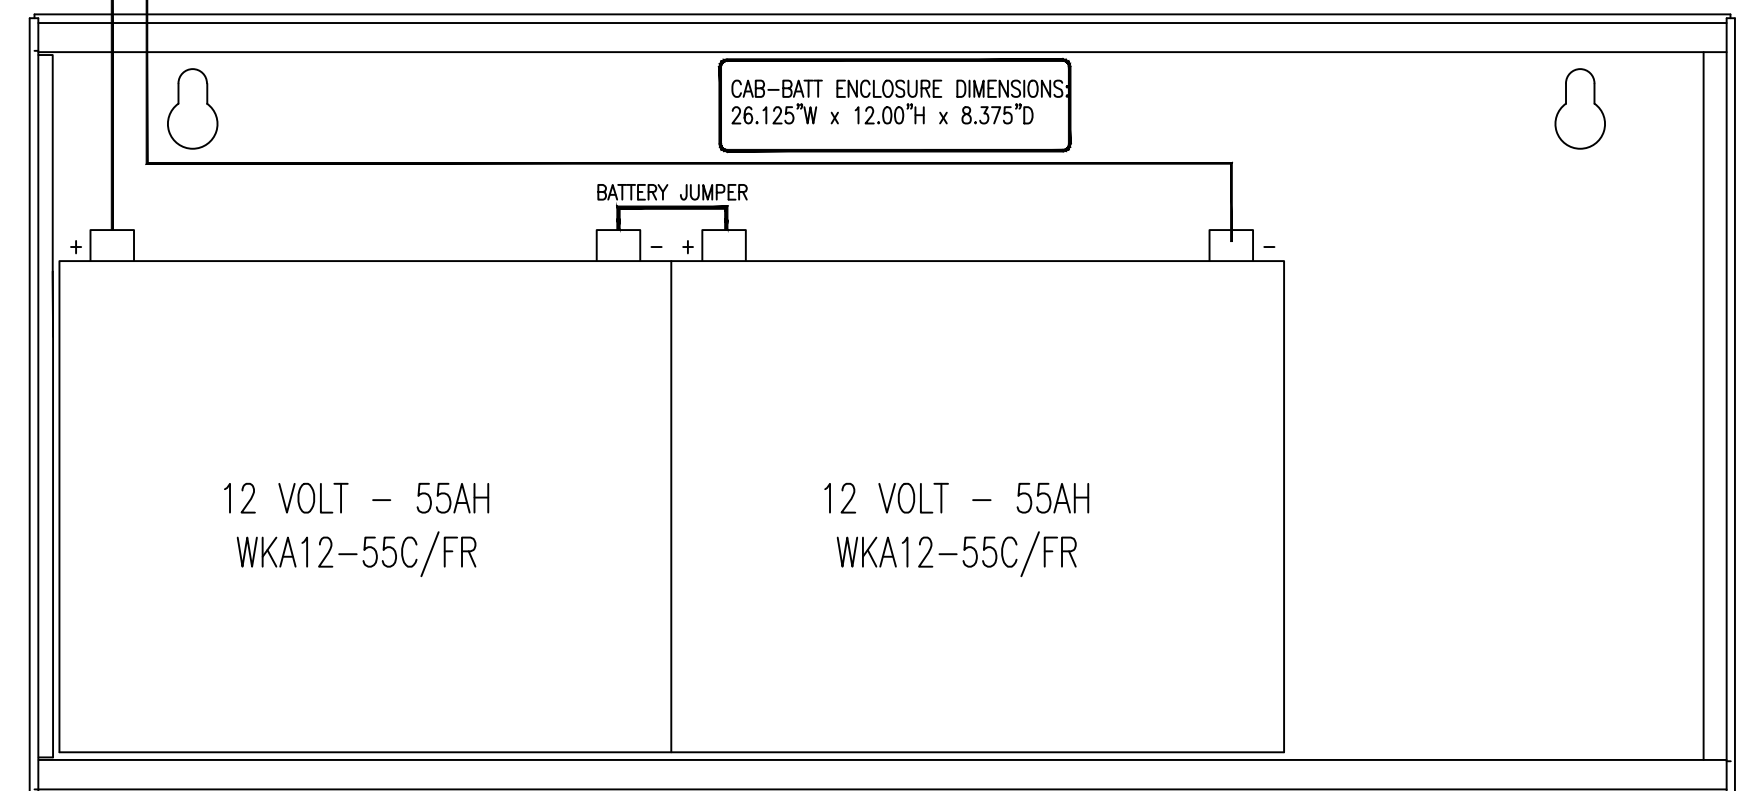

NODE 6

VOICE COMMUNICATION CONTROL PANEL VCP-3
LOCATED BLDG 1 1ST FLR

THE DRAWING AND DESIGN HEREIN SHALL NOT BE DUPLICATED, USED OR DISCLOSED TO OTHERS FOR PROCUREMENT OR OTHER PURPOSE, EXCEPT AS OTHERWISE AUTHORIZED BY CONTRACT WITHOUT WRITTEN PERMISSION OF SIEMENS INDUSTRY INC. ALL REPRODUCTIONS SHALL BEAR THIS NOTICE.

REVISIONS

No.	Revision	By	Date
1			
2			
3			
4			
5			
6			
7			
8			
9			

PROFESSIONAL ENGINEERS APPROVAL STAMP:

DESIGN ENGINEERS:

CONTRACTOR'S NAME & ADDRESS:

PRODUCT MANUFACTURER:
Siemens Industry, Inc.
Building Technologies Division
Fire Safety and Security
CHICAGO BRANCH
585 SLAVIN COURT
Mount Prospect, Illinois 60056
Tel (847) 803-2700 Fax (847) 803-2733

JOB NAME & LOCATION (STREET ADDRESS):

**JESSE BROWN
VA MEDICAL CENTER
XLS MIGRATION**

CHICAGO, IL

SHEET CONTENTS:
**FIRE ALARM
NODE 6
VCP-3**

INSTALLATION TYPE:
☐ NEW INSTALLATION
☐ DESIGN/BUILD
☐ PER CONTRACT DOCUMENT
☐ EXISTING BASE JOB # N/A
☐ OTHERS

SYSTEM SALES REP.: **BRIAN CULLEN**

PROJECT MANAGER: **TIM COSTELLO**

DRAWN BY: **SCOTT ANDERSON**


CAD FILENAME:

SCALE: **NO SCALE**



DATE DRAWN: **12/2016** CHECKED BY:

JOB NUMBER: **440P-203246** SHEET

NETWORK: **5602799** **FA-09**

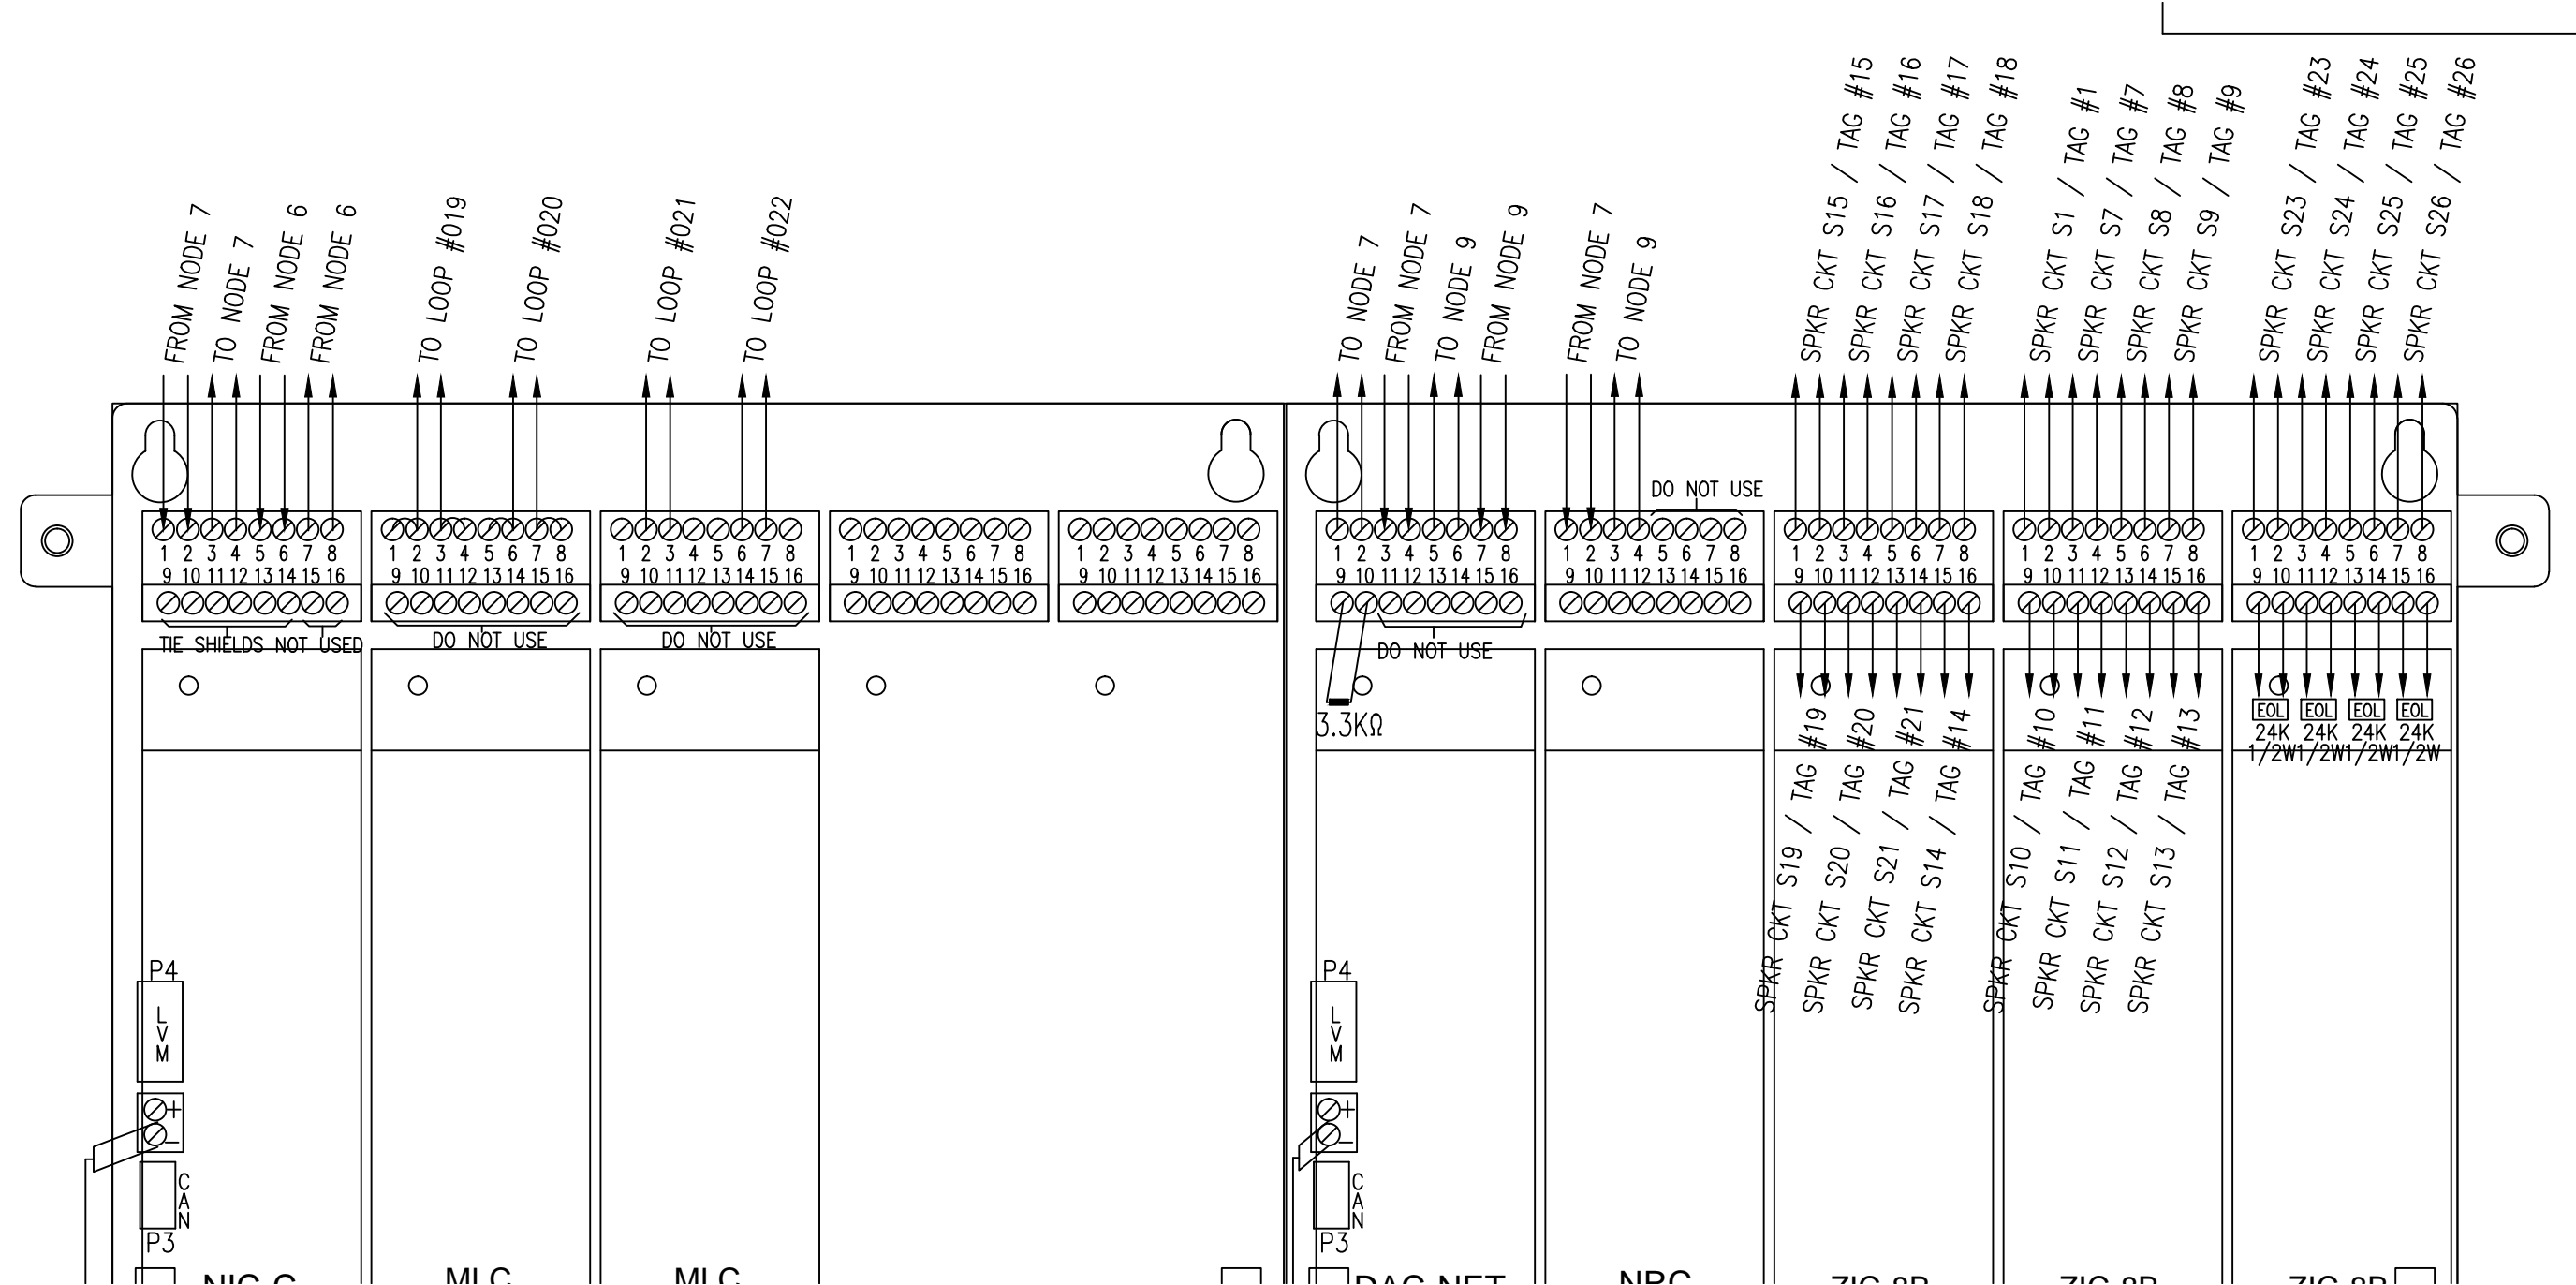

DETAIL 'A'

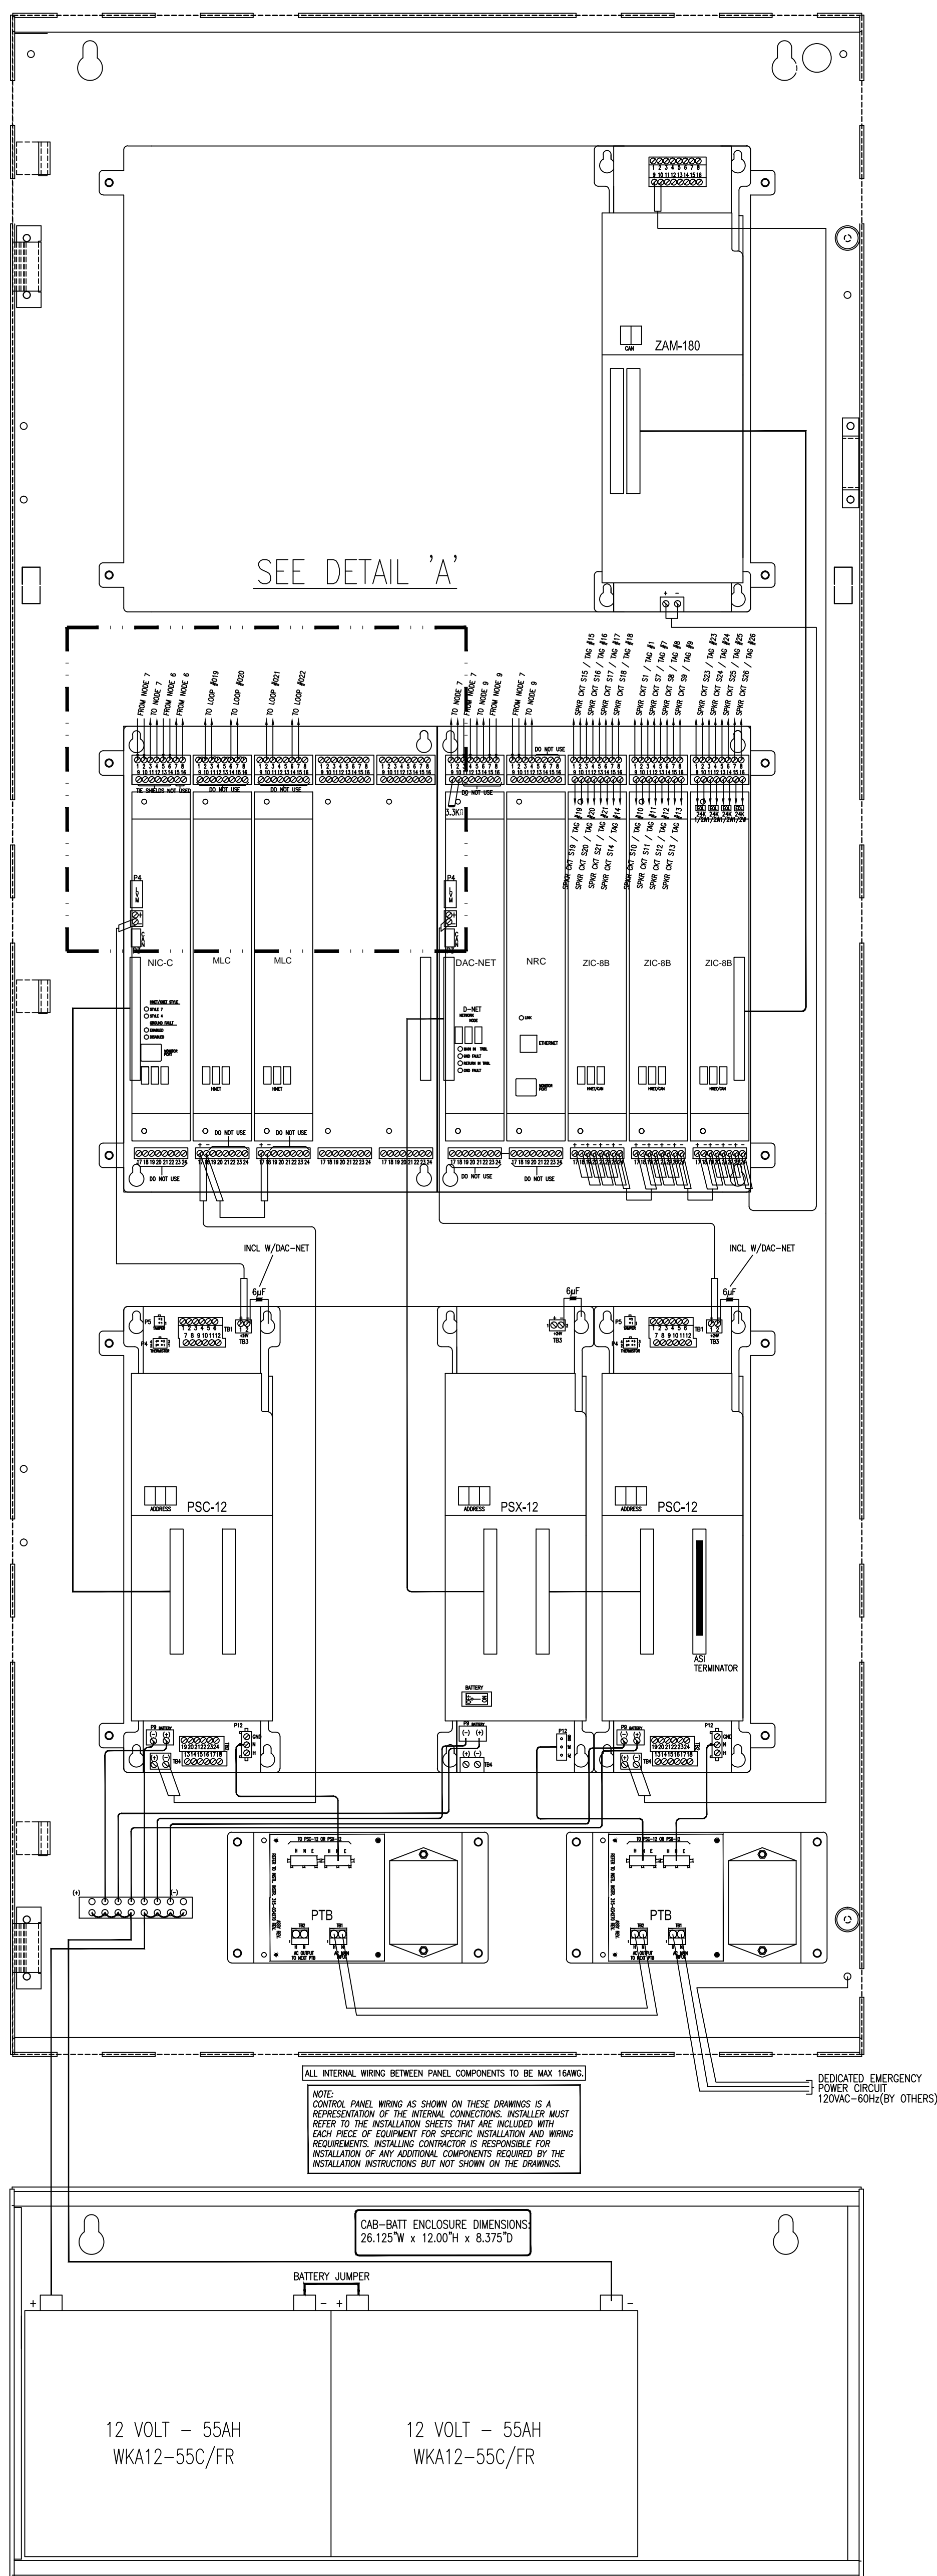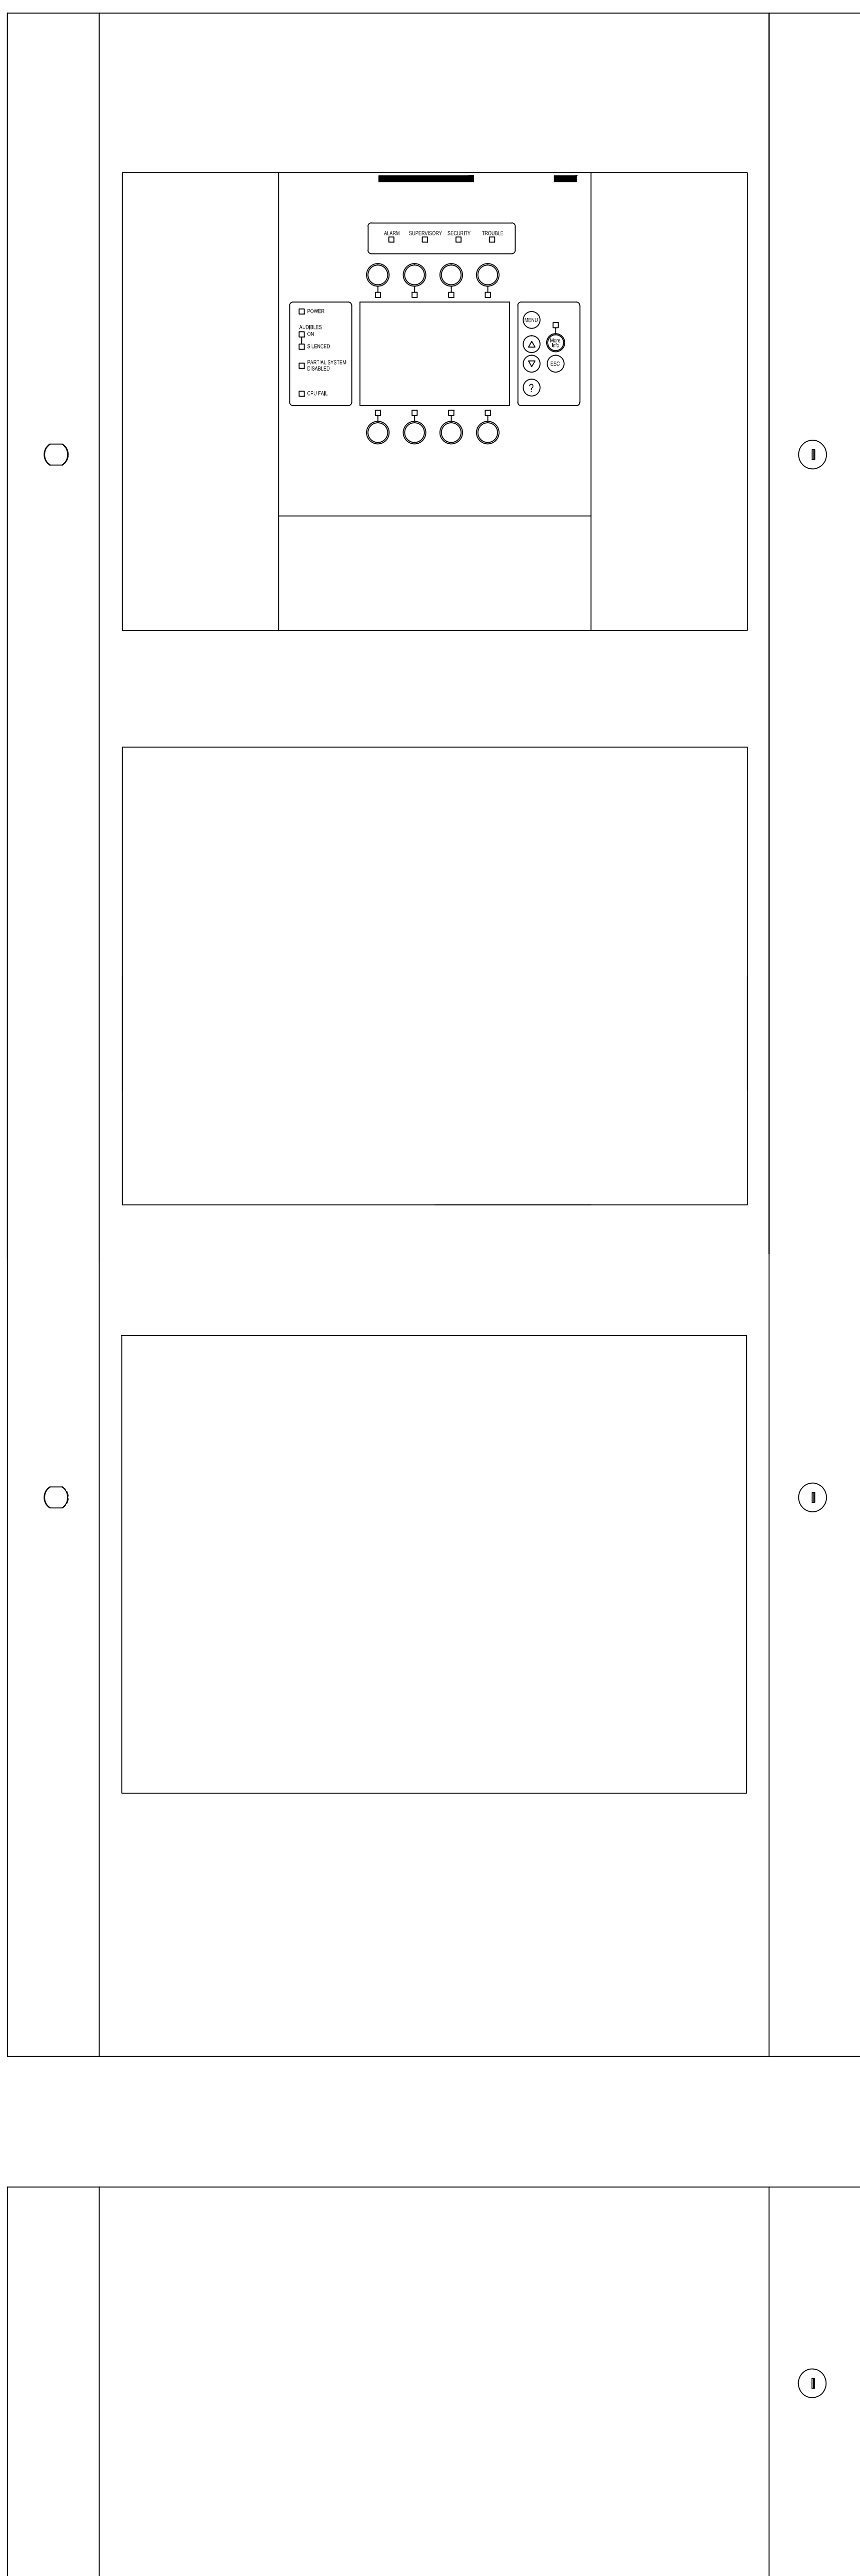

NODE 8

VOICE COMMUNICATION CONTROL PANEL VCP-6
LOCATED BLDG 1 6TH FLR

THE DRAWING AND DESIGN HEREIN SHALL NOT BE DUPLICATED, USED OR DISCLOSED TO OTHERS FOR PROCUREMENT OR OTHER PURPOSE, EXCEPT AS OTHERWISE AUTHORIZED BY CONTRACT WITHOUT WRITTEN PERMISSION OF SIEMENS INDUSTRY INC. ALL REPRODUCTIONS SHALL BEAR THIS NOTICE.

REVISIONS

No.	Revision	By	Date
1			
2			
3			
4			
5			
6			
7			
8			
9			

PROFESSIONAL ENGINEERS APPROVAL STAMP:

DESIGN ENGINEERS:

CONTRACTOR'S NAME & ADDRESS:

PRODUCT MANUFACTURER:
Siemens Industry, Inc.
Building Technologies Division
Fire Safety and Security
CHICAGO BRANCH
585 SLAVIN COURT
Mount Prospect, Illinois 60056
Tel (847) 803-2700 Fax (847) 803-2733

JOB NAME & LOCATION (STREET ADDRESS):

**JESSE BROWN
VA MEDICAL CENTER
XLS MIGRATION**

CHICAGO, IL

SHEET CONTENTS:

**FIRE ALARM
NODE 8
VCP-6**

INSTALLATION TYPE

- ☐ NEW INSTALLATION
☐ DESIGN/BUILD
☐ PER CONTRACT DOCUMENT
☐ EXISTING BASE JOB # N/A
☐ OTHERS

SYSTEM SALES REP: BRIAN CULLEN

PROJECT MANAGER: TIM COSTELLO

DRAWN BY: SCOTT ANDERSON

CAD FILENAME:

SCALE: NO SCALE

DATE DRAWN:

12/2016

CHECKED BY:

JOB NUMBER


440P-203246

NETWORK


5602799

SHEET



FA-11

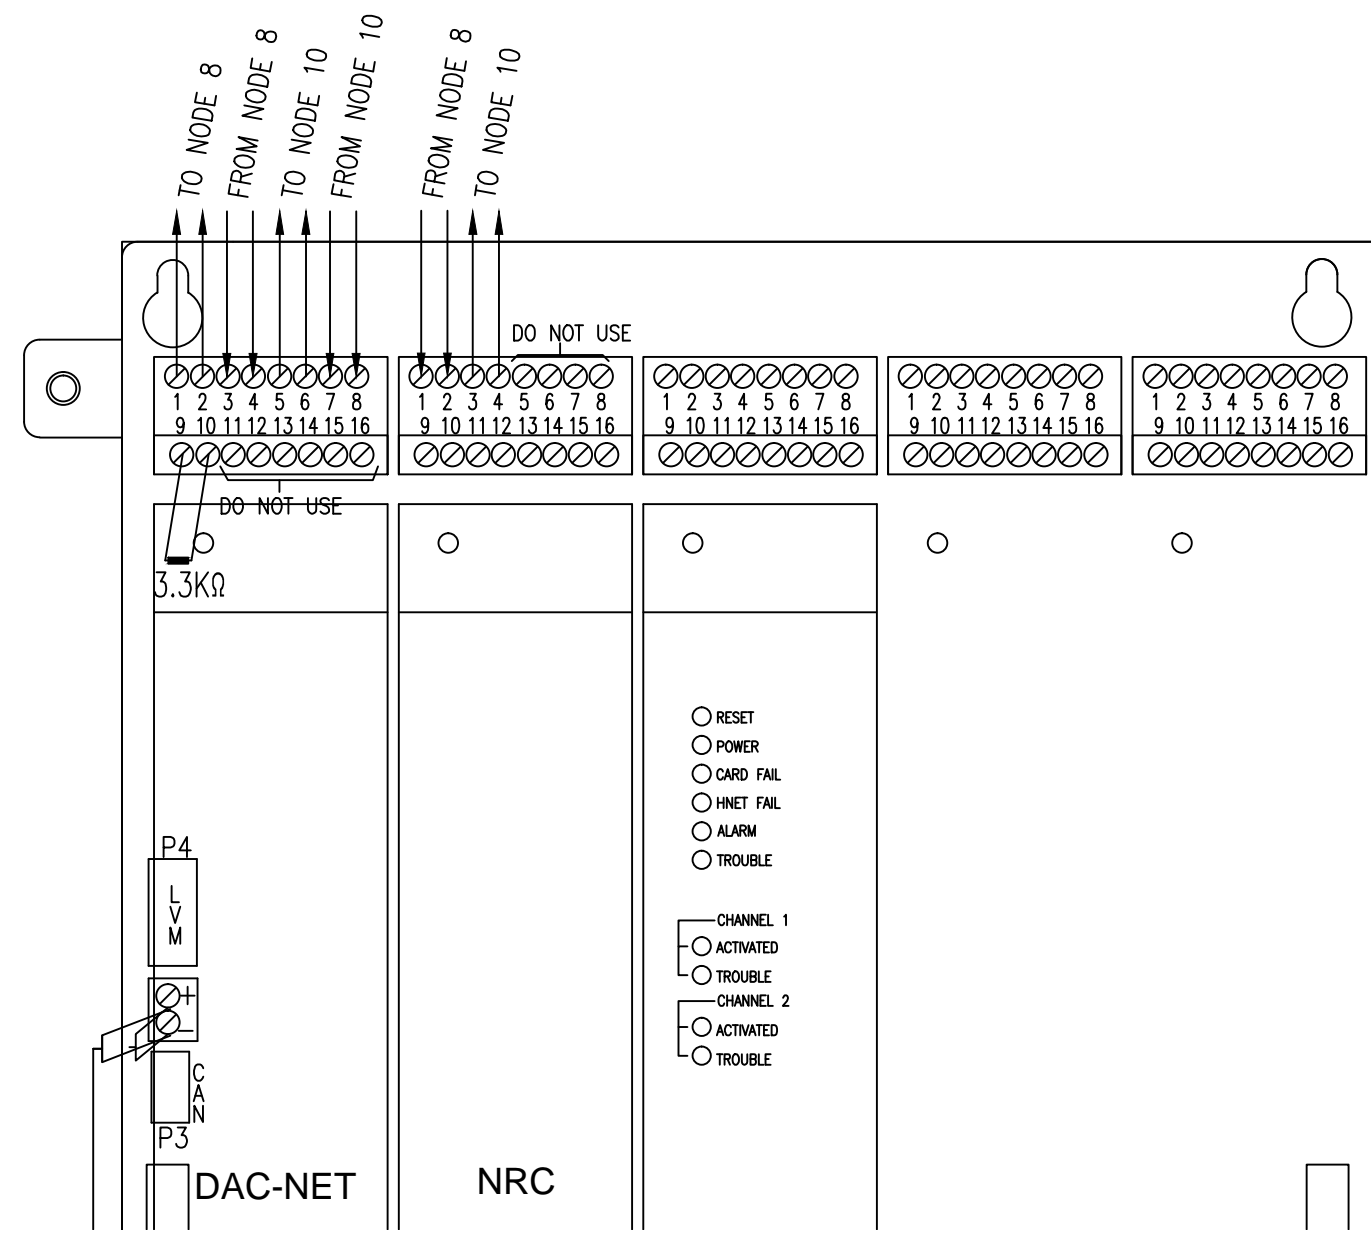

DETAIL 'A'

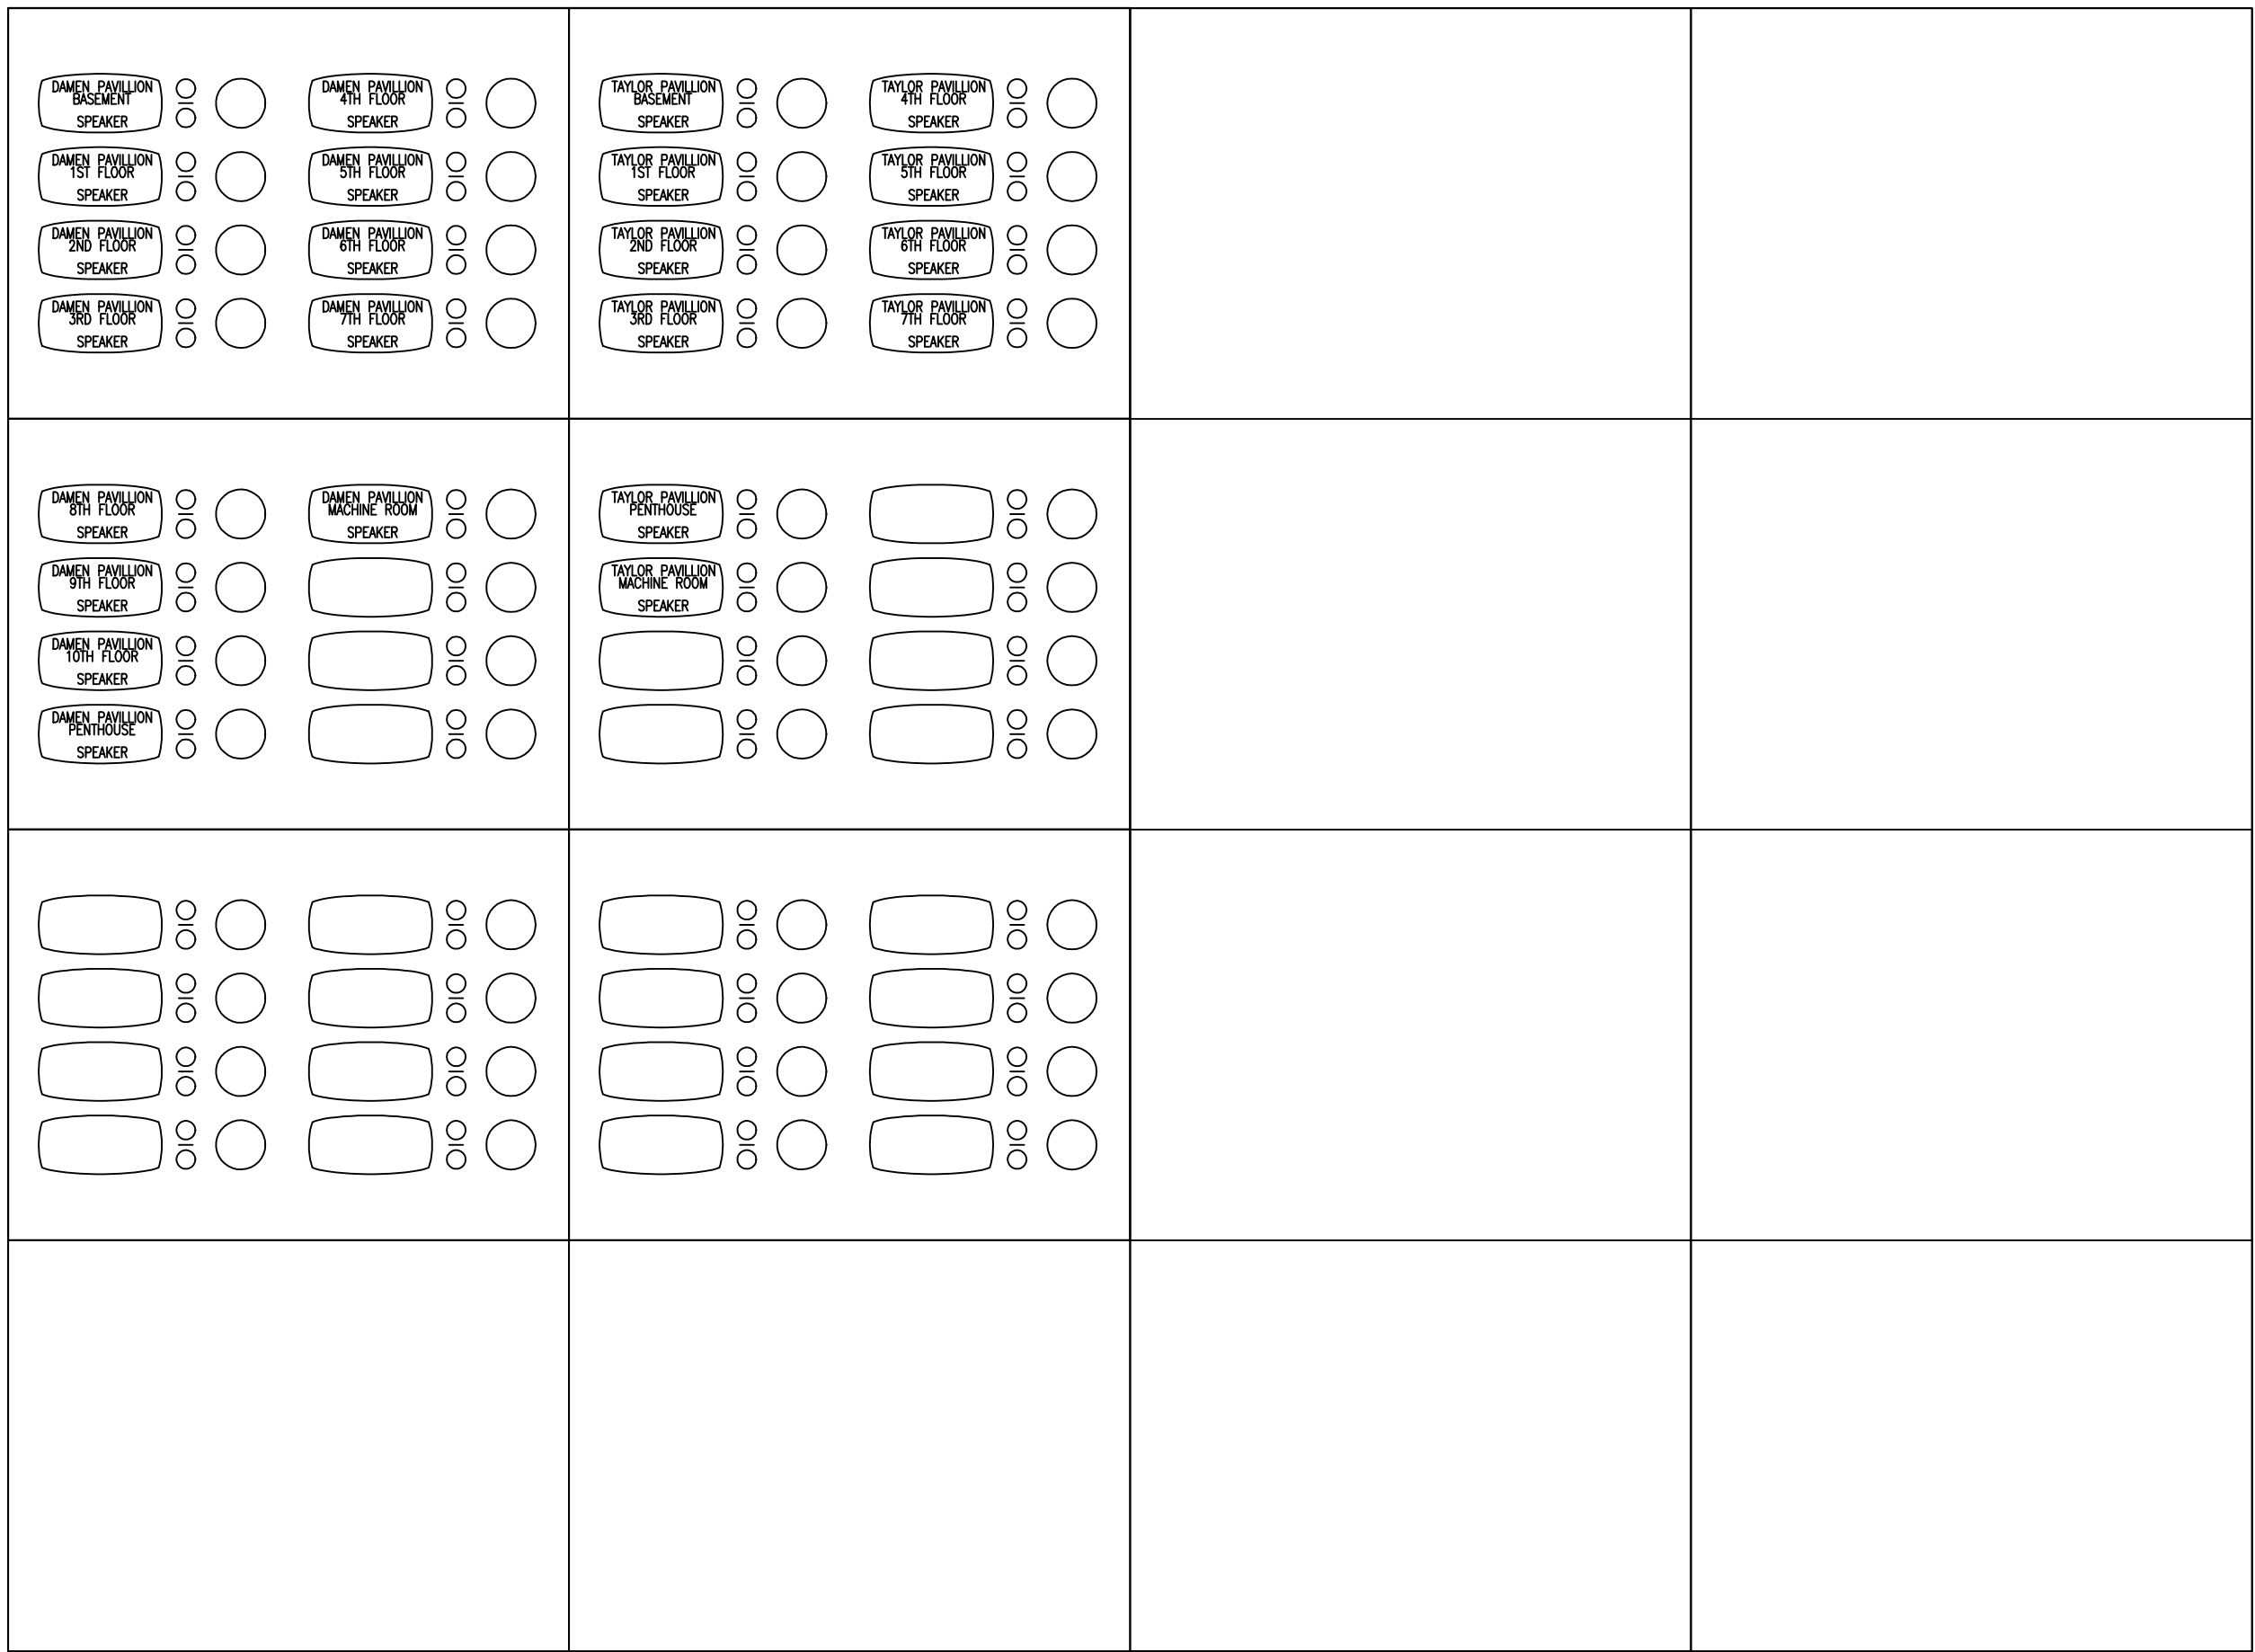

DETAIL 'B'

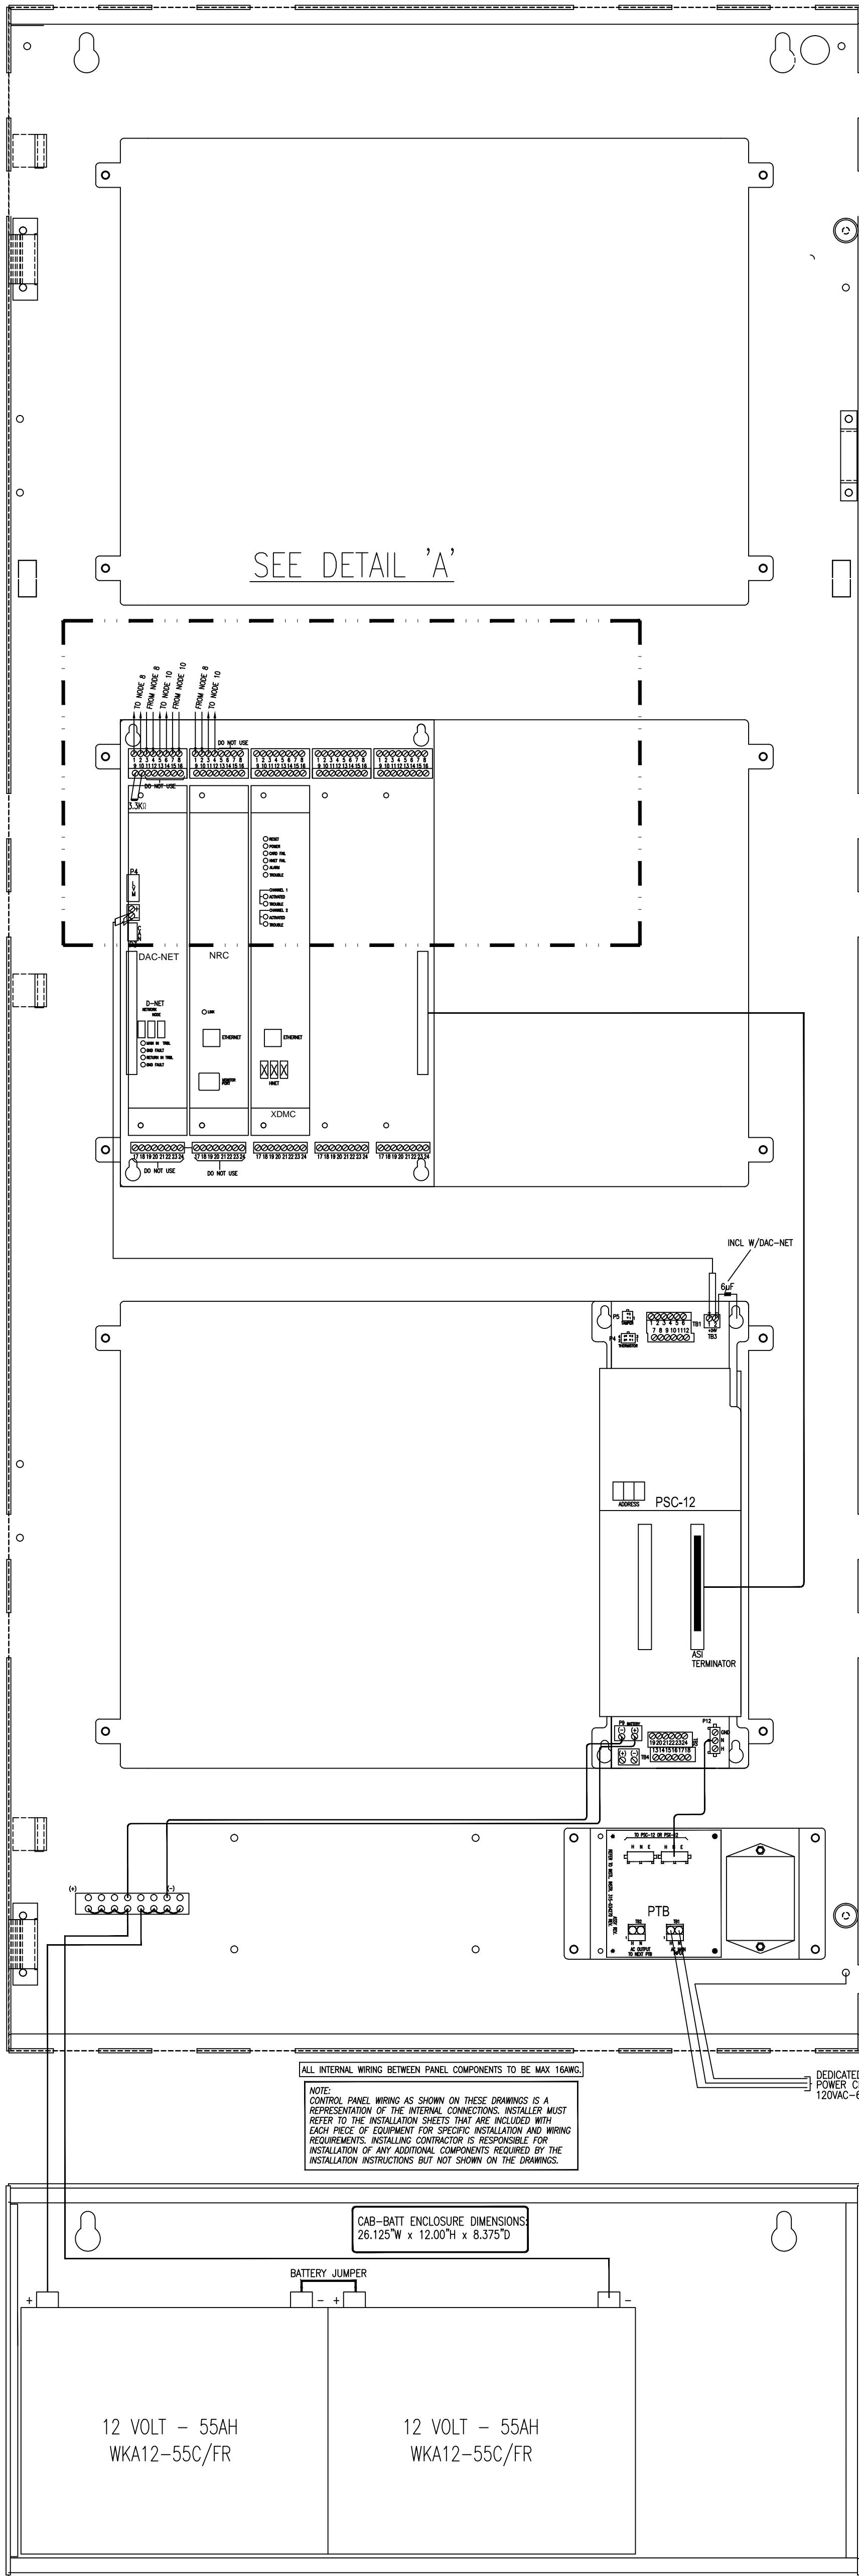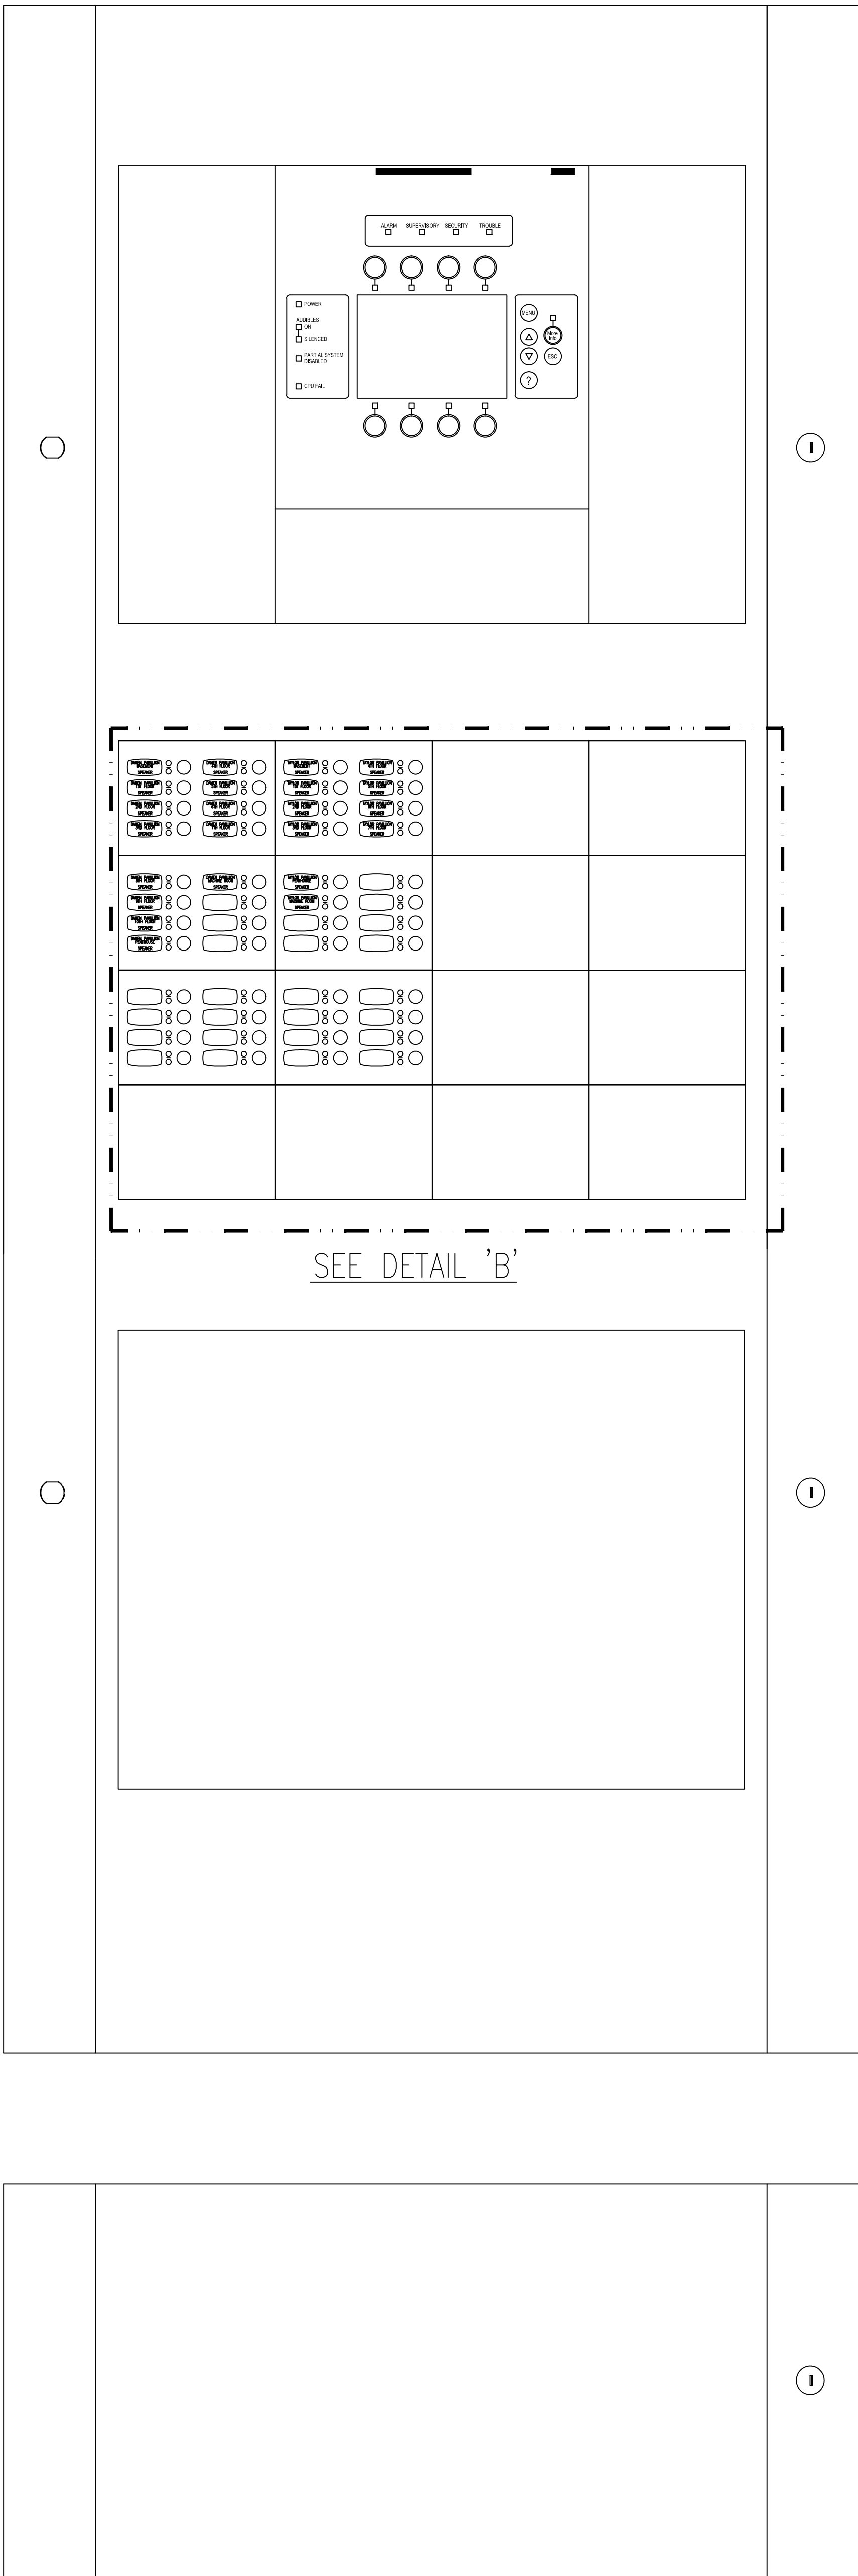

NODE 9

VOICE COMMUNICATION CONTROL PANEL VCP-2
LOCATED BLDG 1 1ST FLR DAMON ST

THE DRAWING AND DESIGN HEREIN SHALL NOT BE DUPLICATED, USED OR DISCLOSED TO OTHERS FOR PROCUREMENT OR OTHER PURPOSE, EXCEPT AS OTHERWISE AUTHORIZED BY CONTRACT WITHOUT WRITTEN PERMISSION OF SIEMENS INDUSTRY INC. ALL REPRODUCTIONS SHALL BEAR THIS NOTICE.

REVISIONS

No.	Revision	By	Date
1			
2			
3			
4			
5			
6			
7			
8			
9			

PROFESSIONAL ENGINEERS APPROVAL STAMP:

DESIGN ENGINEERS:

CONTRACTOR'S NAME & ADDRESS:

PRODUCT MANUFACTURER:
Siemens Industry, Inc.
Building Technologies Division
Fire Safety and Security
CHICAGO BRANCH
585 SLAWIN COURT
Mount Prospect, Illinois 60056
Tel (847) 803-2700 Fax (847) 803-2733

JOB NAME & LOCATION (STREET ADDRESS):

**JESSE BROWN
VA MEDICAL CENTER
XLS MIGRATION**

CHICAGO, IL

SHEET CONTENTS:
**FIRE ALARM
NODE 9
VCP-2**

INSTALLATION TYPE:
☐ NEW INSTALLATION
☐ DESIGN/BUILD
☐ PER CONTRACT DOCUMENT
☐ EXISTING BASE JOB # N/A
☐ OTHERS

SYSTEM SALES REP.: **BRIAN CULLEN**

PROJECT MANAGER: **TIM COSTELLO**

DRAWN BY: **SCOTT ANDERSON**




CAD FILENAME:

SCALE: **NO SCALE**

DATE DRAWN: **12/2016** CHECKED BY:

JOB NUMBER: **440P-203246** SHEET

NETWORK # **5602799** **FA-12**

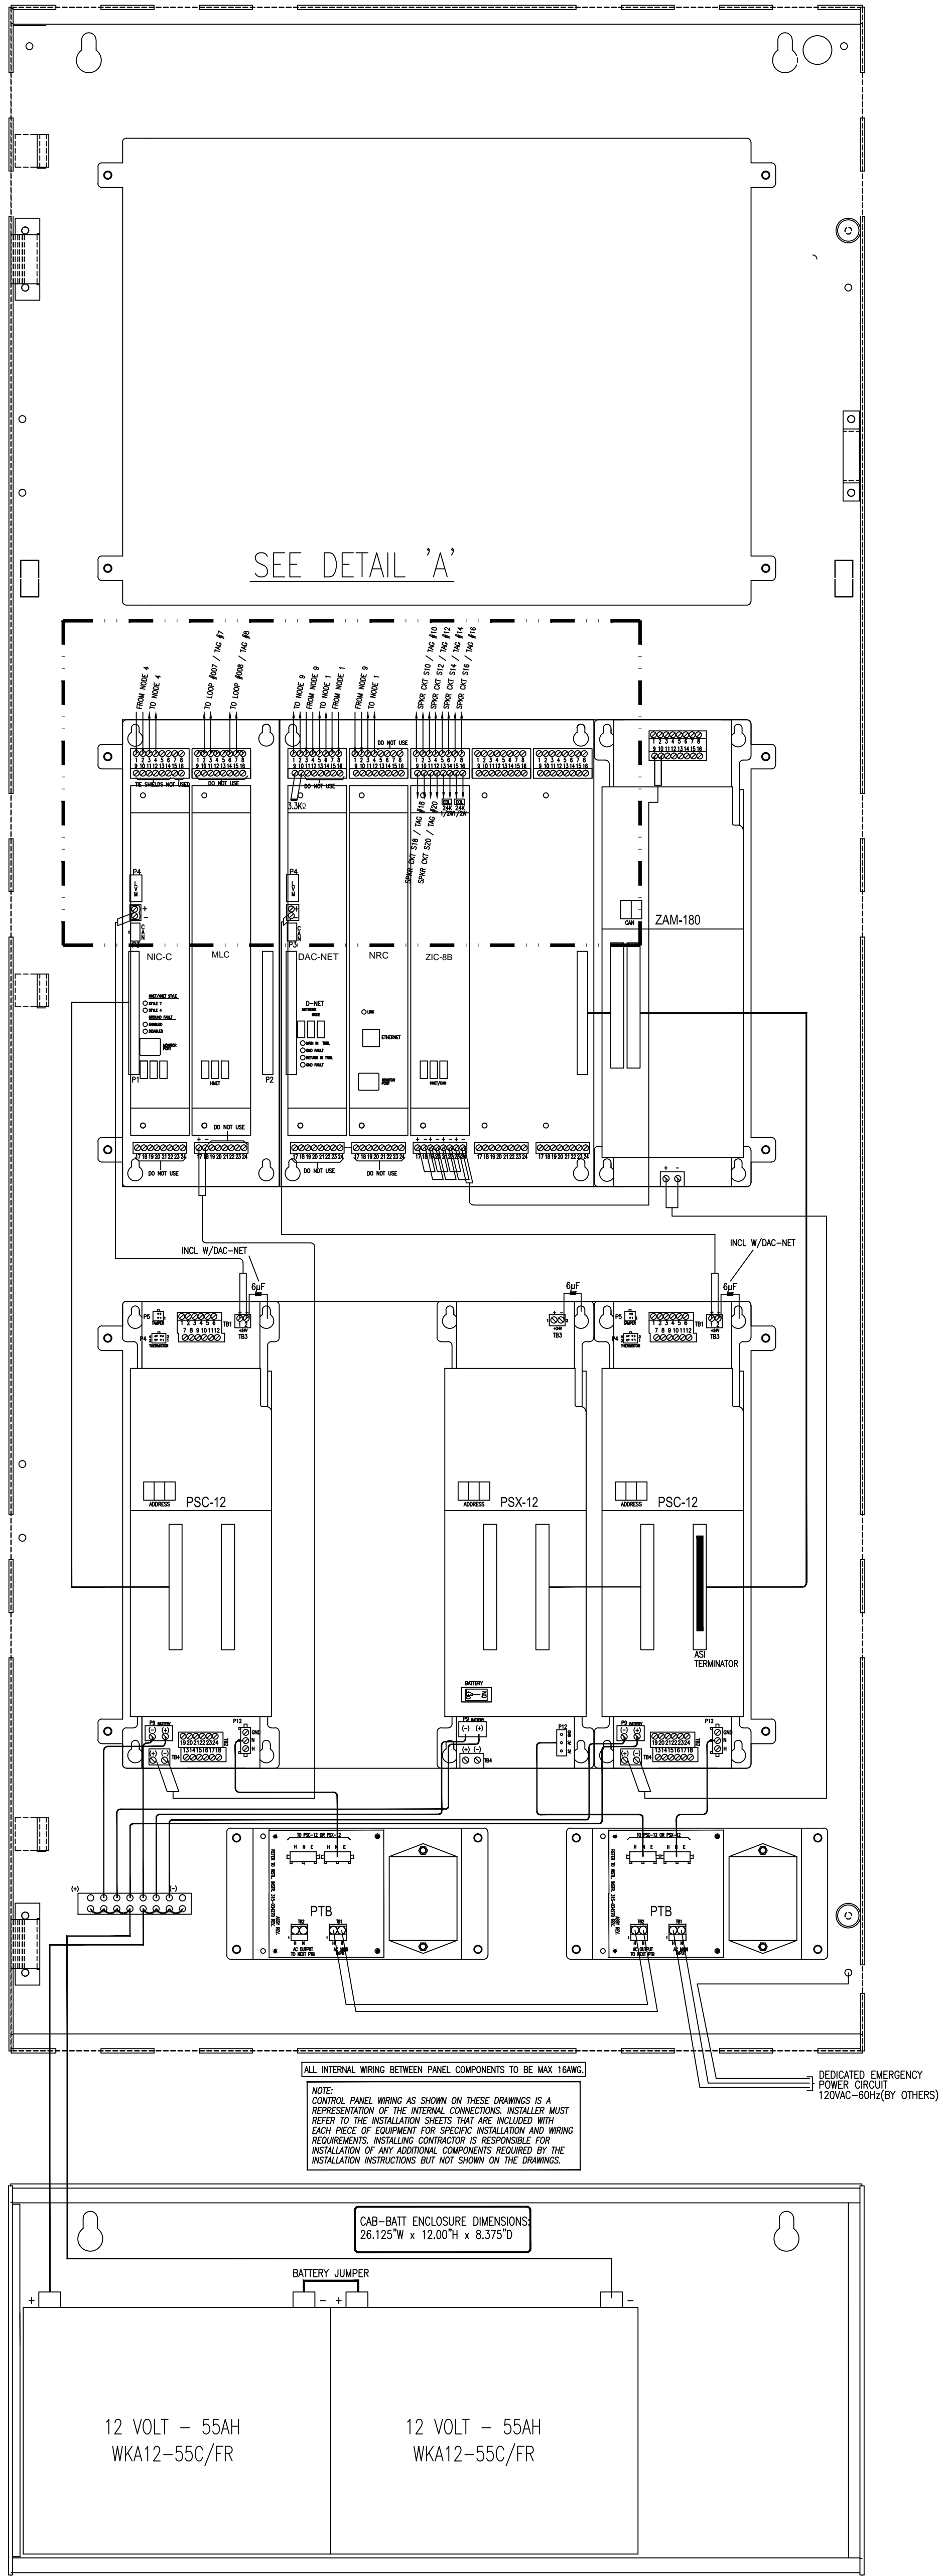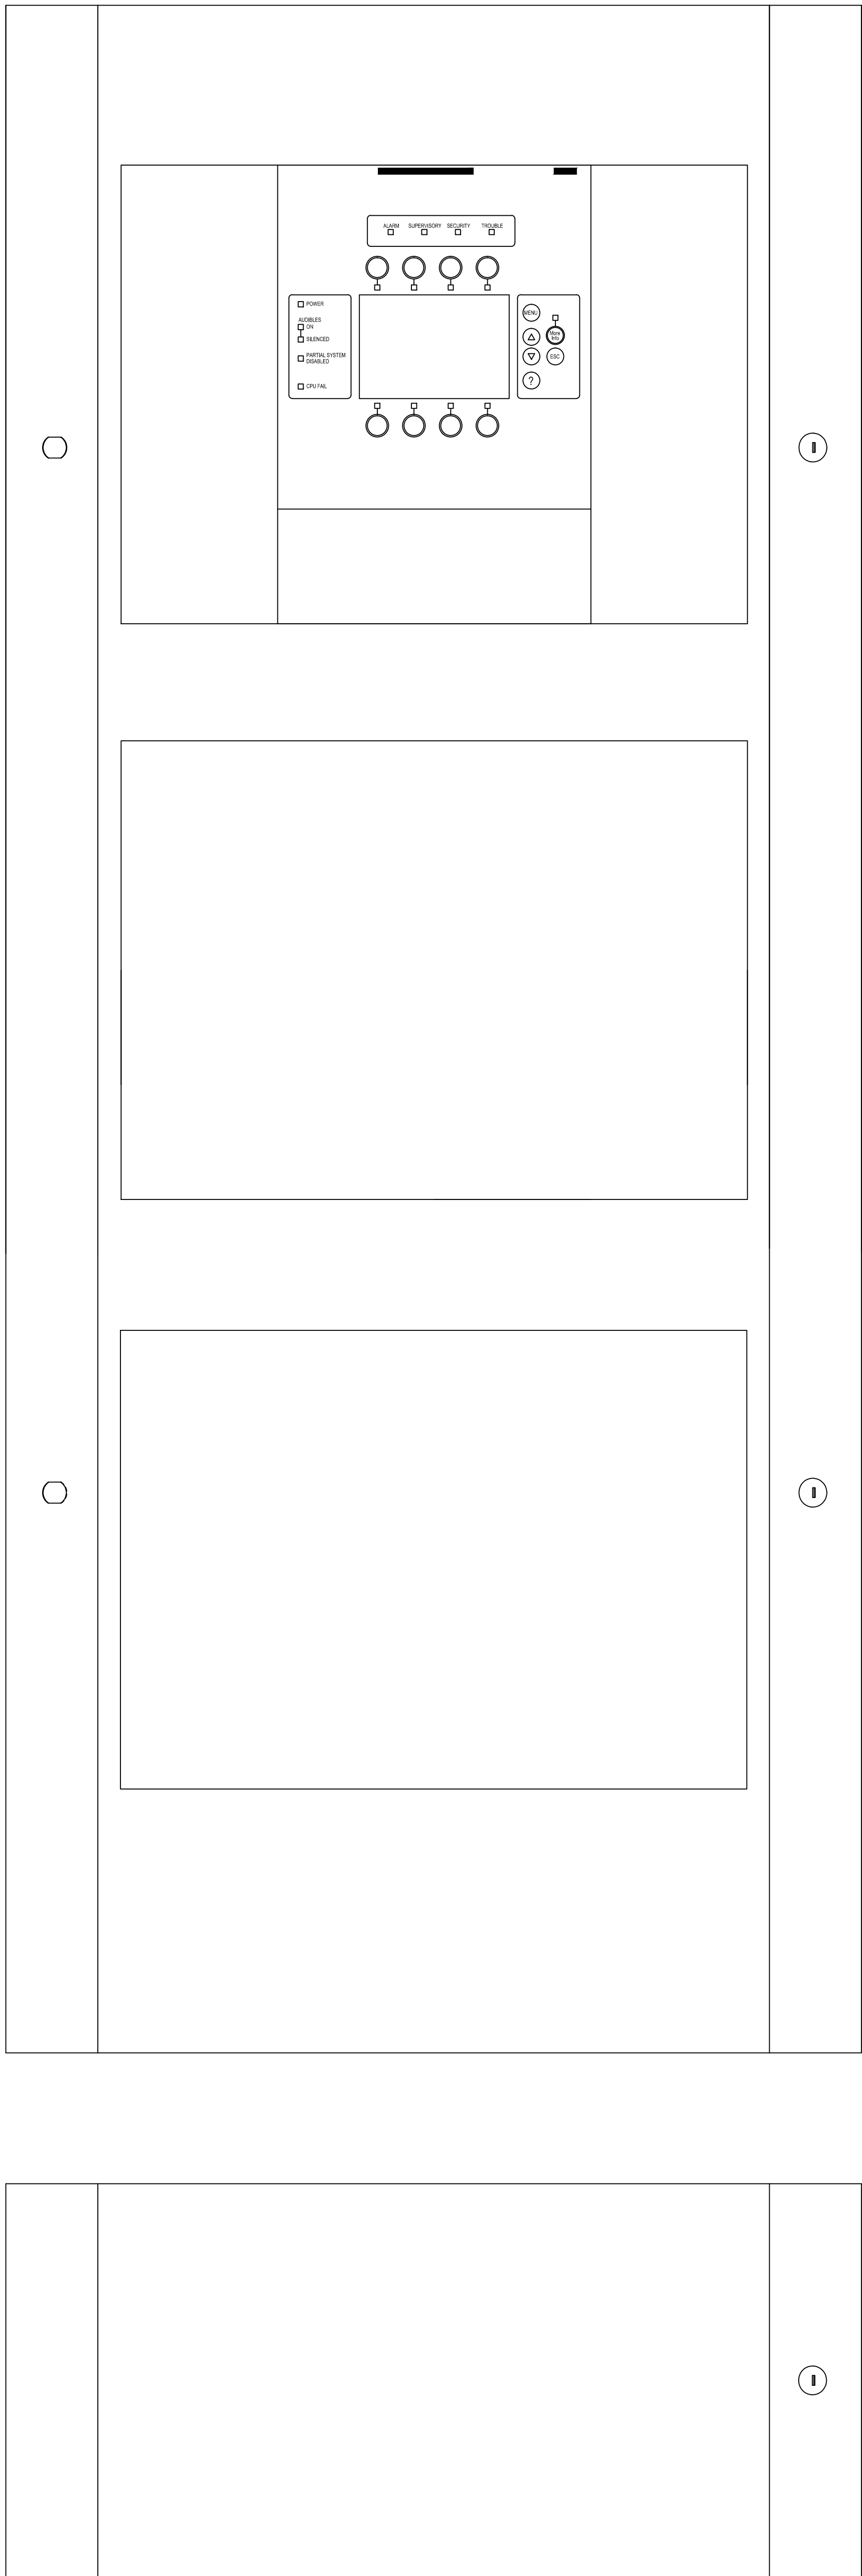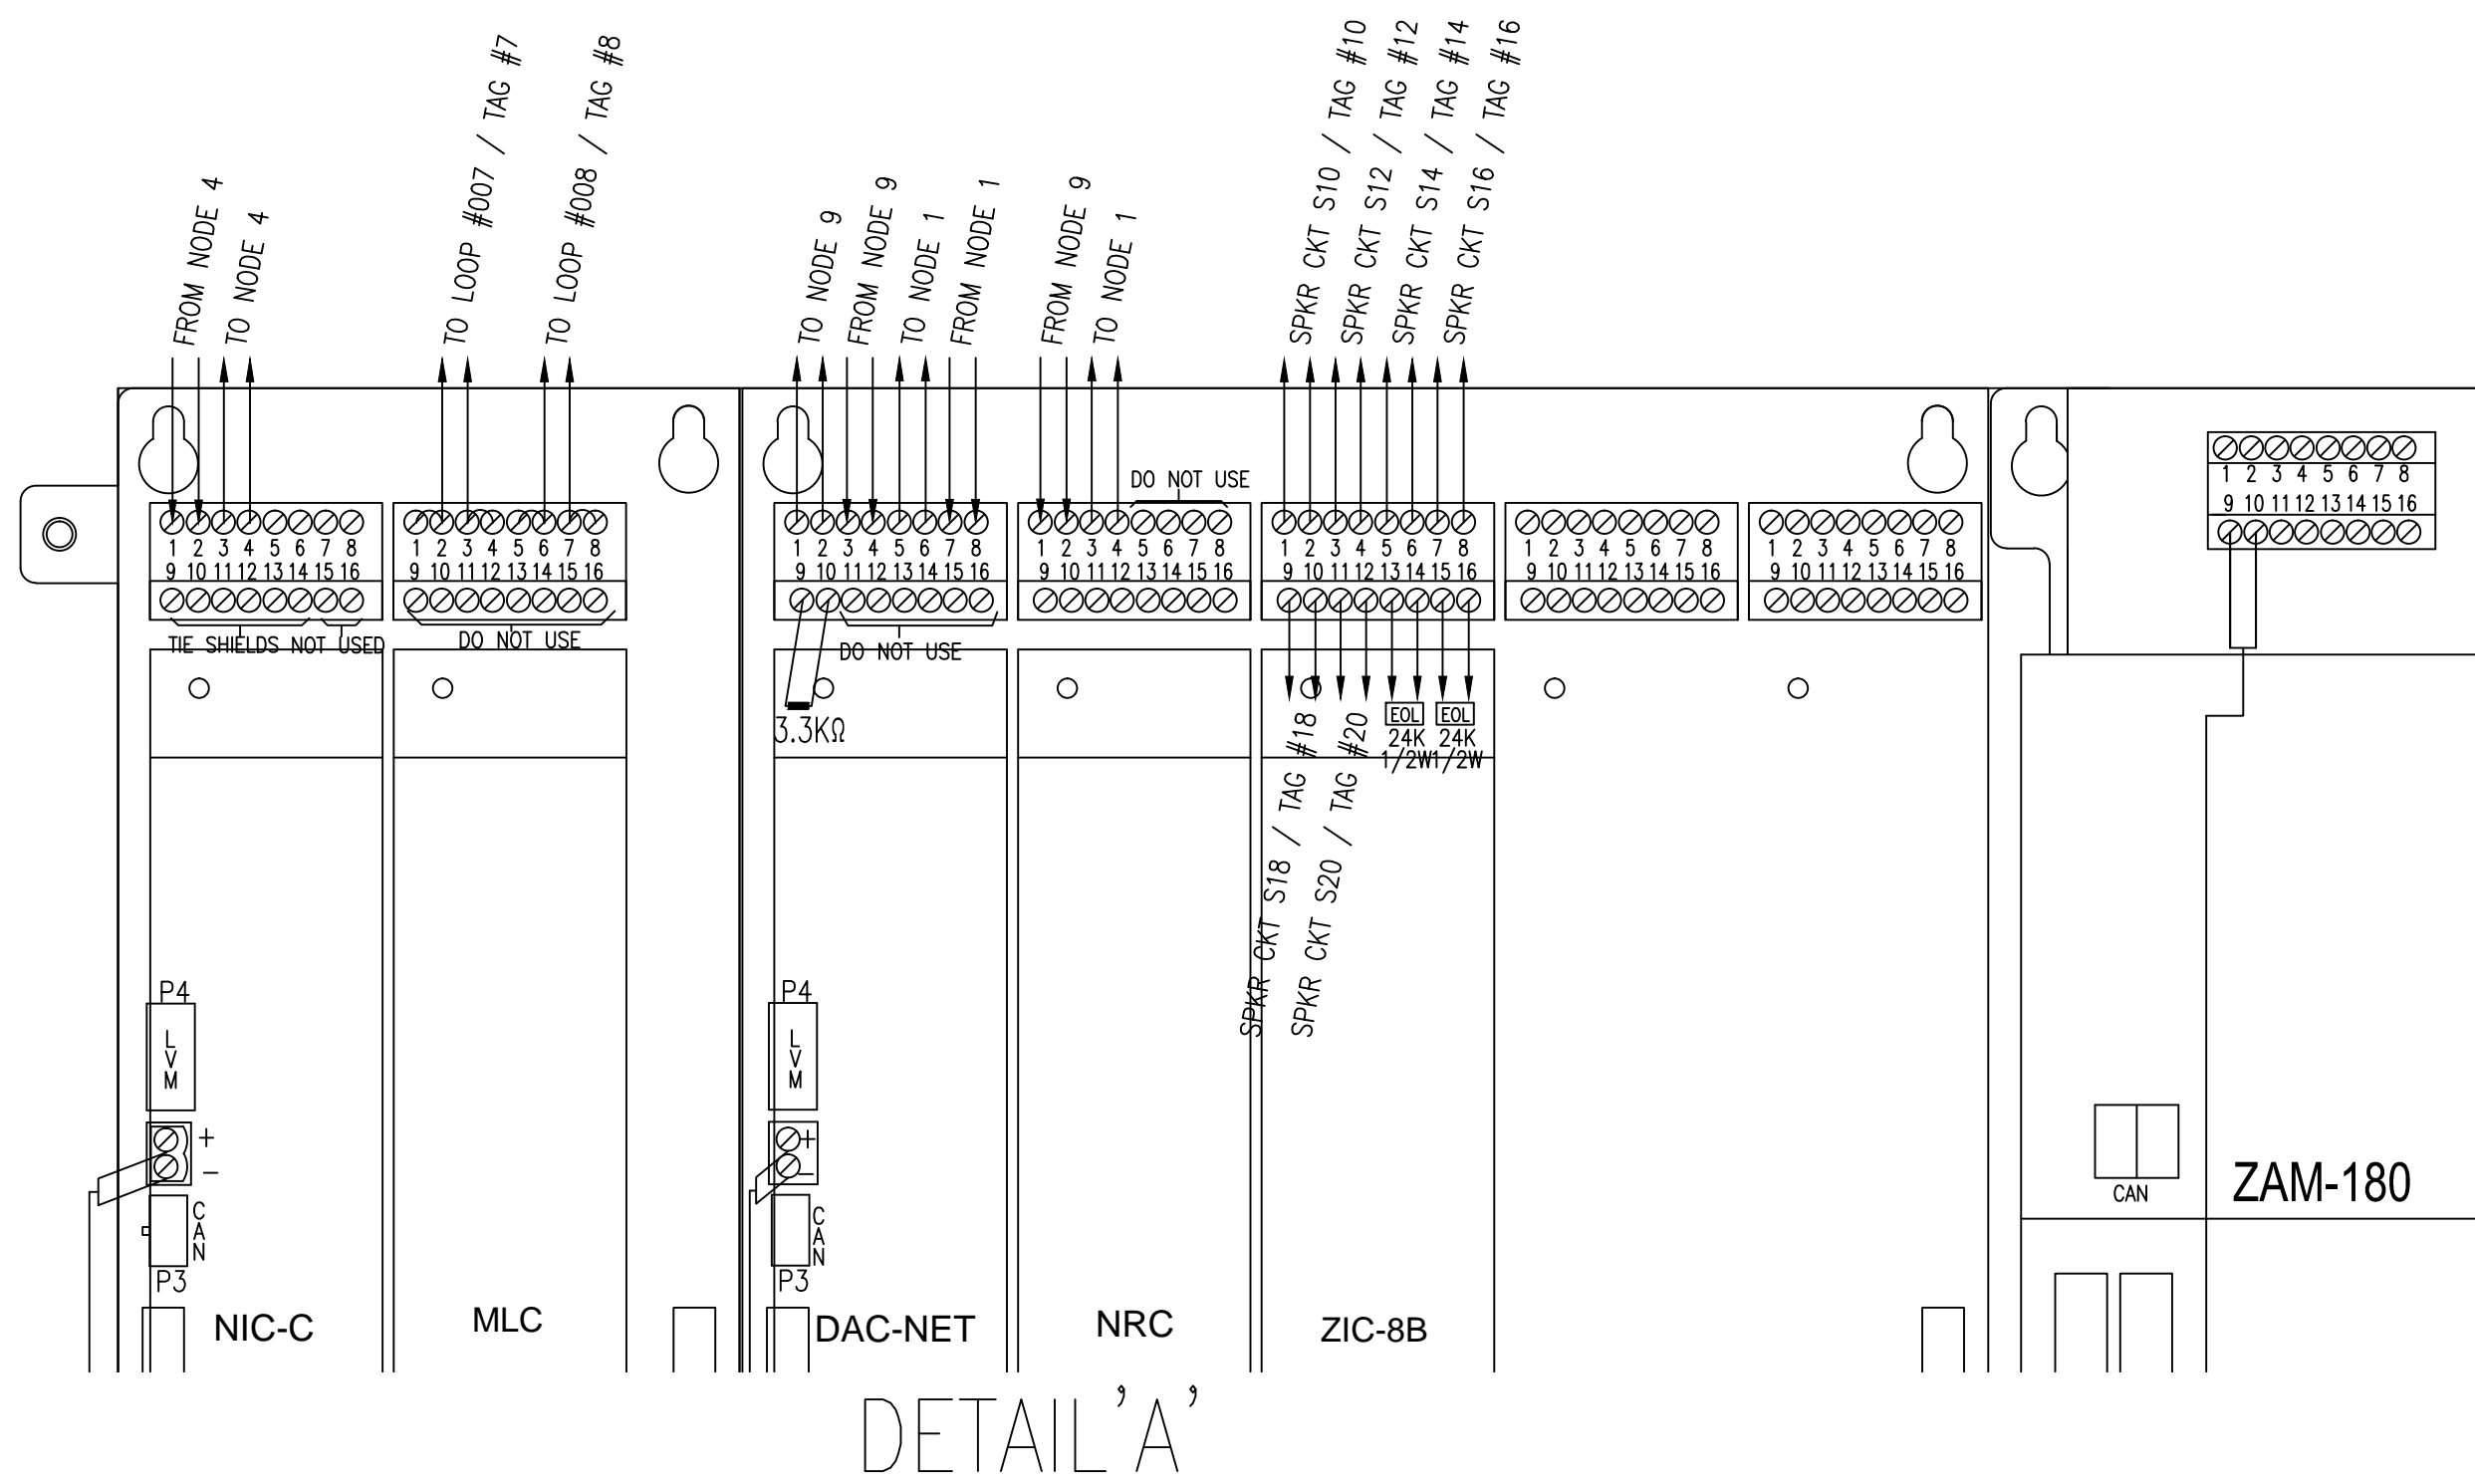

THE DRAWING AND DESIGN HEREIN SHALL NOT BE DUPLICATED, USED OR DISCLOSED TO OTHERS FOR PROCUREMENT OR OTHER PURPOSE (EXCEPT AS OTHERWISE AUTHORIZED BY CONTRACT) WITHOUT WRITTEN PERMISSION OF SIEMENS INDUSTRY INC. ALL REPRODUCTIONS SHALL BEAR THIS NOTICE.

REVISIONS

No.	Revision	By	Date
1			
2			
3			
4			
5			
6			
7			
8			
9			

PROFESSIONAL ENGINEERS APPROVAL STAMP:

DESIGN ENGINEERS:

CONTRACTOR'S NAME & ADDRESS:

PRODUCT MANUFACTURER:
Siemens Industry, Inc.
Building Technologies Division
Fire Safety and Security
CHICAGO BRANCH
585 SLAVIN COURT
Mount Prospect, Illinois 60056
Tel (847) 803-2700 Fax (847) 803-2733

JOB NAME & LOCATION (STREET ADDRESS):

**JESSE BROWN
VA MEDICAL CENTER
XLS MIGRATION**

CHICAGO, IL

SHEET CONTENTS:
**FIRE ALARM
NODE 10
VCP-11**

INSTALLATION TYPE:
☐ NEW INSTALLATION
☐ DESIGN/BUILD
☐ PER CONTRACT DOCUMENT
☐ EXISTING BASE JOB # N/A
☐ OTHERS

SYSTEM SALES REP.: **BRIAN CULLEN**

PROJECT MANAGER: **TIM COSTELLO**

DRAWN BY: **SCOTT ANDERSON**

CAD FILENAME:

SCALE: **NO SCALE**

DATE DRAWN: **12/2016** CHECKED BY:

JOB NUMBER: **440P-203246** SHEET

NETWORK: **5602799** **FA-13**

NODE 10

**VOICE COMMUNICATION CONTROL PANEL VCP-11
LOCATED BLDG 6 5TH FLR STAIR 7**