

SIGN SCHEDULE


ROOM NO.	ROOM NAME	CALLOUT	FIRST COMPONENT TEXT	SECOND COMPONENT TEXT	ADDITIONAL CALLOUT
1D112	SHARED OFFICE	A	1D112	PRINTABLE	
1D113	ED DIRECTOR	A	1D113	PRINTABLE	
1D114	PSYCH DR.	A	1D114	PRINTABLE	
1D115	NURSE MANAGER	A	1D115	PRINTABLE	
1D116	EXISTING (ELEC)	B	1D116		
1D123	NURSE / DOCTOR	A	1D123	PRINTABLE	
1D124	NURSE / DOCTOR	A	1D124	PRINTABLE	
1D124A	MEDS	B	1D124A		M,N,M,N
1D124B	SOILED UTILITY	B,B	1D124B		
1D125A	SUPPLY	B	1D122		
1D125B	FAST TRACK 7	A	1D125B	PRINTABLE	
1D125C	ACUTE CARE / ISO 1	A	1D125C	PRINTABLE	
1D125D	ACUTE CARE / ISO 2	A	1D125D	PRINTABLE	
1D125E	ACUTE CARE / ISO 3	A	1D125E	PRINTABLE	
1D126	AOD	A	1D126	PRINTABLE	
1D126A	ELIG.	A,A	1D126A	PRINTABLE	
1D127A	EKG/BLOOD	A	1D127A	PRINTABLE	M
1D127B	TOILET	D	1D127B		I
1D127C	ELEC. 1	B	1D127C		
1D127D	ELEC. 2	B	1D127D		
1D128	TRIAGE 2	A	1D128	PRINTABLE	
1D129	TRIAGE 1	A	1D129	PRINTABLE	
1D130A	WAITING	A	1D130	PRINTABLE	I,O,P
1D130B	VESTIBULE	S	-----		K,L,S
1D130C	RECEPTION	B	1D131		
1D130D	MENS	C	1D130B		
1D130E	WOMENS	C	1D130C		
1D131A	FAMILY	A	1D131A	PRINTABLE	
1D131B	TOILET	D/CS	1D108A		
1D132	DECONTAM.	B	1D132		M,N
1D132A	STOR.	B	1D132A		
1D133A	ACUTE CARE / ISO 4	A	1D133A	PRINTABLE	
1D133B	ACUTE CARE / ISO 5	A	1D133B	PRINTABLE	
1D133C	ACUTE CARE / ISO 6	A	1D133C	PRINTABLE	
1D134A	ACUTE CARE / ISO 7 / BARIATRIC	A	1D134	PRINTABLE	
1D134B	TOILET / ISO / BARIATRIC	B	1D134A		
1D135A	ACUTE CARE / GYN 8	A	1D135	PRINTABLE	
1D135B	TOILET	B	1D135A		
1D136A	ACUTE CARE 9	A	1D136A	PRINTABLE	
1D136B	ACUTE CARE 10	A	1D136B	PRINTABLE	
1D136C	ACUTE CARE 11 / BARIATRIC	A	1D136C	PRINTABLE	
1D136D	ACUTE CARE 12	A	1D147	PRINTABLE	
1D136E	TREATMENT	A	1D144	PRINTABLE	
1D137A	TOILET	D	1D143A		I
1D137B	CLOSET	B	1D137B		
1D137C	TOILET	D	1D140A		I
1D138A	ANTE	A	1D138	PRINTABLE	
1D138B	MENTAL HEALTH 1	A	1D138A	PRINTABLE	
1D138C	TOILET	B	1D138B		
1D138D	MENTAL HEALTH 2	A	1D138C	PRINTABLE	
1D138E	EQUIP. STORAGE	B	1D111		
1D139A	ANTE	A	1D139	PRINTABLE	
1D139B	MENTAL HEALTH 3	A	1D139A	PRINTABLE	
1D139C	TOILET	B	1D139B		
1D139D	MENTAL HEALTH 4	A	1D139C	PRINTABLE	
1D139E	TOILET	D	1D118A		I
1D140A	FAST TRACK 1	A	1D117B	PRINTABLE	
1D140B	FAST TRACK 2	A	1D117C	PRINTABLE	
1D140C	FAST TRACK 3	A	1D118B	PRINTABLE	
1D140D	MEDS RM	B	1D137A		
1D140E	FAST TRACK 4	A	1D118C	PRINTABLE	
1D140F	FAST TRACK 5	A	1D125B	PRINTABLE	
1D140G	SOILED UTILITY	A	1D140G	PRINTABLE	B
1D140H	FAST TRACK 6	A	1D125A	PRINTABLE	
1D140I	STORAGE	B	1D117A		
1D141A	OFFICE	A	1D141A	PRINTABLE	
1D141B	OFFICE	A	1D141B	PRINTABLE	
1D141C	OFFICE	A	1D141C	PRINTABLE	
1D141D	OFFICE	A	1D141D	PRINTABLE	
1D141E	TREATMENT	A	1D141E	PRINTABLE	
1D141F	LOUNGE	A	1D108	PRINTABLE	
1D141G	TOILET	B	1D120		
1D141H	TELE	B	1D142A		
1D141I	SIGNAL	B	1D141I		
1D142	NURSE / DOCTOR	A	1D137	PRINTABLE	
1D142A	TREATMENT	A	1D141	PRINTABLE	
1D142B	NURSE / DOCTOR	A	1D142B	PRINTABLE	
1D142C	EXAM	A	1D142C	PRINTABLE	
1D142D	EXAM	A	1D142D	PRINTABLE	
1D142E	EXAM	A	1D142E	PRINTABLE	
1D142F	EXAM	A	1D142F	PRINTABLE	
1D142G	EXAM	A	1D142G	PRINTABLE	
1D142H	EXAM	A	1D142H	PRINTABLE	
1D142I	EXAM	A	1D142I	PRINTABLE	
1D142J	EXAM	A	1D142J	PRINTABLE	
C165	CORRIDOR	B	C165		
C165A	CORRIDOR	B	C165A		F,E,E,G
C166A	CORRIDOR	B	C166		E
C166B	CORRIDOR	A	C166A		
C166C	CORRIDOR	A	C166B		
C167	CORRIDOR	G	C167		R,T
C167A	CORRIDOR	B	C167A		
C168	CORRIDOR	G	C168		R,T,I
C168A	CORRIDOR	O	C168A		
C168B	CORRIDOR	O	C168B		R,T,P
C169A	CORRIDOR	B	C169		
C169B	VESTIBULE	B	C169A		S

SIGN SCHEDULE - CONT.

ROOM NO.	ROOM NAME	CALLOUT	FIRST COMPONENT TEXT	SECOND COMPONENT TEXT	ADDITIONAL CALLOUT
C170	CORRIDOR	B	C170		S
C188A	CORRIDOR	B	C188A		
C198	CORRIDOR	B	C198		
S15	STAIR	A	S15	PRINTABLE	L,T,R

GRAPHIC LEGEND

- INDICATES SIGN TYPE, LOCATION, AND MOUNTING DIRECTION
- INDICATES LOCATION OF CORNER GUARDS
- INDICATES LOCATION OF HANDRAIL AND BUMPER GUARDS
- WALL BUMPER GUARD
- HANDRAIL

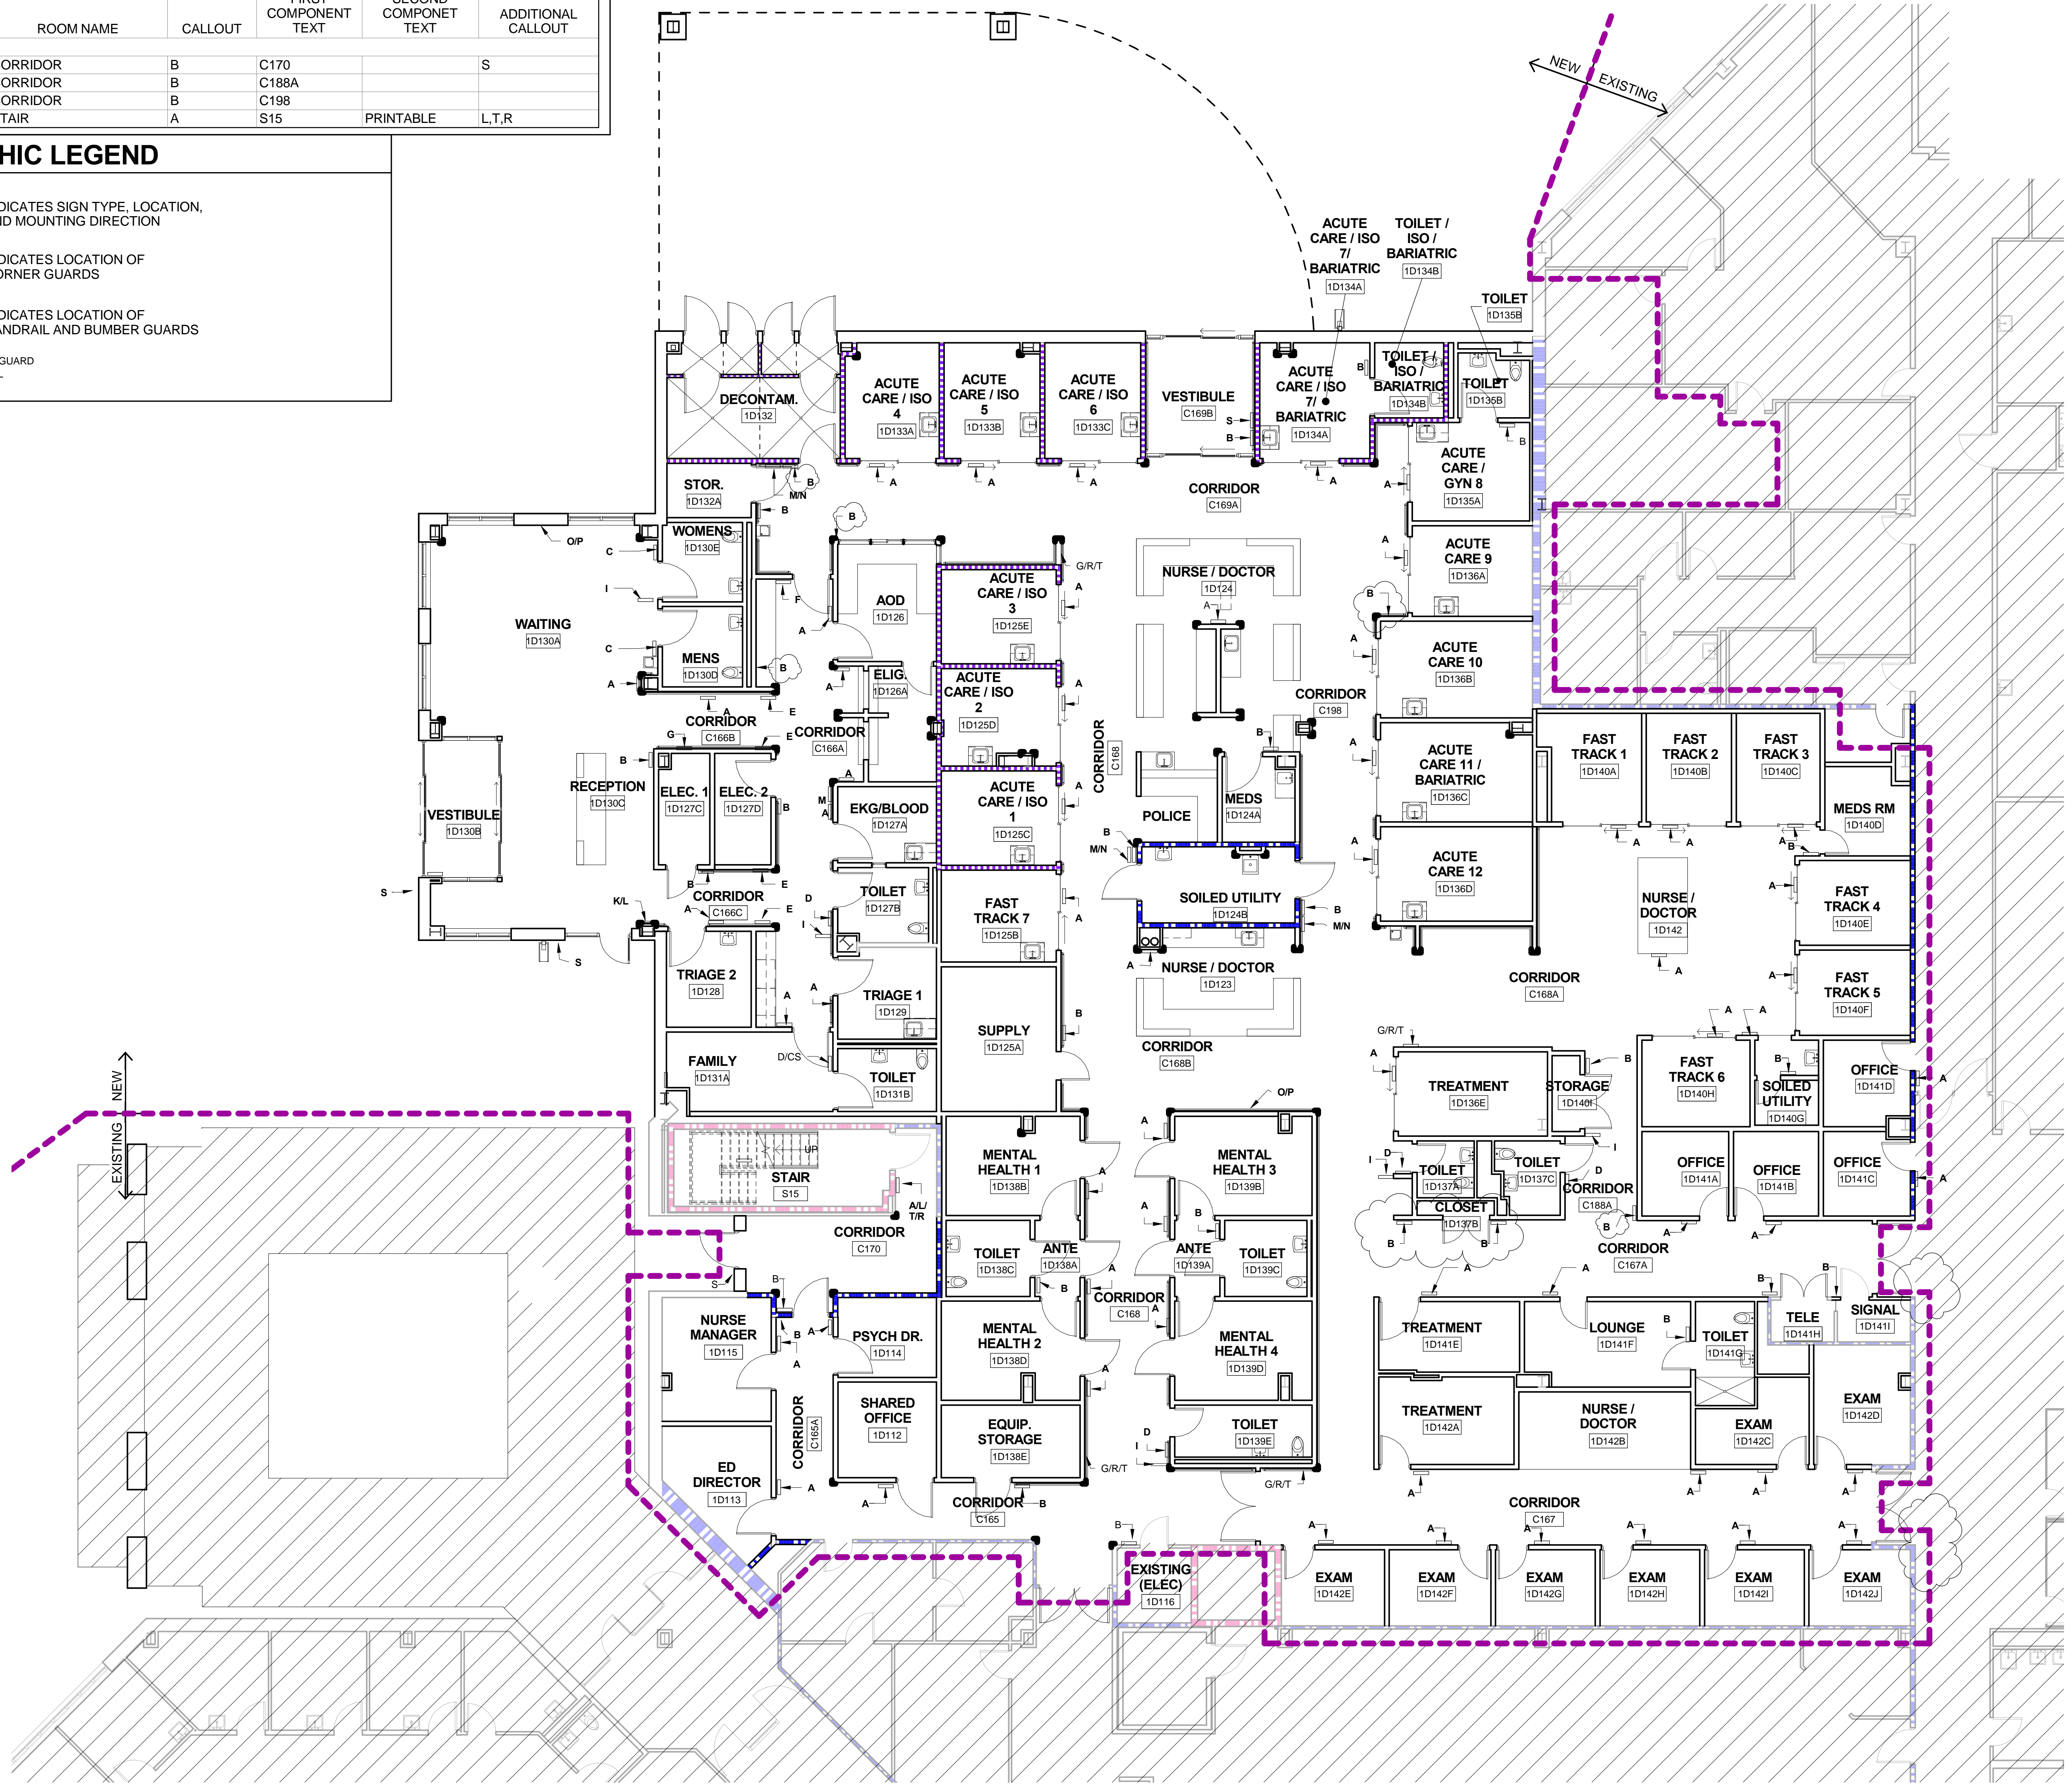

1 FLOOR PLAN - SIGNAGE

1/8" = 1'-0"

CONSTRUCTION DOCUMENTS SUBMISSION
FULLY SPRINKLERED

CONSULTANTS:		ARCHITECT/ENGINEERS:		Drawing Title SIGNAGE SCHEDULE & DETAILS		Project Title EMERGENCY DEPARTMENT MENTAL HEALTH IMPROVEMENTS - REDESIGN		Project Number CSI-112		CENTRAL ARKANSAS VETERANS AFFAIRS HEALTHCARE SYSTEM	
Revisions:		BES DESIGN/BUILD		Approved: Project Director		Location LITTLE ROCK, ARKANSAS		Building Number 1		Department of Veterans Affairs	
1 Revision 1 08/08/2017		BES DESIGN/BUILD		Date 2016.10.31		Drawn BROOKS		Checked CLARK		Dwg. 55 of 123	