


GENERAL NOTES

1. THE CONTRACTOR SHALL NOTIFY THE COR AT LEAST TWO WEEKS IN ADVANCE OF ANY SHUT DOWN.
2. THE CONTRACTOR SHALL VERIFY THE CABLE SLACK IN EACH MANHOLE.

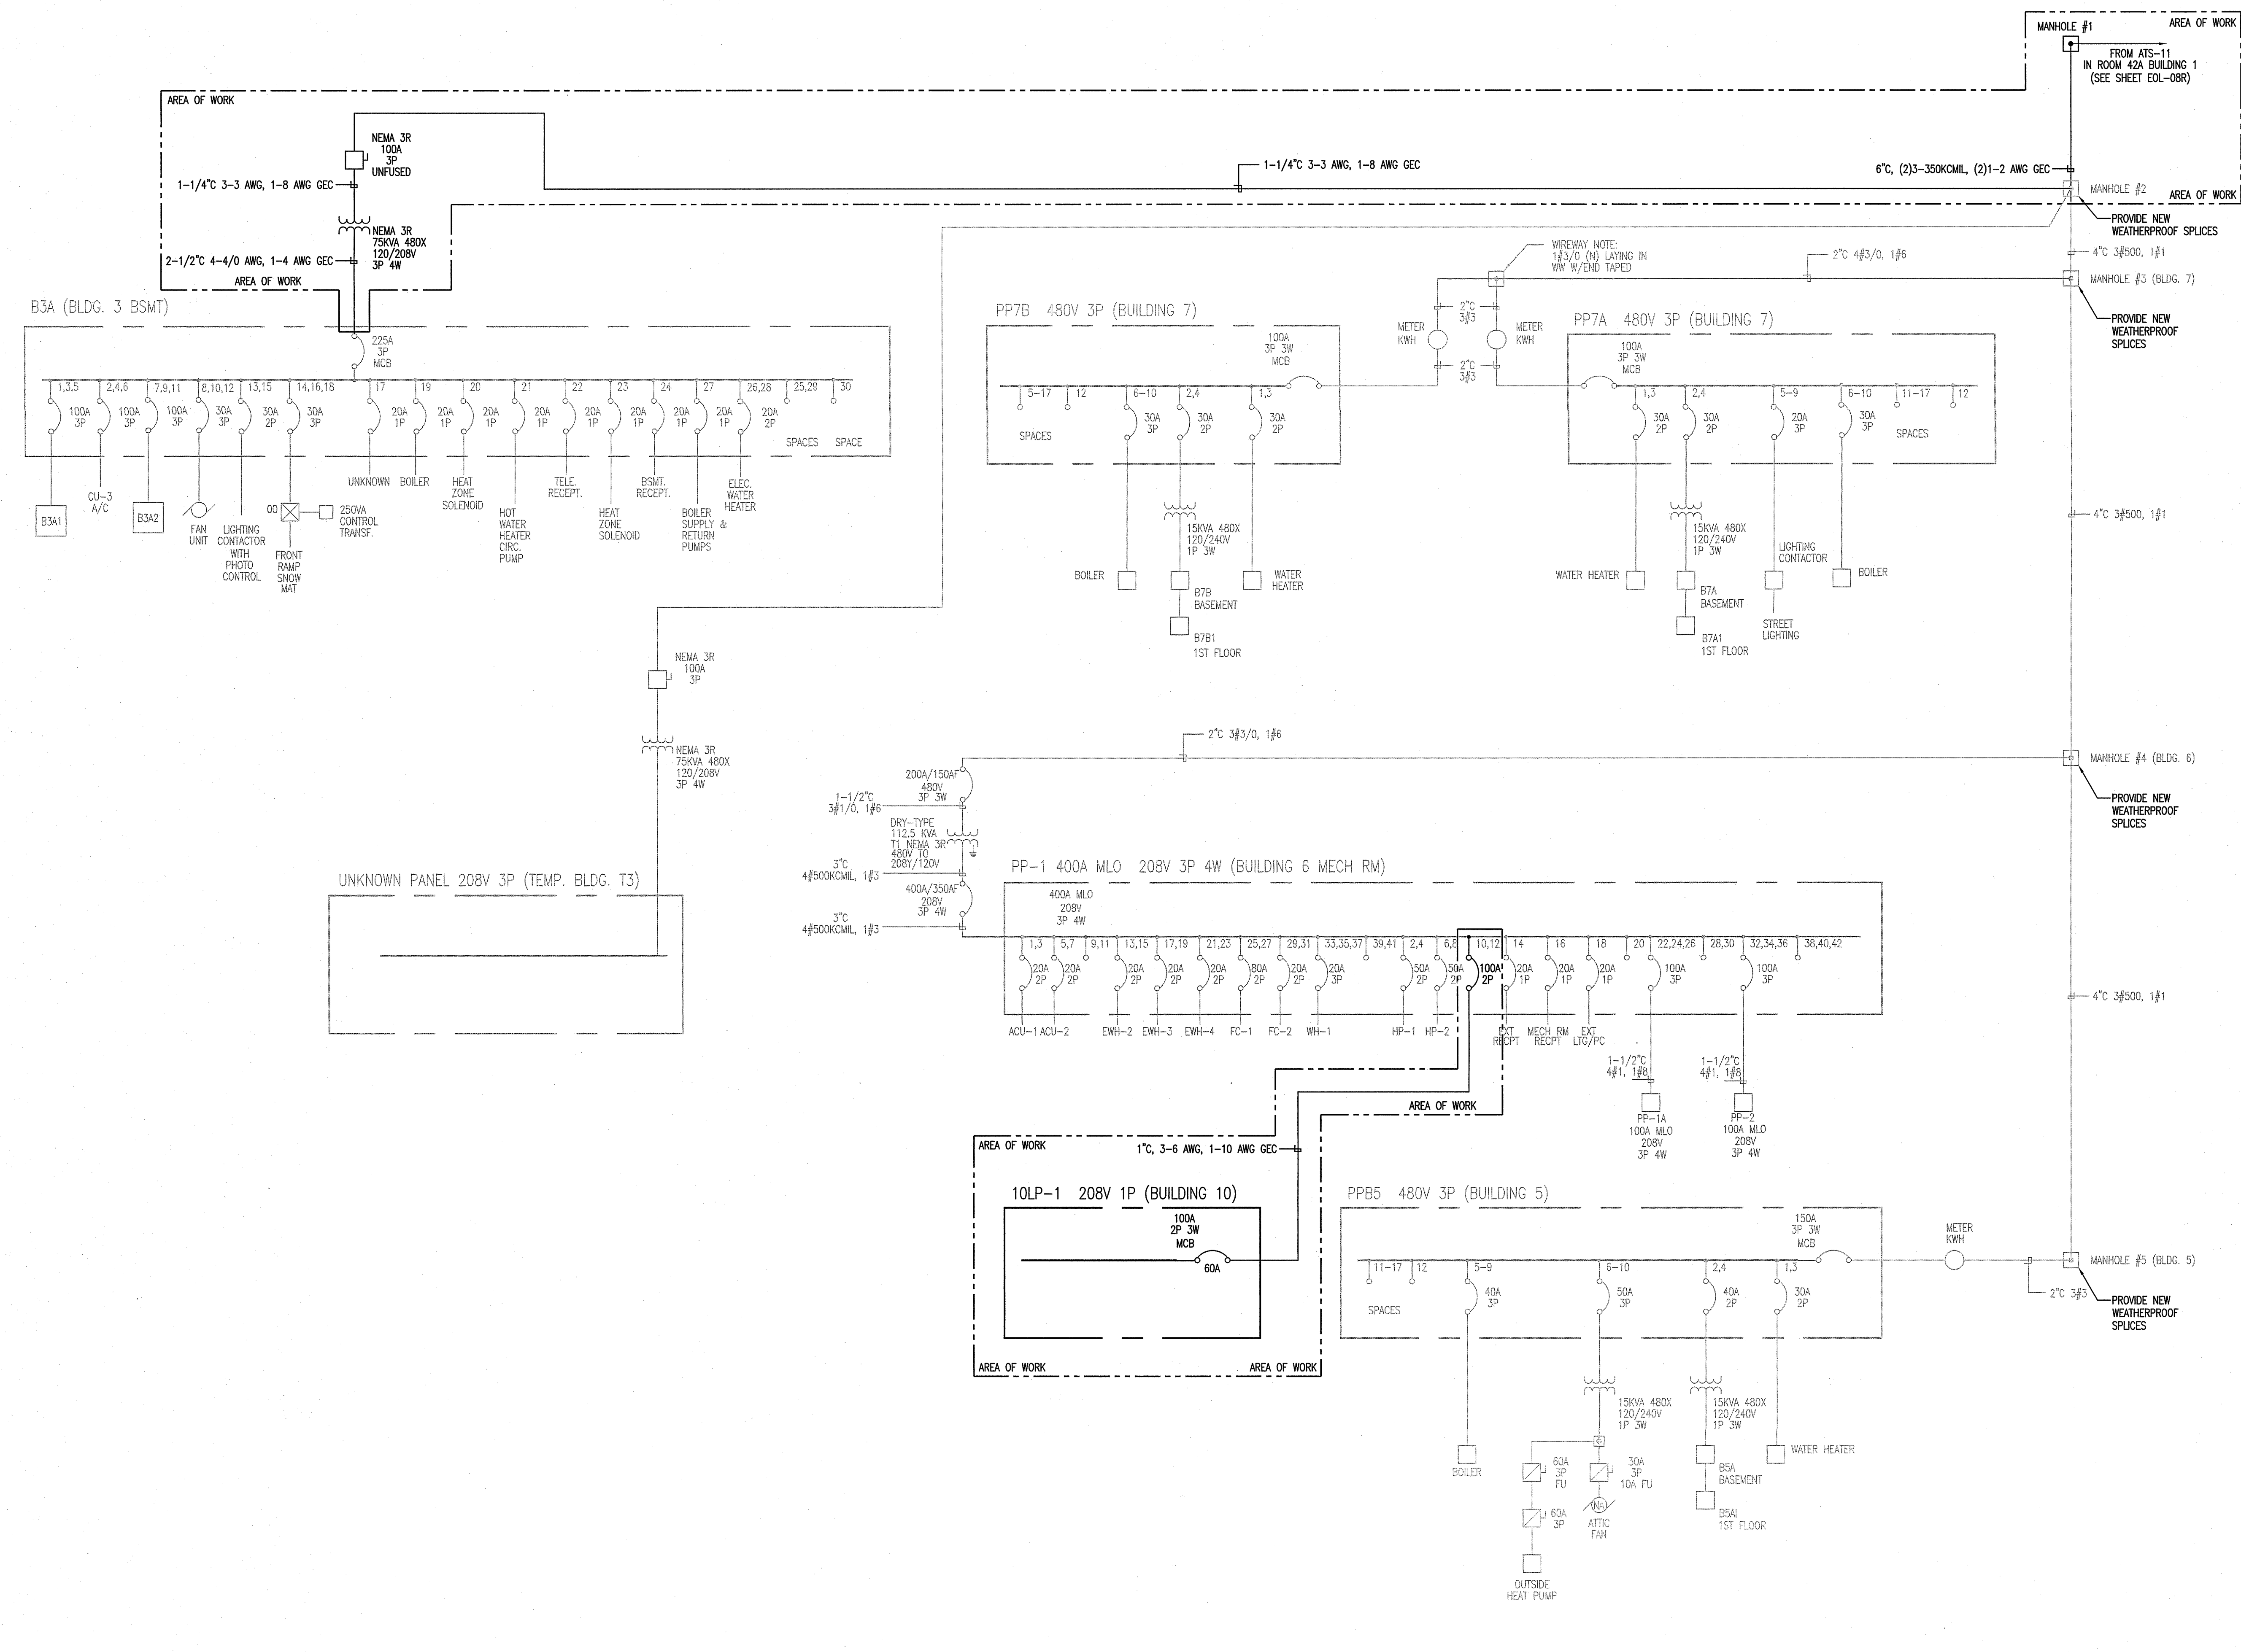

1 SINGLE LINE DIAGRAM - EXCERPT FROM VA FT. WAYNE EOL-04R BUILDINGS 3, 5, 6, 7, 10, AND T3
N.T.S.

one eighth inch = one foot
 one quarter inch = one foot
 one half inch = one foot
 three eighths inch = one foot
 one inch = one foot
 one and one half inches = one foot
 two inches = one foot
 three inches = one foot
 six inches = one foot

L:\Projects - Eng\2014 Projects\2014121-E-602.dwg 9-17-15 01:31:02 PM jwbeazley

Revisions:	Date

CONSULTANTS:

ARCHITECT/ENGINEERS:

APOGEE
Consulting Group, PA
www.apogee.com
Apogee Project # 2014 121

GUIDON
Civil / Structural Engineer
605 N Capitol Avenue, STE 100
Indianapolis, IN 46202
Tel: (317) 800-6389

Drawing Title
ELECTRICAL SINGLE LINE DIAGRAM
EXCERPT FROM EOL-04R

Approved: Project Director

Project Title
REPLACE MAIN ELECTRICAL
TO OUT-BUILDINGS

Location
FORT WAYNE, IN

Date
9/18/2015

Checked
JKM

Drawn
JWB

Project Number
610A4-12-188

Building Numbers
1,3,5,6,7,10,T4,T5,T6

Drawing Number
E-602
Dwg. 40 of 48

Office of Construction and Facilities Management

Department of Veterans Affairs

100% CONSTRUCTION DOCUMENTS