


- NOTE:
1. DEMO STEAM PIPING UP TO HEAT EXCHANGERS INCLUDING VALVES, STRAINERS, AND CONTROL VALVES.
 2. DEMO STEAM TRAPS
 3. HHWS & R AND CONDENSATE PIPING EXISTING TO REMAIN.

EAST AND WEST PENTHOUSE HEAT EXCHANGER PIPING DEMO


NIS

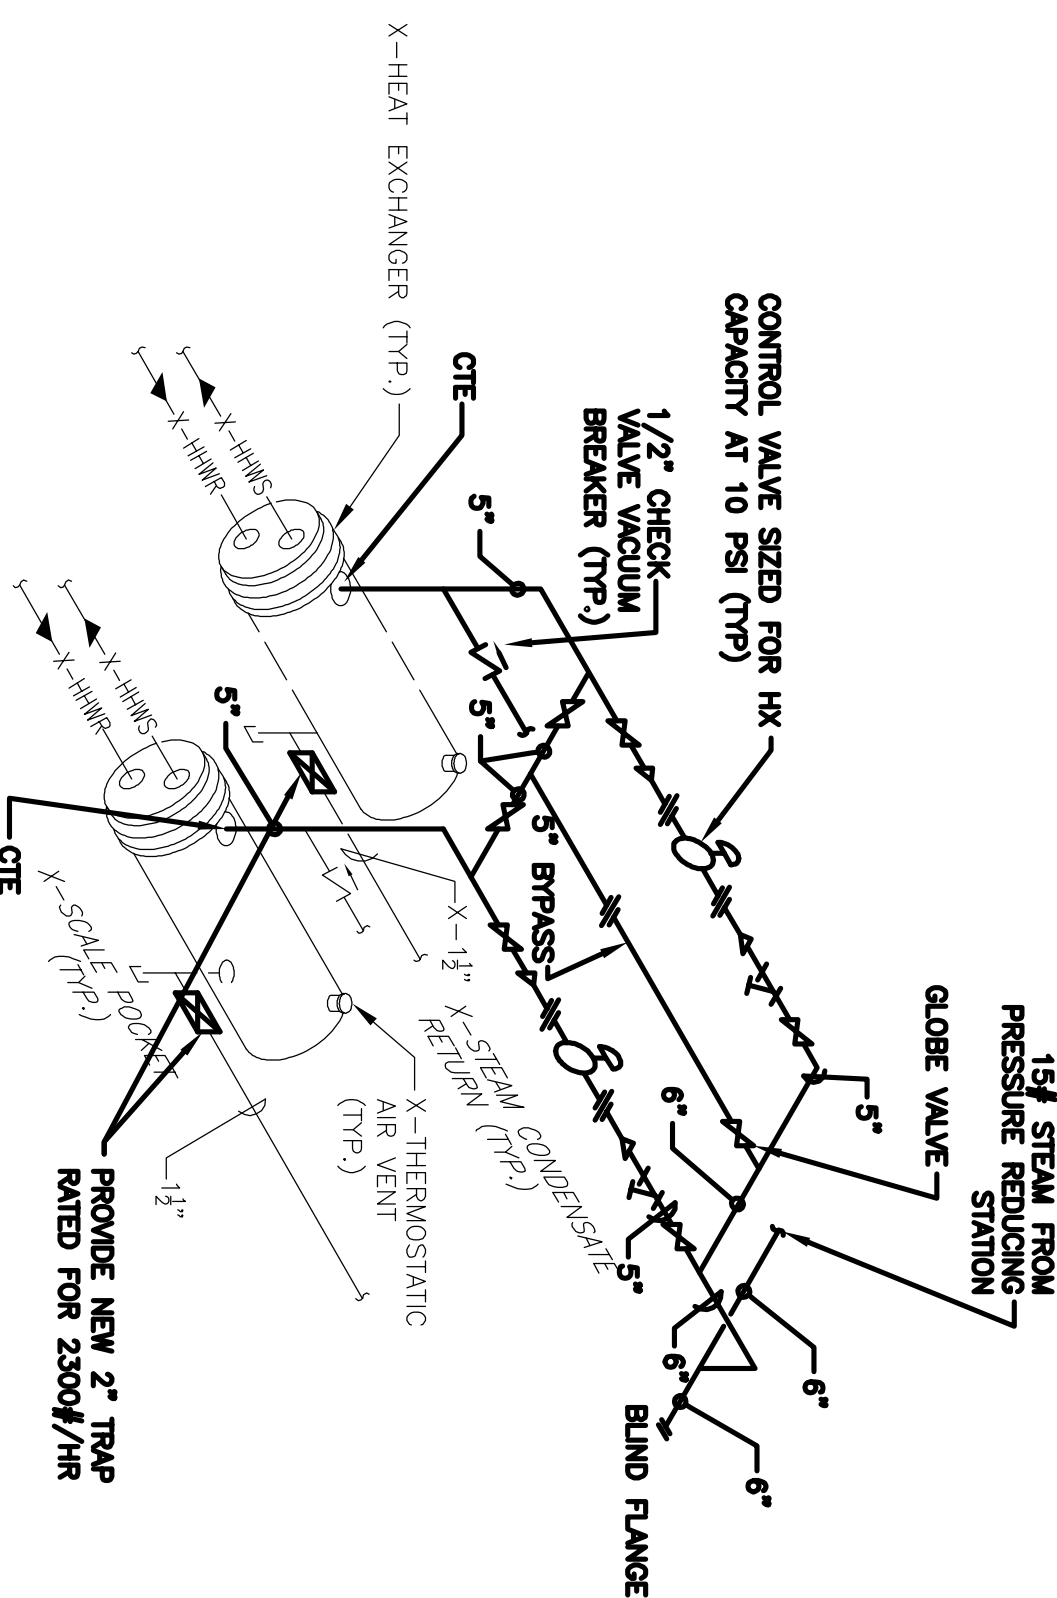

- NOTE:
1. PROVIDE NEW STEAM PIPE, VALVES, CONTROL VALVES, AND FITTINGS FOR EXISTING HEAT EXCHANGERS.
 2. HHWS & R PIPING TO HEAT EXCHANGERS IS EXISTING TO REMAIN.
 3. REPLACE STEAM TRAPS WITH NEW

EAST AND WEST PENTHOUSE HEAT EXCHANGER PIPING NEW WORK

NIS

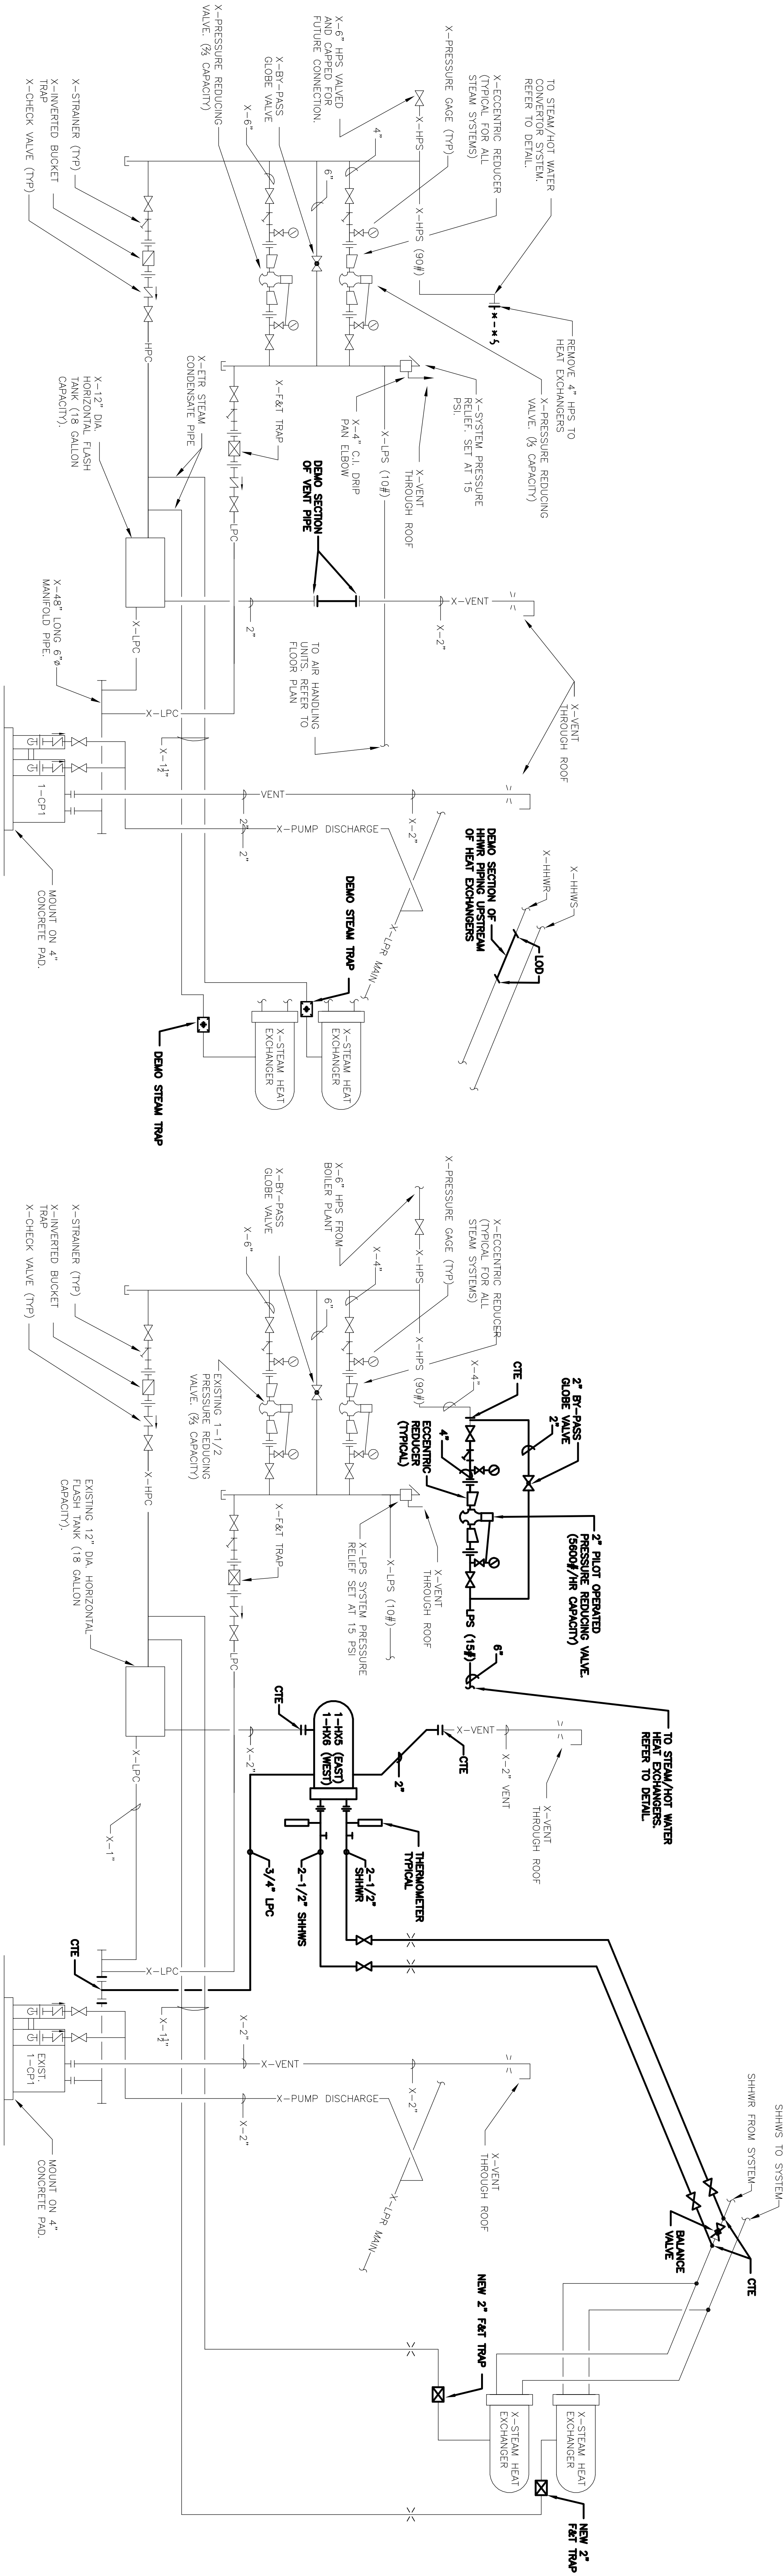

EAST AND WEST PENTHOUSE STEAM PRESSURE REDUCING STATION PIPING DIAGRAM (DEMOLITION)

NIS

EAST AND WEST PENTHOUSE STEAM PRESSURE REDUCING STATION PIPING DIAGRAM (NEW WORK)


NIS

FULLY SPRINKLERED

Revisions:		
FINAL CD SUBMISSION - FOR CONSTRUCTION	06-18-12	Date

CONSULTANTS:

FREDRICK, FREDRICK & HELLER
ENGINEERS, INC.
672 EAST 12TH AVE.
BROOKLYN HTS., OHIO 44147
TEL (440) 544-4944
FAX (440) 544-4944

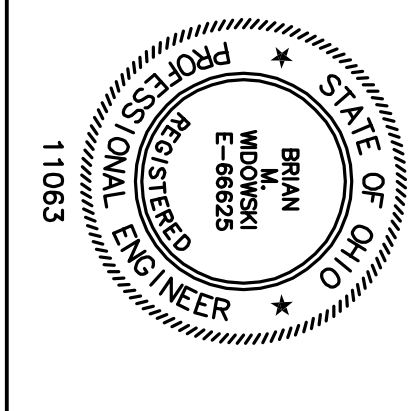

ARCHITECT:

Drawing Title
**EAST-WEST PENTHOUSE
GENERAL PIPING DIAGRAMS AND
MECHANICAL DETAILS**

Approved Project Director

Project Title
**STEAM CONDENSATE
HEAT RECOVERY SYSTEM**

Location
VAMC - WADE PARK

Date	Checked	Drawn	Dwg. of
06-18-12	BMW	DAD	2-H15

**Office of
Facilities
Management**
Department of
Veterans Affairs