



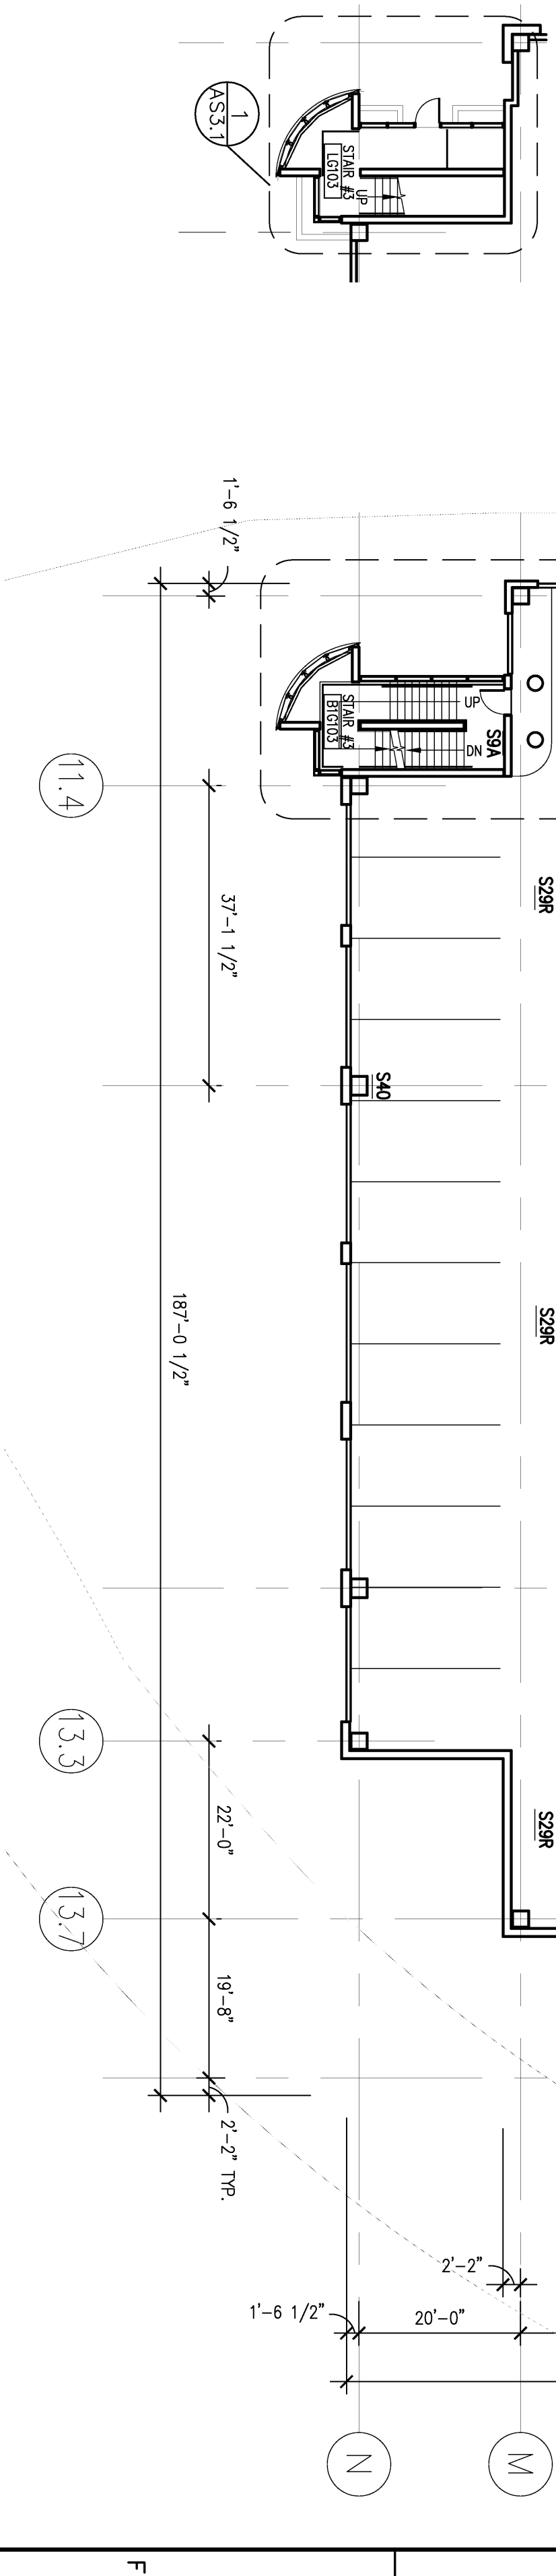

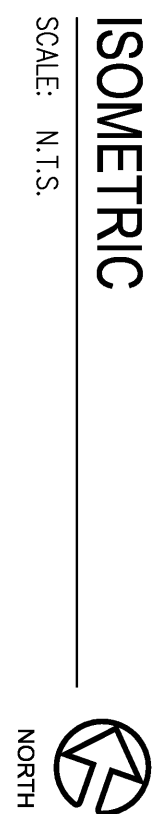


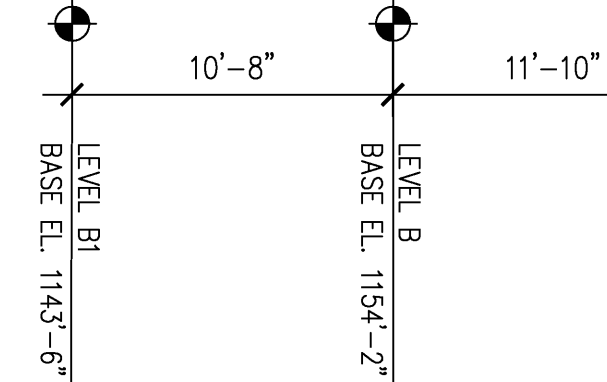
 
* LEVEL 1 WILL BE INITIALLY STRIPED FOR ONLY 20 STANDARD PARKING SPACES TO ALLOW USE OF AREA BY TRANSIT AND SHUTTLE BUSES DURING THE CONSTRUCTION OF A NEW BUILDING FOLLOWING THE COMPLETION OF THE GARAGE.



1
A1.1 LEVEL B1 ARCHITECTURAL PLAN
SCALE: 1/16" = 1'-0"

FINAL AS-BUILT SET

DESIGN/BUILD CONTRACTOR:  PJ DICK INCORPORATED		ARCHITECT/ENGINEER:  Tim Haahs ENGINEERS, ARCHITECTS <i>Parking Planning and Design</i>		MEP ENGINEER:  TOWER ENGINEERING 115 Engeman Heights Pkwy, Suite 400 Dayton, Ohio 45424 Phone (412) 531-5588 Fax (412) 535-2525		CIVIL/LANDSCAPE ENGINEER:  GATEWAY 250 Oak City Plaza, Oak Ridge, TN 37830	
PROJECT INFORMATION Drawing Title LEVEL B1 ARCHITECTURAL PLAN Project Number 646CA2500 I		Location Pittsburgh, PA Project Name VA Pittsburgh Health Care System - Parking Garage at University Drive Division		Building Number - Drawing Number A1.1		Office of Facilities Management  Department of Veterans Affairs	
BULLETIN #6 07/31/07		BULLETIN #2 01/29/07		Revisions: Date		Date	




SCALE: N.T.S.



FINAL AS-BUILT DRAWINGS	01/28/08
△ BULLETIN #6	07/31/07
Revisions:	Date

DESIGN/BUILD CONTRACTOR:

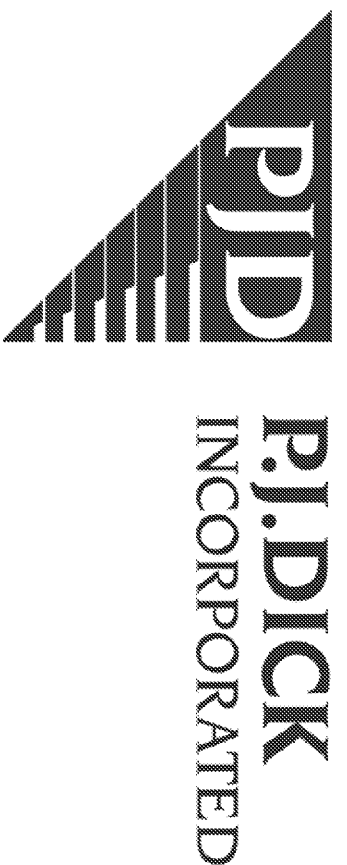


ARCHITECT/ENGINEER:

TimHaahs


ENGINEERS. ARCHITECTS

Parking Planning and Design

MEP ENGINEER:

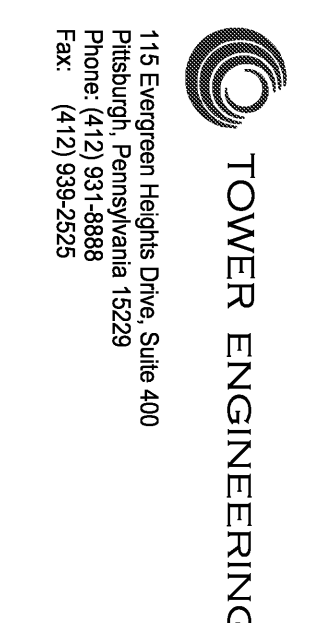

CIVIL/LANDSCAPE ENGINEER

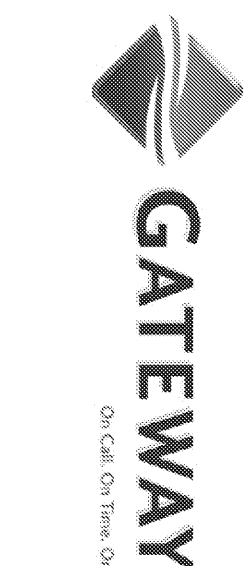

LEVEL B ARCHITECTURAL PLAN

1
A1.2 LEVEL B ARCHITECTURAL PLAN
SCALE: 1/16" = 1'-0"


Project title
VA Pittsburgh Health Care


Building Number

Project Number
646CA2500



**Office of
Facilities
Management**

Department of
Veterans Affairs

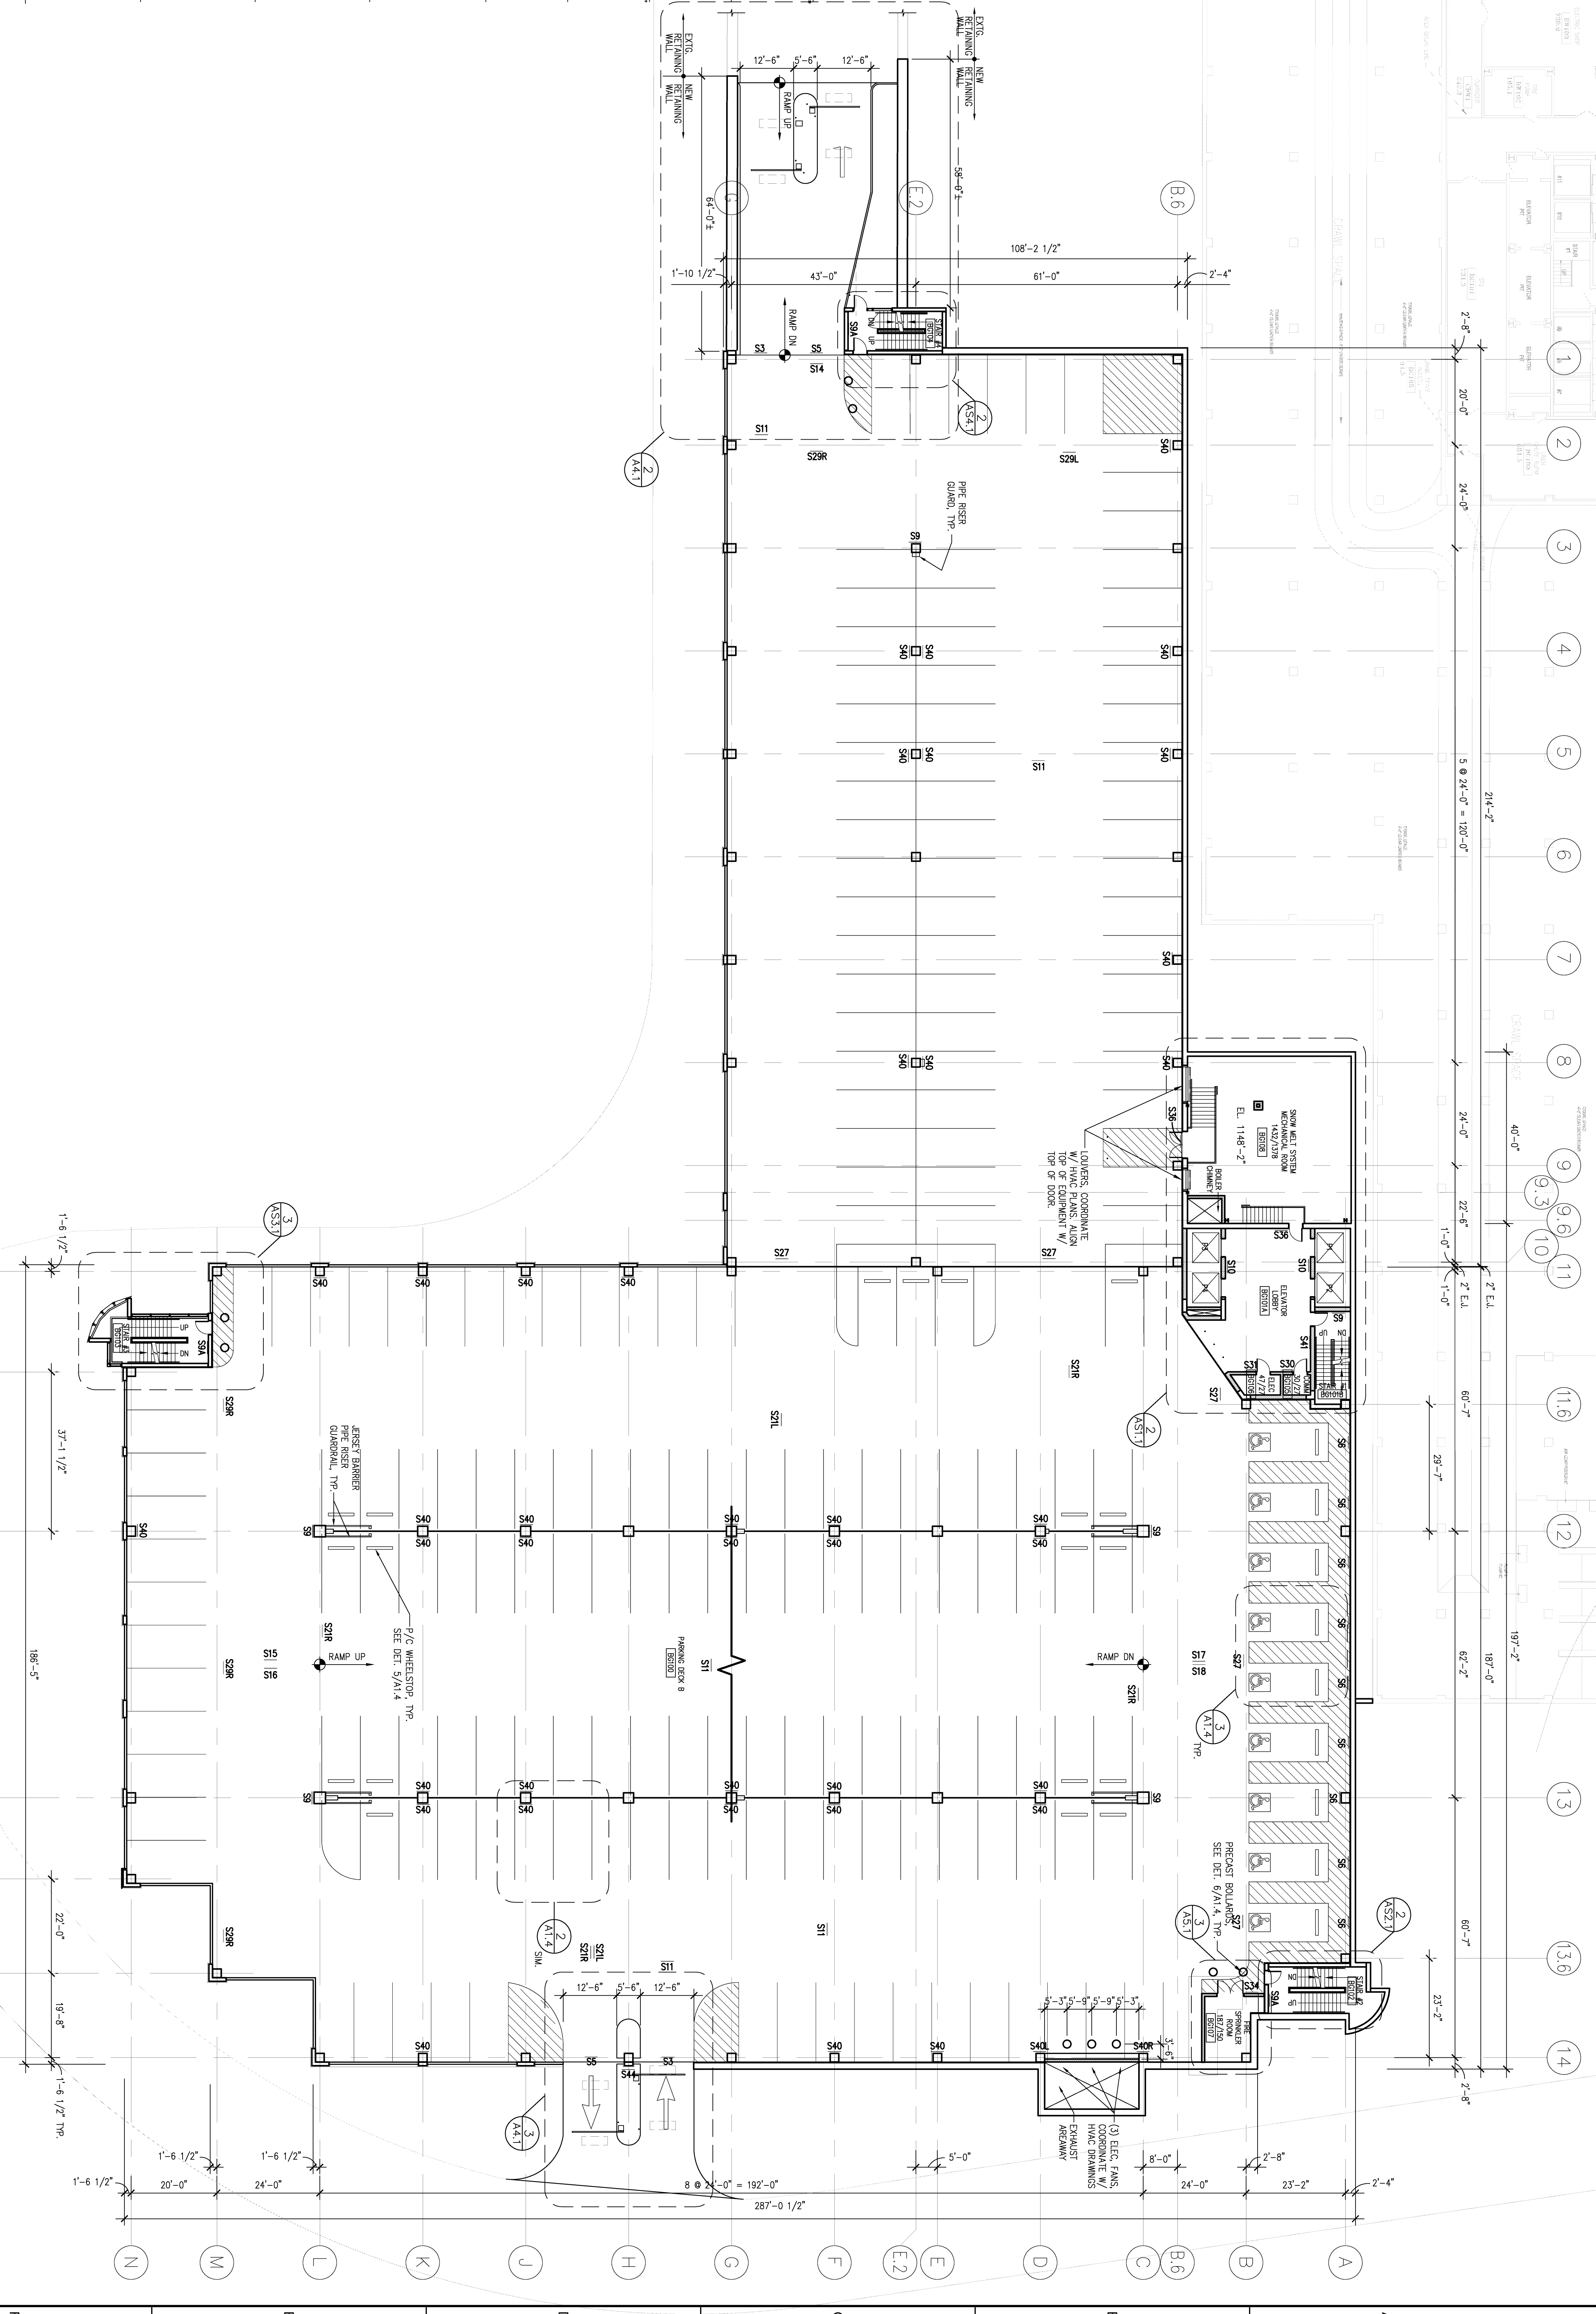

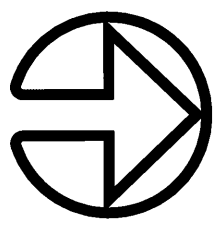

PLAN NORTH

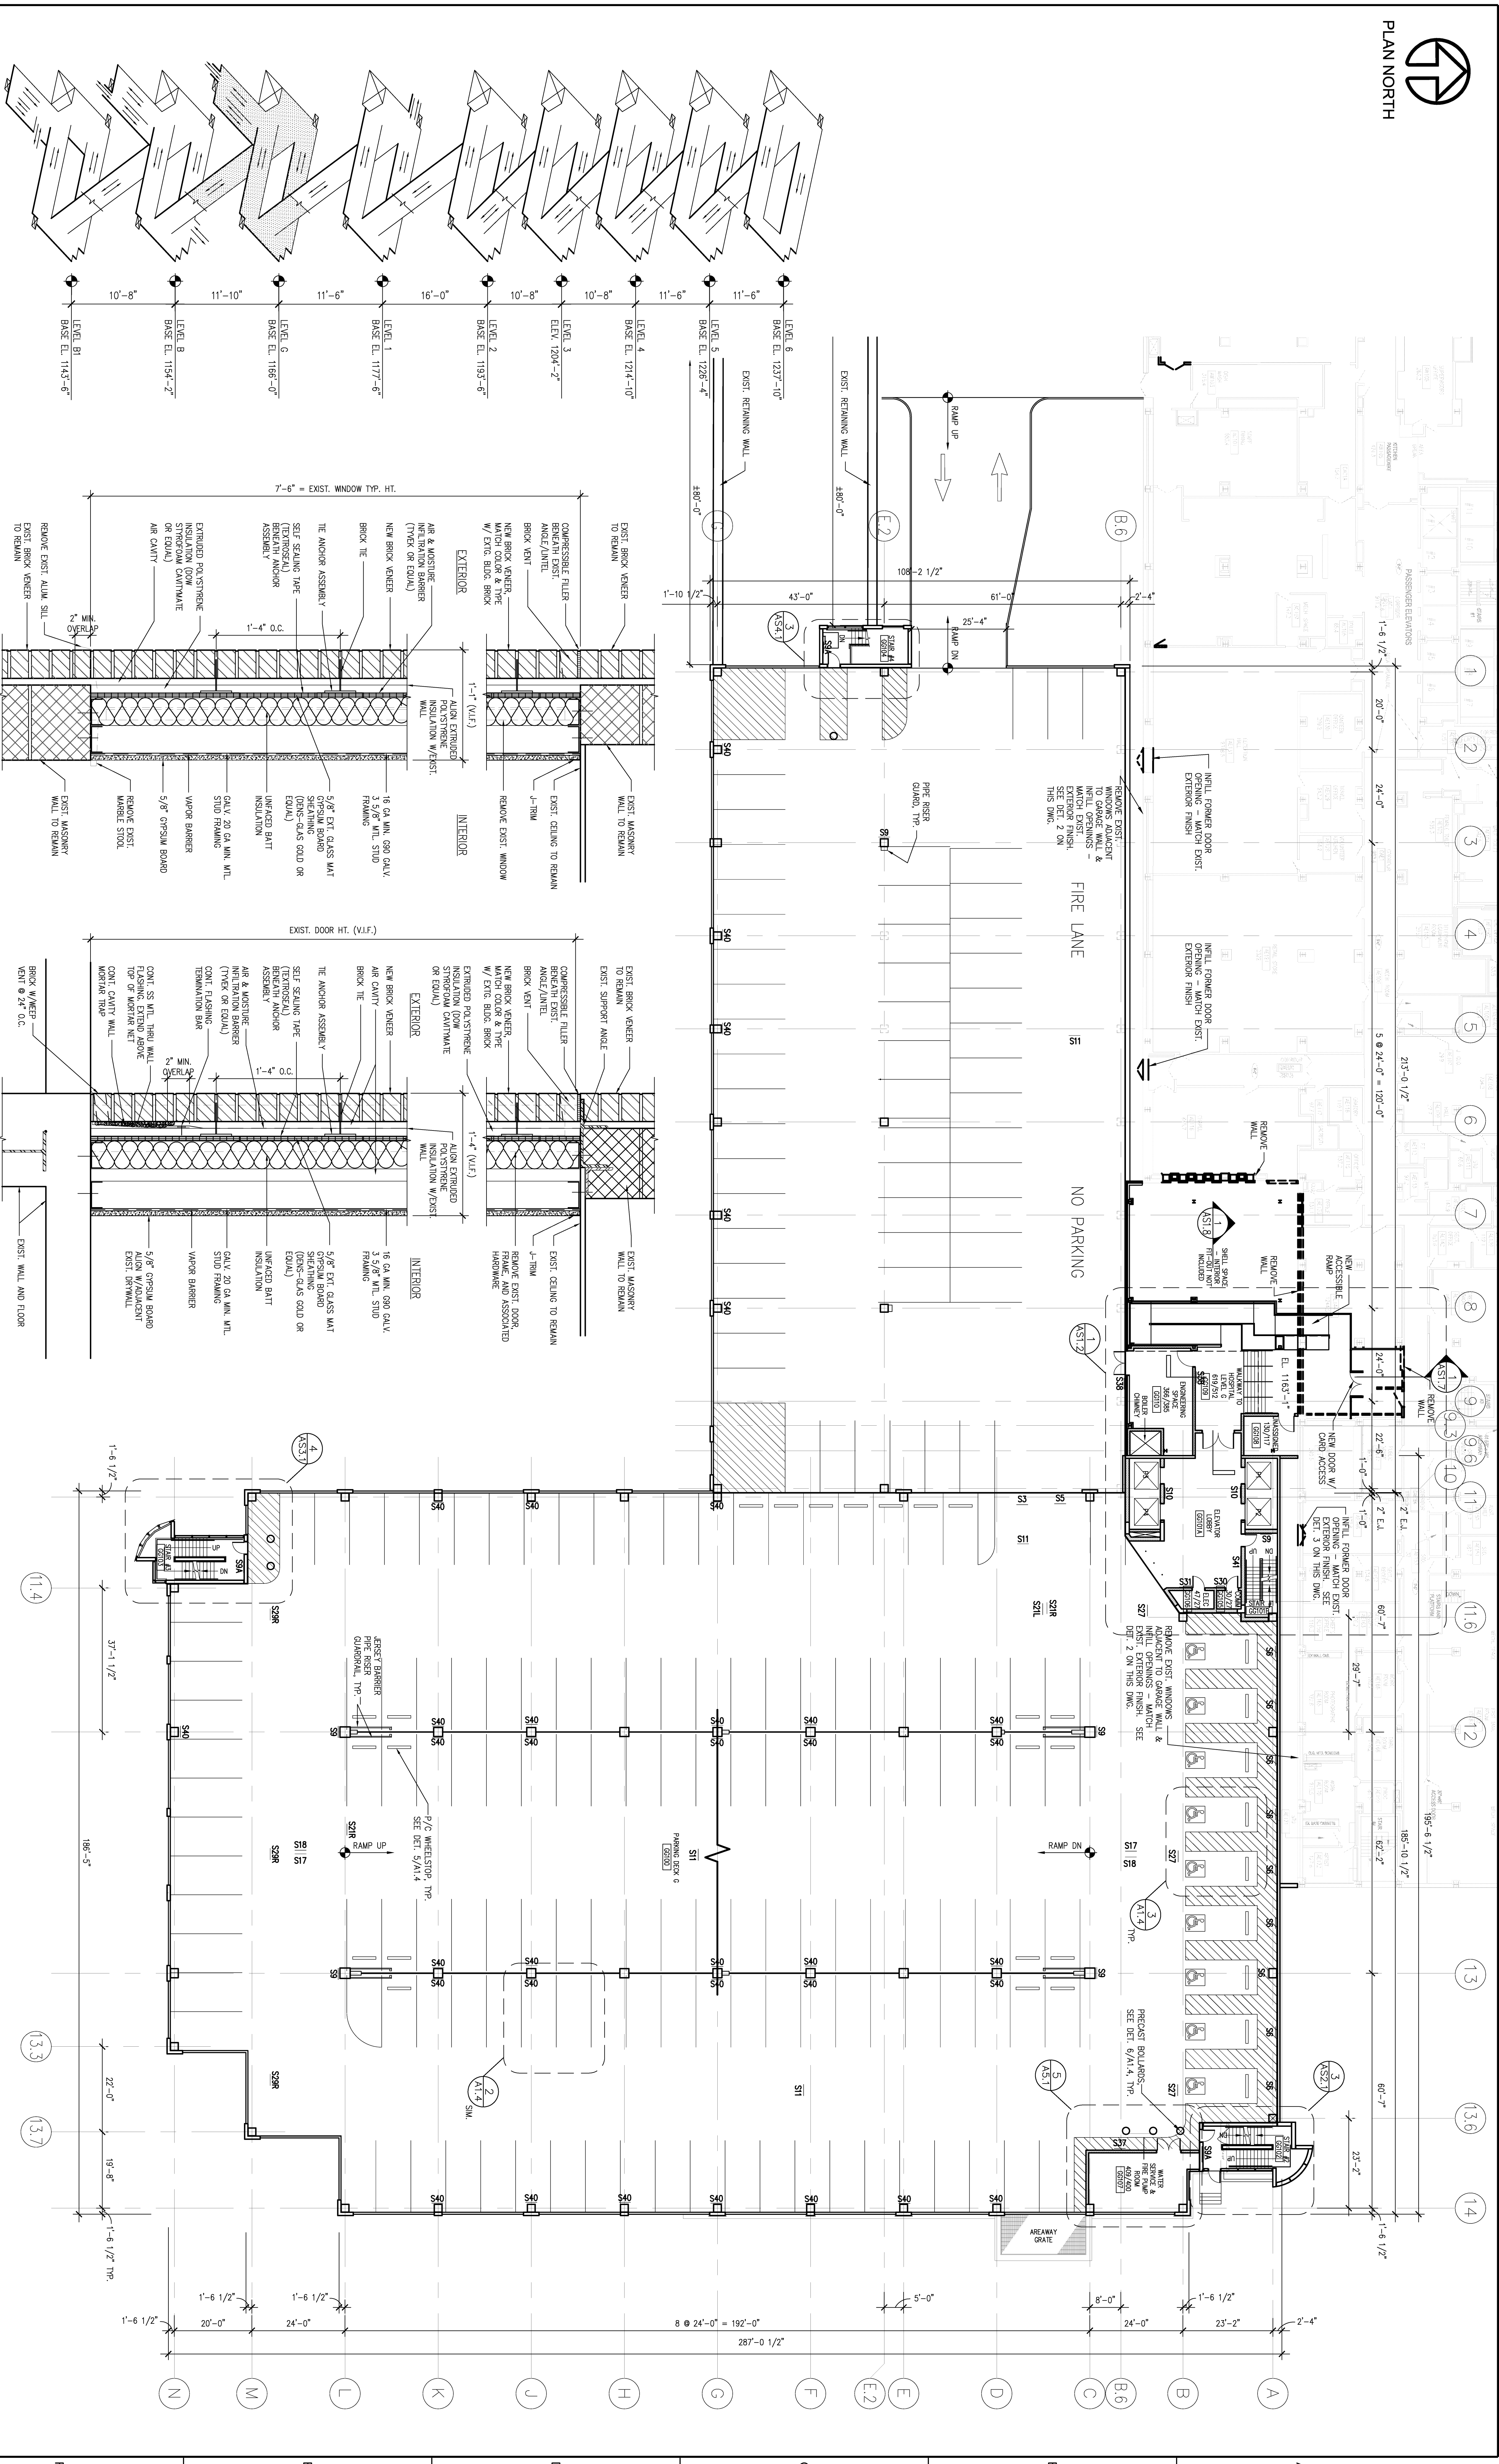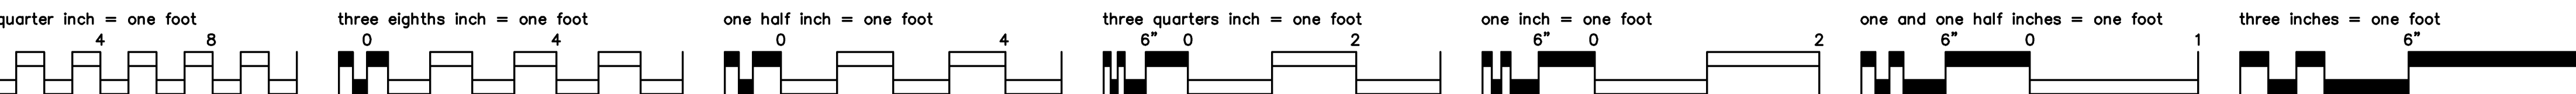

ISOMETRIC
SCALE: N.I.S.
NORTH

2 WINDOW INFILL DETAIL
SCALE: 1 1/2" = 1'-0"

3 DOOR INFILL DETAIL
SCALE: 1 1/2" = 1'-0"

1 LEVEL G ARCHITECTURAL PLAN
SCALE: 1/16" = 1'-0"

FINAL AS-BUILT DRAWINGS 01/28/08

DESIGN/BUILD CONTRACTOR: P.J. DICK INCORPORATED

ARCHITECT/ENGINEER: Tim Haahs ENGINEERS - ARCHITECTS

MEP ENGINEER: TOWER ENGINEERING

CIVIL/LANDSCAPE ENGINEER: GATEWAY

BULLETIN #5 05/29/07

BULLETIN #2 01/29/07

Revisions:

Project Title: VA Pittsburgh Health Care System - Parking Garage at University Drive Division

Location: Pittsburgh, PA

Project Number: 6A6CAZ200 I




Building Number: -

Drawing Number: A1.3

Office of Facilities Management

Department of Veterans Affairs

VA FORM GS-6231, OCT 1978

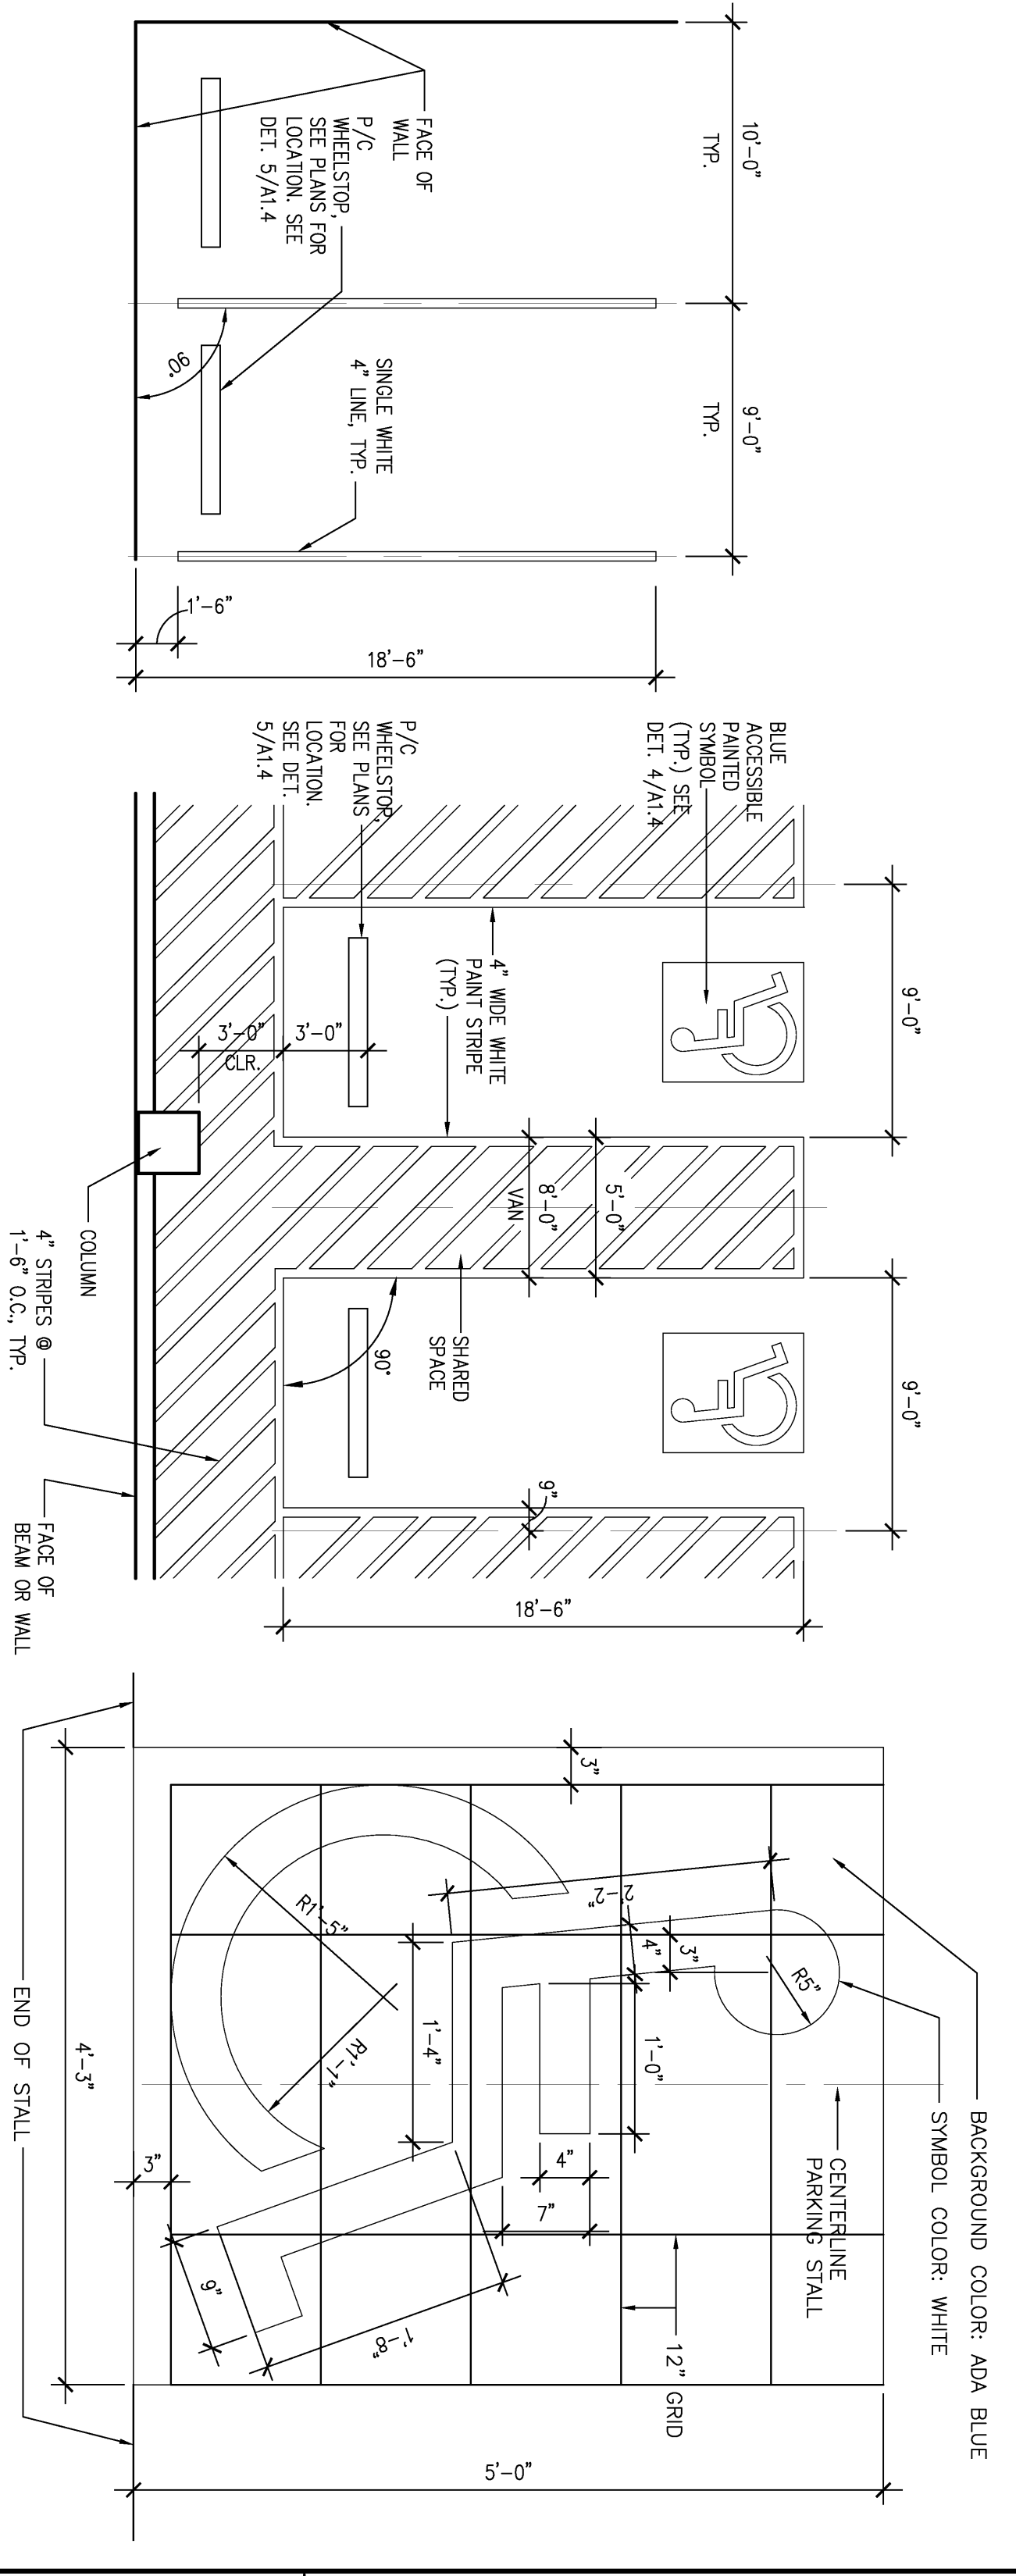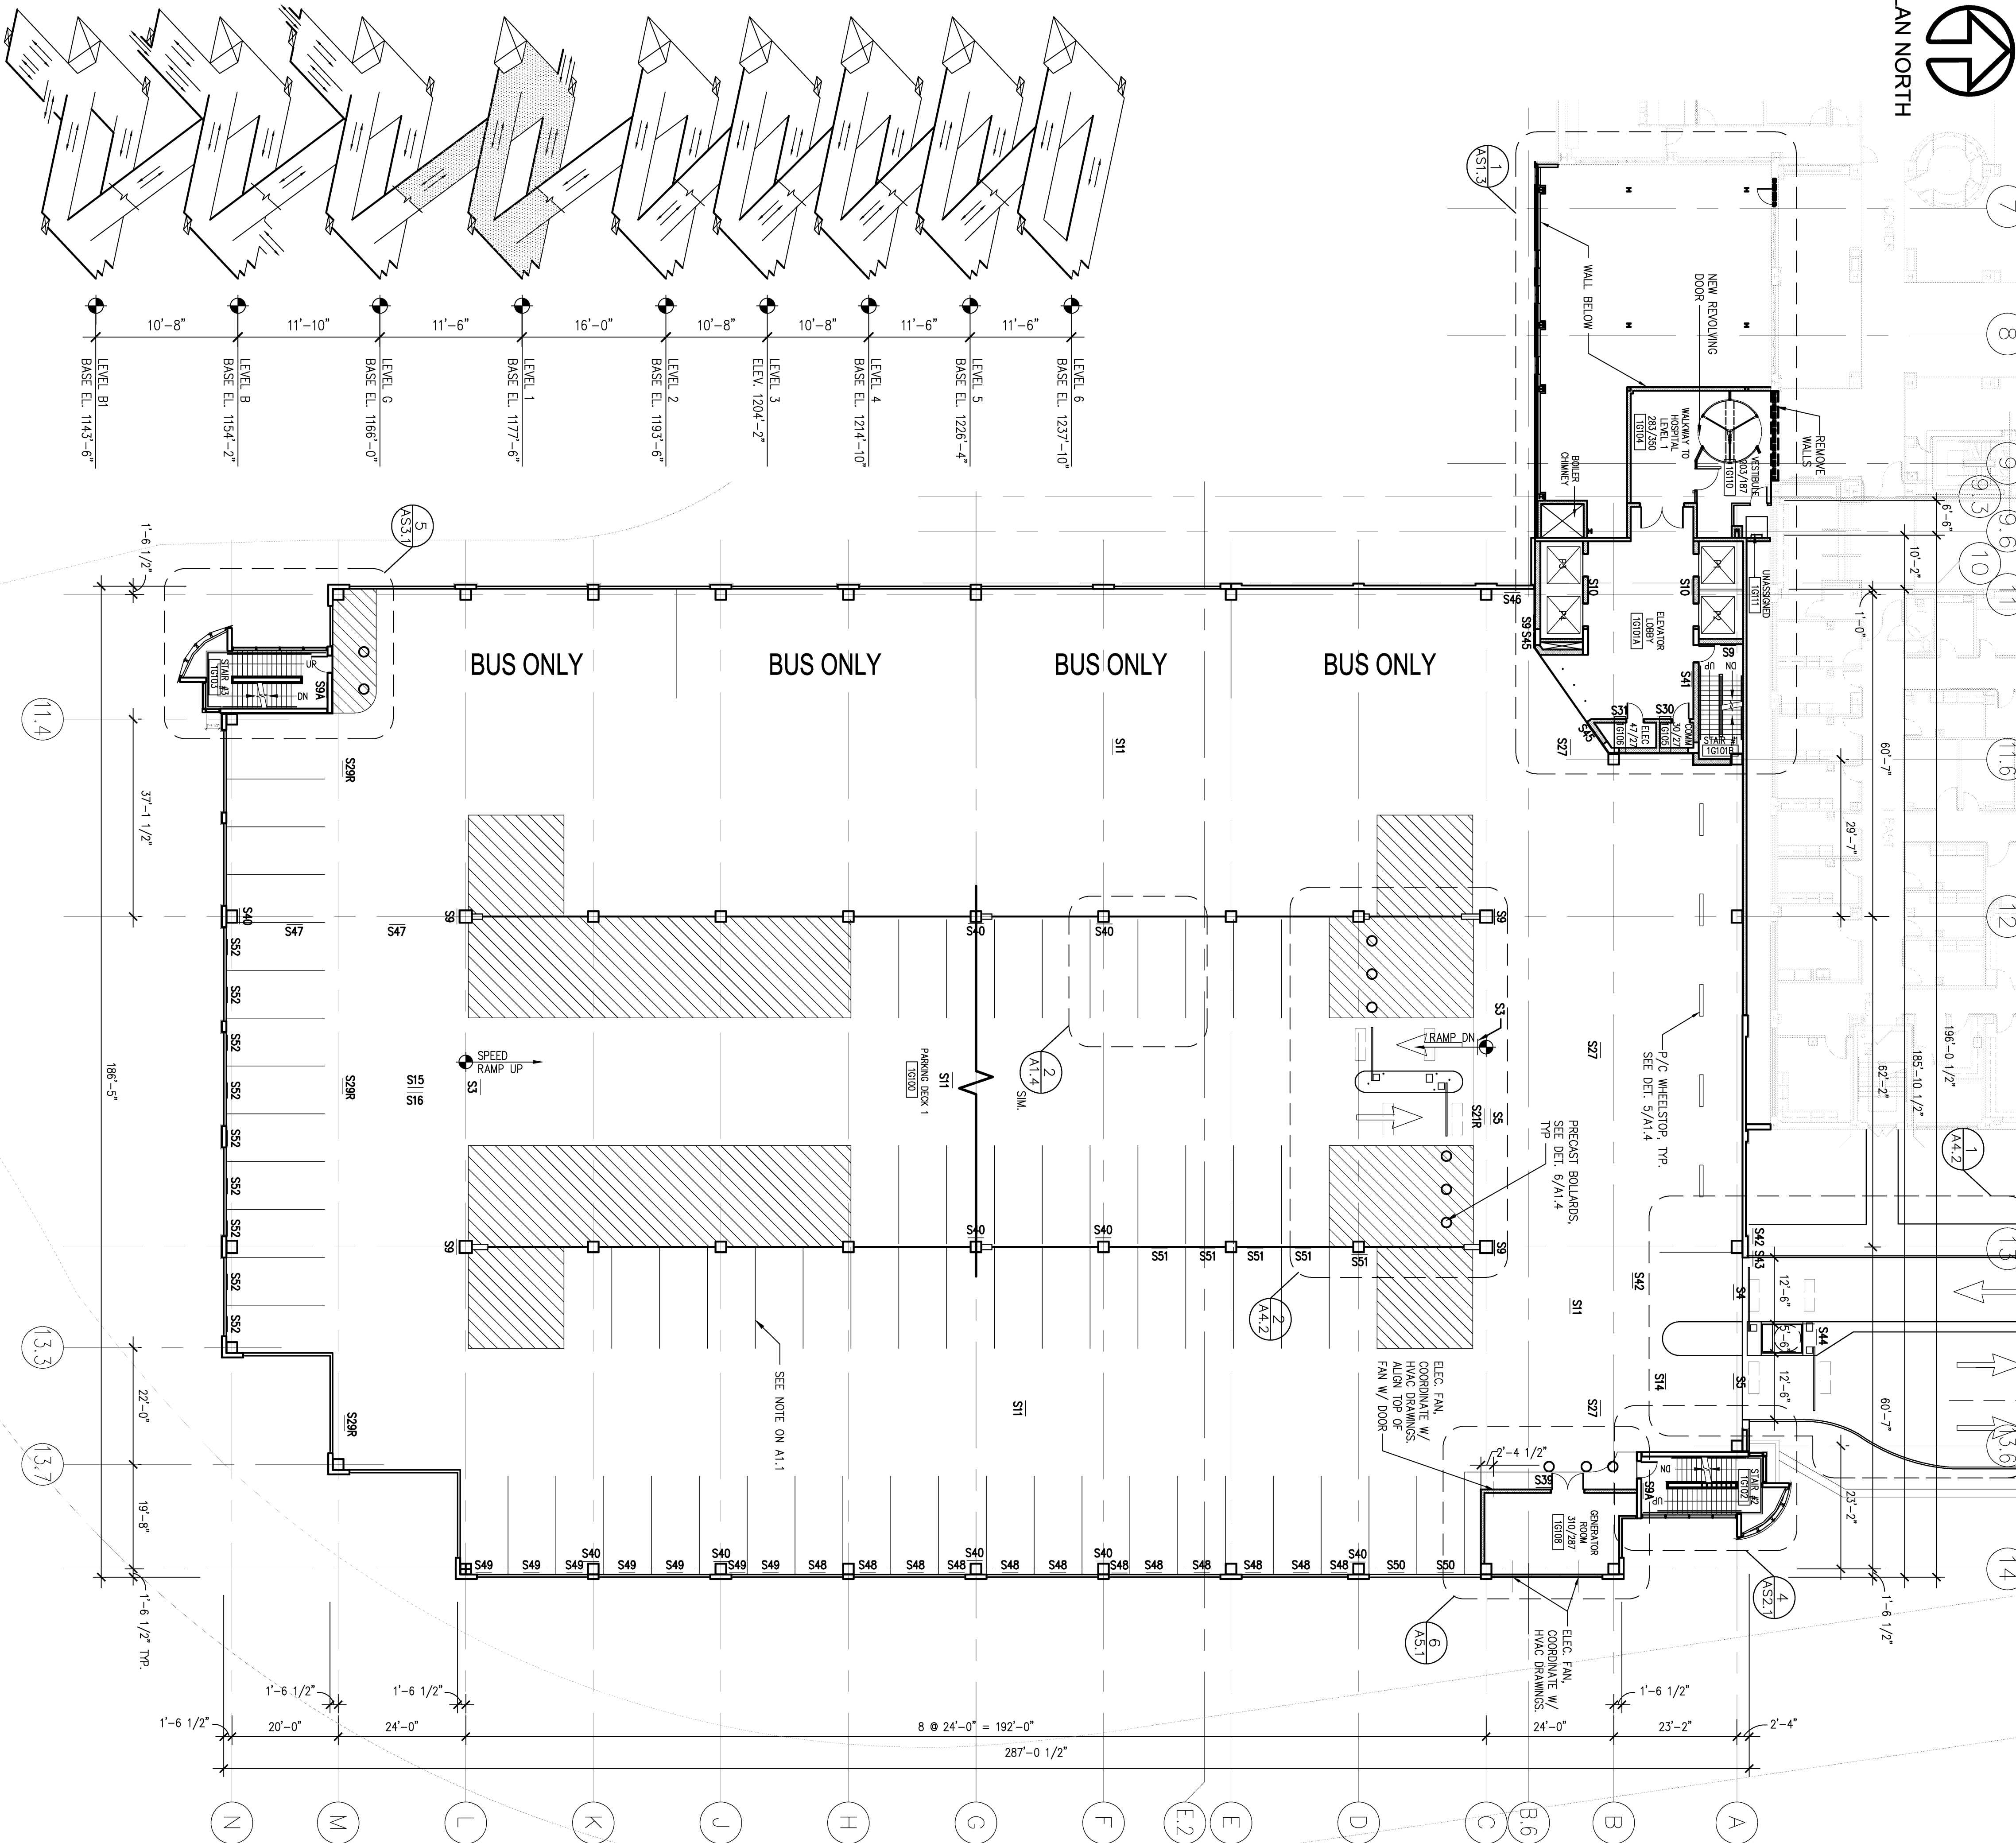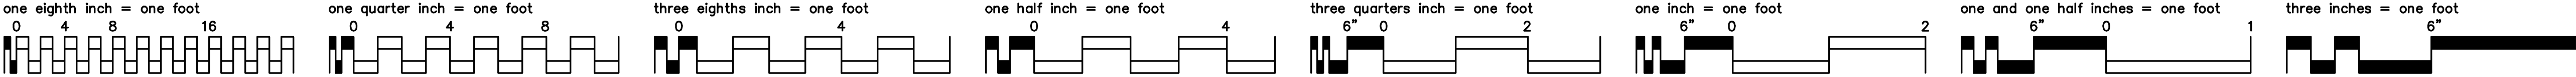


ISOMETRIC




1 LEVEL 1 ARCHITECTURAL PLAN

FINAL AS-BUILT SET

FINAL AS-BUILT DRAWINGS	01/28/08	DESIGN/BUILD CONTRACTOR:	P.D. DICK INCORPORATED	ARCHITECT/ENGINEER:	Tim Haahs ENGINEERS - ARCHITECTS	M/E/P ENGINEER:	TOWER ENGINEERING	CIVIL/LANDSCAPE ENGINEER:	GATEWAY	Project Title	VA Pittsburgh Health Care System - Parking Garage at University Drive Division	Project Number	646CA2500 I	Office of Facilities Management
BULLETIN #5	05/28/07									Location	Pittsburgh, PA	Building Number		
BULLETIN #3	02/28/07									Date	10/31/06	Drawn	EKH	
Revisions:	Date									Checked	NCA	Dwg. - of -		


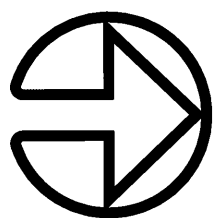


PLAN NORTH

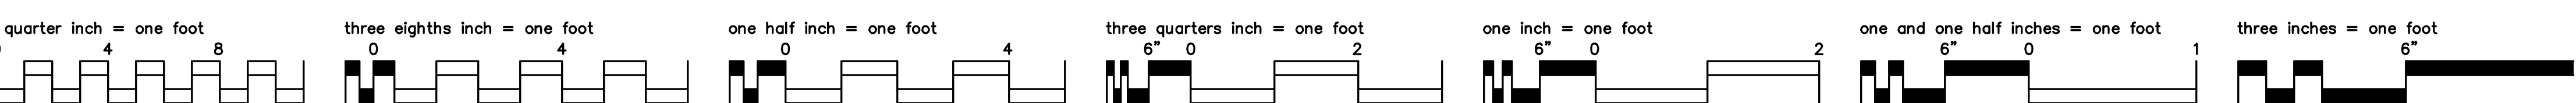

ISOMETRIC

SCALE: N.T.S.

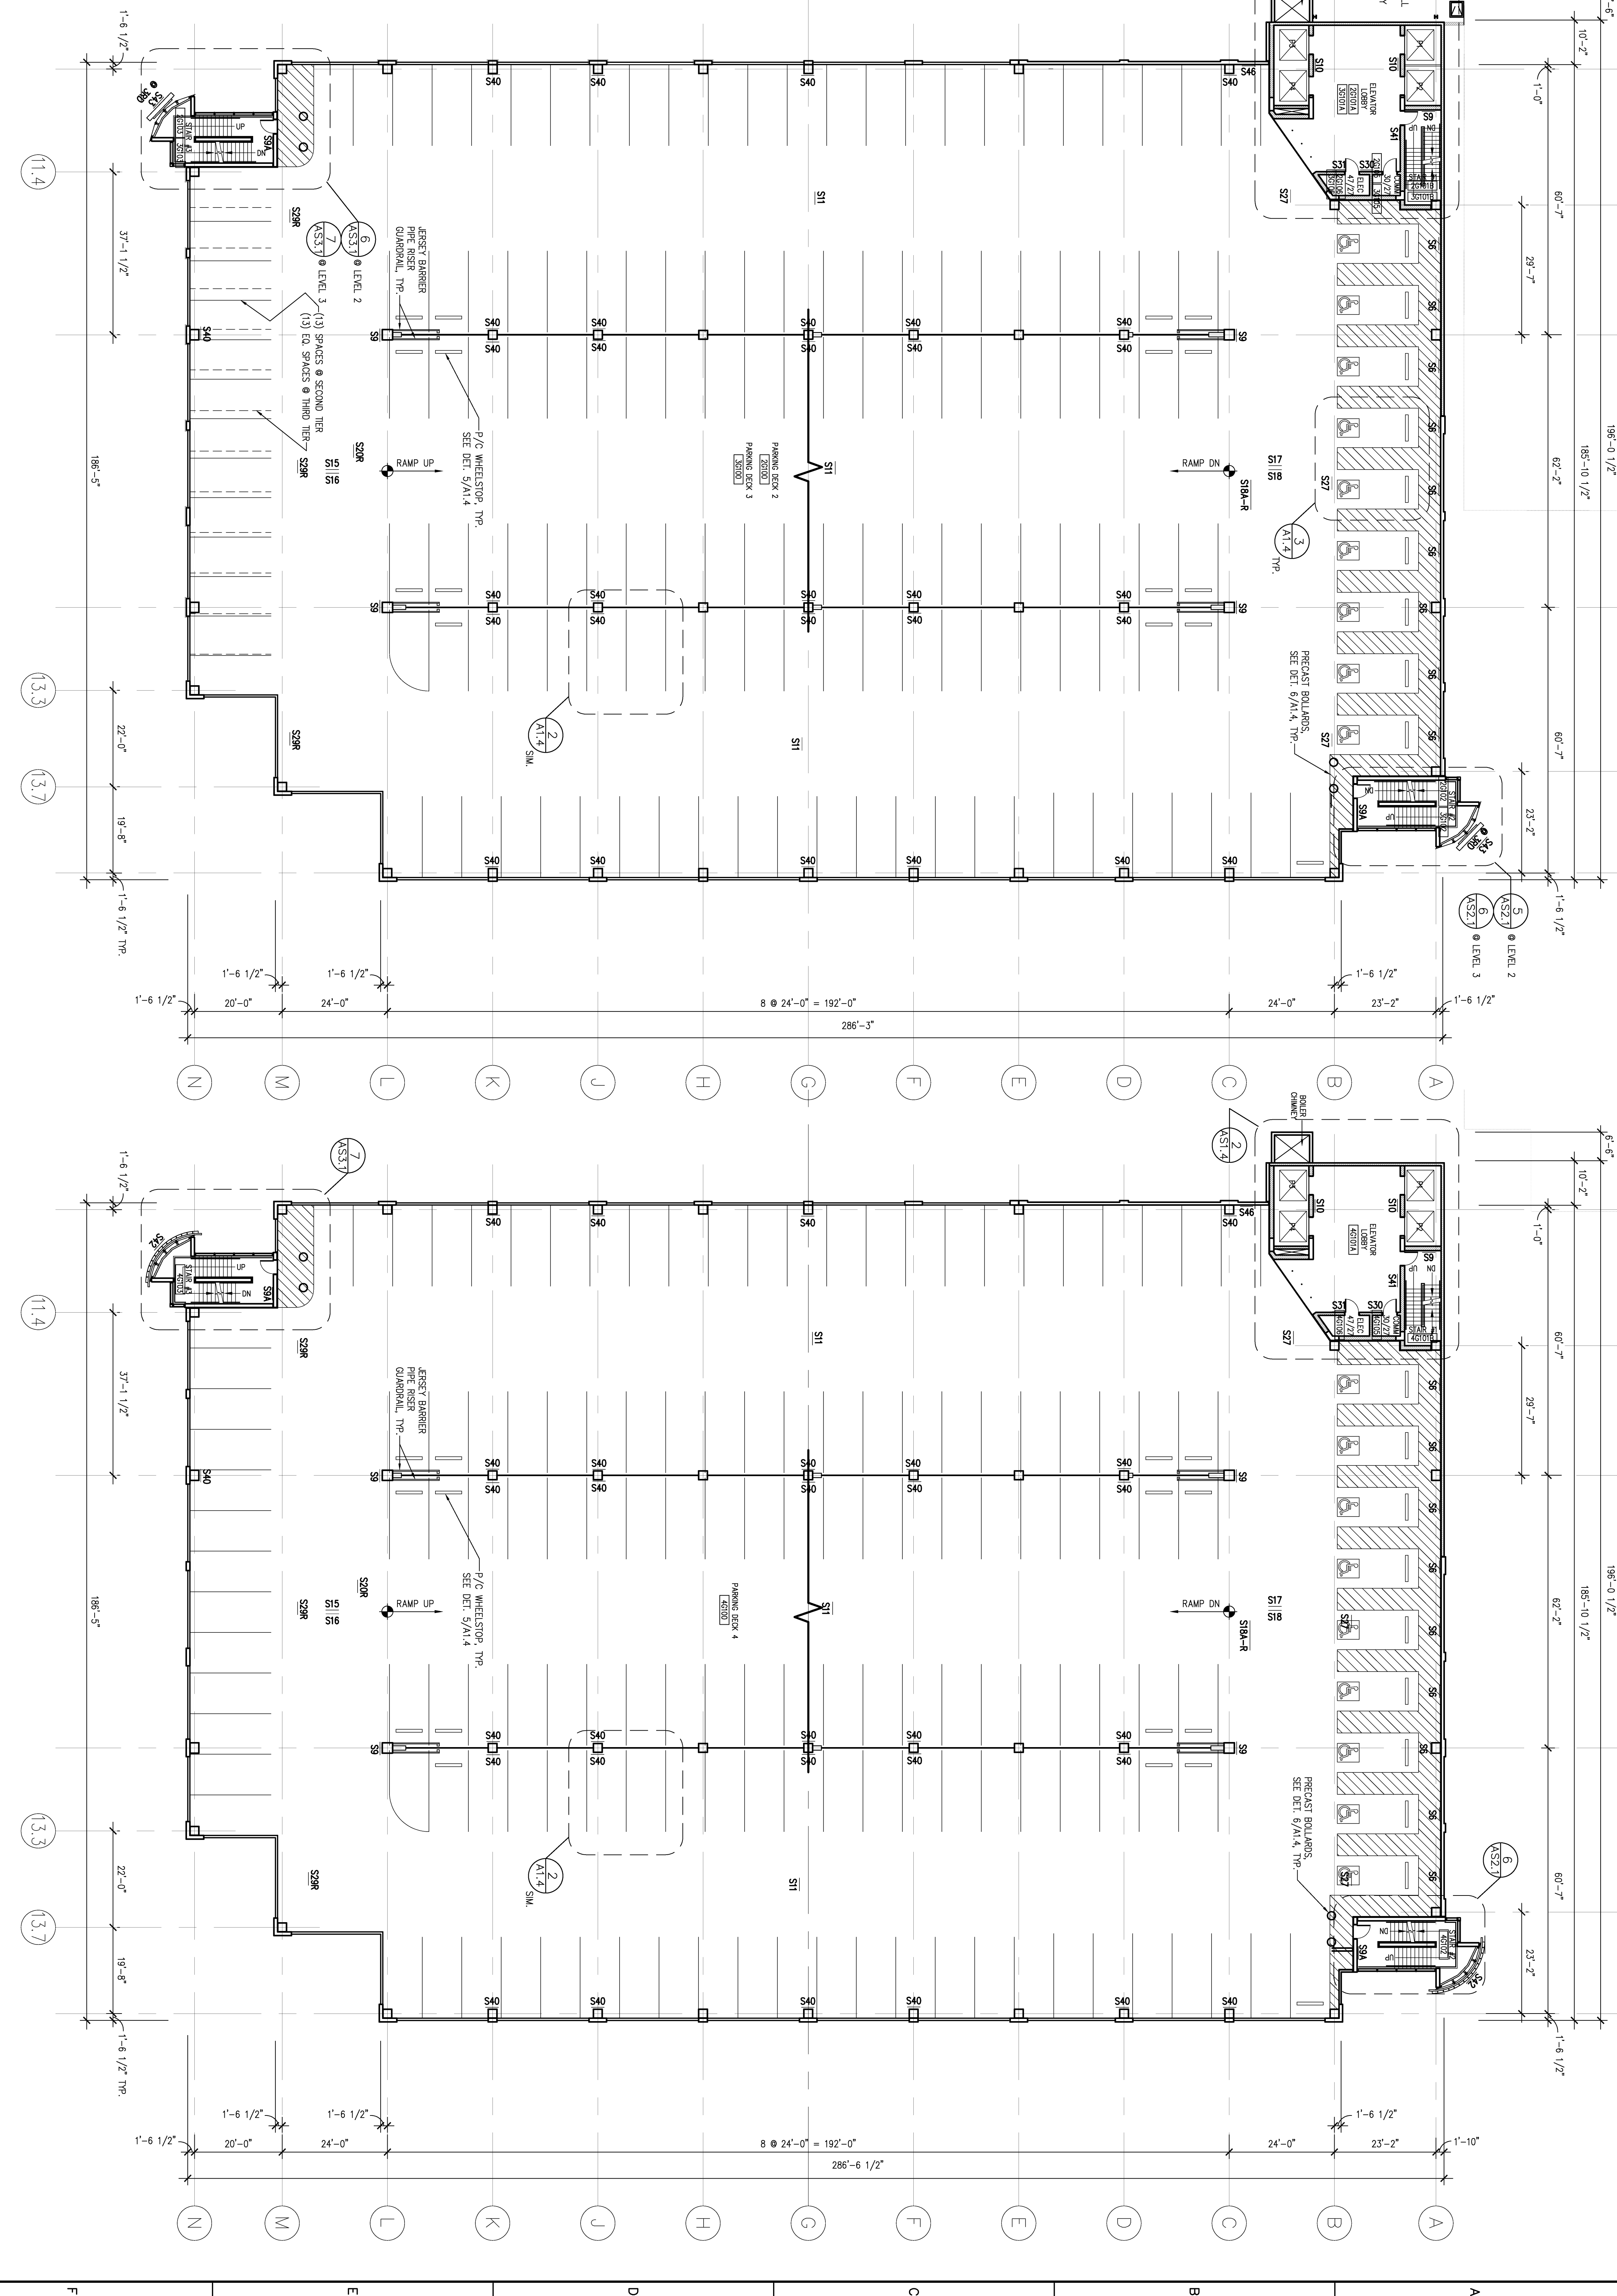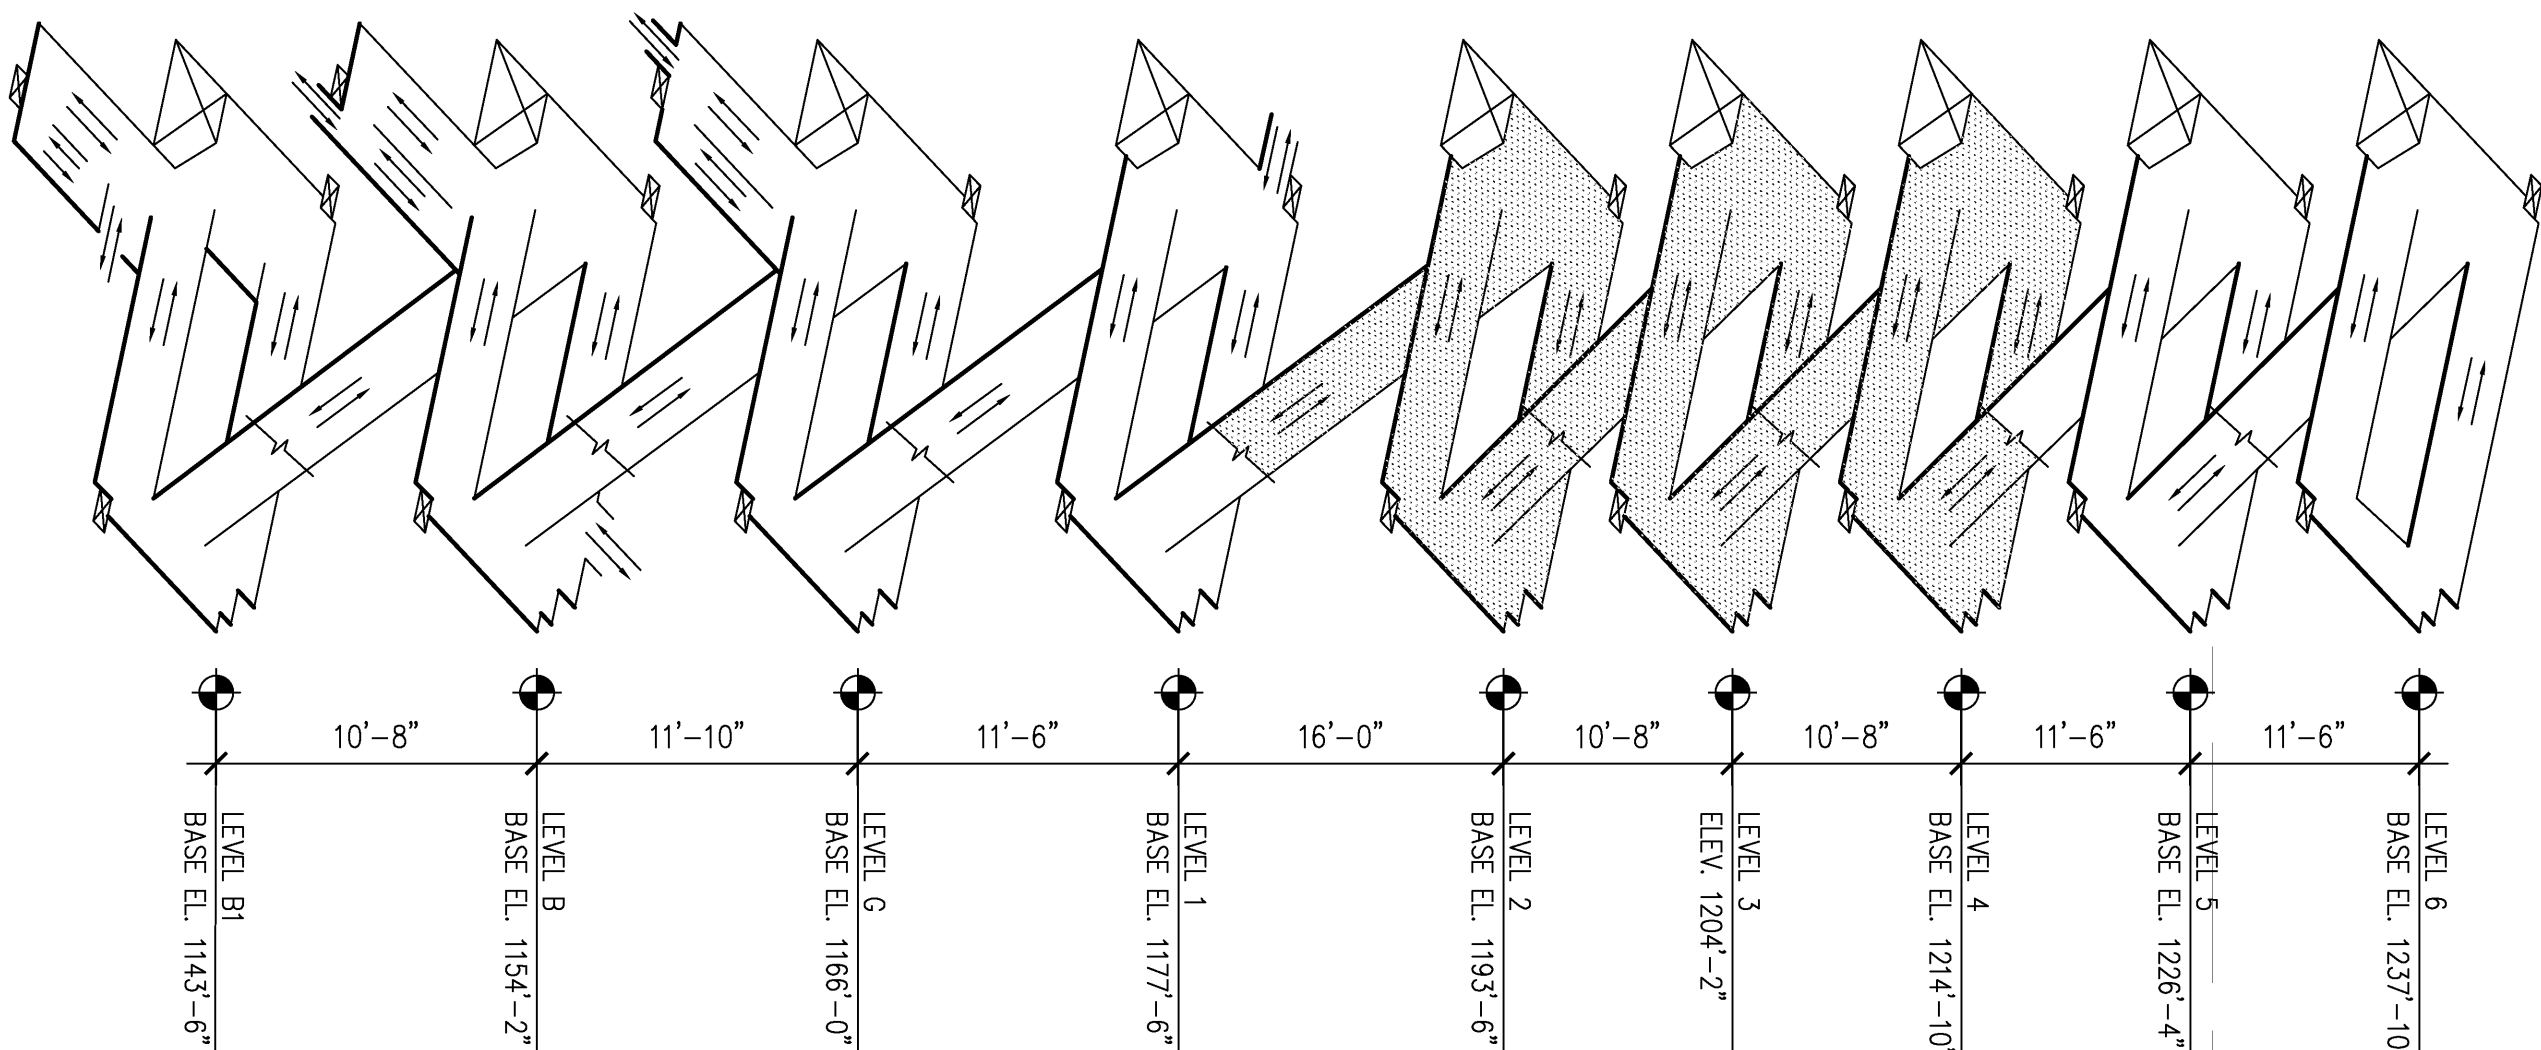

1 LEVEL 2 & 3 ARCHITECTURAL PLAN
A1.5 SCALE: 1/16" = 1'-0"

2 LEVEL 4 ARCHITECTURAL PLAN
A1.5 SCALE: 1/16" = 1'-0"

FINAL AS-BUILT SET

FINAL AS-BUILT DRAWINGS

DESIGN/BUILD CONTRACTOR:

ARCHITECT/ENGINEER:

MEP ENGINEER:

CIVIL/LANDSCAPE ENGINEER:

LEVELS 2 THRU 4
ARCHITECTURAL PLANS

Project Title
VA Pittsburgh Health Care
System - Parking Garage at
University Drive Division

Project Number
646CA2500 I

Office of
Facilities
Management

P.J. DICK
INCORPORATED

Tim Haahs
ENGINEERS-ARCHITECTS
Parking Planning and Design

TOWER ENGINEERING
116 Emporium Regatta Drive Suite 400
Pittsburgh, PA 15206
Phone: (412) 351-4888
Fax: (412) 358-2525

GATEWAY
On Call On Time On Target

Approved Project Director

Location
Pittsburgh, PA

Checked
NCA

Drawn
EKH

Dwg. No. of
A1.5

Department of
Veterans Affairs

Revisions:

Date

10/28/08

10/28/08

10/28/08

10/28/08

10/28/08

10/28/08


10/28/08

10/28/08


10/28/08

10/28/08


VA FORM GS-6231, OCT 1978

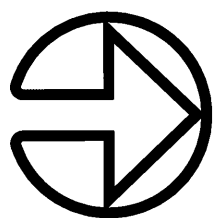

PLAN NORTH

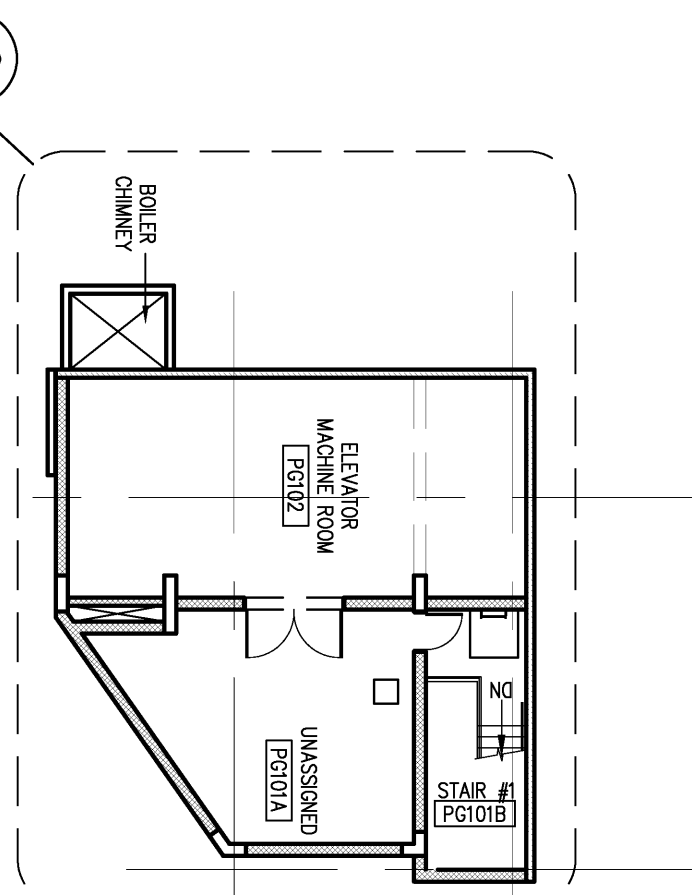

3 ELEVATOR MACHINE RM. PLAN
A1.6 SCALE: 1/16" = 1'-0"

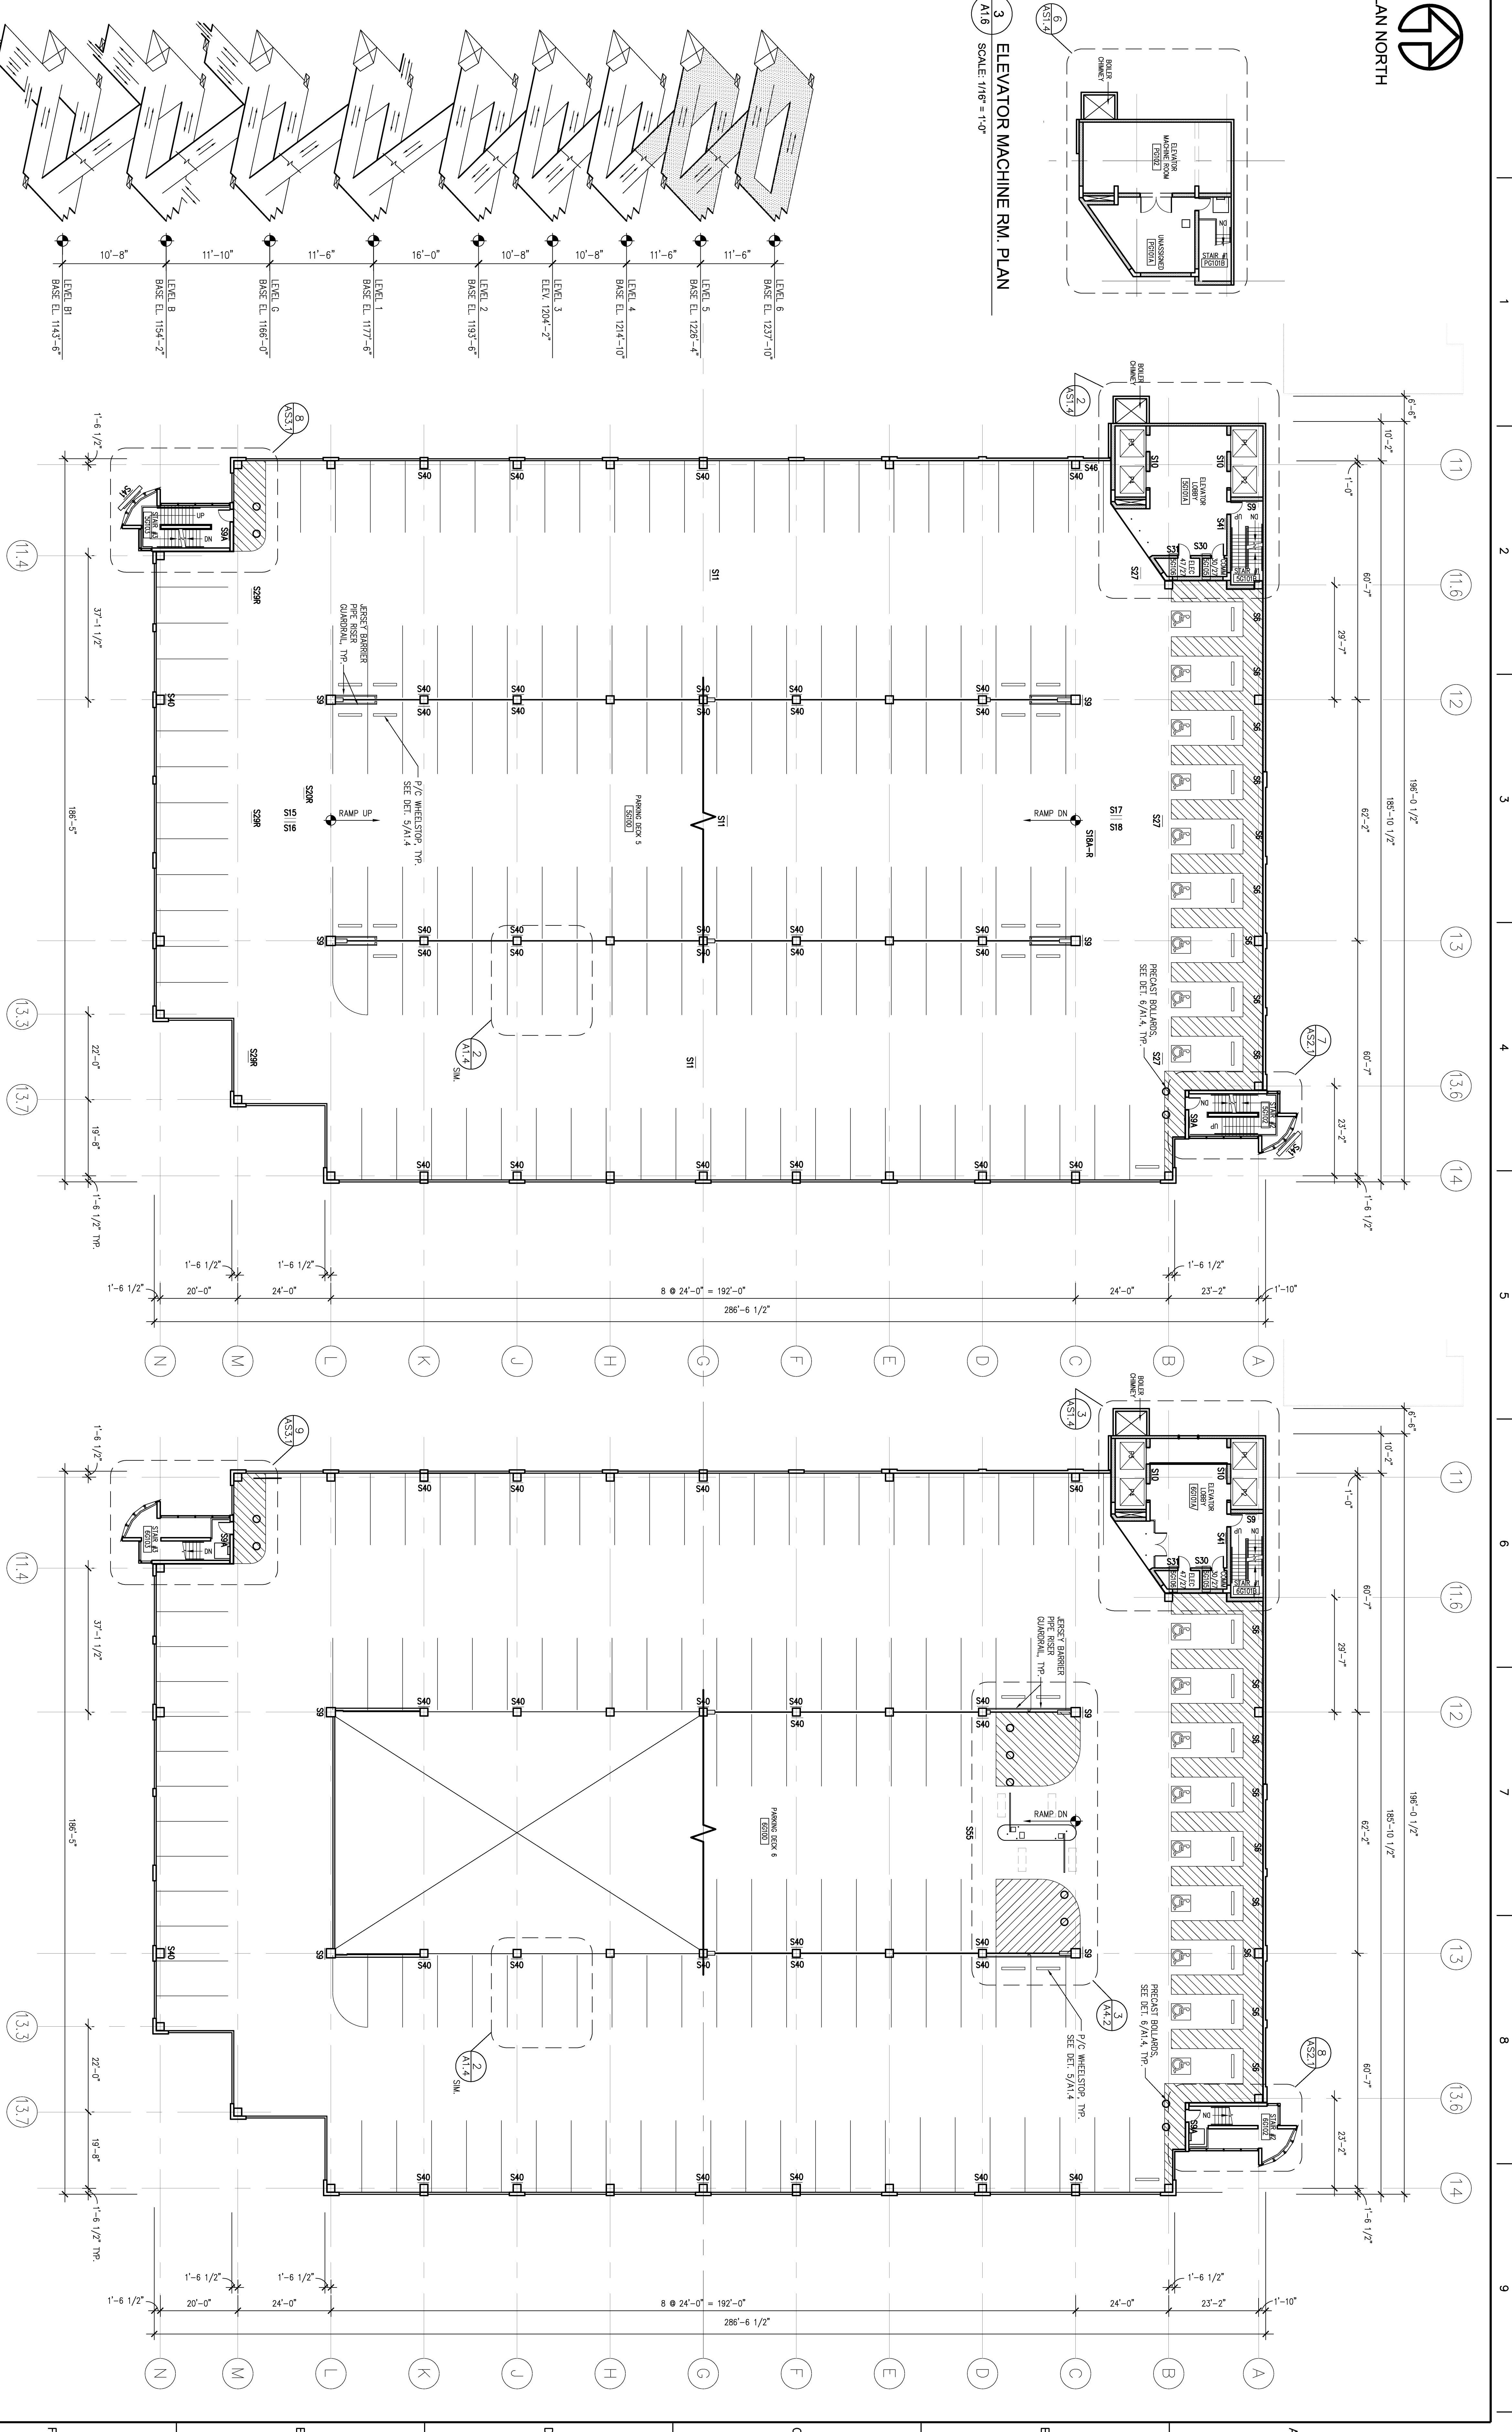

ISOMETRIC

SCALE: N.T.S.



FINAL AS-BUILT DRAWINGS

DESIGN/BUILD CONTRACTOR:

ARCHITECT/ENGINEER:

MEP ENGINEER:

CIVIL/LANDSCAPE ENGINEER:



LEVEL 6 ARCHITECTURAL PLAN

SCALE: 1/16" = 1'-0"


LEVELS 5 & 6 ARCHITECTURAL PLANS

SEE AS2.1 FOR STAIR #2 ROOF PLAN
& AS3.1 FOR STAIR #3 ROOF PLAN

FINAL AS-BUILT SET

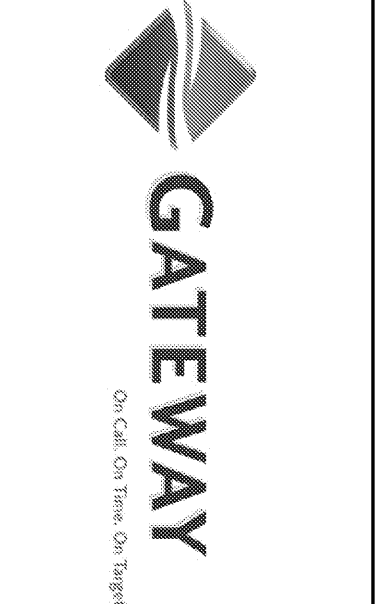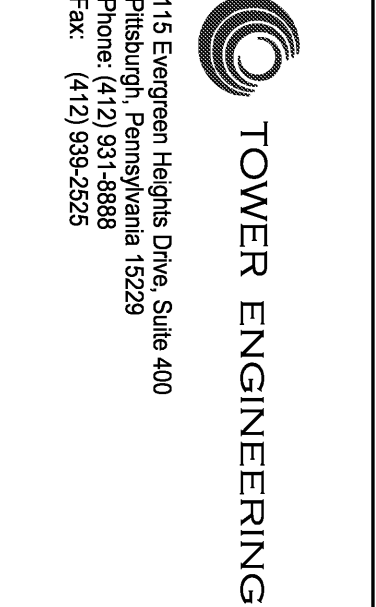

Approved Project Director		Project Title		Project Number	
Drawing Title		VA Pittsburgh Health Care System - Parking Garage at University Drive Division		646CAZ200 I	
Location		Pittsburgh, PA		Building Number	
Date		10/31/06		Drawing Number	
Checked		NCA		A1.6	
Drawn		EKH		Dwg. -- of --	
Office of Facilities Management		Department of Veterans Affairs			

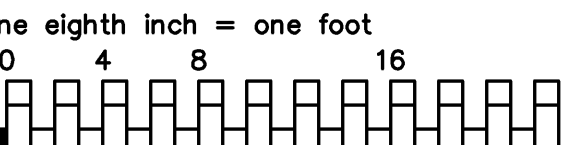

VA FORM GS-6231, OCT 1978