



D	REFLECTED CEILING PLAN
A2	1/4" = 1' - 0"

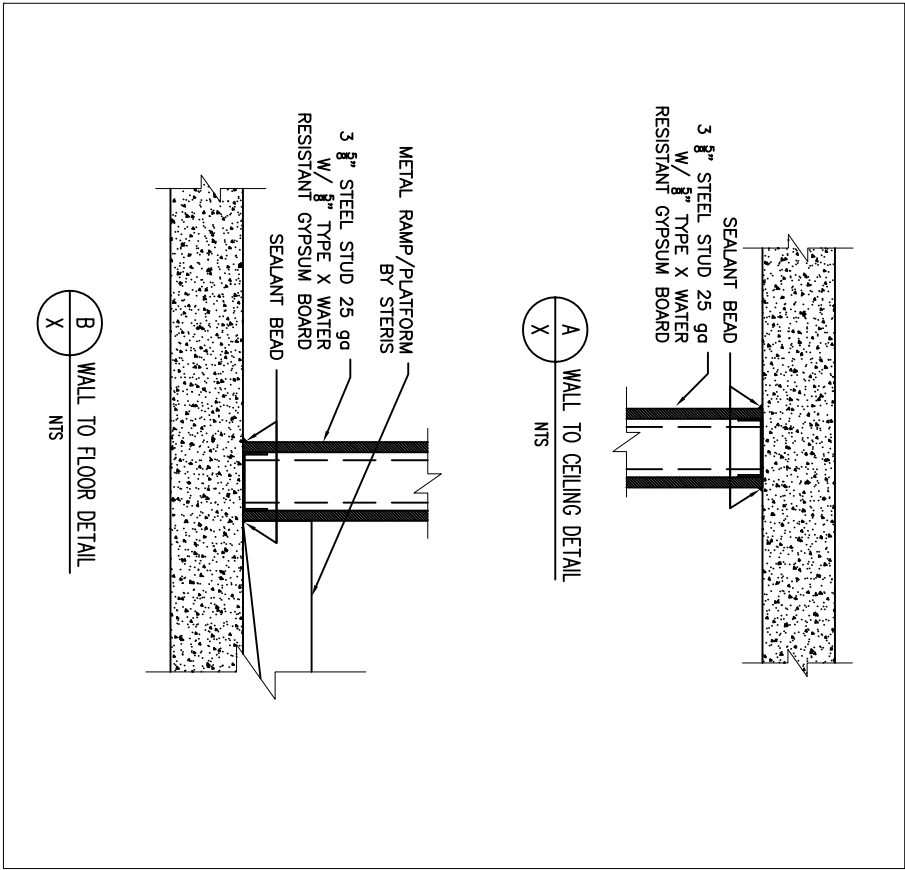

Drawing Title FLOOR/CEILING	Project Title CART WASHER REPLACEMENT			Project Number XXXX	Office of Construction and Facilities Management
				Building Number XXXX	
Approved: Project Director SYLVIE RUPP - CFM DIRECTOR FACILITIES/ENGINEERING PHONE: 307-779-7550 X.7267 FAX: 307-287-9725	Location CHEYENNE VA MEDICAL CENTER			Drawing Number	
	Date 2/9/2017	Checked XX	Drawn	Dwg. X of X	

[illegible]