


DEPARTMENT OF VETERANS AFFAIRS

580-17-123 RENOVATE BLOOD LAB

Michael E. DeBakey VA Medical Center
2002 HOLCOMBE BLVD, HOUSTON, TEXAS 77030

Site Location

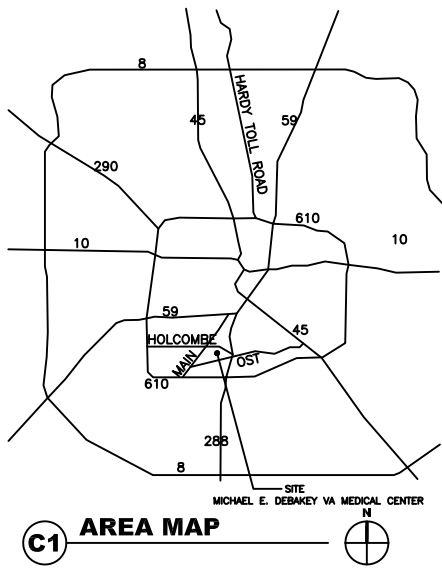

Project Data

General Project Notes

Deduct Alternate #1

Applicable Codes and Standards

Sheet Index

GENERAL	
G001	COVER SHEET
AD101	DEMOLITION FLOOR PLAN
AS101	FLOOR PLAN
AS201	REFLECTED CEILING PLAN
AS601	DETAILS
E101	FLOOR PLAN POWER/LIGHTING

Project Symbols

NOT ALL SYMBOLS ARE USED IN THIS SET

	CENTER LINE		DRAWING BLOCK TITLE, TYPICAL		FURNITURE, FIXTURE, & EQUIPMENT INDICATOR
	ELEVATION INDICATOR		BREAK, ROUND (USER DEFINES SIZE)		GRAPHIC SCALE, 1/8"=1'-0"
	CENTER LINE INDICATOR		BREAK, STRAIGHT (SEE SECTION INDICATORS, BUILDING, WITH BREAK STANDARDS)		ROOM NAME AND NUMBER
	PROJECT LIMIT LINE		DETAIL INDICATOR		COLUMN GRID
	DEMOLITION LINE		DETAIL INDICATOR		KEYNOTE
	EXISTING TO REMAIN LINE		DETAIL INDICATOR FOR SMALL CONDITIONS		WALL OR PARTITION TYPE
	FEATURES ABOVE LINE INDICATOR		DIMENSION LINE		FIRE EXTINGUISHER CABINET
	FIRE RESISTIVE RATED LINE, 1 HOUR		DOOR OPENING/BORROWED LIGHT IDENTIFIER		CORNER GUARD
	FIRE RESISTIVE RATED LINE, 2 HOUR		ELEVATION INDICATOR, EXTERIOR		TRUE/PLAN NORTH ARROW
	FIRE RESISTIVE RATED LINE, 3 HOUR		ELEVATION INDICATOR, INTERIOR, MULTIPLE VIEW		
	FIRE RESISTIVE RATED LINE, 4 HOUR		ELEVATION INDICATOR, INTERIOR, SINGLE VIEW		
	FIRE-RATED, SMOKE BARRIER LINE, 1 HOUR		BUILDING SECTION INDICATOR		
	FIRE-RATED, SMOKE BARRIER LINE, 2 HOUR		ENLARGED PLAN INDICATOR		
	FIRE-RATED, SMOKE BARRIER LINE, 3 HOUR				
	FIRE-RATED, SMOKE BARRIER LINE, 4 HOUR				
	HIDDEN FEATURES LINE				
	NEW LINE				
	PROPERTY LINE				

Materials Legend

	CONCRETE
	EARTH
	BASE COURSE
	EXISTING CONSTRUCTION TO REMAIN
	EXISTING CONSTRUCTION TO BE REMOVED
	NEW CONSTRUCTION
	RIGID INSULATION
	BATT INSULATION

CONSULTANTS:

ARCHITECT/ENGINEERS:

Drawing Title

COVER SHEET

Approved Project Director

Project Title

BLOOD LAB RENOVATION

Location

MEDVAMC

Date

5/1/2007

Checked

Drawn

Project Number

580-17-123

Building Number

Drawing Number

GI-001

Drawn by

Office of
Construction
and Facilities
Management




KEY NOTES

- 1
- NEW LOCATION FOR ENTRY DOOR REMOVED DURING THE DEMOLITION. REUSE EXISTING HARDWARE. RELOCATE EXISTING EXIT LIGHT
- 2
- NEW CHAIR RAIL AS SPECIFIED
- 3
- NEW CORNER GUARD AS SPECIFIED AT ALL OUTSIDE CORNERS.
- 4
- NEW WALL MOUNTED TOILET W/ADA GRAB BARS AS SPECIFIED.
- 5
- NEW WALL MOUNTED LAV. AS SPECIFIED.
- 6
- NEW SPECIMEN PASSTHRU AS SPECIFIED.
- 7
- RE-LAMINATE EXISTING DOOR COMPLETE. REINSTALL USING EXISTING HARDWARE. ADJUST DOOR FOR PROPER OPERATION.
- 8
- INSTALL NEW DIAPER CHANGING STATION. PROVIDE WOOD BACKING AS REQUIRED.
- 9
- PROVIDE BACKING AND ALL ROUGH-IN REQUIRED FOR TV AND QMATIC SYSTEM. COORDINATE WITH COR.
- 10
- INSTALL NEW TILE FLOORING AS SPECIFIED.
- 11
- INSTALL NEW TILE WALLS OVER CEMENT BOARD FULL HT. AS SPECIFIED.
- 12
- INSTALL NEW 2X2 CEILING AS SPECIFIED.
- 13
- PATCH AND REPAIR ALL WALLS. WALL PAPER TO REMAIN WHERE POSSIBLE. PRIME AND 2 COATS PAINT. COLOR TBD.
- 14
- NURSE CALL PER S.O.W.

GENERAL NOTES

- 1
- PROJECT TO BE COMPLETED IN PHASES AS INDICATED. ALL WORK WILL BE DONE AFTER NORMAL BUSINESS HOURS AND ON WEEKENDS. AT THE END OF EACH WORK TIME, THE AREA SHALL BE CLEANED AND READY FOR USE BY THE CLINIC. THE CLINIC WILL REMAIN OPERATIONAL DURING THE RENOVATION.
- 2
- PROVIDE CONSTRUCTION BARRIERS AS REQUIRED TO CONTAIN DUST.
- 3
- ONE BATHROOM WILL BE COMPLETE BEFORE STARTING THE NEXT.

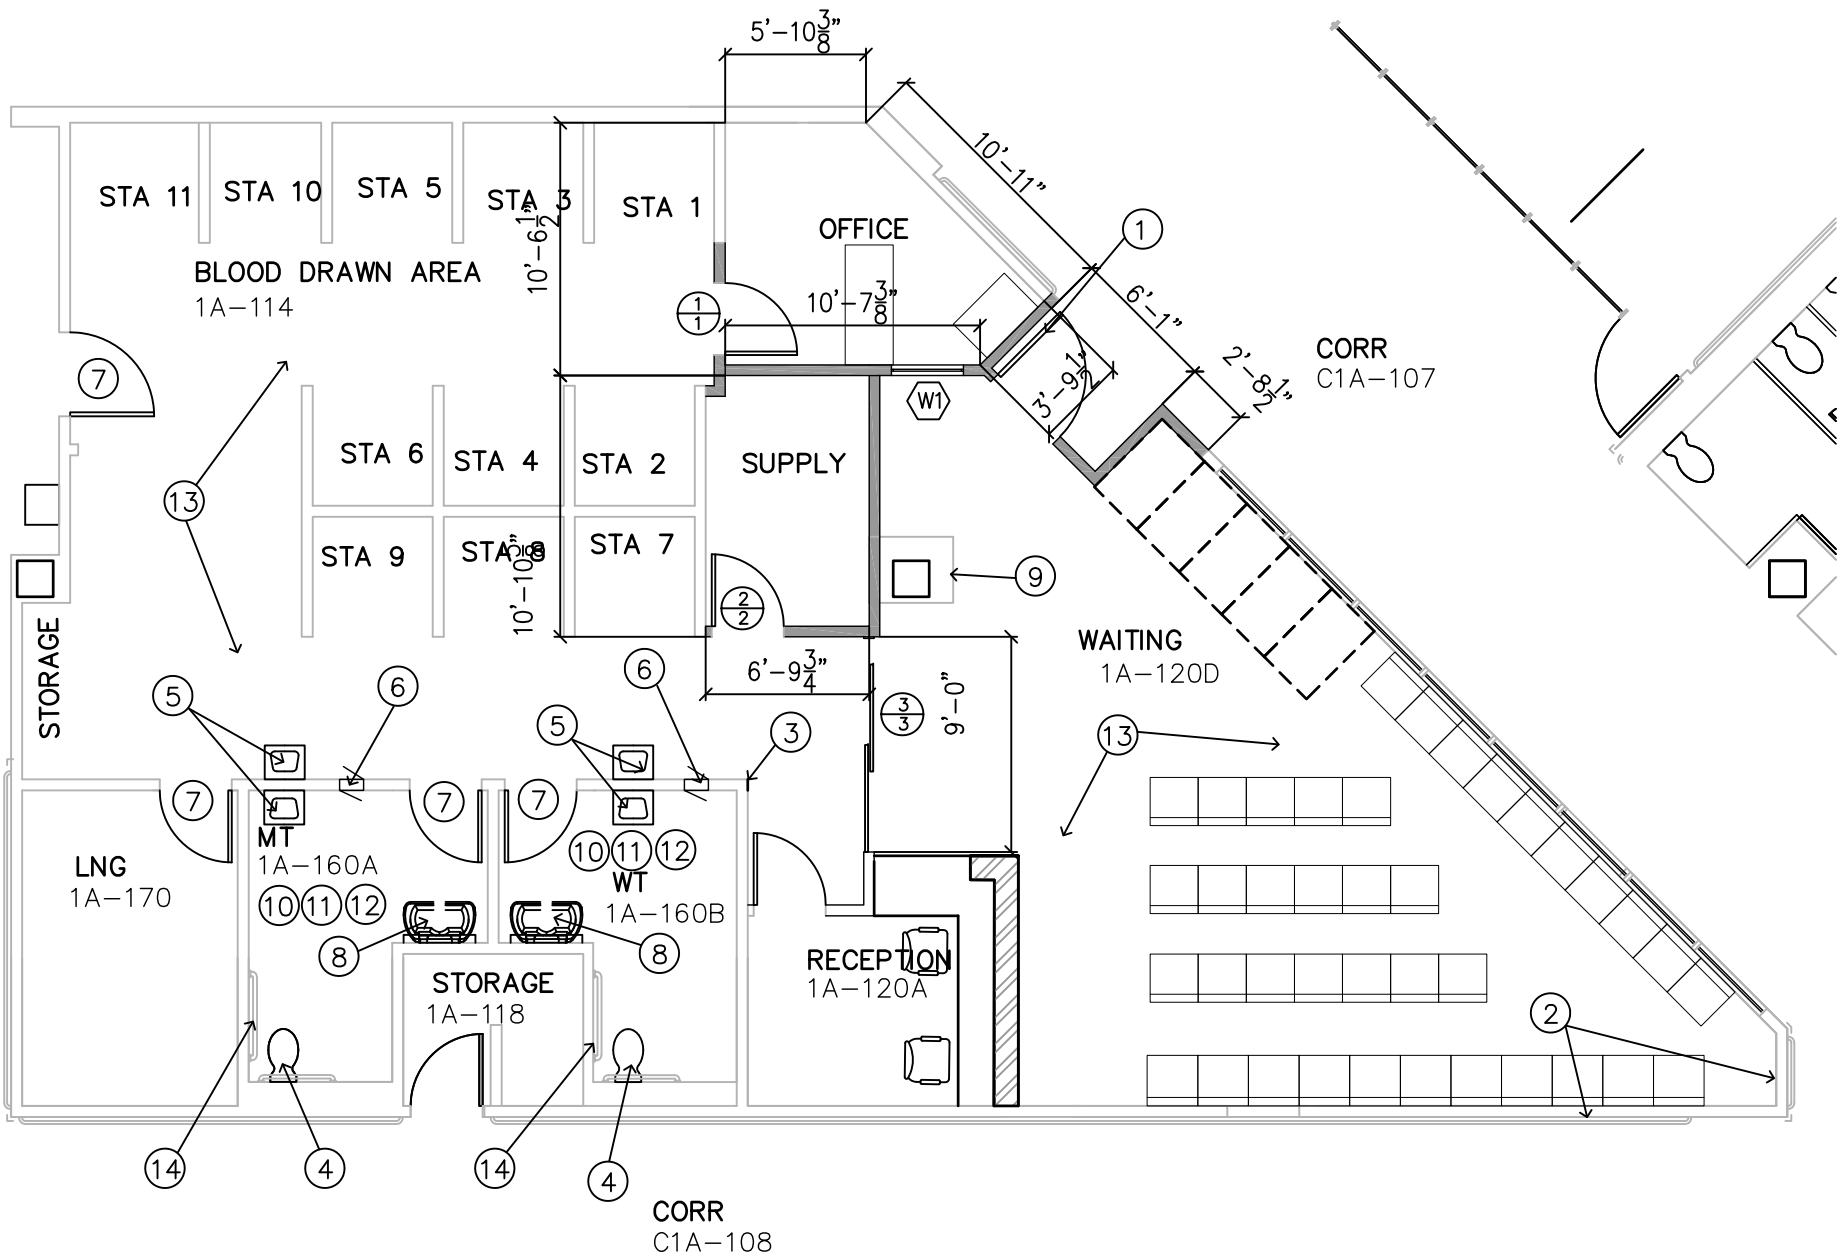

1 FLOOR PLAN-NEW
SCALE:1/8"=1'-0"

LEGEND

- EXISTING WALL
- NEW WALL
- 3/3

DOOR TAG
- W1

WINDOW TAG

PHASING

- PHASE 1 – RELOCATE PATIENT ENTRY AND BUILD OFFICE
- PHASE 2 – BUILD SUPPLY AND NEW ENTRY TO BLOOD DRAW AREA.
- PHASE 3 – MODIFY EXISTING TOILETS.

ALL WORK SHALL BE DONE AT NIGHT AND WEEKENDS ALLOWING THE BLOOD LAB TO STAY OPERATIONAL DURING THE DAY

CONSULTANTS:

ARCHITECT/ENGINEERS:

Drawing Title

FLOOR PLAN

Approved Project Director

Project Title

BLOOD LAB RENOVATION

Location

Date

5/1/2007

Checked

Drawn

Project Number

Building Number

Drawing Number

AS-101

Drawn of

Office of
Construction
and Facilities
Management


Department of
Veterans Affairs

KEY NOTES

- 1 INSTALL NEW 2X2 CEILING AND GRID. TILE TO MATCH EXISTING.
- 2 INSTALL NEW CEILING TO MATCH EXISTING IN THE CORRIDOR
- 3 NEW 24X24 HVAC SUPPLY. PROVIDE 110 CFM SUPPLY – BALANCE ROOM
- 4 NEW RETURN GRILL AND DUCT. CONNECT TO EXISTING RETURN SYSTEM
- 5 NEW 24X24 EXHAUST. CONNECT TO EXISTING EXHAUST DUCT AND BALANCE PER VA STANDARD FOR SUPPLY ROOMS
- 6 INSTALL NEW 24X48 CEILING AND GRID. TILE TO MATCH EXISTING.
- 7 INSTALL NEW 2X2 CEILING AND GRID. TILE (MOISTURE RESISTANT) TO MATCH EXISTING.
- 8 INSTALL NEW EXHAUST DIFFUSER AND BALANCE ROOM
- 9 REPAIR EXISTING CEILING TO MATCH IS AREAS OF NEW CONSTRUCTION

GENERAL NOTES

- 1 PROJECT TO BE COMPLETED IN PHASES AS INDICATED. ALL WORK WILL BE DONE AFTER NORMAL BUSINESS HOURS AND ON WEEKENDS. AT THE END OF EACH WORK TIME, THE AREA SHALL BE CLEANED AND READY FOR USE BY THE CLINIC. THE CLINIC WILL REMAIN OPERATIONAL DURING THE RENOVATION.
- 2 PROVIDE CONSTRUCTION BARRIERS AS REQUIRED TO CONTAIN DUST.
- 3 ONE BATHROOM WILL BE COMPLETE BEFORE STARTING THE NEXT.

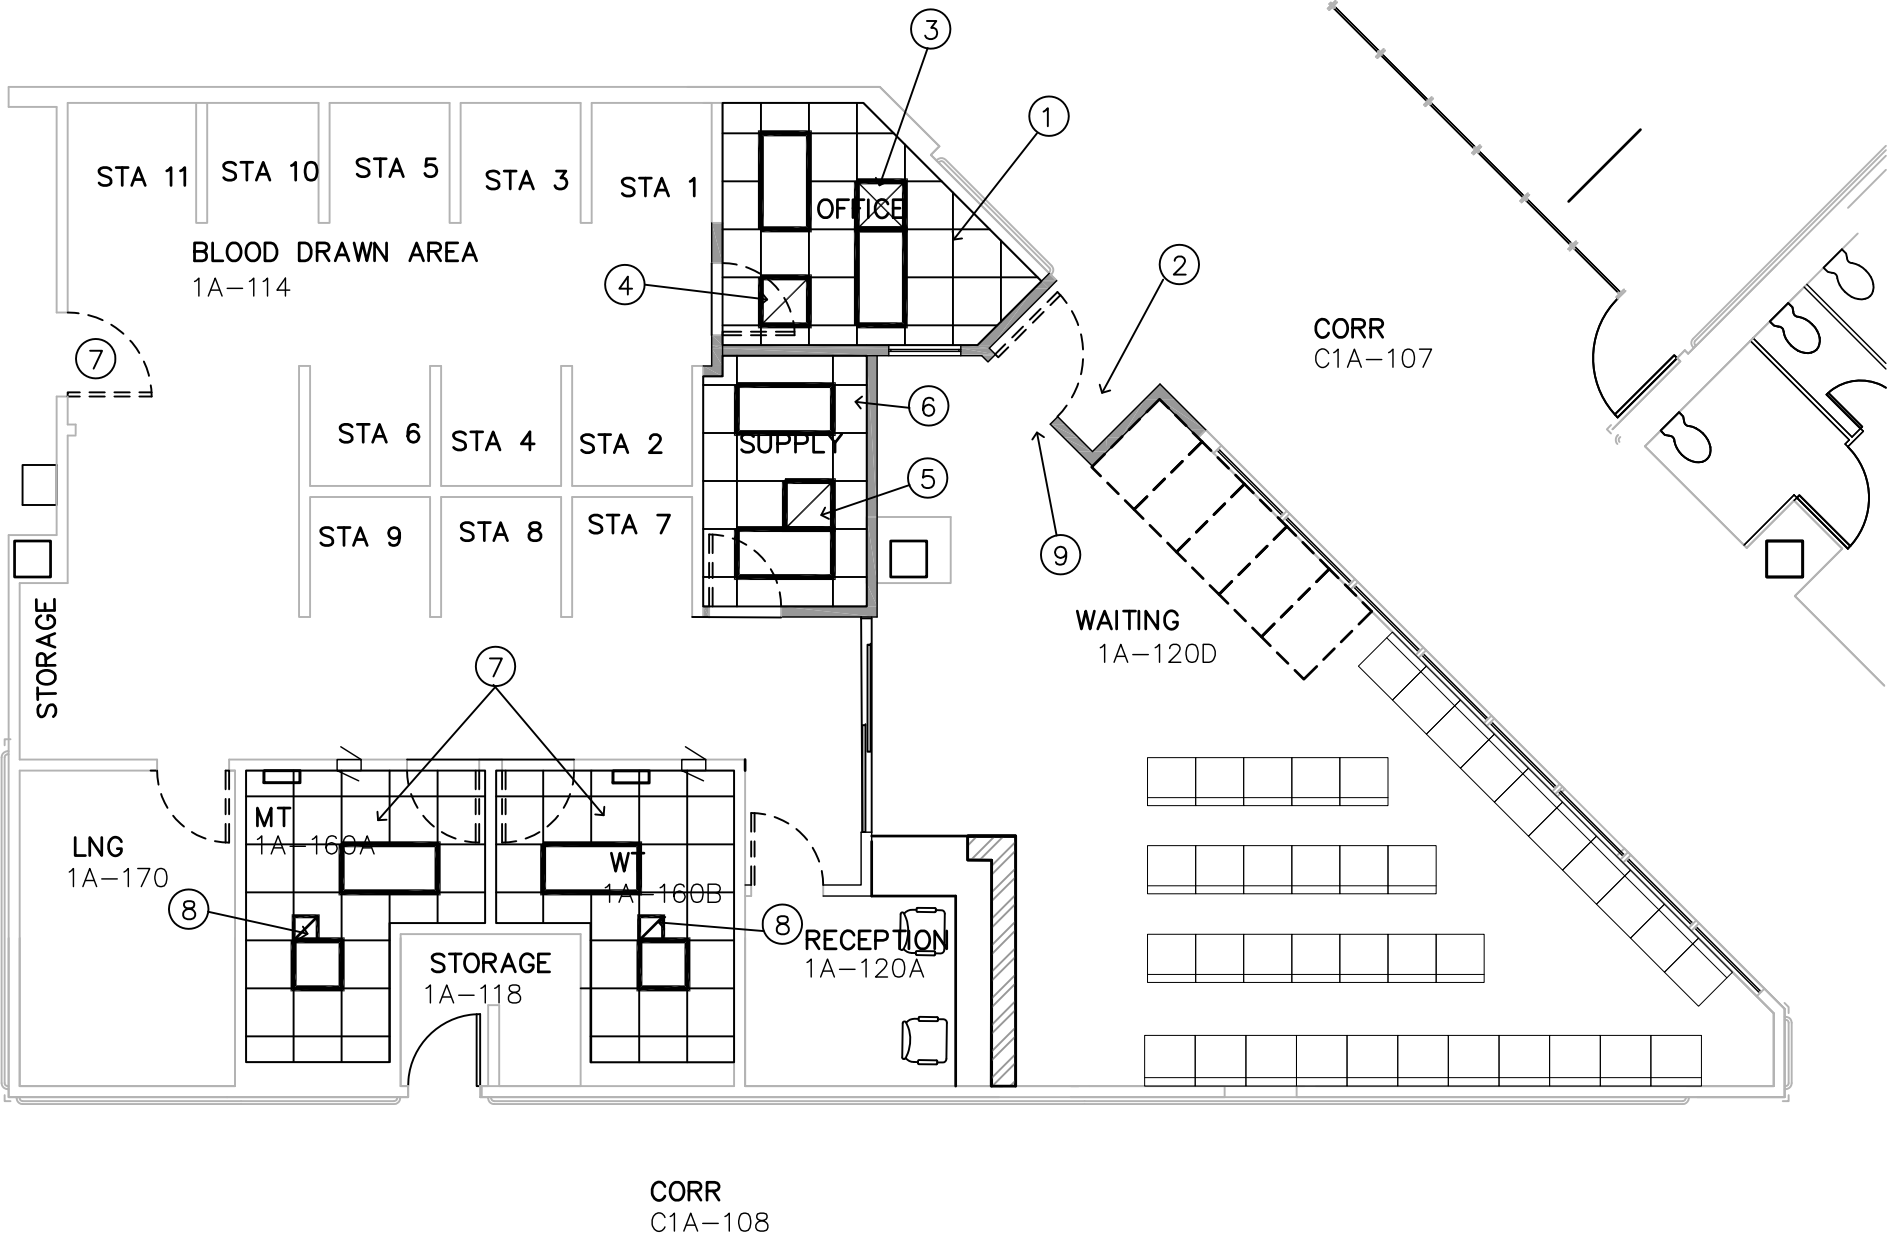

1 REFLECTED CEILING PLAN
SCALE: 1/8"=1'-0"

LEGEND

- EX EXISTING LIGHT - REUSED
- A1 NEW 24X48 LED FIXTURE
- A2 NEW 24X24 LED FIXTURE
- A3 NEW WALL MOUNTED LED FIXTURE


PHASING

- PHASE 1 – RELOCATE PATIENT ENTRY AND BUILD OFFICE
- PHASE 2 – BUILD SUPPLY AND NEW ENTRY TO BLOOD DRAW AREA.
- PHASE 3 – MODIFY EXISTING TOILETS.

ALL WORK SHALL BE DONE AT NIGHT AND WEEKENDS ALLOWING THE BLOOD LAB TO STAY OPERATIONAL DURING THE DAY

CONSULTANTS:

ARCHITECT/ENGINEERS:


Drawing Title REFLECTED CEILING PLAN	Project Title BLOOD LAB RENOVATION	Project Number --	Office of Construction and Facilities Management 
Approved Project Director	Location --	Building Number 100	
Date 5/1/2007	Checked	Drawn	
		Dwg. of --	

KEY NOTES

- 1 NEW HOSPITAL GRADE OUTLET. CONNECT TO EXISTING CIRCUIT FROM RECEPTION DESK. MINIMUM CONDUIT SIZE 3/4"
- 2 NEW MOTION SENSOR LIGHTING CONTROL
- 3 PROVIDE POWER FOR NEW SLIDING DOOR. LOCATE CONTROLS ON EACH SIDE AS INDICATED. COORDINATE FINAL LOCATION WITH COR.
- 4 PROVIDE ROUGH-IN FOR PHONE AND DATA. CABLE AND INSTALLATION BY VA
- 5 NEW 18" LONG LED DECORATIVE WALL FIXTURE LOCATED ABOVE MIRROR
- 6 NEW 24X48 LED FIXTURE IN NEW CEILING
- 7 NEW 24X24 LED FIXTURE IN NEW CEILING
- 8 INSTALL FIXTURES REMOVED DURING DEMOLOTION

GENERAL NOTES

- 1 PROJECT TO BE COMPLETED IN PHASES AS INDICATED. ALL WORK WILL BE DONE AFTER NORMAL BUSINESS HOURS AND ON WEEKENDS. AT THE END OF EACH WORK TIME, THE AREA SHALL BE CLEANED AND READY FOR USE BY THE CLINIC. THE CLINIC WILL REMAIN OPERATIONAL DURING THE RENOVATION.
- 2 PROVIDE CONSTRUCTION BARRIERS AS REQUIRED TO CONTAIN DUST.
- 3 ONE BATHROOM WILL BE COMPLETE BEFORE STARTING THE NEXT.

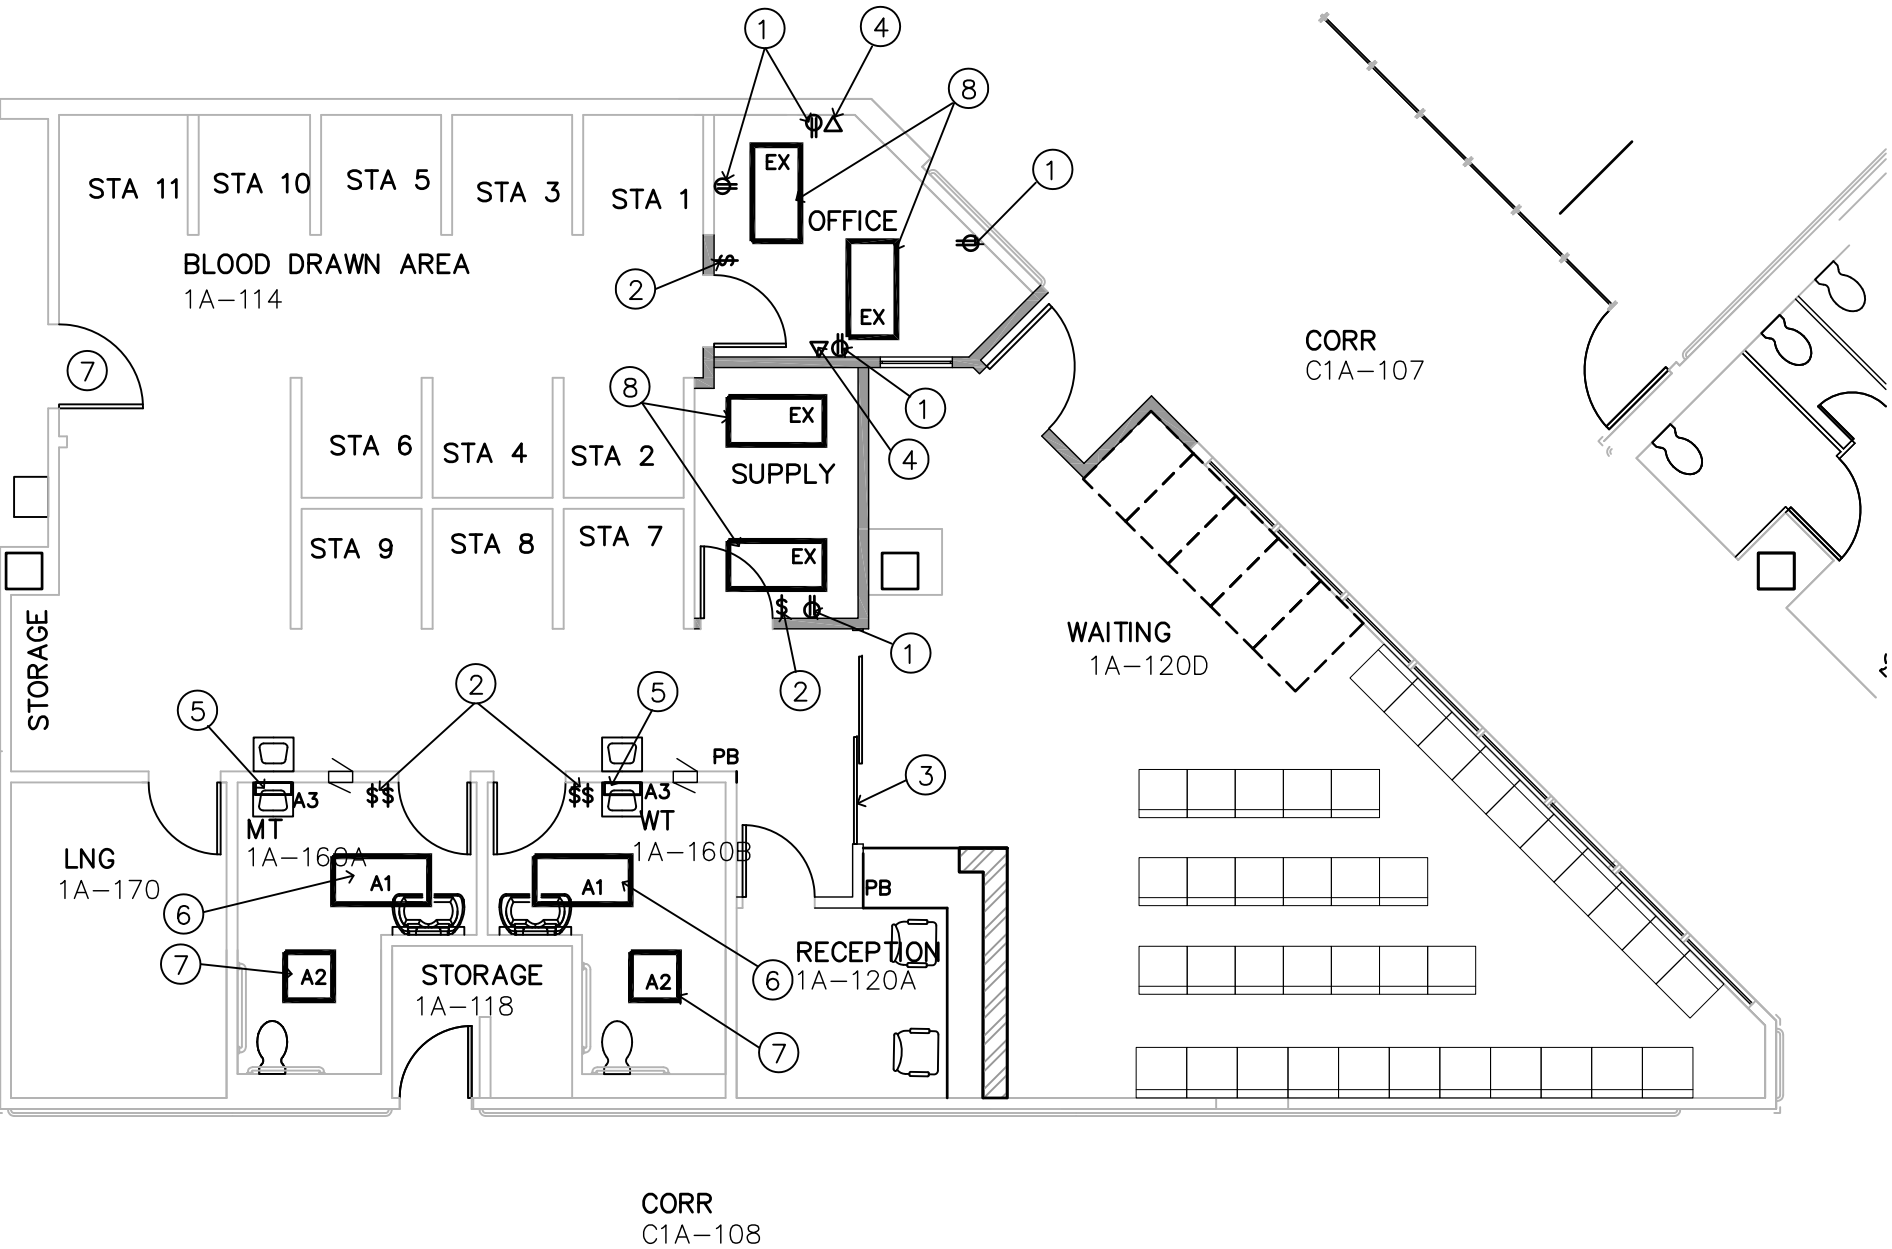

1 FLOOR PLAN-POWER/LIGHTING
SCALE:1/8"=1'-0"

LEGEND

- EX EXISTING LIGHT - REUSED
- A1 NEW 24X48 LED FIXTURE
- A2 NEW 24X24 LED FIXTURE
- A3 NEW WALL MOUNTED LED FIXTURE


PHASING

- PHASE 1 – RELOCATE PATIENT ENTRY AND BUILD OFFICE
- PHASE 2 – BUILD SUPPLY AND NEW ENTRY TO BLOOD DRAW AREA.
- PHASE 3 – MODIFY EXISTING TOILETS.

ALL WORK SHALL BE DONE AT NIGHT AND WEEKENDS ALLOWING THE BLOOD LAB TO STAY OPERATIONAL DURING THE DAY

CONSULTANTS:

ARCHITECT/ENGINEERS:

Drawing Title POWER/LIGHTING	Project Title BLOOD LAB RENOVATION	Project Number --	Office of Construction and Facilities Management 
Approved Project Director	Location --	Building Number 100	
Date 5/1/2007	Checked	Drawn	
		Drawing Number E-101	
		Doc. of --	