


three inches = one foot
one and one half inches = one foot
one inch = one foot
three quarters inch = one foot
one half inch = one foot
three eighths inch = one foot
one quarter inch = one foot
one eighth inch = one foot

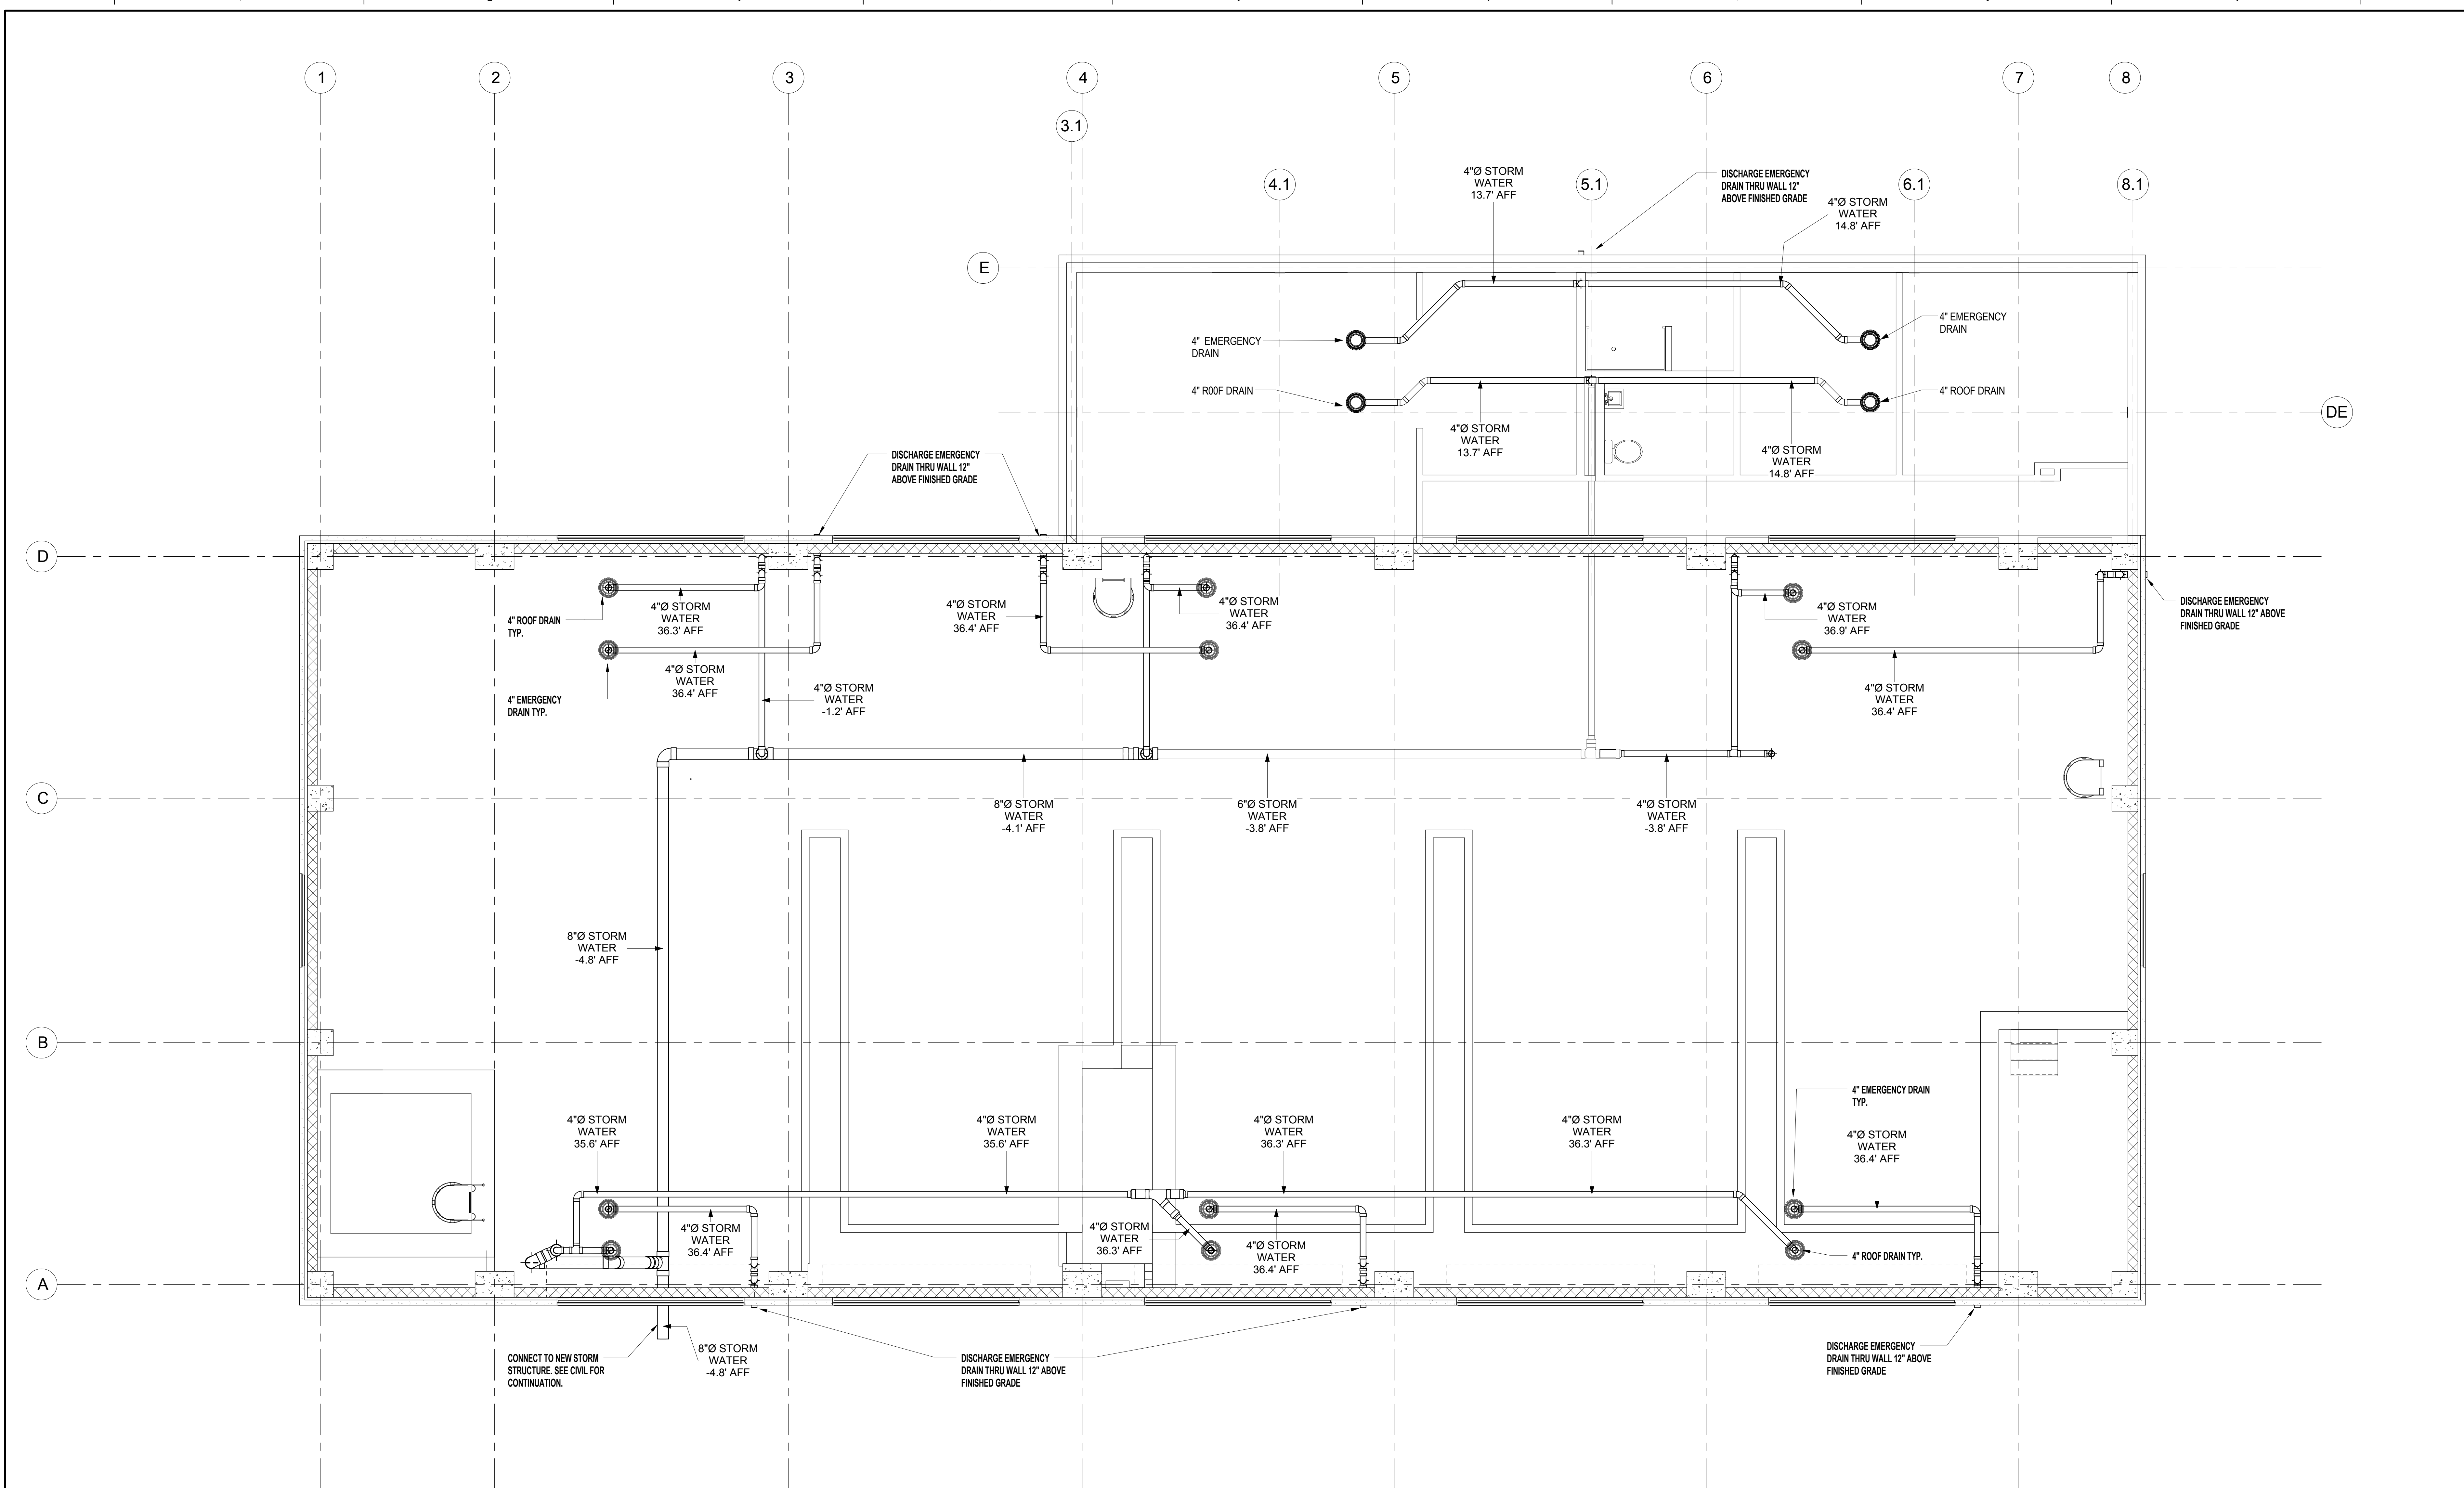

PLUMBING NEW ROOF PLAN
1/4" = 1'-0"

FINAL DESIGN
APPROVED FOR CONSTRUCTION

CONSULTANTS: AEI Affiliated Engineers Affiliated Engineers SE, Inc. Trioga Town Center 12921 SW 1st Road Site 205 Gainesville, Florida 32669 Tel 352.376.5500 Fax 352.375.3479 CA-6140		ENGINEER-OF-RECORD STEPHEN T. STEFFE FL P.E. NO. 70349	ARCHITECT/ENGINEERS: AKEA INC. 3603 NW 98th Street, Suite B Gainesville, FL 32606 Phone: (352) 474-6124 Fax: (352) 553-4437 COA: FL #26693 AKEA Project No. 083-14	Drawing Title PLUMBING NEW ROOF PLAN	Project Title REPLACE BOILERS - FCA D, ENERGY AT THE MALCOM RANDALL VAMC	Project Number 573-14-600 Building Number	Office of Construction and Facilities Management
Approved: Project Director		Location GAINESVILLE, FLORIDA		Date JULY 8, 2016	Checked STS	Drawn CRR	Drawing Number PL203