

1 B401 SINGLE-LINE DIAGRAM
Scale: N.T.S.

[illegible]

CONSULTANTS:




Heapy Engineering

MEP Design Technology Planning Commissioning Energy

Nationally Recognized Leader in Sustainability

1400 W Dorothy Lane, Dayton, OH 45409-1310
 Ph 937-224-0861 Fax 937-224-5777 www.heapy.com
 Heapy Project No.: 2016-05088 Firm License No.: 01528

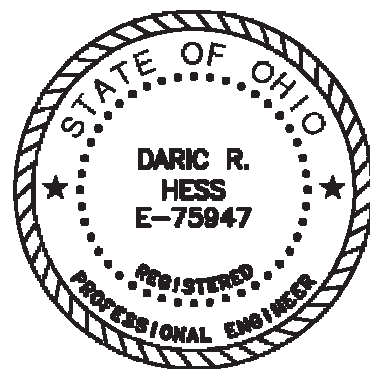

ARCHITECT/ENGINEERS:

JOHN POE ARCHITECTS



3131 NEWMARK DRIVE
SUITE 200
MIAMISBURG, OHIO
45342
937 461 3290 PHONE
937 461 0260 FAX
ipa@iohnpoe.com

Drawing Title

B401 SINGLE-LINE DIAGRAM

Approved: Project Director

Project Title

DEFICIENCIES

Location	Dayton, Ohio
----------	--------------

Date 07/06/2017

Checked
MSG

Drawn
JRS

Project No.	
VA Project No.	552-16-55
JPA Project No.	-

Building Number

Drawing Number

401E001

Dwg of


Office of
Construction
and Facilities
Management




three inches = one foot
one and one-half inches = one foot
one inch = one foot
three-quarters inch = one foot
one-half inch = one foot
three-eighths inch = one foot
one-quarter inch = one foot
one-eighth inch = one foot

GENERAL NOTES
A. SCHEDULE ANY OUTAGES WITH THE COR 4 WEEKS PRIOR TO PERFORMING WORK.
B. WORK PERFORMED IN BUILDING 401 SHALL BE PERFORMED OUTSIDE NORMAL WORKING HOURS.

NOTES
1. REPLACE EXISTING 125A/3P 208V SUB FEED BREAKER SERVING PANEL L3A WITH NEW 115A/3P 208V BREAKER. REFER TO SINGLE LINE DIAGRAM.

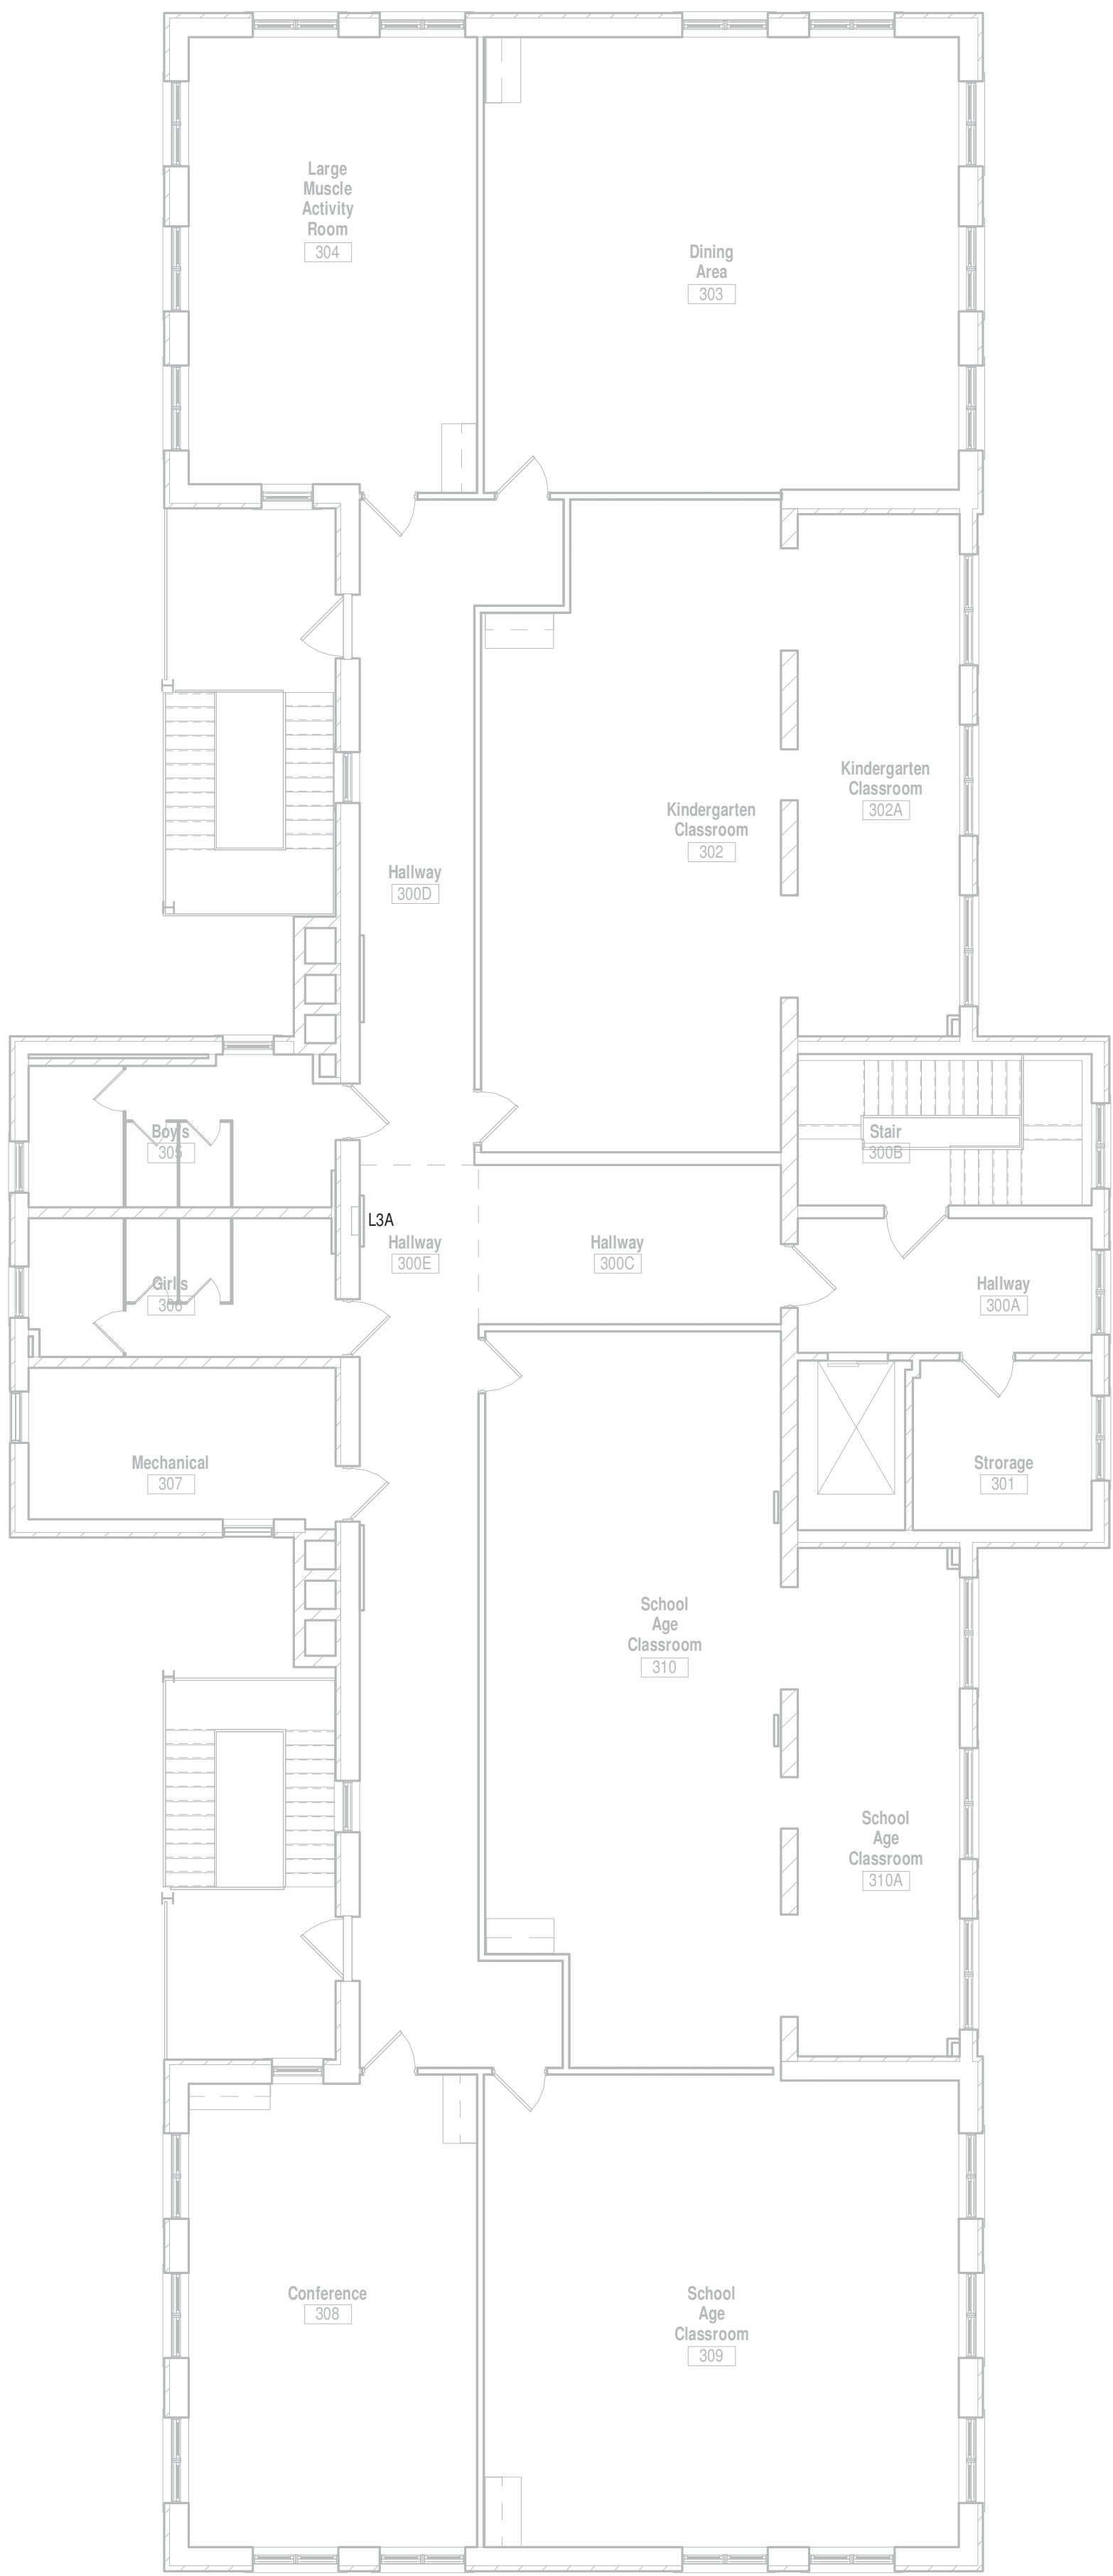

THIRD FLOOR PLAN - POWER
Scale: 1/8" = 1'-0"
PROJECT

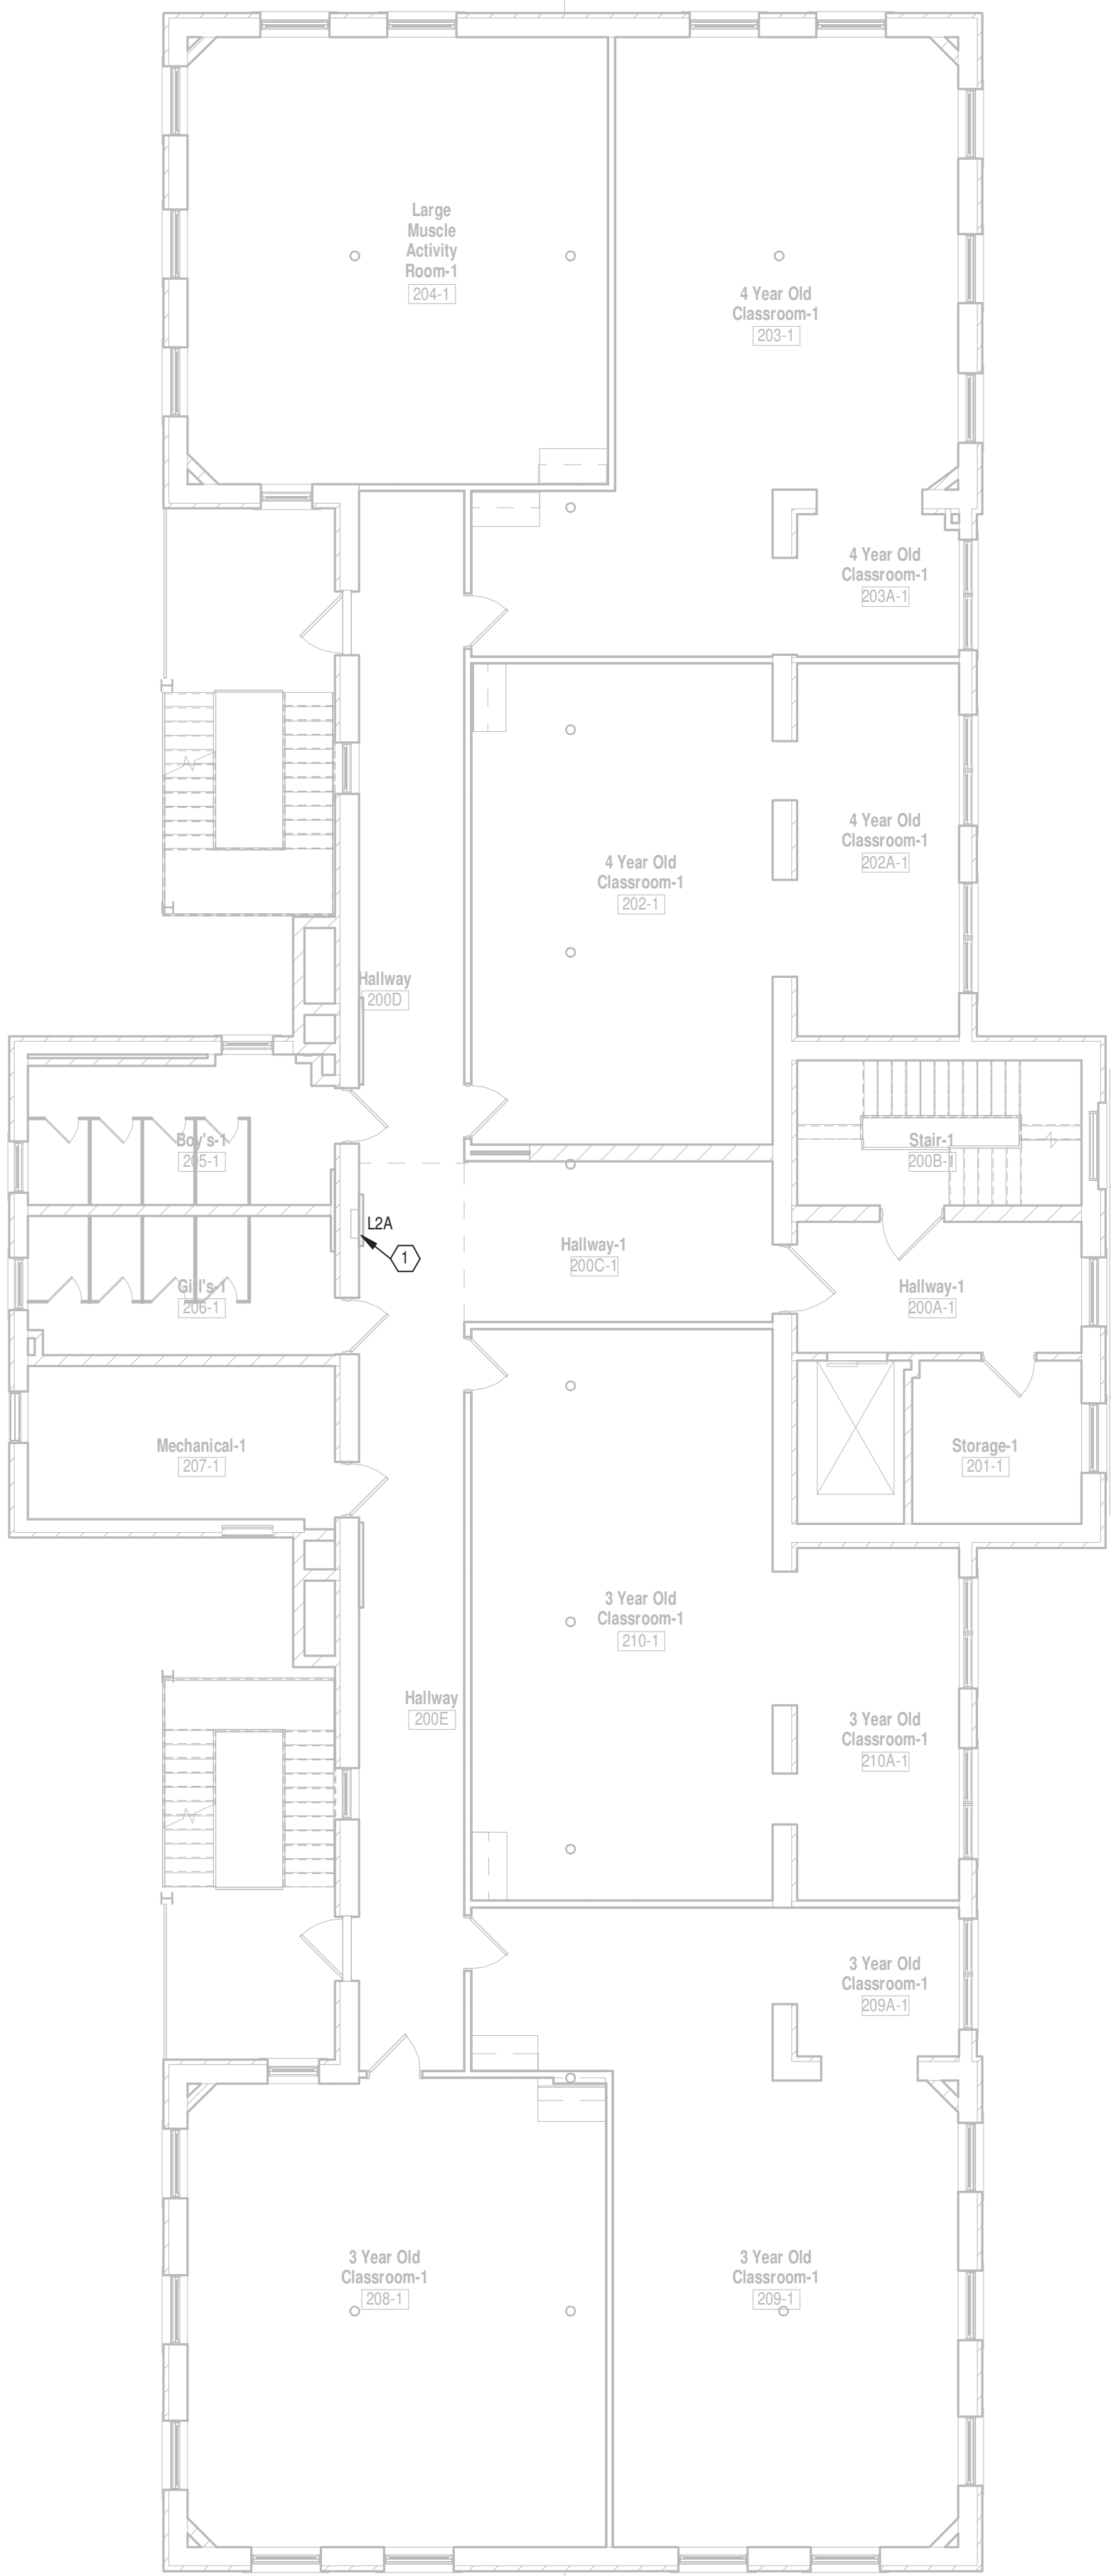

SECOND FLOOR PLAN - POWER
Scale: 1/8" = 1'-0"
PROJECT

<div>7/11/2017 5:42:23 PM</div> <table><tr><td>Revisions</td><td>Date</td></tr><tr><td> </td><td> </td></tr><tr><td> </td><td> </td></tr><tr><td> </td><td> </td></tr></table>	Revisions	Date							<div>CONSULTANTS:</div> <div><div><div><div></div><div>Heapy Engineering</div><div>MEP Design Technology Planning Commissioning Energy</div><div>Nationally Recognized Leader in Sustainability</div></div><div>1400 W Dorothy Lane, Dayton, OH 45409-1310 Ph 937-224-0861 Fax 937-224-5777 www.heapy.com Heapy Project No.: 2016-05088 Firm License No.: 01528</div></div></div> <div><div>STATE OF OHIO</div><div>DARC R. HESS E-75947</div><div>REGISTERED PROFESSIONAL ENGINEER</div></div>	<div>ARCHITECT/ENGINEERS:</div> <div><div>JOHN POE ARCHITECTS</div><div><div></div><div>3131 NEWMARK DRIVE, SUITE 200 MIAMISBURG, OHIO 45342 937 461 3290 PHONE 937 461 0260 FAX jpo@johnpoe.com</div></div></div>	<div>Drawing Title</div> <div>B401 2ND & 3RD FLOOR POWER PLAN</div> <div>Approved: Project Director</div>	<div>Project Title</div> <div>CORRECT ARC FLASH DEFICIENCIES</div> <div>Location Dayton, Ohio</div> <div>Date 07/06/2017</div> <div>Checked MSG</div> <div>Drawn JRS</div>	<div>Project No. 552-16-551 VA Project No. - JPA Project No. - Building Number - Drawing Number 401EP100 Dwg. of</div>	<div>Office of Construction and Facilities Management</div> <div>Department of Veterans Affairs</div>
	Revisions	Date												

A
B
C
D
E
F



A SITE PHOTOGRAPH

CONSULTANTS:




Heapy Engineering

MEP Design Technology Planning Commissioning Energy

Nationally Recognized Leader in Sustainability

1400 W Dorothy Lane, Dayton, OH 45409-1310
Ph 937-224-0861 Fax 937-224-5777 www.heapy.com
Heapy Project No.: 2016-05088 Firm License No.: 01526



Project Title <h1>CORRECT ARC FLASH DEFICIENCIES</h1>			Project No. VJA Project No. 552-16-551 JVA Project No. -		<div>Office of Construction and Facilities Management</div> <div>  <div>Department of Veterans Affairs</div> </div>
Location Dayton, Ohio			Building Number		
Drawing Number 402EP100			Dwg. of		
Date 07/06/2017	Checked MSG	Drawn JRS			