

Department of
Veterans Affairs

GENERAL NOTES:

- SEE SHEET C001 FOR CIVIL NOTES AND ABBREVIATIONS.
- CONTRACTOR IS RESPONSIBLE FOR ALL WORK SHOWN, UNLESS SPECIFICALLY INDICATED OTHERWISE.
- CONTRACTOR SHALL VISIT THE SITE PRIOR TO BIDDING TO DETERMINE THE EXTENT OF THE PROJECT.
- CONTRACTOR SHALL CONTACT PALMETTO UTILITY LOCATION SERVICE AT 1-888-721-7877 PRIOR TO ANY WORK. CONTRACTOR IS RESPONSIBLE FOR FIELD LOCATING AND PROTECTING ALL UTILITIES. CONTACT THE ENGINEER IN THE EVENT THAT UTILITIES CONFLICT WITH NEW FACILITIES.
- ALL PROJECT STAKEOUT SHALL BE PERFORMED BY A REGISTERED LAND SURVEYOR TO BE PAID FOR BY THE CONTRACTOR. FOR STAKEOUT, DO NOT RELY SOLELY ON THE PHYSICAL SCALE AS SHOWN IN DRAWINGS. REFER TO THE GIVEN DIMENSIONS, SYMBOL LEGEND, KEYNOTES, AND REFERENCED DETAILS FOR CORRECT STAKEOUT.
- ALL CONTRACTORS/SUBCONTRACTORS/PERSON THAT WILL BE ENGAGED IN LAND DISTURBING ACTIVITIES SHALL COMPLY WITH ALL EROSION CONTROL AND STORMWATER POLLUTION PREVENTION REQUIREMENTS CONTAINED THROUGHOUT THE DRAWINGS, SPECIFICATIONS AND PERMITS.



KEYNOTES:

- INSTALL 18" CURB AND GUTTER IAW DETAIL C/C620.
- TIE-IN NEW CURB AND GUTTER INTO EXISTING.
- INSTALL 4" THICK CONCRETE PAD.
- RE-INSTALL EXISTING SIGN IAW DETAIL J/C620. SEE PLAN FOR SALVAGE SIGN TYPE.
- INSTALL DOUBLE 4" WIDE YELLOW LINES DETAIL F/C620.
- INSTALL 4" SINGLE WHITE SOLID LINE IAW DETAIL F/C620.
- SEE ARCHITECTURAL PLAN FOR NEW WALL DETAIL.
- INSTALL CONCRETE WILLSTOP IAW DETAIL D/620

CIVIL LEGEND – SITE

- STANDARD DUTY ASPHALT PAVEMENT – INSTALL IAW DETAIL A/C620.
- LIGHT DUTY CONCRETE PAVEMENT – INSTALL IAW DETAIL A/C621.
- CONCRETE PAVEMENT/SIDEWALK – INSTALL IAW DETAIL B/C620.
- ACCESSIBLE PARKING SPACE AND AISLE – IAW DETAIL L/C620.
- SIDEWALK RAMP – INSTALL IAW DETAIL E/C620.
- DYSL/4"

DOUBLE YELLOW SOLID LINE / 4" WIDE EACH
- NEW TRAFFIC SIGN – INSTALL PER PLAN AND IAW DETAILS H/C620 & J/C620.
- CONTRACTION JOINT – INSTALL IAW DETAIL B/C621.
- REINFORCED SLAB – INSTALL IAW DETAIL B/C621.
- THICKENED EDGE – INSTALL IAW DETAIL B/C621.
- LIMITS OF CONSTRUCTION/LIMITS OF DISTURBANCE

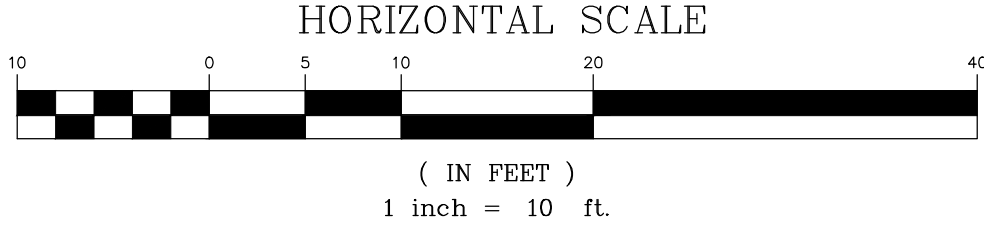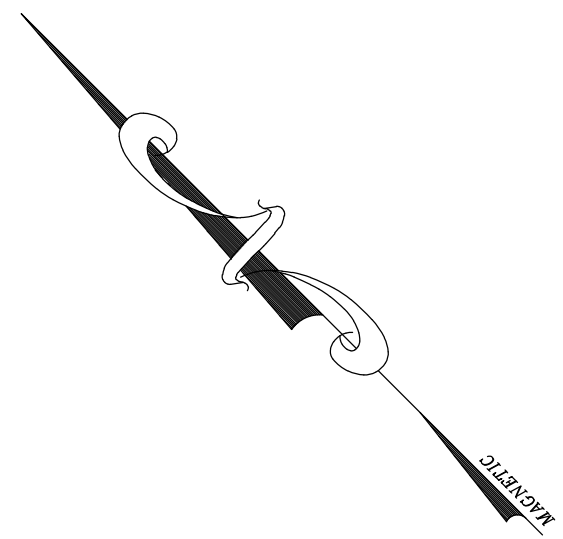

SITE PLAN – AREA 2
SCALE 1" = 10'

<div>Added Keynote 8 regarding installation of concrete willstop.</div> <div>Revisions:</div>		<div>CONSULTANTS:</div> <div><div><div>ADC</div><div>ENGINEERING SPECIALISTS</div><div>SITE SERVICES \ BUILDING ENVELOPE \ STRUCTURAL</div></div><div>1226 YEAMANS HALL ROAD HANAHAN, SC 29410 843-566-0161 fax 843-566-0162 ADCENGINEERING.COM</div><div><div>ADC ENGINEERING INC.</div><div>INC. No. 00253</div><div>STATE OF SOUTH CAROLINA</div></div></div>		<div>ARCHITECT/ENGINEERS:</div> <div><div><div>BES</div><div>DESIGN/BUILD</div></div><div>766 Middle St, Fairhope, AL 36532 Phone: 251.990.5778 Fax: 251.990.3716</div><div>1941 Savage Rd. Suite 300 Charleston, SC 29407 Phone: 843.277.2023 Fax: 866.728.1113</div></div>		<div>Drawing Title</div> <div>SITE PLAN - AREA 2</div> <div>Approved: Project Director</div> <div>Approver</div>	<div>Project Title</div> <div>DORN CORRECT POLICE AND SECURITY SPACE DEFICIENCIES</div> <div>Location</div> <div>W.J. BRYAN DORN VAMC; COLUMBIA SC</div> <div>Date</div> <div>2015.05.08</div> <div>Drawn</div> <div>SDD/WYD</div> <div>Checked</div> <div>CBC</div>	<div>Project Number</div> <div>544-303 (ADC 14211)</div> <div>Building Number</div> <div></div> <div>Drawing Number</div> <div>C202</div> <div>Dwg. 15 of 81</div>	<div>DEPARTMENT OF VETERANS AFFAIRS HEALTHCARE SYSTEM</div> <div><div></div>Department of Veterans Affairs</div>
---	--	--	--	--	--	--	--	--	--

