






three inches = one foot
one and one half inches = one foot
one inch = one foot
three quarters inch = one foot
one half inch = one foot
three eighths inch = one foot
one quarter inch = one foot
one eighth inch = one foot
one sixteenth inch = one foot

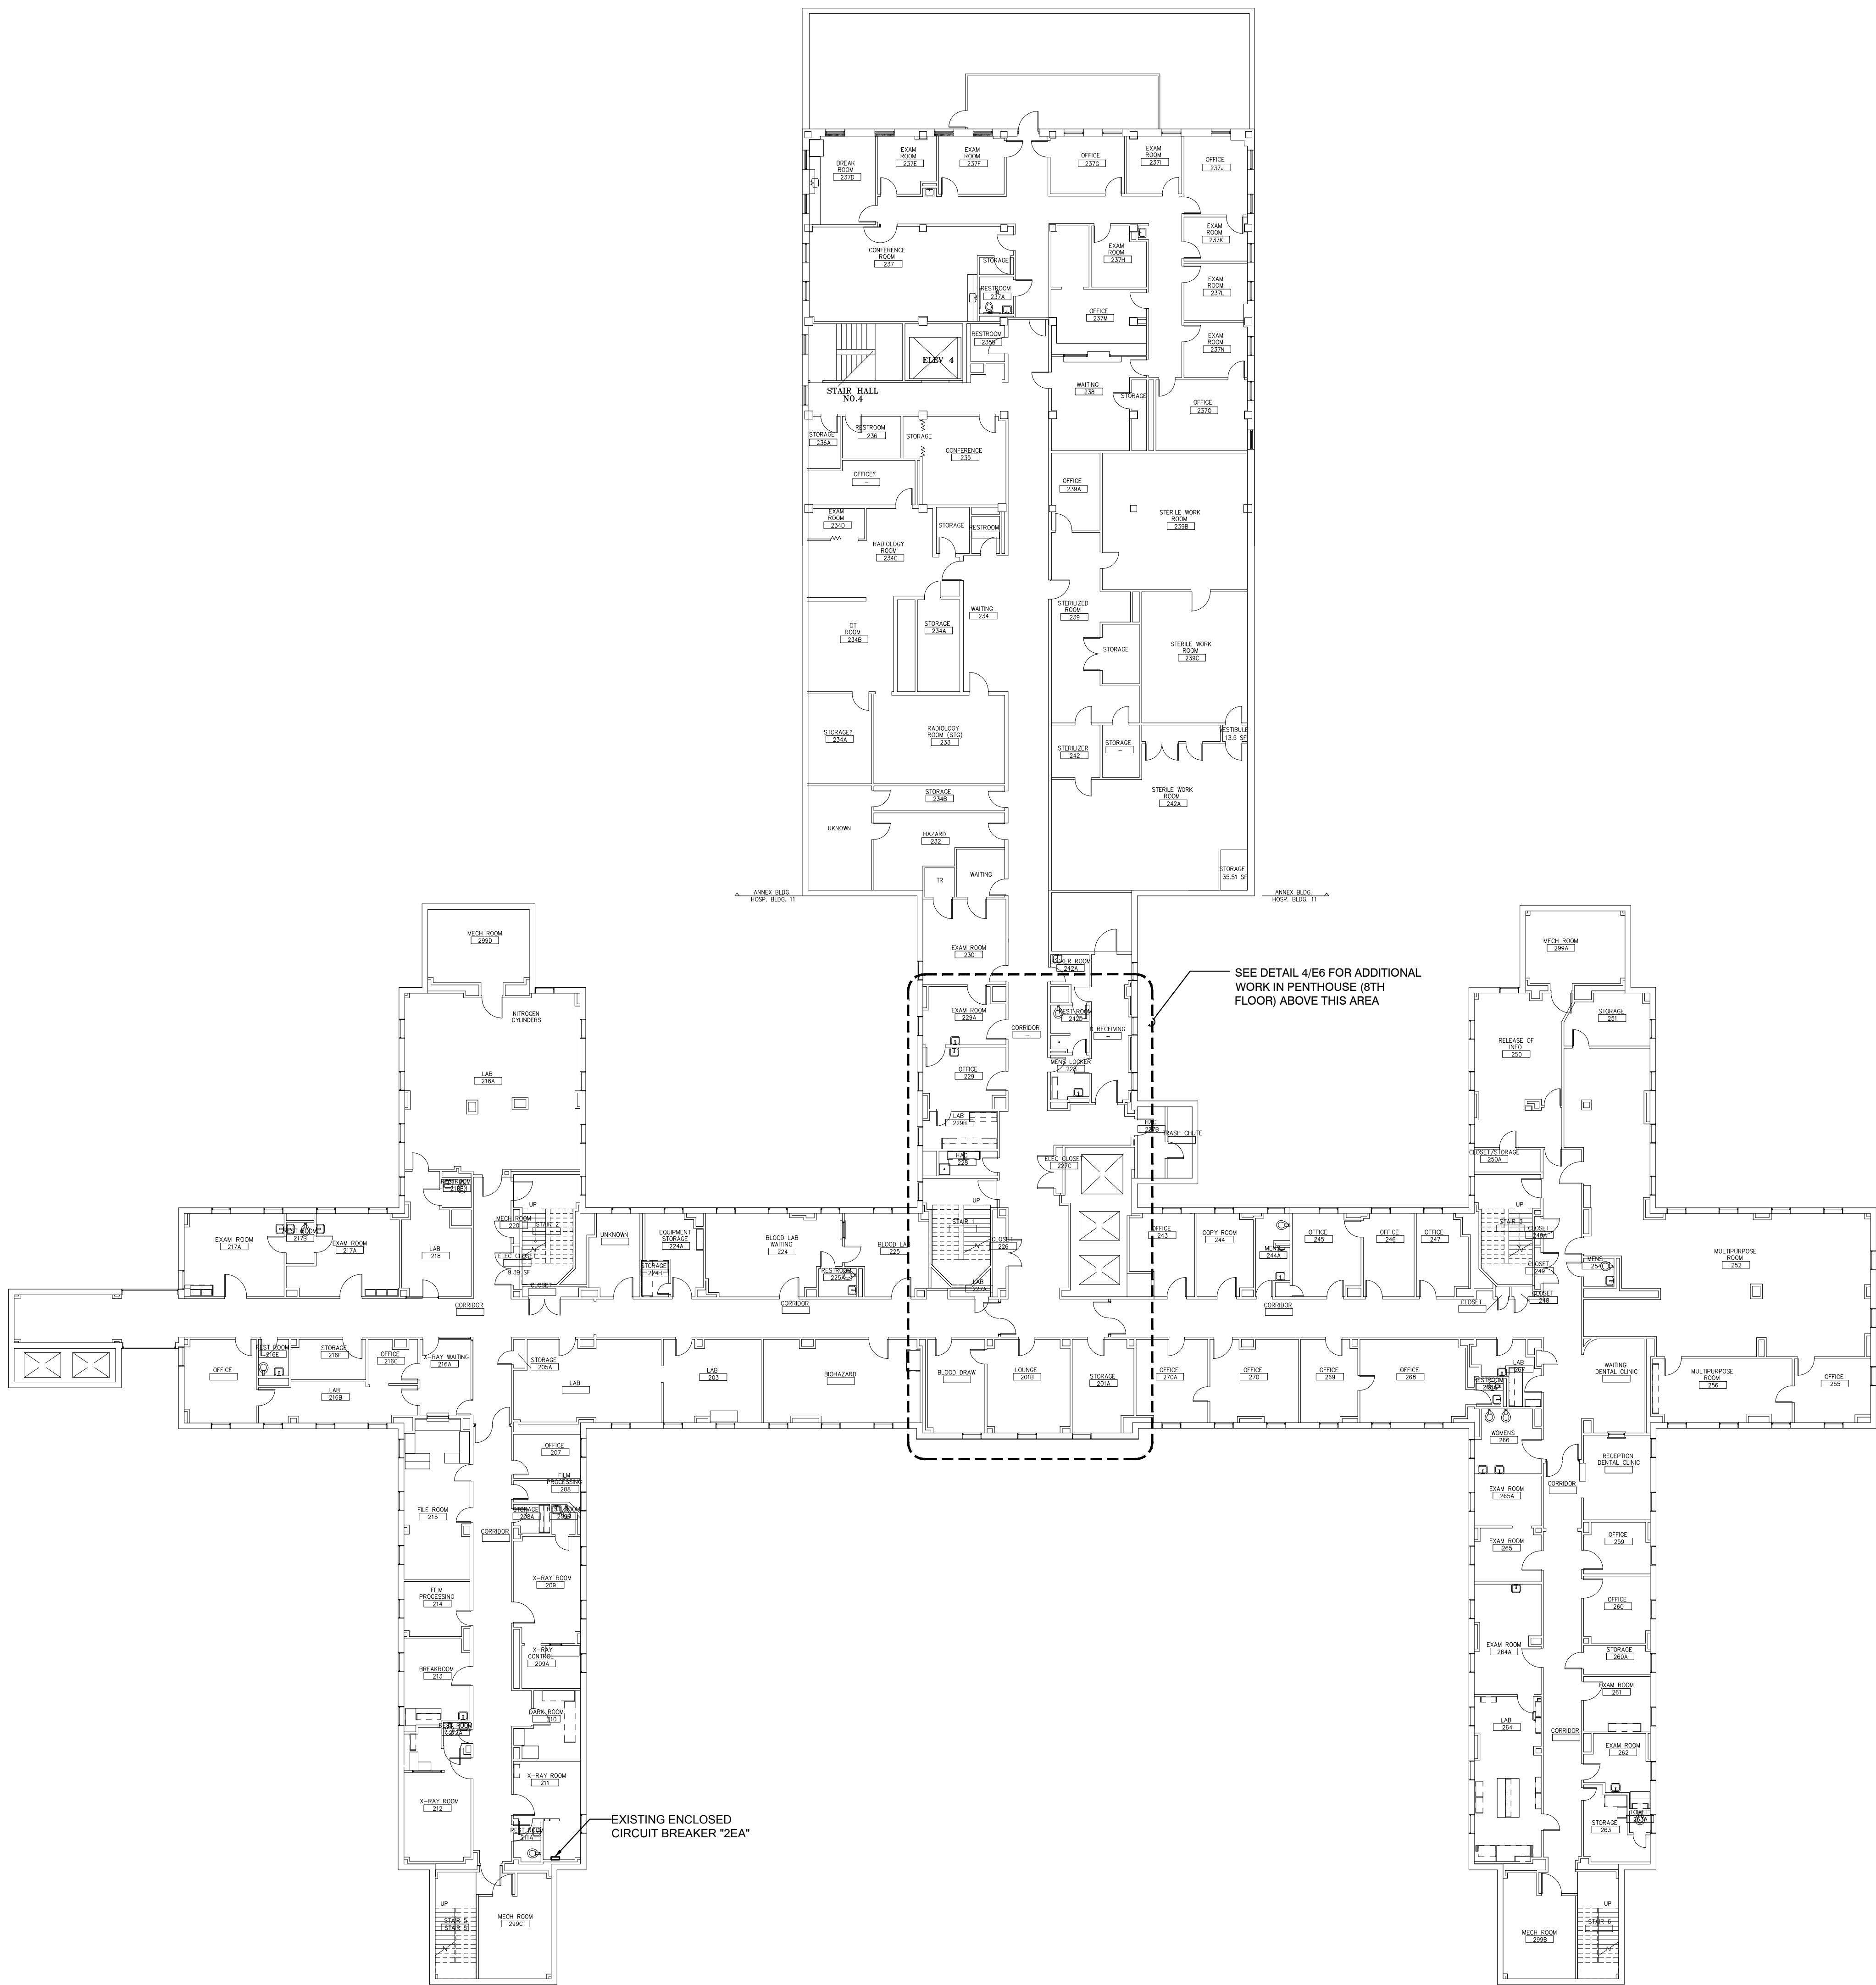

POWER PLAN - BUILDING 11 - SECOND FLOOR
SCALE: 1/16" = 1'-0"

NEW SHEET

		CONSULTANTS:		ARCHITECT/ ENGINEERS  BAIRD, HAMPTON & BROWN, INC. ENGINEERING & SURVEYING 6300 Ridgely Place, Ste 700 Fort Worth, TX 76116 Tel: 817-338-1277 Fax: 817-338-9245 TBPE Firm 000044 E-Mail: mail@bhbinc.com Web Site: www.bhbinc.com TBPLS FIRM 1001300	Drawing Title: POWER PLAN - BUILDING 11 - SECOND FLOOR	Project Title: UPGRADE EMERGENCY POWER TASK ORDER NO. VA257-15-R-0634	Project Number 671A4-15-123	Office of Construction and Facilities Management  Department of Veterans Affairs
					Building Numbers 11, 90, 96			
					Drawing Number E14			
					Dwg. _____ of _____			
					Location: 3600 MEMORIAL BLVD., KERRVILLE, TX 78028			
					Date: MAY 26, 2017			
					Approved Project Director: OFFICE OF CONSTRUCTION AND FACILITIES MANAGEMENT WESTERN REGION			
 ADDENDUM #3	8-25-17							
Revisions:	Date:							