


three inches = one foot
one and one half inches = one foot
one inch = one foot
three quarters inch = one foot
one half inch = one foot
one quarter inch = one foot
three eighths inch = one foot
one eighth inch = one foot

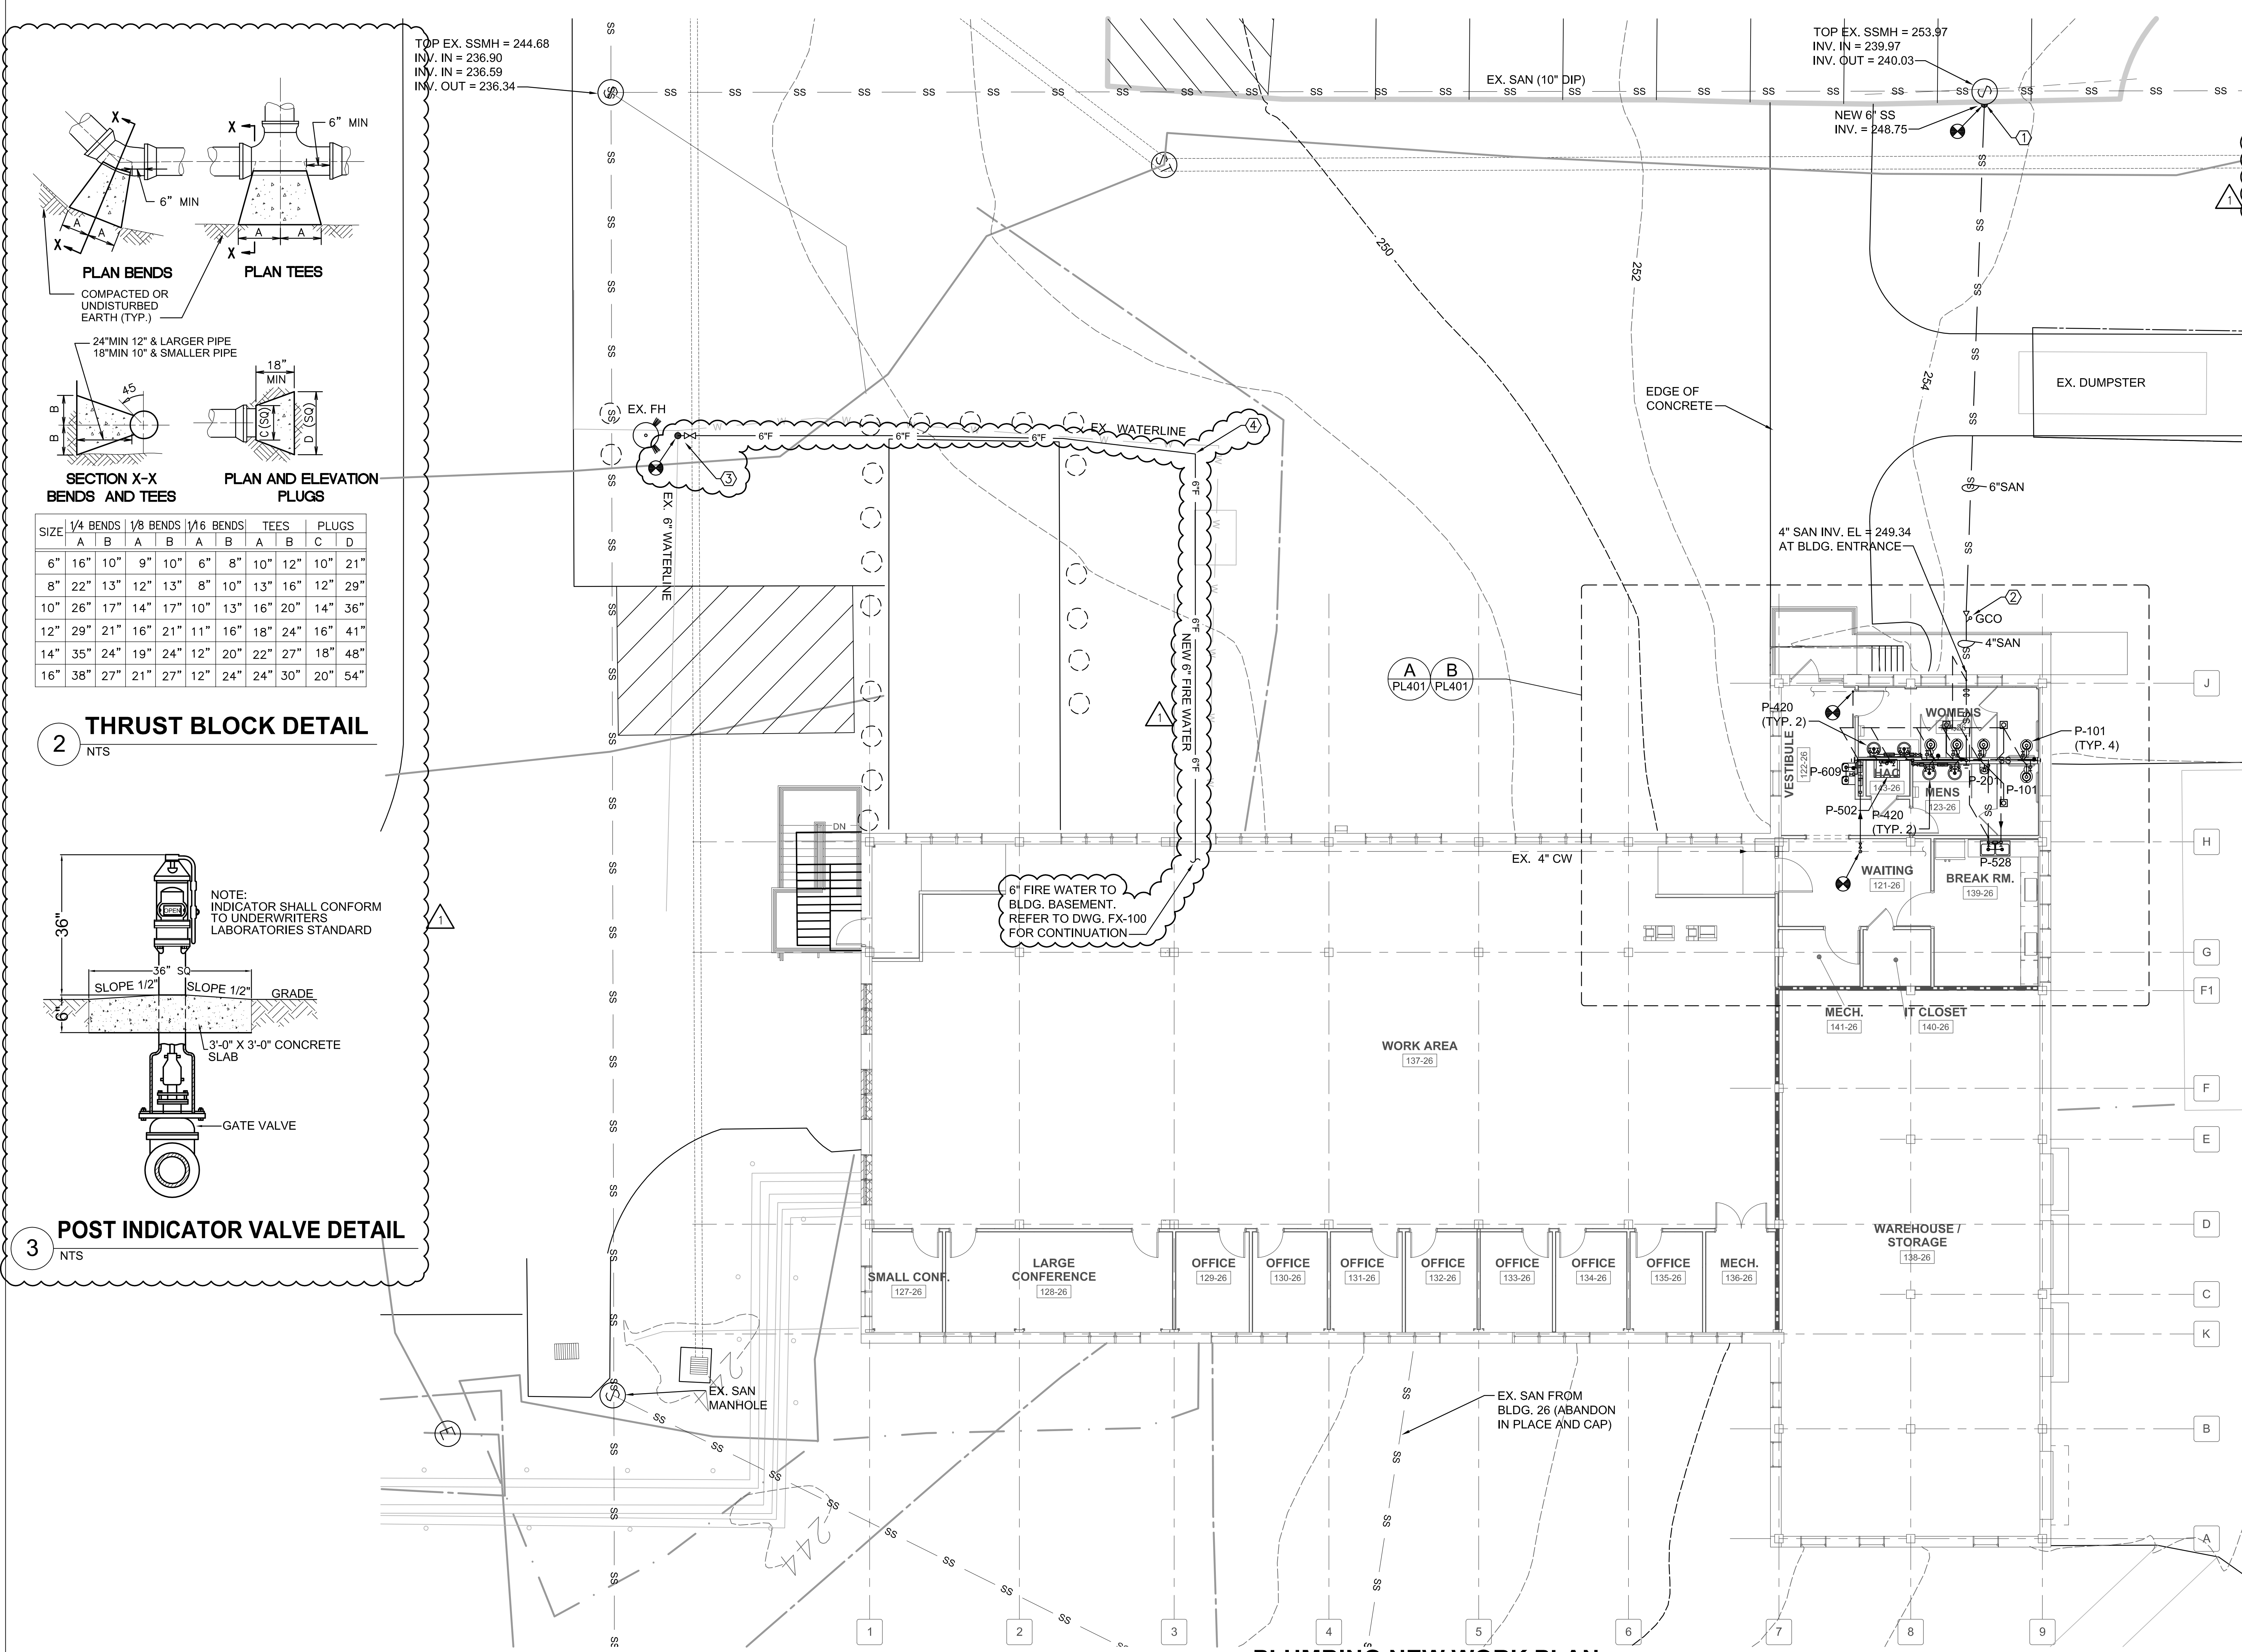

- ### GENERAL FLOOR PLAN NOTES
- 1. CONNECT NEW 6" SAN LINE FROM BUILDING 26 TO EXISTING MANHOLE, INV. ELEV. = 248.75'.
 - 2. SANITARY SEWER DRAIN LINE (4"). PROVIDE WITH A CLEAN-OUT TO GRADE AT BUILDING 5 FOOT LINE AND TRANSITION TO 6" SANITARY LINE AFTER THE CLEAN-OUT. CO TOP ELEV. = 254.50'.
 - 3. CONNECT NEW 6" FIRE WATER LINE TO BUILDING 26A TO EXISTING 6" FIRE WATER MAIN. INSTALL 6" PIV SHUTOFF VALVE AND THRUST BLOCK AT TIE-IN POINT.
 - 4. INSTALL THRUST BLOCK AT 90-DEGREE ELBOW AND AT ANY CHANGE OF DIRECTION NOT INDICATED.

GENERAL PLUMBING NOTES


FOR GENERAL PLUMBING NOTES, SEE DWG. PP001.

LEGEND

FOR LEGEND, SEE DWG. PP001.

NEW WORK PLUMBING NOTES

1. CONTRACTOR SHALL FIELD VERIFY ALL TIE-IN CONNECTIONS BEFORE CONSTRUCTION.

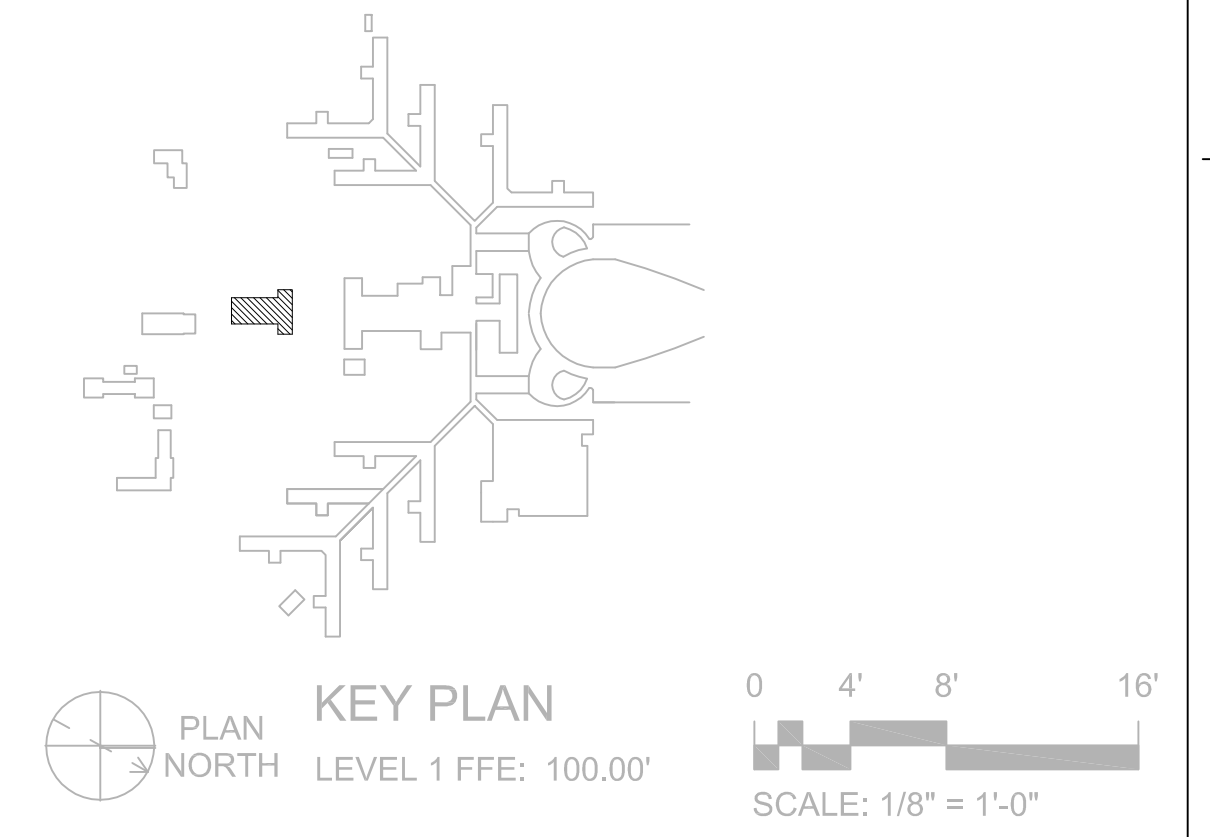

PLAN BENDS

COMPACTED OR UNDISTURBED EARTH (TYP.)

PLAN TEES

COMPACTED OR UNDISTURBED EARTH (TYP.)

SECTION X-X BENDS AND TEES

24" MIN 12" & LARGER PIPE
18" MIN 10" & SMALLER PIPE

PLAN AND ELEVATION PLUGS

SIZE	1/4 BENDS		1/8 BENDS		1/16 BENDS		TEES			PLUGS		
	A	B	A	B	A	B	A	B	C	D		
6"	16"	10"	9"	10"	6"	8"	10"	12"	10"	21"		
8"	22"	13"	12"	13"	8"	10"	13"	16"	12"	29"		
10"	26"	17"	14"	17"	10"	13"	16"	20"	14"	36"		
12"	29"	21"	16"	21"	11"	16"	18"	24"	16"	41"		
14"	35"	24"	19"	24"	12"	20"	22"	27"	18"	48"		
16"	38"	27"	21"	27"	12"	24"	24"	30"	20"	54"		

THRUST BLOCK DETAIL

NTS

POST INDICATOR VALVE DETAIL

NTS

CONSULTANTS:		ARCHITECT/ENGINEERS:		Drawing Title PLUMBING NEW WORK PLAN		Project Title RENOVATE BLDG. 26A FOR SWING SPACE FUNCTIONS		Project Number 557-16-105		CARL VINSON VAMC			
				Approved: Project Director		Location 1826 VETERANS BLVD. DUBLIN, GA 31021		Building Number 26A					
1. ADDED 6" FIRE WATER LINE				 BES DESIGN/BUILD, LLC 766 Middle St, Fairhope, AL 36532 Phone: 251.990.5778 Fax: 251.990.3716		Date 04-26-2017		Drawn JL		Checked MF		Drawing Number PL101	
Revisions:						Dwg. of							