


ROOM#	ROOM NAME
A-301	BLOOD BANK
A-301A	BONE & TISSUE BANK
A-301B	PACKING
A-301C	LABORATORY
A-301D	MALE TOILET
A-301E	STORAGE
A-301F	FEMALE TOILET
A-301G	CHEMISTRY
A-301H	HEMATOLOGY & SEROLOGY
A-301I	GLASS WASH
A-301J	GLASS & SOLUTION
A-301K	STORAGE
A-301L	CHEMISTRY
A-301M	AUTOCLAVE
A-301N	HISTOPATHOLOGY
A-301O	BACTERIOLOGY
A-301P	EQUIPMENT REPAIR
A-301Q	MEDIA PREP
A-301R	BACTERIOLOGY
A-301S	TRANSFER
A-301T	IN C.
A-301U	REF.
A-301V	BACTERIOLOGY MICROSCOPE
A-301W	FLUORESCENT ROOM
A-301X	FLUORESCENT MICROSCOPE
A-301Y	DARK ROOM LAB
A-301Z	RESIDENTS LAB
A-302	URINALYSIS
A-303	RESIDENTS OFFICE
A-304	RESIDENTS OFFICE
A-305	STUDENTS LAB
A-306	STUDENT + F. BOOK FILE
A-307	OFFICE
A-308	RADIO STUDIO
A-309	CONTROL
A-310	PROJECTION
A-311	REVIEW
A-312	M. GEN.
A-313	TOILET
A-314	TOILET
A-315	TOILET
A-316	TOILET
A-317	TOILET
A-318	TOILET
A-319	TOILET
A-320	CLERKS
A-321	RECEPTION
A-322	WAITING
A-323	E. SPEC. TOILET
A-324	E. SPEC. TOILET
A-325	E. SPEC. TOILET
A-326	E. SPEC. TOILET
A-327	E. SPEC. TOILET
A-328	E. SPEC. TOILET
A-329	E. SPEC. TOILET
A-330	E. SPEC. TOILET
A-331	E. SPEC. TOILET
A-332	E. SPEC. TOILET
A-333	E. SPEC. TOILET
A-334	E. SPEC. TOILET
A-335	E. SPEC. TOILET
A-336	E. SPEC. TOILET
A-337	E. SPEC. TOILET

NOTES
1-ALL FIXTURES ARE TYPE C-2, UNLESS OTHERWISE NOTED.
2-FOR DARK ROOM WIRING DIAGRAM SEE DWG. 1E-66.

ALL ADDENDUM, CLARIFICATION AND CHANGE ORDER DATA HAVE BEEN ADDED TO THIS DRAWING.
THIS DRAWING IS COMPLETE AND UP-TO-DATE AS OF 8-25-67

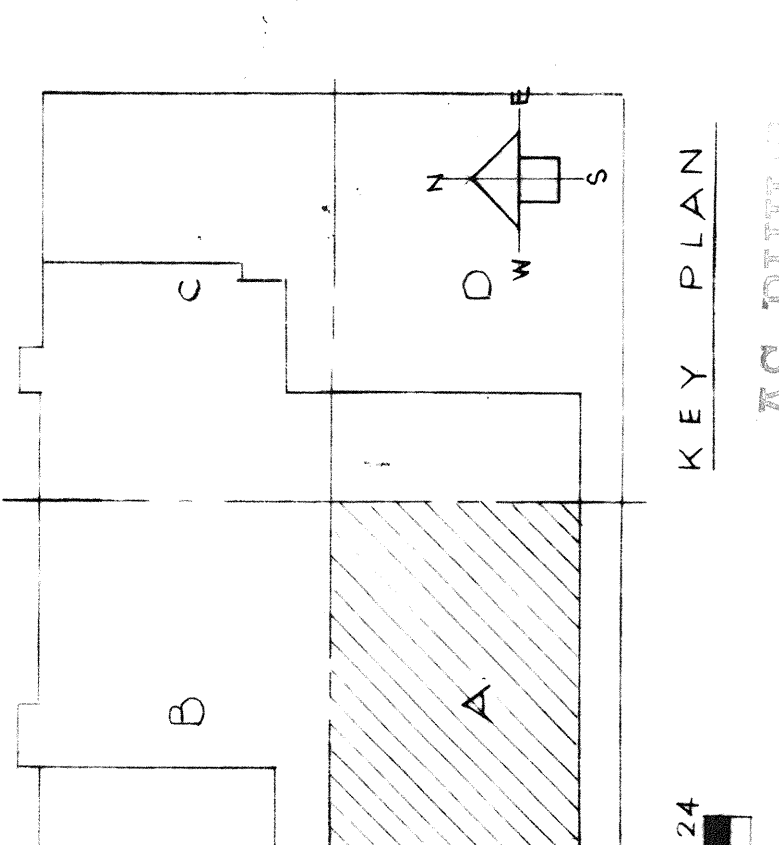


THIRD FLOOR PLAN "A" LG.
BUILDING NO. 1

1062 BED
M. S. & N. HOSPITAL
VETERANS ADMINISTRATION
MIAMI, FLORIDA

REVISIONS
DRAWN BY: [Signature]
CHECKED BY: [Signature]
DATE: May 5, 1964

SMITH & KOPACH
BEISWENGER, HOCH & ARNOLD
ARCHITECTS-ENGINEERS
721 N.W. 21 COURT - MIAMI, FLORIDA
PROJ. NO. 69-2312

DRAWING NUMBER
1-E24
SHEET 44 OF 502

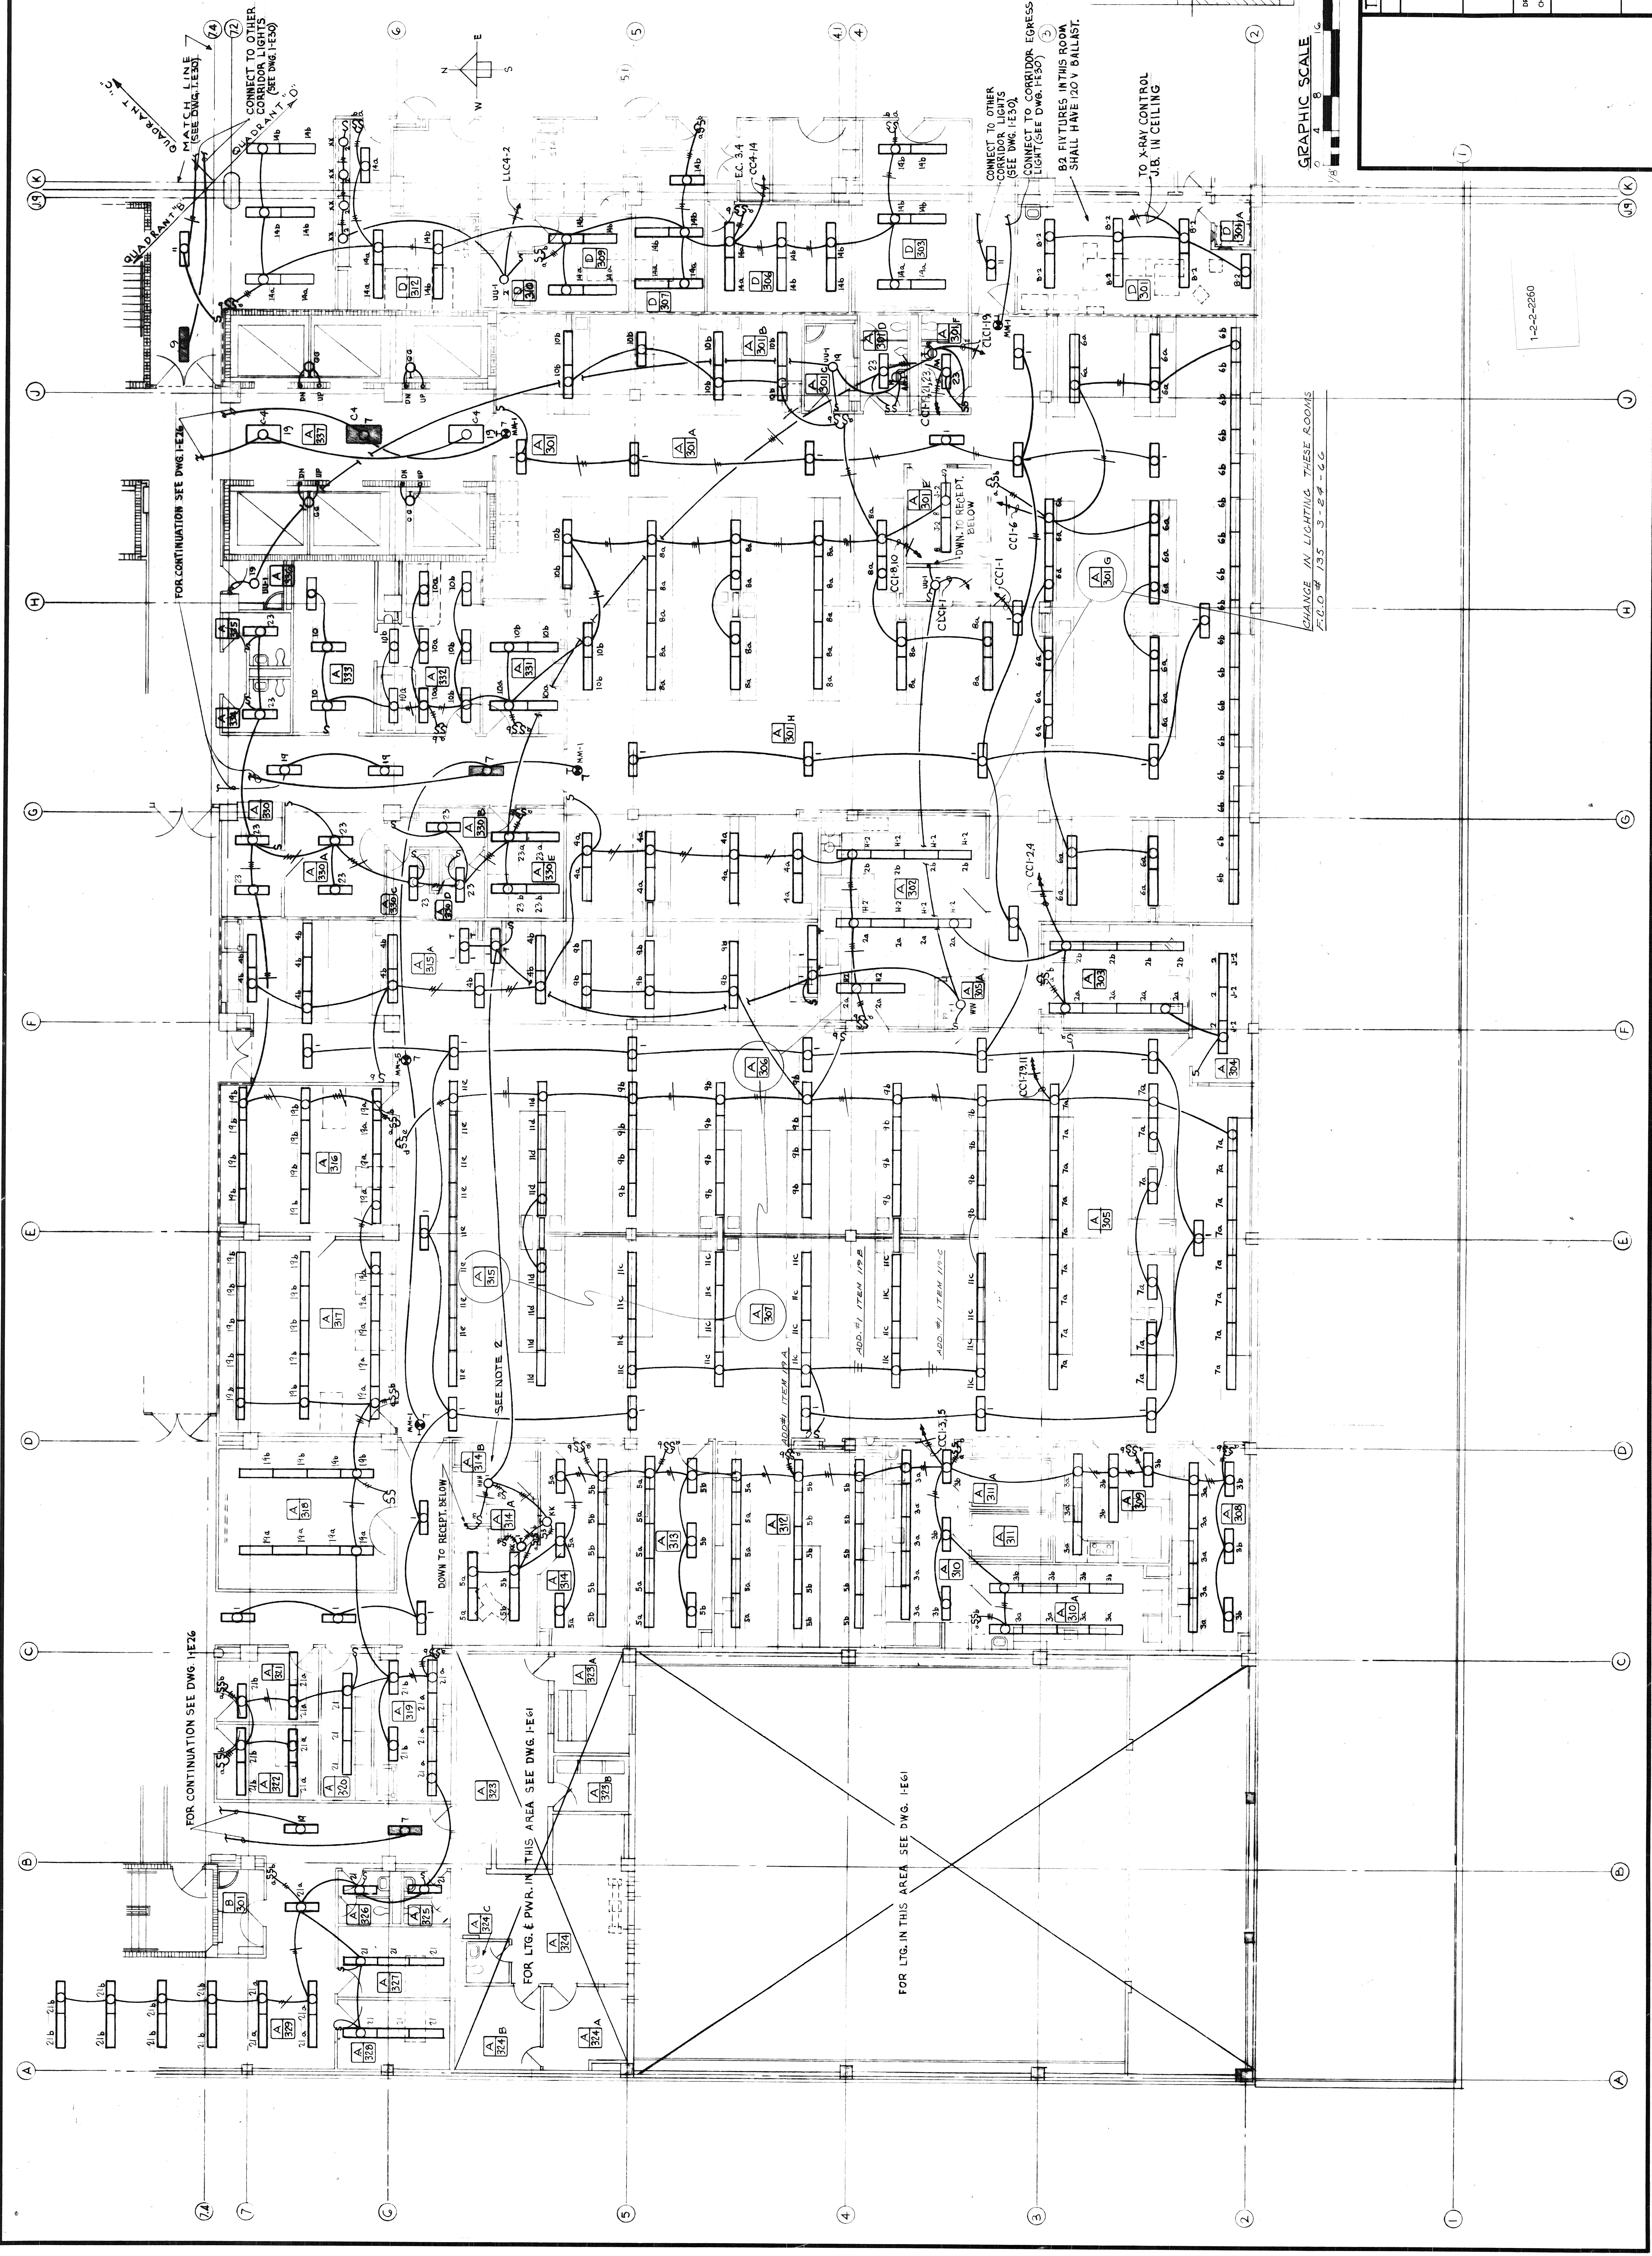

RETURN TRUCKS TO PLAN FILES