
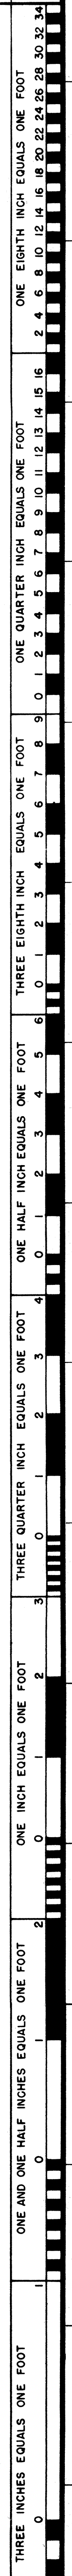


|  |                                      |
|--|--------------------------------------|
| PROJECT TITLE<br><b>10 120 Bed Nursing Home Care Unit</b>                              | DATE<br>JAN 16 1978                  |
| DRAWN BY<br>STIMSON  | CHECKED BY<br><i>Walter J. Hubbs</i> |
| DESIGNED BY<br><b>The Smith, Korach, Hayet, Haynie Partnership</b>                     |                                      |
| ARCHITECTS, ENGINEERS, PLANNERS<br>175 Fontainebleau Boulevard<br>Miami, Florida 33199 |                                      |
| PROJECT NUMBER<br><b>546-007</b>   | DATE<br>JAN 16 1978                  |
| APPROVED: PROJECT DIRECTOR<br><i>[Signature]</i>                                       |                                      |
| VETERANS ADMINISTRATION  |                                      |
| LOCATION<br><b>V.A.H. Miami, Florida</b>   |                                      |

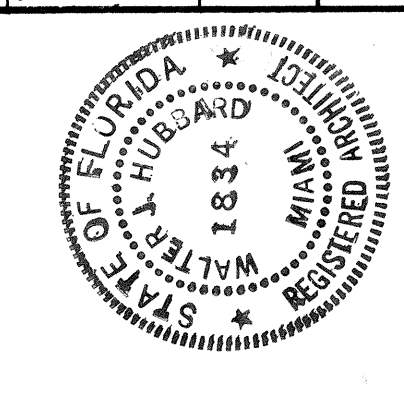

**NORTH ELEVATION**  
1/8"=1'-0"

**EAST ELEVATION**  
1/8"=1'-0"