



three inches = one foot
one and one-half inches = one foot
one inch = one foot
three-quarters inch = one foot
one-half inch = one foot
three-eighths inch = one foot
one-quarter inch = one foot
one-eighth inch = one foot

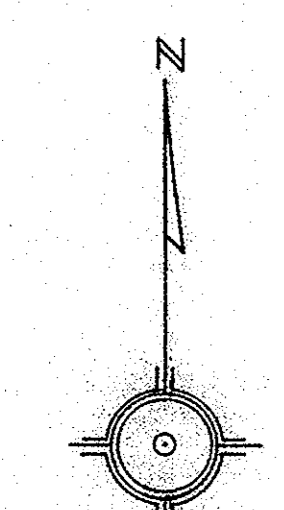

TERMINAL H FRAME FOR
ELECTRIC AND TELEPHONE
SERVICE.

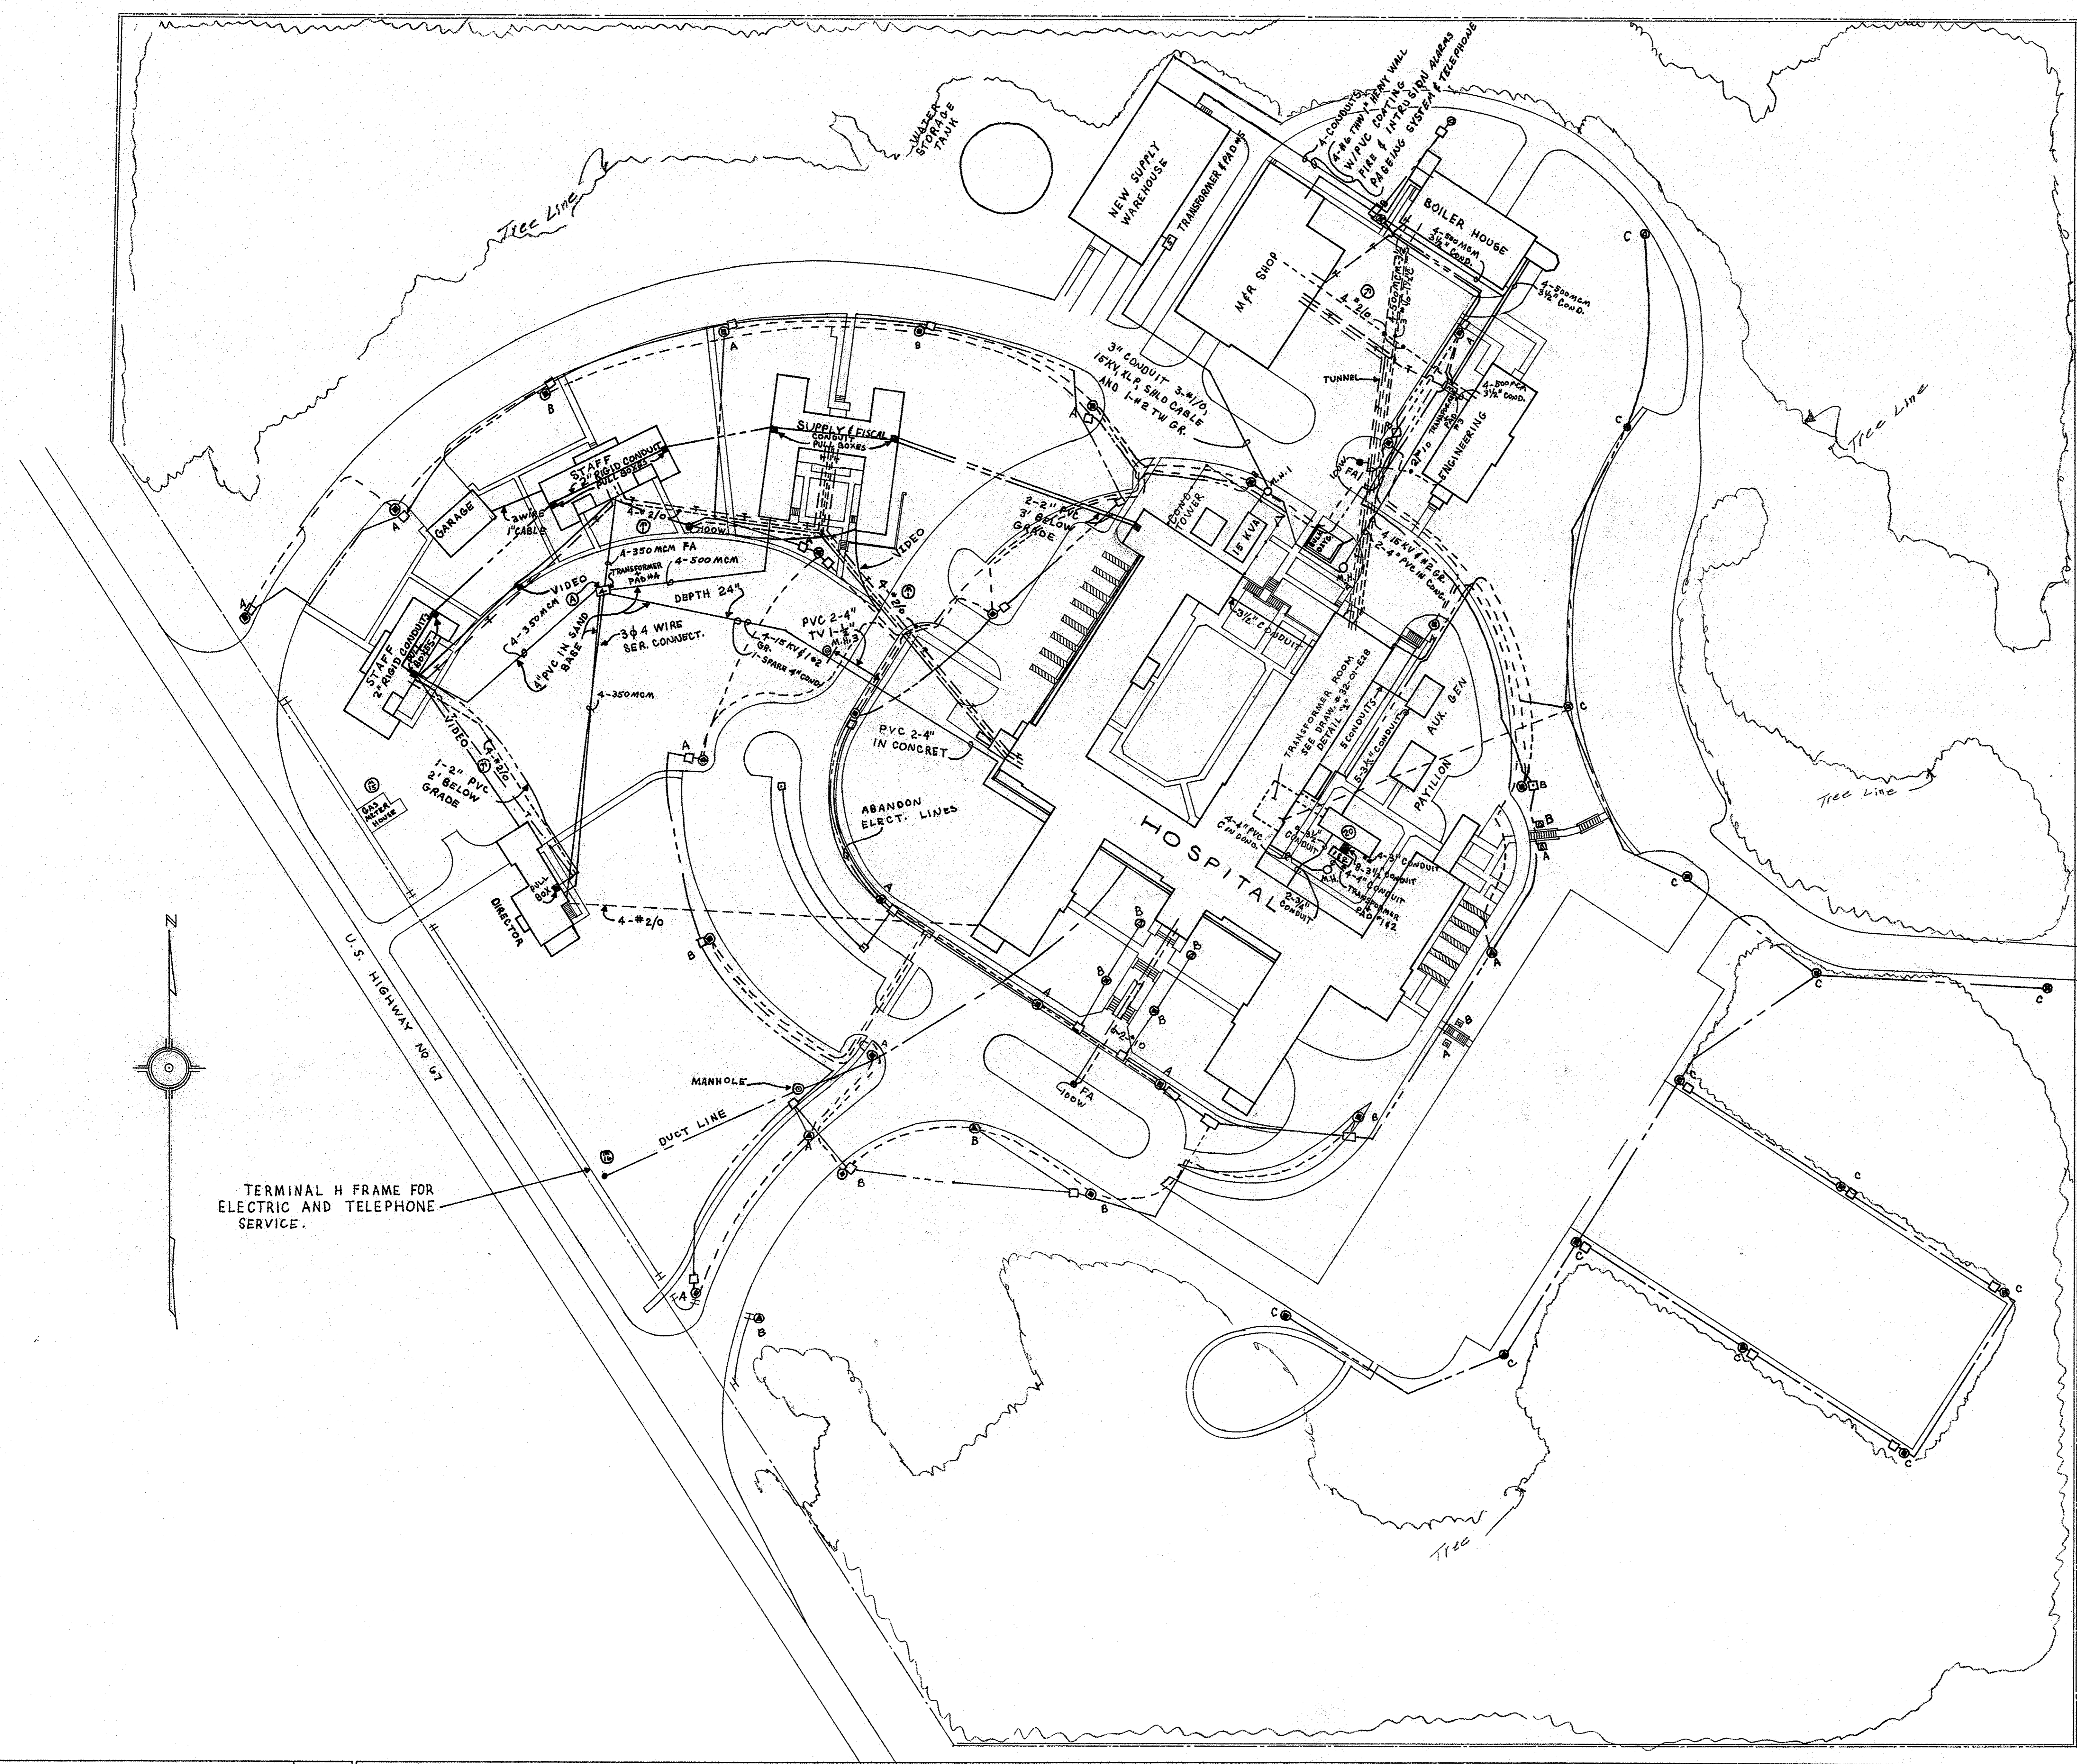

CORRECTIONS	11-13-85
Revisions	Date

Drawing Title UTILITY SITE PLAN ELECTRICAL		Project Title		Date
Approved: Division Chief		Building Number	Checked	Drawn
Approved: Service Director		Location JOHN J. PERSHING VA MEDICAL CENTER POPLAR BLUFF, MO		DRAWING NO. Dwg. Of

Veterans Administration