

- KEY NOTES
- CONNECT EXISTING DUCT TO NEW DIFFUSER OR GRILLE.
  - ISOLATION ROOM PRESSURE MONITOR DISPLAY KEY SWITCH AT 5'-0" AFF.
  - ISOLATION ROOM PRESSURE MONITOR, MODEL TS18630-SM WITH KEY SWITCH FOR SWITCHING FROM ISOLATION ROOM TO NORMAL OCCUPANCY. LOCATE ABOVE DOOR. INITIAL SET PRESSURE TO 0.01" DIFFERENTIAL PRESSURE.

HVAC THIRD FLOOR PLAN  
SCALE: 1/8" = 1'-0"


EXHIBIT "H.4"  
INSTALL OPERATING ROOM BOOMS  
PHASE 2  
PROJECT NO.: 618-12-302  
EXISTING THIRD FLOOR HVAC PLAN

100% SUBMITTAL - CD SUBMITTAL  
FULLY SPRINKLERED

GENERAL NOTES:

GENERAL CONTRACTOR AND/OR ALL SUBCONTRACTORS SHALL FIELD VERIFY ALL DIMENSIONS SHOWN ON THESE PLANS AND SHALL BE RESPONSIBLE FOR VARIATIONS BETWEEN PLAN DIMENSIONS AND ACTUAL FIELD DIMENSIONS. WHERE VARIATIONS ARE FOUND TO OCCUR THE CONTRACTOR SHALL NOTIFY THE PROJECT ENGINEER IN WRITING PRIOR TO PROCEEDING WITH CONSTRUCTION; NO ADJUSTMENT TO THE WORK WILL BE MADE WITHOUT THE PRIOR APPROVAL OF THE PROJECT ENGINEER.

GENERAL CONTRACTOR SHALL BE RESPONSIBLE FOR GENERAL DEMOLITION INCLUDING REMOVAL OF WALLS, PARTITIONS, DOORS & CEILING & FLOORS. ANY AND ALL CUTTING OF CONCRETE FLOORS, WALLS OR STRUCTURE SHALL BE THE GENERAL CONTRACTOR'S RESPONSIBILITY. CORE DRILLING THROUGH CONCRETE WALLS, FLOORS OR STRUCTURE FOR PIPING OR CONDUIT SHALL BE THE RESPONSIBILITY OF THE SUBCONTRACTOR BY TRADE; FIRESTOPPING OF THESE OPENING SHALL BE DONE BY THE RESPECTIVE SUBCONTRACTOR. REMOVAL OF DEBRIS RESULTING FROM DEMOLITION, CUTTING, AND/OR DRILLING IS THE RESPONSIBILITY OF THE GENERAL CONTRACTOR. PATCHING AND REPAIR OF CONCRETE WALLS, FLOOR, OR STRUCTURE SHALL BE THE RESPONSIBILITY OF THE GENERAL CONTRACTOR; THIS WILL BE ACCOMPLISHED UPON COMPLETION OF THE INSTALLATION OF ANY AND ALL UTILITIES INSTALLED BY THE VARIOUS SUBCONTRACTORS.

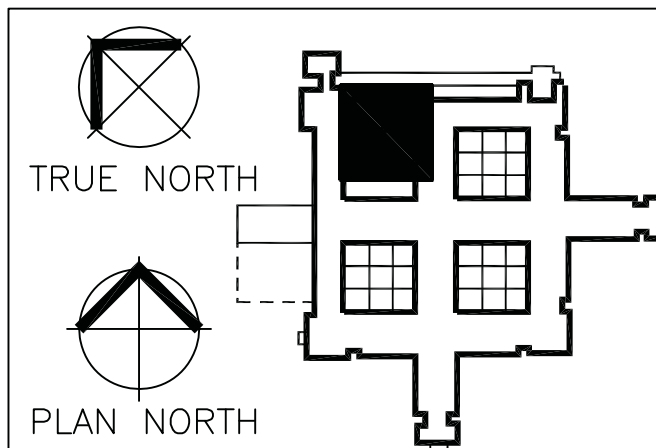

Drawing Scale  
SEE PLAN

Plot Scale  
12" = 1'-0"

Drawing Title  
HVAC THIRD FLOOR PLAN

Approved: Cynthia Doolittle, Chief, Projects Section

Approved: Steven Challeen, Director, Engineering

Project Title

Location  
V.A. MEDICAL CENTER  
ONE VETERANS DRIVE  
MINNEAPOLIS, MN 55417

Date  
4.8.2011

Checked  
NJ

Drawn  
KET

Office of  
Facilities  
Management

Department of  
Veterans Affairs