

KEY NOTES

- EXISTING 12" EXHAUST DUCT UP TO EXISTING EXHAUST FAN IN PENTHOUSE A-2 (SEE 3/M7.1 FOR PENTHOUSE PLAN). REBALANCE FAN TO 250 CFM.
- NEW DUCT STATIC PRESSURE SENSOR. INCORPORATE INTO AHU-36 CONTROL SEQUENCE.

HVAC THIRD FLOOR INTERSTITIAL PLAN
SCALE: 1/8" = 1'-0"

EXHIBIT "H.5"
INSTALL OPERATING ROOM BOOMS
PHASE 2
PROJECT NO.: 618-12-302
EXISTING THIRD FLR. INTERST HVAC PLAN


100% SUBMITTAL - CD SUBMITTAL
FULLY SPRINKLERED

REVISIONS	DATE

GENERAL NOTES:

GENERAL CONTRACTOR AND/OR ALL SUBCONTRACTORS SHALL FIELD VERIFY ALL DIMENSIONS SHOWN ON THESE PLANS AND SHALL BE RESPONSIBLE FOR VARIATIONS BETWEEN PLAN DIMENSIONS AND ACTUAL FIELD DIMENSIONS. WHERE VARIATIONS ARE FOUND TO OCCUR, THE CONTRACTOR SHALL NOTIFY THE PROJECT ENGINEER IN WRITING PRIOR TO PROCEEDING WITH CONSTRUCTION; NO ADJUSTMENT TO THE WORK WILL BE MADE WITHOUT THE PRIOR APPROVAL OF THE PROJECT ENGINEER.

GENERAL CONTRACTOR SHALL BE RESPONSIBLE FOR GENERAL DEMOLITION INCLUDING REMOVAL OF WALLS, PARTITIONS, DOORS & CEILING & FLOORS. ANY AND ALL CUTTING OF CONCRETE FLOORS, WALLS OR STRUCTURE SHALL BE THE GENERAL CONTRACTOR'S RESPONSIBILITY. CORE DRILLING THROUGH CONCRETE WALLS, FLOORS OR STRUCTURE FOR PIPING OR CONDUIT SHALL BE THE RESPONSIBILITY OF THE SUBCONTRACTOR BY TRADE. FIRESTOPPING OF THESE OPENING SHALL BE DONE BY THE RESPECTIVE SUBCONTRACTOR. REMOVAL OF DEBRIS RESULTING FROM DEMOLITION, CUTTING, AND/OR DRILLING IS THE RESPONSIBILITY OF THE GENERAL CONTRACTOR. PATCHING AND REPAIR OF CONCRETE WALLS, FLOOR, OR STRUCTURE SHALL BE THE RESPONSIBILITY OF THE GENERAL CONTRACTOR; THIS WILL BE ACCOMPLISHED UPON COMPLETION OF THE INSTALLATION OF ANY AND ALL UTILITIES INSTALLED BY THE VARIOUS SUBCONTRACTORS.

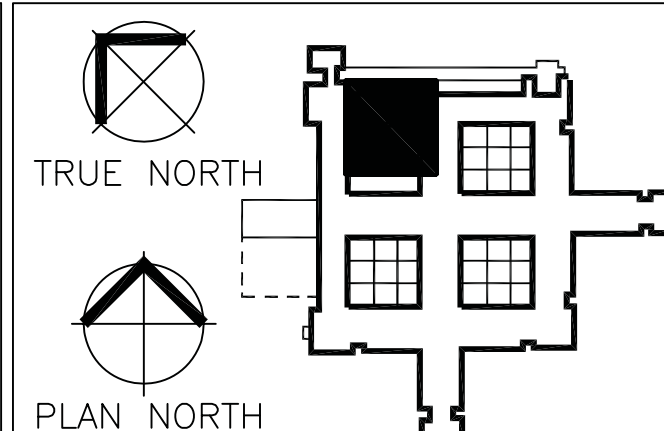

Drawing Scale
SEE PLAN

Plot Scale
12" = 1'-0"

Drawing Title
HVAC THIRD FLOOR INTERSTITIAL PLAN

Approved: Cynthia Doolittle, Chief, Projects Section

Approved: Steven Challeen, Director, Engineering

Project Title

Location
V.A. MEDICAL CENTER
ONE VETERANS DRIVE
MINNEAPOLIS, MN 55417

Date
4.8.2011

Checked
NJI

Drawn
KET

Project No.

Dwg. 25 of 39

Office of
Facilities
Management

Department of
Veterans Affairs