



three inches = one foot  
one and one half inches = one foot  
one inch = one foot  
three quarters inch = one foot  
one half inch = one foot  
three eighths inch = one foot  
one quarter inch = one foot  
one eighth inch = one foot

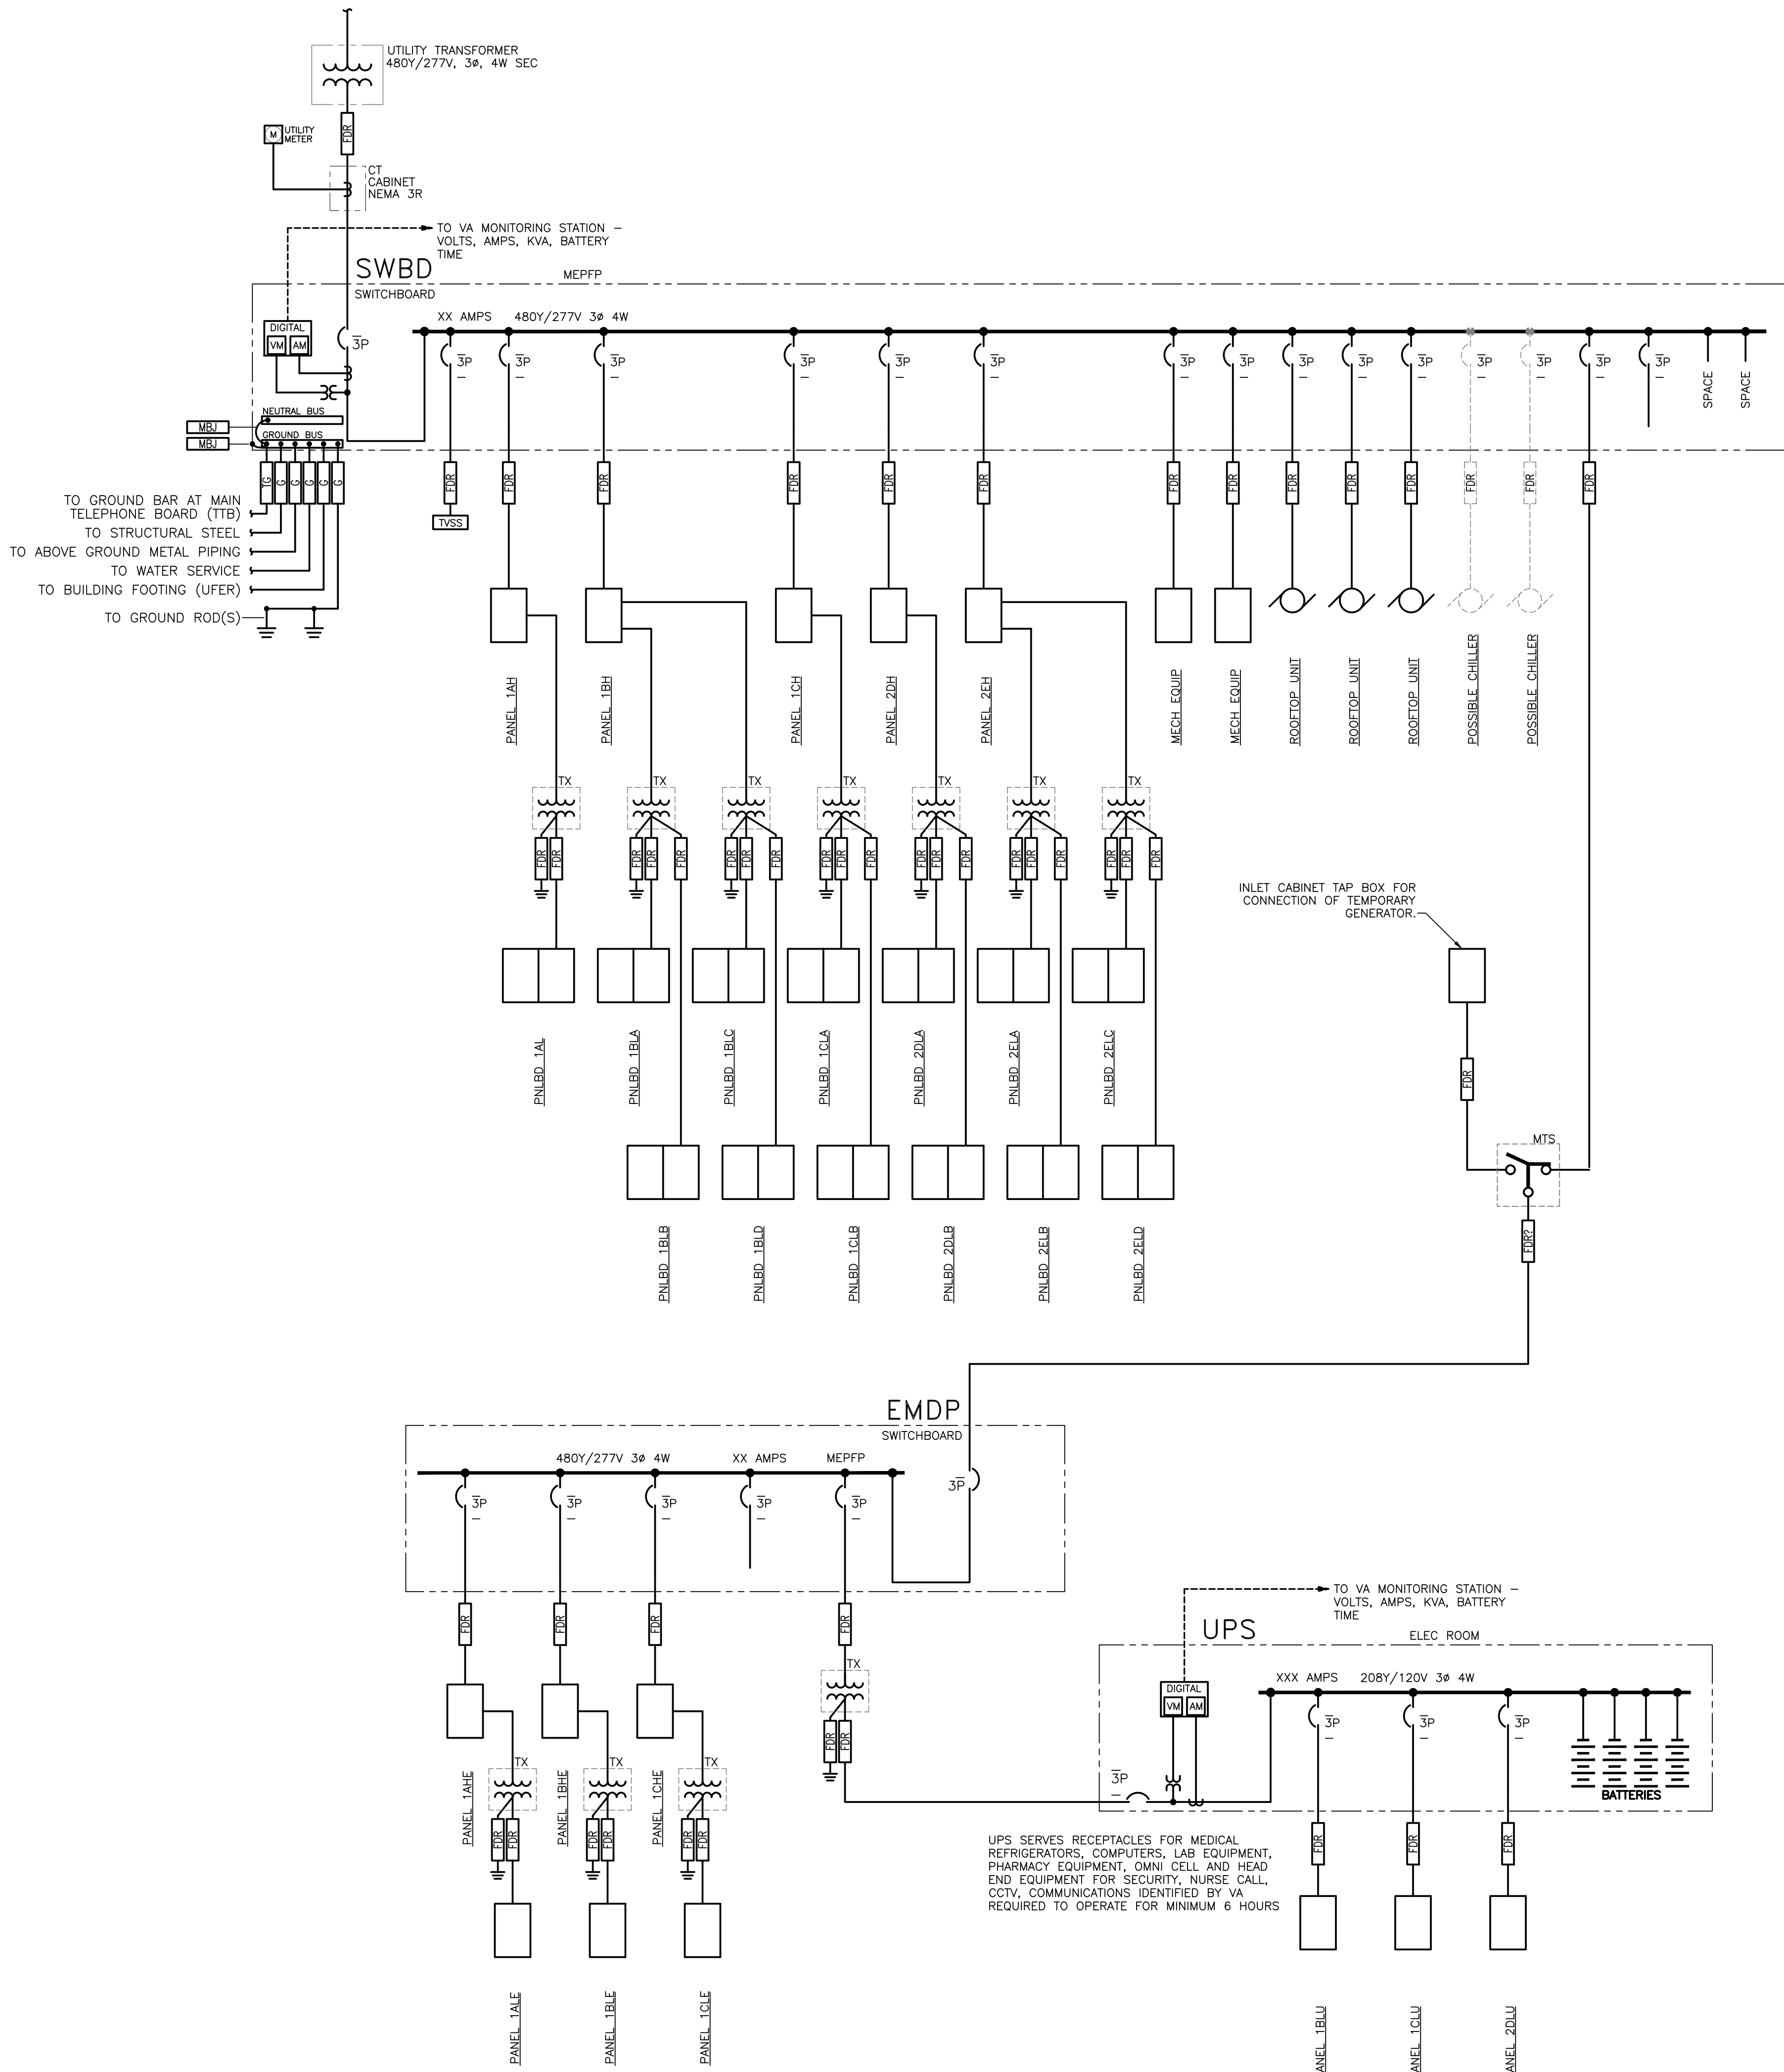

1 GENERAL ONE LINE DIAGRAM  
NO SCALE

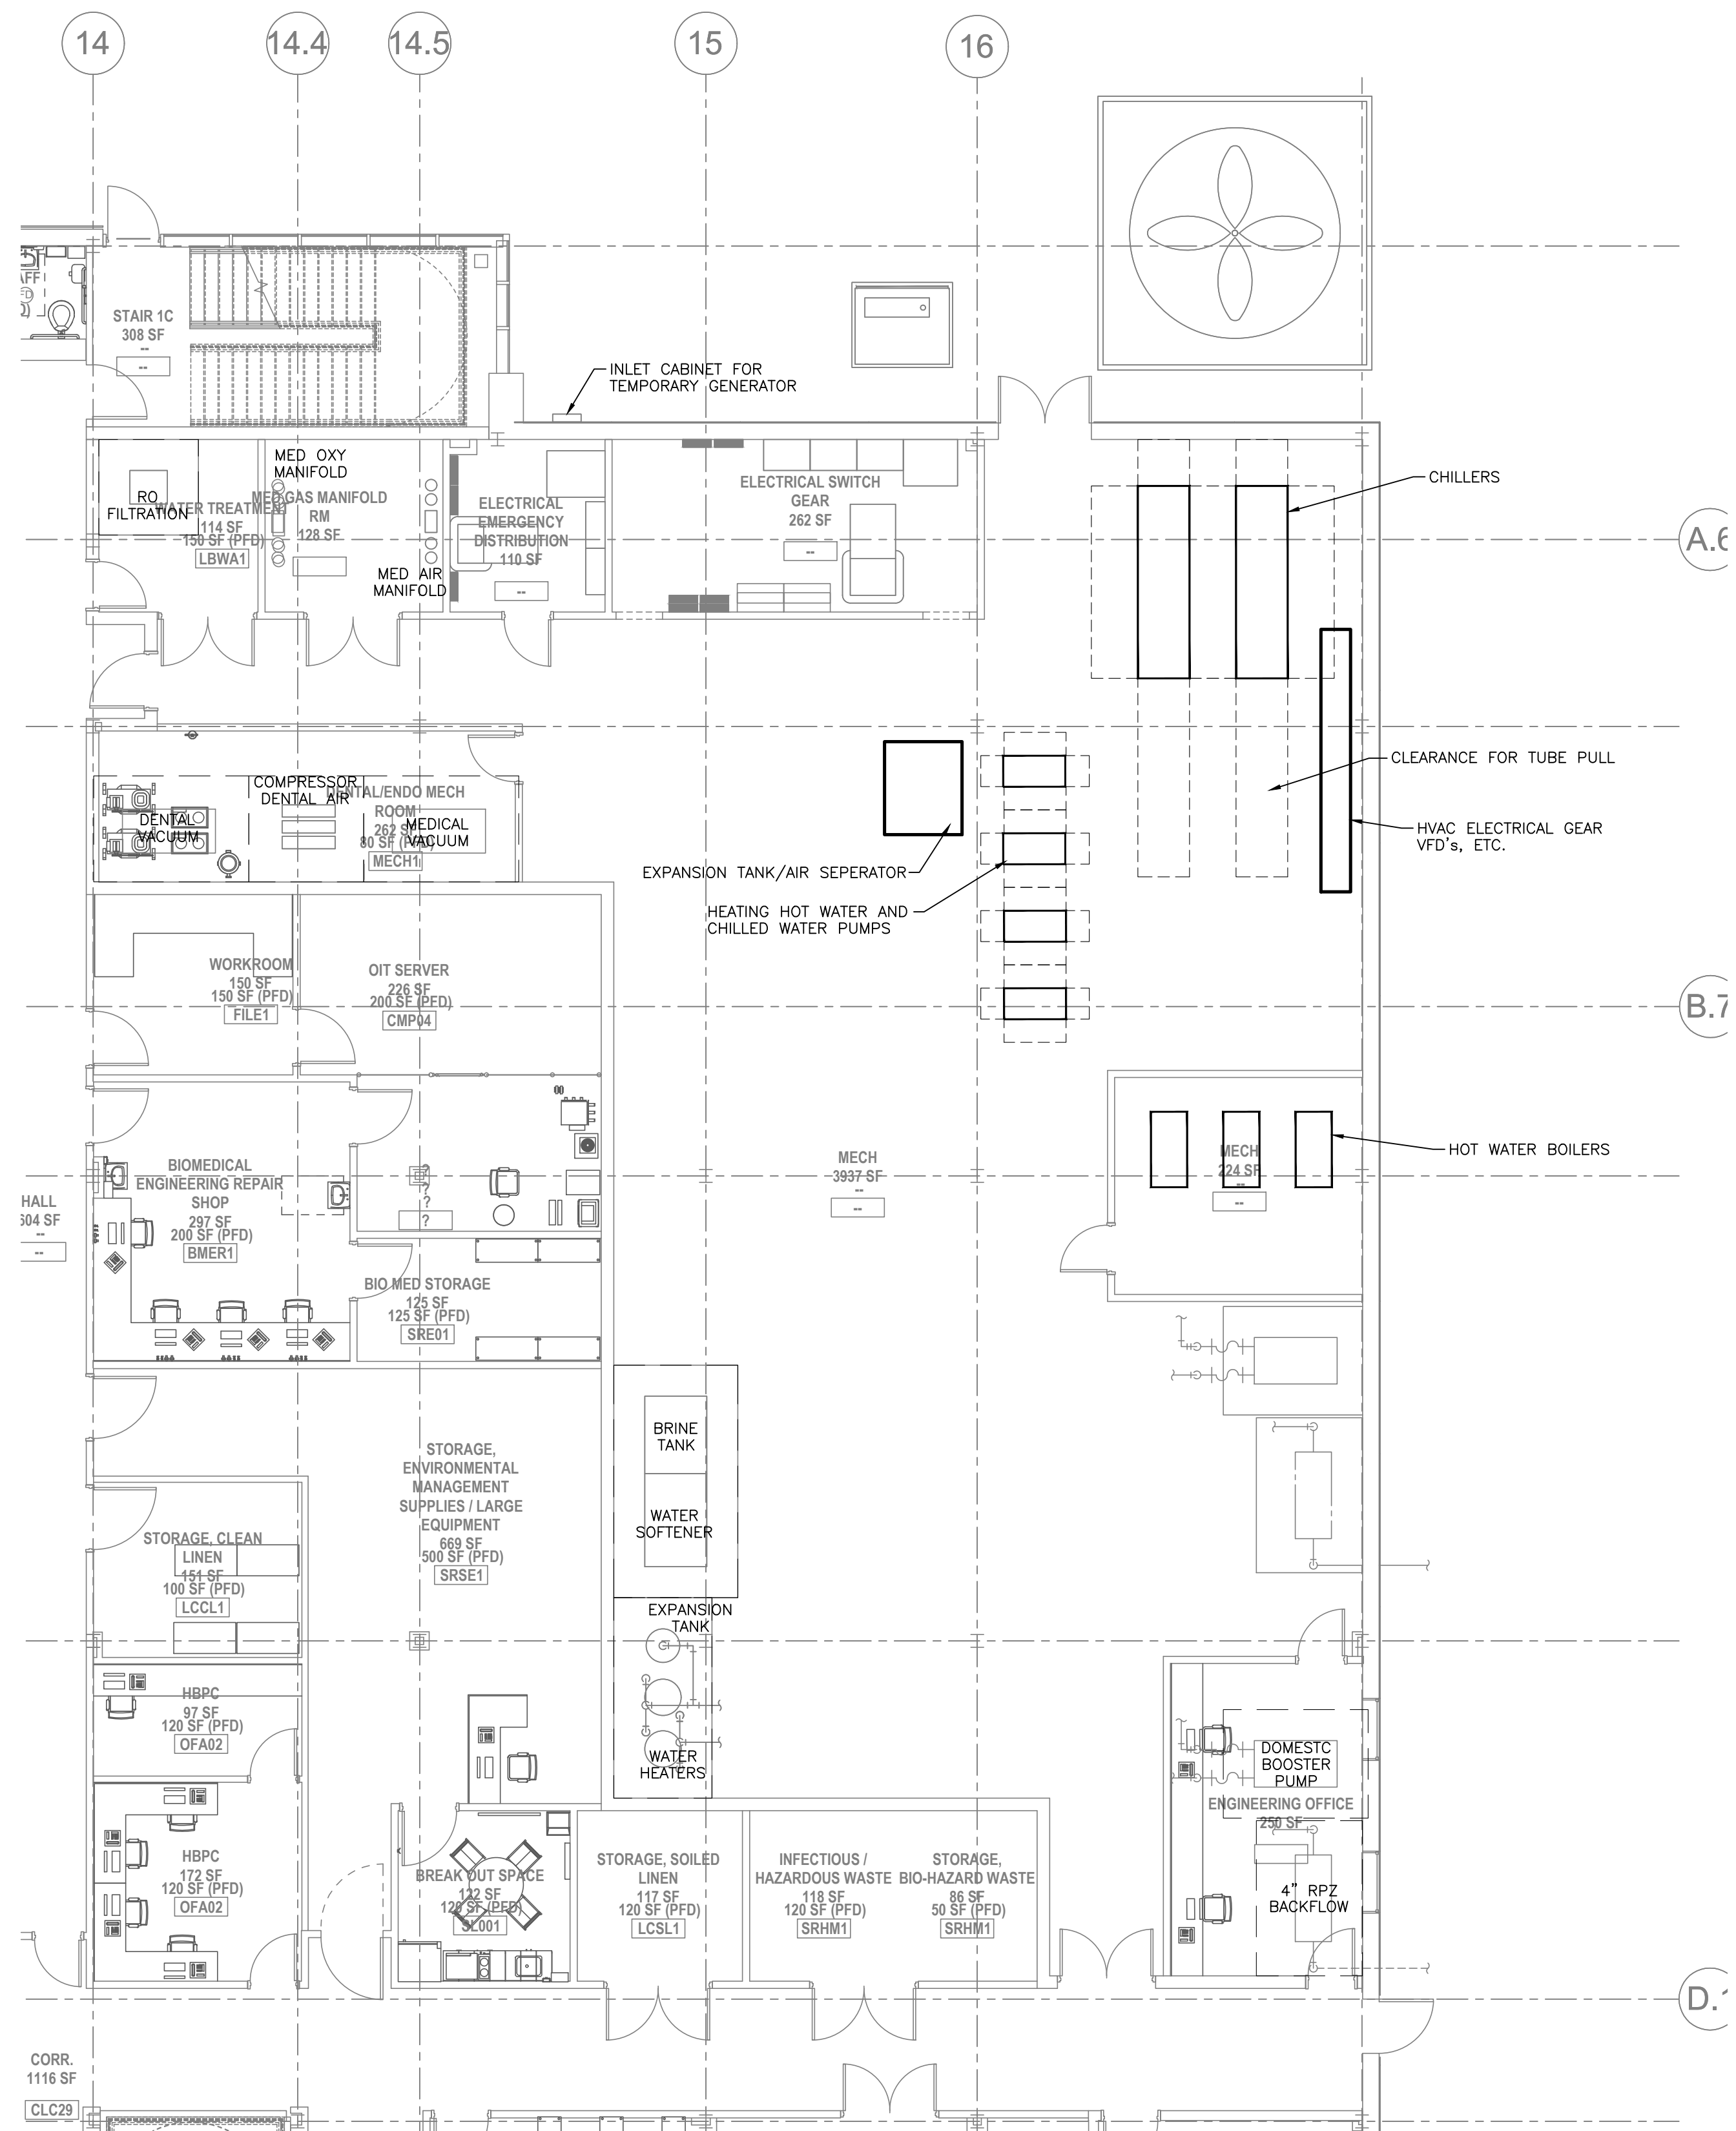

2 ENLARGED MECHANICAL ROOM PLAN  
SCALE: 1/8"=1'-0"

100% SCHEMATIC  
DESIGN - NOT FOR  
CONSTRUCTION

FULLY  
SPRINKLERED

Revisions:	Date

**CONSULTANTS:**

**KJWW** **ENGINEERING CONSULTANTS**  
Experience you can build on.®  
15 Sunnen Drive, Suite 104 | St. Louis, Missouri 63143  
314.645.1132 Fax: 314.645.1173  
www.kjww.com

**ANDERSON ENGINEERING**  
13605, 1st Ave. North, Suite 100 | Plymouth, Minnesota 55441  
763.412.4000 Fax: 763.412.4050  
www.ae-mn.com

**HENDERSON ENGINEERS**  
8345 LEXA DRIVE, SUITE 300  
LINCOLN, NE 68504  
TEL: 913.742.5000 FAX: 913.742.5001  
www.hel-eng.com  
163000000  
OK, CORPORATE NUMBER: 01639  
EXPIRES 06/30/19

THIS DOCUMENT IS RELEASED  
FOR THE PURPOSE OF  
PRELIMINARY SUBMITTAL  
LICENSE #  
IT IS NOT TO BE USED FOR  
CONSTRUCTION  
PURPOSES.

**ARCHITECT/ENGINEERS:**

**Oculus Inc.**  
ARCHITECTURE | STRATEGIC PLANNING |  
INTERIORS | MOVE MANAGEMENT  
1 South Memorial Drive  
Suite 1500  
Saint Louis, MO 63102  
(p) 314.367.6100  
(f) 314.367.1489  
www.oculusinc.com

Drawing Title <b>ENLARGED PLAN AND ELECTRICAL ONE LINE</b>	
Approved: Project Director	

Project Title <b>VA TULSA, OK CBOC - DESIGN PROCESS DOCUMENT</b>	
Project Number VA101-17-R-0320	
Building Number	
Location <b>TULSA, OK</b>	
Date 06/20/2017	Checked HEI
Drawn HEI	Dwg. of

**Office of  
Facilities  
Management**

**Department of  
Veterans Affairs**