

EXISTING HVAC PLAN


SCALE: 1/4" = 1'-0"



EQUIPMENT SCHEDULE						
EQUIP NO	CAP CFM	TSP"WC	TYPE	FAN DISCH ARR	VOLTAGE	TYPE DRIVE
RA-1	1760	2.0	SCROLL	TOP HORIZ	208 / 3Ø	1750 TEFC

NEW CONSTRUCTION NOTES:

1. CONTRACTOR SHALL INSTALL ALL NEW EQUIPMENT AND MATERIALS IN ACCORDANCE WITH SMACNA AND ALL APPLICABLE BLDG, MECH, ELECT AND NFPA CODES.
2. REUSE EXISTING MATERIALS THAT ARE IN GOOD CONDITION AND MATCH THE SIZES REQUIRED.
3. CONTRACTOR INSPECT THE EXISTING DUCT TO BE REUSED TO BE IN GOOD CONDITION, REPAIR LEAKS AND DAMAGE TO BE IN ACCORDANCE WITH SMACNA LEAK LIMITS.
4. PROVIDE NEBB CERTIFIED AIR BALANCE CONTRACTOR: AIR RIGHT, INC 303-232-5145
5. PROVIDE A DUCT CLEANING SERVICE FOR THE EXISTING SUPPLY AIR DUCT INCLUDING AH-22 AND ALL EXISTING SUPPLY DUCTS.
6. PROVIDE MOTOR STARTER AND DISCONNECT WITH RA-1. VA WILL INSTALL AND RUN ALL NECESSARY CONDUIT AND WIRING TO RA-1.

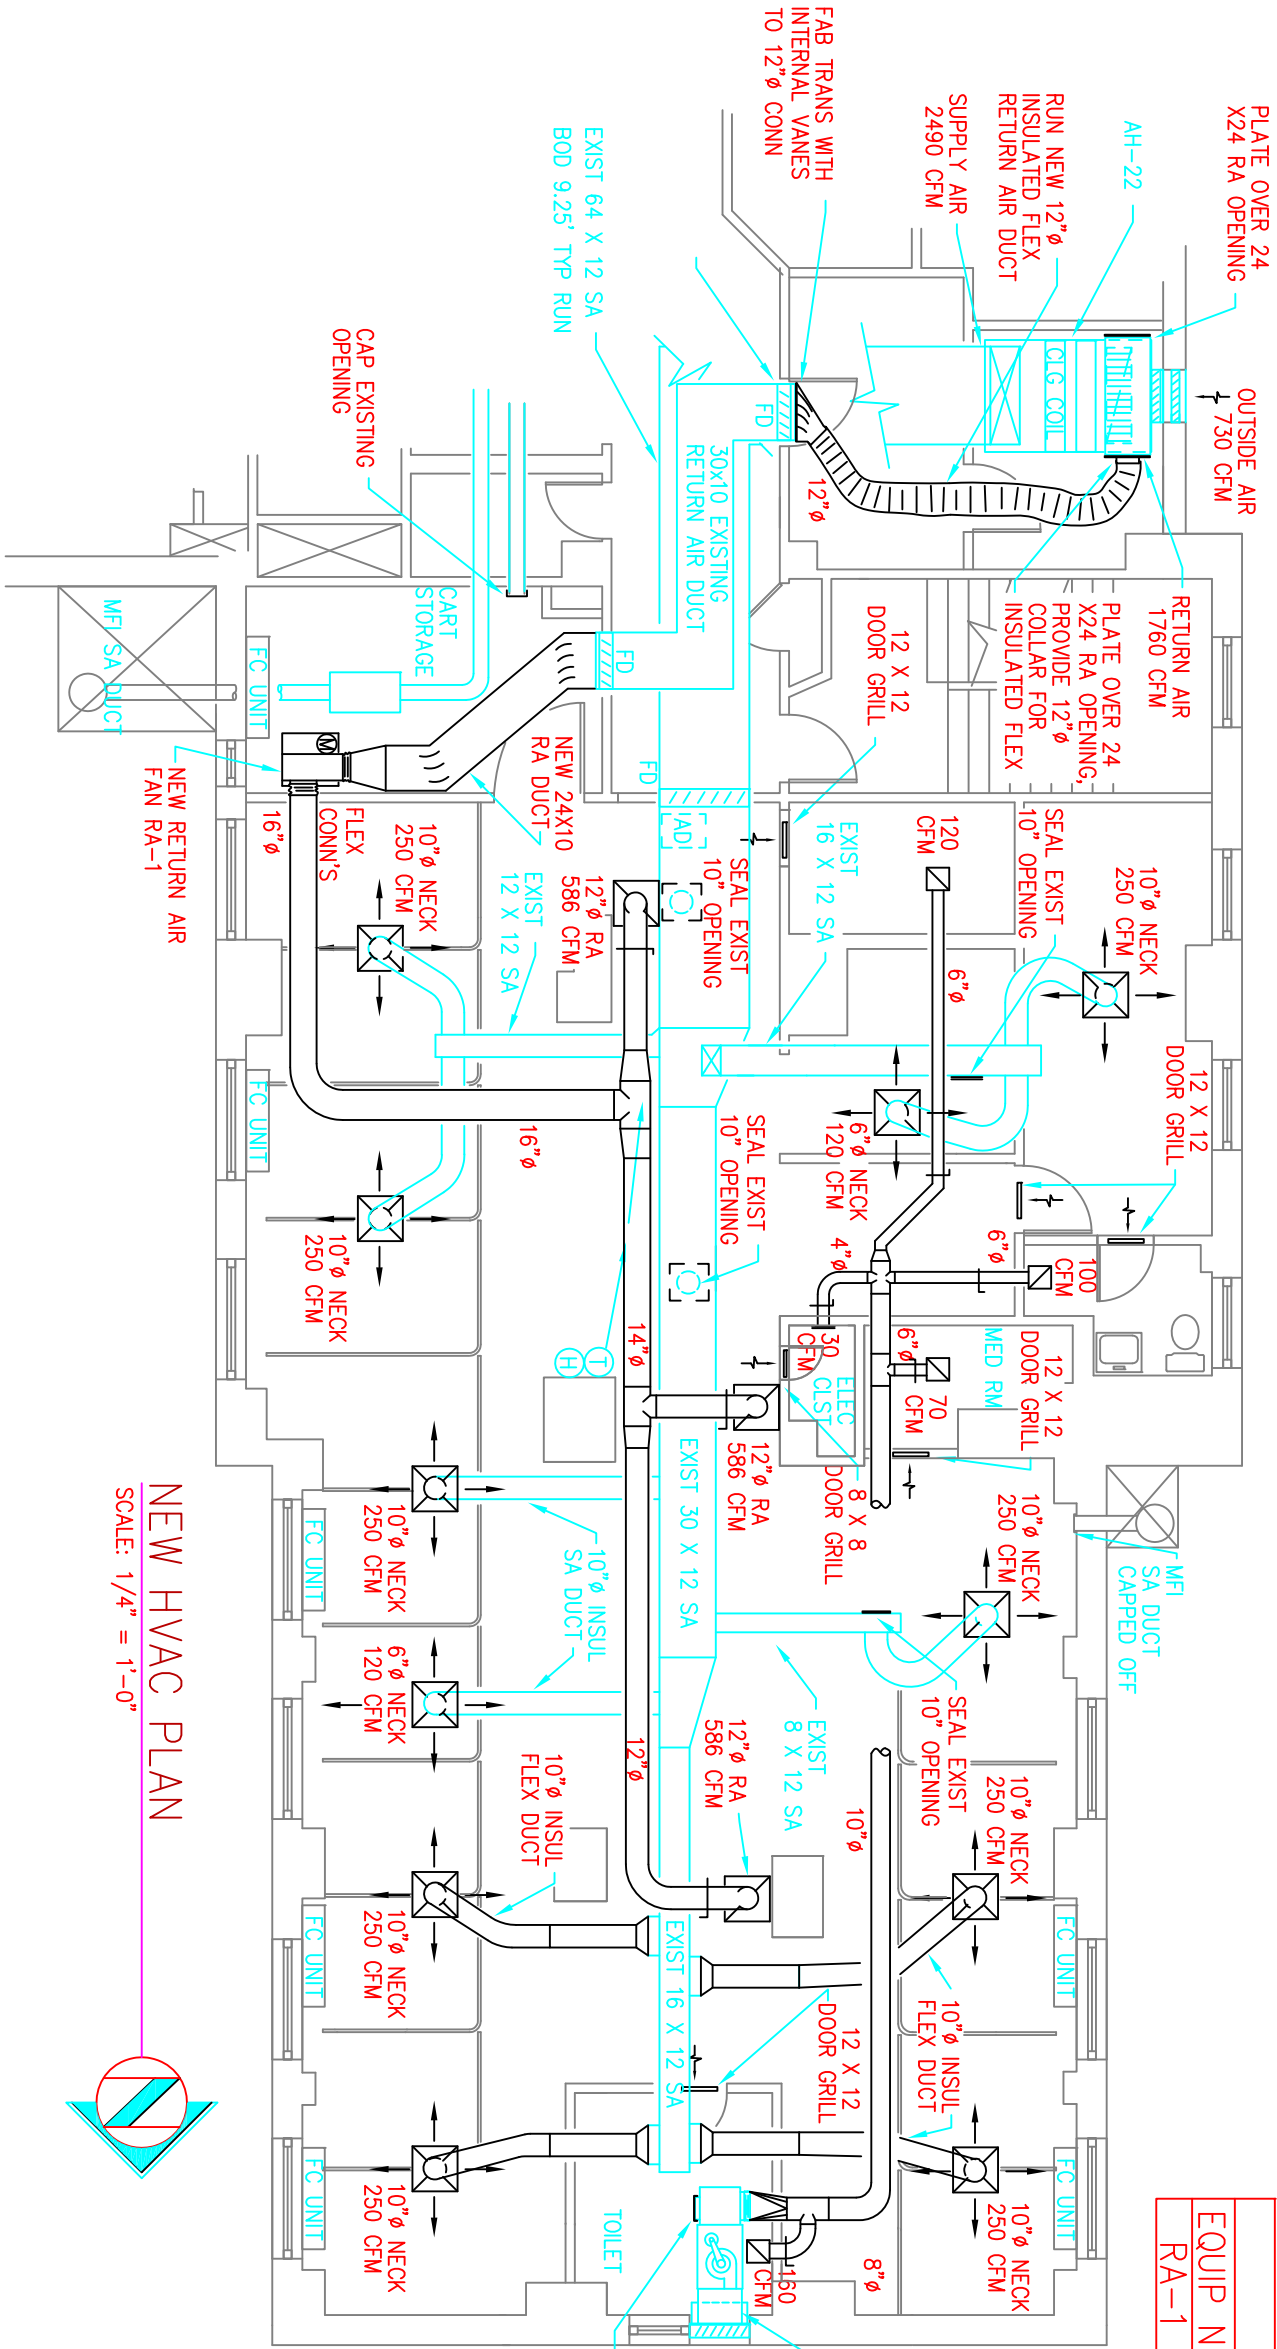

NEW HVAC PLAN

SCALE: 1/4" = 1'-0"



PLOTTING NOTES:

1. FULL SIZE V.A. "E" SHEET (AS INDICATED)
2. HALF SIZE V.A. "D" SHEET (1/2 THE INDICATED SCALE)
3. LETTER SIZE: (NOT SCALE)

GENERAL NOTES:

1. SCALED DIMENSIONS & ARCHITECTURAL FEATURES MAY NOT BE CORRECT.
2. CONTRACTORS & A/E's ARE RESPONSIBLE TO FIELD VERIFY ALL DIMENSIONS WITHIN THE PROJECT AREA.

DEPARTMENT OF VETERANS AFFAIRS

MEDICAL CENTER
1055 Clement Street
Denver, Colorado, 80220

By	Revisions	Date
Sylvester	Issued for bid	2-04

Drawing Title			Project Title			Date
4 NE HVAC DUCTWORK PLAN DEMO & NEW			STEP-DOWN UNIT 4 NE RENOVATION			02/2004
Approved: Service Chief	Brown	Sylvester	Building Number	1	Title Block By	Project No. XX-XXX
Approved: Section Chief	Checked KIB	Wing	C	skca	DWG M-1	DWG 1 OF 1