
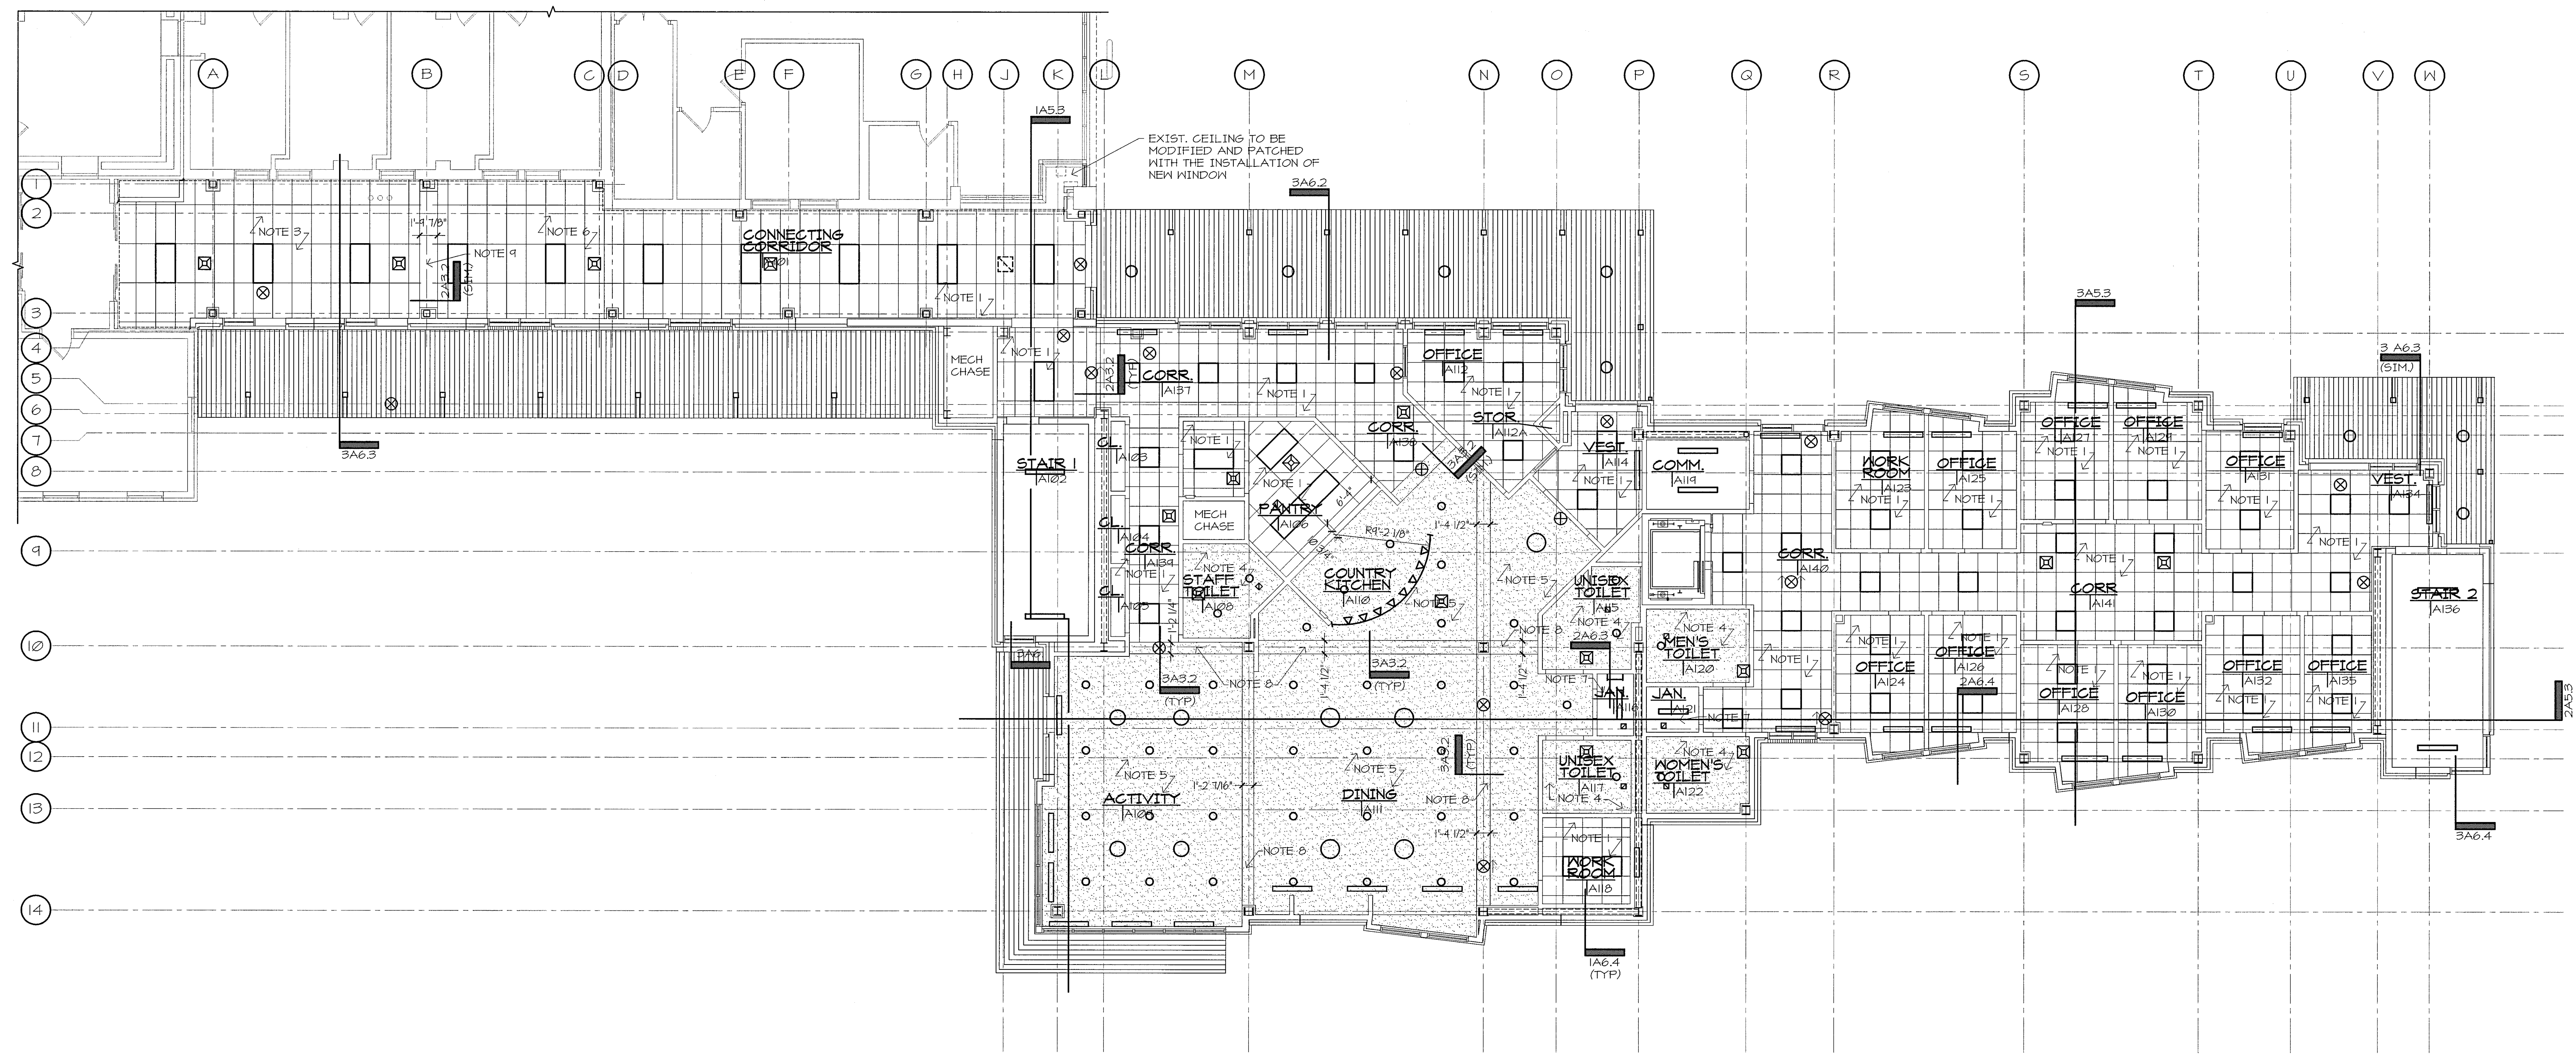


three inches = one foot  
one and one half inches = one foot  
one inch = one foot  
three quarters inch = one foot  
one half inch = one foot  
three eighths inch = one foot  
one quarter inch = one foot  
one eighth inch = one foot  
one sixteenth inch = one foot

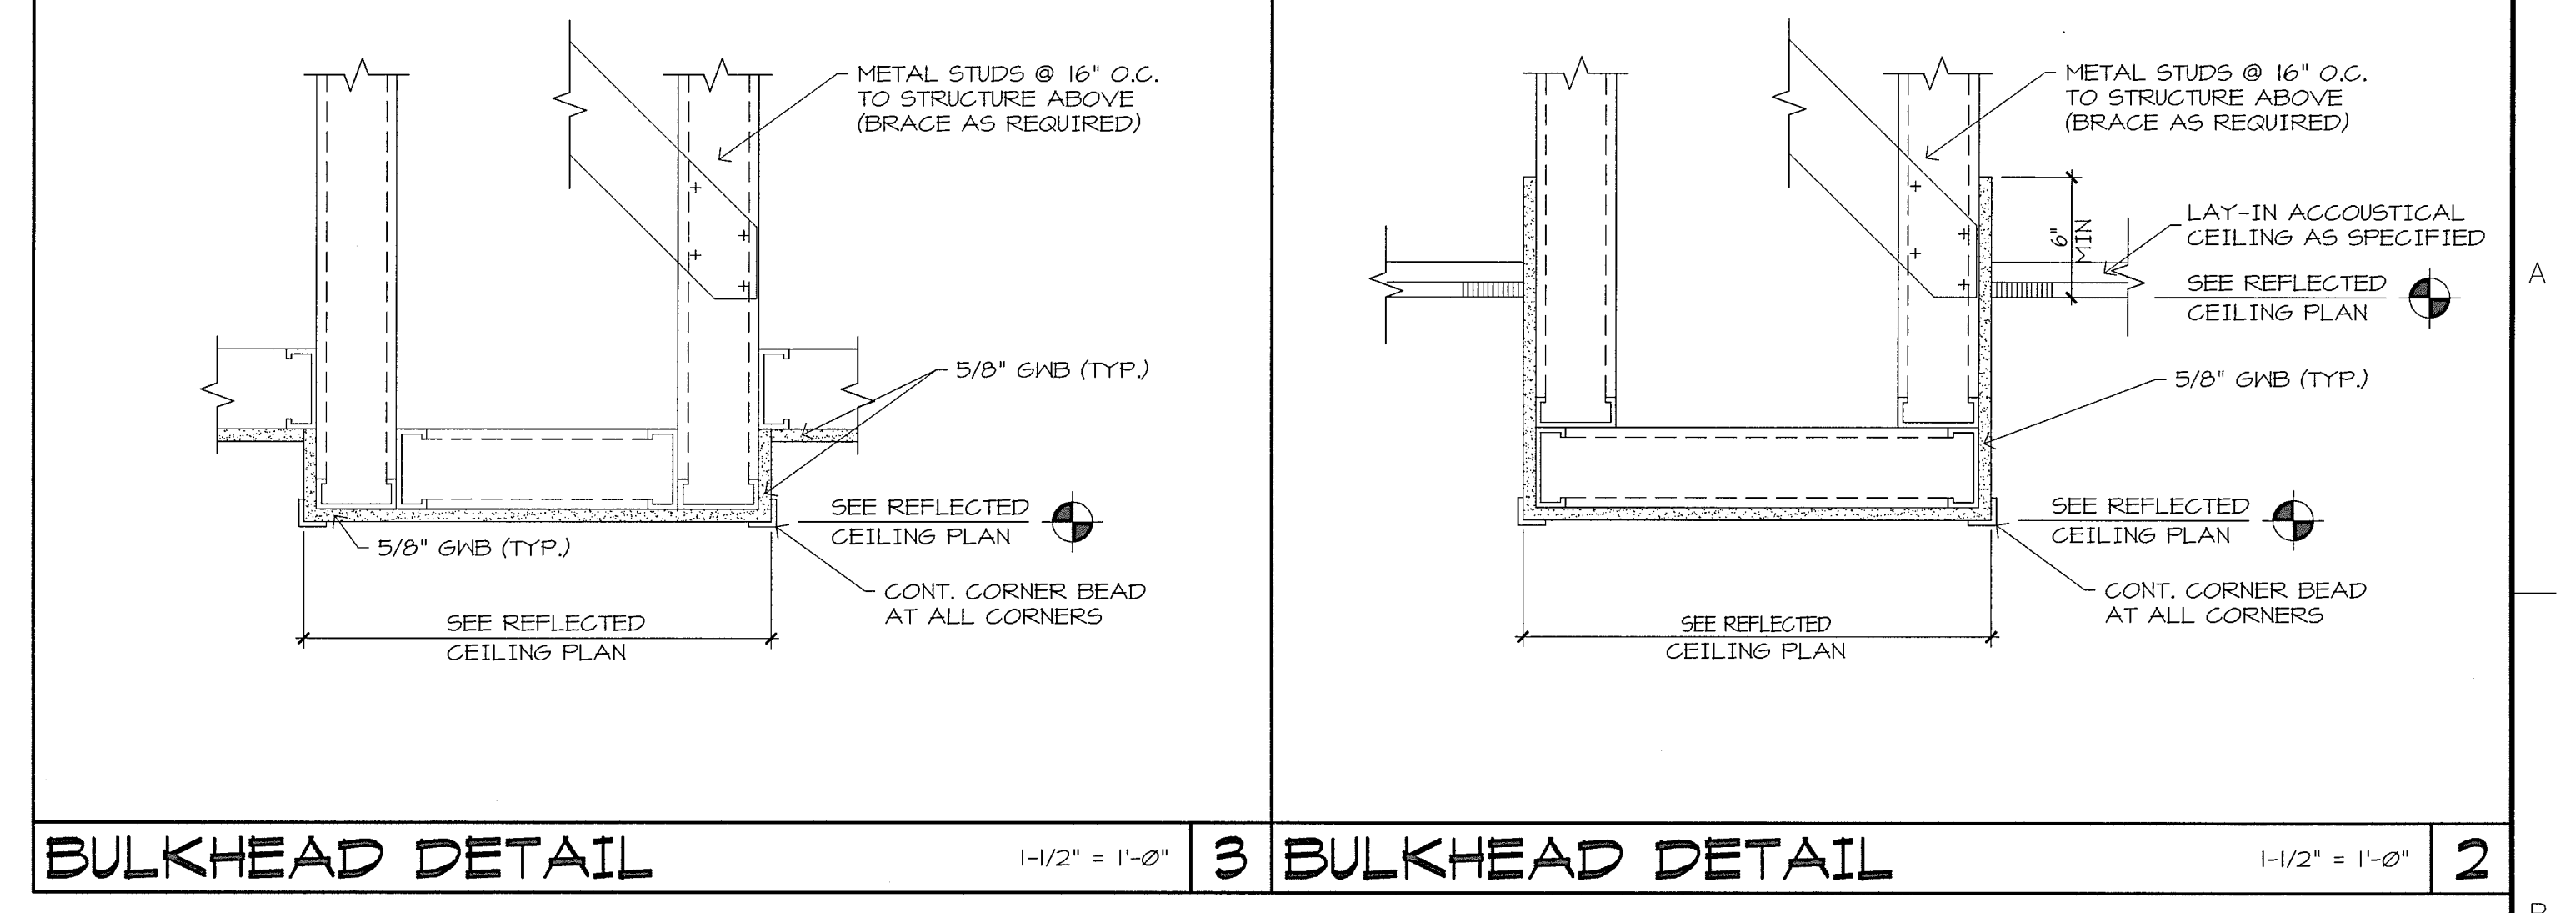

**REFLECTED CEILING PLAN LEGEND**

- 2 x 2 FLUORESCENT LIGHT FIXTURE
- 2 x 4 FLUORESCENT LIGHT FIXTURE
- 1 x 4 FLUORESCENT LIGHT FIXTURE
- RECESSED DOWNLIGHT
- SMOKE DETECTOR
- EXIT SIGN
- DIFFUSER (SUPPLY) RE: MECH
- RETURN REGISTER RE: MECH

**REFLECTED CEILING PLAN NOTES**

NOTE 1: ACT @ 10'-0" AFF  
NOTE 2: ACT @ 11'-0" AFF  
NOTE 3: INSTALL CEILING AS HIGH AS POSSIBLE (8'-0" MIN HT)  
NOTE 4: INSTALL CEILING @ 9'-0" AFF  
NOTE 5: INSTALL CEILING @ 10'-0" AFF  
NOTE 6: CEILING HEIGHT WILL VARY FROM EAT END OF CONNECTING CORRIDOR  
NOTE 7: EXPOSED STRUCTURE ABOVE  
NOTE 8: BOTTOM OF BULKHEAD @ 9'-6" AFF  
NOTE 9: BOTTOM OF BULKHEAD 2" BELOW CEILING ON EAST SIDE OF BULKHEAD

<b>REFLECTED CEILING PLAN - FIRST FLOOR</b>		<b>CONSULTANTS:</b>		<b>ARCHITECT/ENGINEERS:</b>		<b>Drawing Title</b>		<b>Project Title</b>		<b>Project Number</b>		<b>Office of Construction and Facilities Management</b>	
				<b>SFCs</b>		<b>REFLECTED CEILING PLAN - FIRST FLOOR</b>		<b>Adult Day Care Building VA Medical Center</b>		<b>VA246-P-0568</b>		<b>Department of Veterans Affairs</b>	
				SFCs Inc. • 305 South Jefferson Street Roanoke, Virginia 24011.2003 540.344.6664 • Fax 540.343.6925 www.sfcscs.com		Approved: Project Director		Location Beckley, West Virginia		Building Number -			
				ANDERSON & ASSOCIATES, INC. Professional Design Services www.andassoc.com		Date 08/05/2011		Checked -		Drawn MCA		Drawing Number <b>A3.2</b> Dwg. 26 of 77	
Revisions:		Date:											