
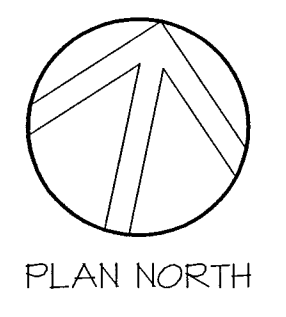



one eighth inch = one foot
one quarter inch = one foot
three eighths inch = one foot
one half inch = one foot
three quarters inch = one foot
one inch = one foot
one and one half inches = one foot
two inches = one foot
three inches = one foot

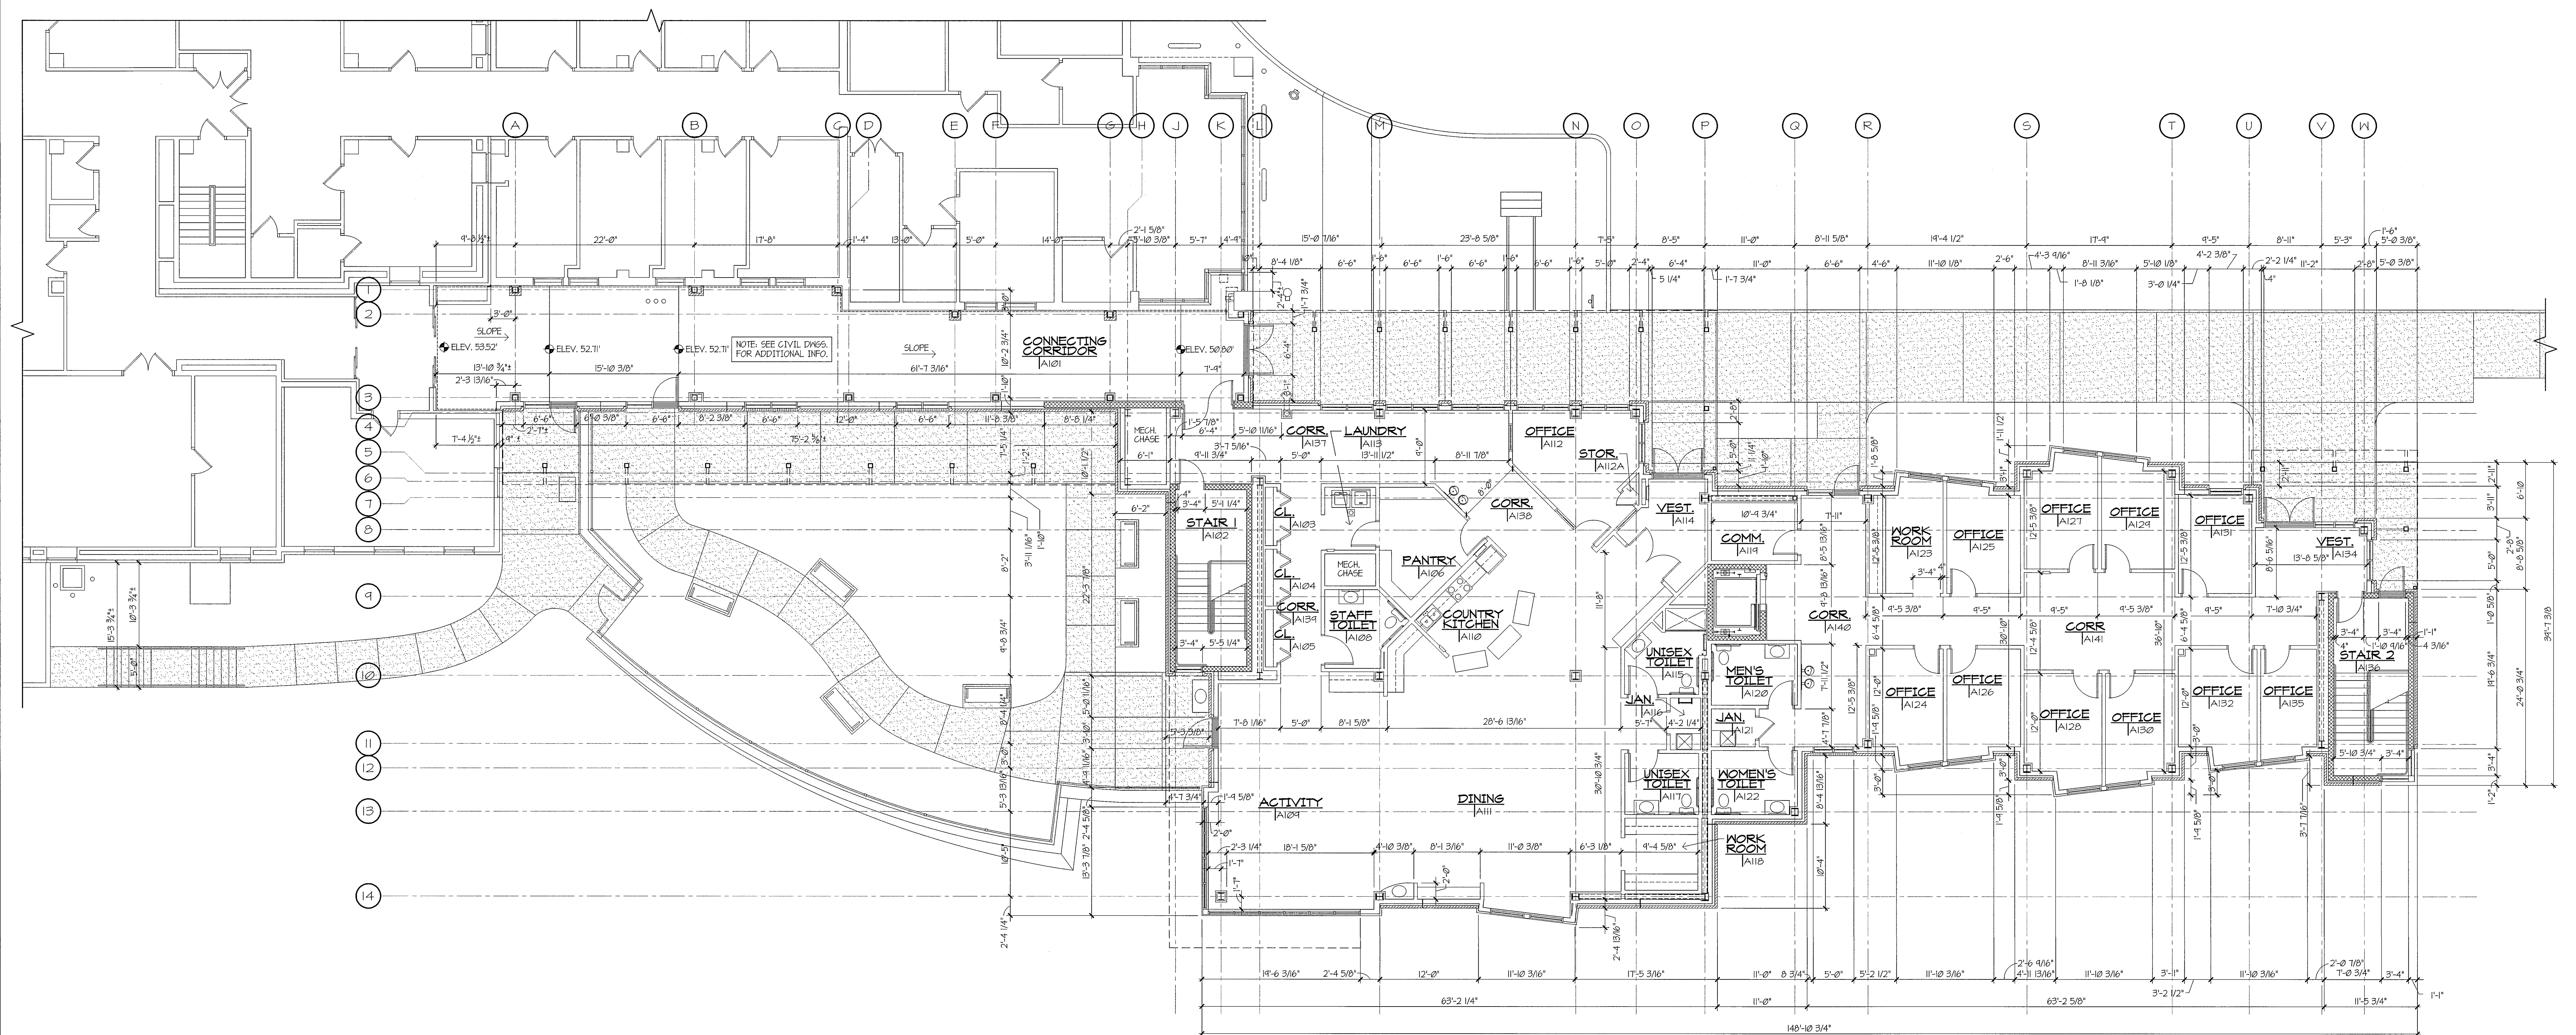

FIRST FLOOR PLAN

Revisions	Date

CONSULTANTS:

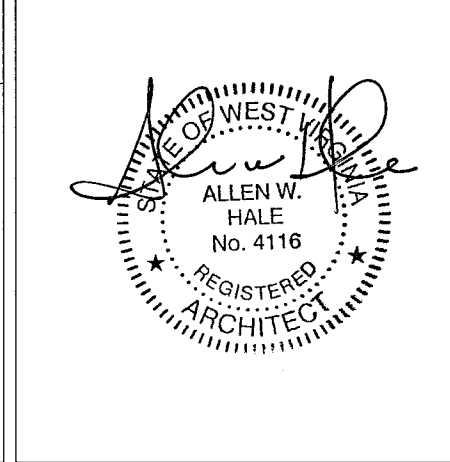

ARCHITECT/ENGINEERS:
SFCS
Architecture
Engineering
Planning
Interiors
SFCS Inc. • 305 South Jefferson Street
Roanoke, Virginia 24011.2003
540.344.6664 • Fax 540.343.6925
www.sfcs.com

ANDERSON & ASSOCIATES, INC.
Professional Design Services
www.andassoc.com
100 Ashmore Dr.
Blacksburg, VA 24060
540-852-8982

Drawing Title
**FIRST FLOOR
DIMENSION PLAN**
Approved Project Director

Project Title
Adult Day Care Building
VA Medical Center
Comm No. 10110.00
Location
Beckley, West Virginia
Date
08/05/2011
Checked
-
Drawn
MCA

Project Number
VA246-P-0568
Building Number
-
Drawing Number
A15
Dwg. 22 of 77

Office of
Construction
and Facilities
Management
Department of
Veterans Affairs