
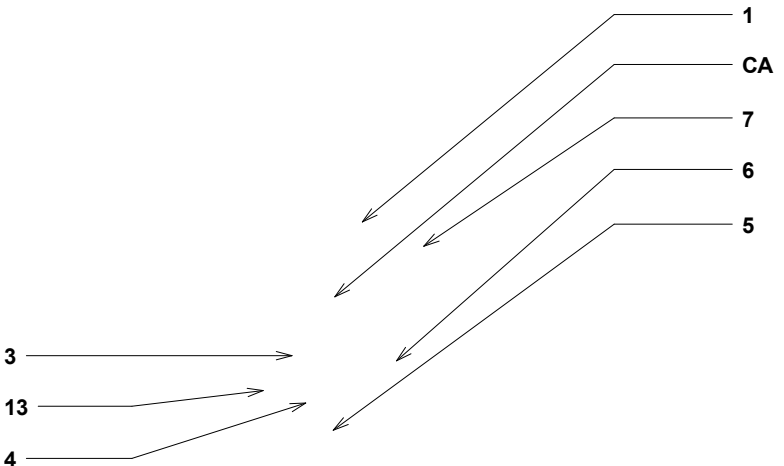


Approximate location of waterline to be replaced.

Building 7

Bldg 1

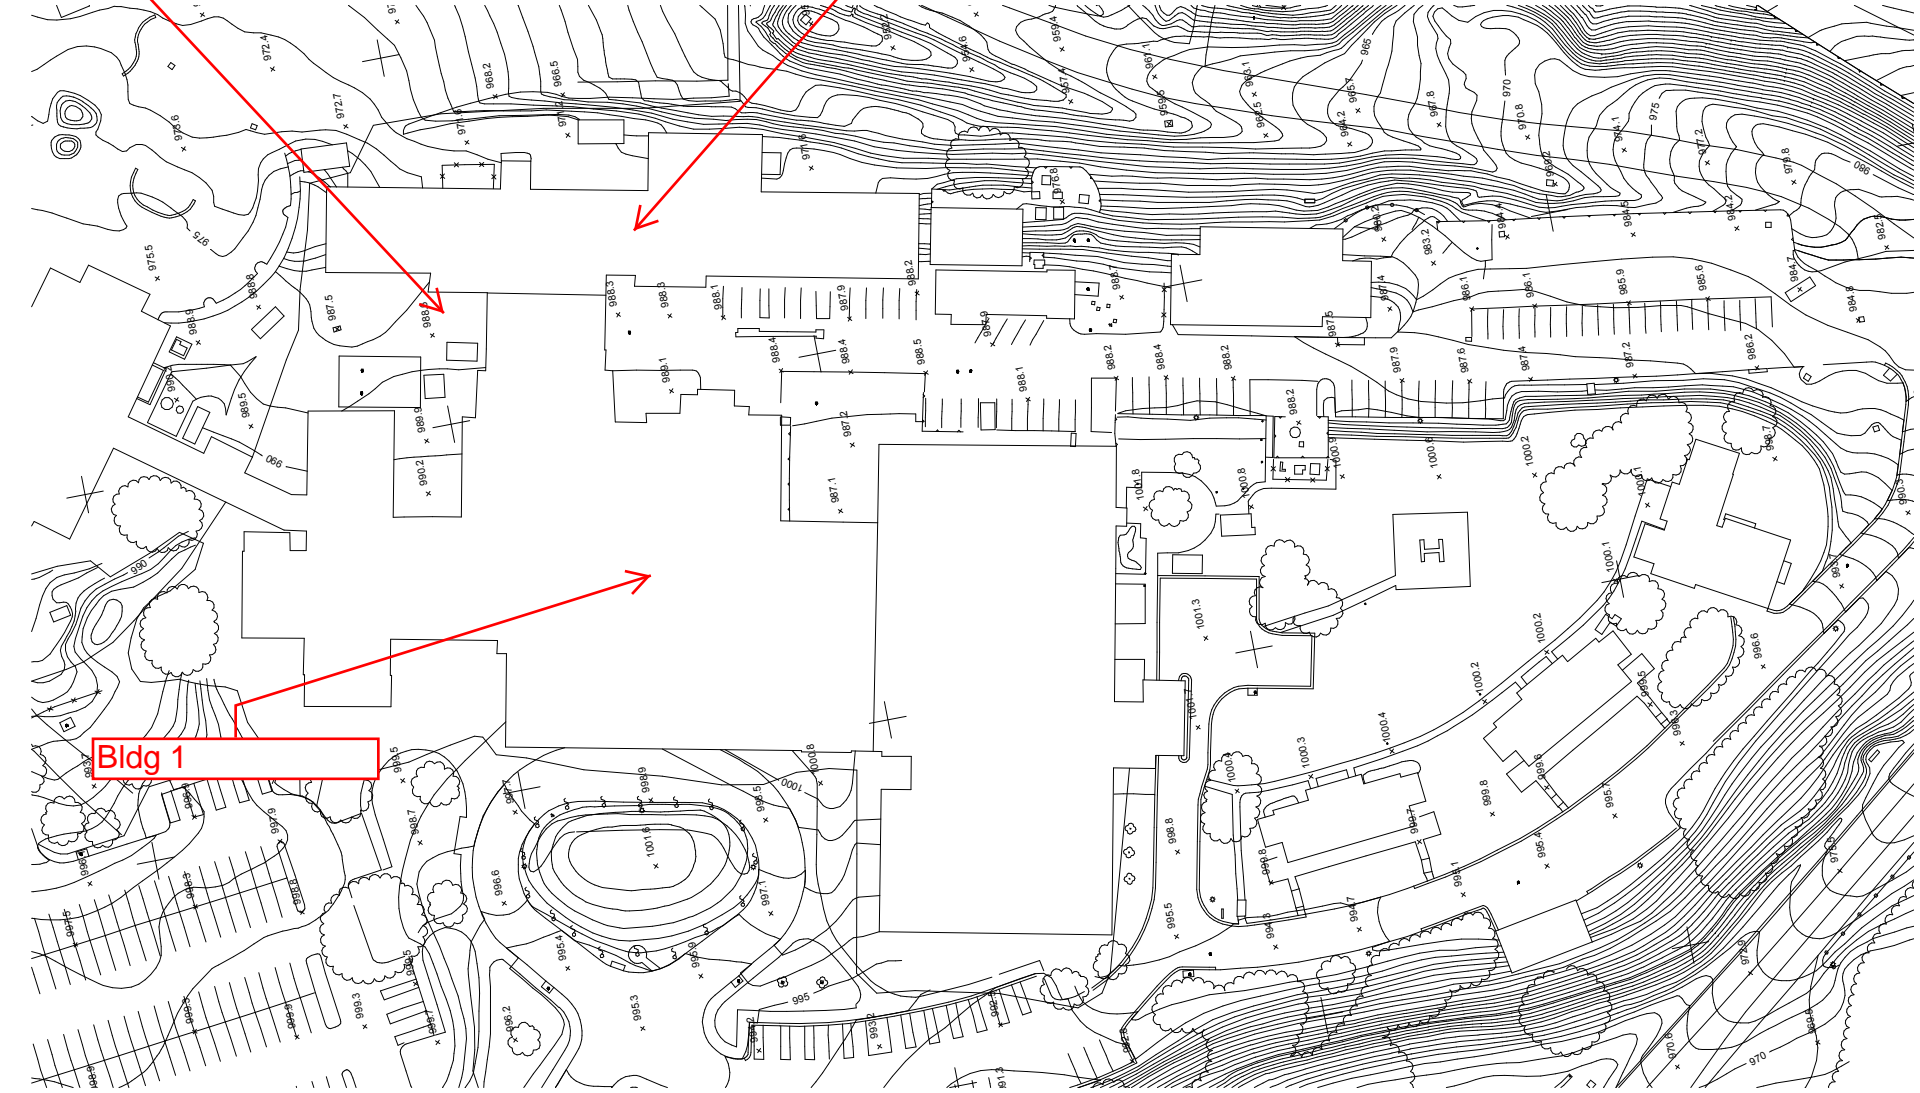

**IKM Incorporated**  
One PPG Place  
Pittsburgh, PA 15222

Project Title  
**VAPHS Masterplan**  
Sheet Title  
**Site Plan**

Project No.  
**08-045**  
Date  
**12/04/08**

Drawing No.  
**A1.8**





